

CONSTRUCTION PLANS

HAWAII LOA RIDGE

JUGHANDLE INTERSECTION AND DRAIN OUTLET

WAILUPE AND NIU, HONOLULU, OAHU, HAWAII

OWNER : HAWAII-LOA RIDGE , INC.


DEVELOPER : LEADERSHIP HOMES HAWAII

GRAY,RHEE & ASSOCIATES INC.
CONSULTING ENGINEERS

AS-BUILT CONSTRUCTION PLANS
APPROVED:

GRAY,RHEE AND ASSOCIATES , INC. DATE

DIV. OF ENGINEERING DATE

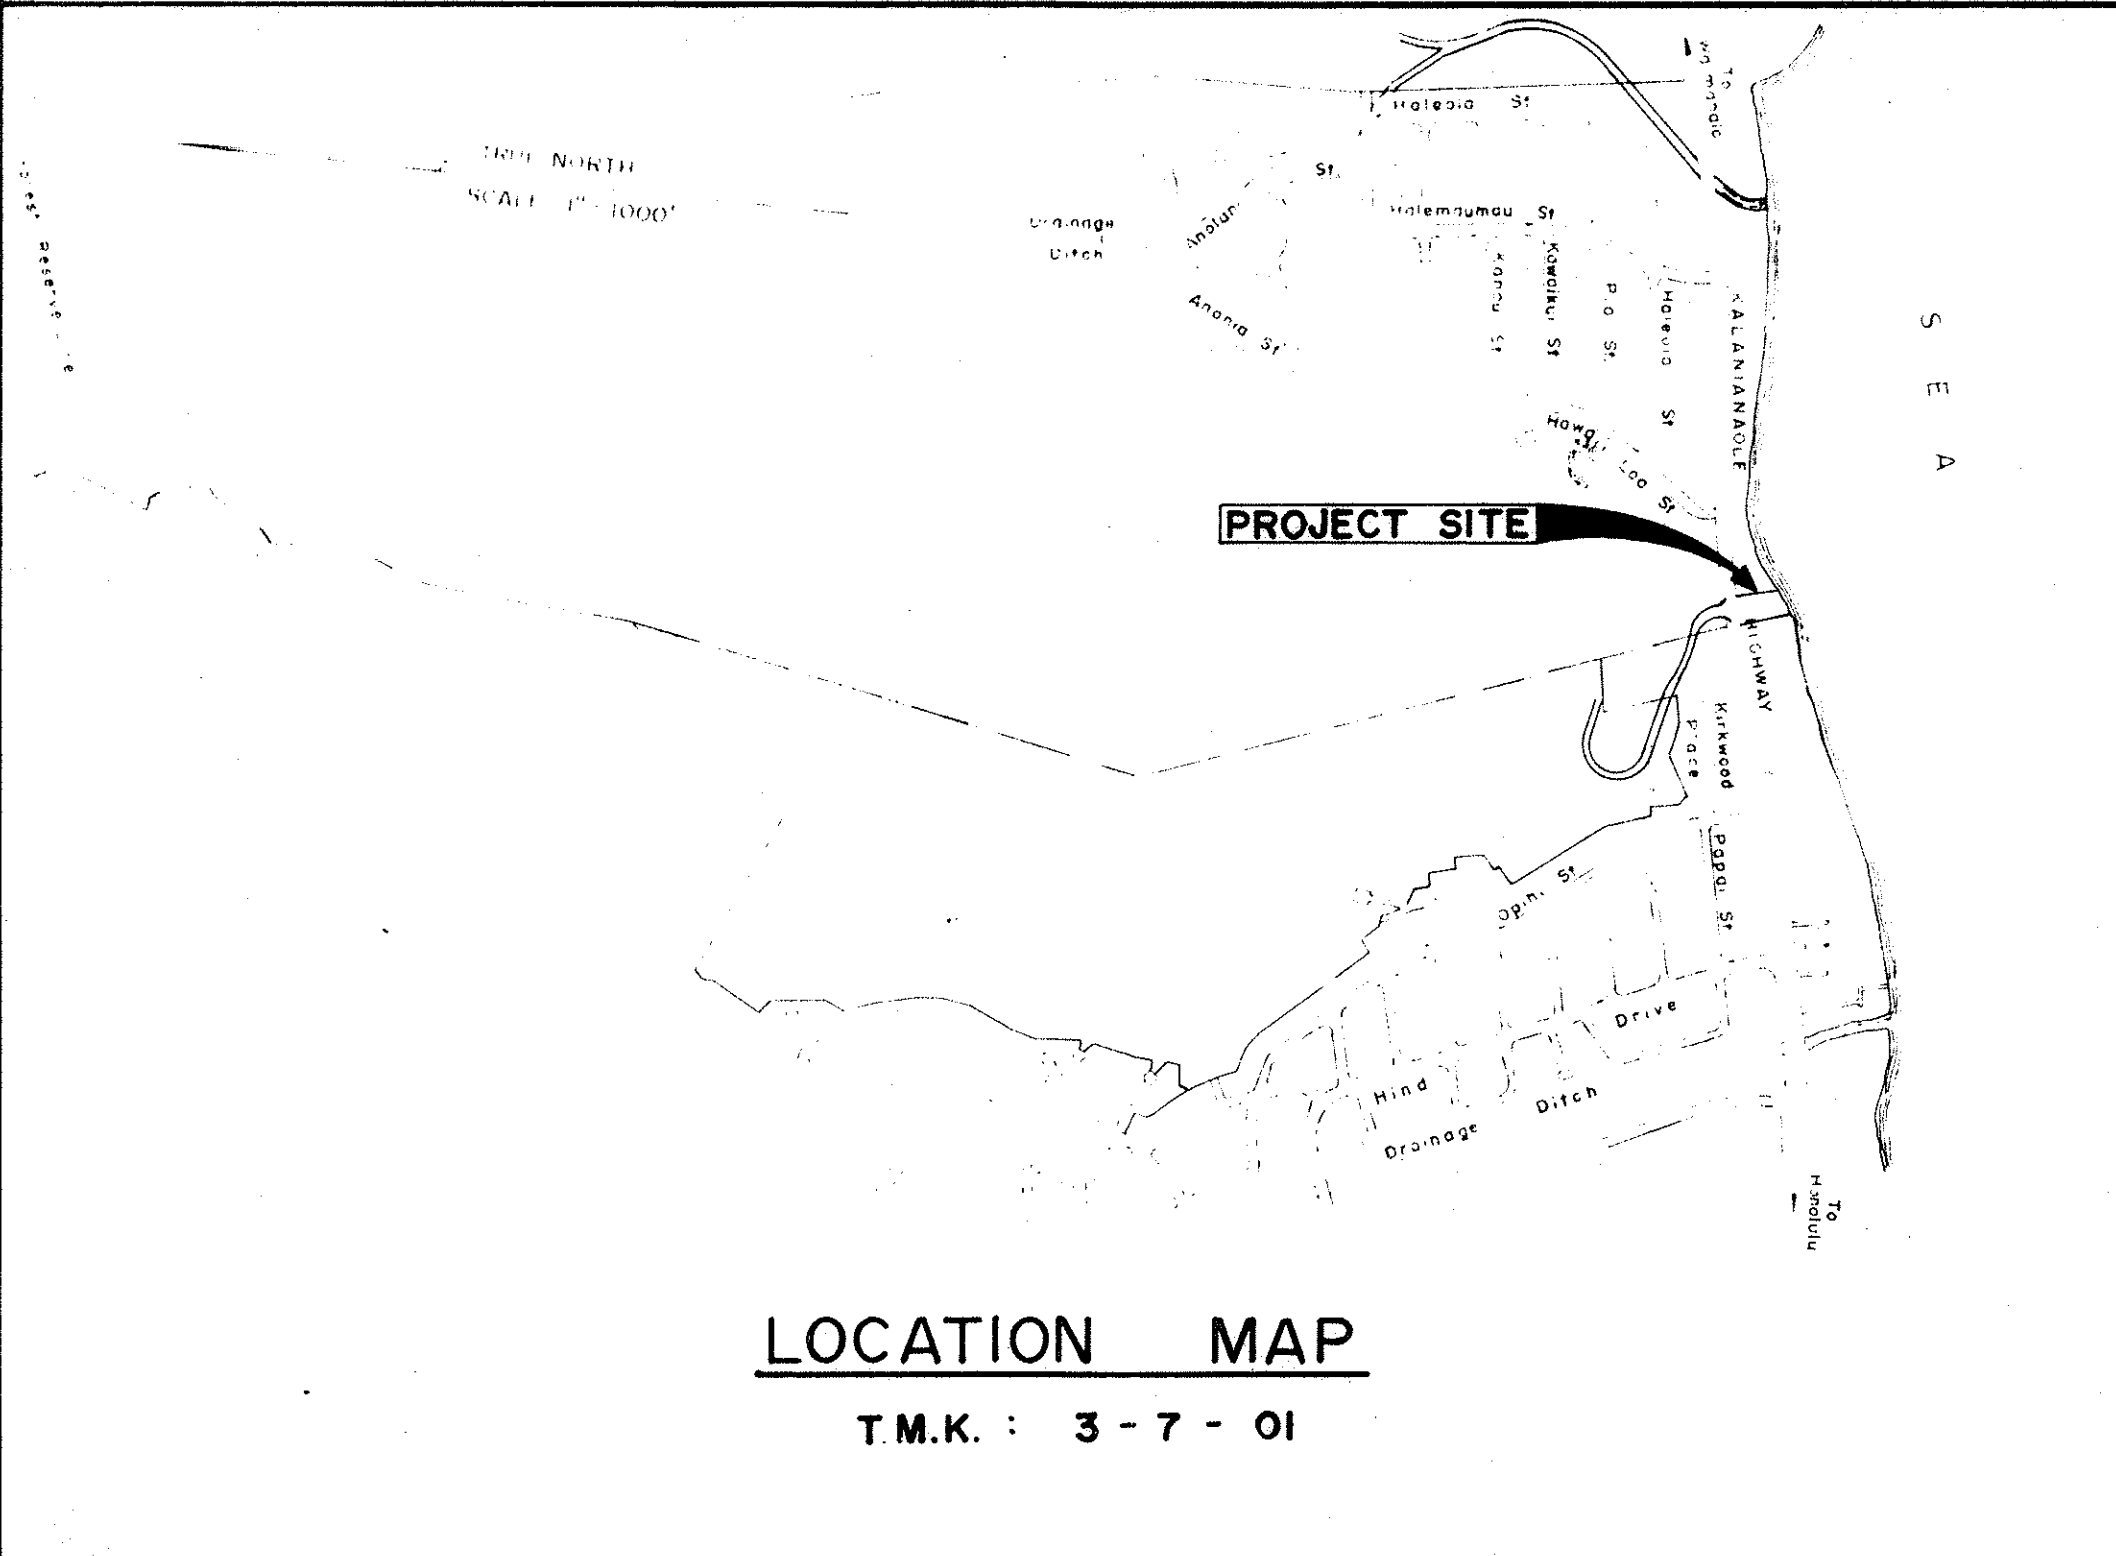

LOCATION MAP

T.M.K. : 3 - 7 - 01

INDEX TO DRAWINGS

SHEET NO.	DESCRIPTION
1.	TITLE SHEET
2.	SITE AND GRADING PLAN
3.	PLAN AND PROFILE
4.	PLAN AND PROFILE
5.	SECTIONS
6.	DETAILS
7.	TRAFFIC SIGNAL, SIGN, AND PAVEMENT MARKING PLAN
8.	LANDSCAPING PLAN: PRESENT
9.	LANDSCAPING PLAN: FUTURE
10.	TRAFFIC SIGNAL LEGEND AND NOTES
11.	TRAFFIC SIGNAL PLAN
12.	TRAFFIC SIGNAL PLAN AT E. HIND DRIVE & KALANIANA'OLE HIGHWAY
13.	TRAFFIC SIGNAL DETAILS AND STREET LIGHTING PLAN
14.	TRAFFIC SIGNAL DETAILS
15.	TRAFFIC SIGNAL DETAILS
16.	STREET LIGHTING DETAILS

APPROVED:

CHAIRMAN,
DEPT. OF LAND AND NATURAL RESOURCES

DATE

CHIEF, HIGHWAYS DIVISION
DEPARTMENT OF TRANSPORTATION

DATE

DIRECTOR , DEPARTMENT OF LAND UTILIZATION

DATE

Kay H. Hays
DIRECTOR & CHIEF ENGINEER ,
DEPARTMENT OF PUBLIC WORKS

8/8/74
DATE

CHIEF, ENVIRONMENTAL PROTECTION AND
HEALTH SERVICES DIVISION

DATE

James C. Village
DIRECTOR , DEPARTMENT OF TRANSPORTATION SERVICES

5-28-74
DATE

MANAGER & CHIEF ENGINEER , B.W.S.

DATE

DIRECTOR , DEPARTMENT OF RECREATION

DATE