



**1 LIGHTING DEMOLITION PLAN**  
E-4 SCALE: 3/8" = 1'-0"

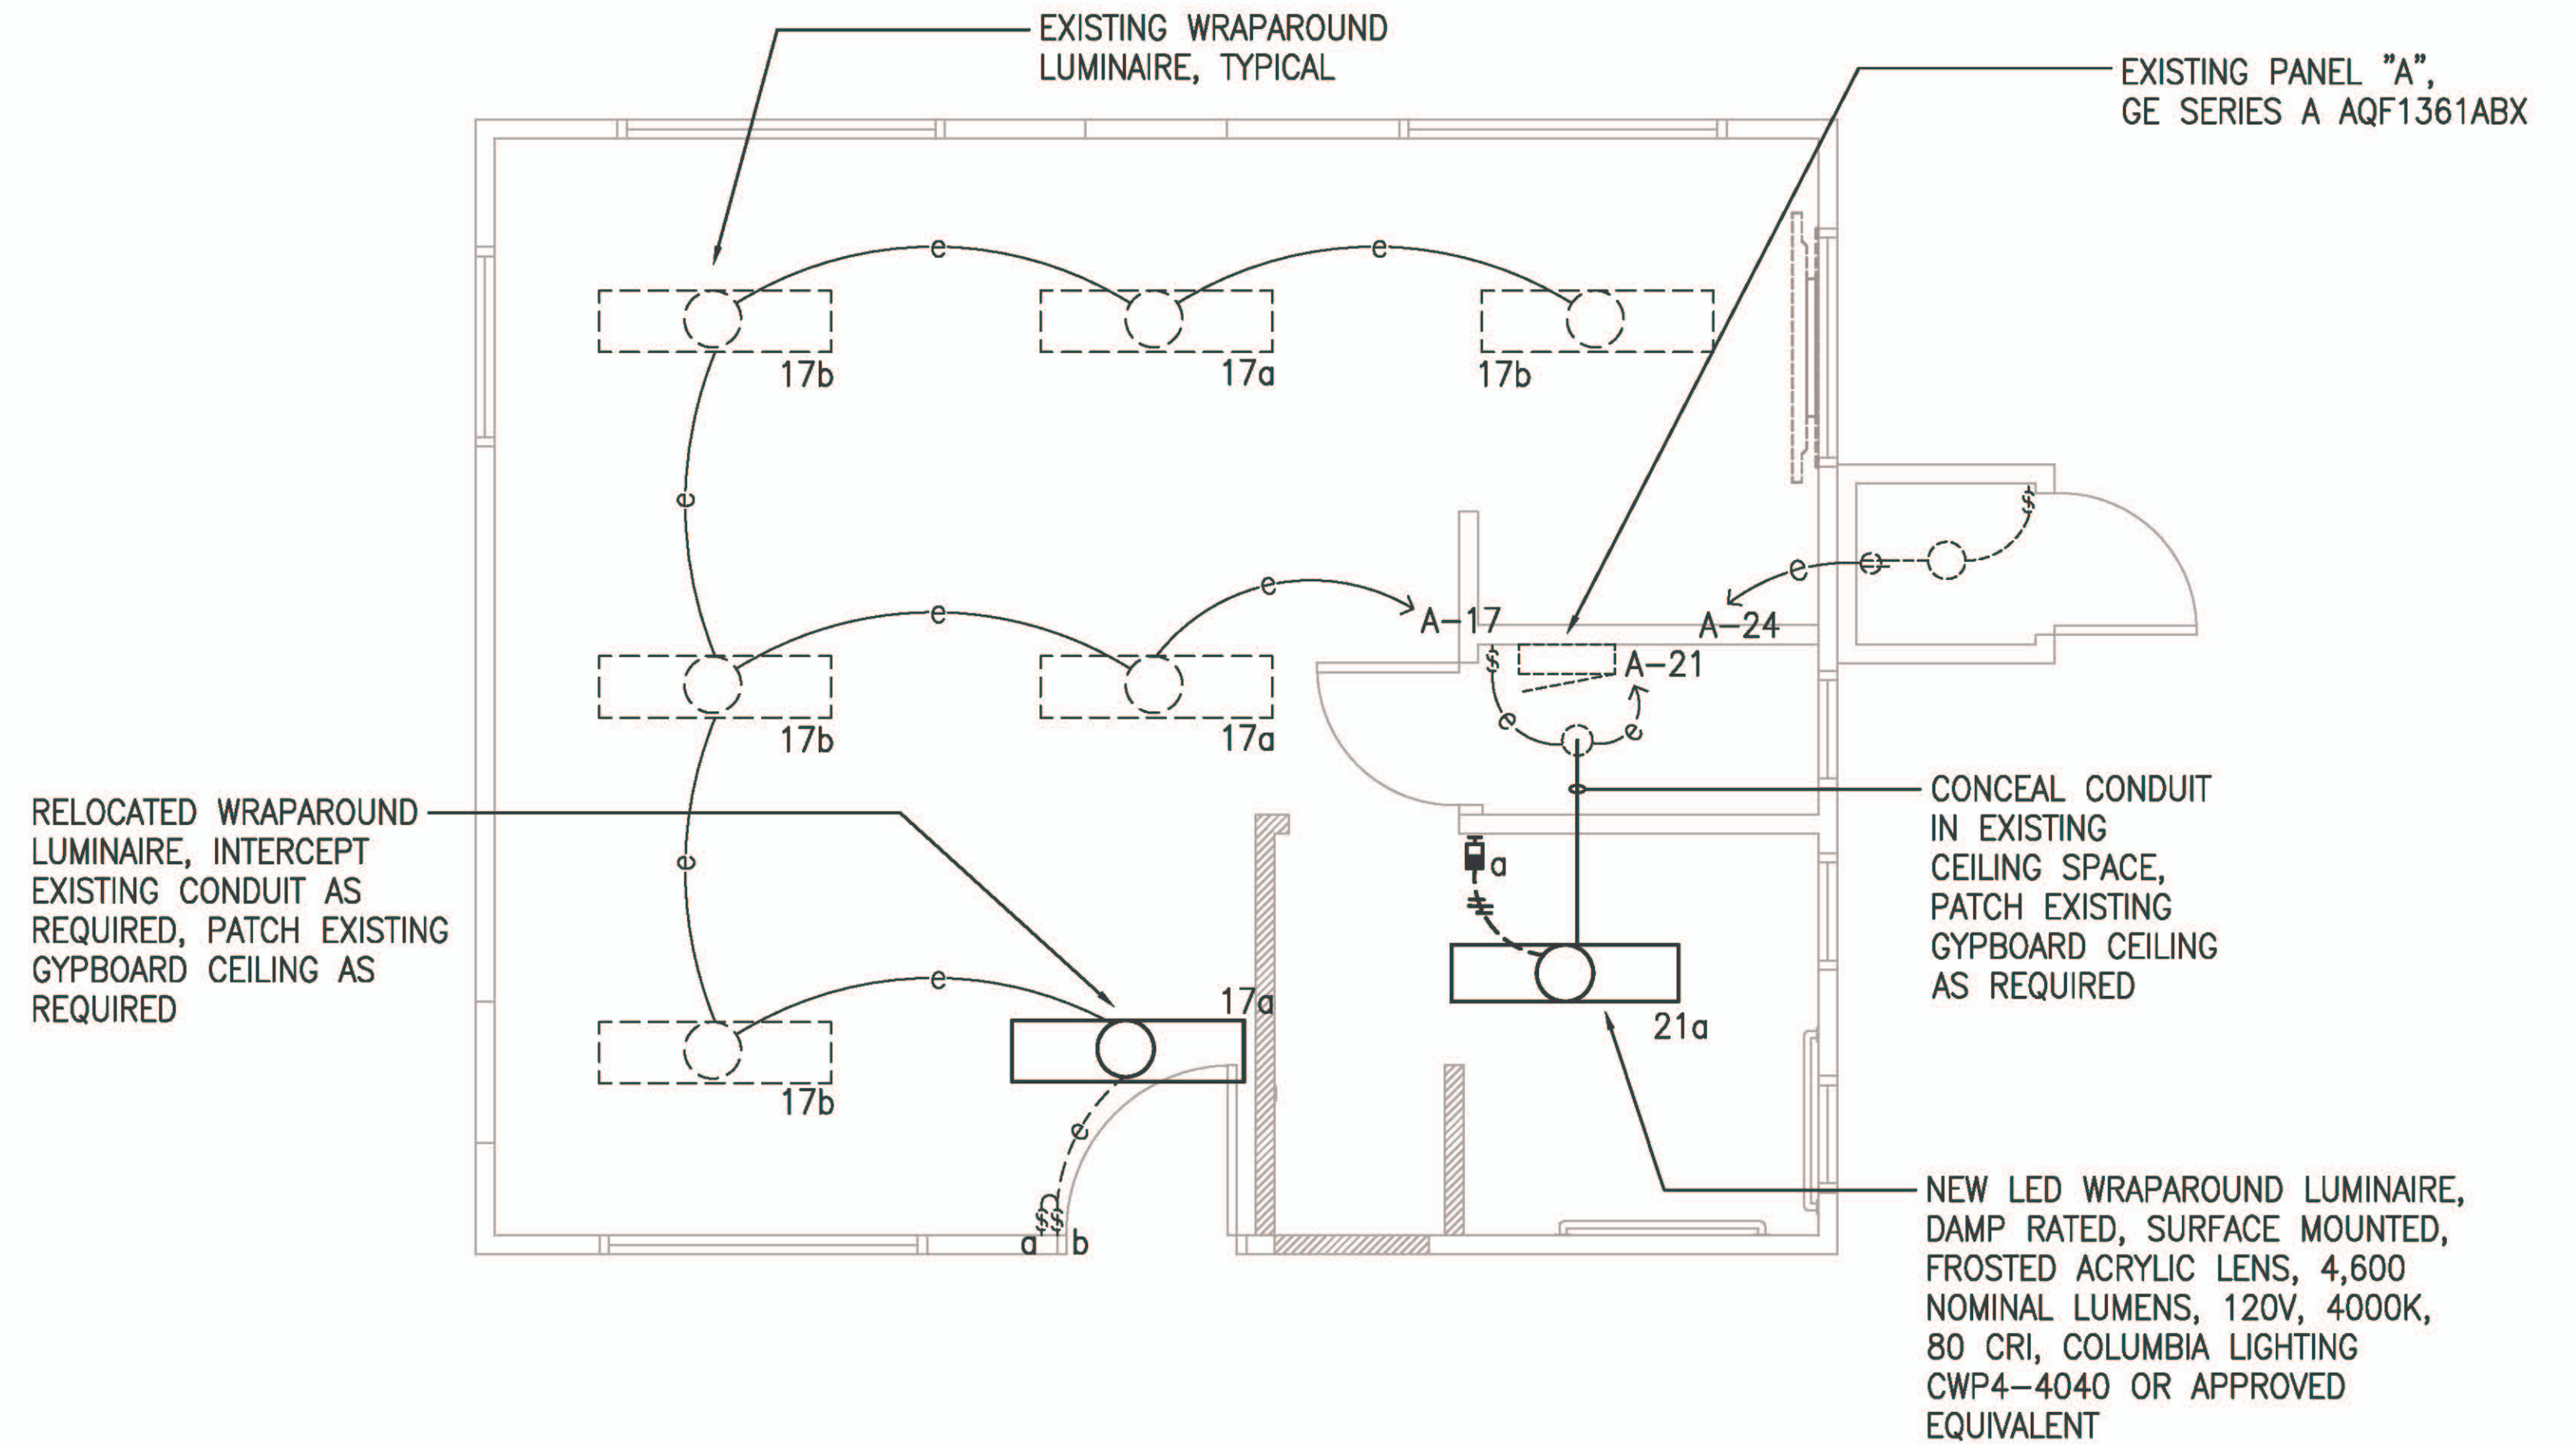

**2 LIGHTING PLAN**  
E-4 SCALE: 3/8" = 1'-0"


**NOTE:**

1. VERIFY EXISTING LIGHTING CIRCUIT ASSIGNMENTS.

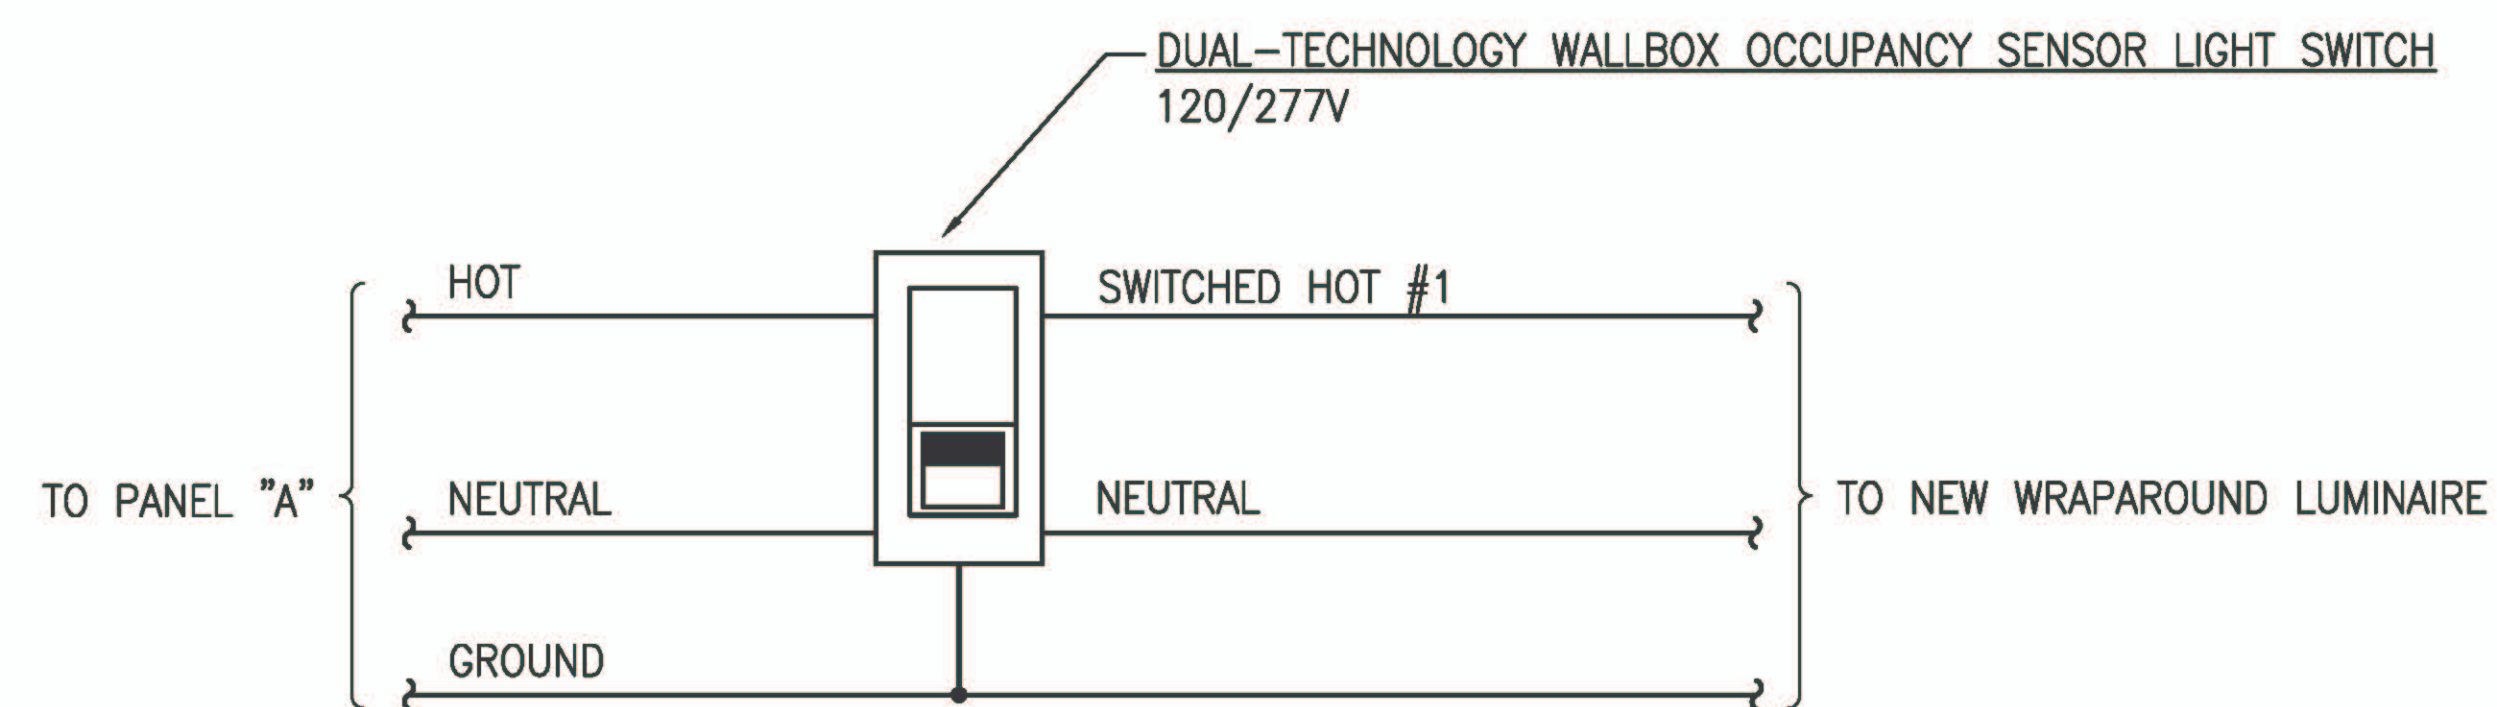

**3 OCCUPANCY SENSOR SWITCH WIRING DIAGRAM**  
E-4 NO SCALE

**GRAPHIC SCALE**

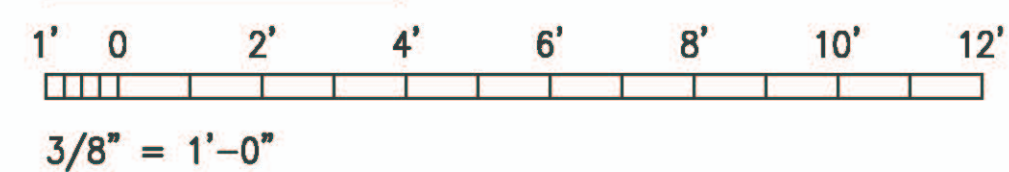

|   |  |                      |             |                 |              |
|---|--|----------------------|-------------|-----------------|--------------|
| <p>THIS WORK WAS PREPARED BY ME OR UNDER MY SUPERVISION</p> <p><i>Michele N. Adolpho</i></p> <p>PROJECT ENGINEER FOR<br/>ECS, INC.</p> <p>APRIL 30, 2024<br/>EXPIRATION DATE OF LICENSE</p> | REV  | DATE                 | DESCRIPTION | BY              | APPROVED     |
|   | STATE OF HAWAII<br>DEPARTMENT OF TRANSPORTATION<br>HARBORS DIVISION  |                      |             |                 |              |
|   | JOB TITLE<br>REPAIR HARBOR AGENT'S OFFICE<br>AT KALAELOA BARBERS POINT HARBOR<br>KALAELOA BARBERS POINT HARBOR, OAHU, HAWAII |                      |             |                 |              |
|   | SHEET TITLE<br>LIGHTING PLAN   |                      |             |                 |              |
|   | DESIGNED BY: JC  | JOB NUMBER<br>S10846 |             |                 | SHEET<br>E-4 |
| DRAWN BY: OL  |  |                      |             | 16 OF 16 SHEETS |              |
| CHECKED BY: MA  |  |                      |             |                 |              |
| DATE<br>JAN. 2023   |  |                      |             |                 |              |
| SCALE<br>AS NOTED   |  |                      |             |                 |              |