
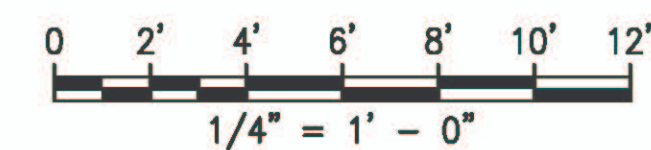
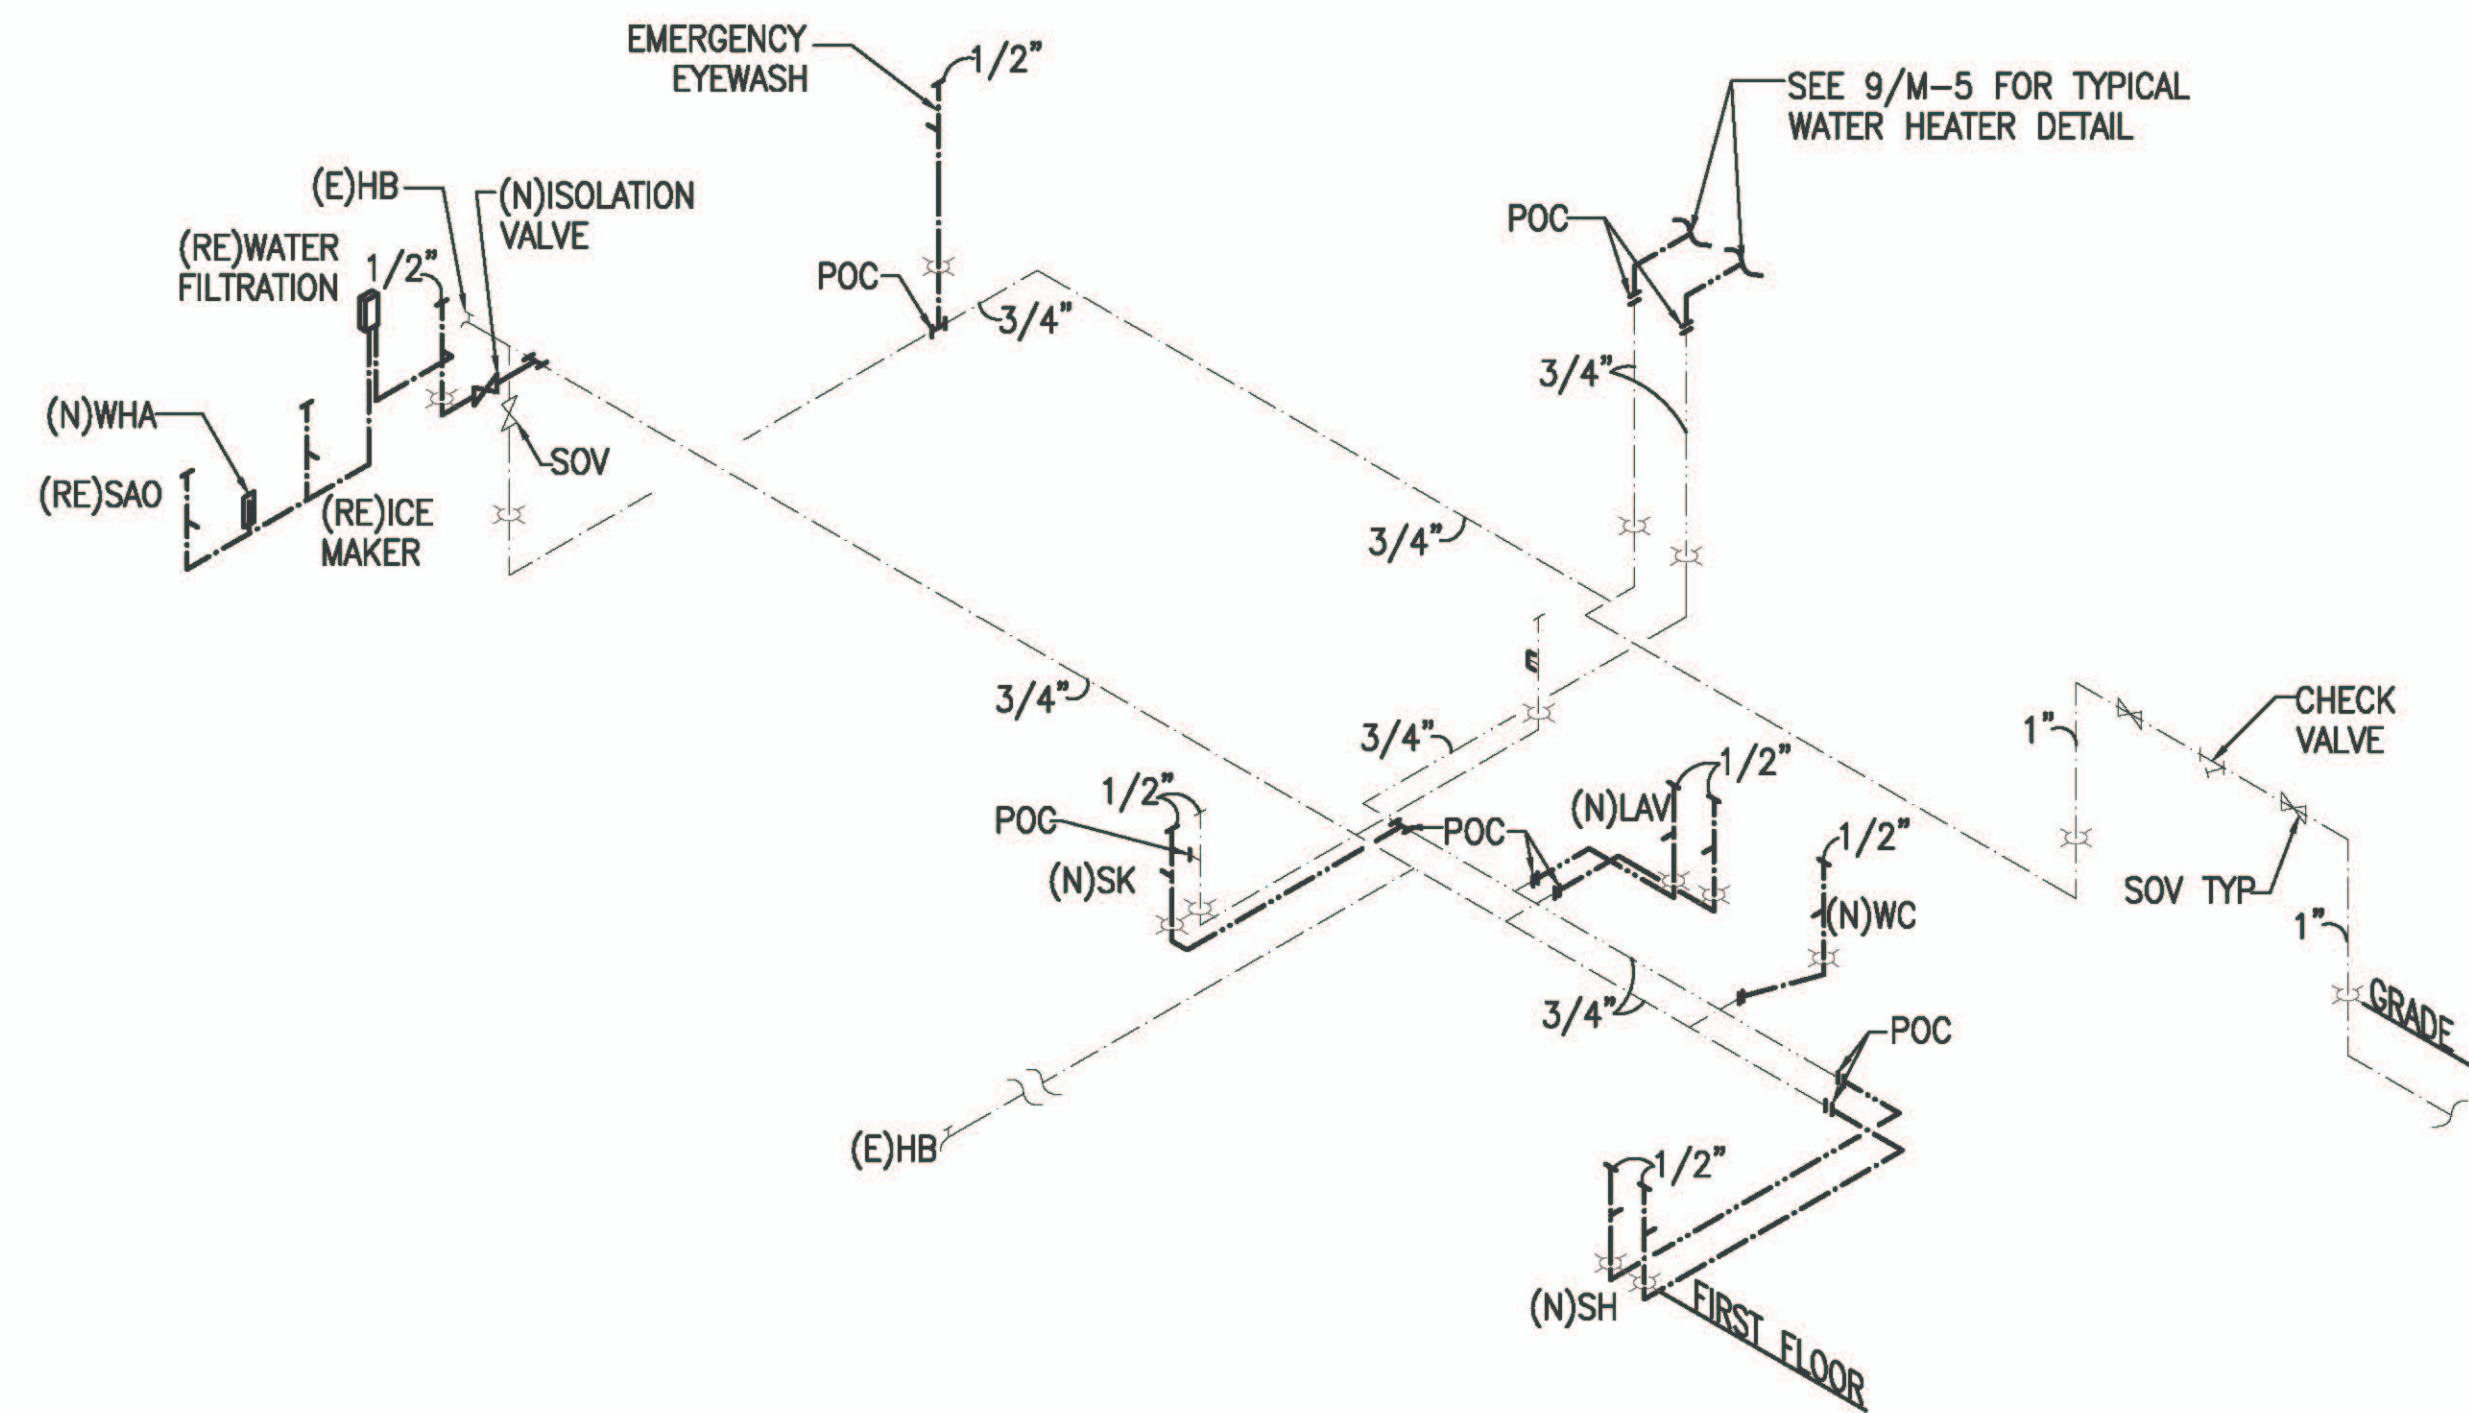


NEW PLUMBING NOTE:

- (P1) PROVIDE AND INSTALL NEW WATER CLOSET COMPLETE. PROVIDE NEW BOWL, TANK, SUPPLY STOP, SUPPLY TUBING, WAX GASKET, FLANGE, ESCUTCHEON, AND ASSOCIATED ACCESSORIES. PROVIDE NEW SANITARY, WATER, AND VENT PIPING AS SHOWN IN NEW PLUMBING PLAN UP TO POC. PATCH/REPAIR FLOORS AND WALLS TO MATCH EXISTING. CONTRACTOR TO FIELD VERIFY.
- (P2) PROVIDE AND INSTALL NEW SHOWER COMPLETE. PROVIDE NEW SHOWER DRAIN, VALVE KIT, TRIM KIT, SHOWER HEAD, P-TRAP, AND ASSOCIATED ACCESSORIES. PROVIDE NEW SANITARY, WATER, AND VENT PIPING AS SHOWN IN NEW PLUMBING FLOOR PLAN UP TO POC. PATCH/REPAIR WALLS, AND FLOORS TO MATCH EXISTING. CONTRACTOR TO FIELD VERIFY.
- (P3) PROVIDE AND INSTALL NEW LAVATORY COMPLETE. PROVIDE NEW BOWL, P-TRAP, SUPPLY STOPS, SUPPLY TUBING, ESCUTCHEONS, FAUCET, AND ASSOCIATED ACCESSORIES. PROVIDE NEW SANITARY, WATER, AND VENT PIPING AS SHOWN IN NEW PLUMBING FLOOR PLAN UP TO POC. PATCH/REPAIR FLOORS, WALLS TO MATCH EXISTING. CONTRACTOR TO FIELD VERIFY.
- (P4) PROVIDE AND INSTALL NEW SINK COMPLETE. PROVIDE NEW FAUCET, P-TRAP, ESCUTCHEON, SUPPLY STOPS, SUPPLY TUBING, ETC. PROVIDE NEW SANITARY, VENT, AND WATER PIPING AS REQUIRED UP TO POC AS SHOWN IN NEW PLUMBING PLAN. PATCH/REPAIR WALLS AND FLOORS TO MATCH EXISTING. CONTRACTOR TO FIELD VERIFY.
- (P5) PROVIDE AND INSTALL NEW FLOOR SINK COMPLETE. PROVIDE NEW SANITARY, AND VENT PIPING AS SHOWN IN NEW PLUMBING PLAN. PATCH/REPAIR WALLS, FLOORS TO MATCH EXISTING. CONTRACTOR TO FIELD VERIFY.
- (P6) RE-INSTALL EXISTING ICE MAKER COMPLETE. PROVIDE NEW WATER PIPING FROM WATER FILTRATION SYSTEM AS REQUIRED. PROVIDE NEW SANITARY PIPING TO NEW FLOOR SINK AS SHOWN IN NEW PLUMBING PLAN. CONTRACTOR TO FIELD VERIFY.
- (P7) RE-INSTALL SAO COMPLETE. PROVIDE NEW WATER PIPING FROM WATER FILTRATION SYSTEM AS REQUIRED TO SAO. CONTRACTOR TO FIELD VERIFY.
- (P8) PROVIDE AND INSTALL NEW EMERGENCY EYEWASH COMPLETE. INCLUDING, BUT NOT LIMITED TO WALL BRACKET MOUNT, STAINLESS STEEL BOWL, FLAG HANDLE, STAY-OPEN BALL VALVE, AND ASSOCIATED ACCESSORIES. PROVIDE NEW 1/2" WATER PIPING AS SHOWN ON PLAN. PROVIDE NEW PVC SANITARY PIPING FROM EMERGENCY EYEWASH CONNECTION TO TERMINATE 6" ABOVE GRADE INTO GRASS AREA. CONTRACTOR TO FIELD VERIFY.

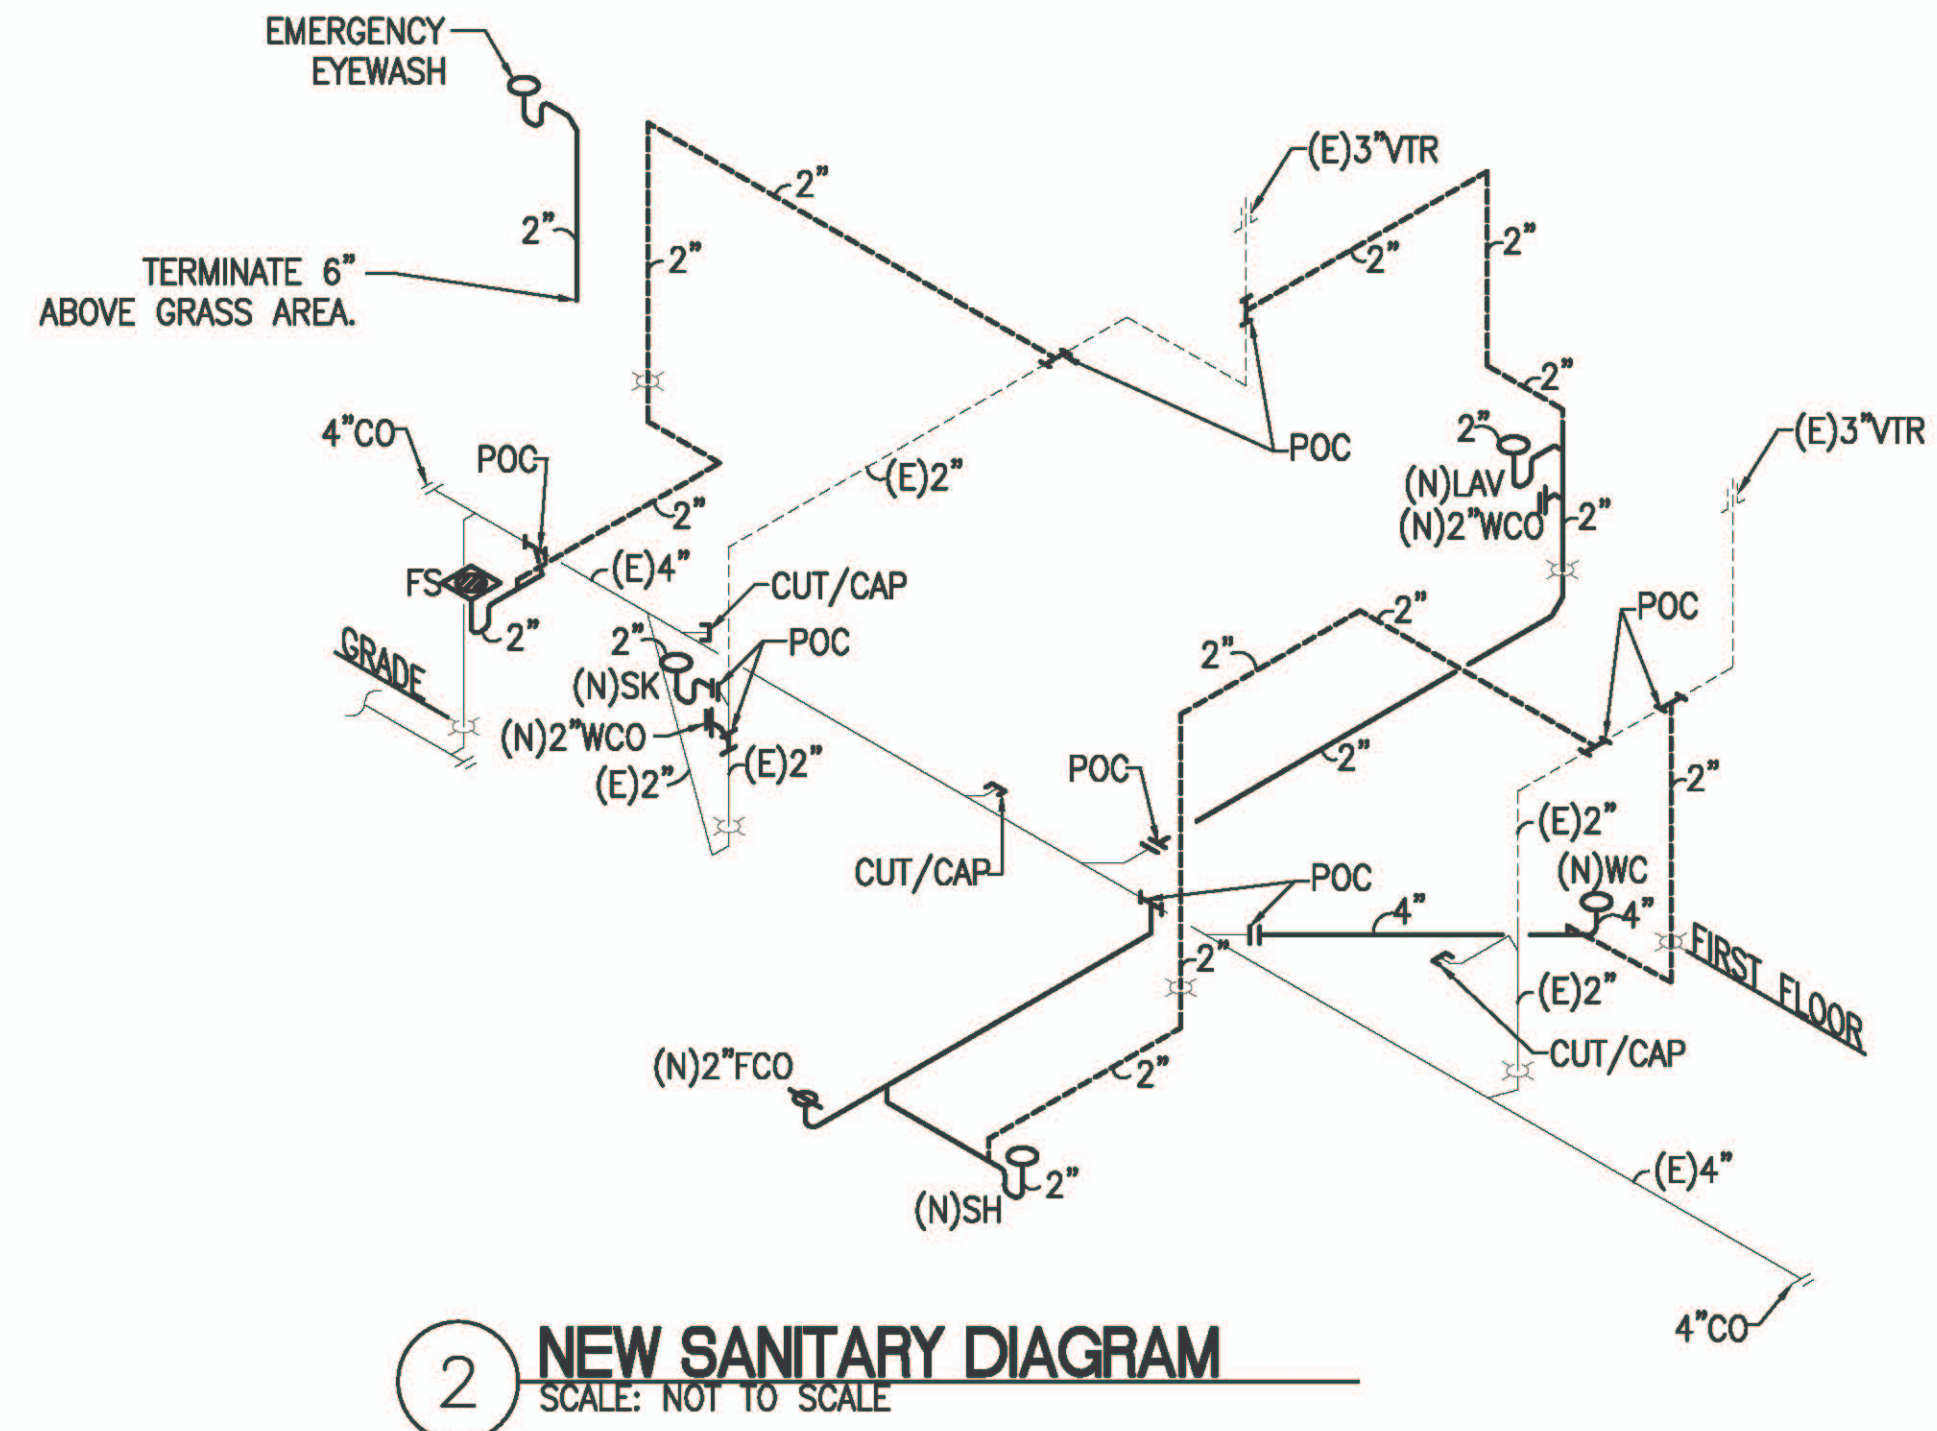

THIS WORK WAS PREPARED BY ME
OR UNDER MY SUPERVISION

DESIGNED BY: MEI
DRAWN BY: MEI
CHECKED BY: RRT
DATE: JAN. 2023
EXPIRATION DATE OF LICENSE: APRIL 30, 2024

REV	DATE	DESCRIPTION	BY	APPROVED
STATE OF HAWAII DEPARTMENT OF TRANSPORTATION HARBORS DIVISION				
JOB TITLE REPAIR HARBOR AGENT'S OFFICE AT KALAELOA BARBERS POINT HARBOR KALAELOA BARBERS POINT HARBOR, OAHU, HAWAII				
SHEET TITLE NEW PLUMBING FLOOR PLAN				
DESIGNED BY: MEI			SHEET	
DRAWN BY: MEI			M-3	
CHECKED BY: RRT			10 OF 16 SHEETS	
DATE: JAN. 2023				
SCALE: AS NOTED		JOB NUMBER S10846		