



EXISTING LIGHT POLE ASSEMBLY,
TYPICAL

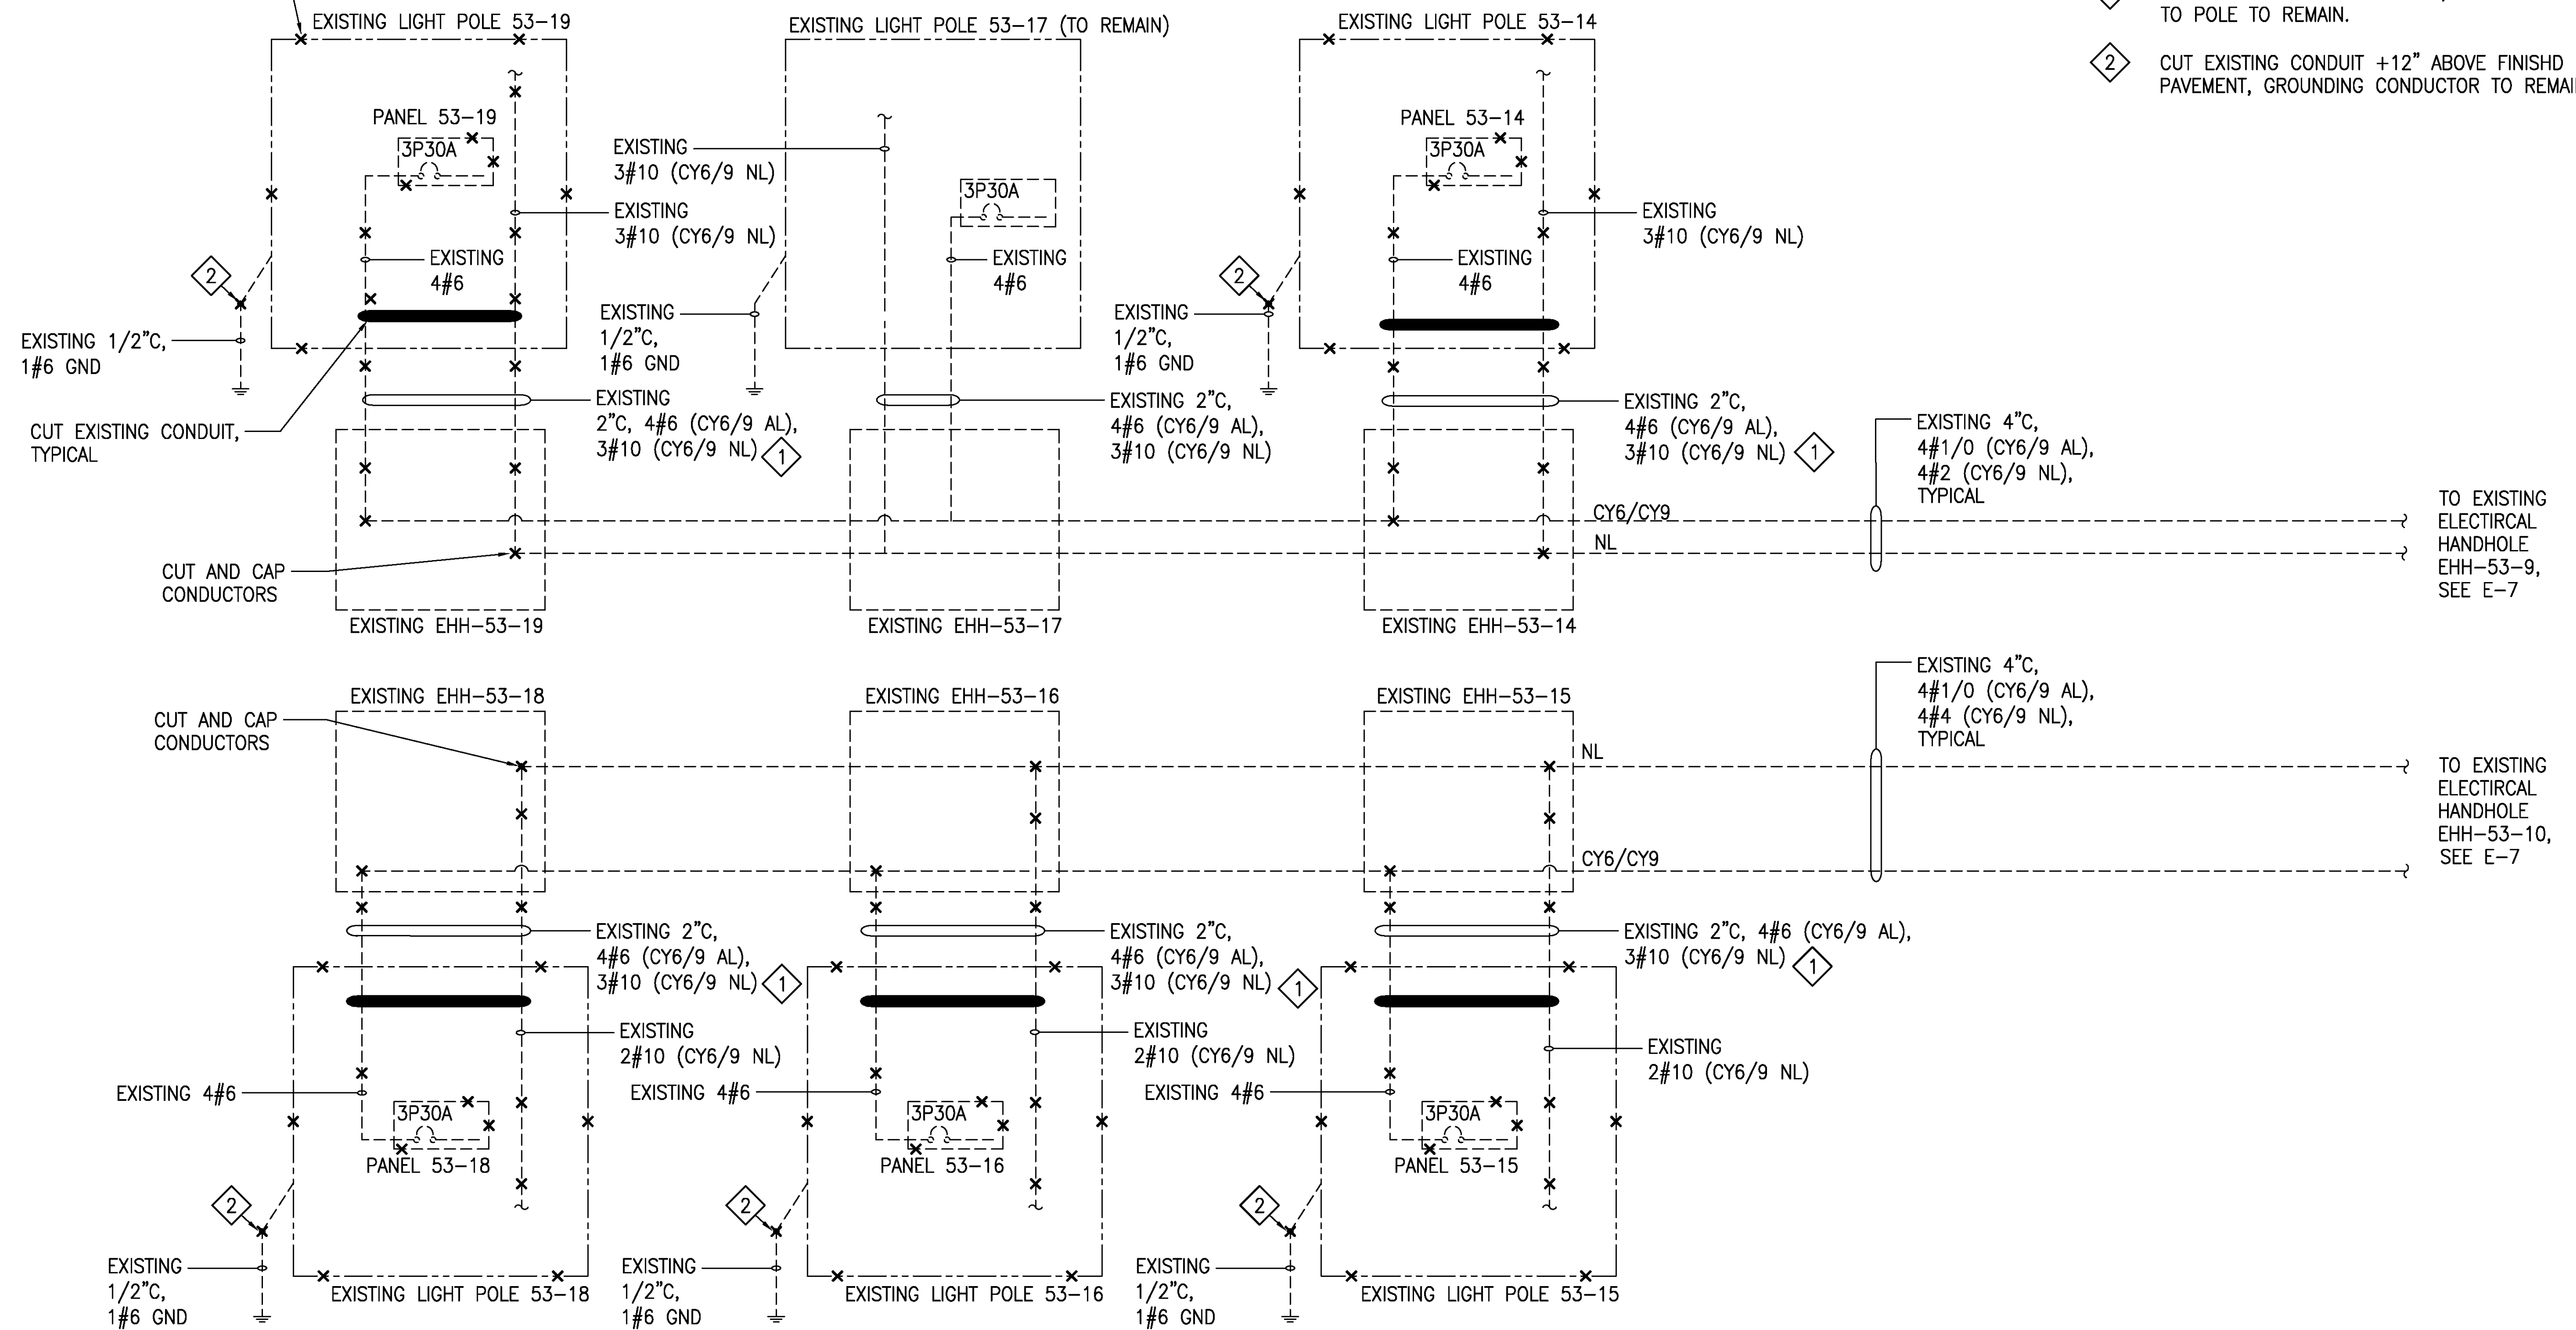

NOTES:

- 1 REMOVE EXISTING CONDUCTORS, CONDUIT STUB-UP TO POLE TO REMAIN.
- 2 CUT EXISTING CONDUIT +12" ABOVE FINISHED PAVEMENT, GROUNDING CONDUCTOR TO REMAIN.

1
E-7 DEMOLITION ONE-LINE DIAGRAM - 2
NO SCALE

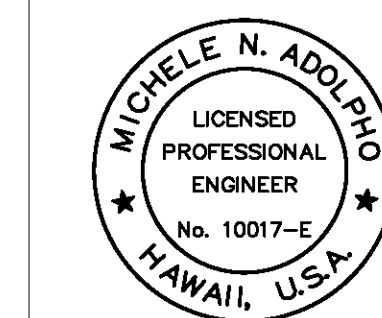

THIS WORK WAS PREPARED BY ME
OR UNDER MY SUPERVISION
EXP. 4-30-24
Michele N. Adolp
ECS, INC.

REVISION	DATE	DESCRIPTION	BY	APPROVED
STATE OF HAWAII DEPARTMENT OF TRANSPORTATION HARBORS DIVISION				
JOB TITLE REPAIR LIGHT POLES AND PEDESTALS AT PIER 53 HONOLULU HARBOR, OAHU, HAWAII				
SHEET TITLE DEMOLITION ONE-LINE DIAGRAM - 2				
DESIGNED BY: JC	JOB NUMBER S10859			SHEET E-8
DRAWN BY: CAD				13 of 18 SHEETS
CHECKED BY: M.A.				
DATE: 04/2023 SCALE: AS SHOWN				