



| INDEX TO DRAWINGS | |
|-------------------|---|
| SHEET NO. | TITLE |
| T-1 | TITLE SHEET, LOCATION AND VICINITY MAPS |
| T-2 | INDEX TO DRAWINGS AND GENERAL PLAN |
| S-1 | STRUCTURAL NOTES |
| S-2 | LIGHT POLE REPAIR DETAILS |
| S-3 | LIGHT POLE REPAIR DETAILS |
| E-1 | ELECTRICAL SYMBOL LIST, GENERAL NOTES |
| E-2 | OVERALL ELECTRICAL SITE PLAN |
| E-3 | EXISTING LIGHT POLE DETAIL - DEMOLITION PLAN |
| E-4 | LIGHT POLE DETAIL |
| E-5 | NEW LIGHT POLE BASE DETAIL |
| E-6 | LIGHT POLE MOUNTING BRACKET - DEMOLITION AND NEW PLANS |
| E-7 | DEMOLITION ONE-LINE DIAGRAM - 1 |
| E-8 | DEMOLITION ONE-LINE DIAGRAM - 2 |
| E-9 | ONE-LINE DIAGRAM - 1 |
| E-10 | ONE-LINE DIAGRAM - 2 |
| E-11 | TYPICAL LIGHT POLE CONNECTION DIAGRAM - DEMOLITION WORK |
| E-12 | TYPICAL LIGHT POLE CONNECTION DIAGRAM |
| E-13 | PANEL SCHEDULES |

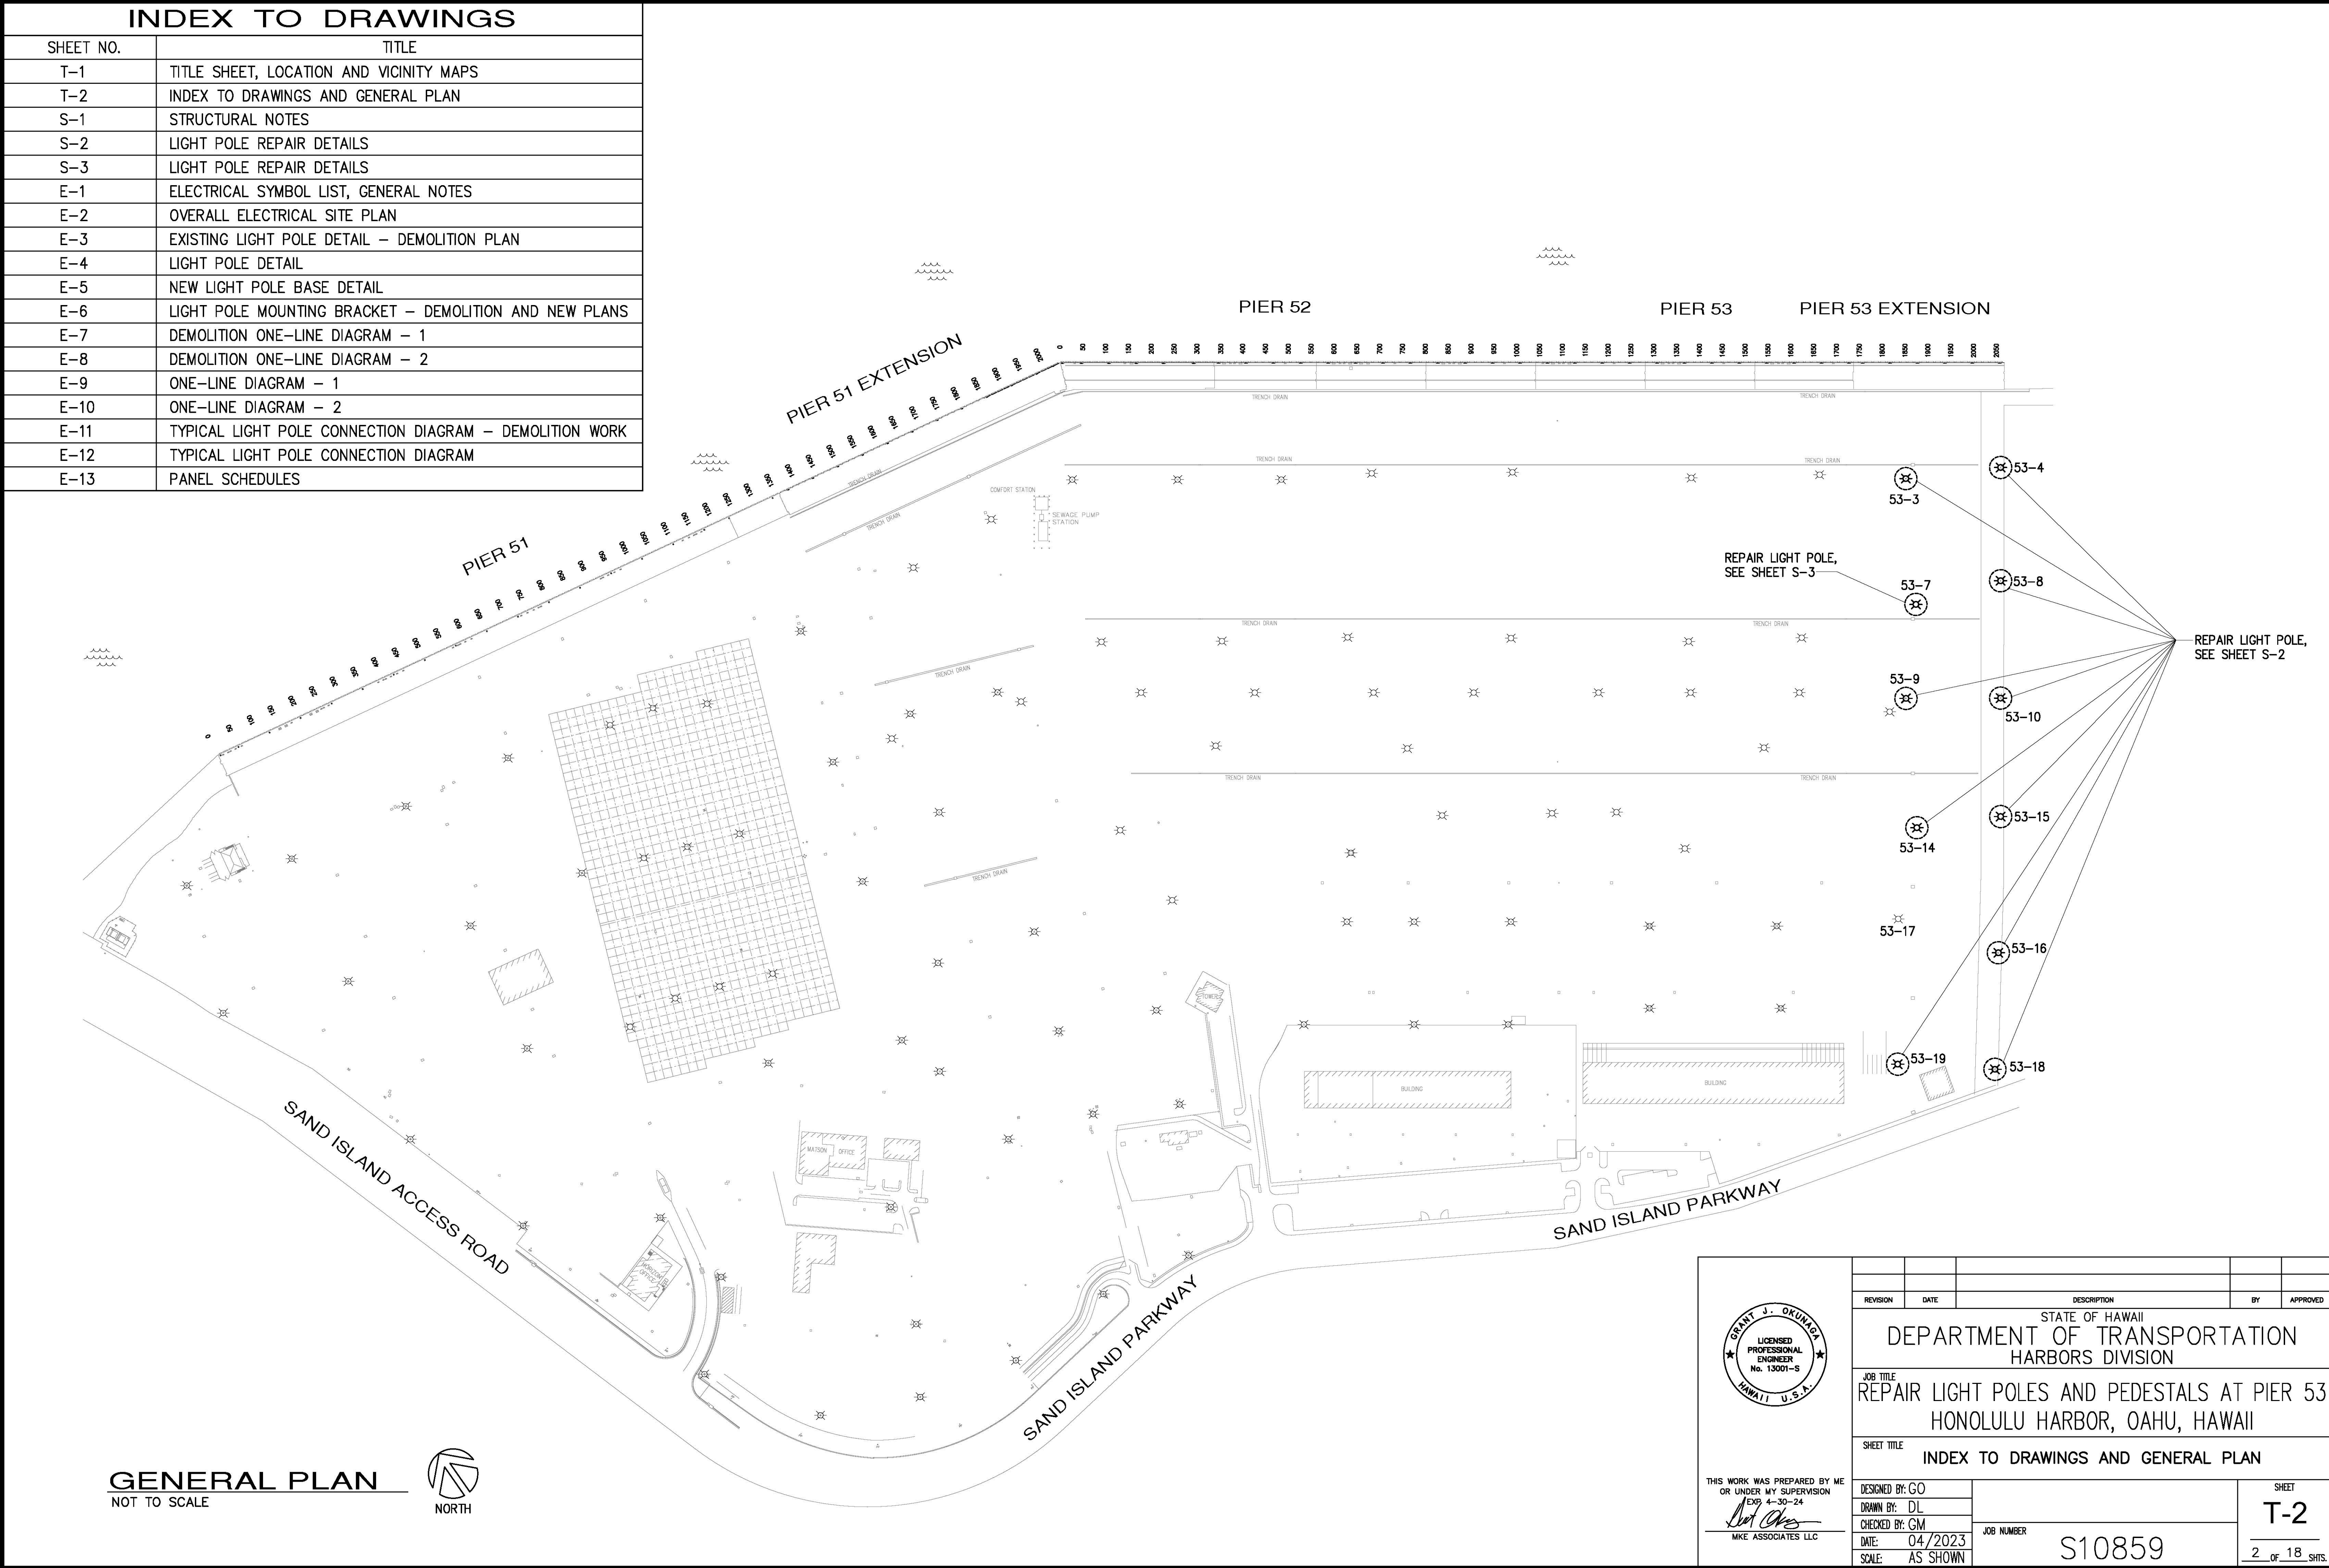

GENERAL PLAN
NOT TO SCALE

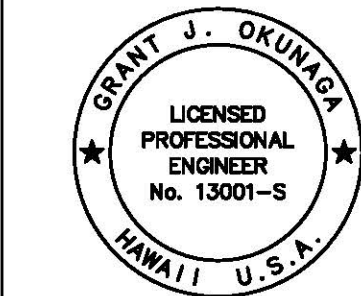

THIS WORK WAS PREPARED BY ME
OR UNDER MY SUPERVISION
EXP. 4-30-24
Grant J. Okunaga
MKE ASSOCIATES LLC

| REVISION | DATE | DESCRIPTION | BY | APPROVED |
|---|----------------------|-------------|---------------|----------|
| STATE OF HAWAII DEPARTMENT OF TRANSPORTATION HARBORS DIVISION | | | | |
| JOB TITLE REPAIR LIGHT POLES AND PEDESTALS AT PIER 53 HONOLULU HARBOR, OAHU, HAWAII | | | | |
| SHEET TITLE INDEX TO DRAWINGS AND GENERAL PLAN | | | | |
| DESIGNED BY: GO | JOB NUMBER S10859 | | SHEET T-2 | |
| DRAWN BY: DL | | | | |
| CHECKED BY: GM | | | | |
| DATE: 04/2023 | | | | |
| SCALE: AS SHOWN | | | 2 of 18 SHTS. | |