



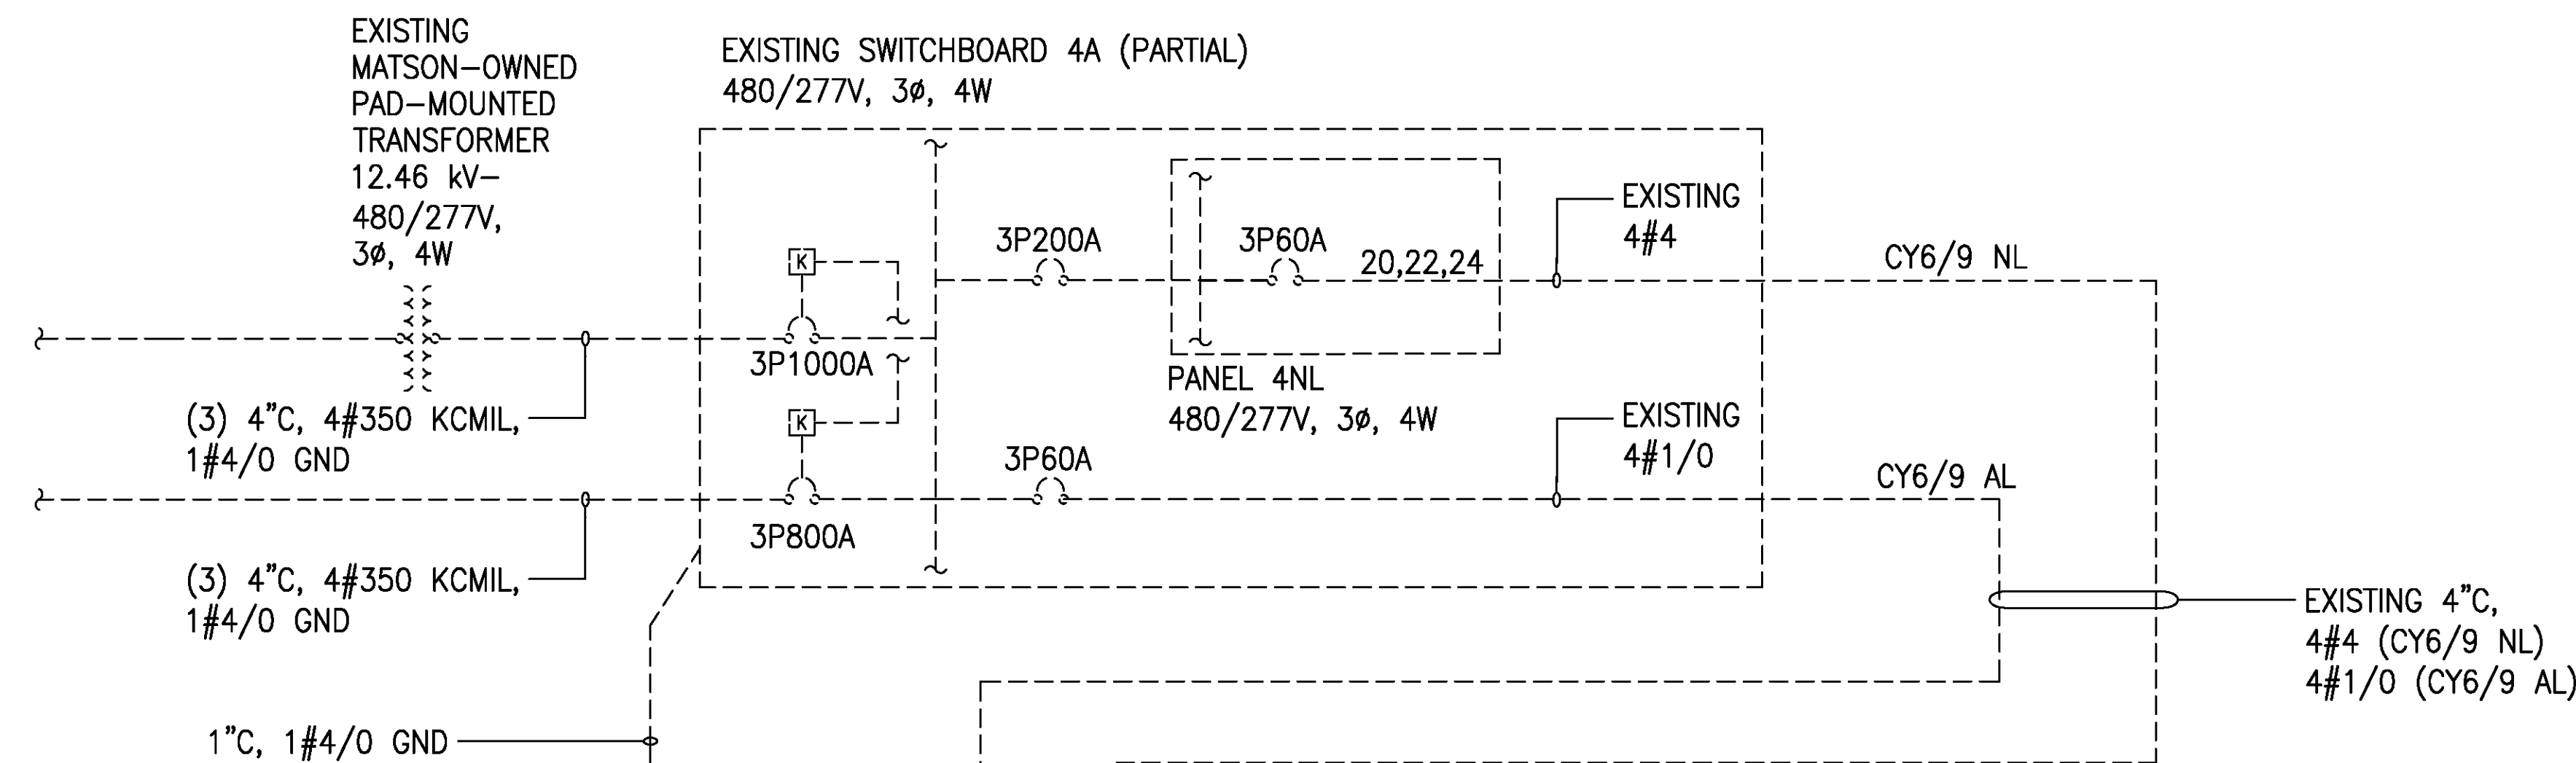

NOTES:


- 1 EXISTING CONDUCTORS CAPPED IN HANDHOLE.
2. UNLESS OTHERWISE INDICATED, SOLID LINES INDICATE NEW WORK. DASHED LINES INDICATE EXISTING EQUIPMENT.
- 3 COUPLE TO EXISTING CONDUIT CONTAINING EXISTING GROUNDING CONDUCTOR TO NEW CONDUIT.

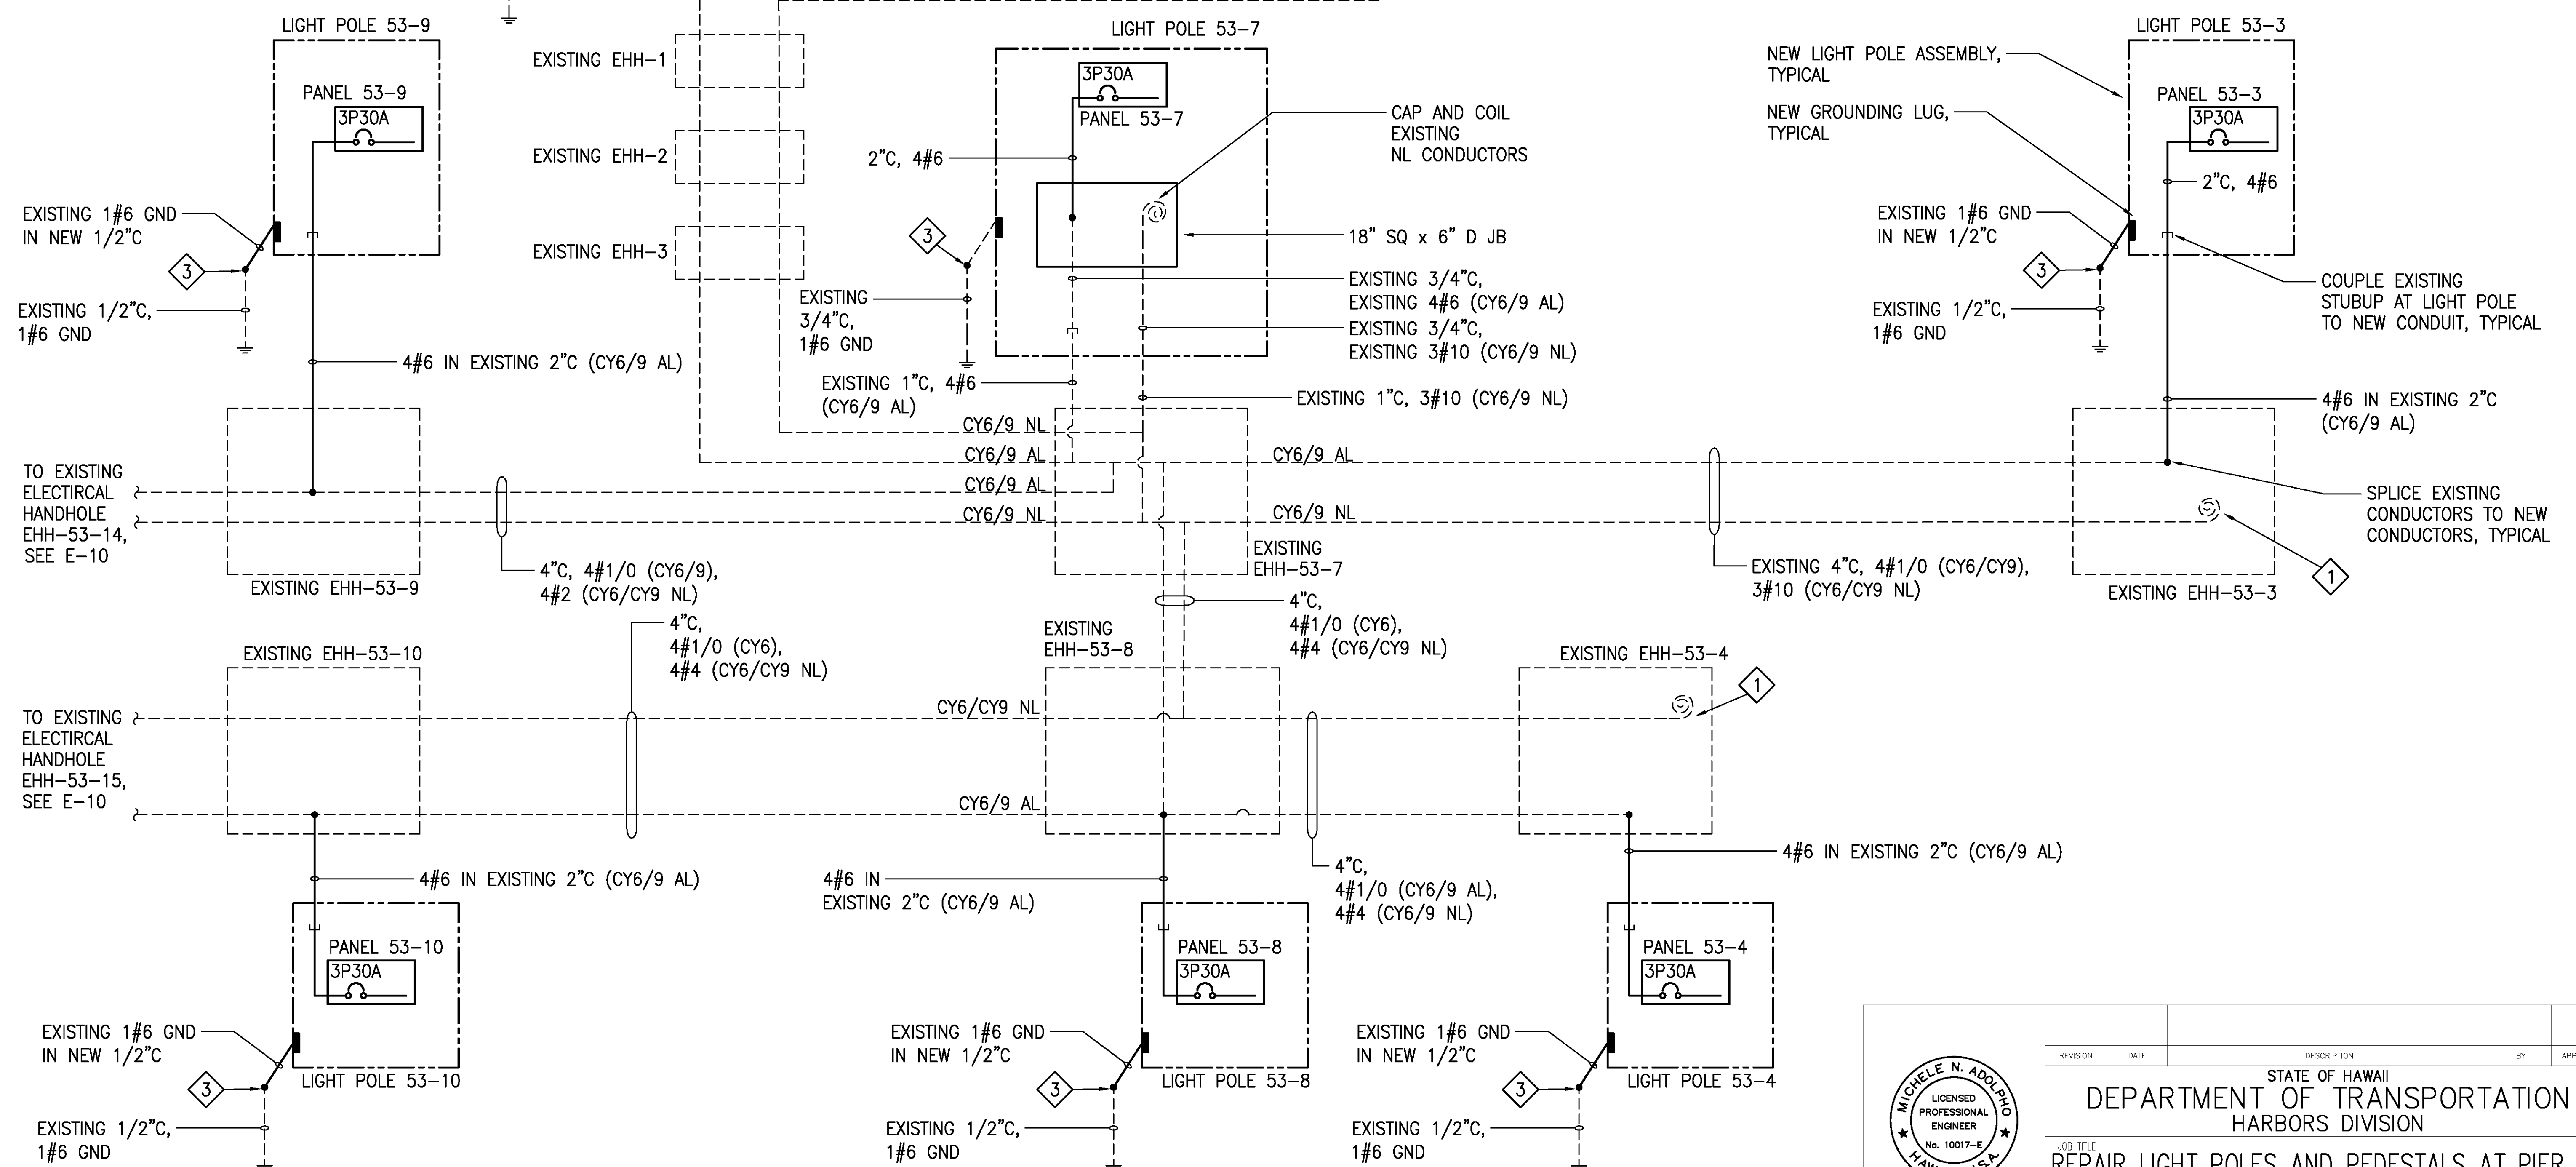


1 ONE-LINE DIAGRAM - 1
E-9 NO SCALE

		STATE OF HAWAII DEPARTMENT OF TRANSPORTATION HARBORS DIVISION	
JOB TITLE REPAIR LIGHT POLES AND PEDESTALS AT PIER 53 HONOLULU HARBOR, OAHU, HAWAII			
SHEET TITLE ONE-LINE DIAGRAM - 1			
DESIGNED BY: JC DRAWN BY: CAD CHECKED BY: M.A. DATE: 04/2023 SCALE: AS SHOWN	JOB NUMBER S10859	SHEET E-9 14 of 18 SHTS.	

4/25/23-16:50 Y:\044\044.088 Pier 53 Repair Elec Panels\044.088 E-9-E-10.R03.R04.dwg

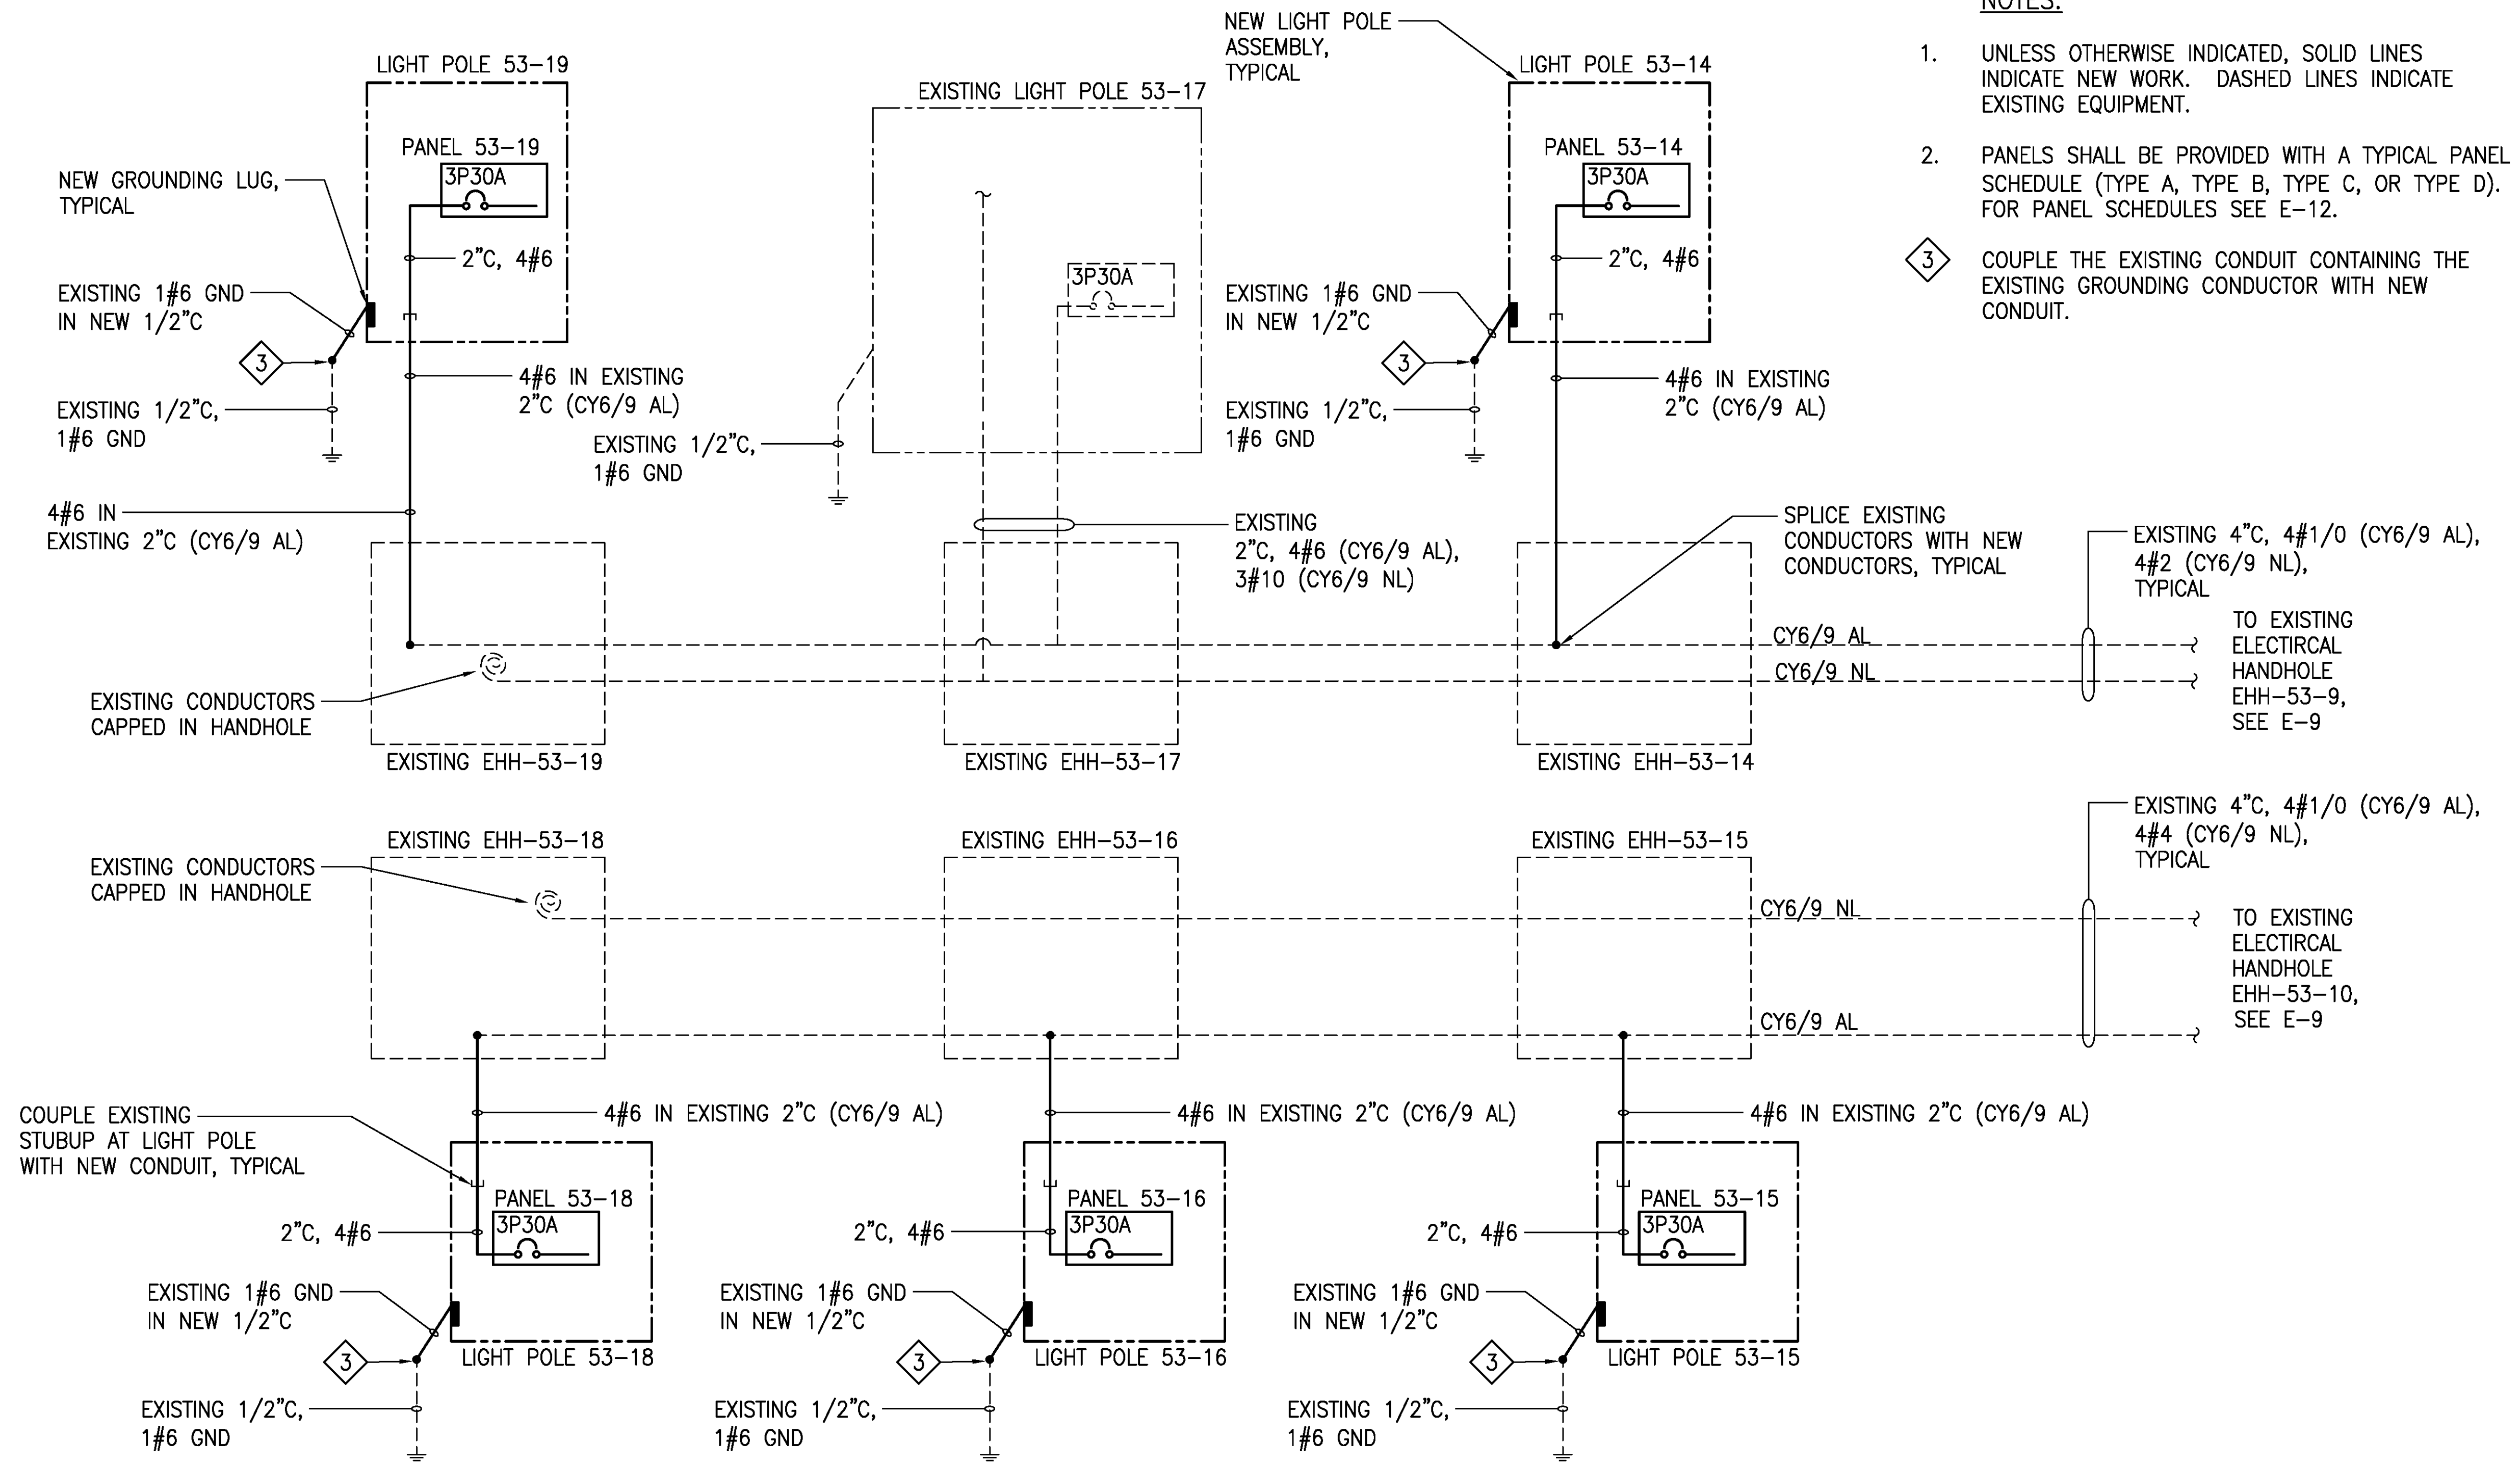

2 ONE-LINE DIAGRAM - 2
E-10 NO SCALE

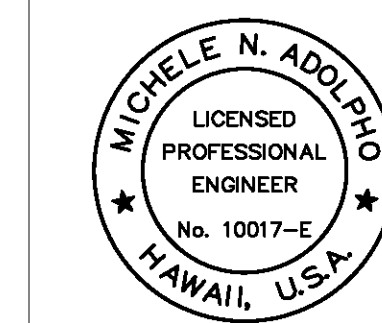

THIS WORK WAS PREPARED BY ME
OR UNDER MY SUPERVISION
EXP. 4-30-24
Michele N. Adolp
ECS, INC.

REVISION	DATE	DESCRIPTION	BY	APPROVED
STATE OF HAWAII DEPARTMENT OF TRANSPORTATION HARBORS DIVISION				
JOB TITLE REPAIR LIGHT POLES AND PEDESTALS AT PIER 53 HONOLULU HARBOR, OAHU, HAWAII				
SHEET TITLE ONE-LINE DIAGRAM - 2				
DESIGNED BY: JC		JOB NUMBER S10859		SHEET E-10 15 of 18 SHITS
DRAWN BY: CAD				
CHECKED BY: MA				
DATE: 04/2023				
SCALE: AS SHOWN				