



NOTE:

- 1 REMOVE LIGHT POLE, NEW LIGHT POLE TO BE INSTALLED ON EXISTING CONCRETE FOUNDATION. REMOVE, SALVAGE, AND STORE EXISTING LUMINAIRES FOR REINSTALLATION ON NEW LIGHT POLE.

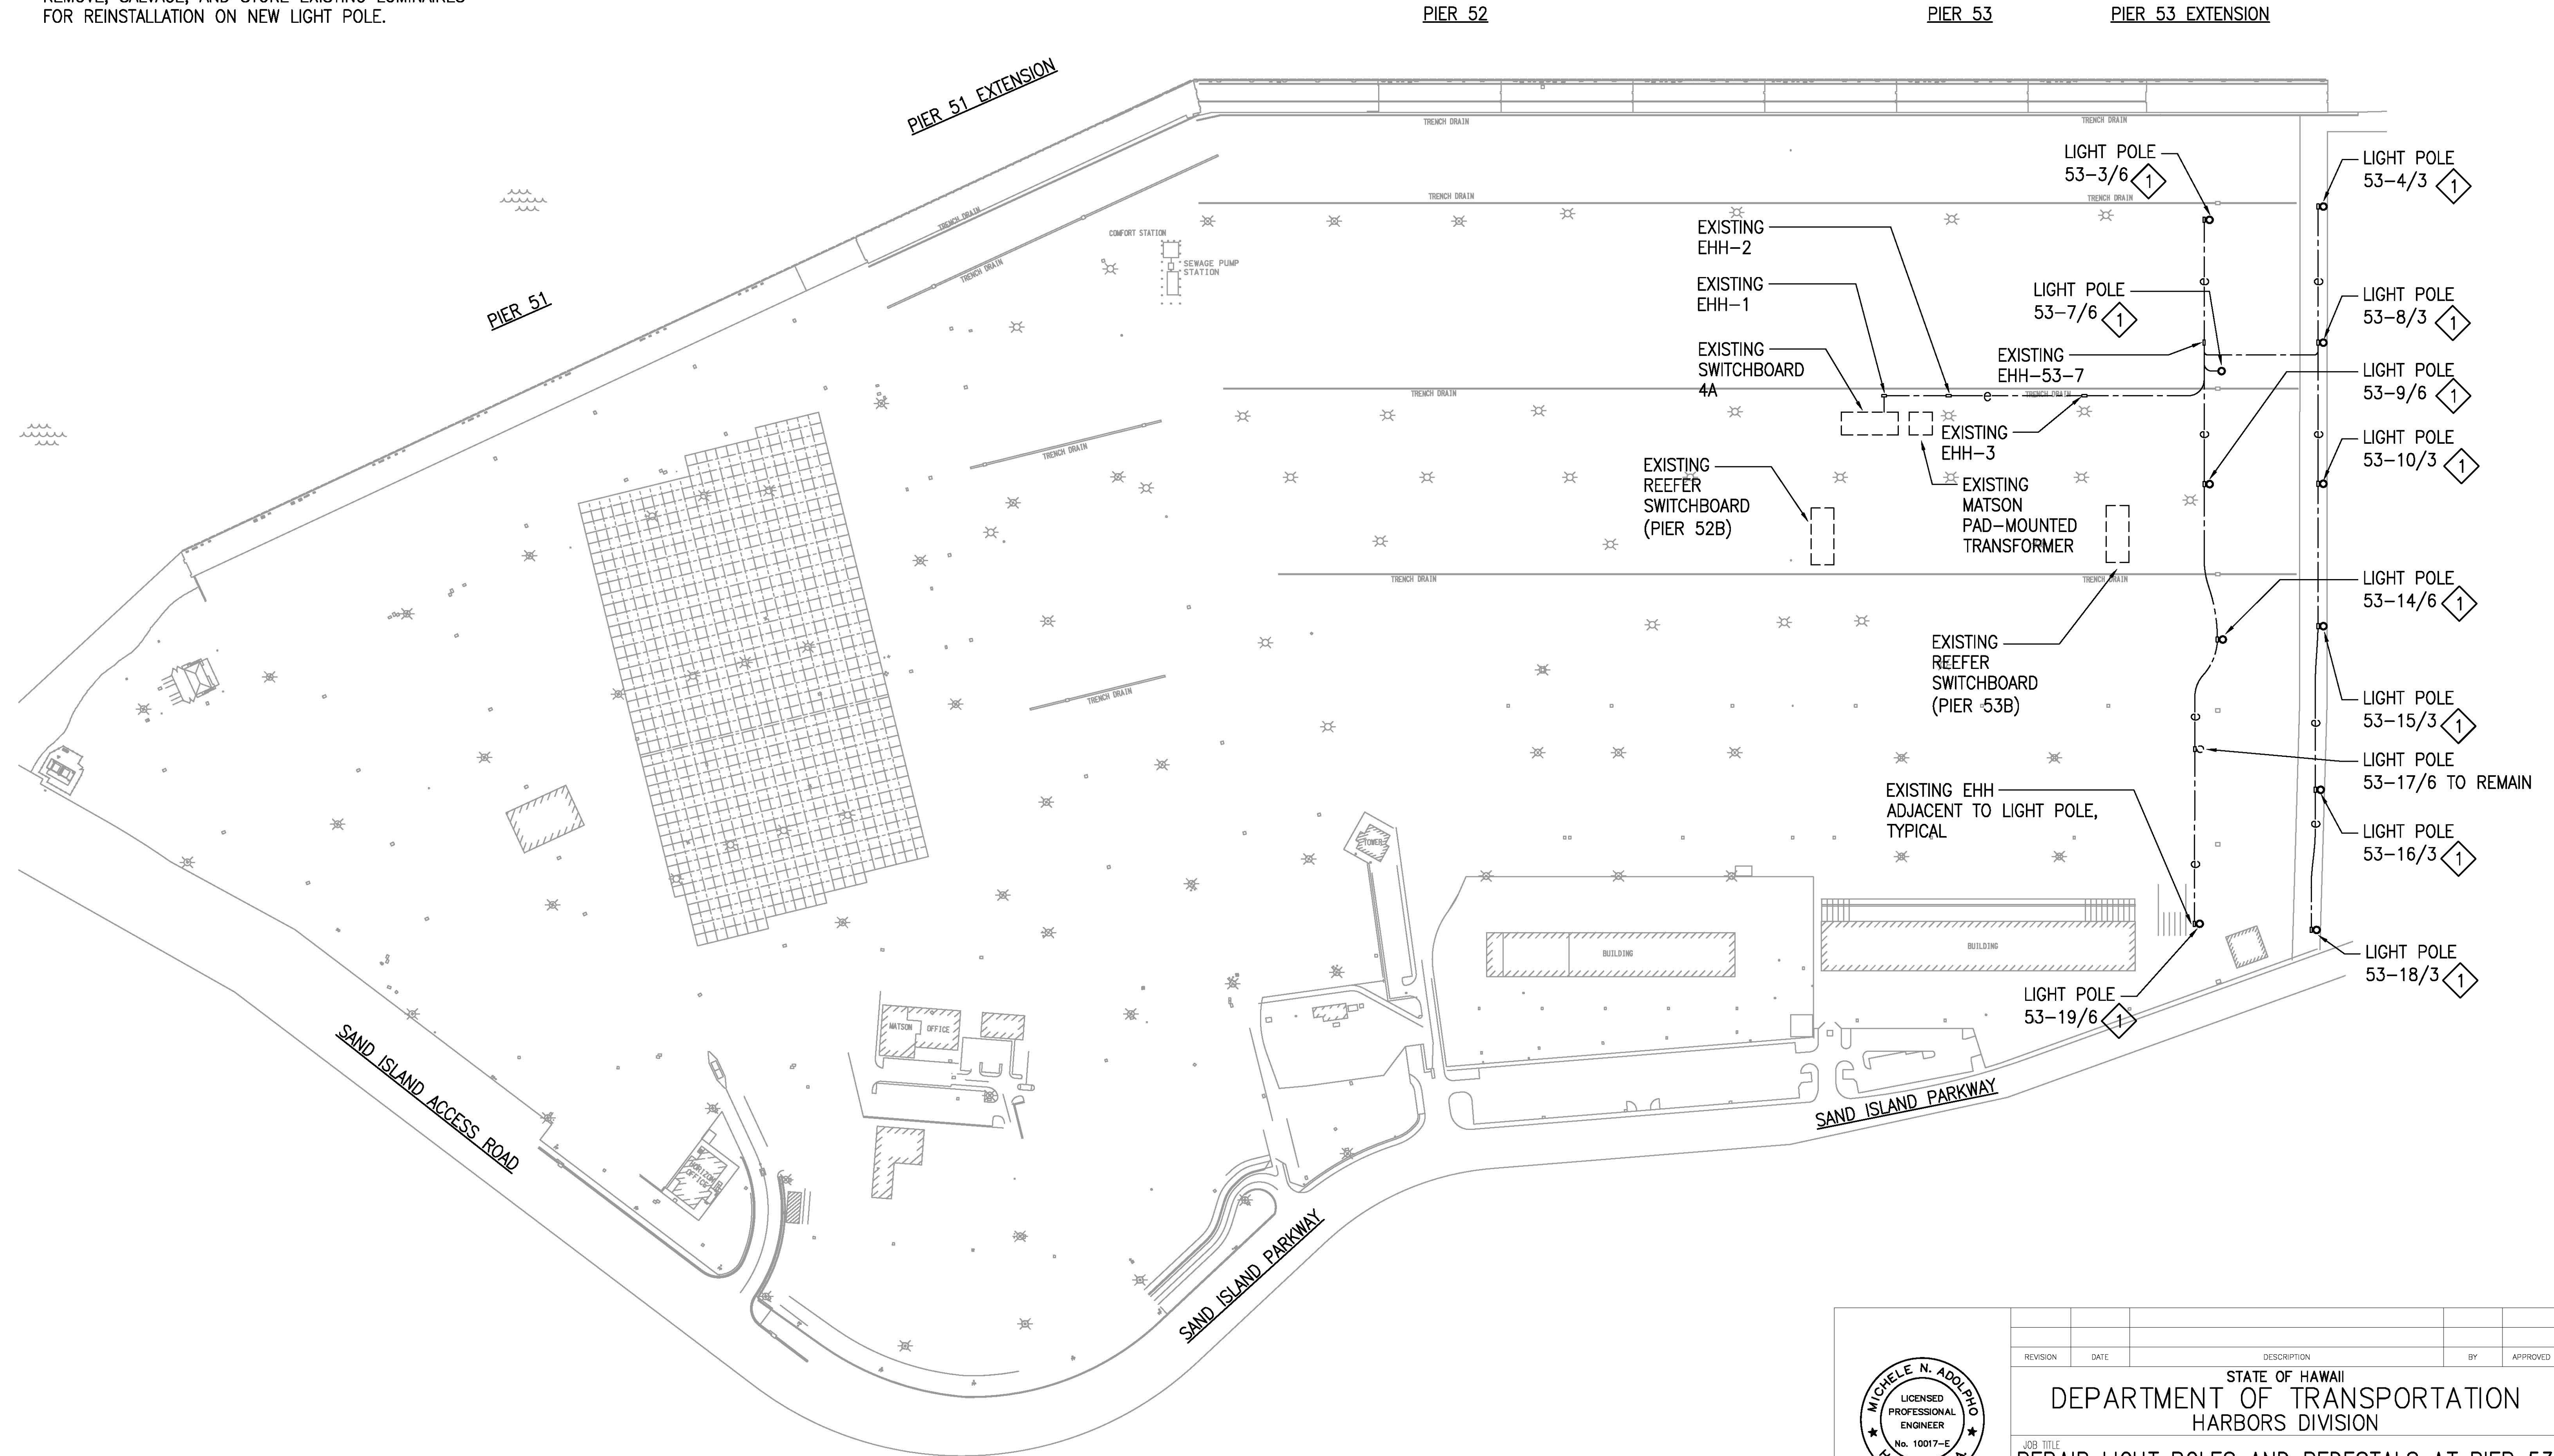

OVERALL ELECTRICAL SITE PLAN
NOT TO SCALE

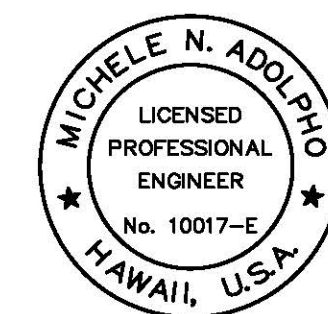

THIS WORK WAS PREPARED BY ME
OR UNDER MY SUPERVISION
EXP. 4-30-24
Michele N. Adolp
ECS, INC.

REVISION	DATE	DESCRIPTION	BY	APPROVED
STATE OF HAWAII DEPARTMENT OF TRANSPORTATION HARBORS DIVISION				
JOB TITLE REPAIR LIGHT POLES AND PEDESTALS AT PIER 53 HONOLULU HARBOR, OAHU, HAWAII				
SHEET TITLE OVERALL ELECTRICAL SITE PLAN				
DESIGNED BY: JC	DRAWN BY: CAD		SHEET E-2	
CHECKED BY: M.A.	DATE: 04/2023		JOB NUMBER S10859	
SCALE: AS SHOWN			7 of 18 SHEETS	