



FED. ROAD DIST. NO.	STATE	FED. AID PROJ. NO.	FISCAL YEAR	SHEET NO.	TOTAL SHEETS
HAWAII	HAW.	1-H3-1(66)	1992	62	440


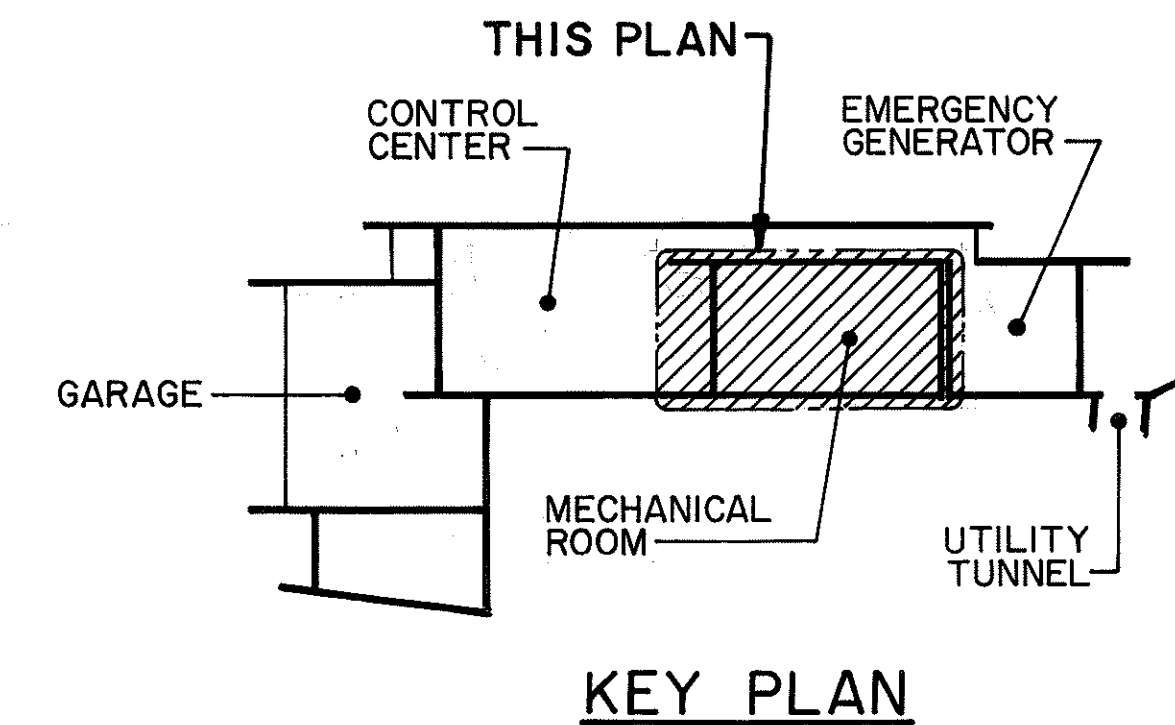


NOTES:

1. FOR BUILDING AIR CONDITIONING UNIT SCHEDULE REFER TO SHEET NO. M3
2. FOR FAN SCHEDULE REFER TO SHEET NO. M5.
3. FOR CONDENSING UNIT SCHEDULE REFER TO SHEET NO. M3

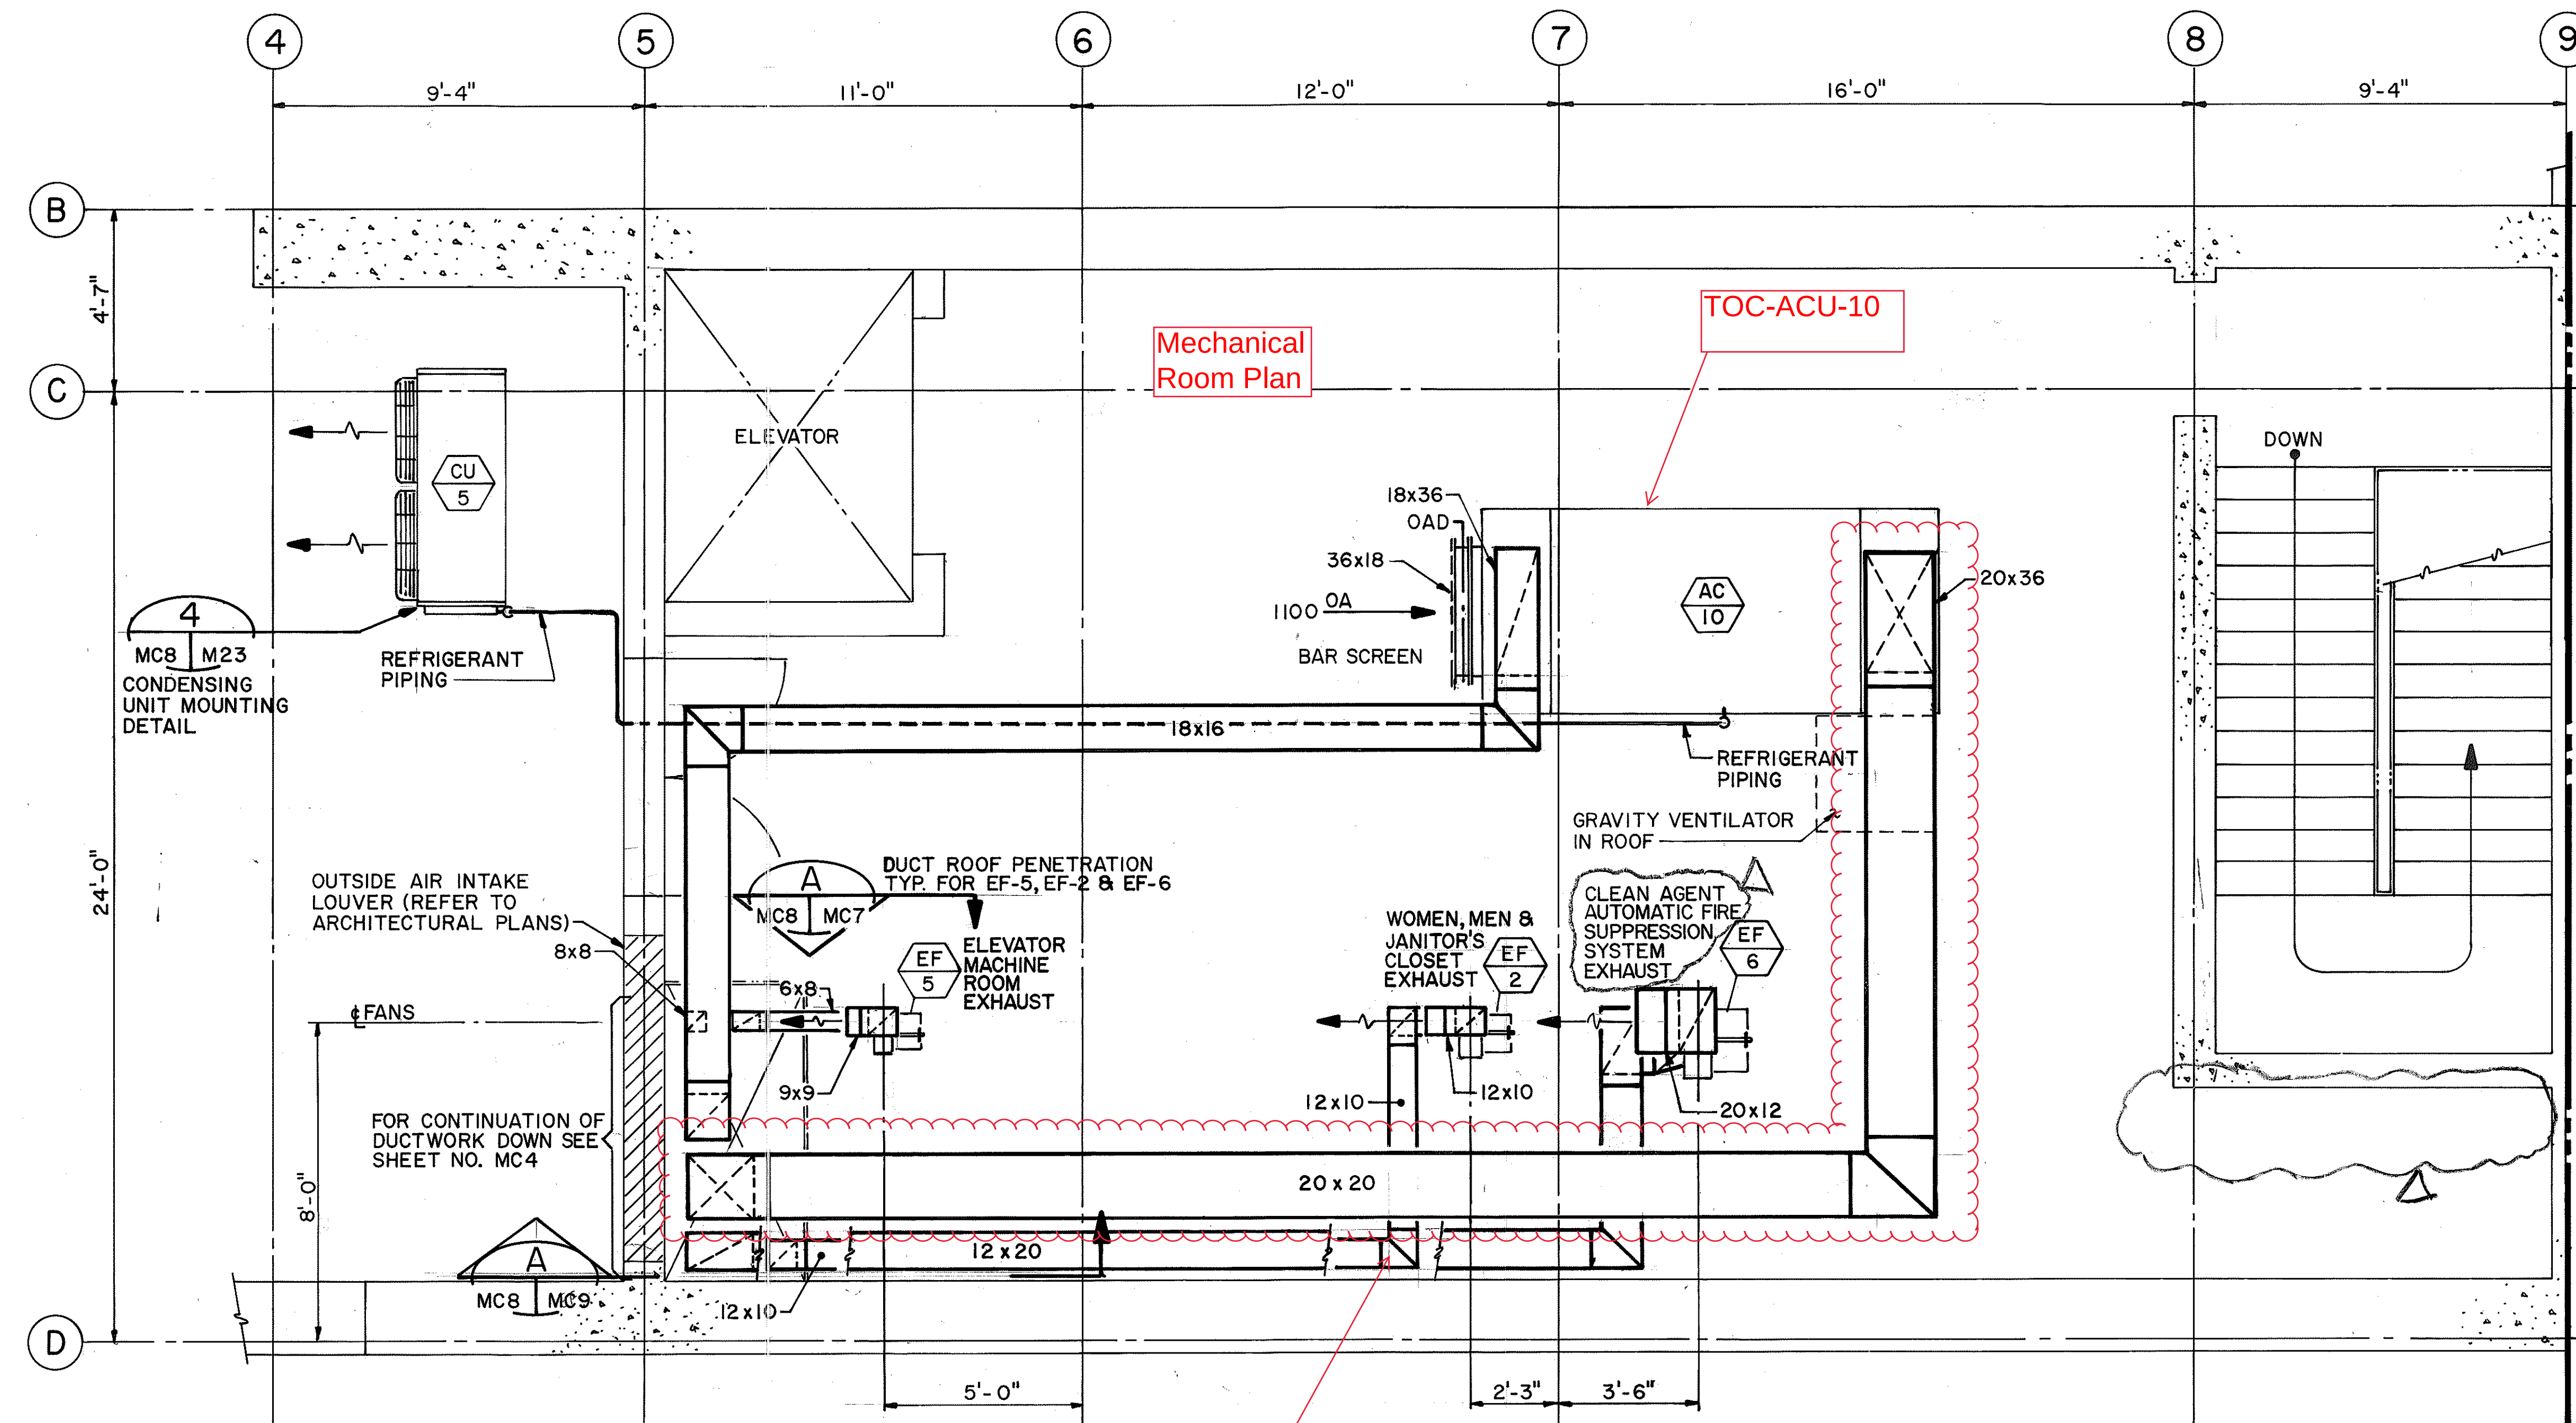

SURVEY PLOTTED BY	DATE
DRAWN BY	04/24/90
TRACED BY	01/08/90
QUANTITIES BY	06/18/90
CHECKED BY	

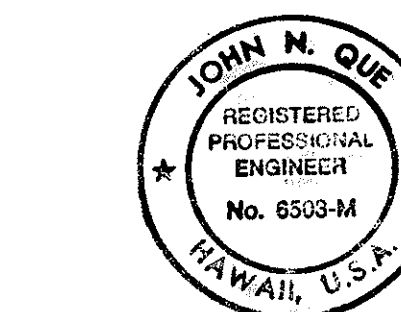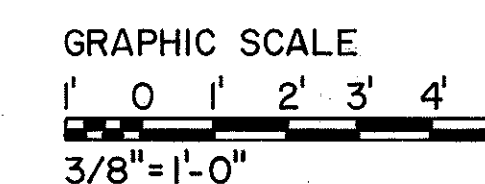


THIS WORK WAS PREPARED BY ME
OR UNDER MY SUPERVISION

John N. Que

1/25/94	REV. PER DCN 66-034
1/18/94	REV. DETAIL NO. & REF. PER DCN 66-030
DATE	REVISION


STATE OF HAWAII DEPARTMENT OF TRANSPORTATION HIGHWAYS DIVISION
HVAC - LEVEL 3
MECHANICAL ROOM PLAN
CONTROL BUILDING
INTERSTATE ROUTE H-3
F.A.I. PROJ. NO. 1-H3-1 (66)
SCALE: 3/8"=1'-0" DATE: APR 1992
SHEET NO. MC8 OF 19 SHEETS

FED. ROAD DIST. NO.	STATE	FED. AID PROJ. NO.	FISCAL YEAR	SHEET NO.	TOTAL SHEETS
HAWAII	HAW.	I-H3-1(66)	1992	63	440

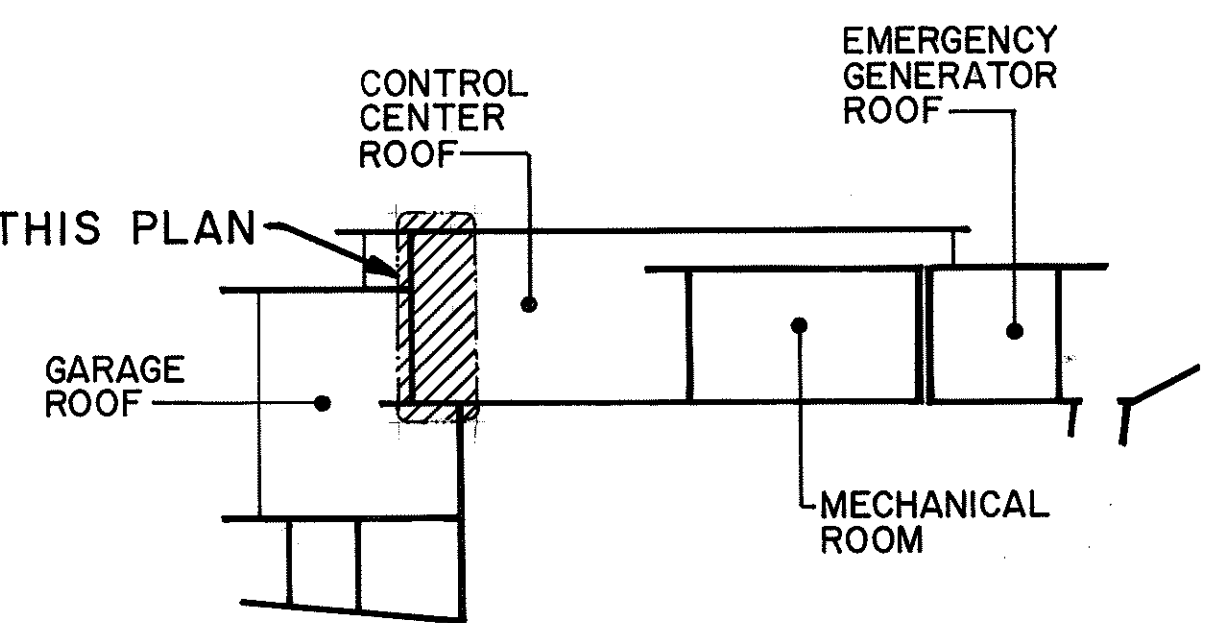


KEY PLAN



- NOTES:
1. FOR LEGEND AND GENERAL NOTES REFER TO SHEET NO. M1
 2. FOR CONDENSING UNIT SCHEDULE REFER TO SHEET NO. M3

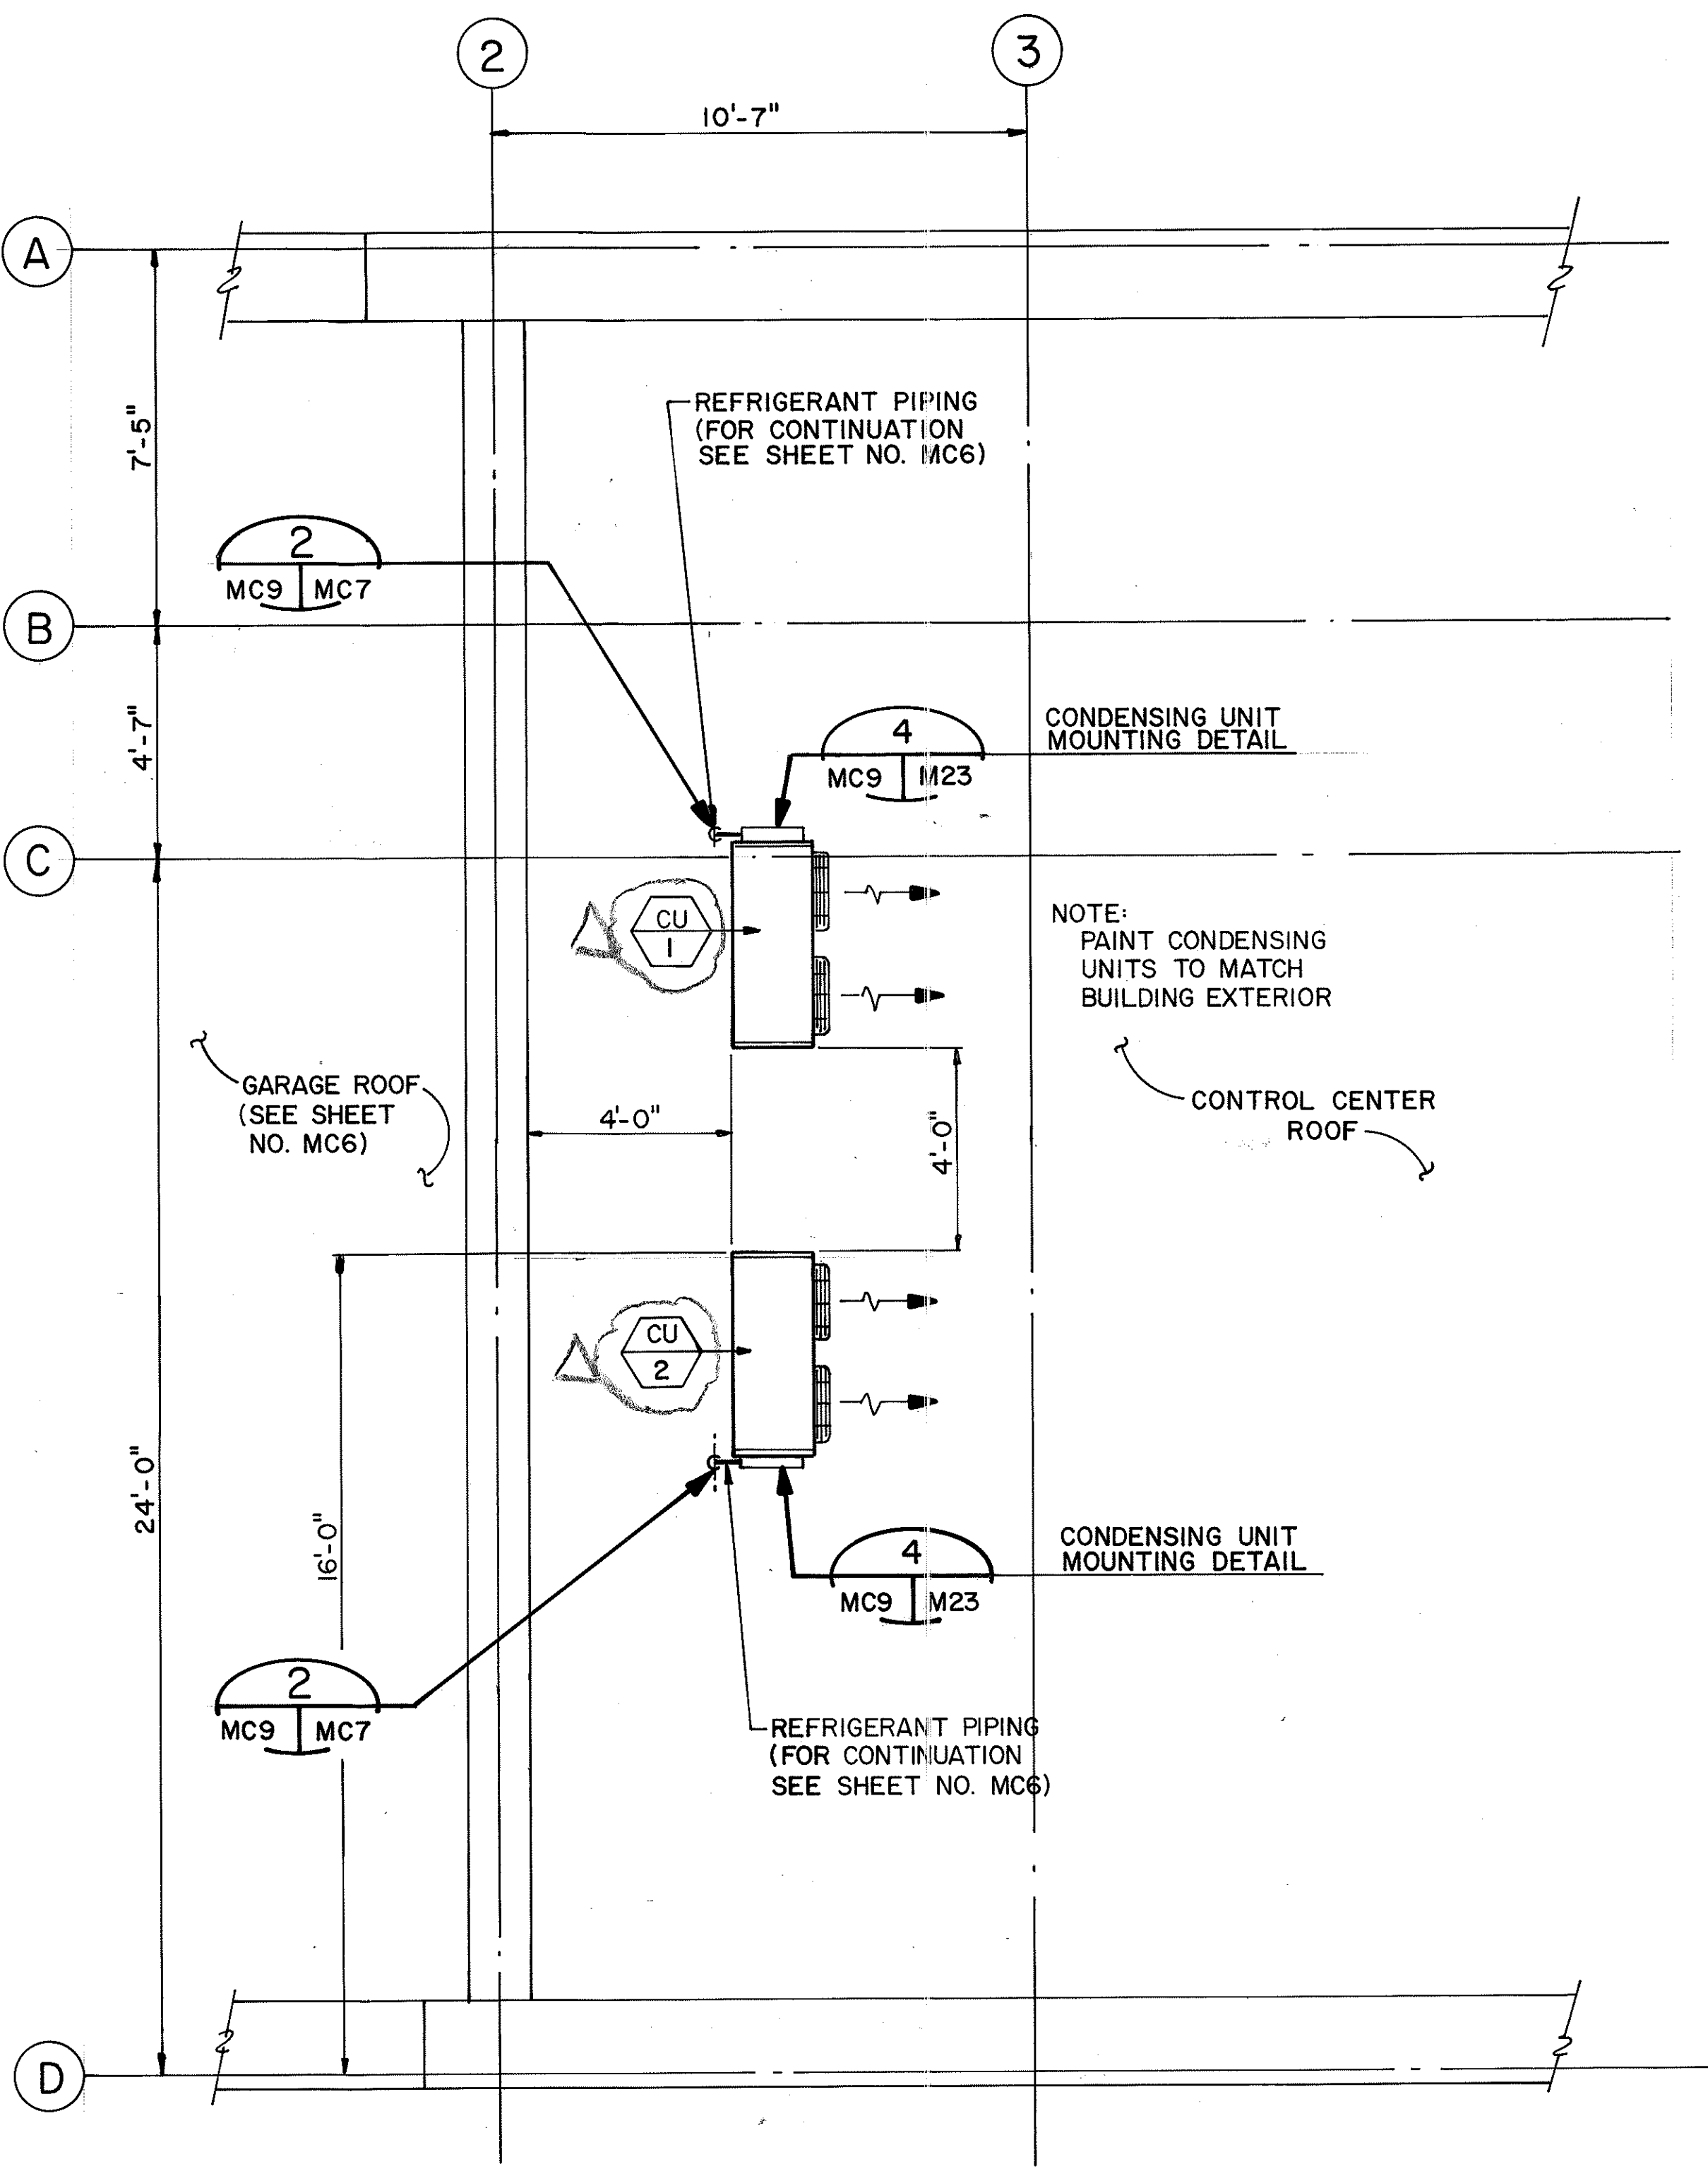

PARTIAL PLAN
3/8"=1'-0"

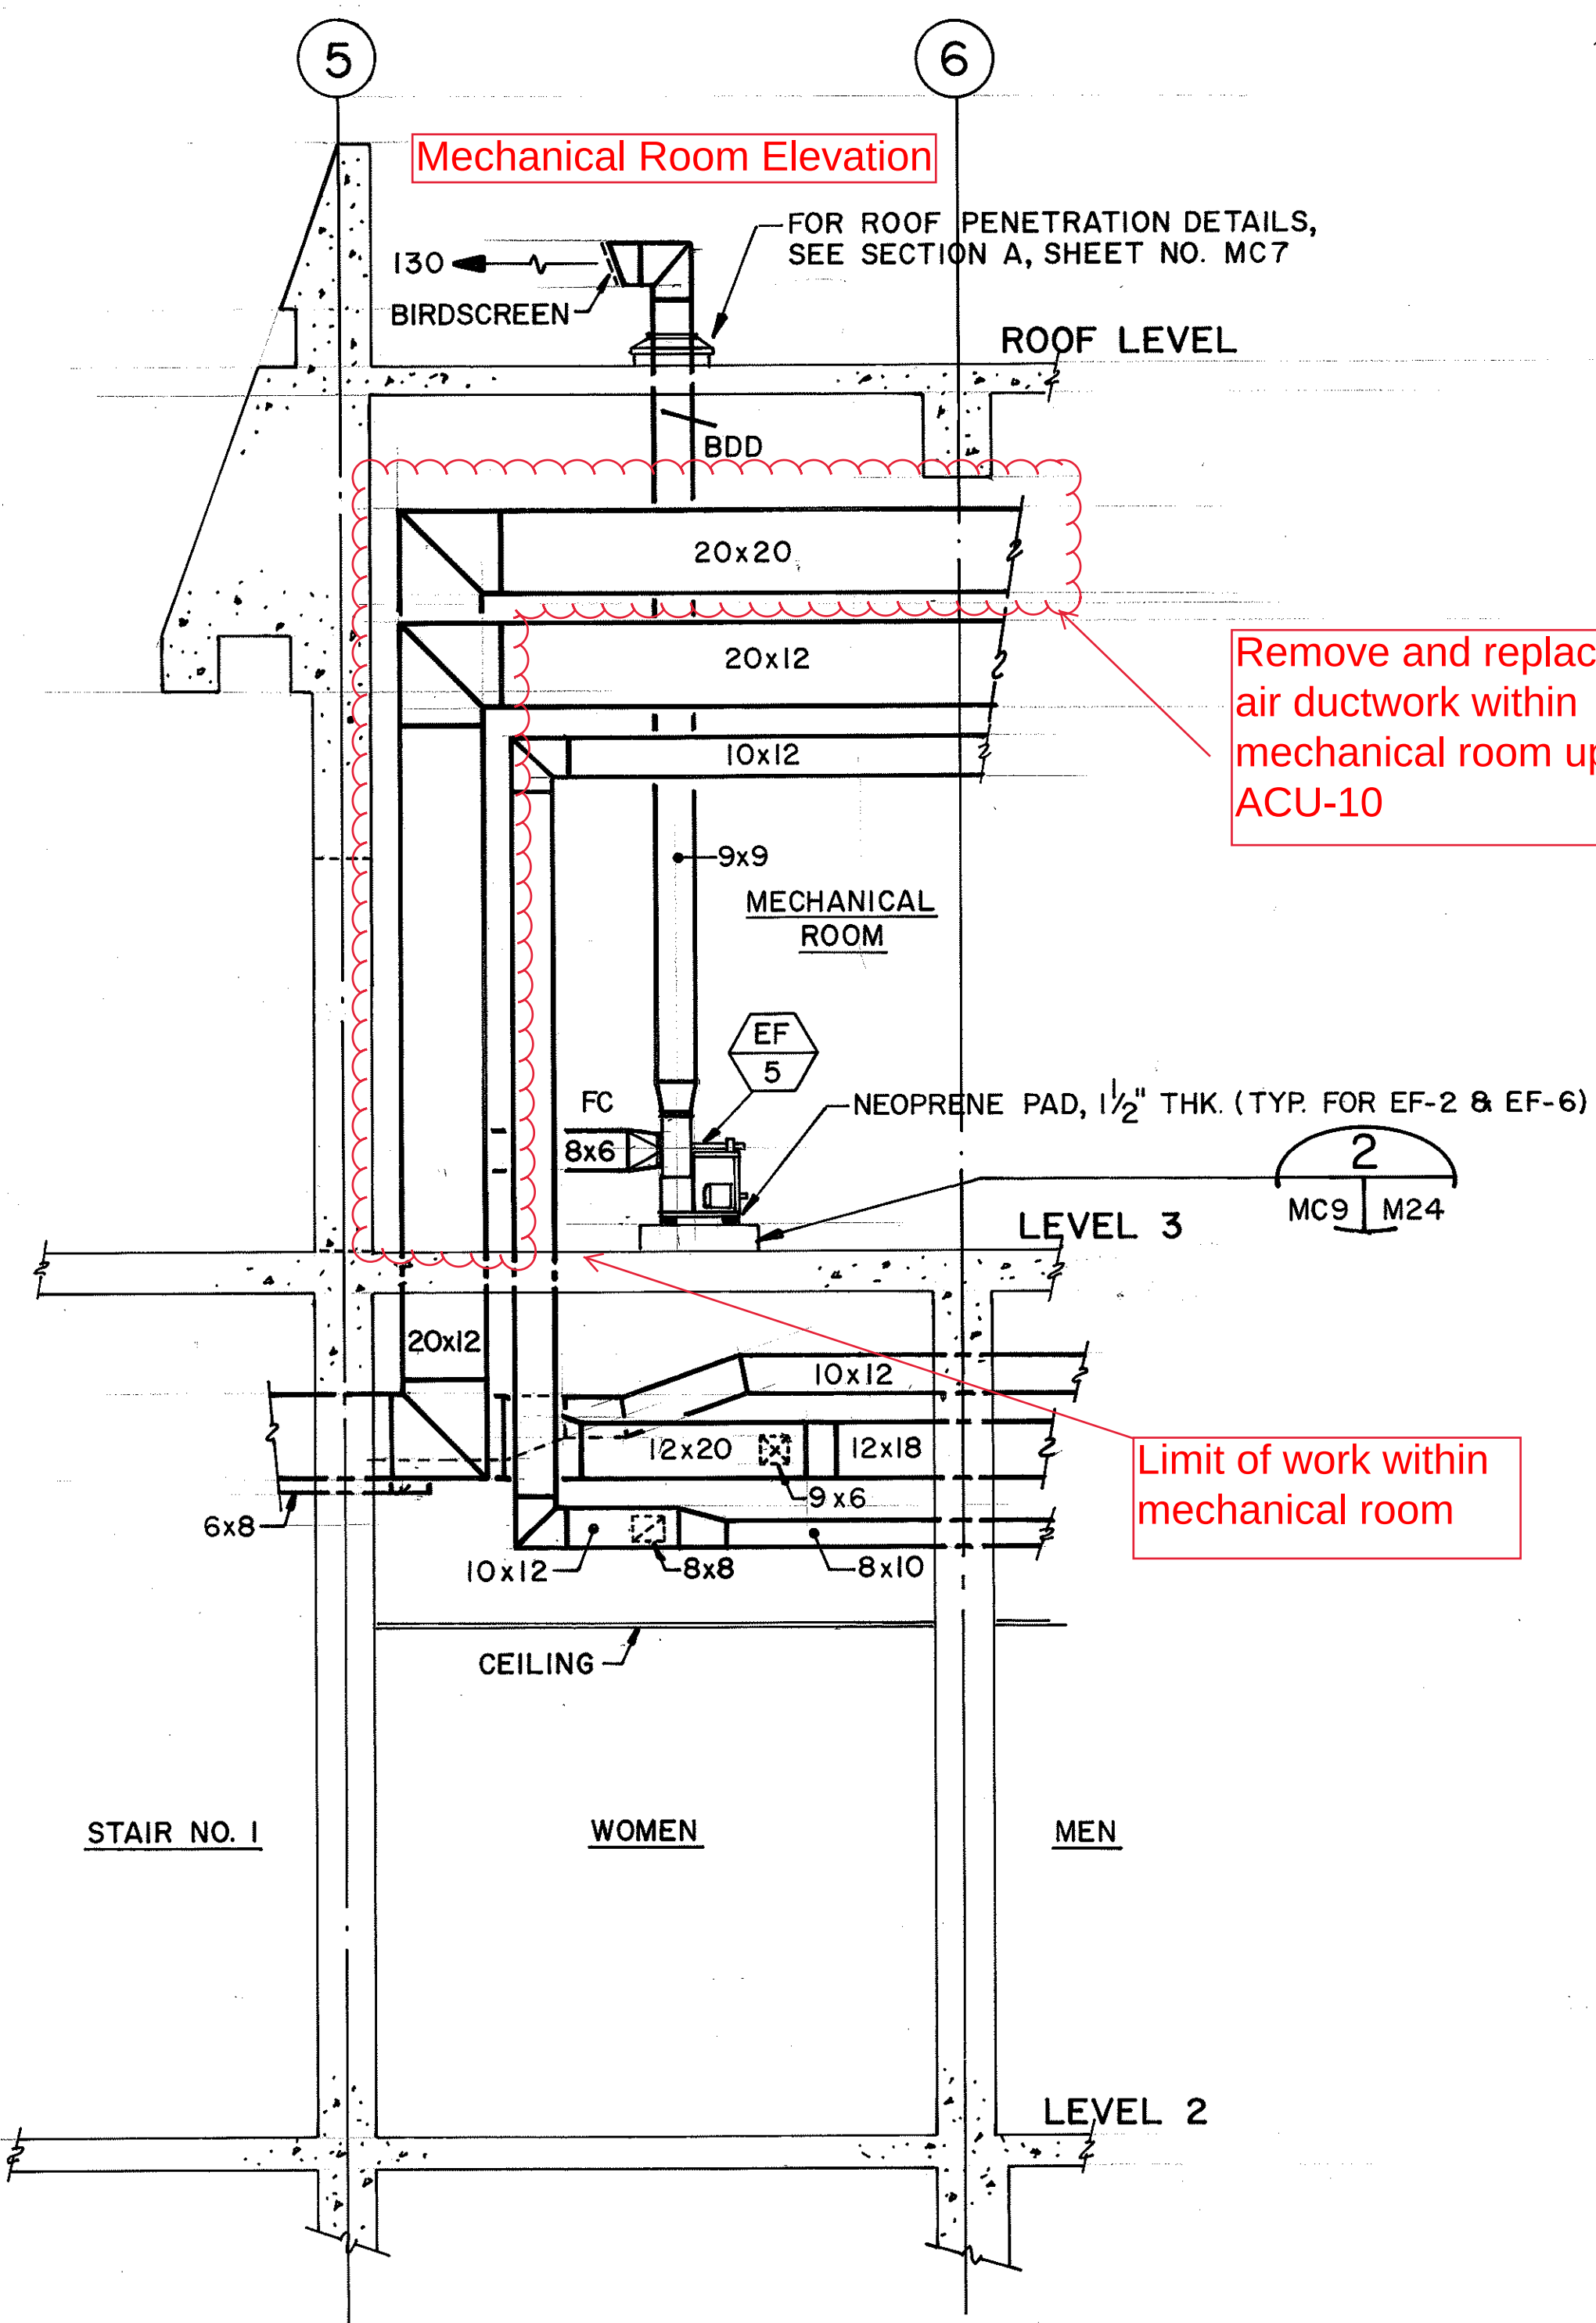

SECTION A
3/8"=1'-0"

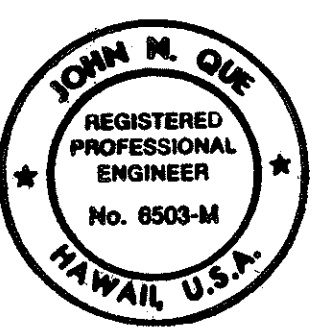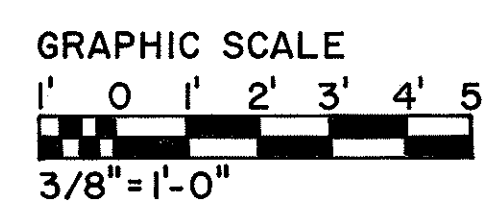


THIS WORK WAS PREPARED BY ME OR UNDER MY SUPERVISION

DATE	REVISION
11/23/94	REV. PER DCN 66-054
1/12/94	REV. CU TAG NO'S AND DETAIL REFERENCE PER DCN 66-030
DATE	REVISION
STATE OF HAWAII DEPARTMENT OF TRANSPORTATION HIGHWAYS DIVISION HVAC - LEVEL 3 PARTIAL PLAN & SECTION CONTROL BUILDING INTERSTATE ROUTE H-3 F.A.I. PROJ. NO. I-H3-1(66)	
SCALE: 3/8"=1'-0" DATE: APR. 1992 SHEET NO. MC9 OF 19 SHEETS	


ORIGINAL PLAN	DATE: 04/18/90
DRAWN BY: D. E. DRYDEN	DESIGNED BY: D. E. DRYDEN
NOTE BOOK	QUANTITIES BY: J. N. QUE
	CHECKED BY: J. N. QUE

FED. ROAD DIST. NO.	STATE	FED. AID PROJ. NO.	FISCAL YEAR	SHEET NO.	TOTAL SHEETS
HAWAII	HAW.	I-H3-1(66)	1992	58	440

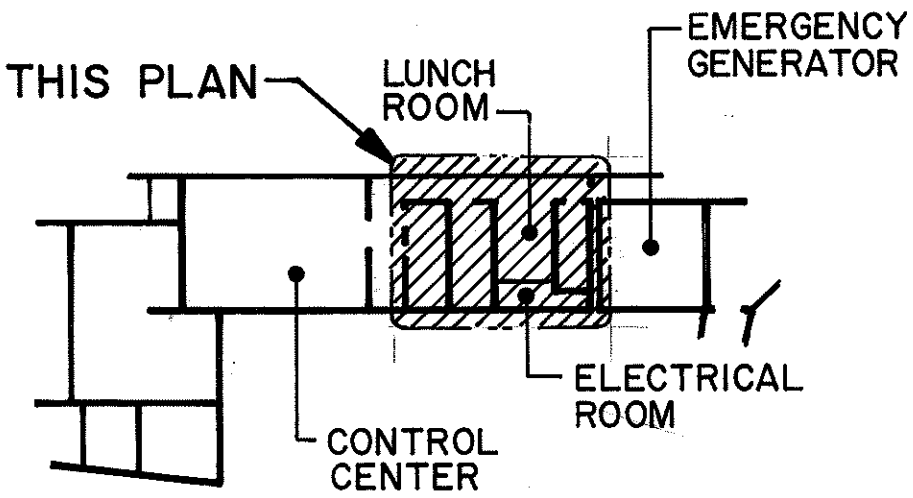



KEY PLAN

- NOTES:
- FOR LEGEND AND GENERAL NOTES REFER TO SHEET NO. M1
 - FOR AIR DISTRIBUTION DEVICE SCHEDULE REFER TO SHEET NO. M6

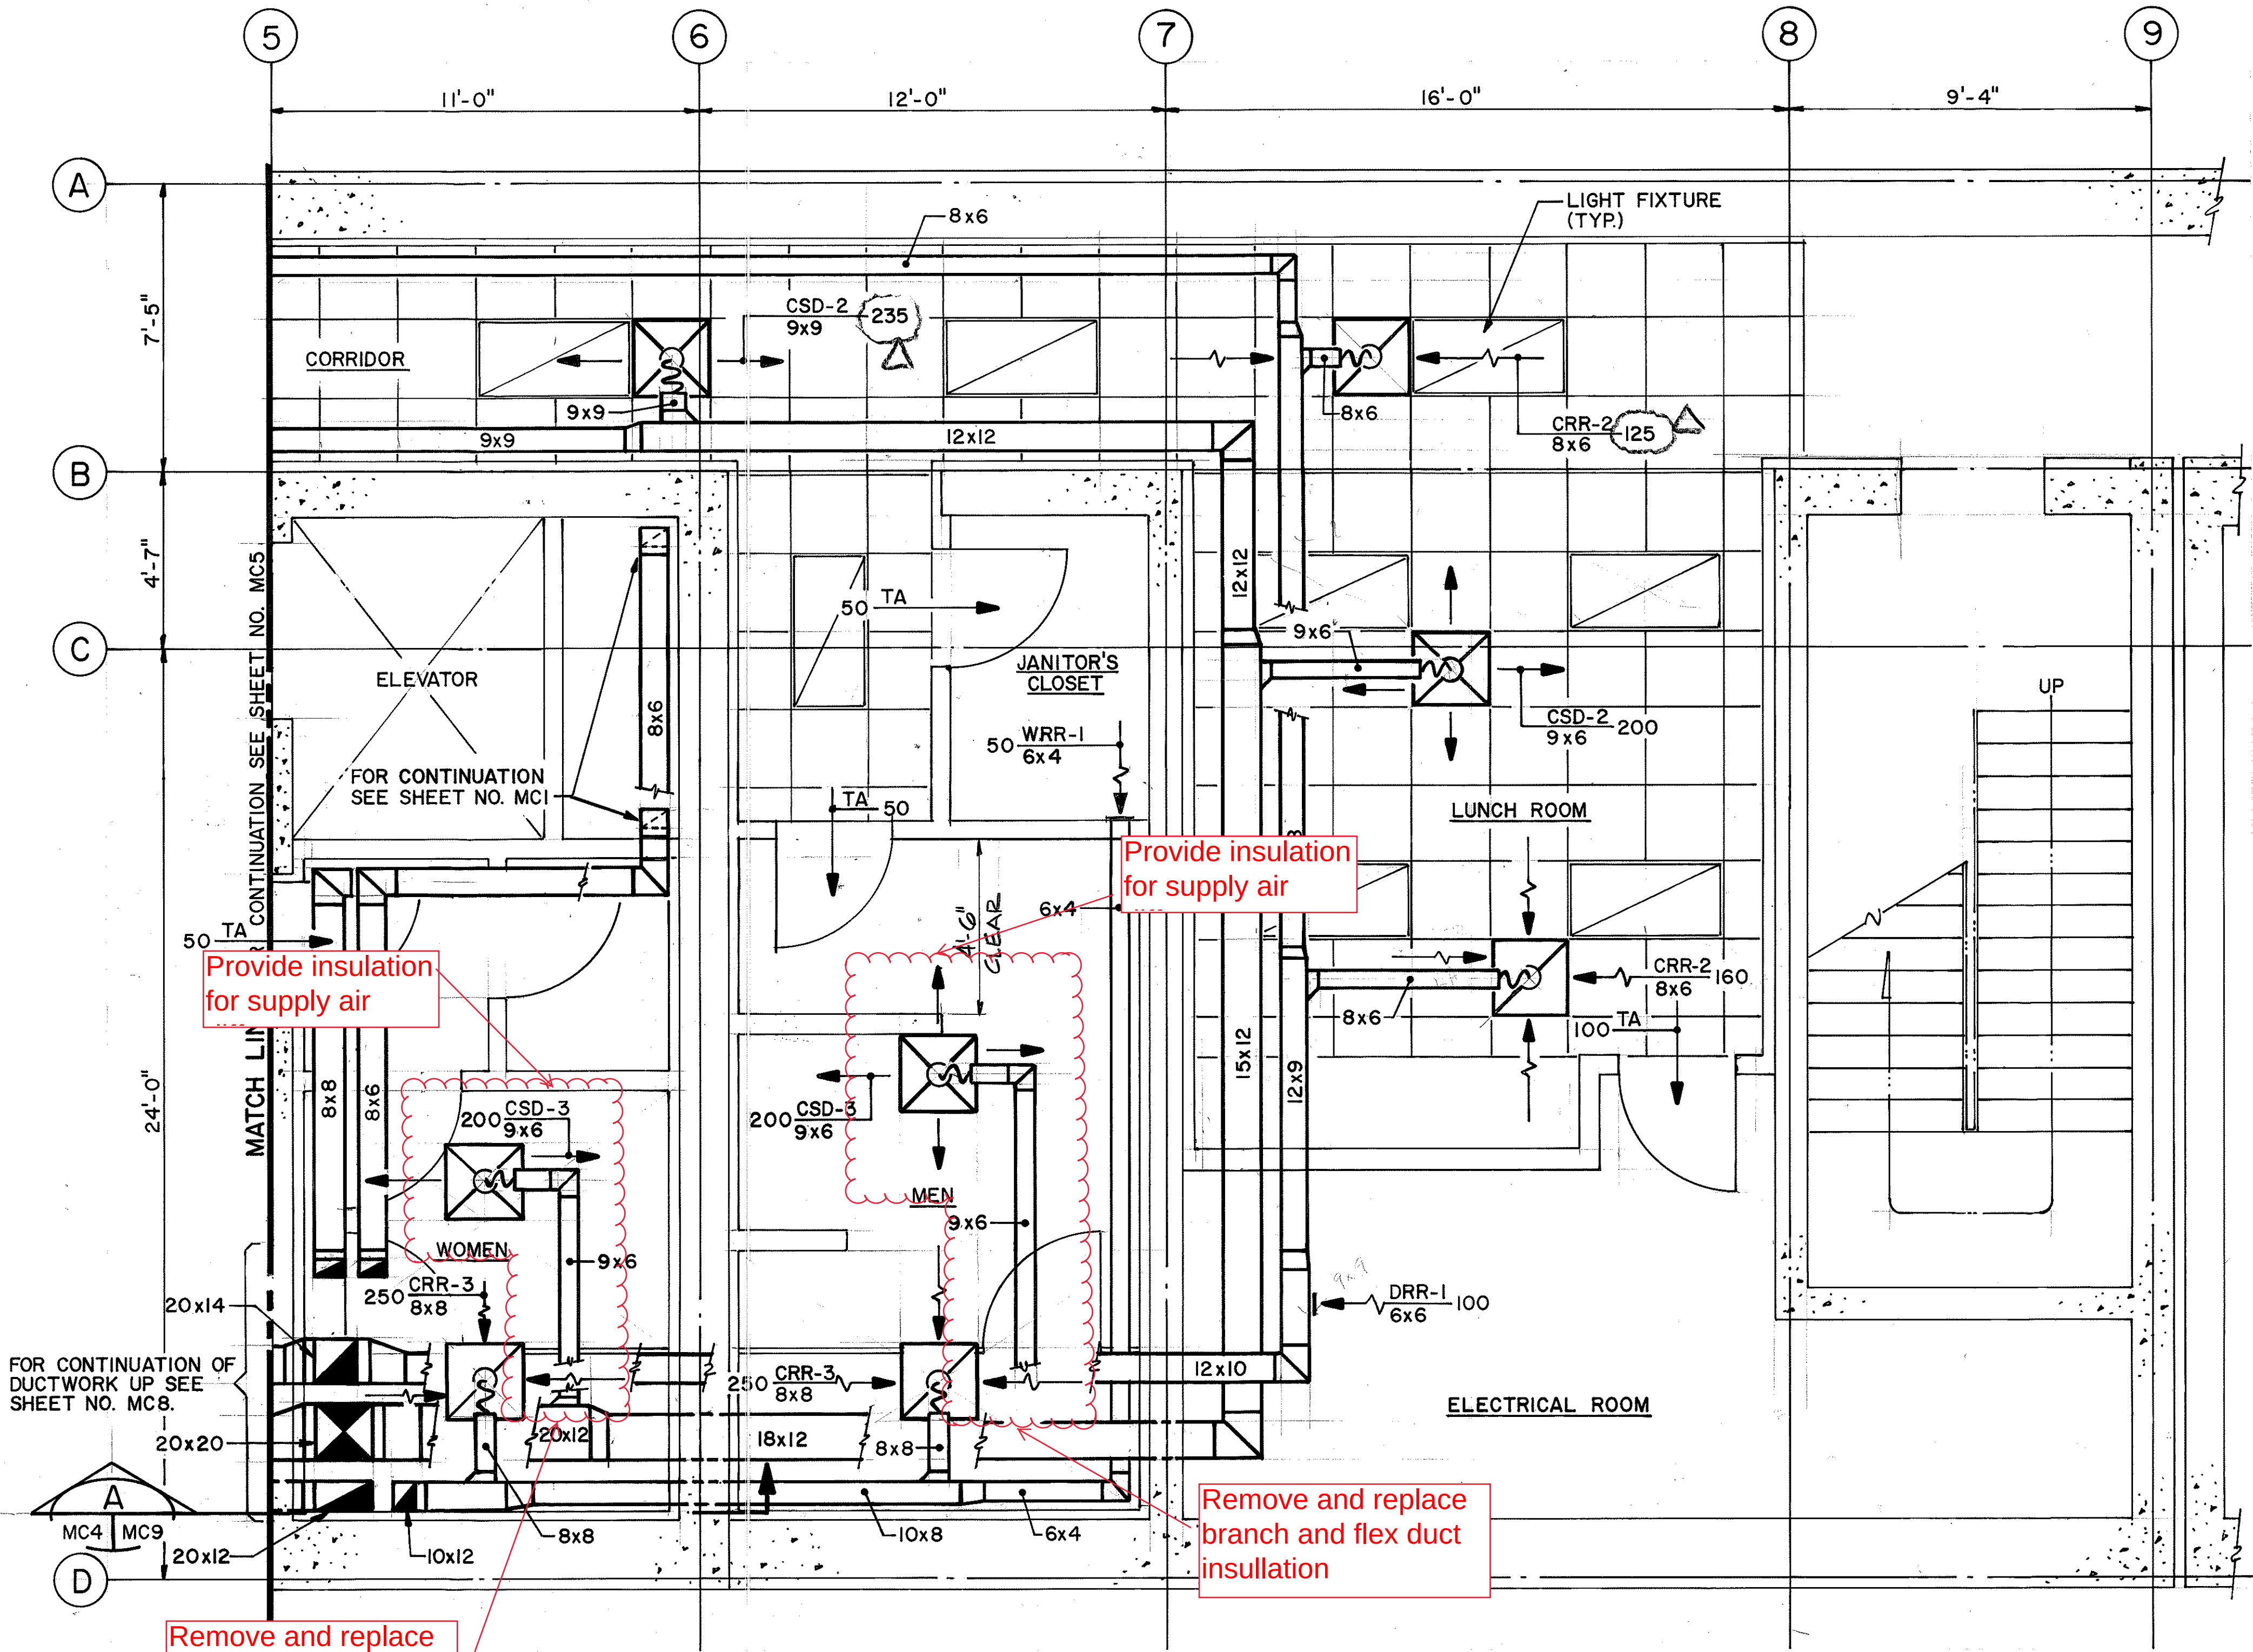

Restroom Plan

ORIGINAL PLAN	DATE
NO.	04/16/90
DESIGNED BY	D. E. DRYDEN
CHECKED BY	J. N. QUE
DATE	04/12/90
DESIGNED BY	D. E. DRYDEN
CHECKED BY	J. N. QUE
DATE	06/01/90

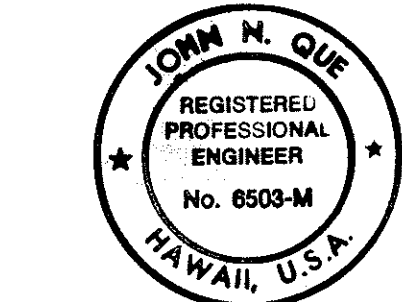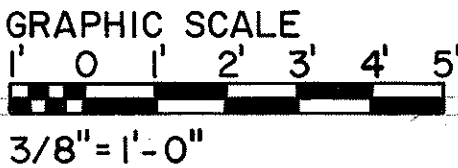

THIS WORK WAS PREPARED BY ME OR UNDER MY SUPERVISION

DATE	REVISION
11/23/94	REV. PER DCN 66-054
1/18/94	REV. CORRIDOR SUPPLY AND RETURN CFM PER DCN 66-030
2/8/93	REVISED WALL LOCATION BETWEEN MEN'S TOILET AND J.C. IN ACCORDANCE WITH ADA REGULATIONS PER DCN 66-001
STATE OF HAWAII DEPARTMENT OF TRANSPORTATION HIGHWAYS DIVISION HVAC LEVEL 2 PARTIAL PLAN-1 CONTROL BUILDING INTERSTATE ROUTE H-3 F.A.I. PROJ. NO. I-H3-1 (66) SCALE: 3/8"=1'-0" DATE: APR 1992 SHEET NO. MC4 OF 19 SHEETS	