





FED. ROAD DIST. NO.	STATE	PROJ. NO.	FISCAL YEAR	SHEET NO.	TOTAL SHEETS
HAWAII	HAW.	63A-01-72 UNIT I	1976	7	8

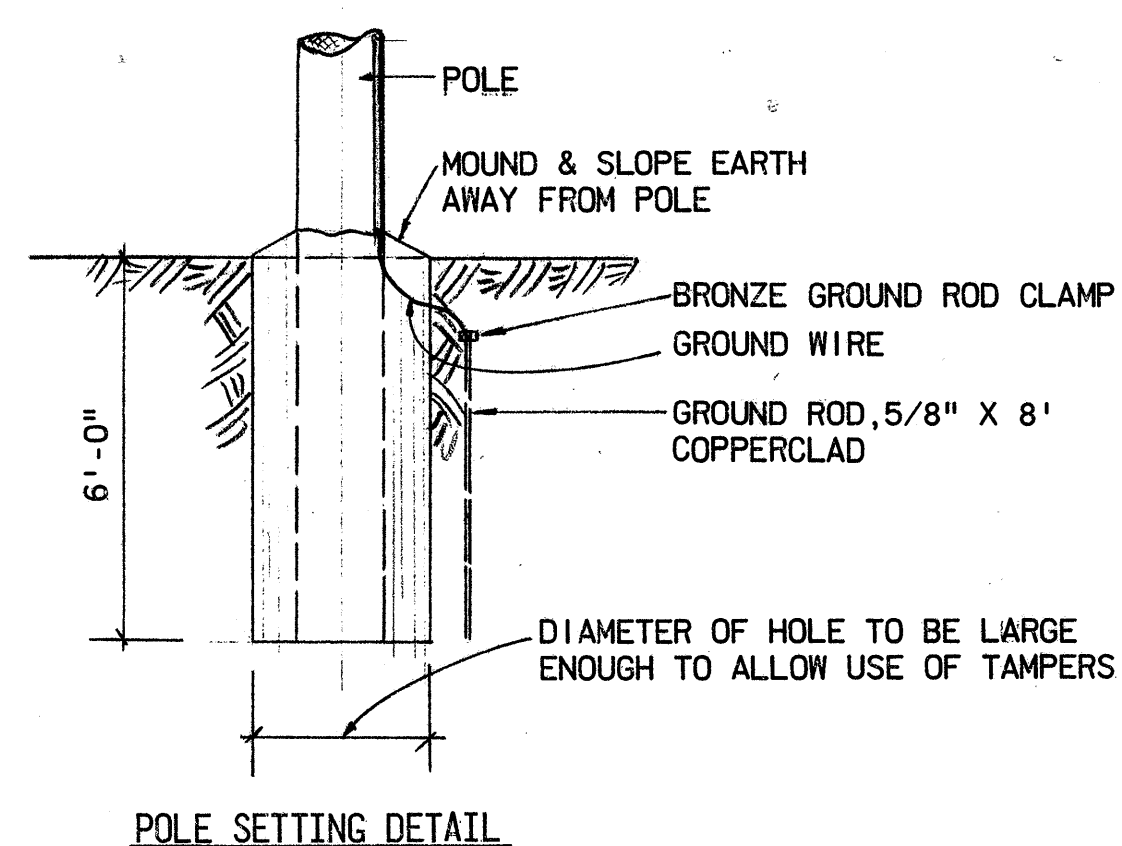


POLE SETTING DETAIL

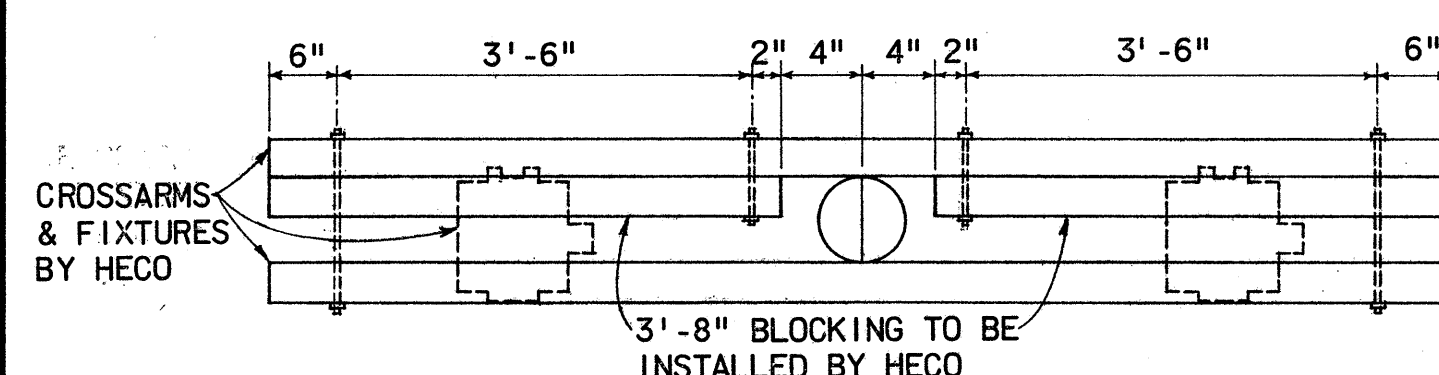

TOP VIEW

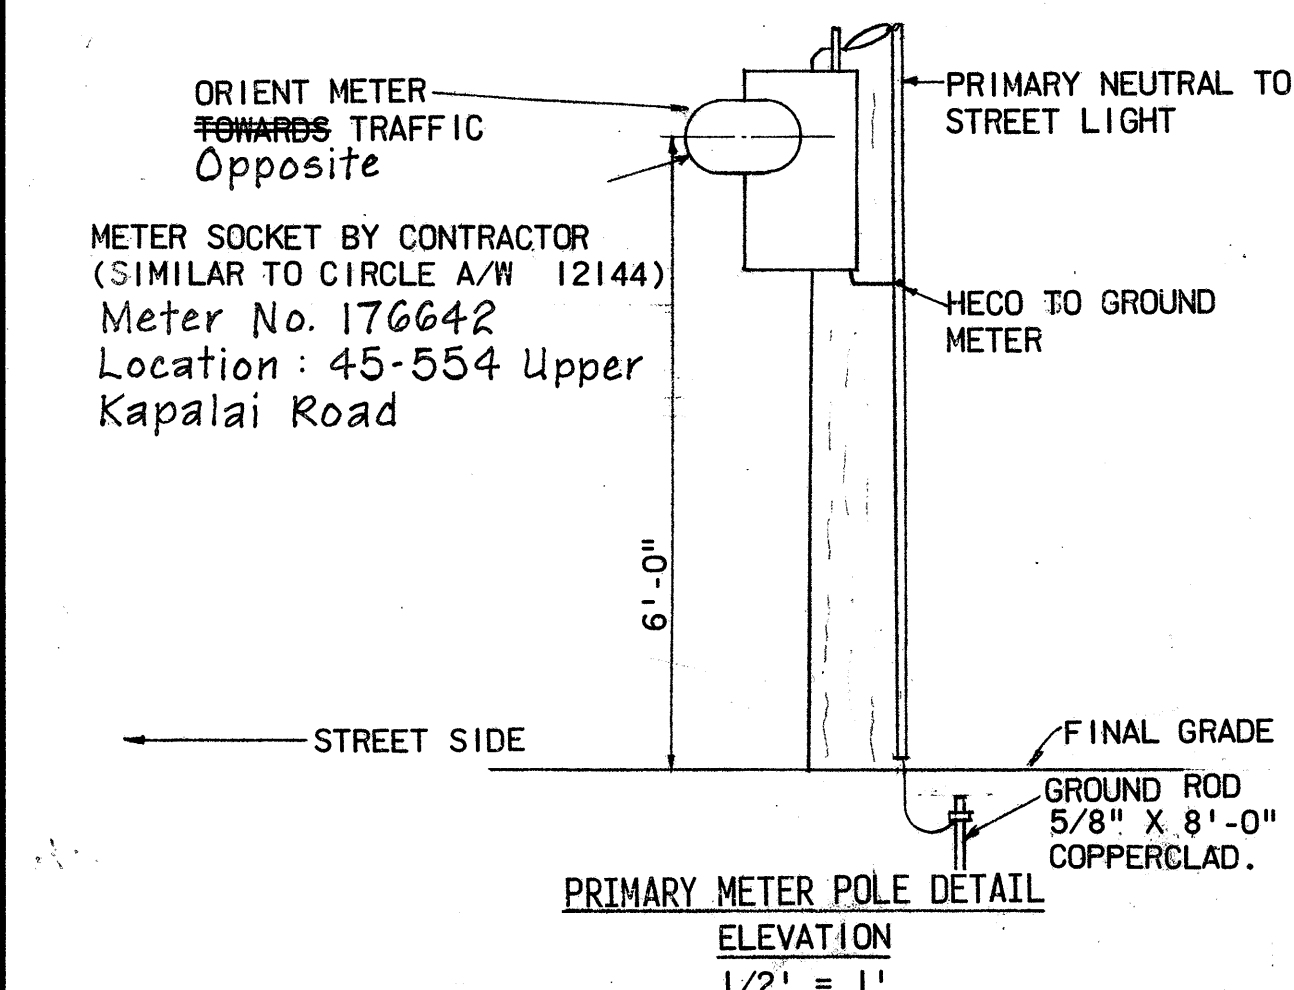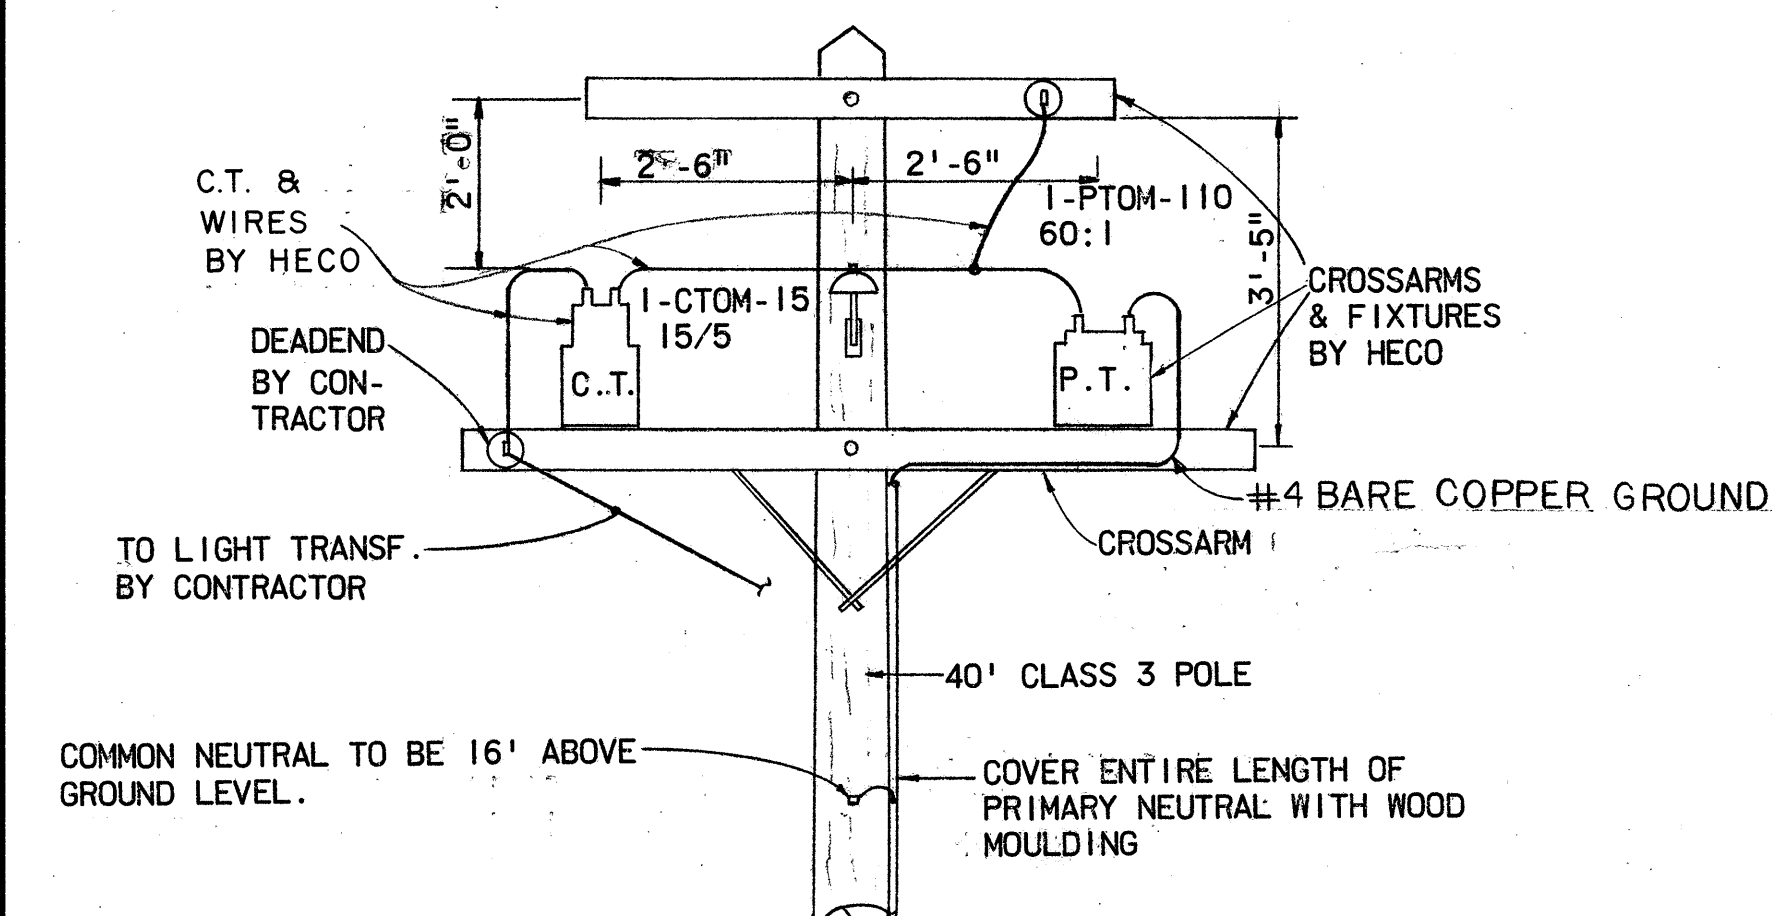



NOTE:
ALL WORK BY CONTRACTOR UNLESS OTHERWISE NOTED.

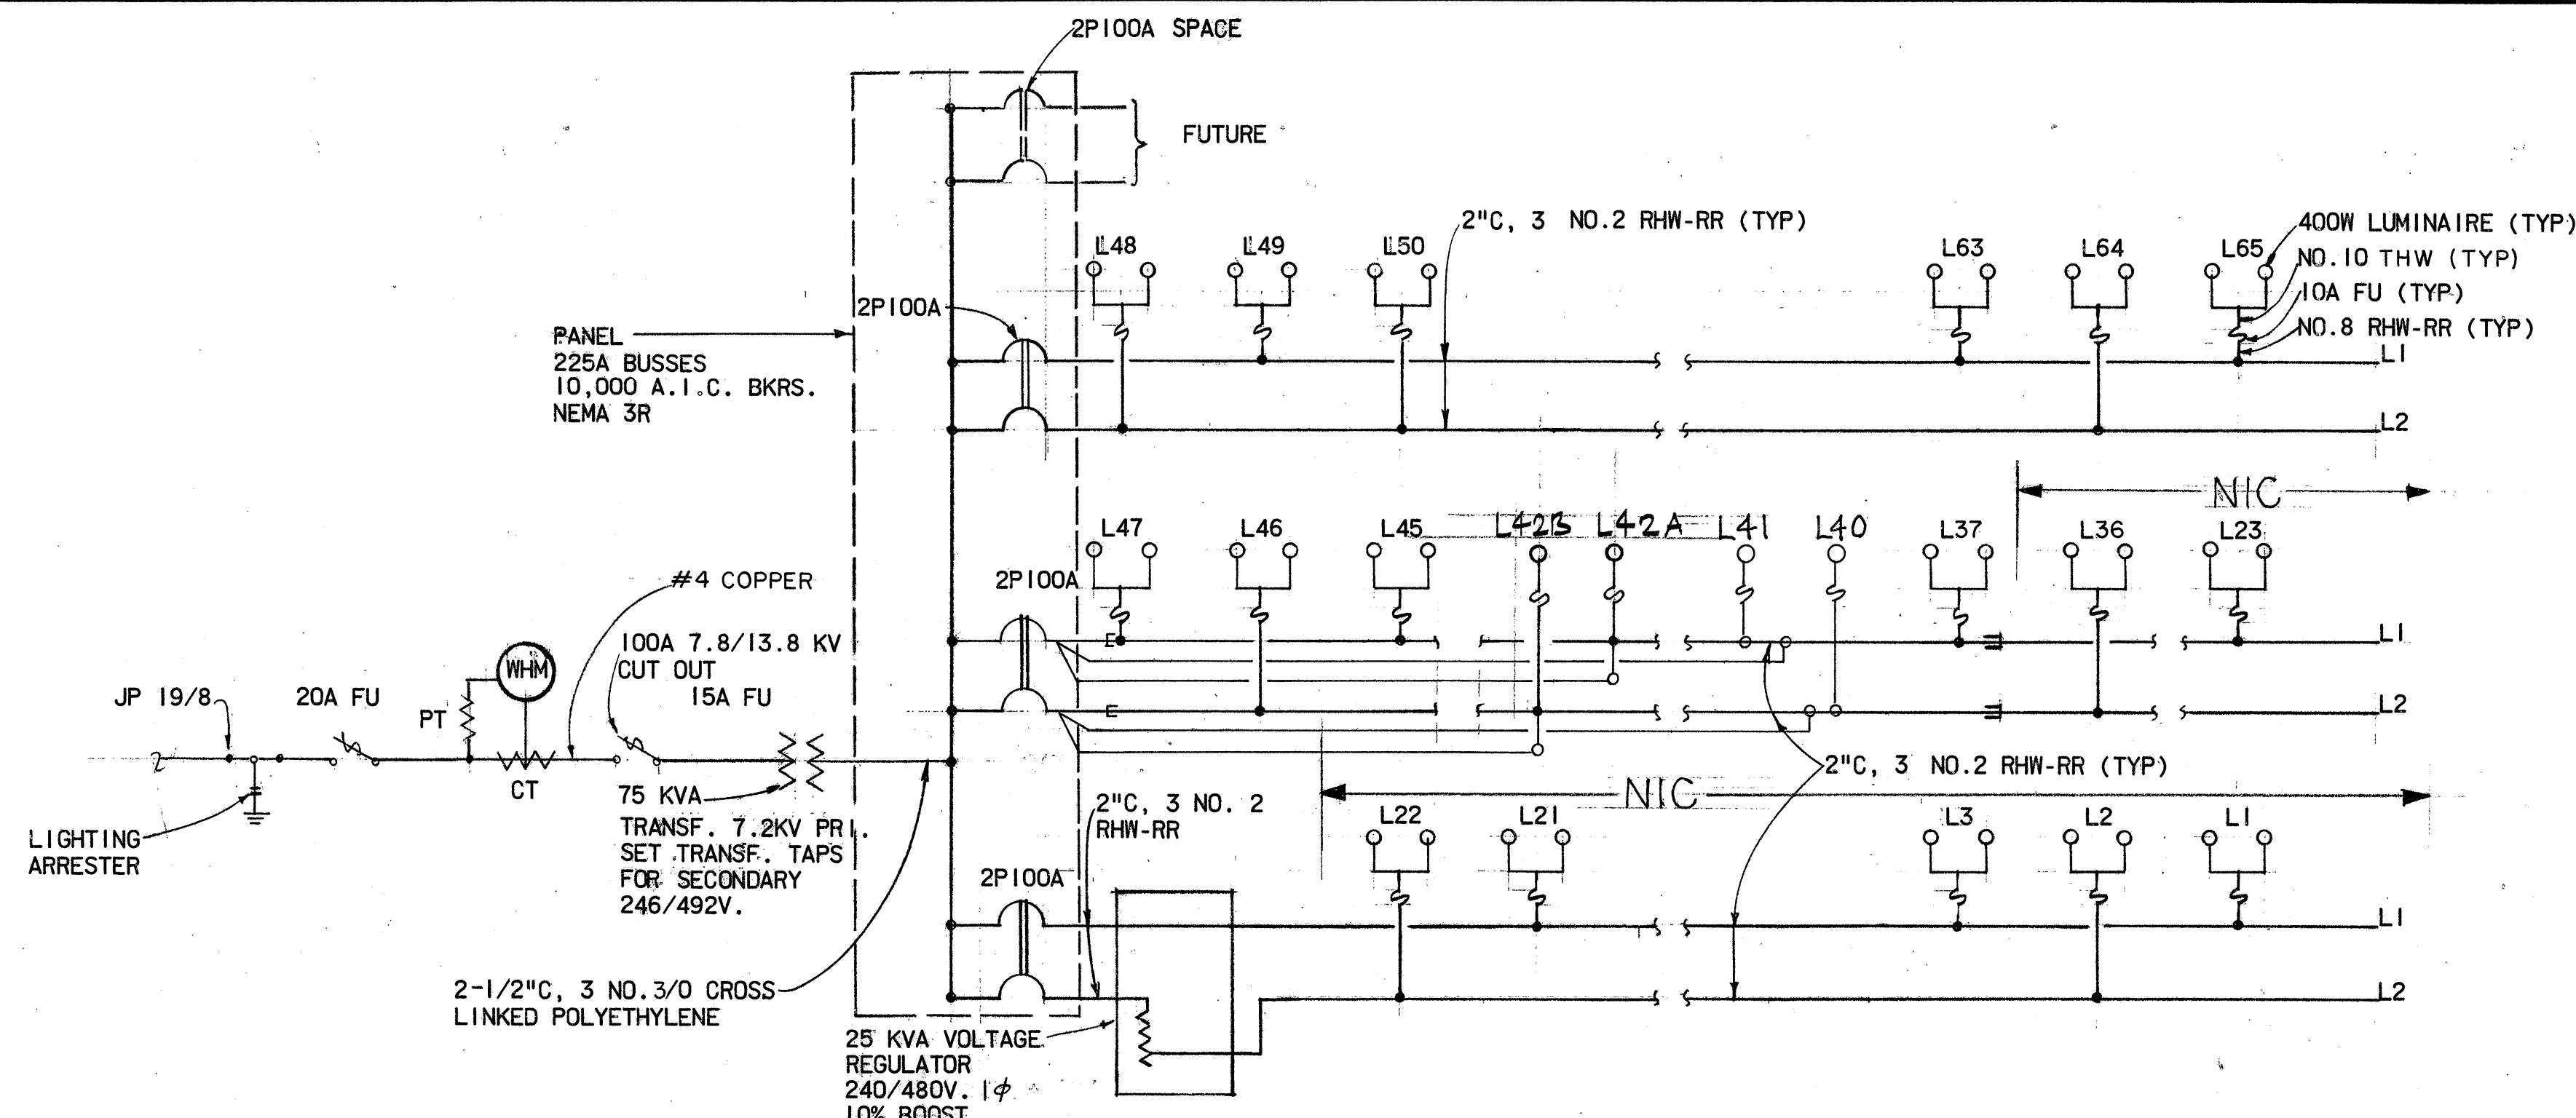

SINGLE LINE DIAGRAM

NOTE: IN LIEU OF RHW-RR CABLE, THE CONTRACTOR MAY USE RHH-USE OR APPROVED EQUAL.

NOTE: NEUTRAL CONDUCTOR NOT SHOWN ABOVE

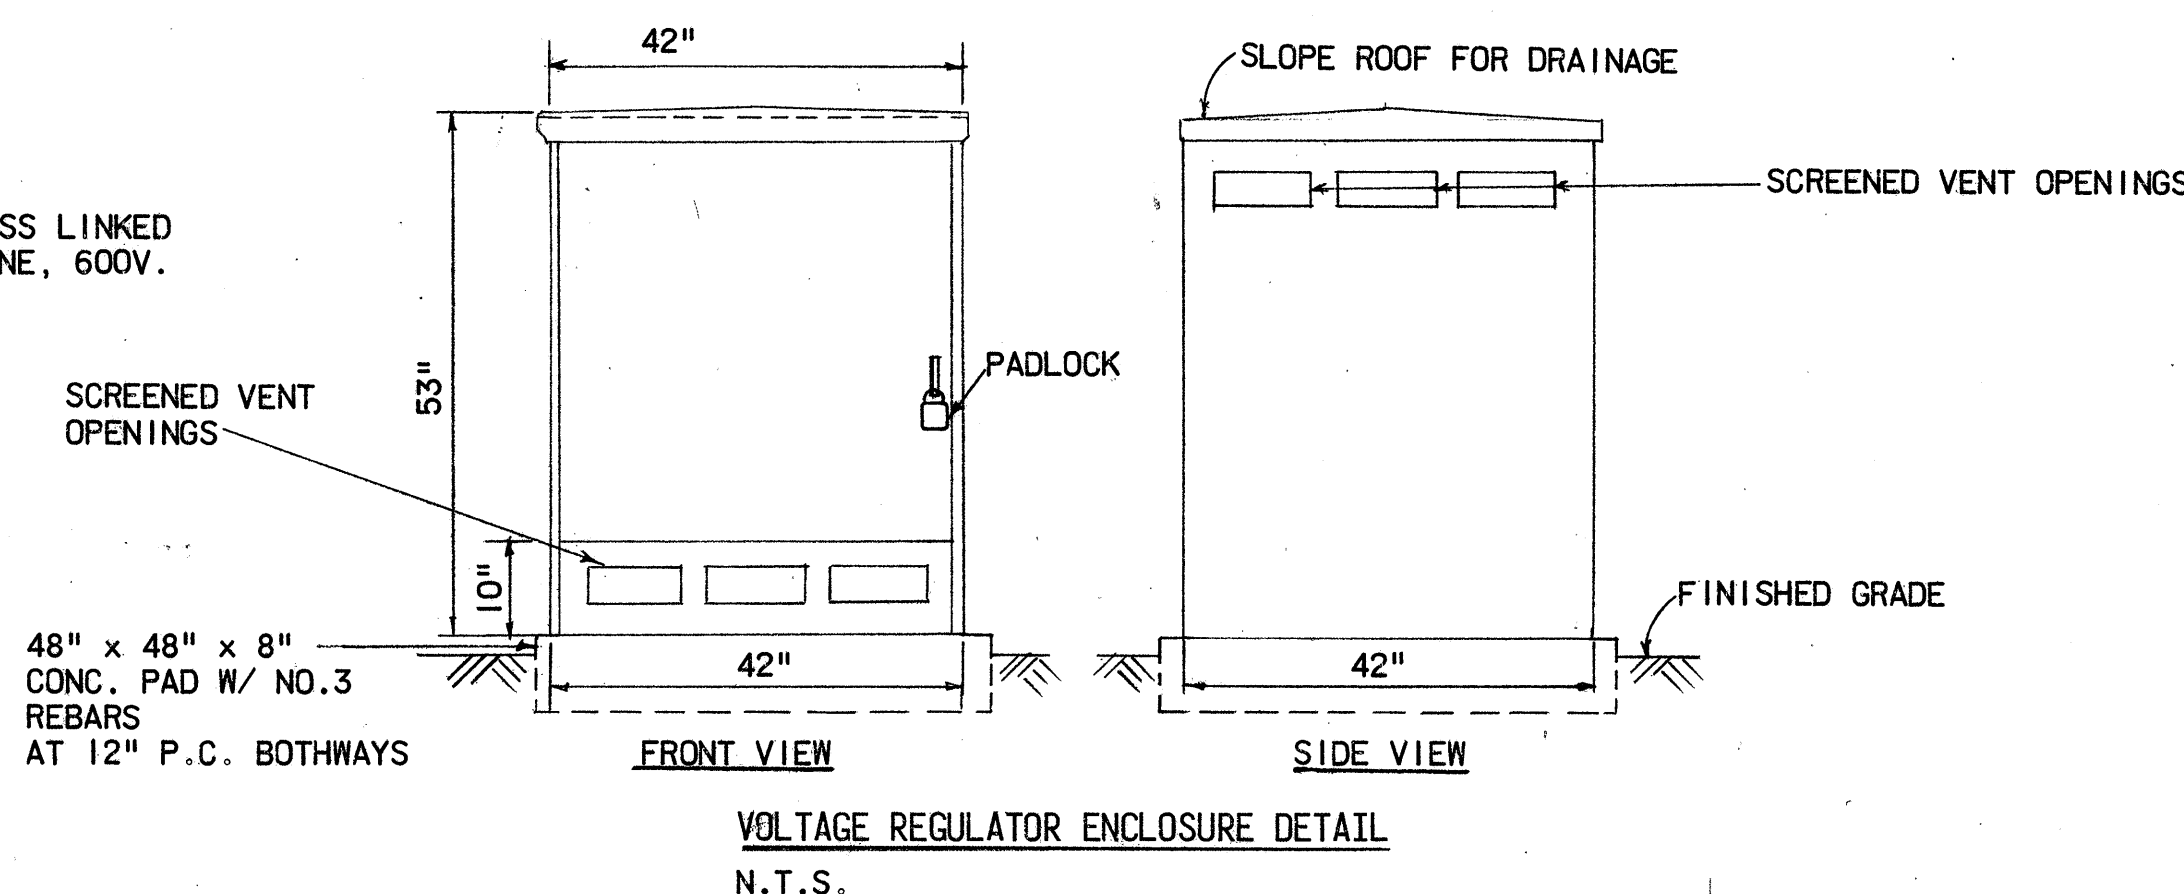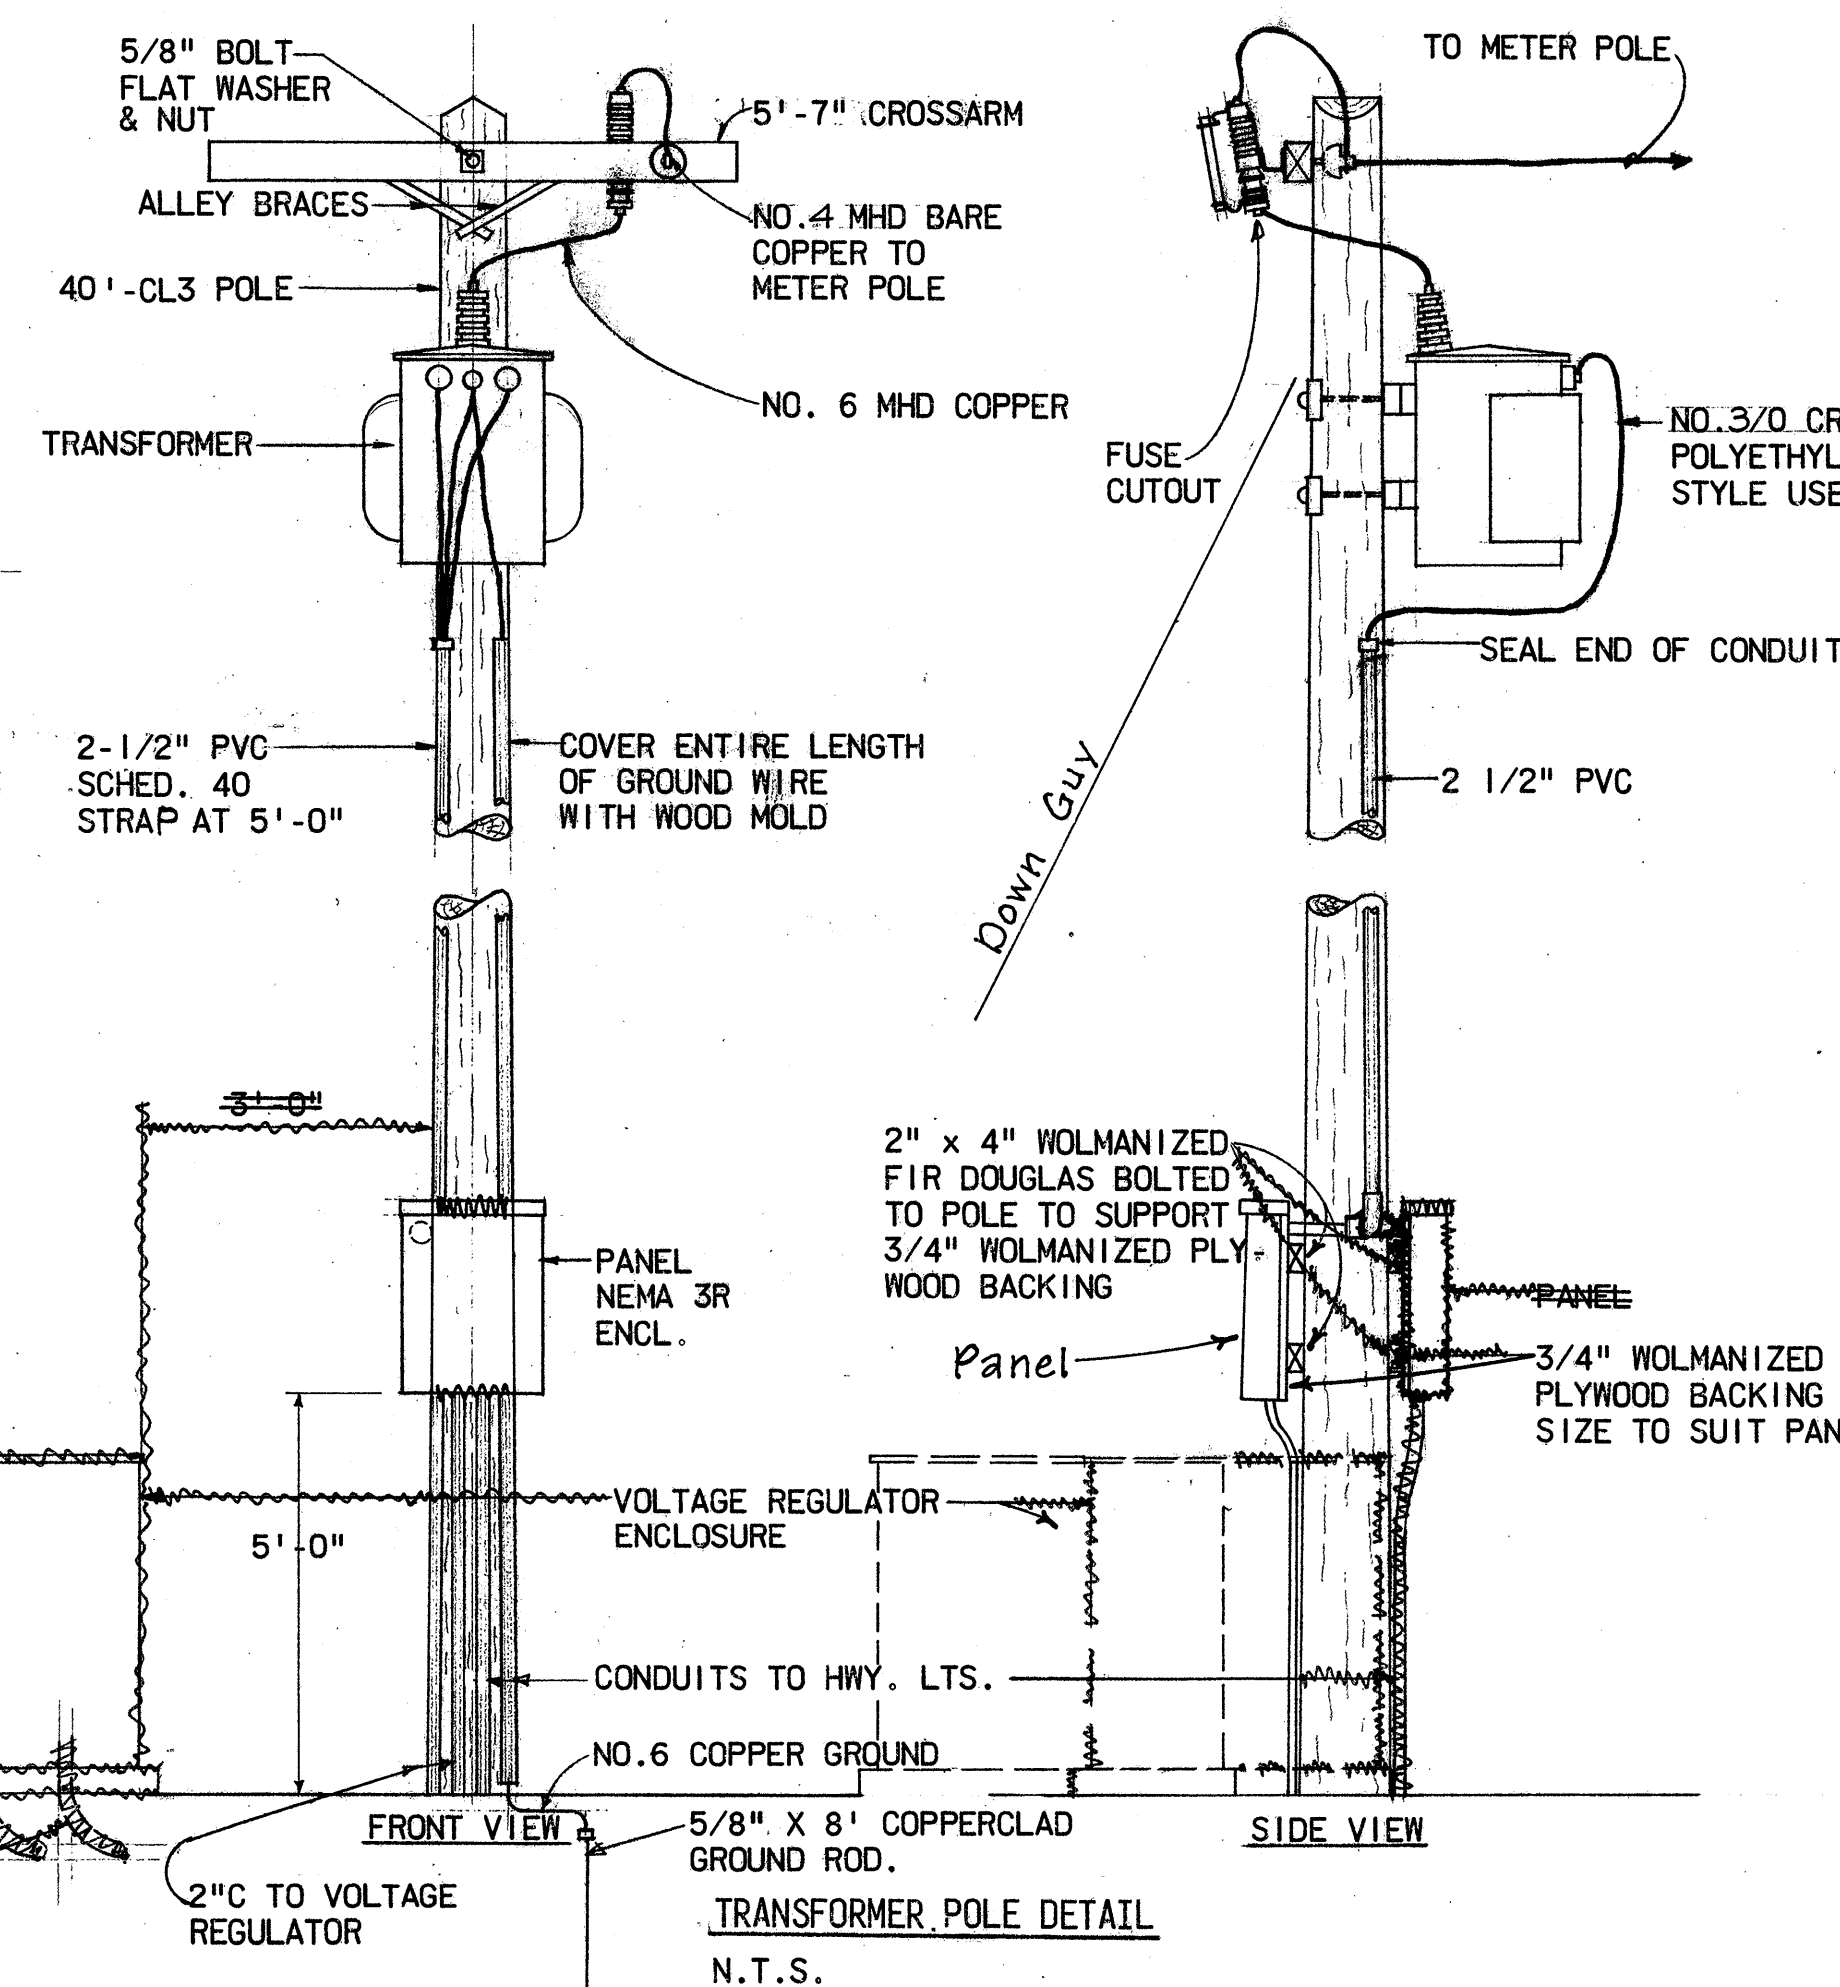


9-24-76 REVISE SINGLE LINE DIAGRAMS
6/9/76 CABLE DETAIL FOR TRANSFORMER

DATE REVISION

STATE OF HAWAII
DEPARTMENT OF TRANSPORTATION
HIGHWAYS DIVISION

HIGHWAY LIGHTING IMPROVEMENT
ON LIKELIKE HIGHWAY
BETWEEN WILSON TUNNEL AND KAMEHAMEHA HIGHWAY
PROJECT NO. 63A-01-72
UNIT I

SHEET No. 1 OF 1 SHEETS

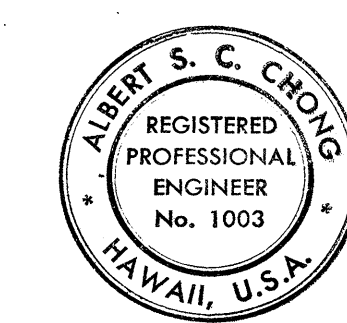

THIS WORK WAS PREPARED BY ME
OR UNDER MY SUPERVISION
Albert S. C. Chong, PE

C.O. A. D. D. D. 7