


FED. ROAD DIST. NO.	STATE	FED. AID PROJ. NO.	FISCAL YEAR	SHEET NO.	TOTAL SHEETS
HAWAII	HAW.	1-HI-1(51)	1968	26	33

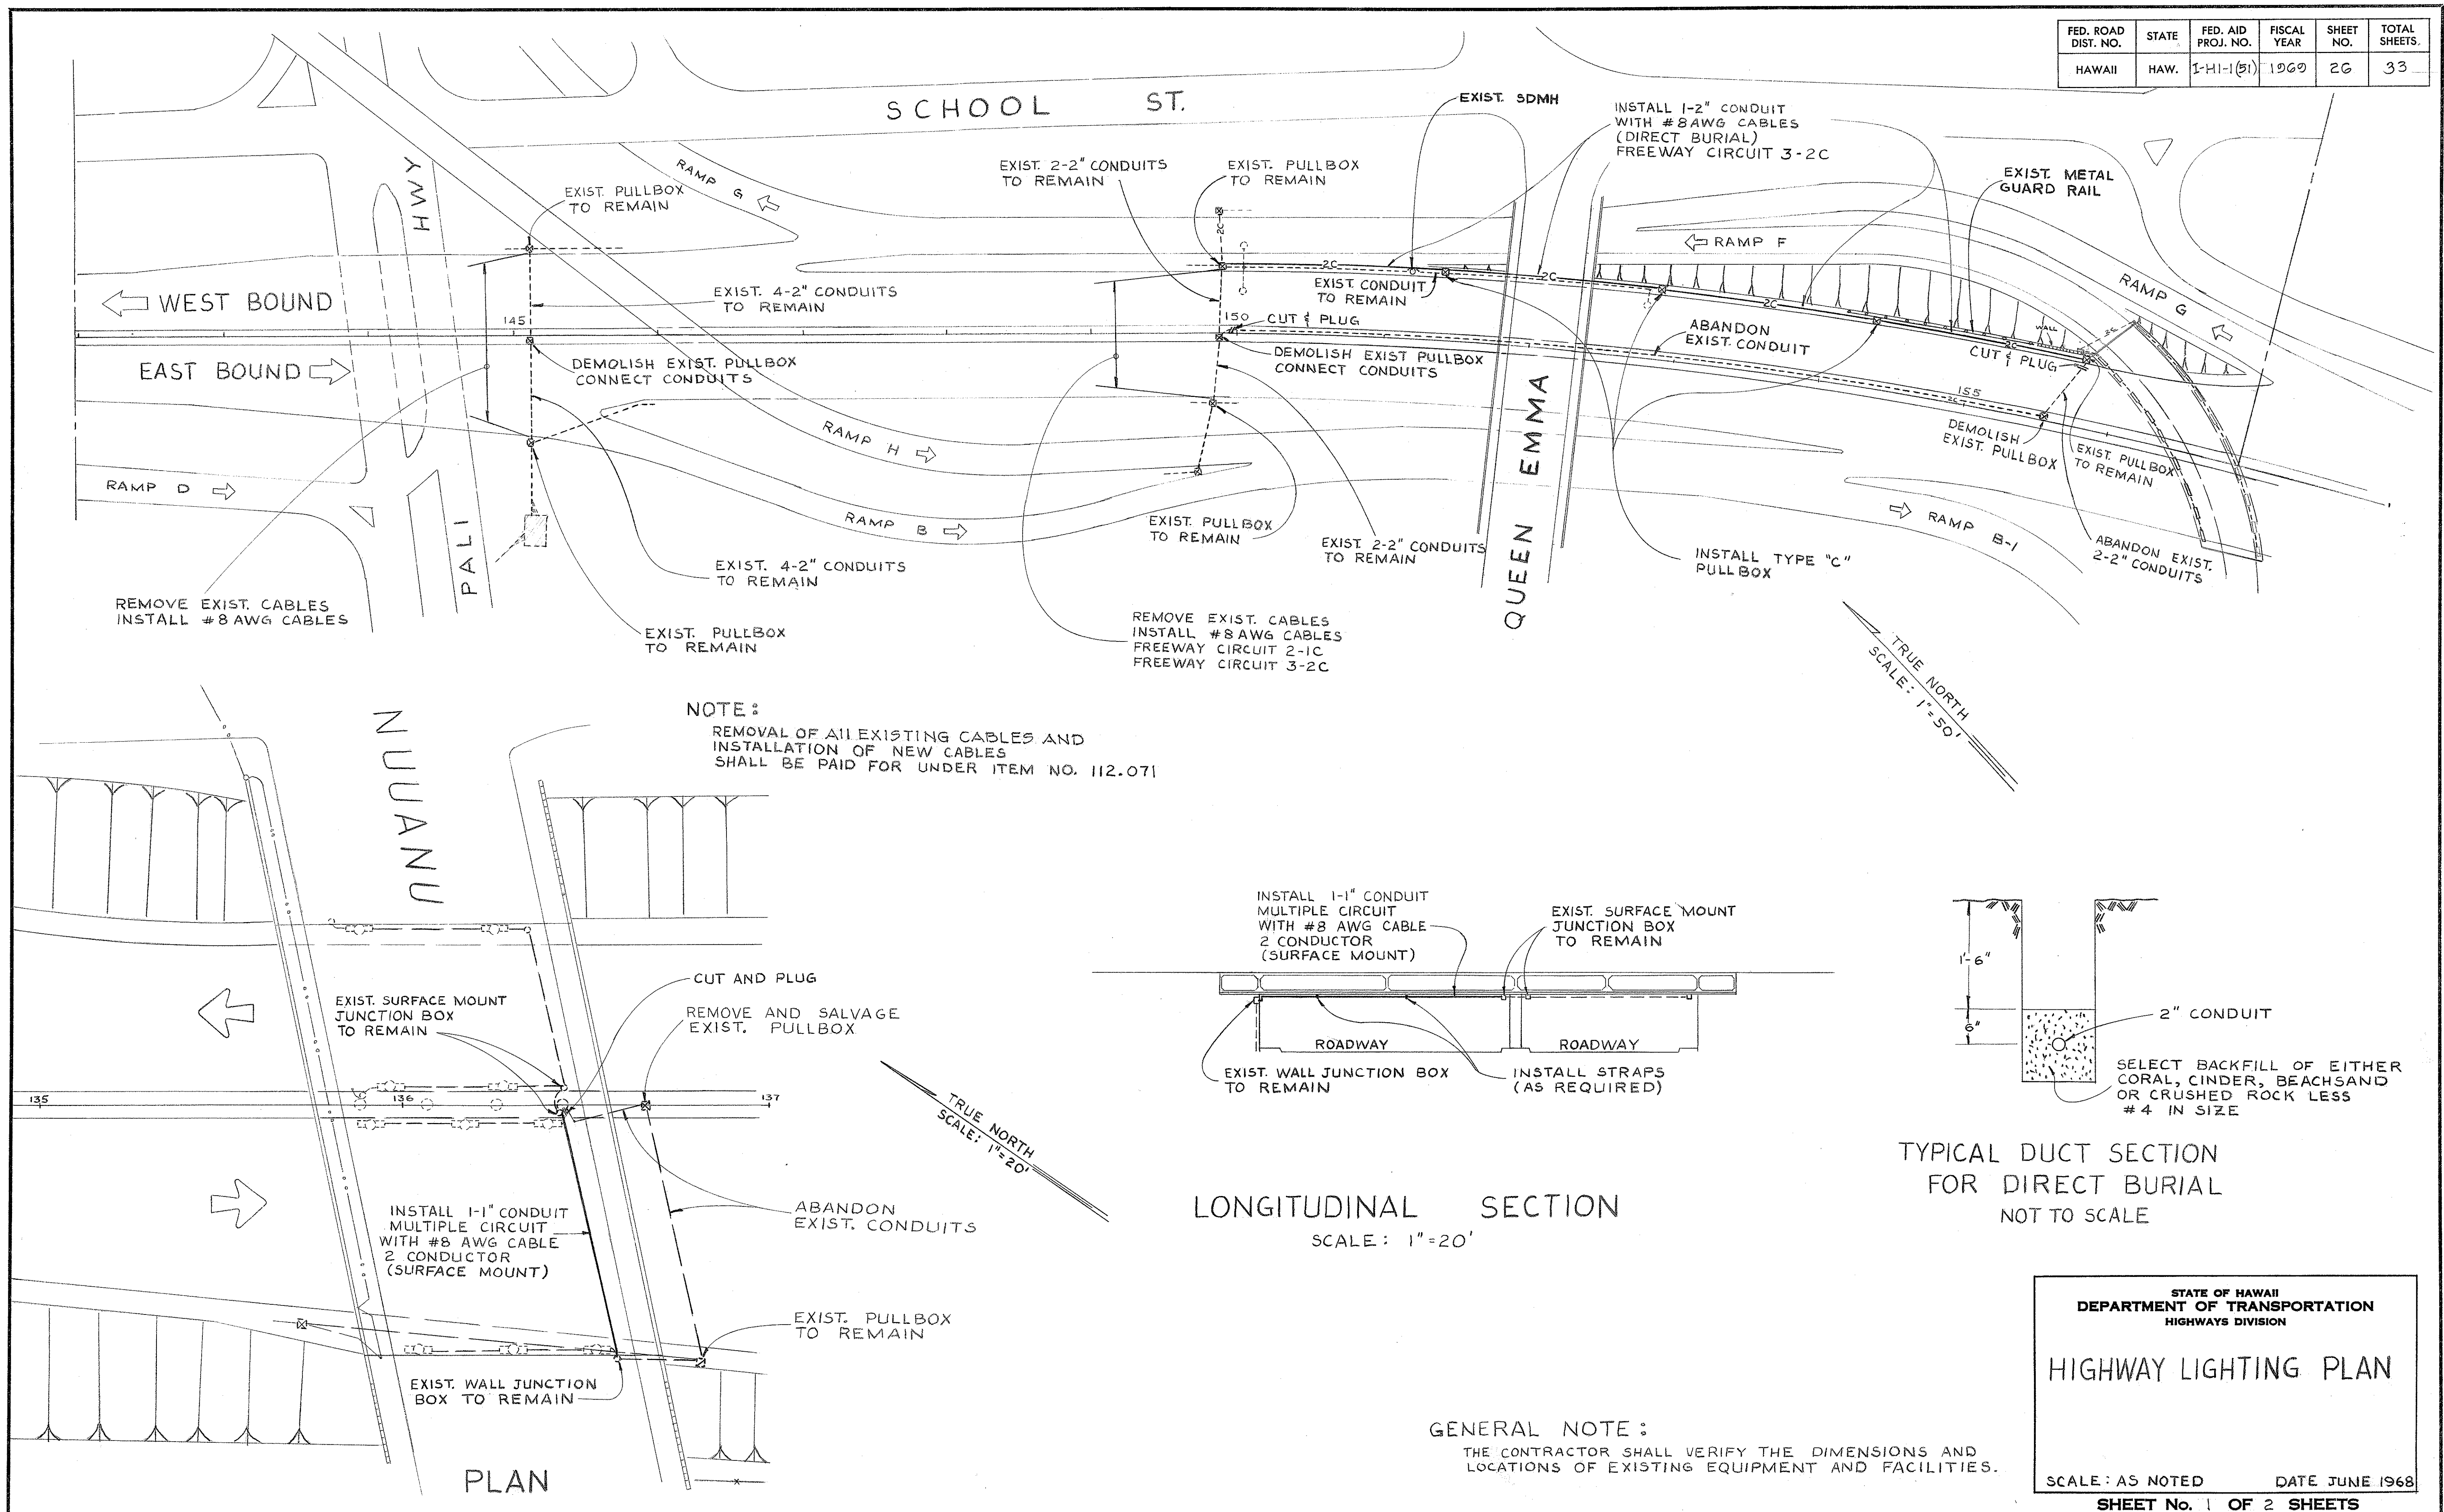

DATE	DESIGNED BY	CHECKED BY
PLAN	NOTE BOOK	No.

STATE OF HAWAII
DEPARTMENT OF TRANSPORTATION
HIGHWAYS DIVISION

HIGHWAY LIGHTING PLAN

SCALE: AS NOTED DATE JUNE 1968

SHEET No. 1 OF 2 SHEETS

