


FED. ROAD DIST. NO.	STATE	FED. AID PROJ. NO.	FISCAL YEAR	SHEET NO.	TOTAL SHEETS
HAWAII	HAW.	I-HI-1(164):16	1981	16	30

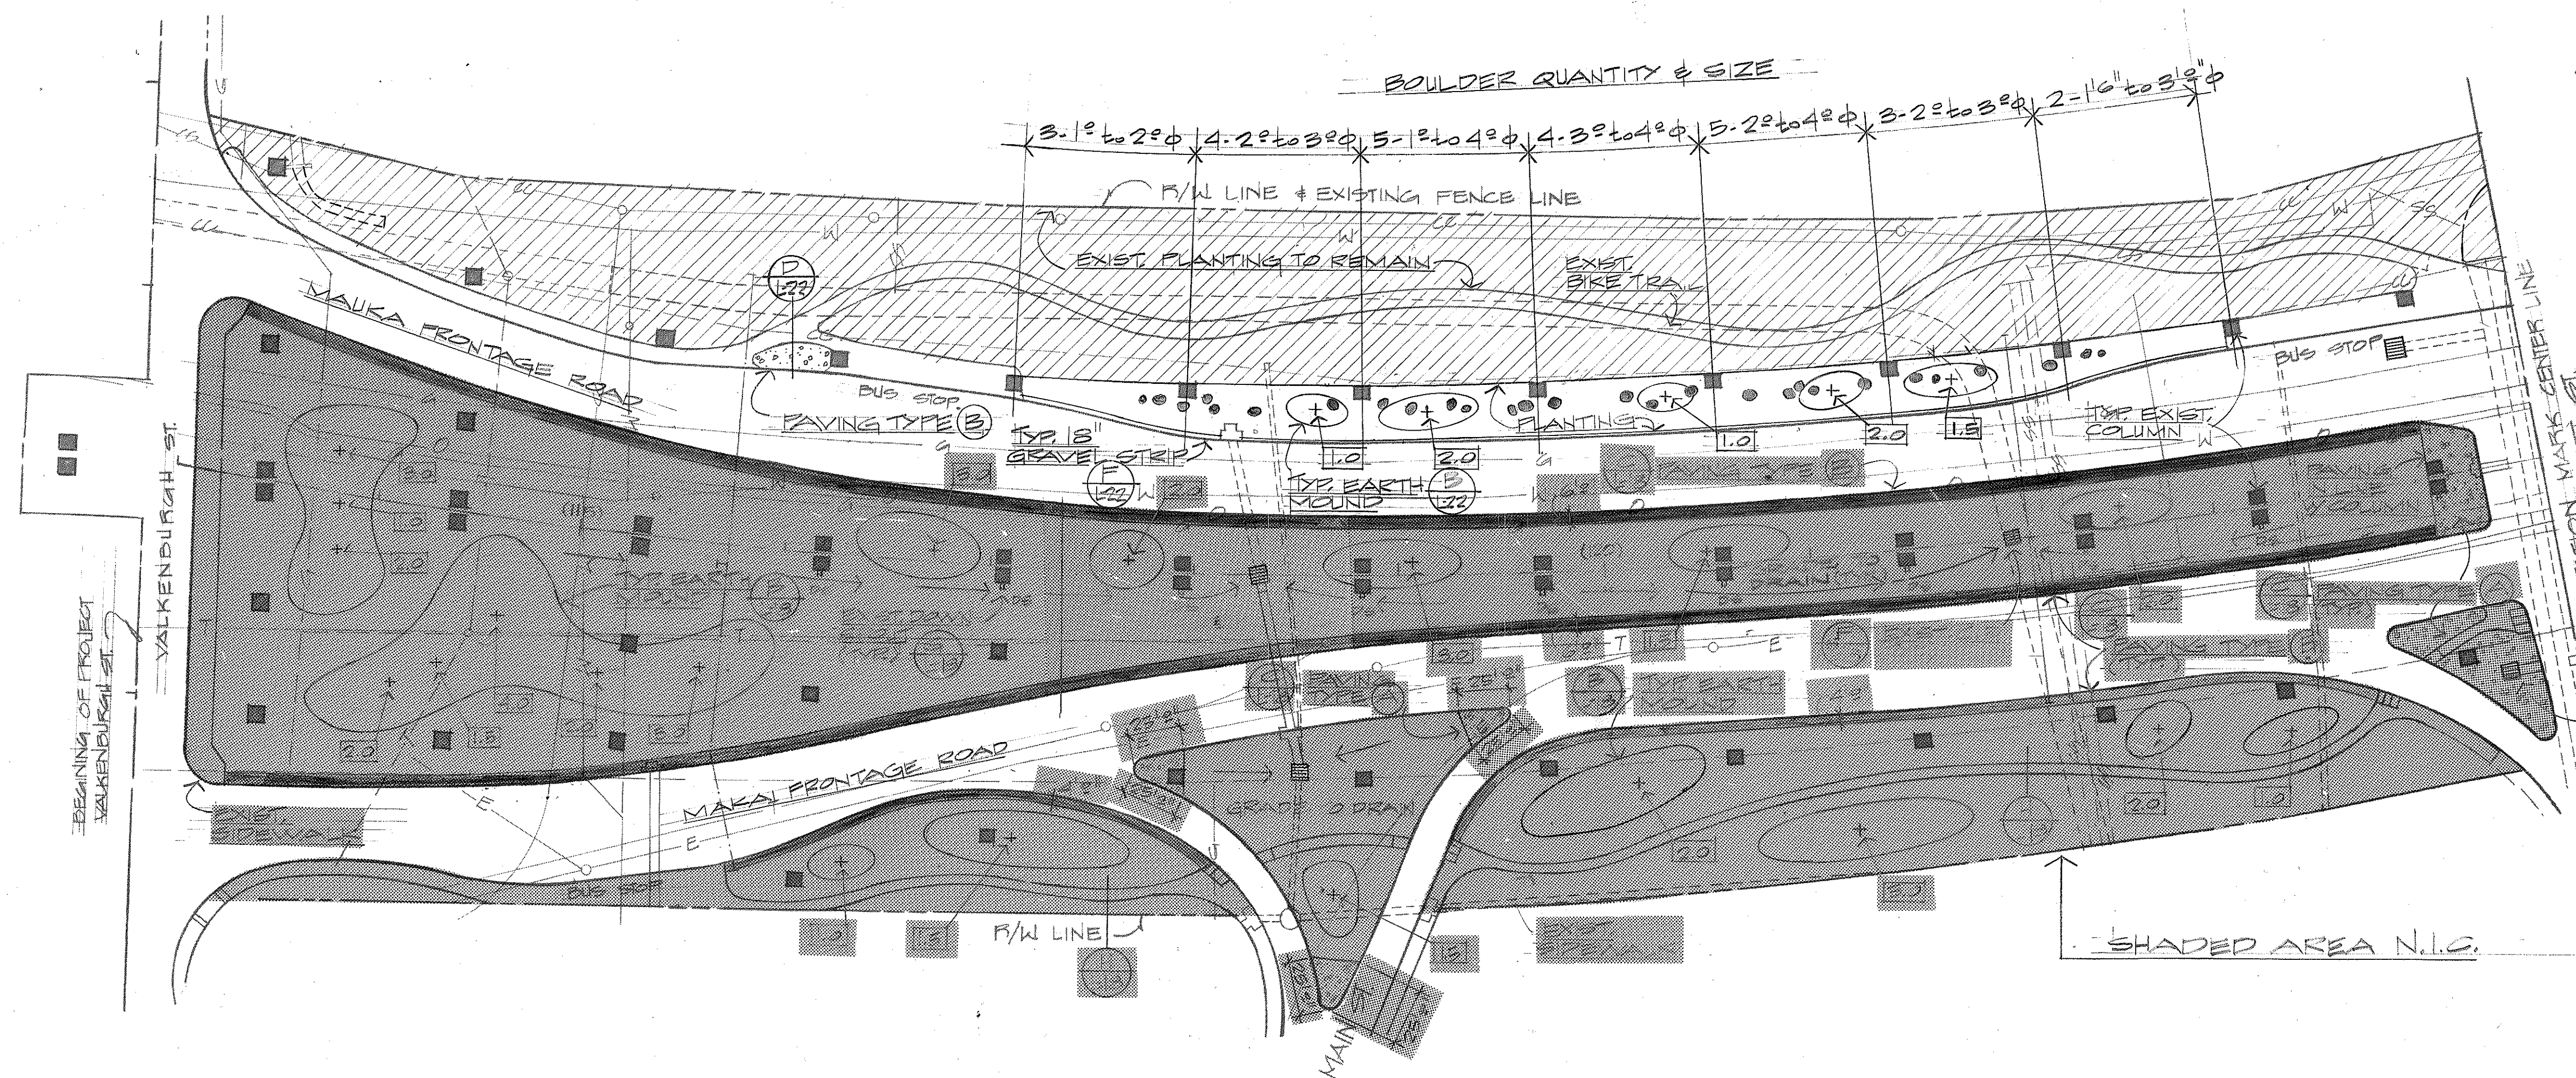

ORIGINAL PLAN	SURVEY PLOTTED BY	DATE
NOTE BOOK	DRAWN BY	*****
No.	DESIGNED BY	
	CHECKED BY	

STATE OF HAWAII
DEPARTMENT OF TRANSPORTATION
LAND TRANSPORTATION FACILITIES DIVISION

PAVING & EARTHWORK PLAN


AIRPORT INTERCHANGE
ROADWAY LANDSCAPING
F.A.I. PROJ. NO. I-HI-1(164):16
SCALE AS SHOWN DATE: 9-14-81

SHEET NO. 16 OF 30 SHEETS

THIS WORK WAS PREPARED BY ME OR UNDER MY SUPERVISION:

Melvin K. P. Lau
Signature

FED. ROAD DIST. NO.	STATE	FED. AID PROJ. NO.	FISCAL YEAR	SHEET NO.	TOTAL SHEETS
HAWAII	HAW.	I-H-1(164):16	1981	18	30

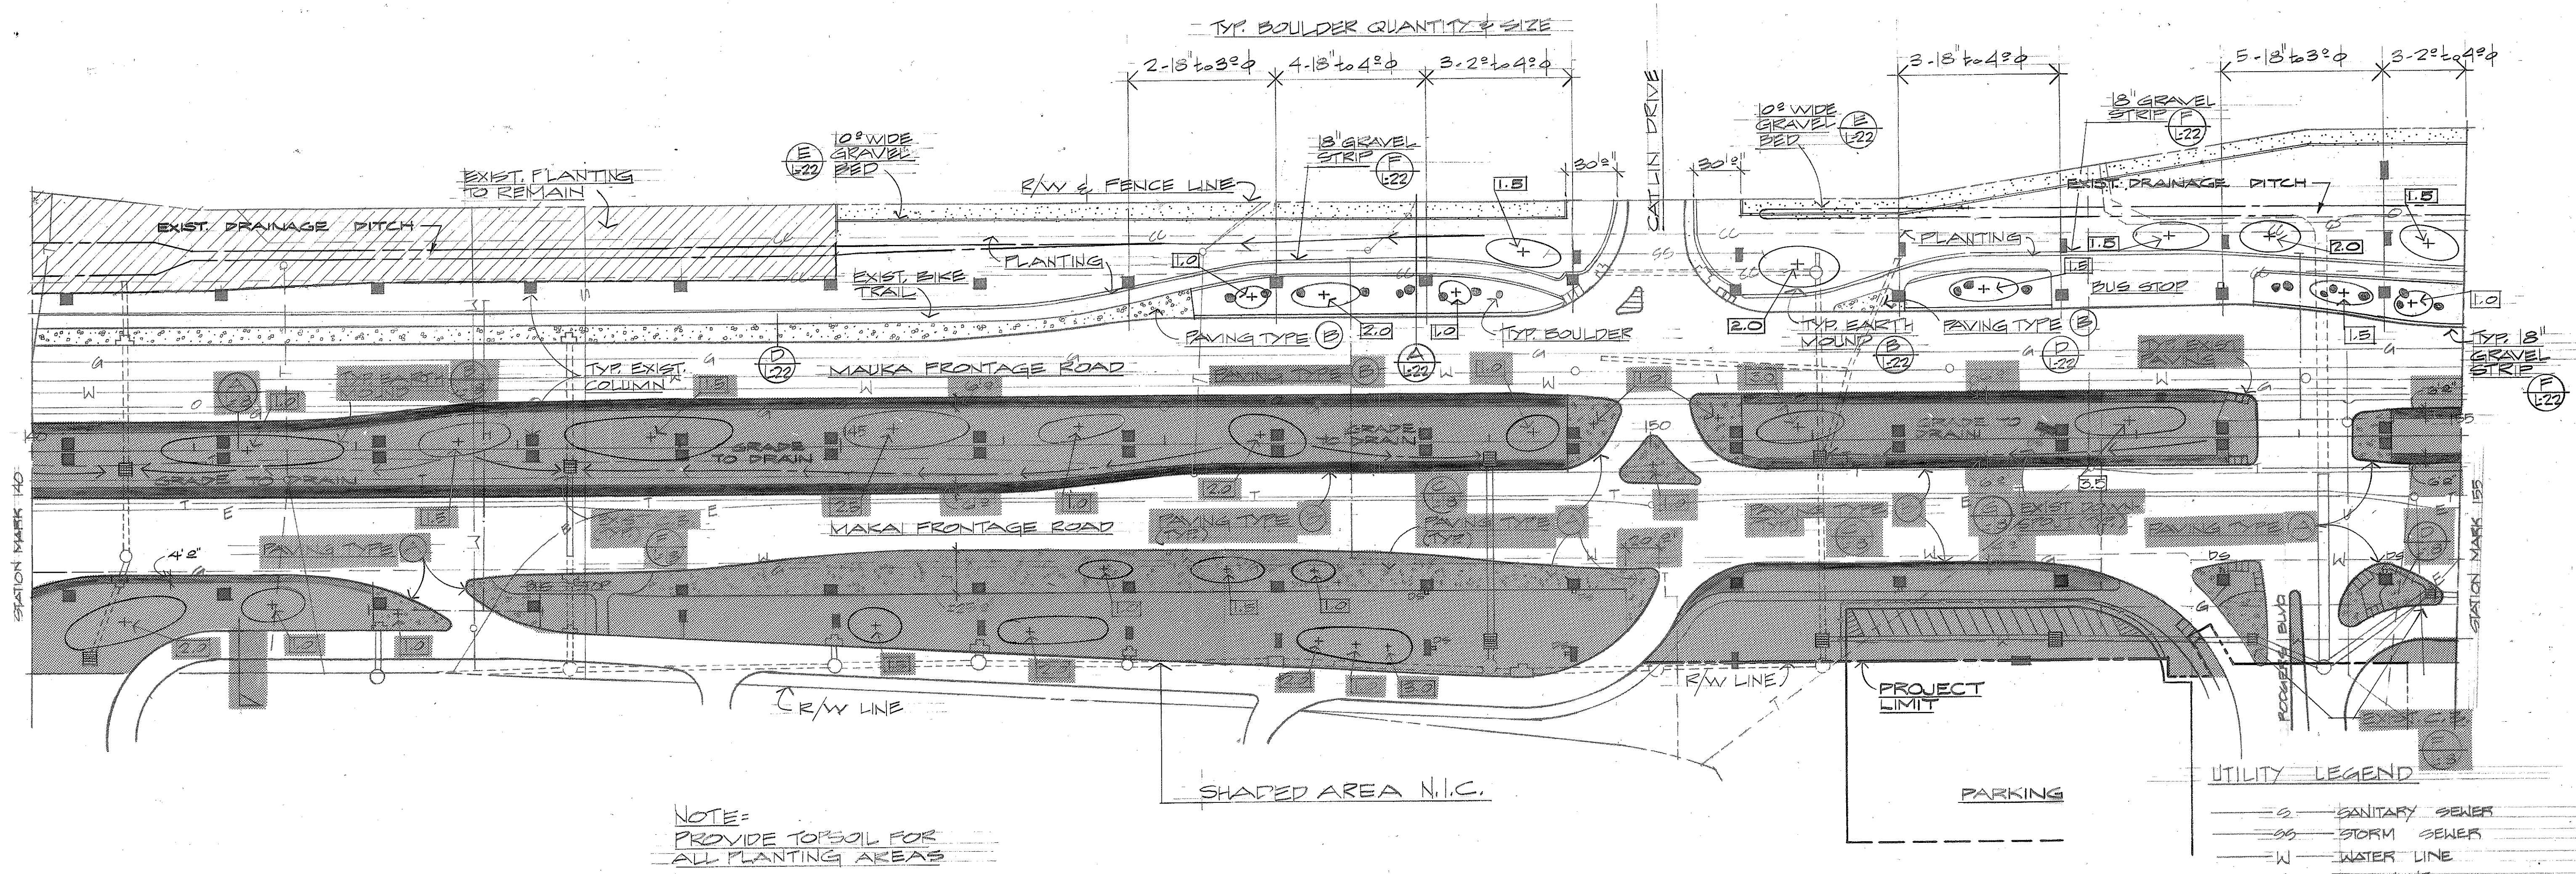

PARTIAL SITE PLAN
SCALE: 1" = 50'

ORIGINAL PLAN	DATE
SURVEY PLOTTED BY	
DRAWN BY	
TRACED BY	
QUANTITIES BY	
CHECKED BY	

STATE OF HAWAII
DEPARTMENT OF TRANSPORTATION
LAND TRANSPORTATION FACILITIES DIVISION

PAVING & EARTHWORK PLAN


AIRPORT INTERCHANGE
ROADWAY LANDSCAPING
F.A.I. PROJ. NO. I-H-1(164):16
SCALE AS SHOWN DATE: 9-14-81

SHEET NO. 17 OF 30 SHEETS

THIS WORK WAS PREPARED BY ME OR UNDER MY SUPERVISION.

Melvin K. F. Lau
Signature

FED. ROAD DIST. NO.	STATE	FED. AID PROJ. NO.	FISCAL YEAR	SHEET NO.	TOTAL SHEETS
HAWAII	HAW.	I-HI-1(164):16	1981	20	30

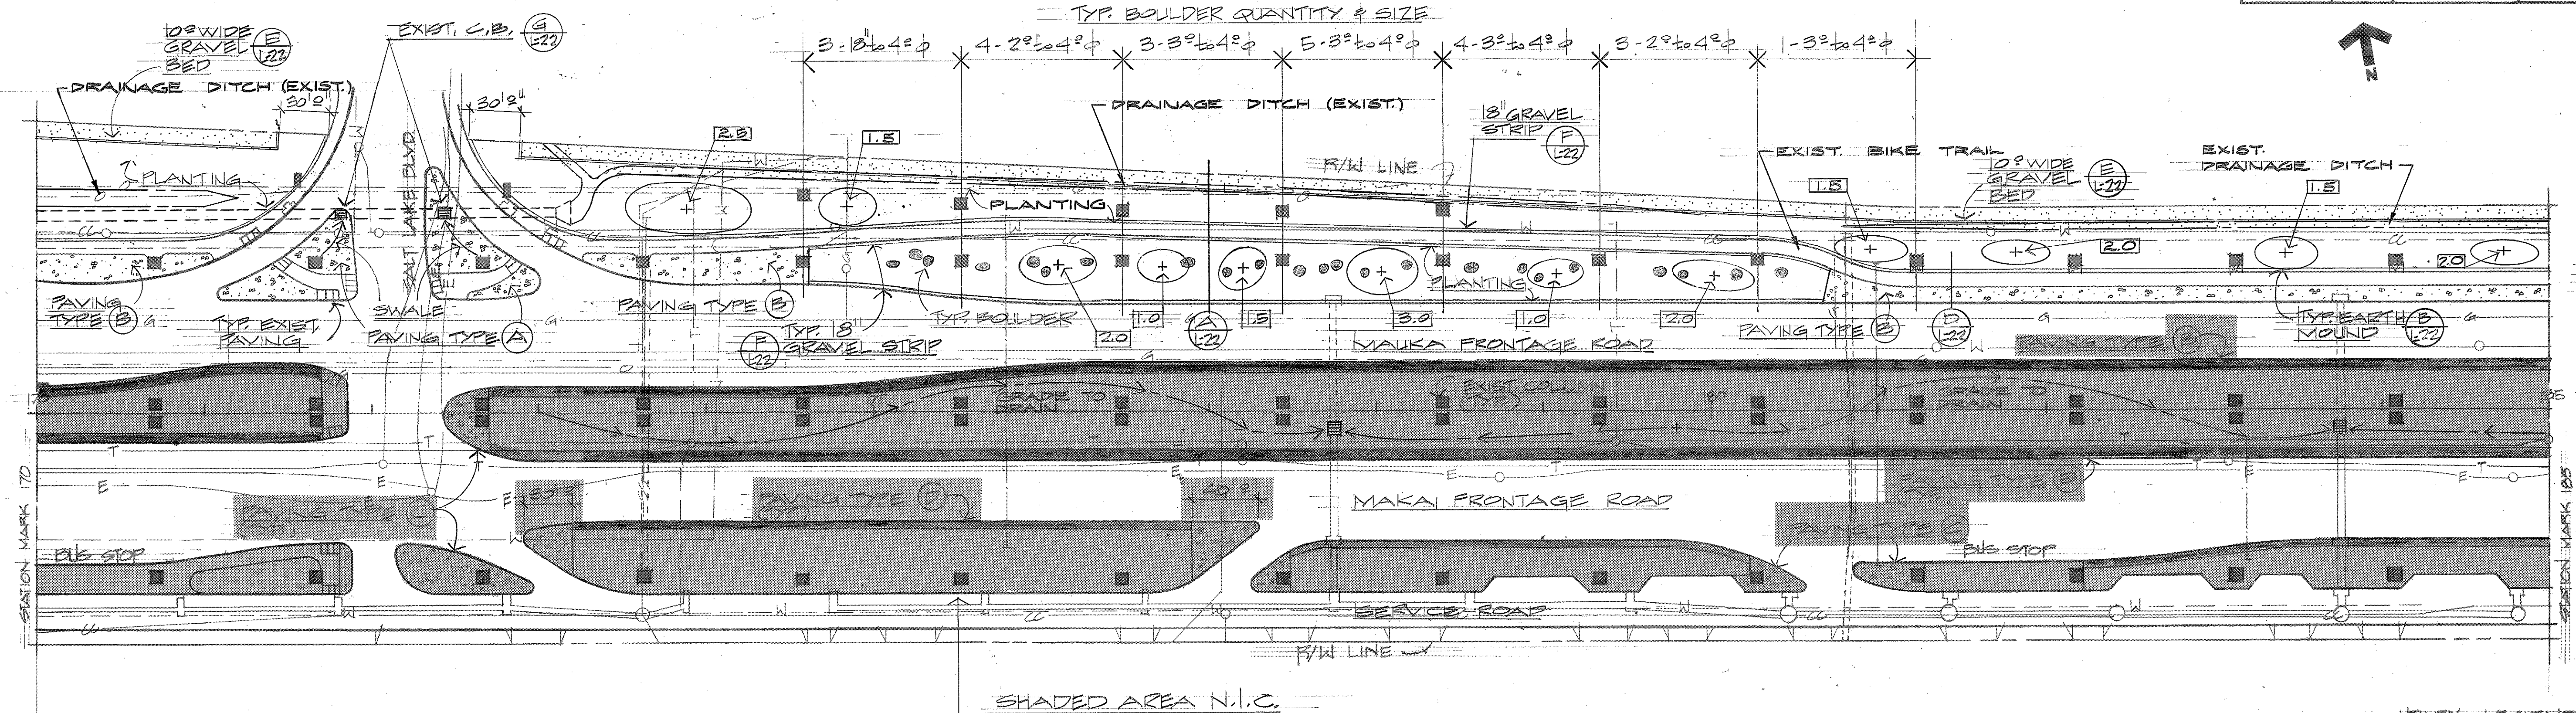

PARTIAL SITE PLAN
SCALE 1" = 50'

UTILITY LEGEND

S	SANITARY SEWER
SS	STORM SEWER
W	WATER LINE
G	GAS LINE
O	OIL LINE
CC	COMMUNICATION CABLE
E	ELECTRIC OUTLINE
T	TELEPHONE OUTLINE
○	MANHOLE, VALVE BOX
---	ABANDONED LINE
---	IRRIGATION PIPE

ORIGINAL PLAN	DATE
DESIGNED BY	
TRACED BY	
NOTED BY	
CHECKED BY	



THIS WORK WAS PREPARED BY ME OR UNDER MY SUPERVISION.
M. K. J. Jm
Signature


STATE OF HAWAII
DEPARTMENT OF TRANSPORTATION
LAND TRANSPORTATION FACILITIES DIVISION

PAVING & EARTHWORK
PLAN

AIRPORT INTERCHANGE
ROADWAY LANDSCAPING
F.A.I. PROJ. NO. I-HI-1(164):16
SCALE AS SHOWN DATE: 9-14-81

SHEET NO. 19 OF 30 SHEETS

FED. ROAD DIST. NO.	STATE	FED. AID PROJ. NO.	FISCAL YEAR	SHEET NO.	TOTAL SHEETS
HAWAII	HAW.	I-HI-1(164):16	1981	21	30

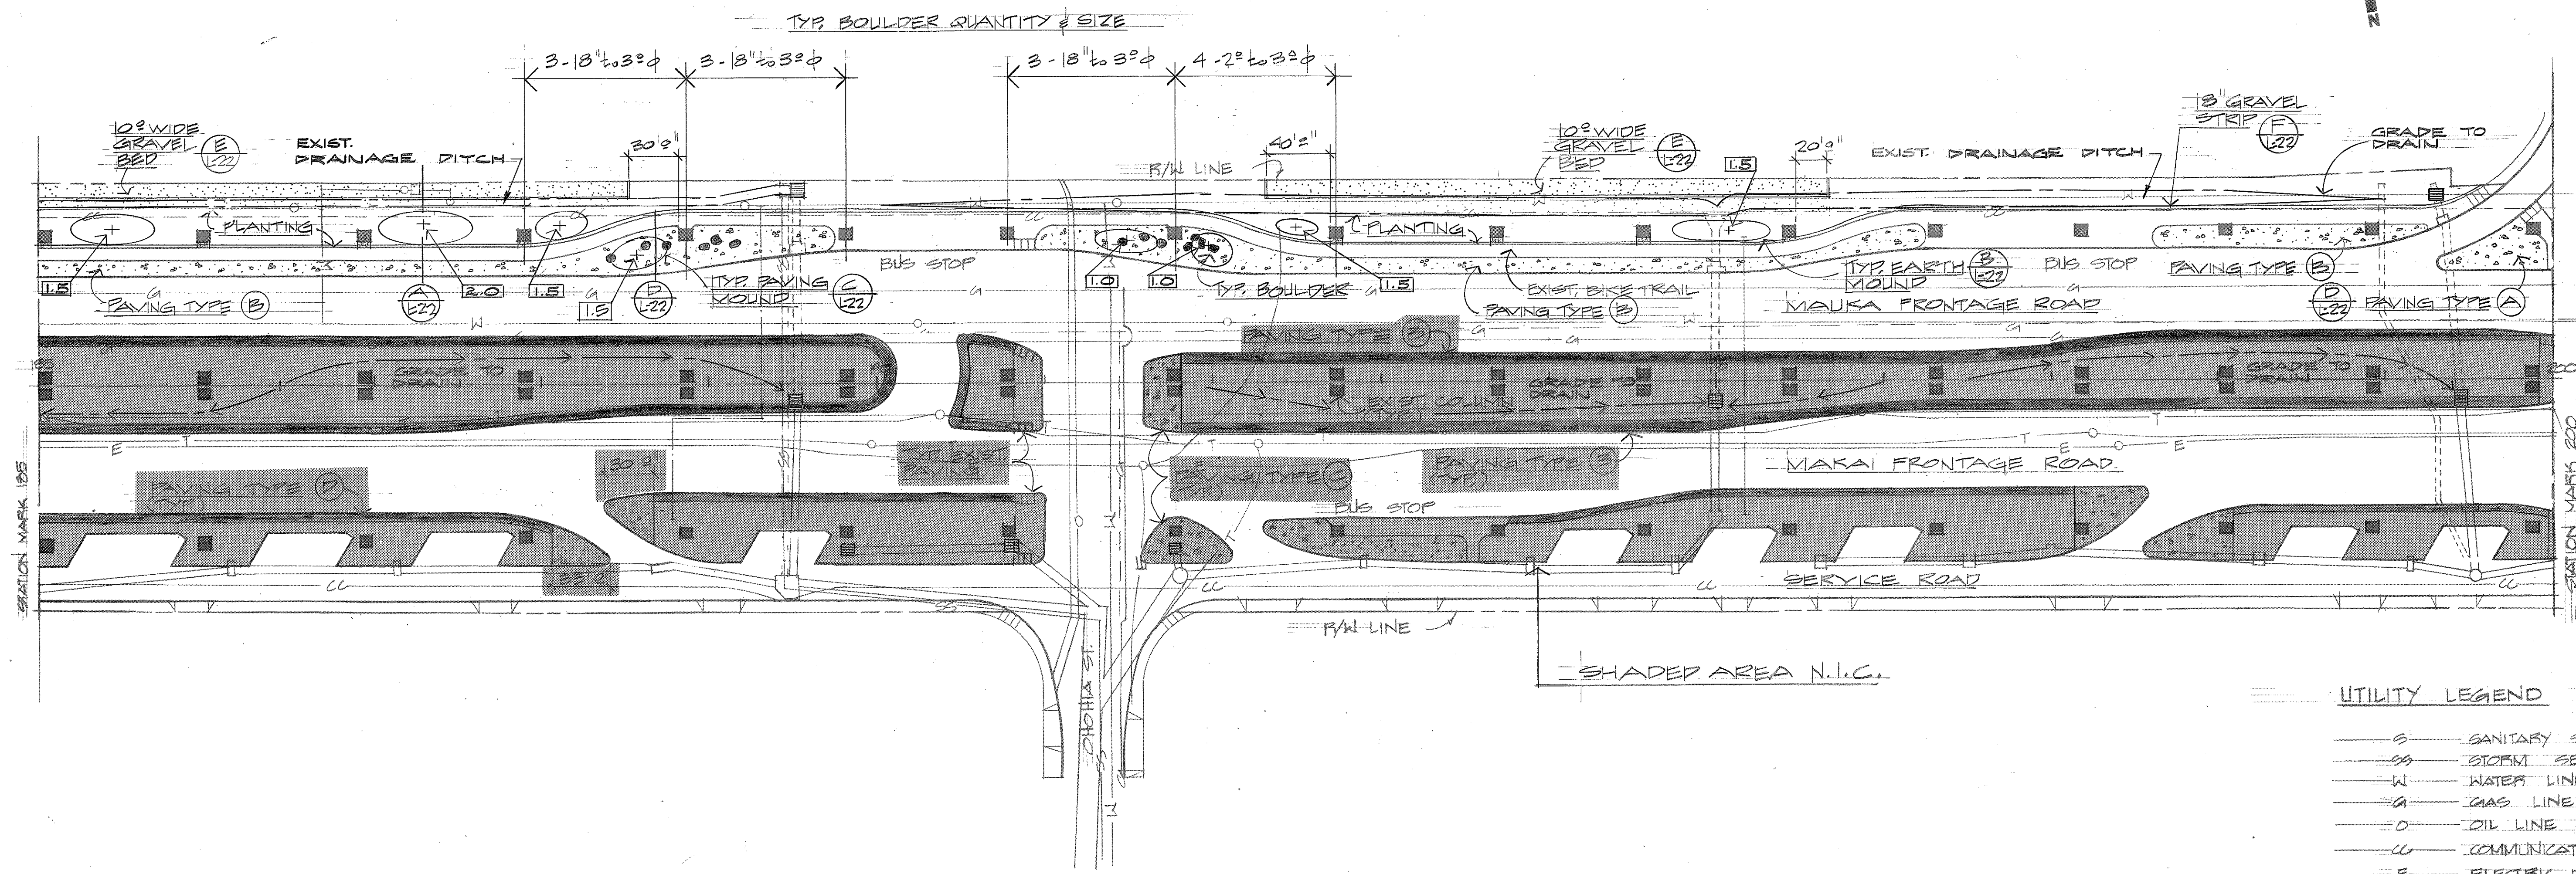


PARTIAL SITE PLAN
SCALE = 1" = 50'

UTILITY LEGEND

- S — SANITARY SEWER
- SS — STORM SEWER
- W — WATER LINE
- G — GAS LINE
- O — OIL LINE
- CC — COMMUNICATION CABLE
- E — ELECTRIC DUCTLINE
- T — TELEPHONE DUCTLINE
- — MANHOLE VALVE BOX
- ABANDONED LINE
- IRRIGATION PIPE

ORIGINAL PLAN	SHEET PLOTTED BY	DATE
NOTE BOOK	DESIGNED BY	
NO.	CHECKED BY	

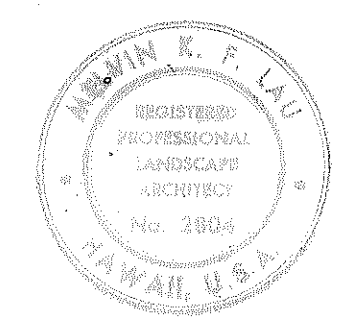

THIS WORK WAS PREPARED BY ME OR UNDER MY SUPERVISION.
K. F. Lau
Signature


STATE OF HAWAII
DEPARTMENT OF TRANSPORTATION
LAND TRANSPORTATION FACILITIES DIVISION

PAVING & EARTHWORK PLAN

AIRPORT INTERCHANGE
ROADWAY LANDSCAPING
F.A.I. PROJ. NO. I-HI-1(164):16
SCALE AS SHOWN DATE: 9-14-81

SHEET NO. 20 OF 30 SHEETS


FED. ROAD DIST. NO.	STATE	FED. AID PROJ. NO.	FISCAL YEAR	SHEET NO.	TOTAL SHEETS
HAWAII	HAW.	I-HI-1(164):16	1981	22	30

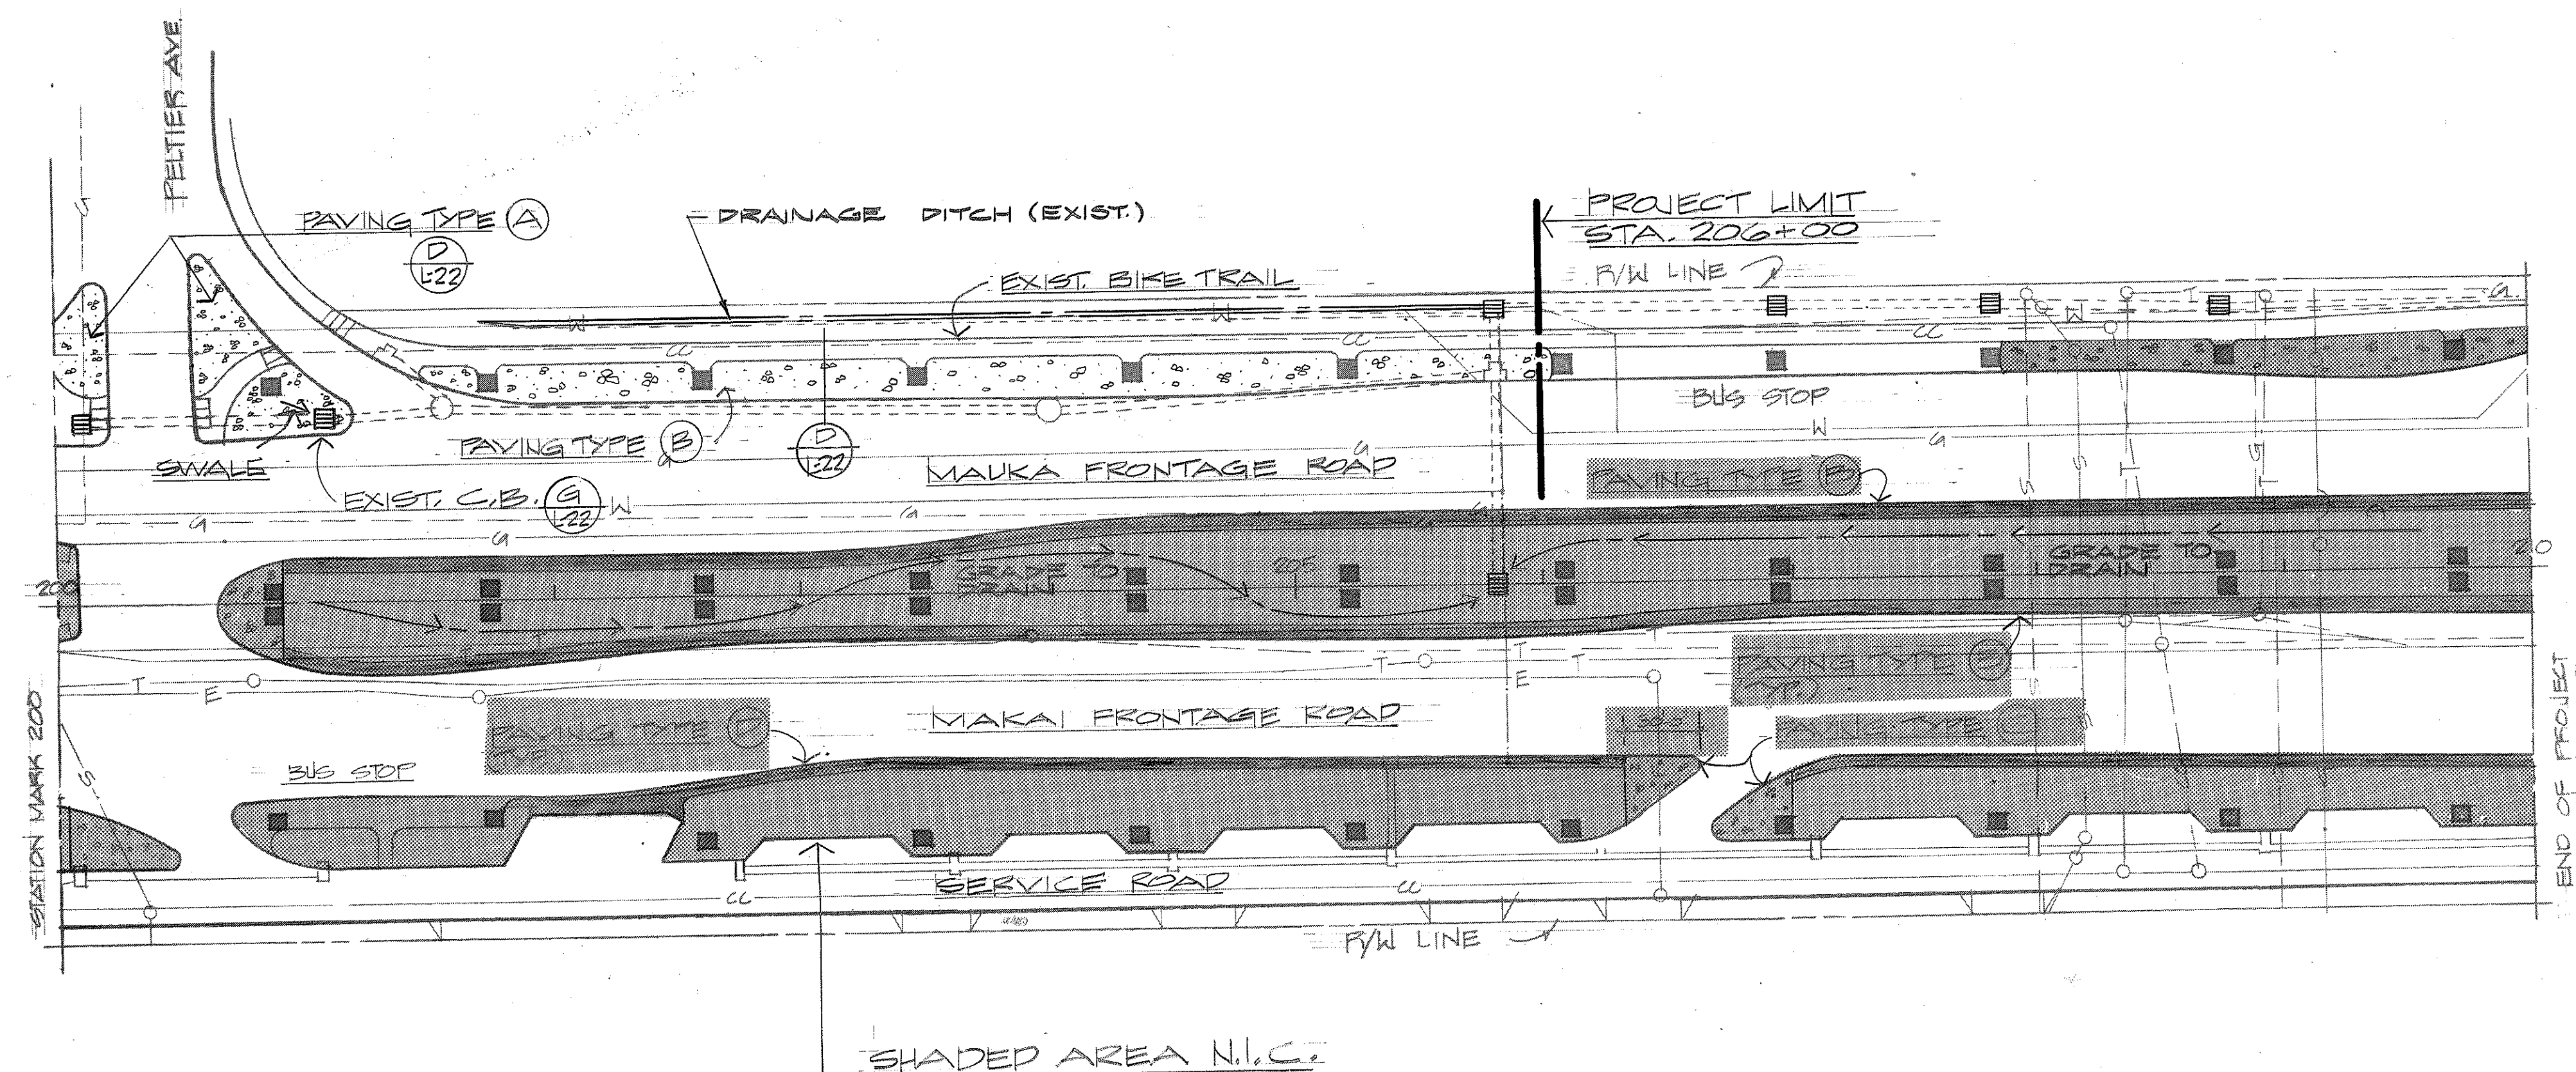

PARTIAL SITE PLAN
SCALE = 1" = 50'

LEGEND FOR UTILITIES

- S— SANITARY SEWER
- SS— STORM SEWER
- W— WATER LINE
- G— GAS LINE
- O— OIL LINE
- CC— COMMUNICATION CABLE (ARMY OR NAVY)
- T— TELEPHONE DUCTLINE
- E— ELECTRIC DUCTLINE
- O— MANHOLE, VALVE BOX
- — — ABANDONED LINE
- — — IRRIGATION PIPE

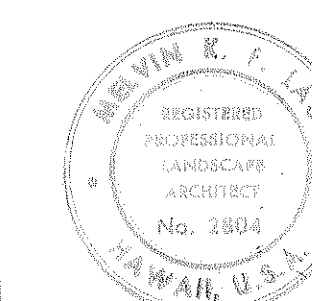

THIS WORK WAS PREPARED BY
ME OR UNDER MY SUPERVISION.
M. K. F. Lau
Signature

STATE OF HAWAII
DEPARTMENT OF TRANSPORTATION
LAND TRANSPORTATION FACILITIES DIVISION

PAVING & EARTHWORK
PLAN

AIRPORT INTERCHANGE
ROADWAY LANDSCAPING
F.A.I. PROJ. NO. I-HI-1(164):16
SCALE AS SHOWN DATE: 9-14-81

SHEET NO. 22 OF 30 SHEETS