


FED. ROAD DIST. NO.	STATE	FED. AID PROJ. NO.	FISCAL YEAR	SHEET NO.	TOTAL SHEETS
HAWAII	HAW.	I-IR-HI-1(173):16	1982	18	22

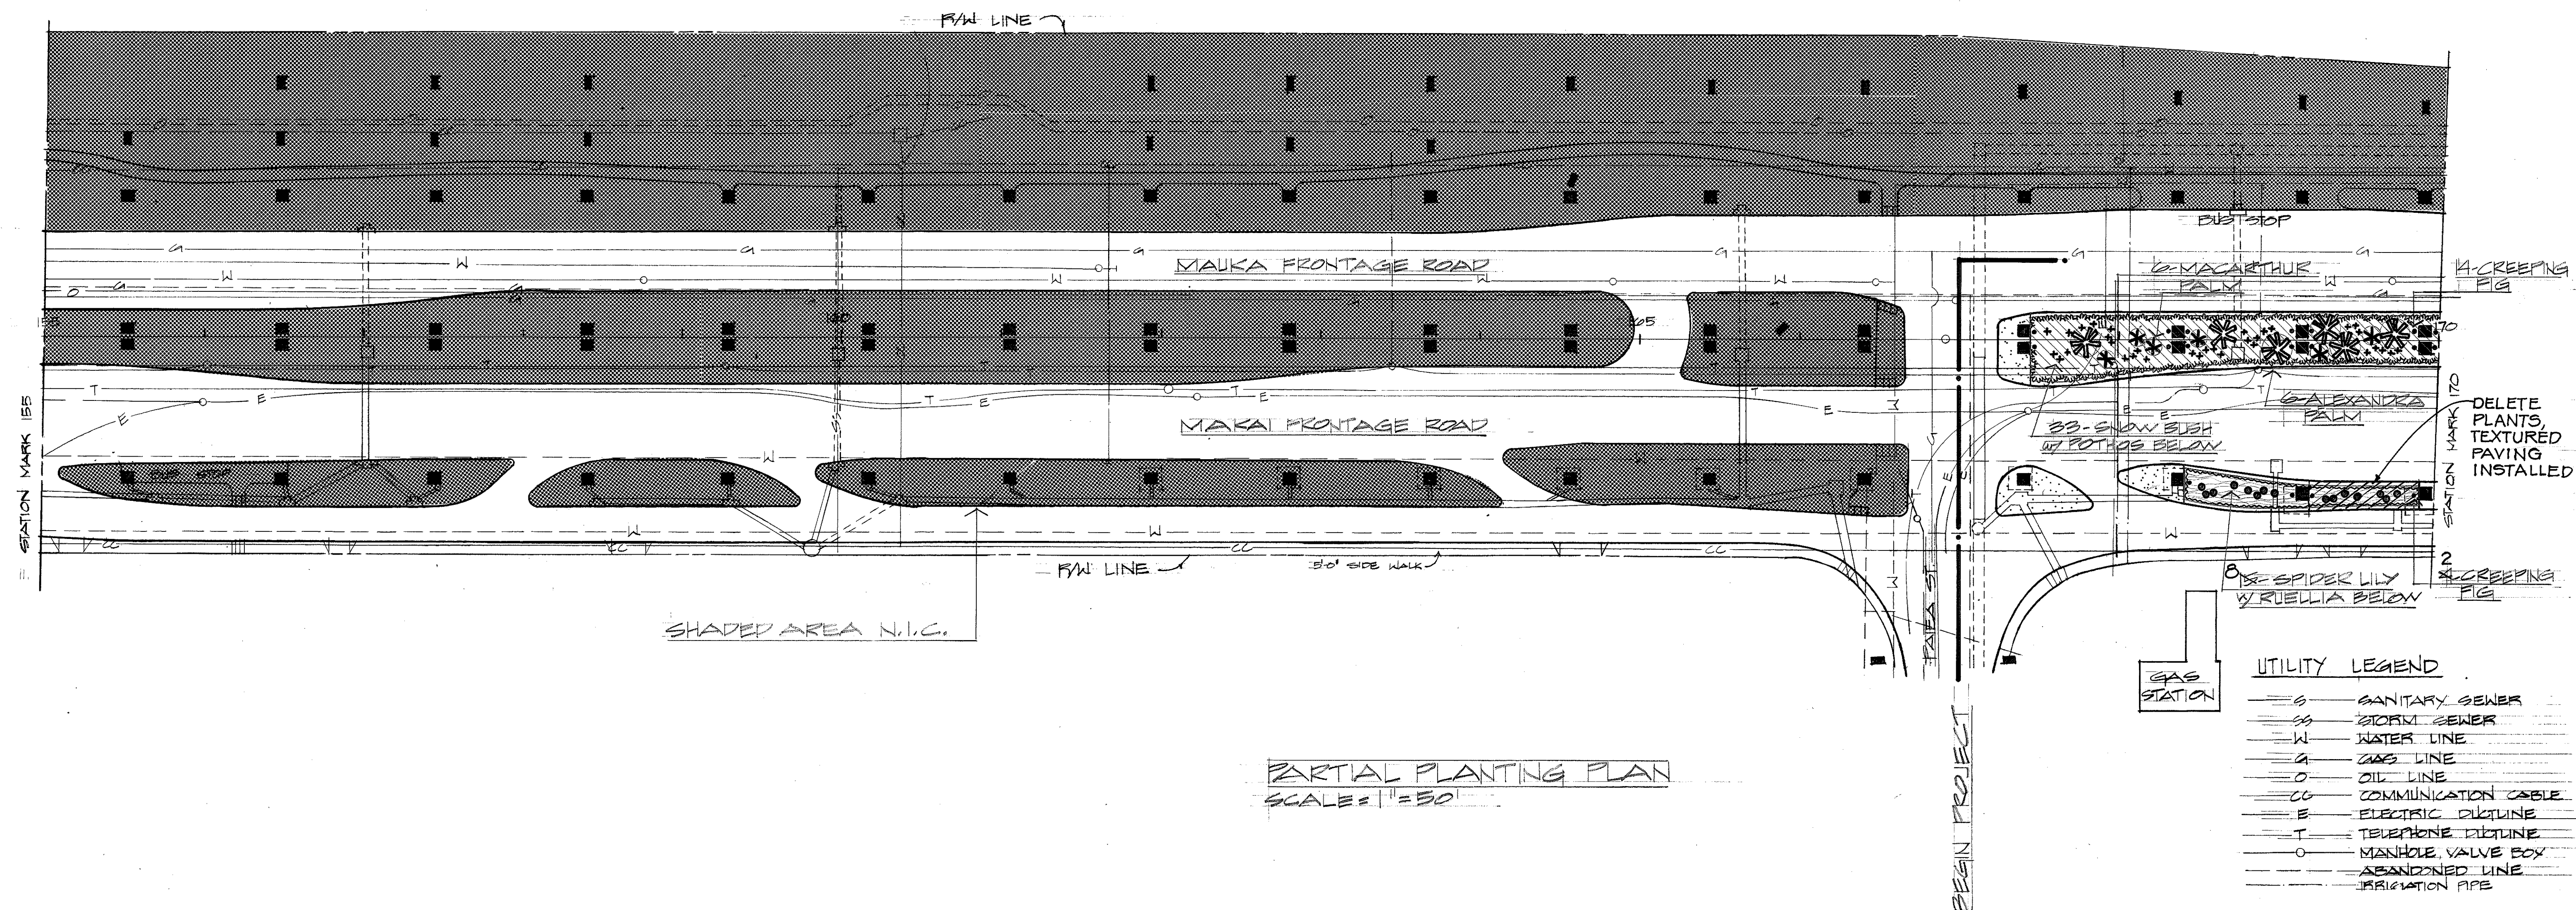

UTILITY LEGEND	
S	SANITARY SEWER
SS	STORM SEWER
W	WATER LINE
A	GAS LINE
O	OIL LINE
CC	COMMUNICATION CABLE
E	ELECTRIC DUCTLINE
T	TELEPHONE DUCTLINE
V	MANHOLE, VALVE BOX
---	ABANDONED LINE
---	IRRIGATION PIPE

SURVEY PLOTTED BY	DATE
DRAWN BY	
TRACED BY	
QUANTITIES BY	
CHECKED BY	
NOTE BOOK	
No.	

THIS WORK WAS PREPARED BY:
ME OR UNDER MY SUPERVISION.
Melvin K. F. Lau
Signature


STATE OF HAWAII
DEPARTMENT OF TRANSPORTATION
LAND TRANSPORTATION FACILITIES DIVISION

PARTIAL PLANTING PLAN

AIRPORT INTERCHANGE
ROADWAY EROSION CONTROL & LANDSCAPING
F.A.I. PROJ. NO. I-IR-HI-1(173):16
SCALE: AS SHOWN DATE: 2/3/83

SHEET NO. 18 OF 22 SHEETS

FED. ROAD DIST. NO.	STATE	FED. AID PROJ. NO.	FISCAL YEAR	SHEET NO.	TOTAL SHEETS
HAWAII	HAW.	I-IR-HI-1(173):16	1982	19	22

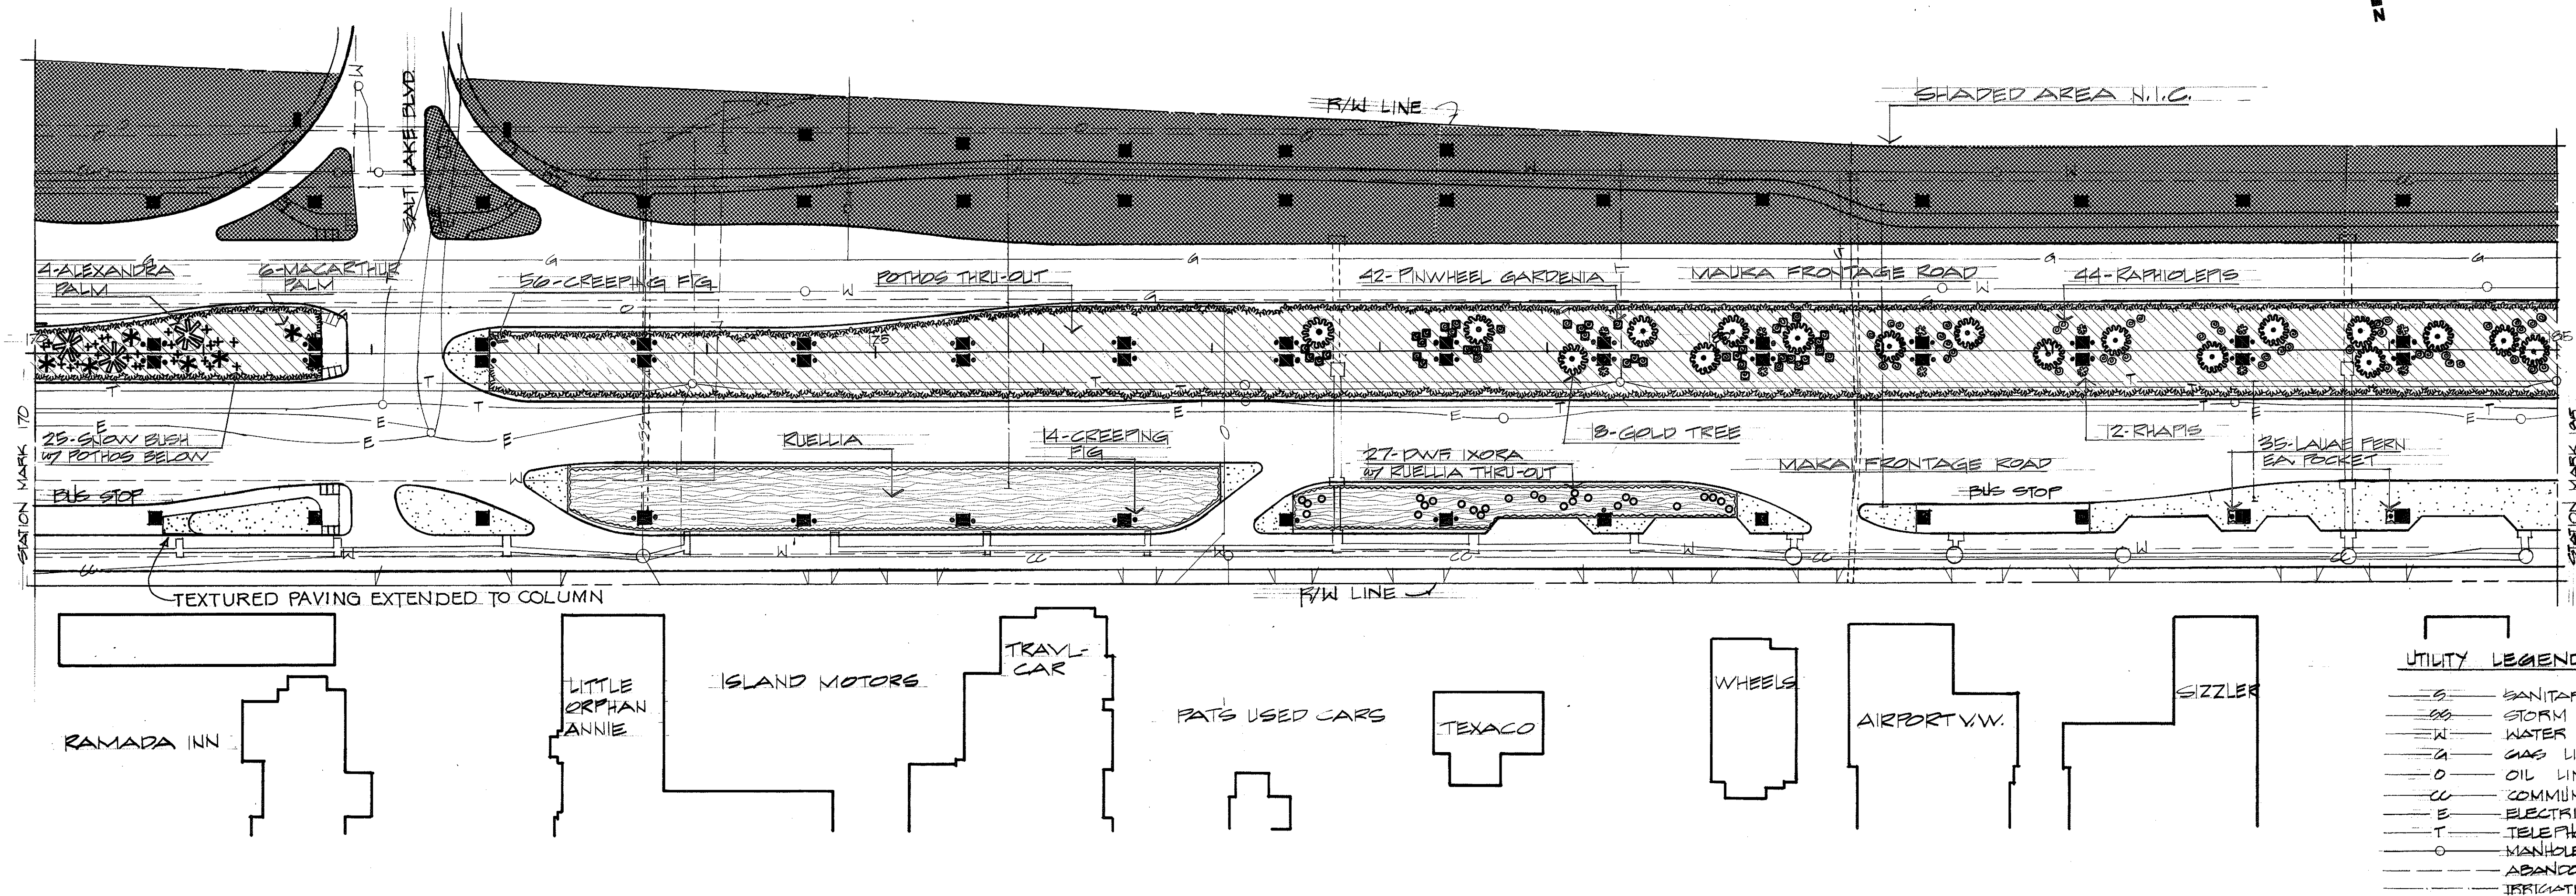

PARTIAL PLANTING PLAN
SCALE = 1" = 50'

SURVEY PLOTTED BY	DATE
DRAWN BY	
DESIGNED BY	
CHECKED BY	
NOTE BOOK	
NO.	

THIS WORK WAS PREPARED BY ME OR UNDER MY SUPERVISION.

Marvin K. P. Lau
Signature


STATE OF HAWAII
DEPARTMENT OF TRANSPORTATION
LAND TRANSPORTATION FACILITIES DIVISION

PARTIAL PLANTING PLAN

AIRPORT INTERCHANGE
ROADWAY EROSION CONTROL & LANDSCAPING
F.A.I. PROJ. NO. I-IR-HI-1(173):16
SCALE: AS SHOWN DATE: 2/3/83

SHEET NO. 19 OF 22 SHEETS

FED. ROAD DIST. NO.	STATE	FED. AID PROJ. NO.	FISCAL YEAR	SHEET NO.	TOTAL SHEETS
HAWAII	HAW.	I-IP-HI-1(173):16	1982	20	22

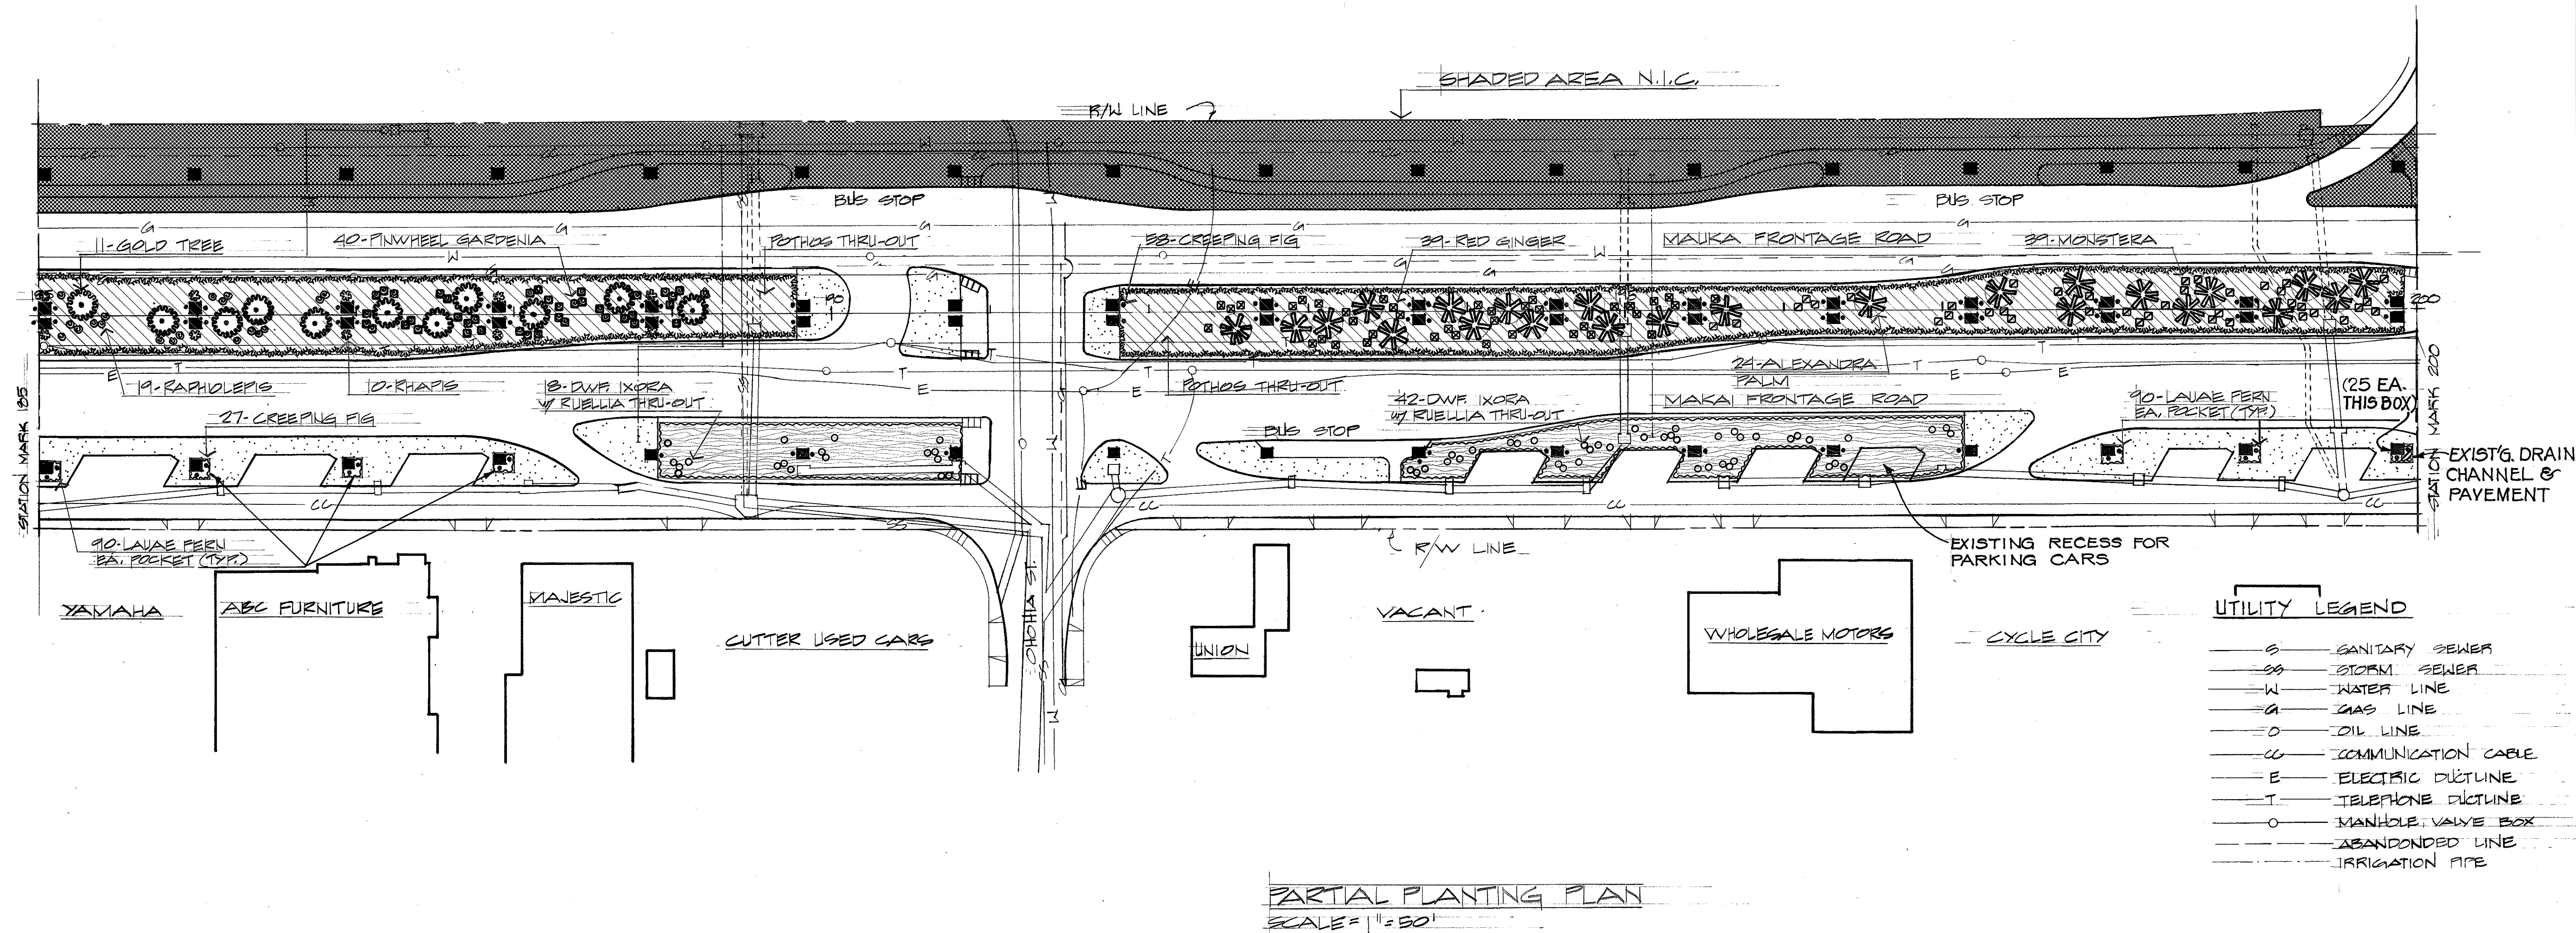

ORIGINAL PLAN	SURVEY PLOTTED BY	DATE
NO.	DRAWN BY	
	DESIGNED BY	
	CHECKED BY	

THIS WORK WAS PREPARED BY ME OR UNDER MY SUPERVISION.

Kevin K. P. Lau
Signature


STATE OF HAWAII
DEPARTMENT OF TRANSPORTATION
LAND TRANSPORTATION FACILITIES DIVISION

PARTIAL PLANTING PLAN

AIRPORT INTERCHANGE
ROADWAY EROSION CONTROL & LANDSCAPING
F.A.I. PROJ. NO. I-IP-HI-1(173):16
SCALE AS SHOWN DATE: 2/3/83

SHEET NO. 20 OF 22 SHEETS

FED. ROAD DIST. NO.	STATE	FED. AID PROJ. NO.	FISCAL YEAR	SHEET NO.	TOTAL SHEETS
HAWAII	HAW.	I-IR-HI-K(173)-16	1982	21	22

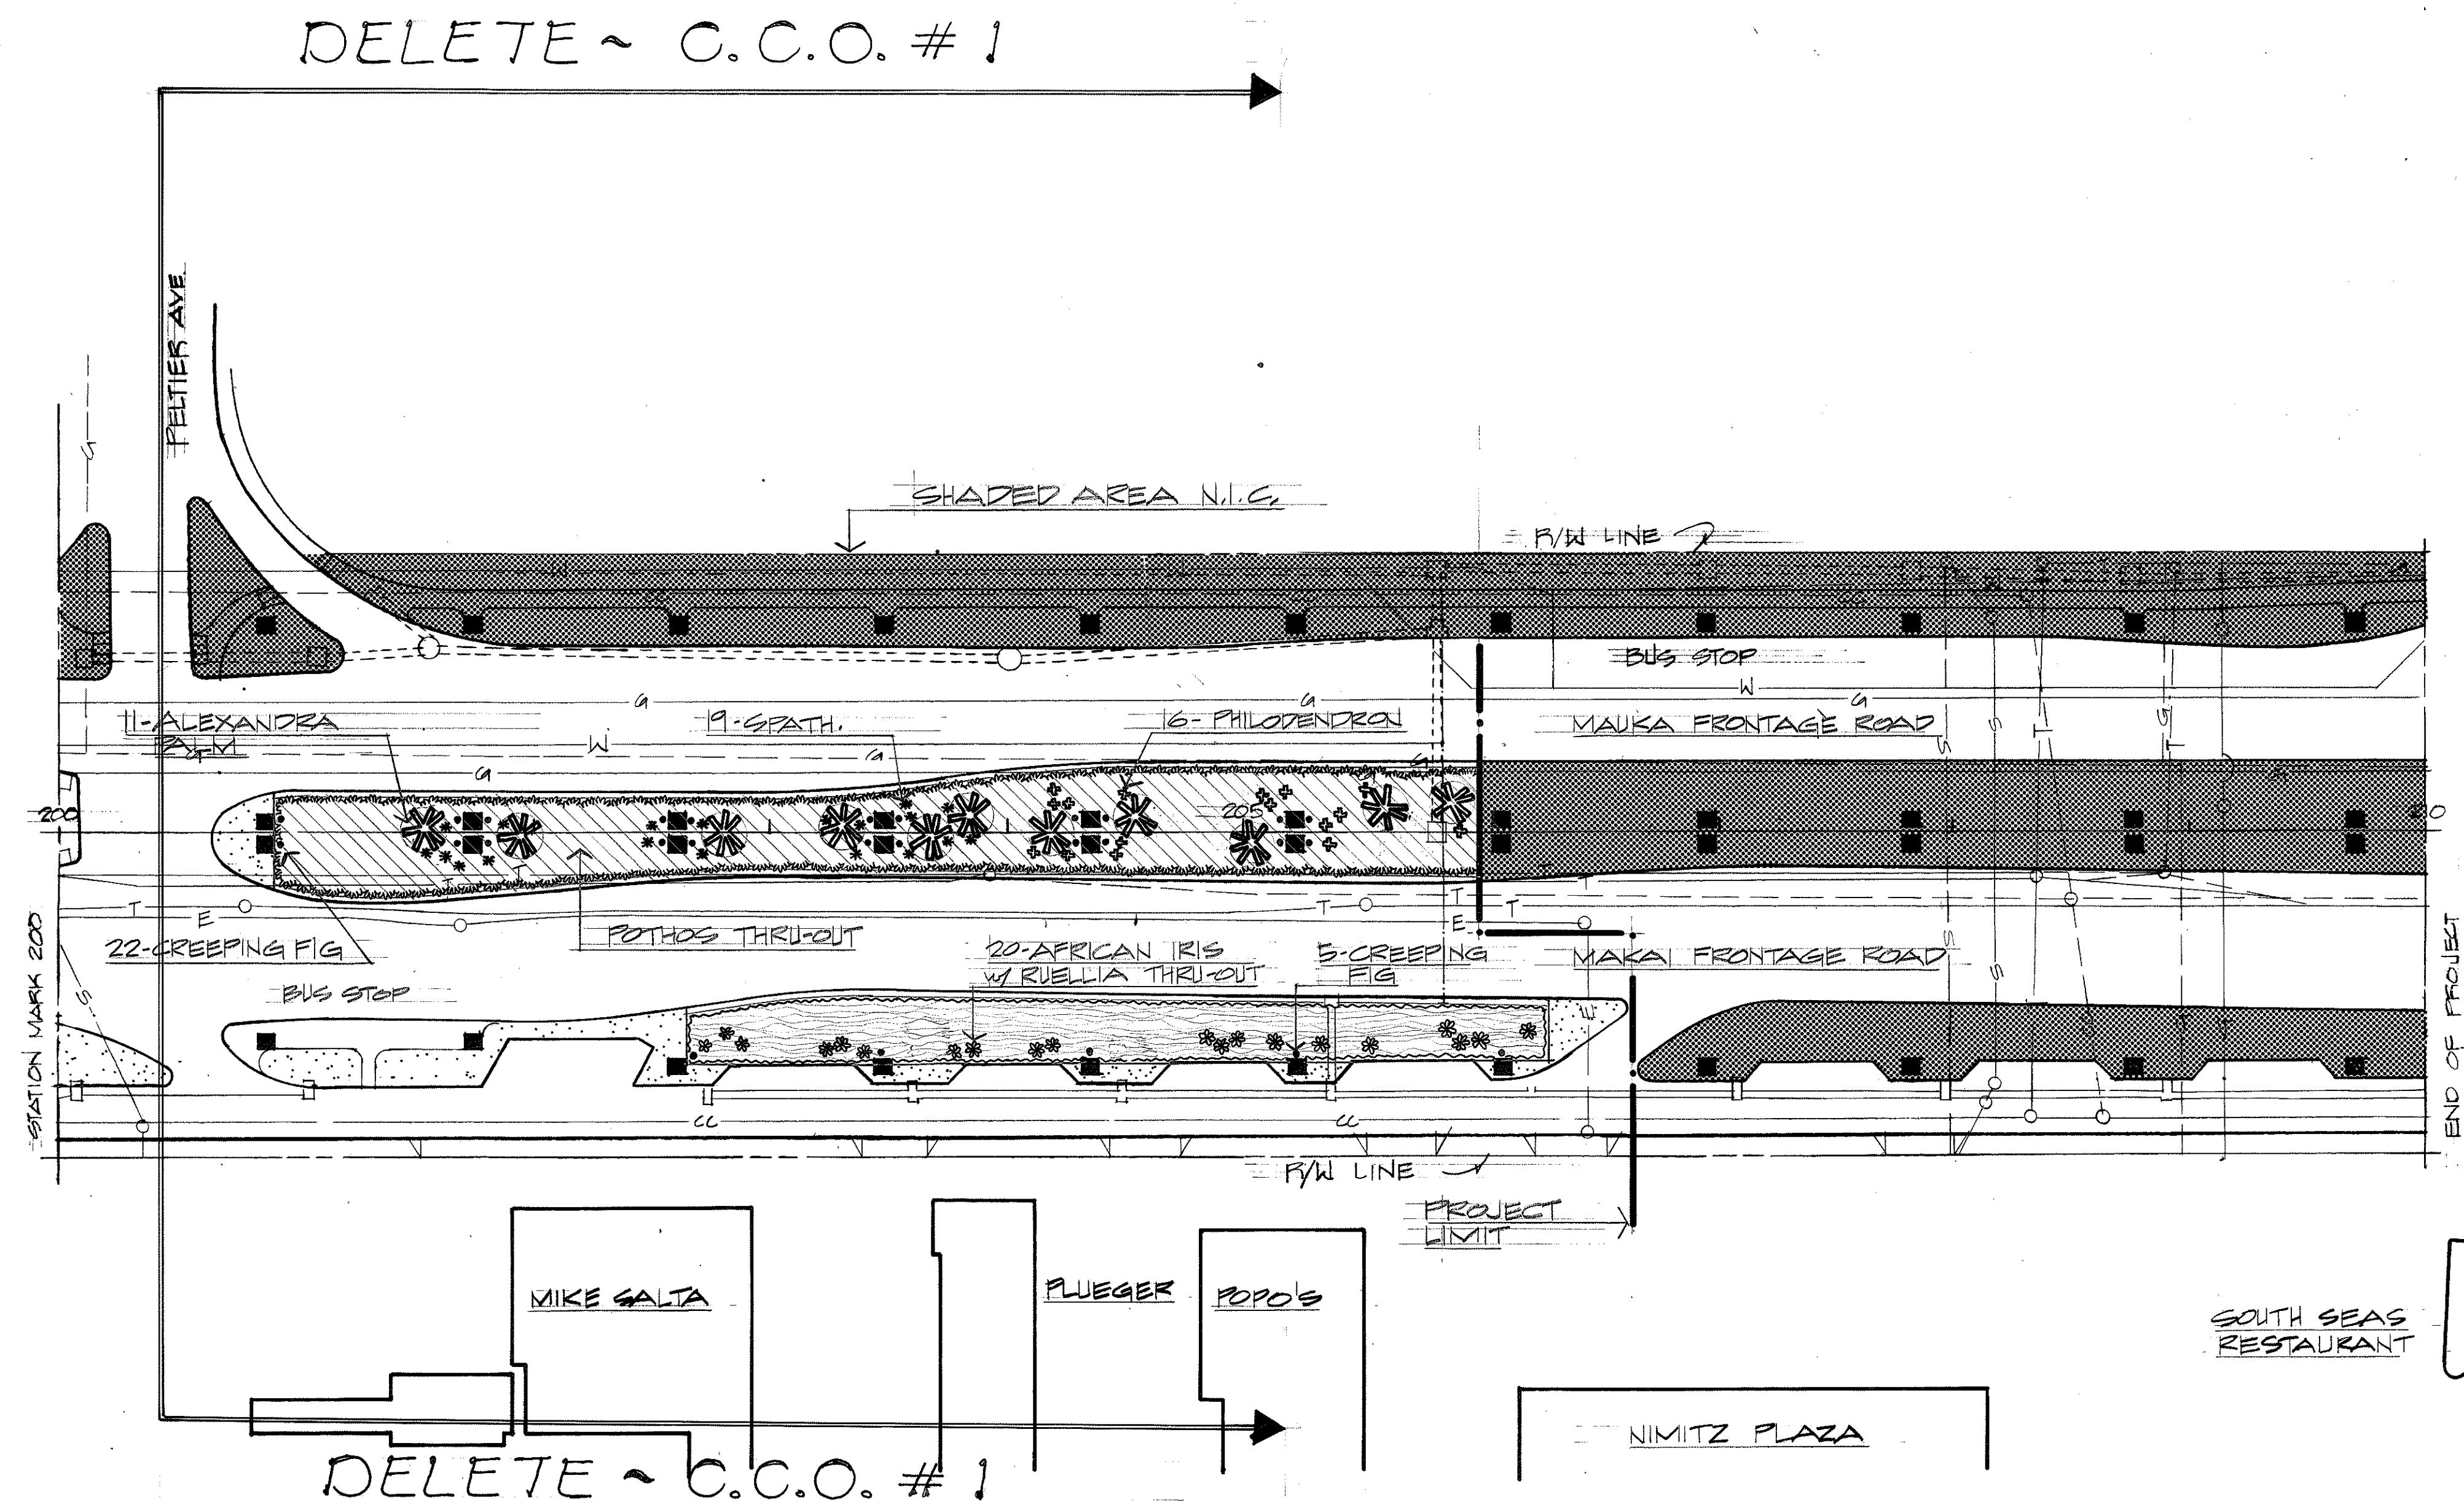

PARTIAL PLANTING PLAN
SCALE = 1" = 50'

LEGEND FOR UTILITIES

- S— SANITARY SEWER
- SS— STORM SEWER
- W— WATER LINE
- G— GAS LINE
- O— OIL LINE
- CU— COMMUNICATION CABLE (ARMY OR NAVY)
- T— TELEPHONE DUCTLINE
- E— ELECTRIC DUCTLINE
- O— MANHOLE, VALVE BOX
- — — ABANDONED LINE
- — — IRRIGATION PIPE

C.C.O. # 1
DELETE ALL WORK EAST
OF PELTIER AVE.

	STATE OF HAWAII DEPARTMENT OF TRANSPORTATION LAND TRANSPORTATION FACILITIES DIVISION
	PARTIAL PLANTING PLAN
	AIRPORT INTERCHANGE ROADWAY EROSION CONTROL & LANDSCAPING F.A.I. PROJ. NO. I-IR-HI-K(173)-16 SCALE: AS SHOWN DATE: 2/3/83
	SHEET NO. 21 OF 22 SHEETS

THIS WORK WAS PREPARED BY ME OR UNDER MY SUPERVISION.
M. K. F. Leo
Signature