
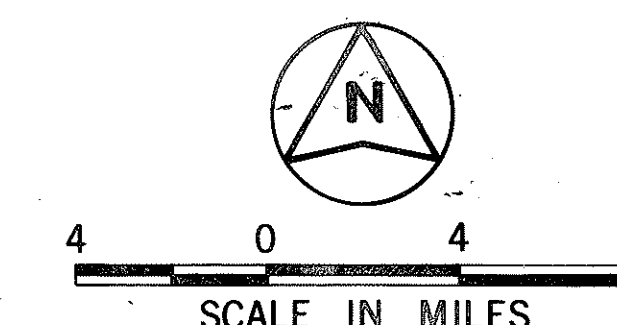
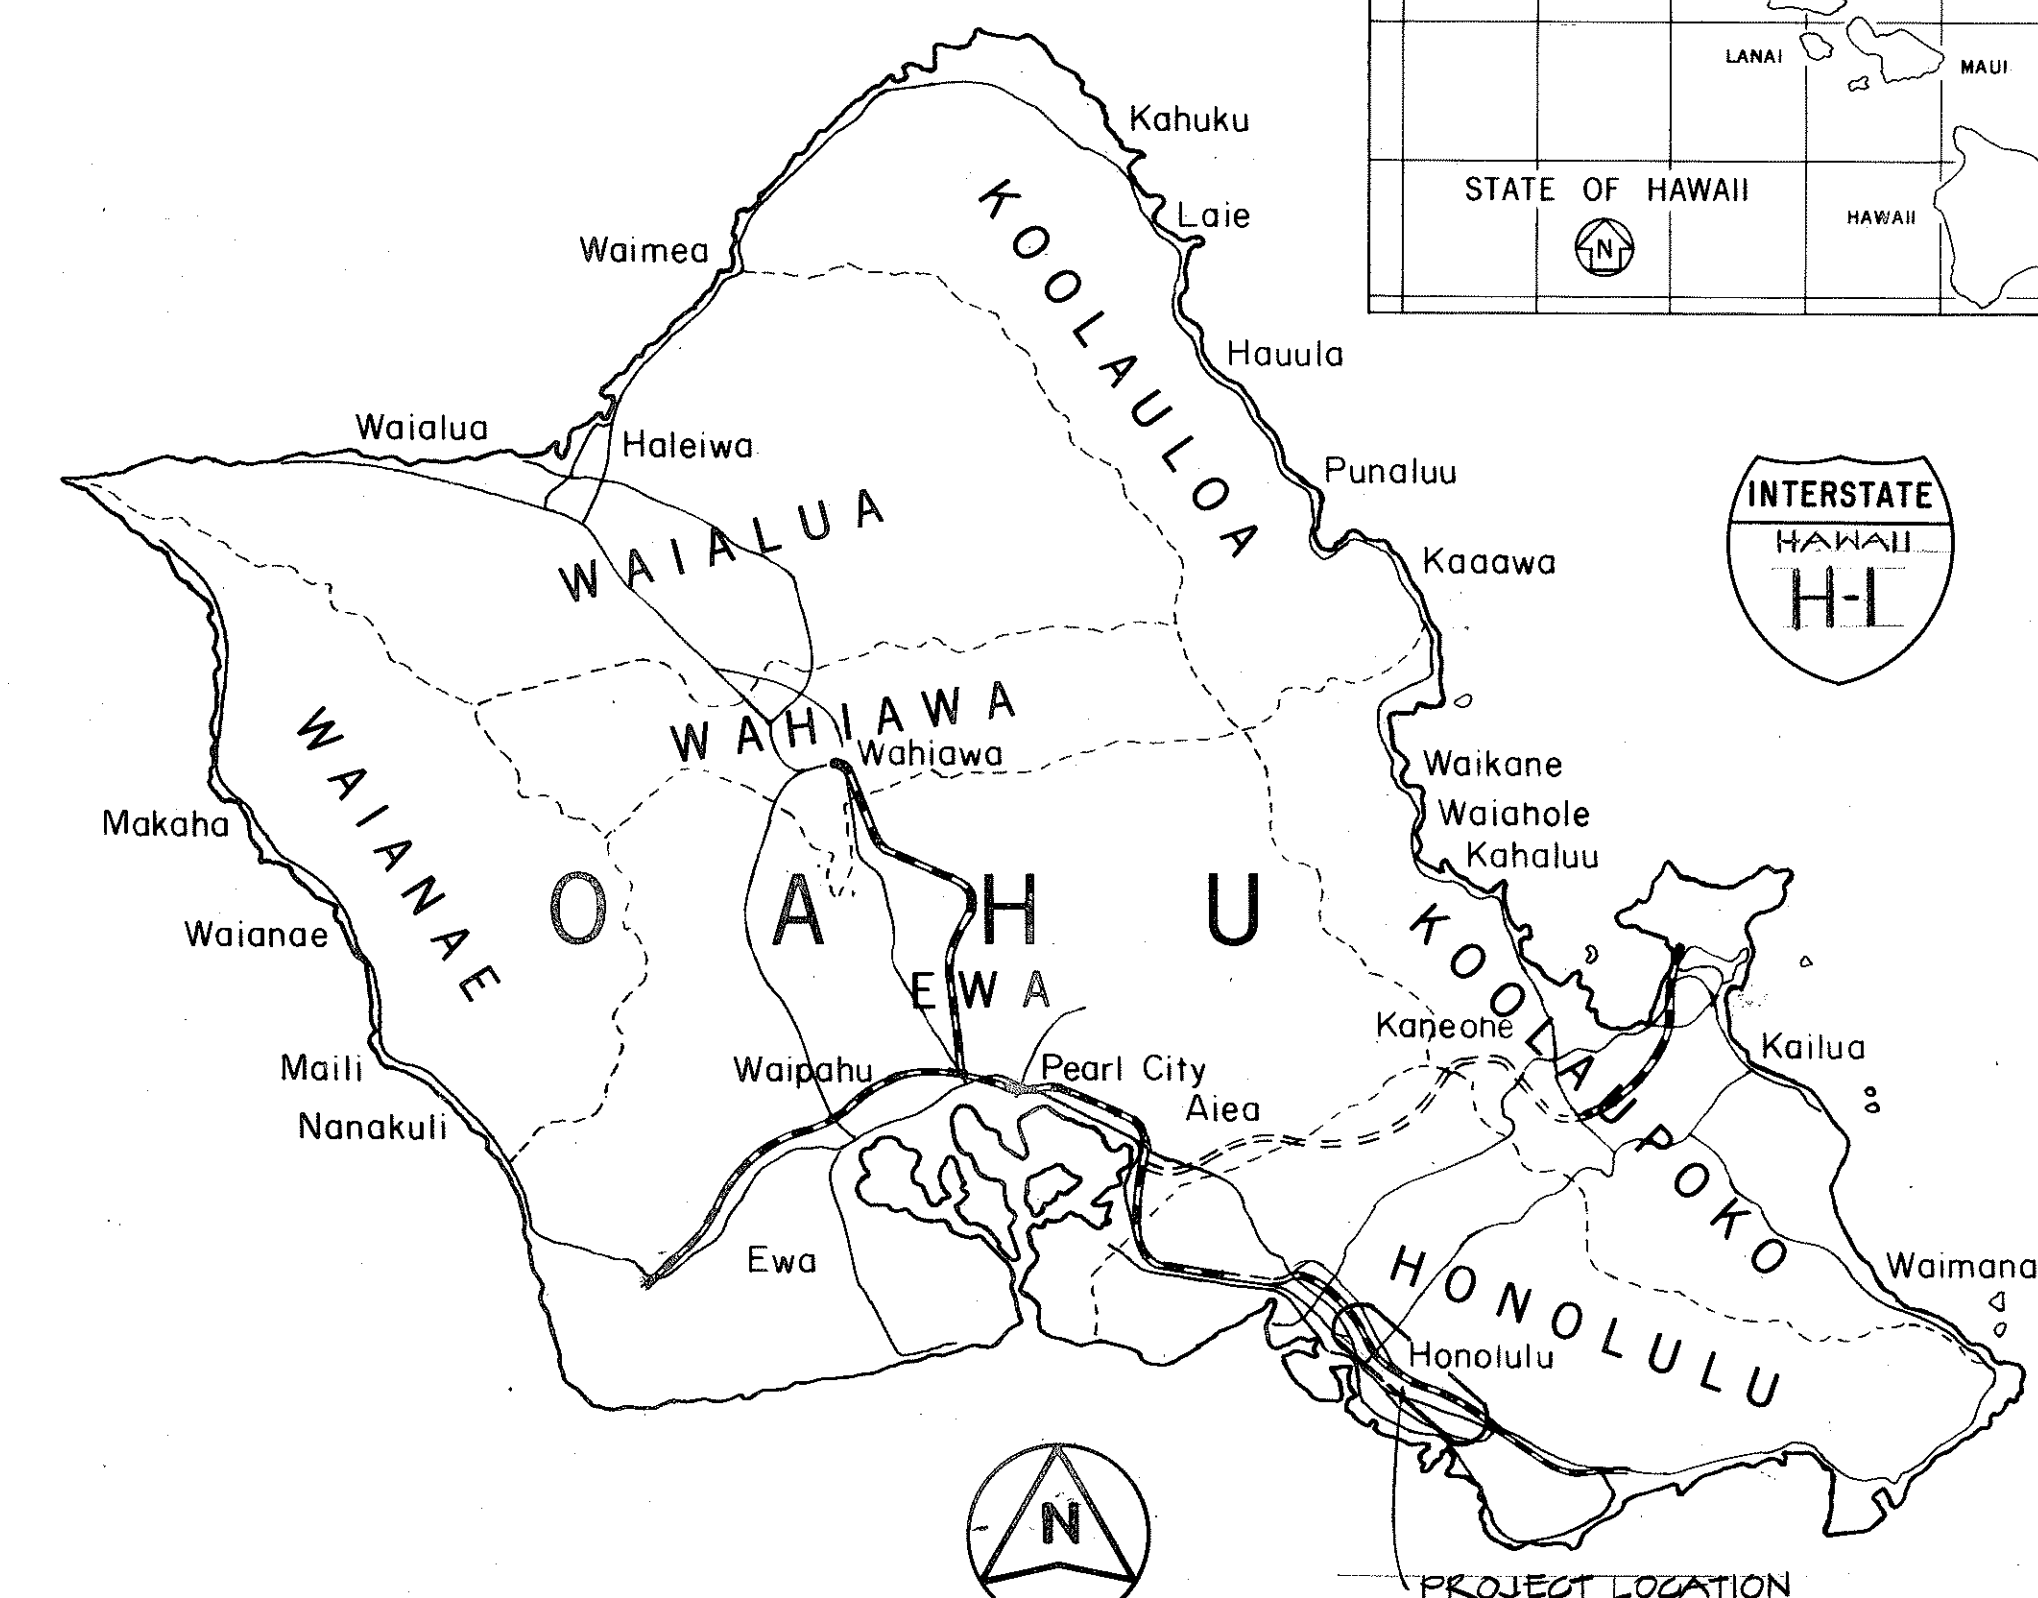


INDEX TO DRAWINGS	
SHEET NO.	DESCRIPTION
64	TITLE SHEET
65	STANDARD PLANS SUMMARY
66	HWY. LG. SYMBOLS, NOTES
67	ONE-LINE DIAGRAMS (H-1 & PALI HWY)
68 - 69	INTERSTATE H-1 HIGHWAY LG. PLANS
70 - 71	PALI HIGHWAY LIGHTING PLANS
72	NIUANU AVE & PALI HWY. STRUCTURES
73	GRADE SEPARATION NO. 8 - RAMP F
74	NIUANU TRANSFORMER STATION
75	EXIST. SERIES CIRCUIT DIAGRAMS
76	ONE-LINE DIAGRAMS (INTERSTATE H-1)
77 - 83	INTERSTATE H-1 HIGHWAY LIGHTING PLANS
84	UNIVERSITY INTERCHANGE
85	MC CULLY ST. SEPARATION
86	MAKIKI & UNIVERSITY TRANS. STATIONS
87	HIGHWAY LG. STD. DETAILS
88	LG. STD. ON CONC. BARRIER
89	SLIP BASE INSERT STD.
90	HWY. LG. LUMINAIRE DETAILS
91	SIGN SCH'D, ELEVATION
92 - 97	MISS. ELECTRICAL DETAILS

FED. ROAD DIST. NO.	STATE	FED. AID PROJ. NO.	FISCAL YEAR	SHEET NO.	TOTAL SHEETS
HAWAII	HAW.	IR-HI-1 (186)	1986	64	97

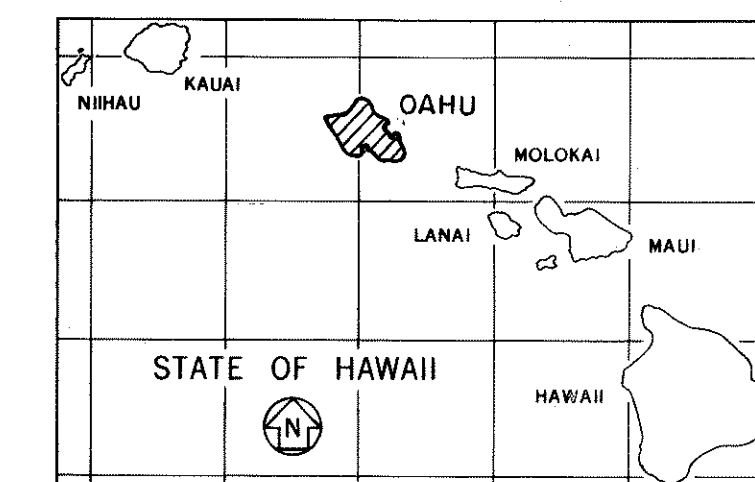

FEDERAL AID INTERSTATE PROJECTS PREVIOUSLY CONSTRUCTED OR UNDER CONSTRUCTION


STATE OF HAWAII DEPARTMENT OF TRANSPORTATION HIGHWAYS DIVISION

HONOLULU, HAWAII


PLANS FOR INTERSTATE ROUTE H-1 HIGHWAY LIGHTING IMPROVEMENTS

AALA STREET TO PUNCHBOWL STREET AND
KEEAUMOKU STREET TO OLD WAIALAE ROAD
PROJECT NO. IR-HI-1(186)

DISTRICT OF HONOLULU
ISLAND OF OAHU

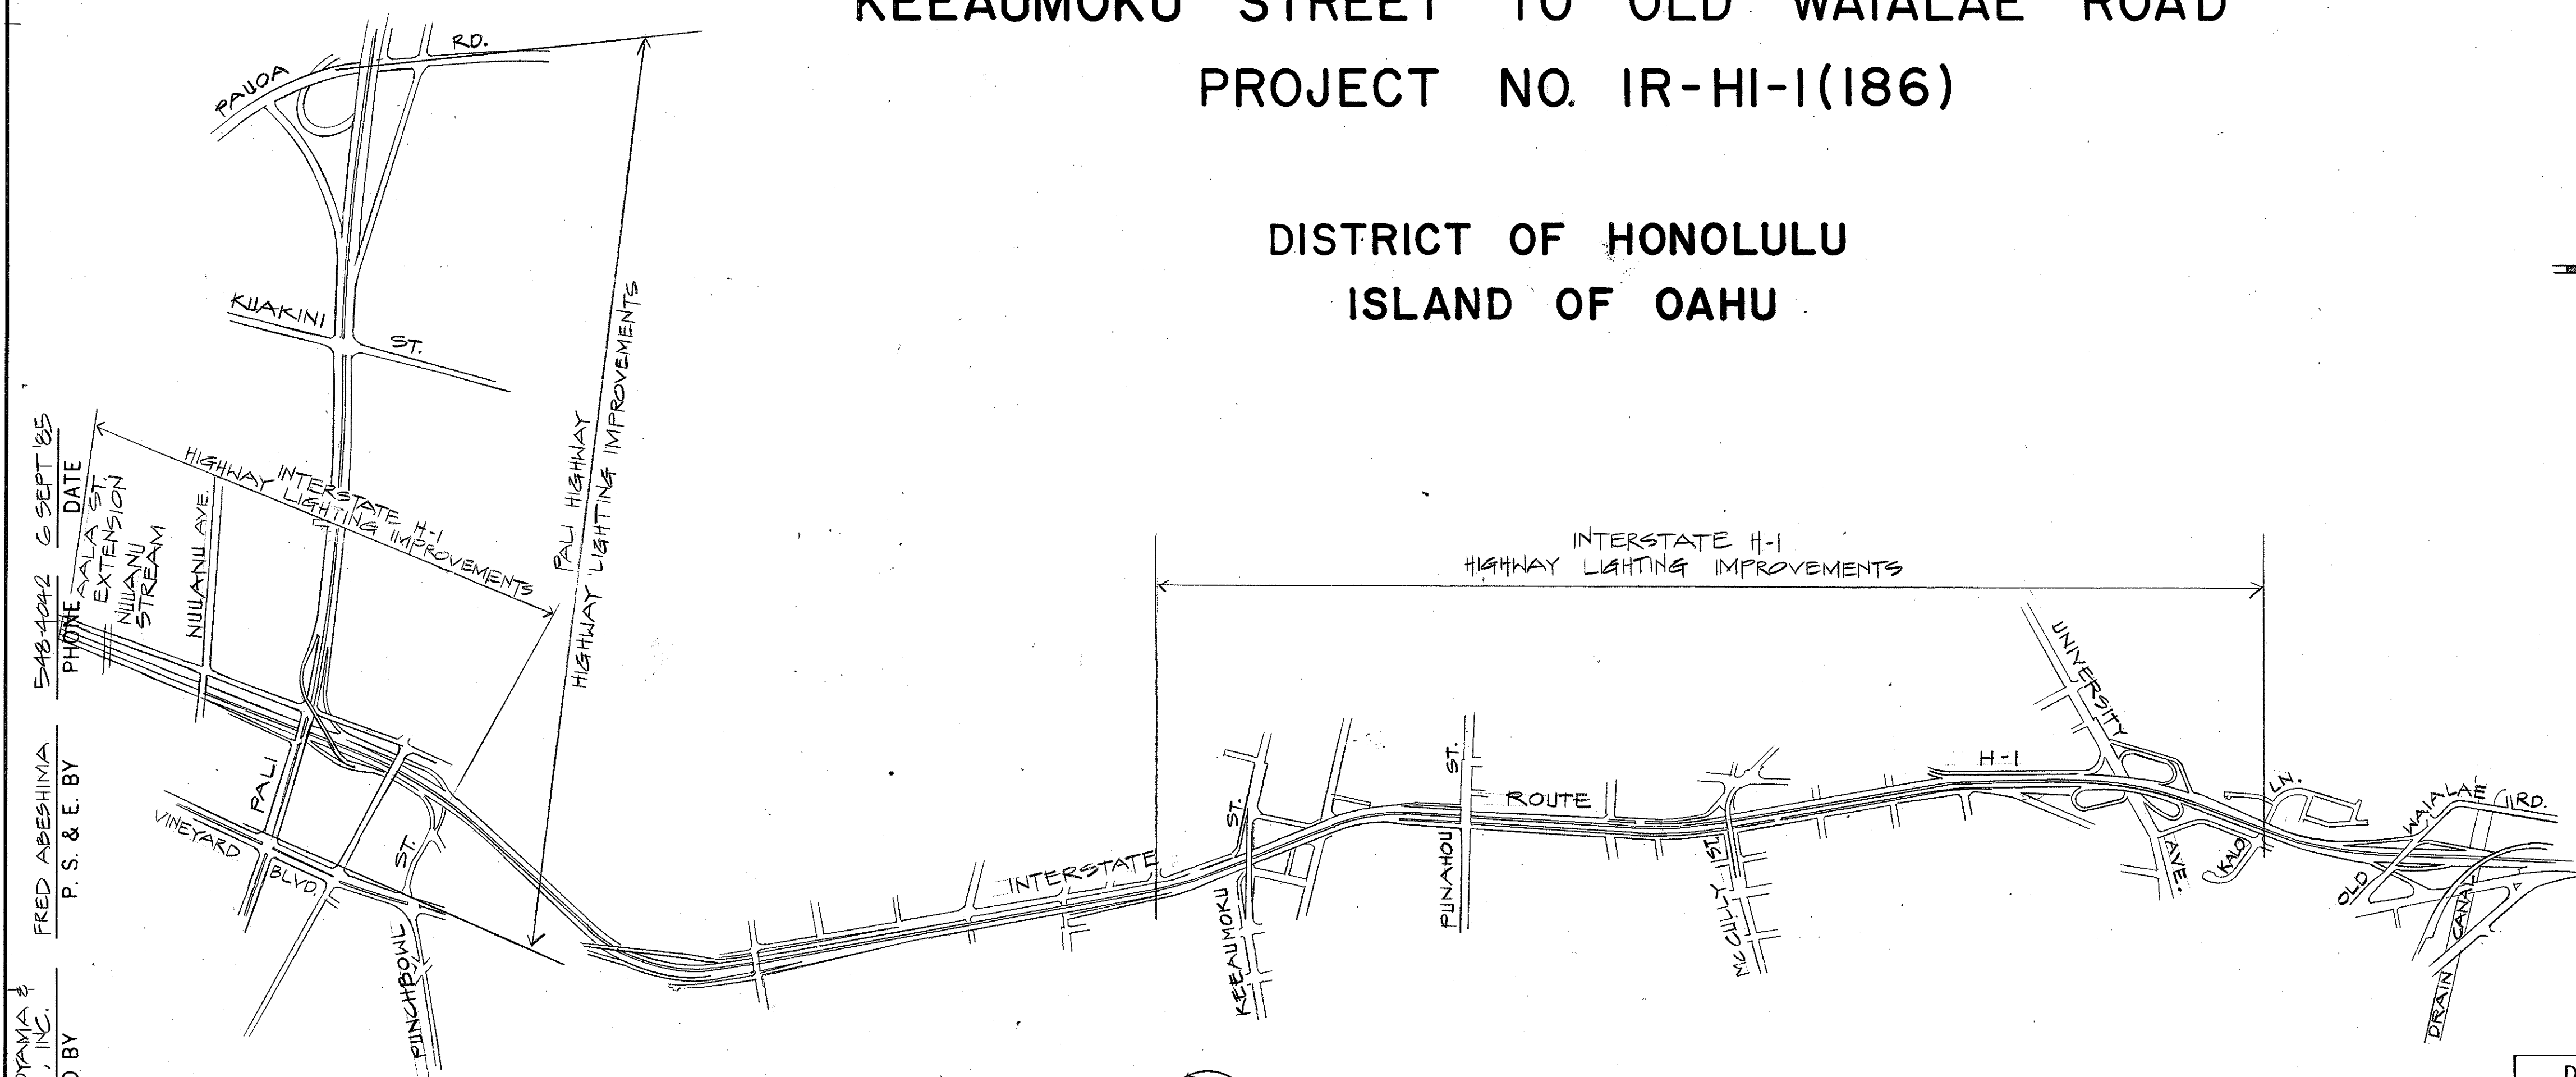

LAYOUT PLAN
SCALE: 1" = 300'

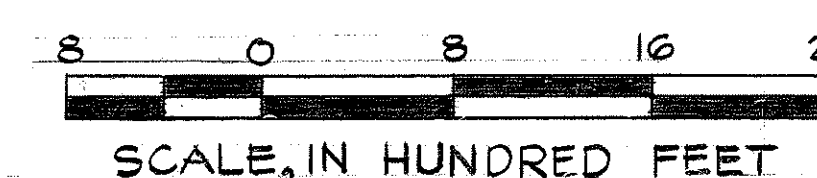

DEPARTMENT OF TRANSPORTATION
FEDERAL HIGHWAY ADMINISTRATION
APPROVED: *[Signature]*
DIVISION ADMINISTRATOR DATE 9/20/86

DEPARTMENT OF TRANSPORTATION
STATE OF HAWAII
APPROVED: *[Signature]*
DIR. OF TRANSPORTATION DATE 9/20/86