

FED. ROAD DIST. NO.	STATE	FED. AID PROJ. NO.	FISCAL YEAR	SHEET NO.	TOTAL SHEETS
HAWAII	HAW.	I-H2-1007	1973	1	274

INDEX OF DRAWINGS	
SHEET NO.	DESCRIPTION
1	TITLE SHEET
2-4	TYPICAL ROADWAY SECTION
5-27	PLAN, PROFILE & S.E. DIAGRAM
28-30	DETAIL ROADWAY PLAN
31-33	TRAFFIC STAGING & DETOUR PLANS
① 34-43	MISC. & STANDARD DETAILS
② 44-72	DRAINAGE PLANS & DETAILS
③ 73-111	SIGNING PLANS & DETAILS
112-115	TRAFFIC GATE HOUSE (WHEELER A.F.B.)
116-119, 119A	LANDSCAPE PLAN
120-131	HIGHWAY LIGHTING & TRAFFIC SIGNAL SYSTEMS
132-154	ELECTRICAL PLANS & DETAILS
④ 155-164	WATER & SEWER PLANS & DETAILS
165-168	RETAINING WALLS
169-224	STRUCTURES & DETAILS
225-273	CROSS - SECTIONS

① C.O. 37 S-1 ② C.O. 69 S-1 ③ C.O. 98 S-1 &
 ④ C.O. 158 S-1 are added sheets.
 TOTAL SHEET COUNT AFTER "AS-BUILT" POSTINGS: 278 SHEETS

MAY, 1973
DATE

548-5812
PHONE


HERBERT T. IWAI
PS & E BY

AUSTIN, YEE & PARK
(A JOINT VENTURE)
DESIGN BY

STATE OF HAWAII
 DEPARTMENT OF TRANSPORTATION
 HIGHWAYS DIVISION
 HONOLULU, HAWAII

"AS BUILT"
 PLANS FOR
 CONSTRUCTION OF A PORTION OF
 INTERSTATE ROUTE H-2
 WAHIAWA INTERCHANGE

FEDERAL AID INTERSTATE PROJECT NO. I-H2-1 (II):7

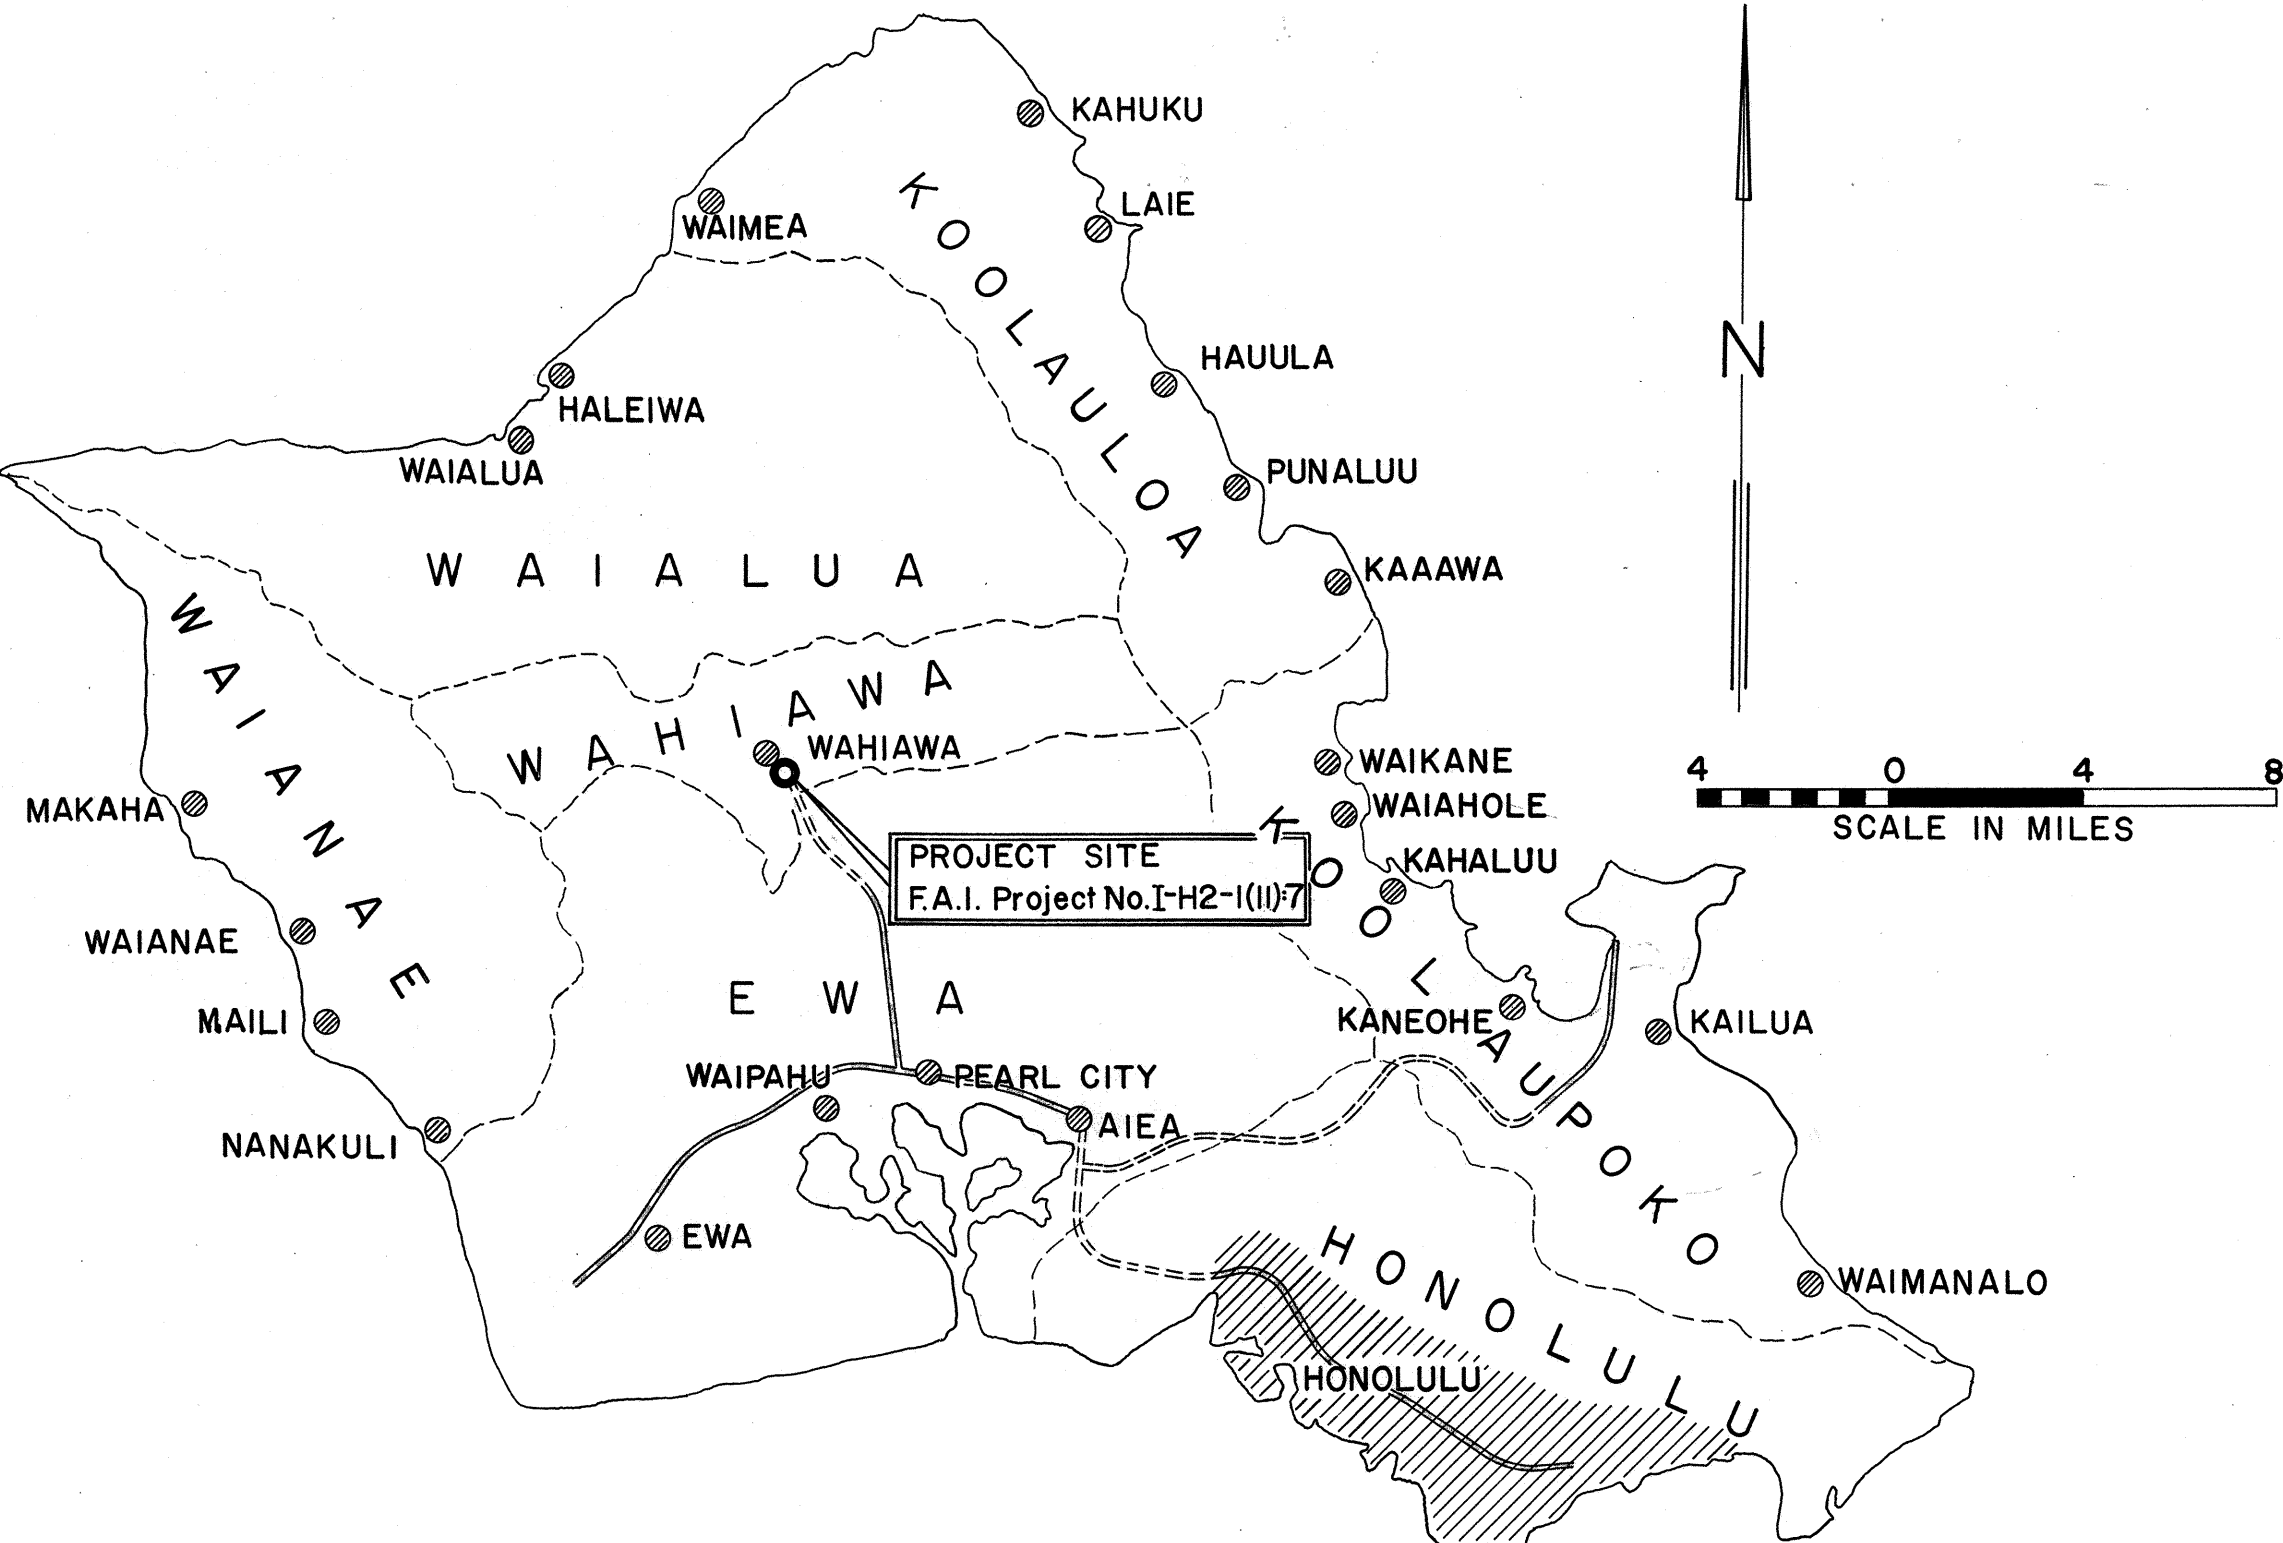

— FEDERAL AID INTERSTATE PROJECTS PREVIOUSLY CONSTRUCTED OR UNDER CONSTRUCTION

NOTE:
 ALL CHANGES MADE DURING CONSTRUCTION HAVE BEEN INCORPORATED ON THESE PLANS IN RED EXCEPT CHANGES IN THE ORIGINAL THEORETICAL QUANTITIES. FOR ACTUAL QUANTITIES, REFER TO PROJECT LEDGER AND/OR COMPUTATION BOOK.

David Jamashvili
 PROJECT ENGINEER 11/2/77
 DATE

DESIGN CLASSIFICATION

CURRENT ADT (1973) 0
 INTERIM ADT (1977) . . . 24,971
 DESIGN ADT (1993) . . . 33,861
 DHV 10 %
 D 55/45
 T₂₄ 1,200
 V 50 mph
 CONTROL OF ACCESS . . . FULL

DEPARTMENT OF TRANSPORTATION
 FEDERAL HIGHWAY ADMINISTRATION
 APPROVED:
[Signature] 5-14-73
 DIVISION ENGINEER DATE

DEPARTMENT OF TRANSPORTATION
 STATE OF HAWAII
 APPROVED:
Murray Lee 5/9/73
 FOR DIRECTOR OF TRANSPORTATION DATE

GROSS LENGTH OF PROJECT	0.867 Mi.
LENGTH OF STRUCTURES	0.062 Mi.
NET LENGTH OF ROADWAY	0.805 Mi.

