


INDEX TO DRAWINGS	
SHEET NO.	DESCRIPTION
1	TITLE SHEET
2 - 6	TYPICAL ROADWAY SECTIONS
7 - 23	SHEET KEY MAP AND PLAN & PROFILE
24 - 28	BORING LOGS
29 - 31	INTERSECTION DETAILS & GRADES
32 - 40	SUPERELEVATION DIAGRAMS
41 - 61	MISCELLANEOUS, TYPICAL & STANDARD ROADWAY DETAILS
62 - 67	CONSTRUCTION SEQUENCE PLANS & DETAIL
68	SURCHARGE PLAN
69	SEDIMENT CONTROL PLAN
70 - 71	UNDERDRAIN PLAN
72 - 130	DRAINAGE PLANS & DETAILS
131 - 136	WATER SYSTEM PLANS
137 - 154	ELECTRIC & TELEPHONE PLANS & DETAILS
155 - 168	HIGHWAY LIGHTING PLANS & DETAILS
169 - 170	HAWAII LOA COLLEGE FORCE MAIN
171	INDEX TO BRIDGE DRAWINGS & LOCATION PLAN
172 - 201	BRIDGE NO. 1 & NO.2, PLANS & DETAILS
202 - 221	BRIDGE NO.3, PLANS & DETAILS
222 - 233	KAMOOALII STREAM BRIDGE, PLANS & DETAILS
234	TYPICAL BRIDGE DETAILS
235 - 240	STANDARD BRIDGE DETAILS
241 - 268	TRAFFIC SIGNING, PAVEMENT MARKINGS PLANS & DETAILS
269 - 272	LANDSCAPING PLANS & DETAILS
273 - 275	SPRINKLER SYSTEM
276 - 328	CROSS SECTIONS

STATE OF HAWAII
DEPARTMENT OF TRANSPORTATION
HIGHWAYS DIVISION
HONOLULU, HAWAII

PLANS FOR
CONSTRUCTION OF A PORTION OF
INTERSTATE ROUTE H-3
HALEKOU INTERCHANGE
FEDERAL AID INTERSTATE PROJECT NO. I-IR-H3-I(24):II

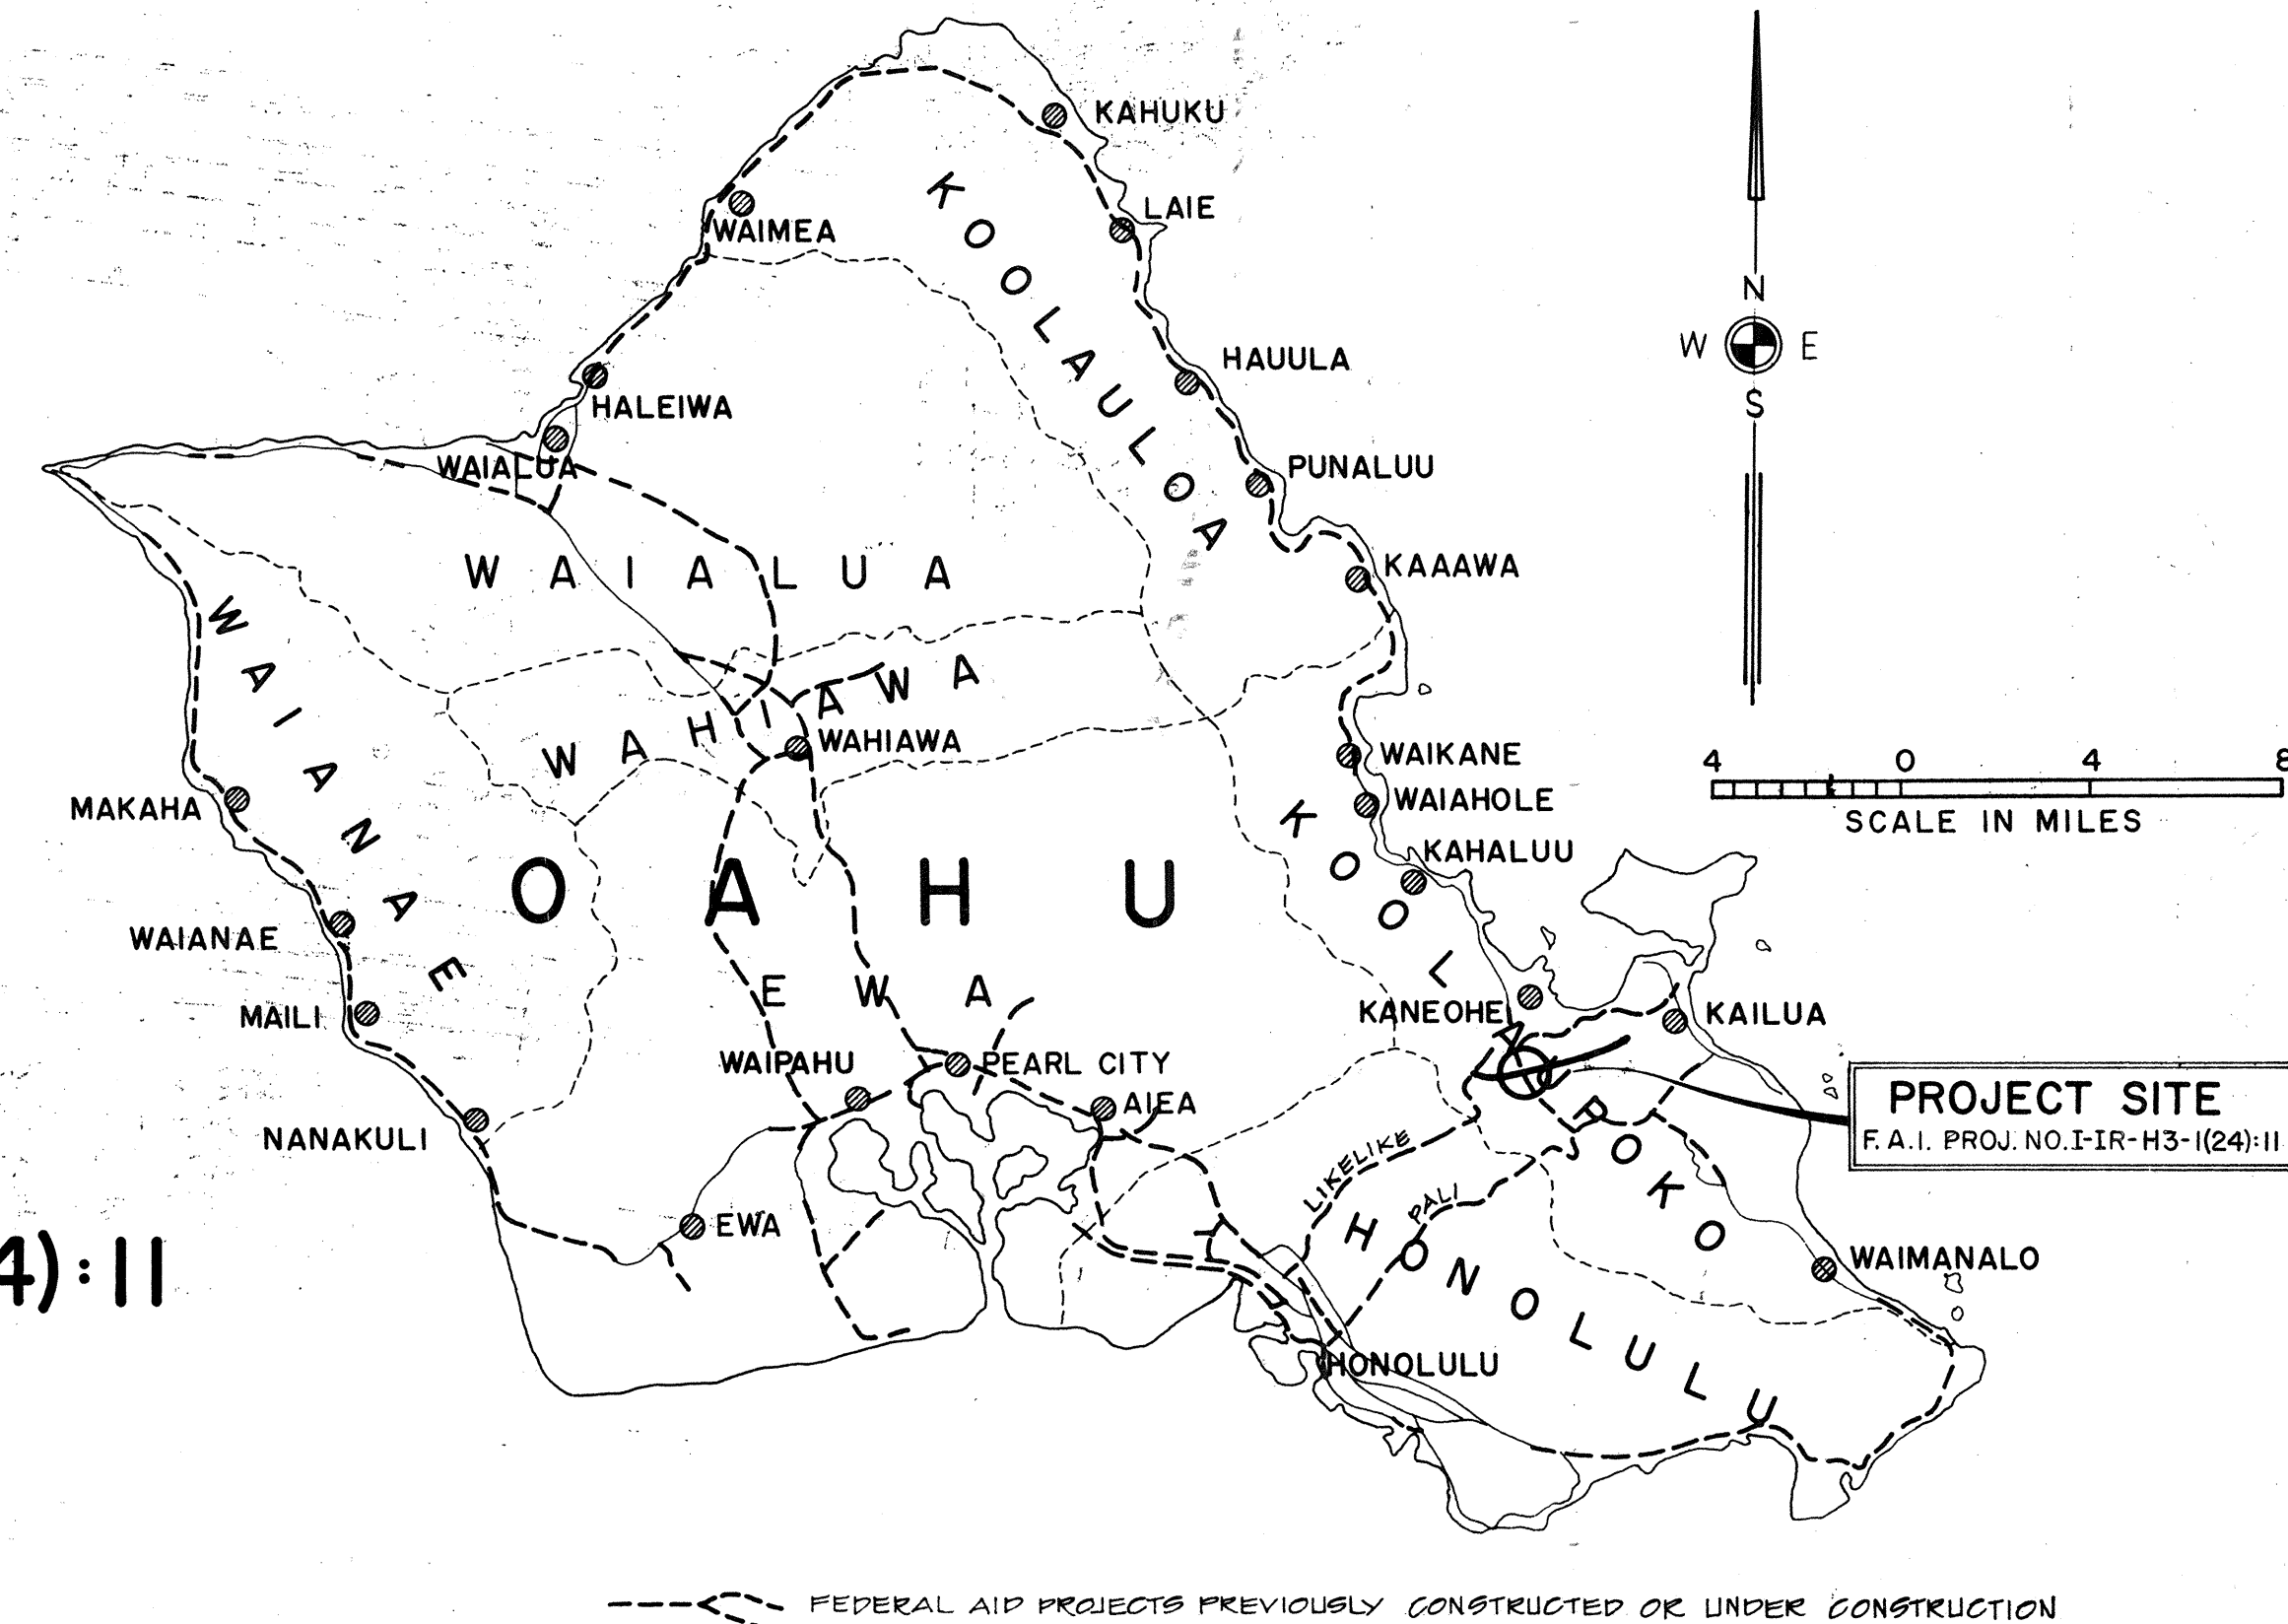

DISTRICT OF KOOLAUPOKO
ISLAND OF OAHU


SCALES:
PLANS 1" = 50'
PROFILES HORIZ. 1" = 50'
VERT. 1" = 10'
DETAIL ROADWAY PLANS 1" = 50'
CROSS SECTIONS - HORIZ. 1" = 50'
VERT. 1" = 10'

OCT. 1982
DATE

548-4125
PHONE

ALBERT YAMAGUCHI
P. S. & E. BY

ALBERT YAMAGUCHI
REDESIGNED BY

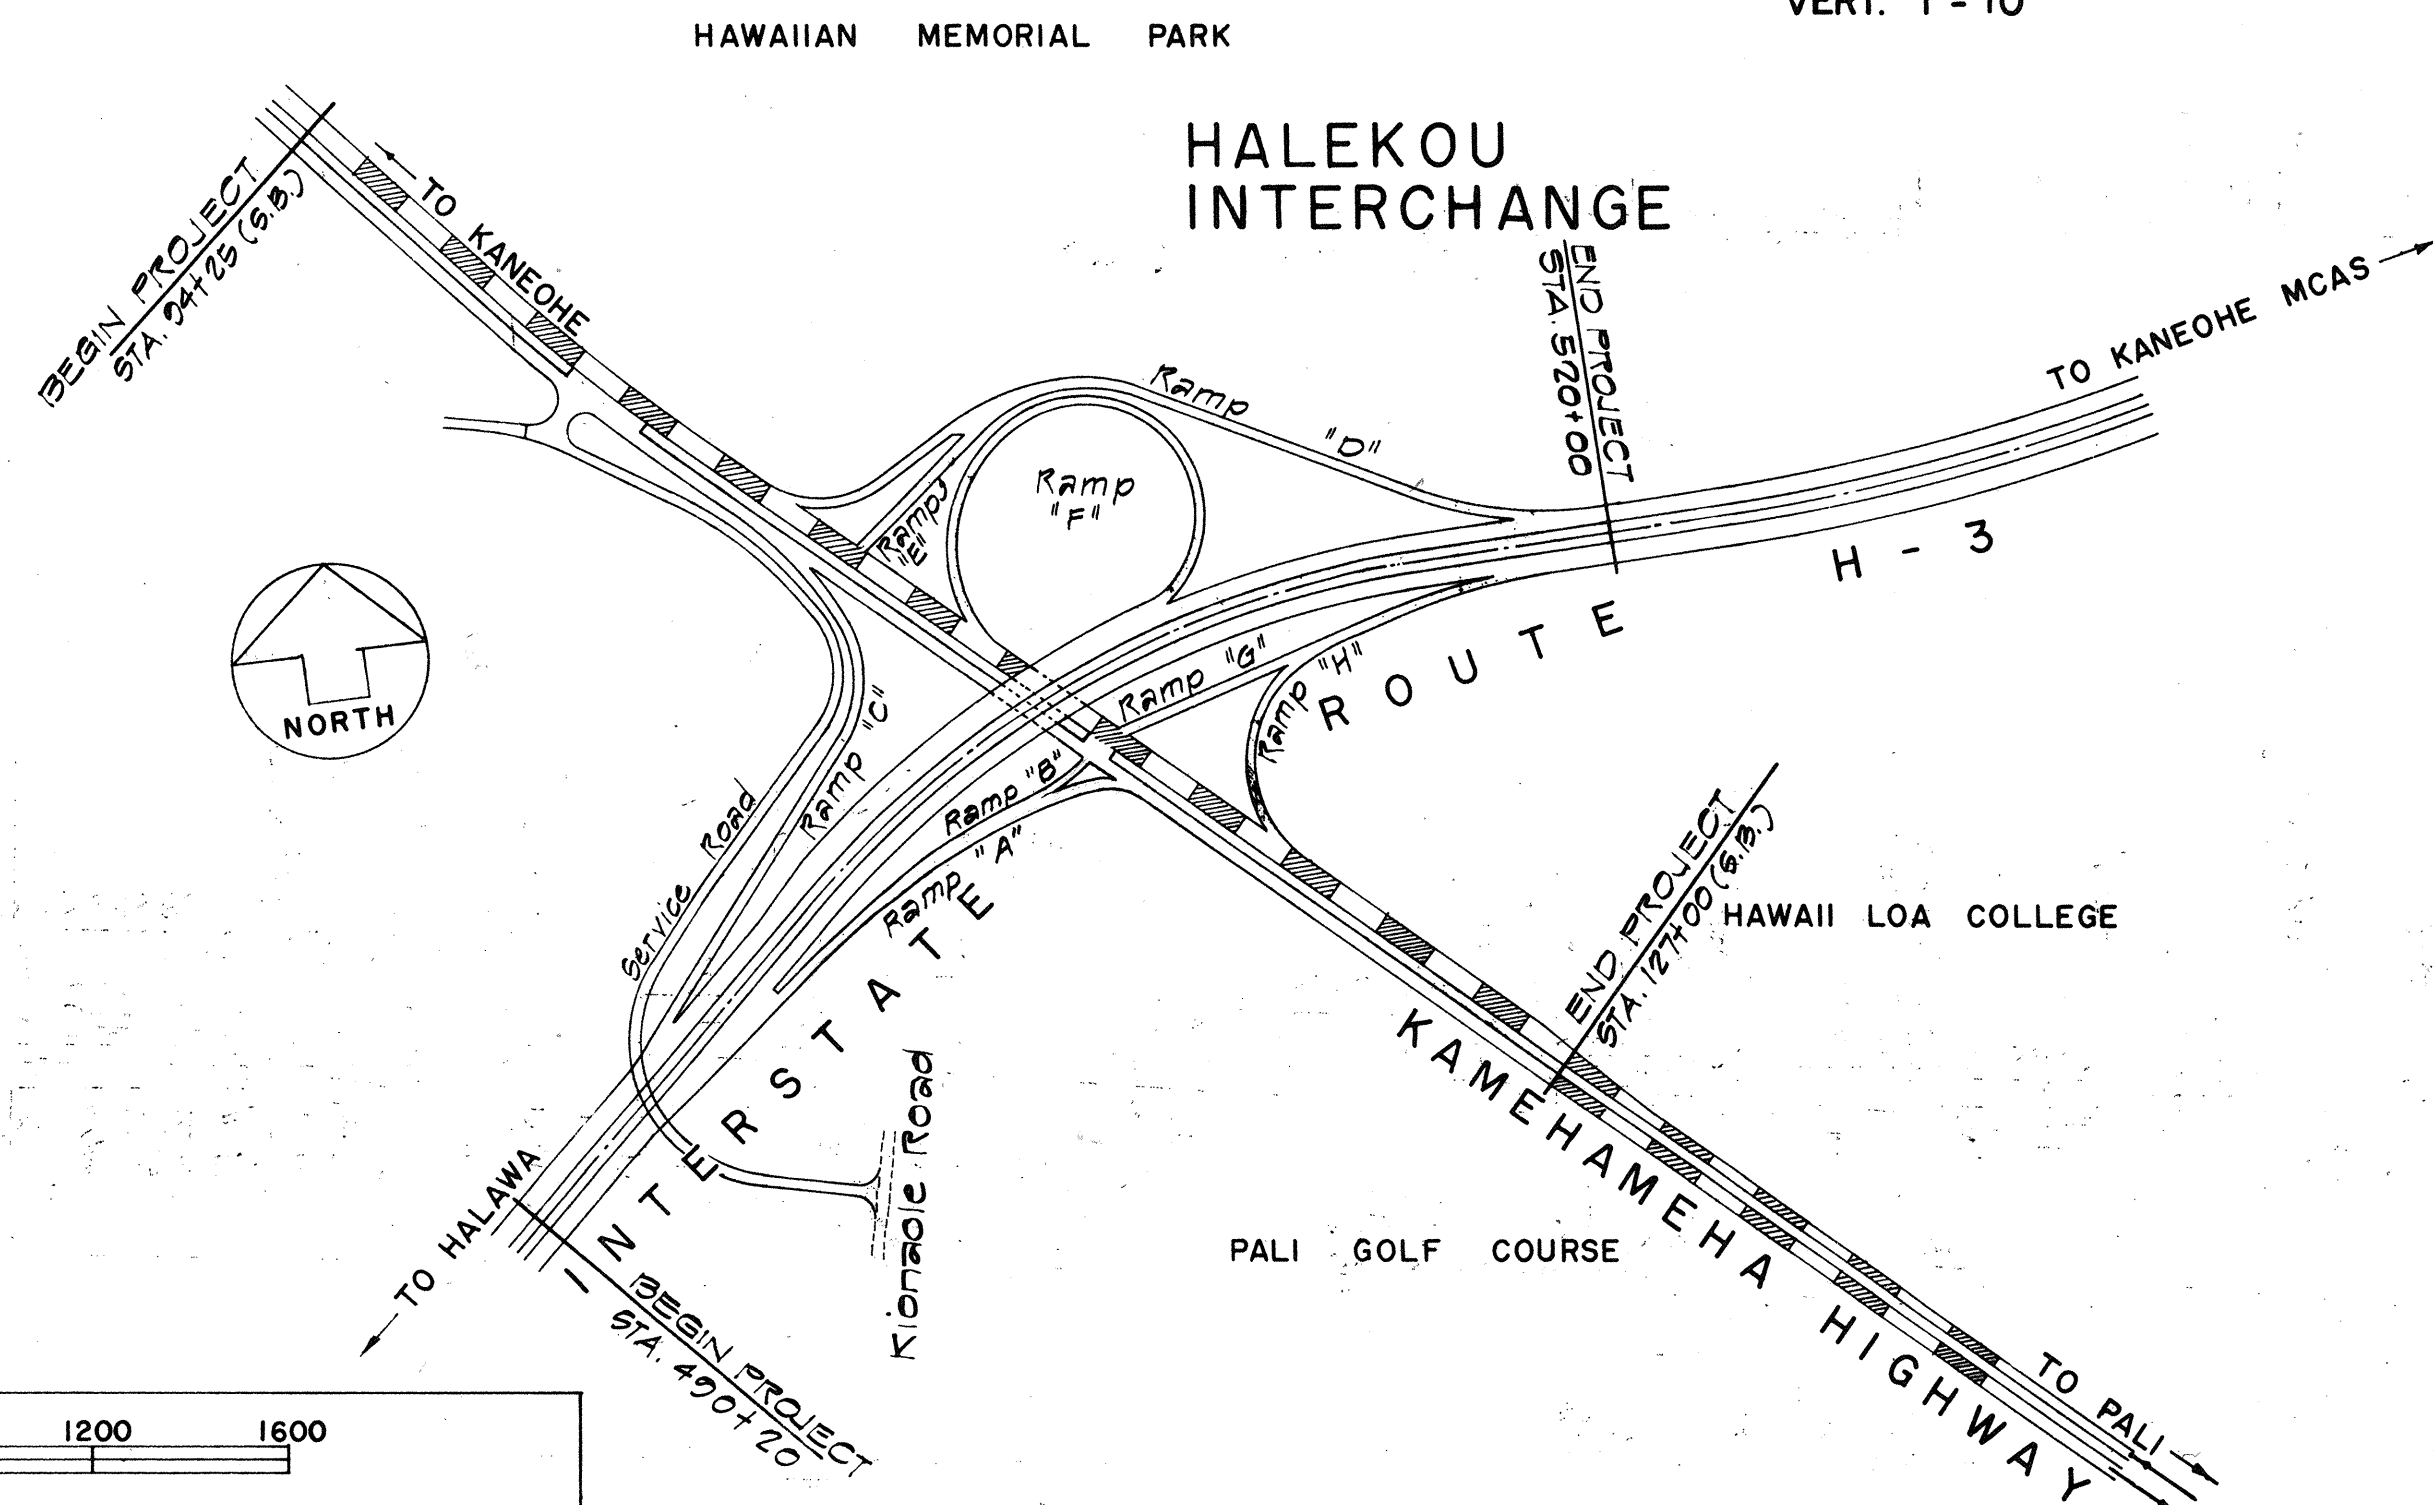

LAYOUT PLAN	
GROSS LENGTH OF PROJECT	0.564 MI.
LENGTH OF STRUCTURES	0.039 MI.
NET LENGTH OF ROADWAY	0.525 MI.

DESIGN DESIGNATION

CURRENT ADT (1983)	20,787
FUTURE ADT (1993)	25,837
DESIGN ADT (2003)	31,776
DHV	2,560
D	67/33
T	2.0%
T ₂₄	3.5%
V	60 MPH

12/22/82	PROJECT NUMBER AMENDED PER ADDENDUM NO. I	DEPARTMENT OF TRANSPORTATION FEDERAL HIGHWAY ADMINISTRATION APPROVED: <i>[Signature]</i> 11/17/82 DIVISION ADMINISTRATOR DATE
DATE	REVISION	DEPARTMENT OF TRANSPORTATION STATE OF HAWAII APPROVED: <i>[Signature]</i> 11/17/82 DIR. OF TRANSPORTATION DATE

FEDERAL AID INTERSTATE PROJECT COVERED UNDER THIS CONTRACT
FEDERAL AID PROJECT PREVIOUSLY CONSTRUCTED

DD-22-11

IR