

STATE OF HAWAII
DEPARTMENT OF TRANSPORTATION
HIGHWAYS DIVISION
HONOLULU, HAWAII

INSTALLATION OF HIGHWAY LIGHTS

AT FARRINGTON HIGHWAY AND KUNIA ROAD JUNCTION

WAIPAHU, HAWAII


PROJECT
LOCATION

PROJECT A-90-02-63

"AS BUILT PLANS"

WIND NAKAMURA LTD. CONSULTING ELECTRICAL ENGINEERS

INDEX OF DRAWINGS	
SHEET NO. 1	TITLE SHEET AND VICINITY MAP
NP2	HIGHWAY LIGHTING LAYOUT & DETAILS

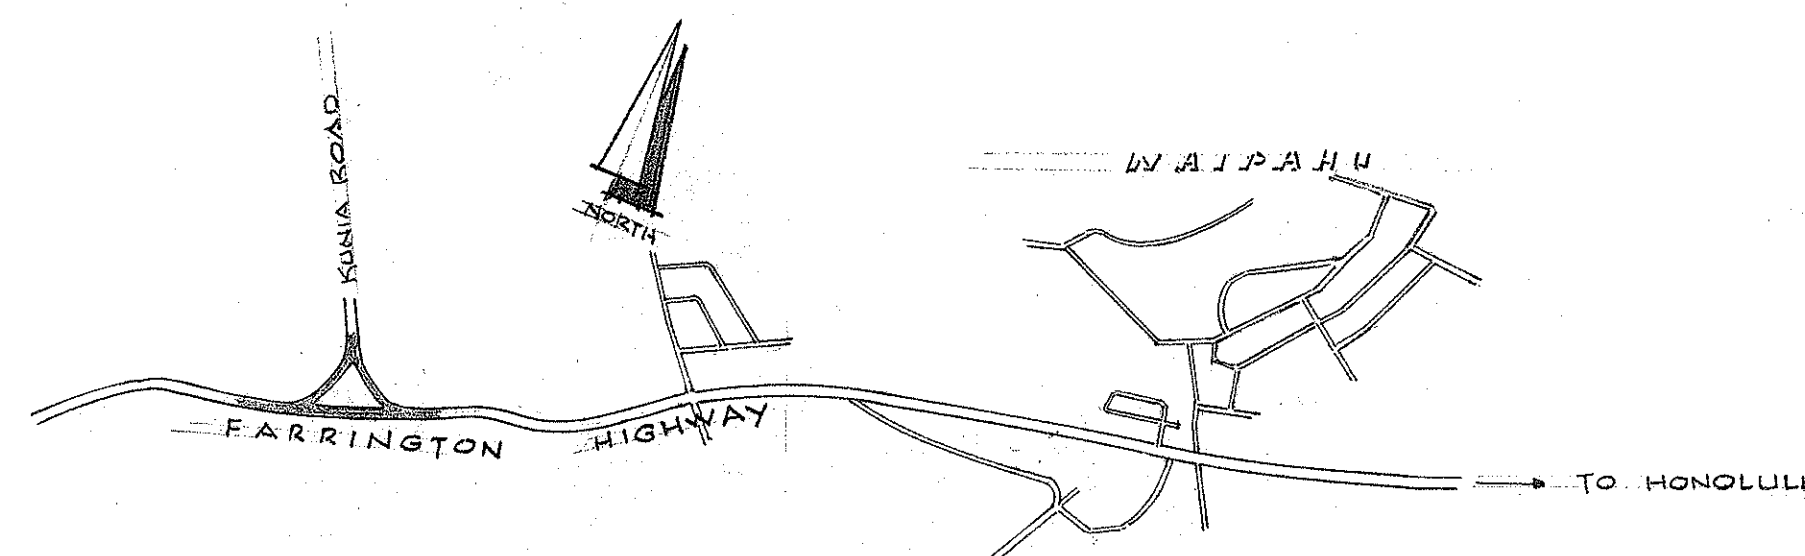

VICINITY PLAN

APPROVED: DATE: 4/13/63

Tuzio Matsuda
DIRECTOR OF TRANSPORTATION

NOTE: ALL CHANGES MADE DURING
CONSTRUCTION ARE SHOWN IN
RED ON THESE TRACINGS AND
CHECKED BY

F. J. Takakawa
PROJECT ENGINEER

8/4/64
DATE