
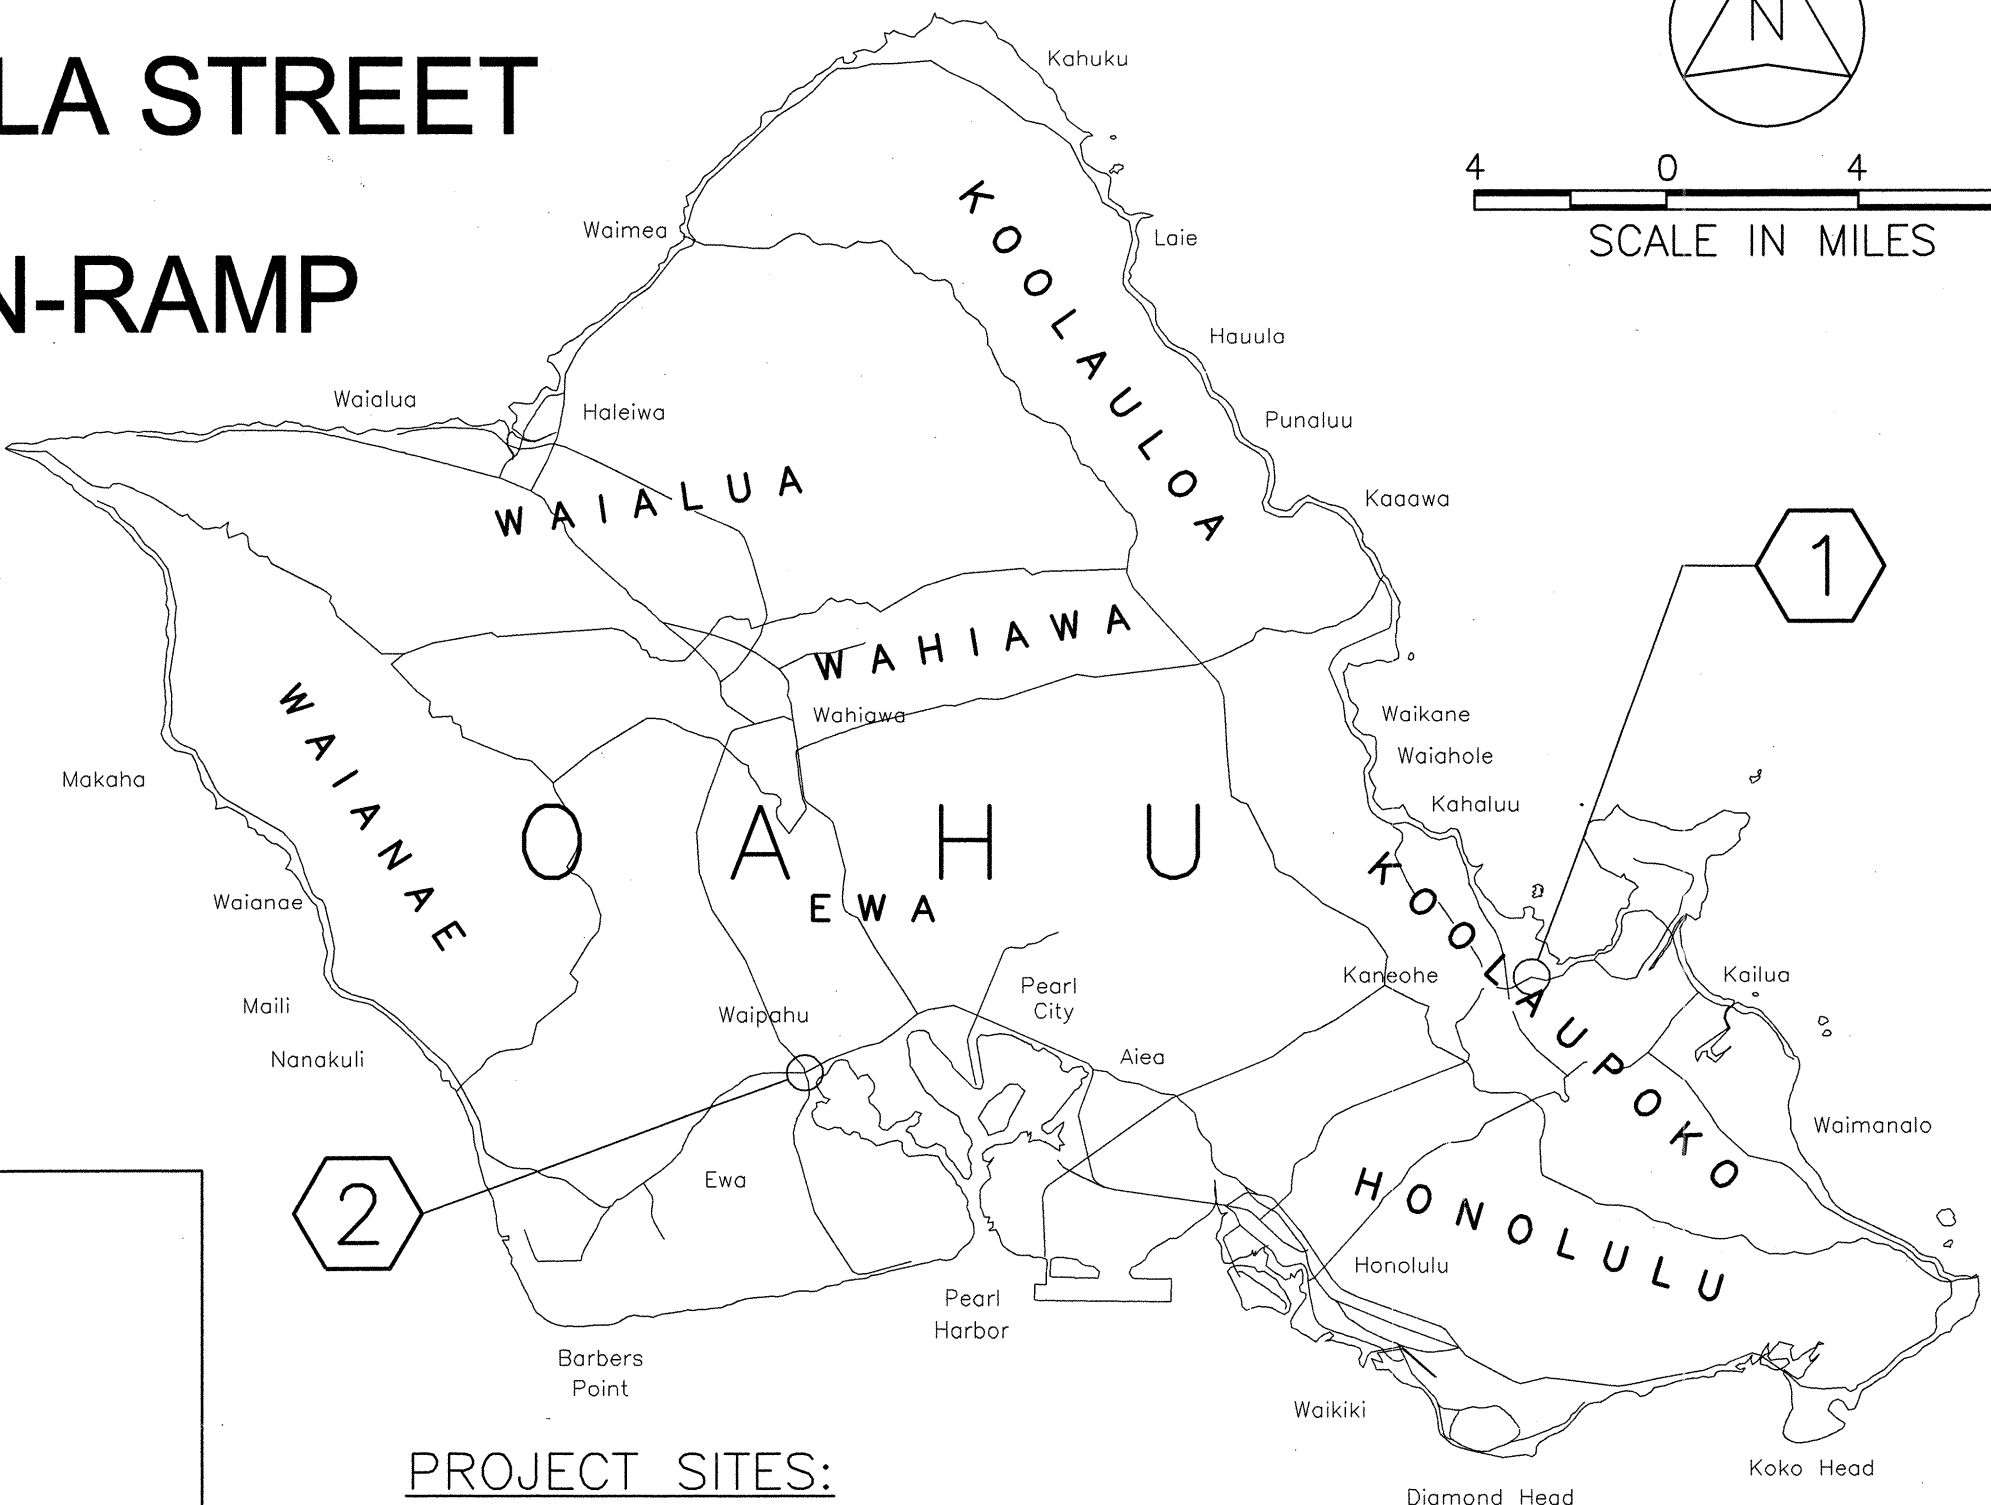
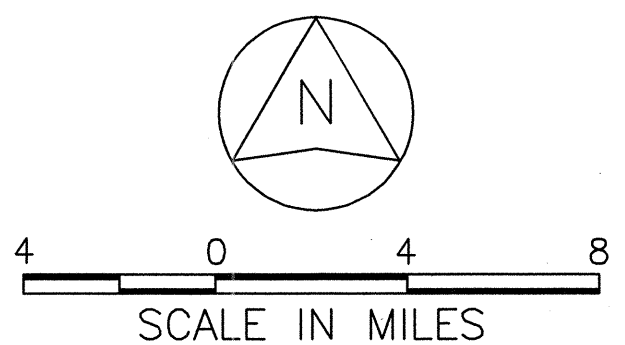


STATE OF HAWAII  
DEPARTMENT OF TRANSPORTATION  
HIGHWAYS DIVISION  
HONOLULU, HAWAII

PLANS FOR  
TRAFFIC OPERATIONAL IMPROVEMENTS  
AT VARIOUS LOCATIONS  
VICINITY OF KANEOHE BAY DRIVE AND PUOHALA STREET  
AND  
VICINITY OF KUNIA ROAD AND H-1 WEST ON-RAMP  
PROJECT NO. HWY-O-01-13  
DISTRICTS OF KOOLAUPOKO AND EWA  
ISLAND OF OAHU


| FED. ROAD DIST. NO. | STATE | PROJ. NO.   | FISCAL YEAR | SHEET NO. | TOTAL SHEETS |
|---------------------|-------|-------------|-------------|-----------|--------------|
| OAHU                | HAW.  | HWY-O-01-13 | 2016        | 1         | 47           |

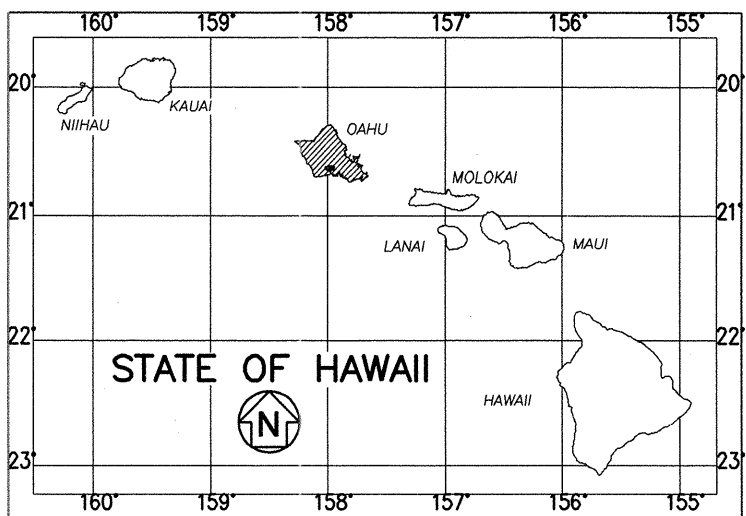

PROJECT SITES:

- 1 KANEOHE BAY DRIVE AND PUOHALA STREET (ROUTE 65)  
MILE POST 0.29 TO MILE POST 0.48
- 2 KUNIA ROAD AT H-1 WESTBOUND ON-RAMP (ROUTE 750)  
MILE POST 0.21 (KUNIA RD) TO MILE POST 6.59 (KUNIA RD)


| INDEX TO DRAWINGS |                                                     |
|-------------------|-----------------------------------------------------|
| SHEET NO.         | DESCRIPTION                                         |
| 1                 | TITLE SHEET                                         |
| 2                 | STANDARD PLANS SUMMARY                              |
| 3                 | ABBREVIATIONS AND LEGEND                            |
| 4                 | GENERAL NOTES                                       |
| 5-7               | WATER POLLUTION AND EROSION CONTROL NOTES           |
| 8-12              | UTILITY NOTES                                       |
| 13-14             | TYPICAL SECTIONS (KANEOHE)                          |
| 15-16             | ROADWAY PLAN (KANEOHE)                              |
| 17-19             | FINISH GRADE PLAN (KANEOHE)                         |
| 20                | MISCELLANEOUS DETAILS (KANEOHE)                     |
| 21-24             | CURB RAMP NOTES AND DETAILS (KANEOHE)               |
| 25                | PAV'T MARK. LEGEND, DETAILS & NOTES                 |
| 26-27             | PAVEMENT MARKING, SIGNING & STRIPING PLAN (KANEOHE) |
| 28                | PAVEMENT MARKING, SIGNING & STRIPING PLAN (KUNIA)   |
| 29                | TRAFFIC SIGNAL NOTES AND LEGEND                     |
| 30-32             | TRAFFIC SIGNAL PLANS (KUNIA)                        |
| 33                | TRAFFIC SIGNAL PLANS (KANEOHE)                      |
| 34                | TRAFFIC SIGNAL DETAILS                              |
| 35                | ELECTRICAL SYMBOLS AND NOTES                        |
| 36                | ELECTRICAL PLAN (KUNIA)                             |
| 37                | ELECTRICAL PLAN (KANEOHE)                           |
| 38                | ELECTRICAL DUCT SECTION                             |
| 39                | ELECTRICAL METER DETAILS                            |
| 40                | ELECTRICAL ONE LINE DIAGRAMS                        |
| 41-43             | TRAFFIC CONTROL NOTES AND DETAILS                   |
| 44-46             | TRAFFIC CONTROL PLANS (KANEOHE)                     |
| 47                | WORK ZONE SIGNING PLAN, NOTES & DETAILS             |

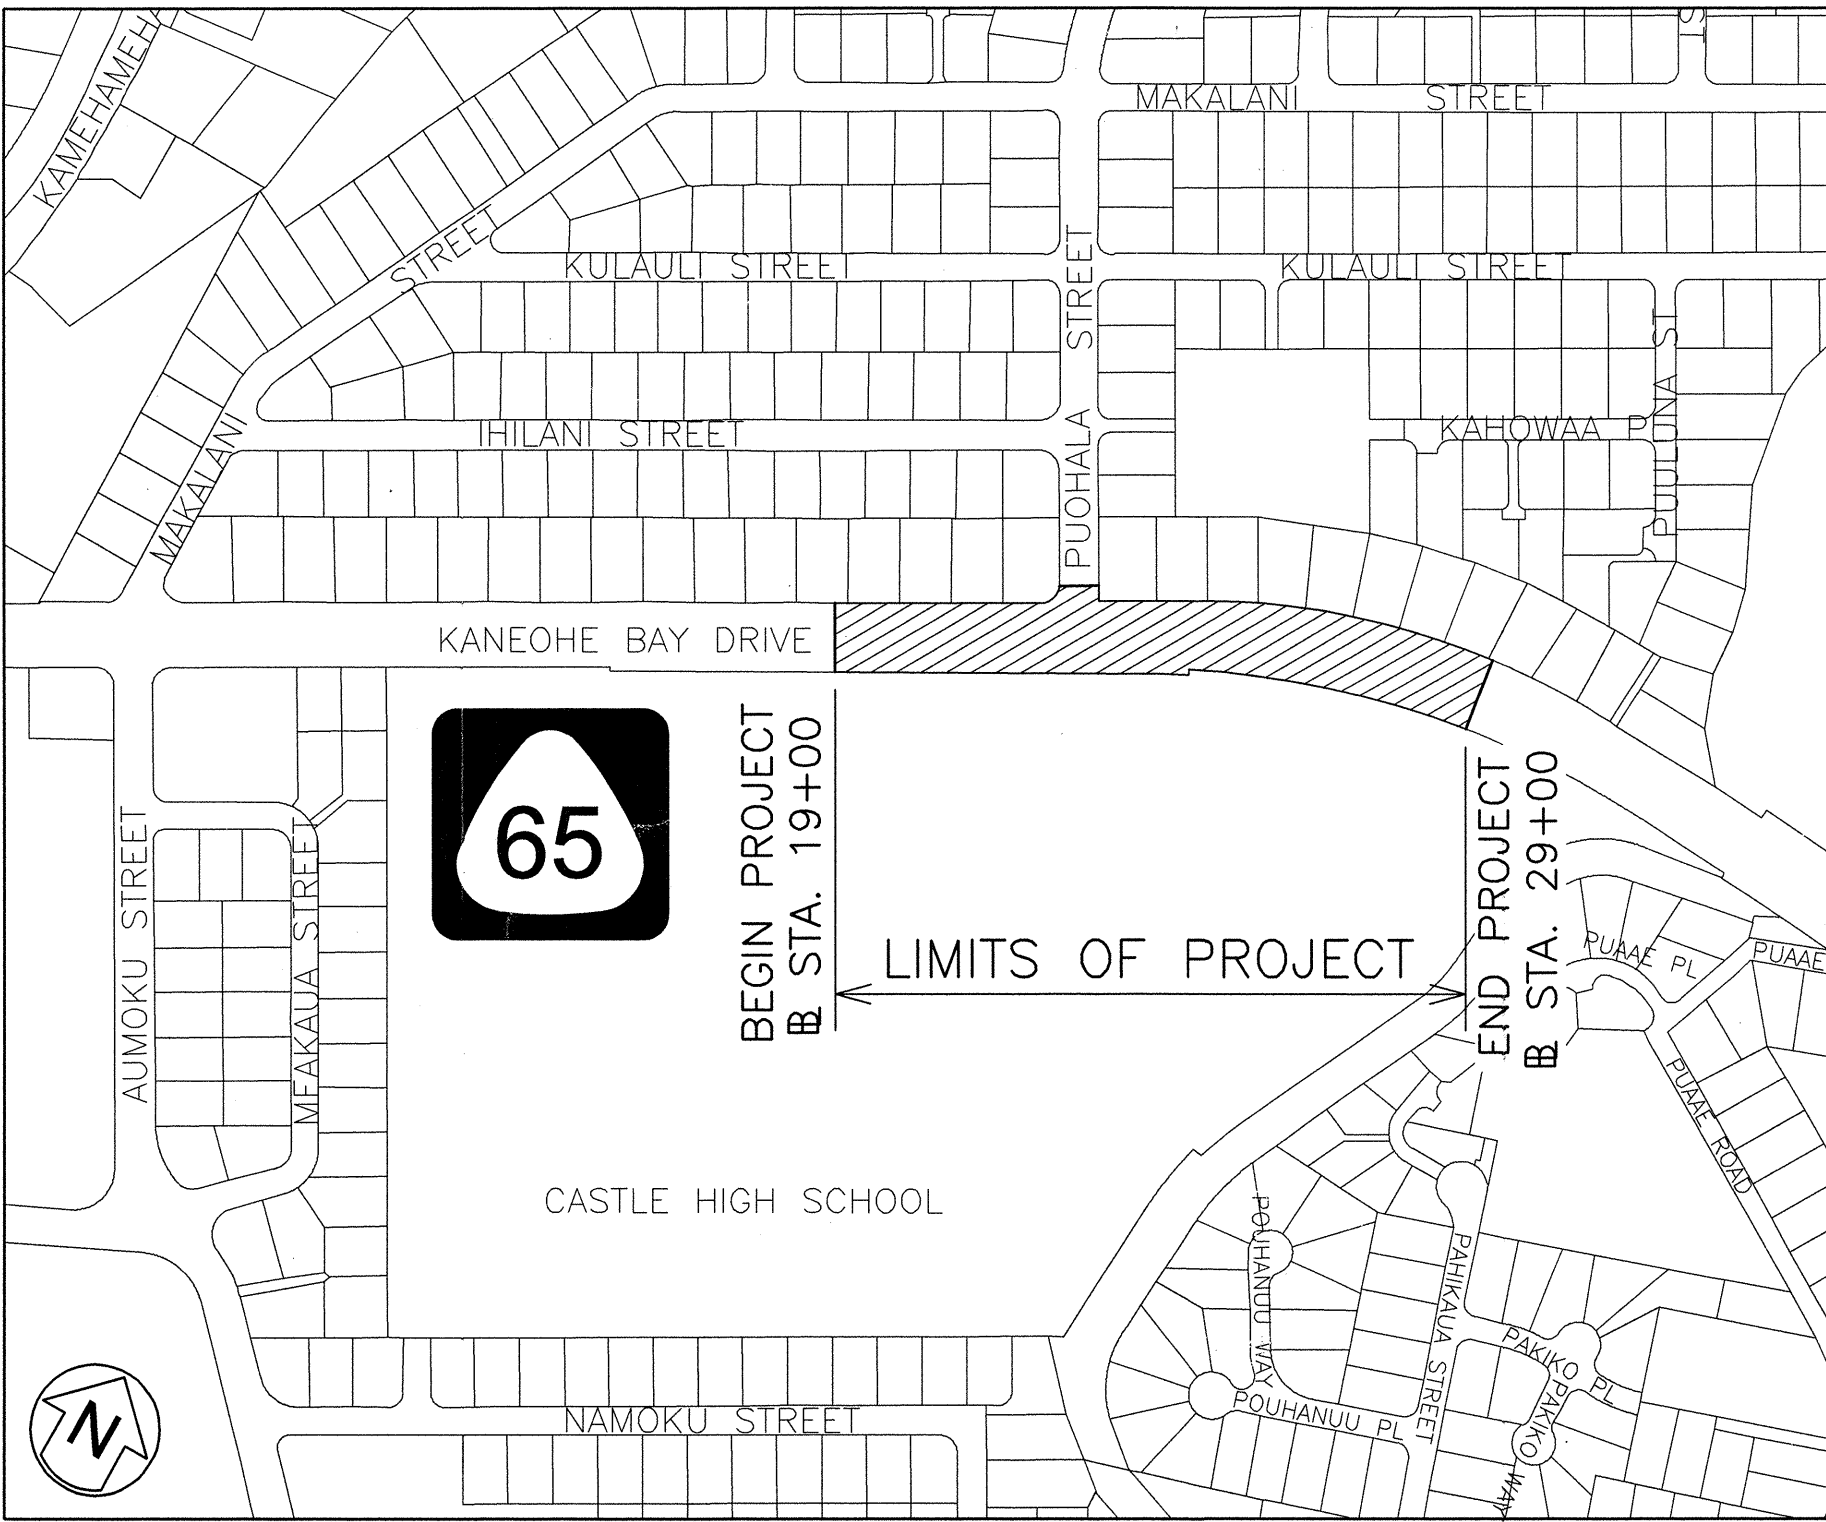

LOCATION PLAN

GROSS LENGTH OF PROJECT ..... 0.19 MILES

SCALE IN HUNDRED FEET

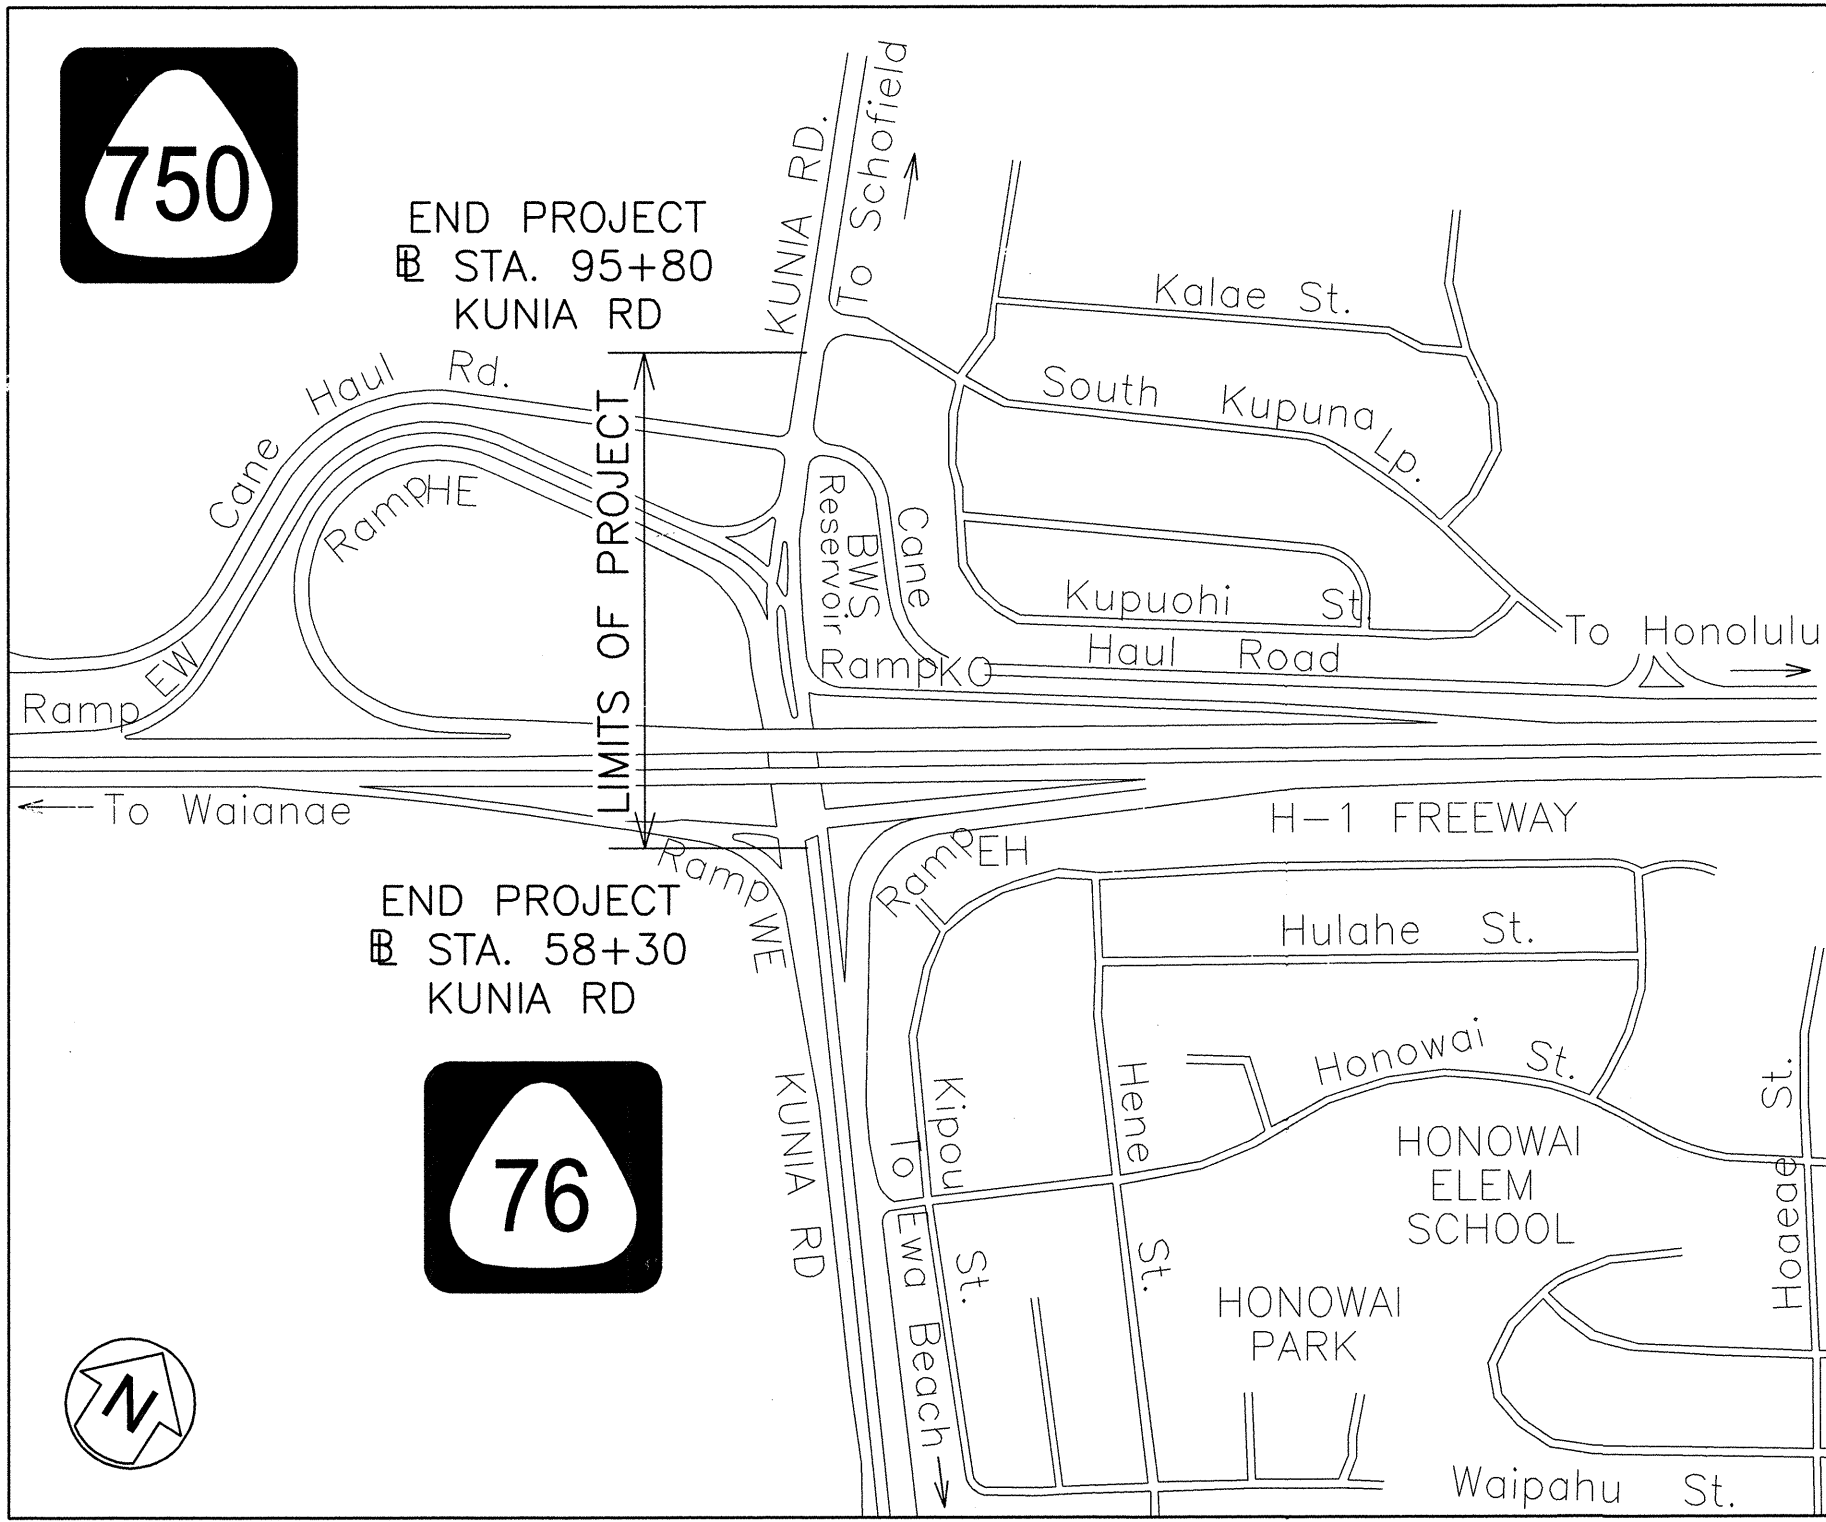

LOCATION PLAN

GROSS LENGTH OF PROJECT ..... 0.26 MILES

NOT TO SCALE

|                                                 |         |
|-------------------------------------------------|---------|
| DEPARTMENT OF TRANSPORTATION<br>STATE OF HAWAII |         |
| APPROVED:                                       | 3/23/16 |
| DIR. OF TRANSPORTATION                          | DATE    |