

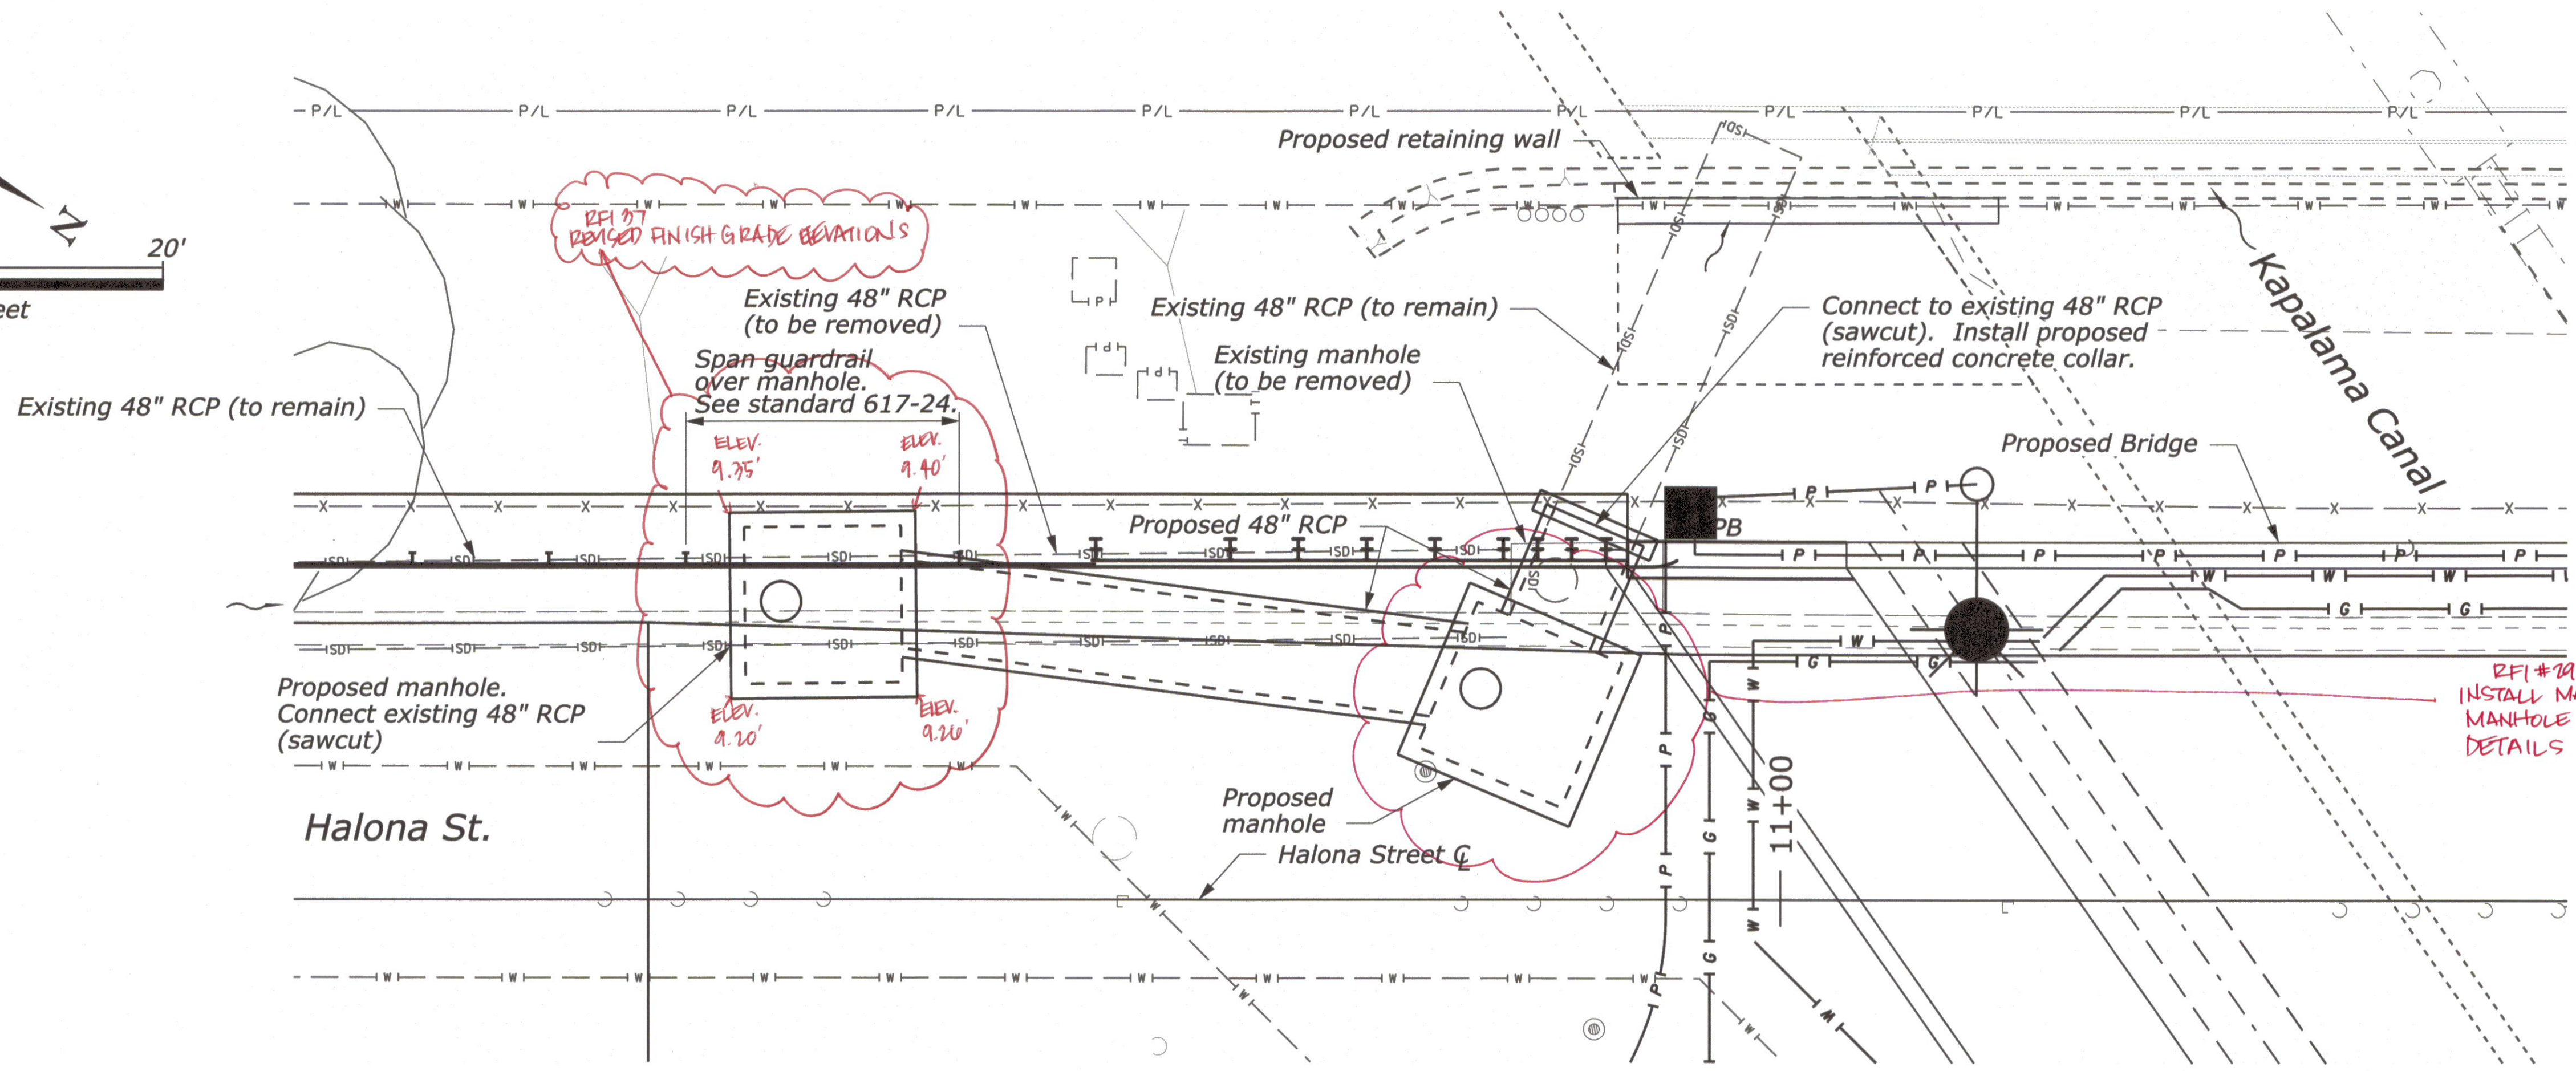


User: DENPWP01.dgn
12:14:59 PM \\denpwp01\pwwcs\jobs596\213265\205370_12\T01-602LayoutHA.dgn
8/5/2016

STATE	PROJECT	SHEET NO.
HI	HI STP H1(1)	T1

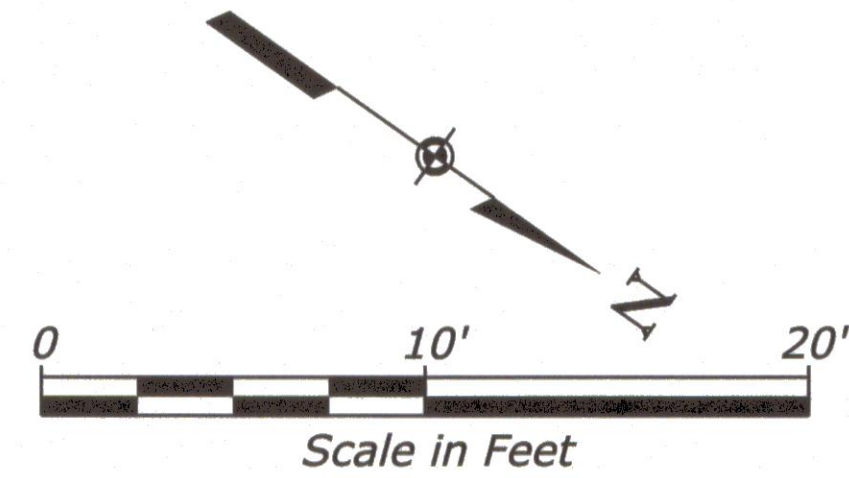

RFI #19: INSTALL MANHOLE BOX LID AND MANHOLE RISER PER STANDARD DETAILS M-604-20 (SHEET NO. T0-1, T0-2, T0-3).

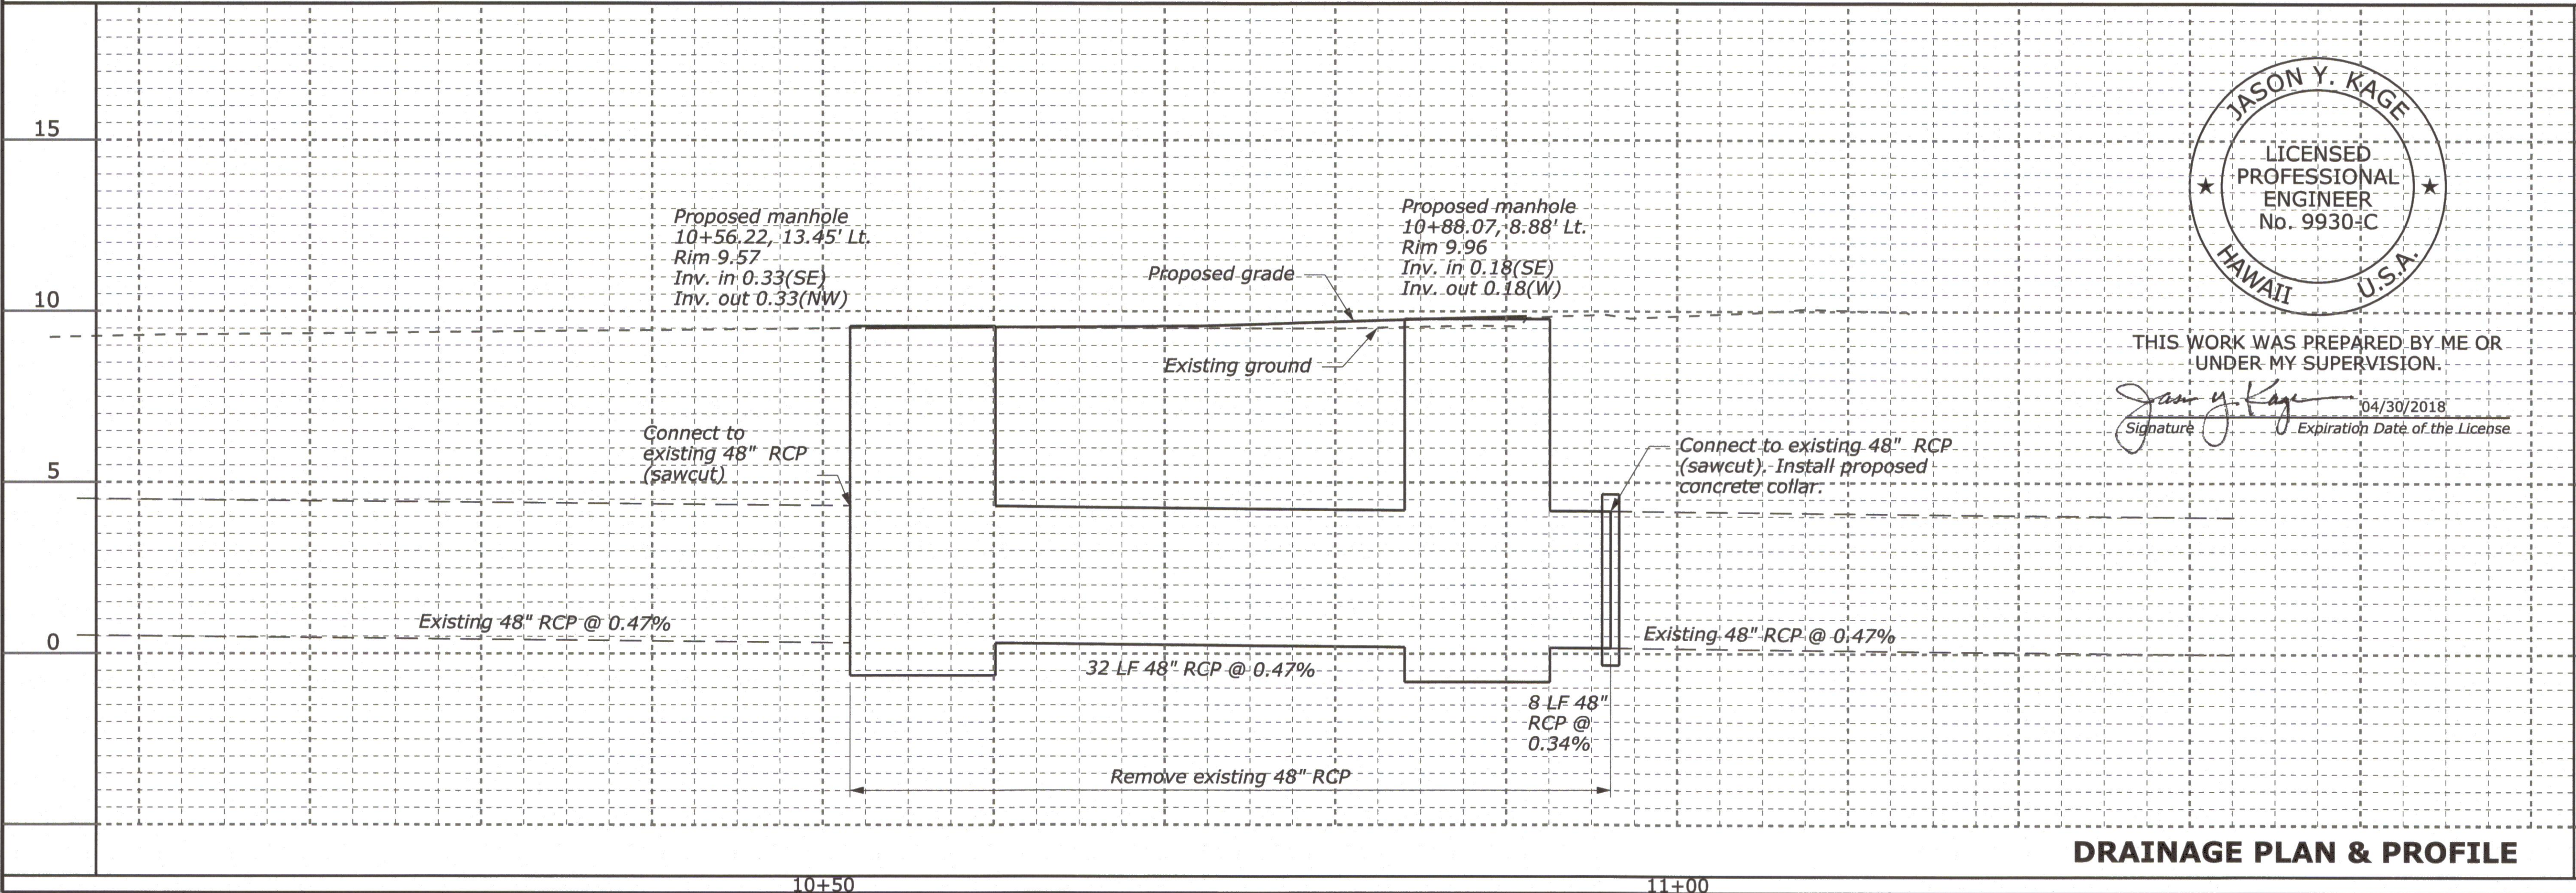

THIS WORK WAS PREPARED BY ME OR UNDER MY SUPERVISION.
Signature: Jason Y. Kage
Expiration Date of the License: 04/30/2018

DRAINAGE PLAN & PROFILE