



FED. ROAD DIST. NO.	STATE	FEDERAL AID PROJ. NO.	FISCAL YEAR	SHEET NO.	TOTAL SHEETS
HAWAII	HAW.	IM-0300(115)	2009	8	36

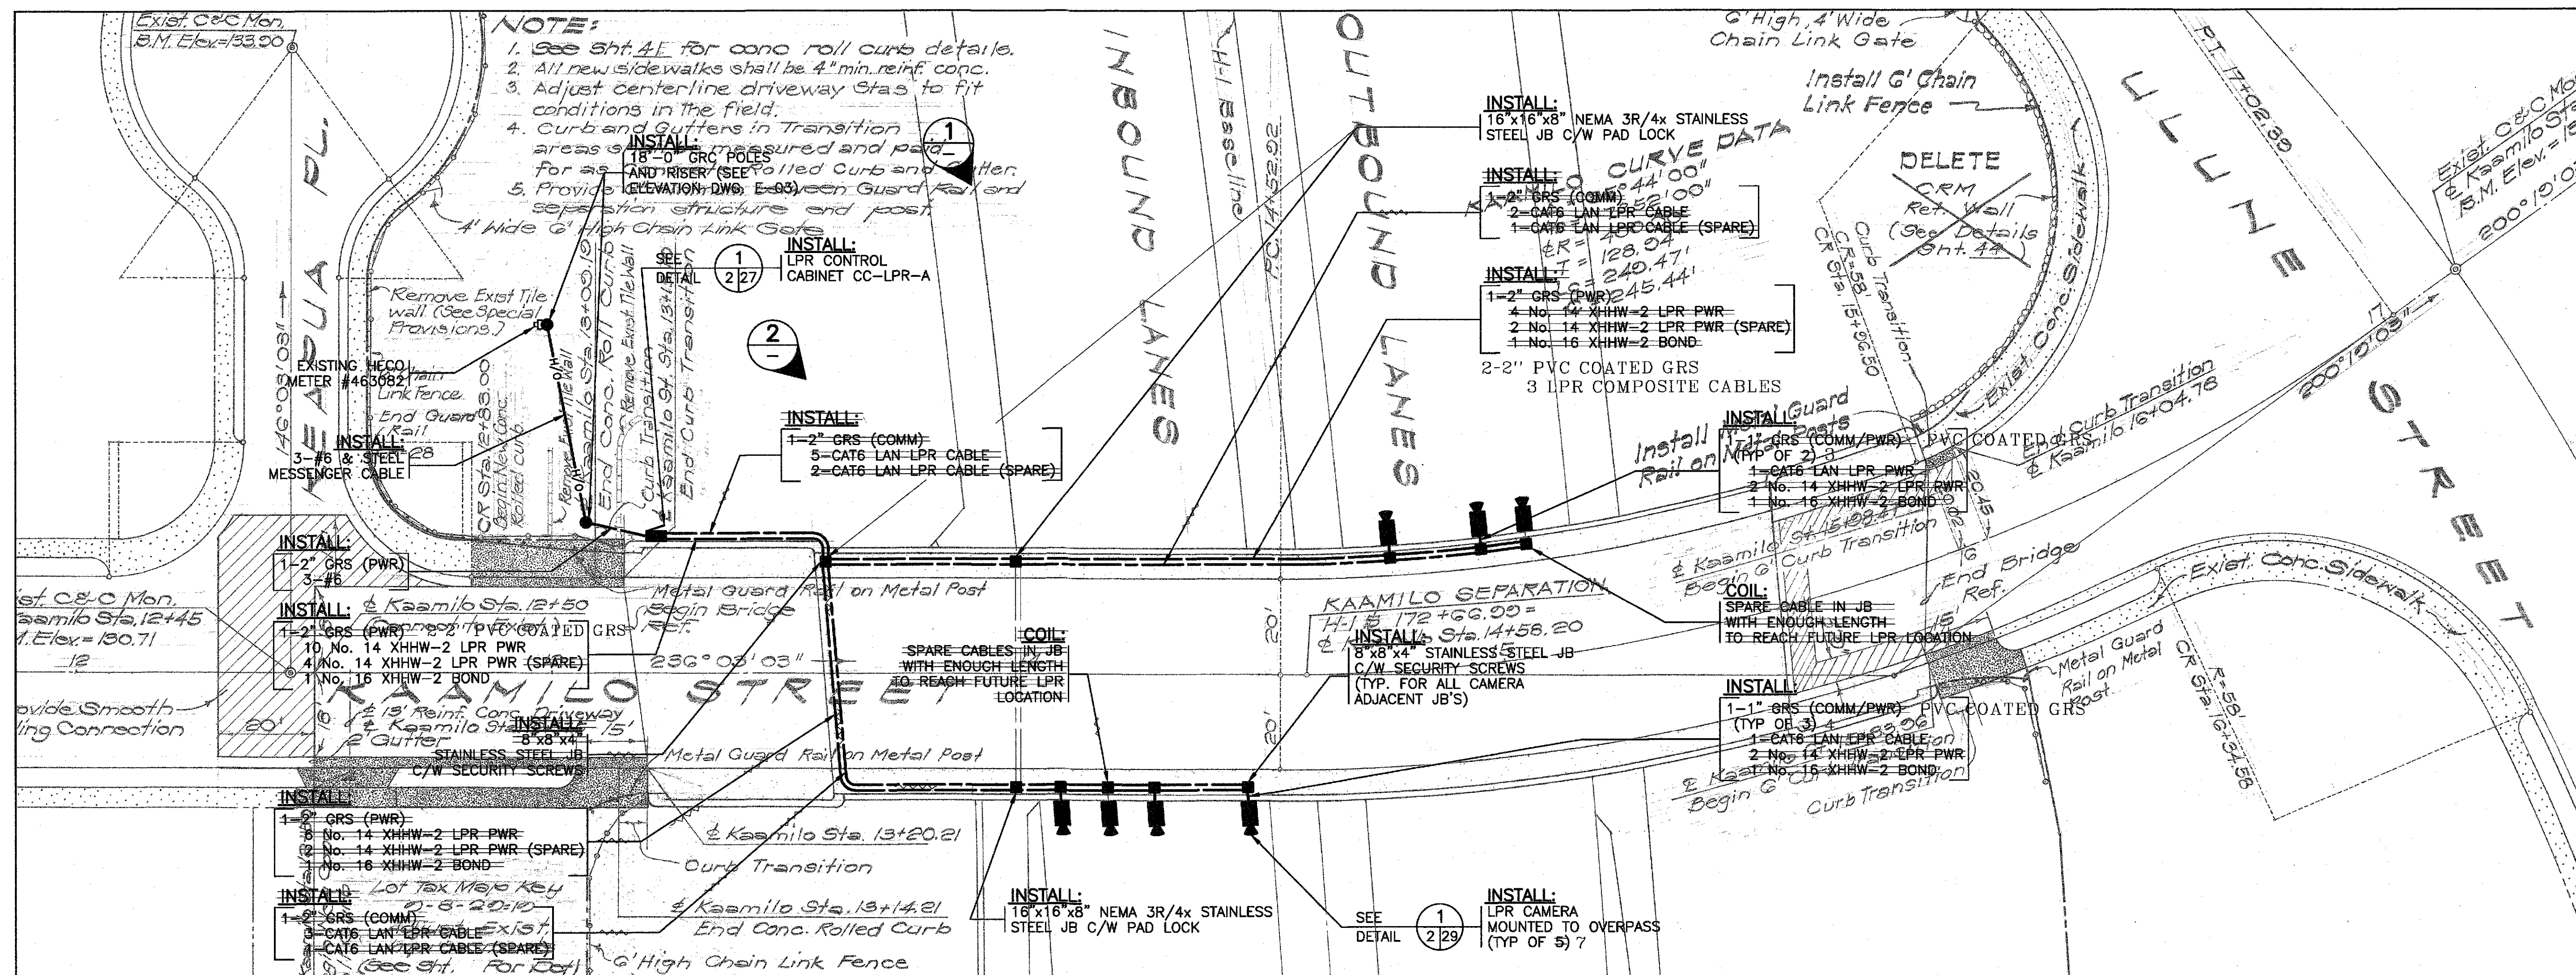

SITE PLAN
SCALE: 1" = 20'-0" 1 KAAMILO


0 1"=20'-0" 50'

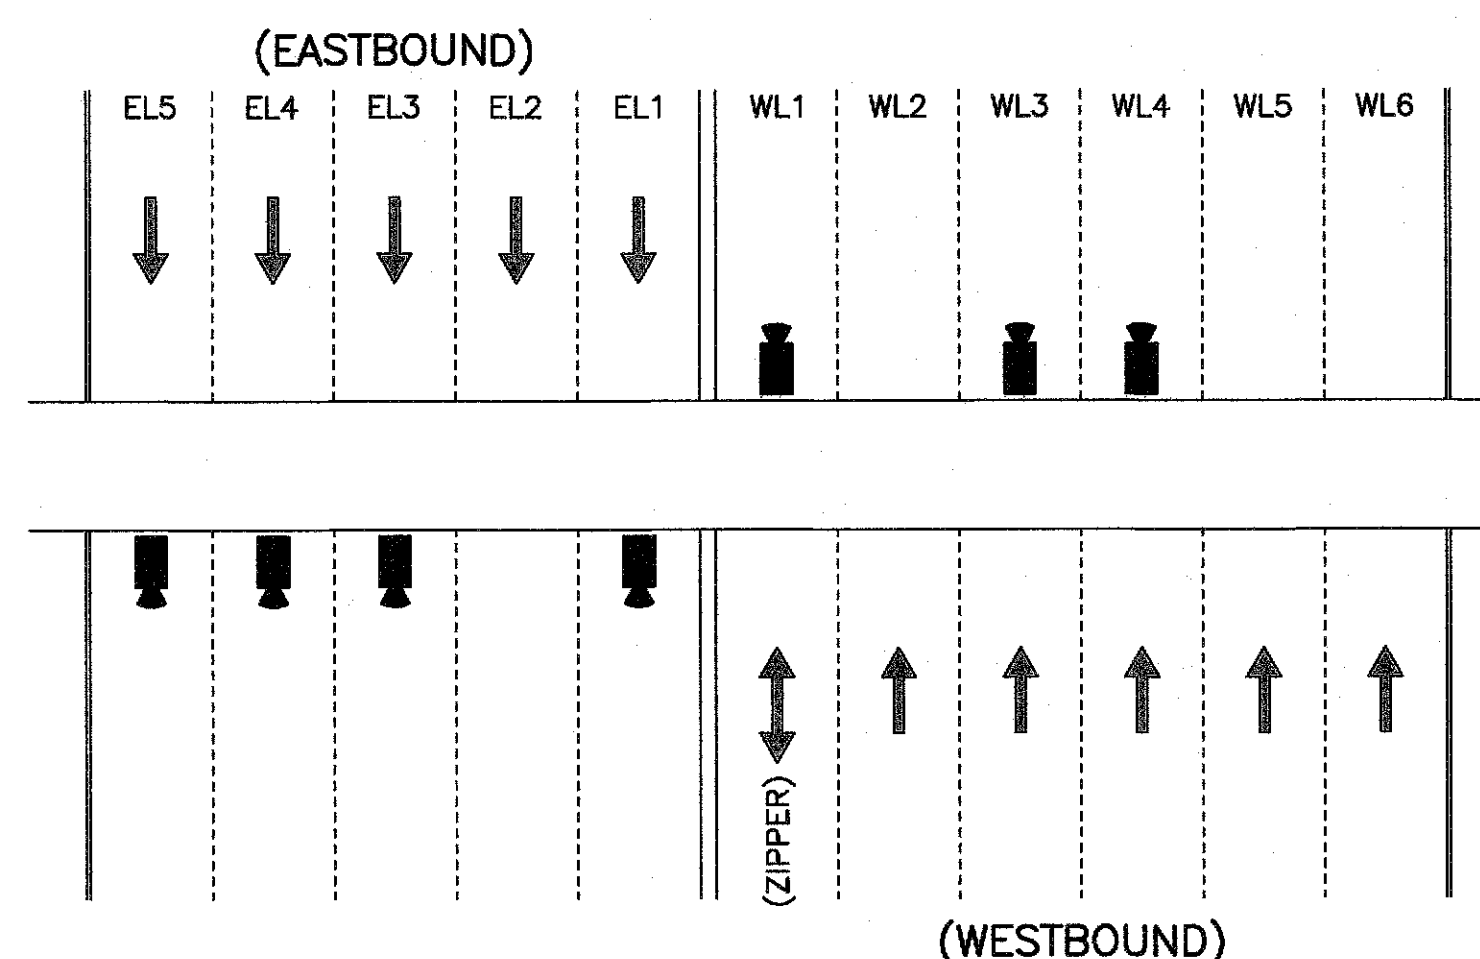

KAAMILO LANE LAYOUT
N.T.S.



PICTURE 1 EASTBOUND TRAFFIC
N.T.S.

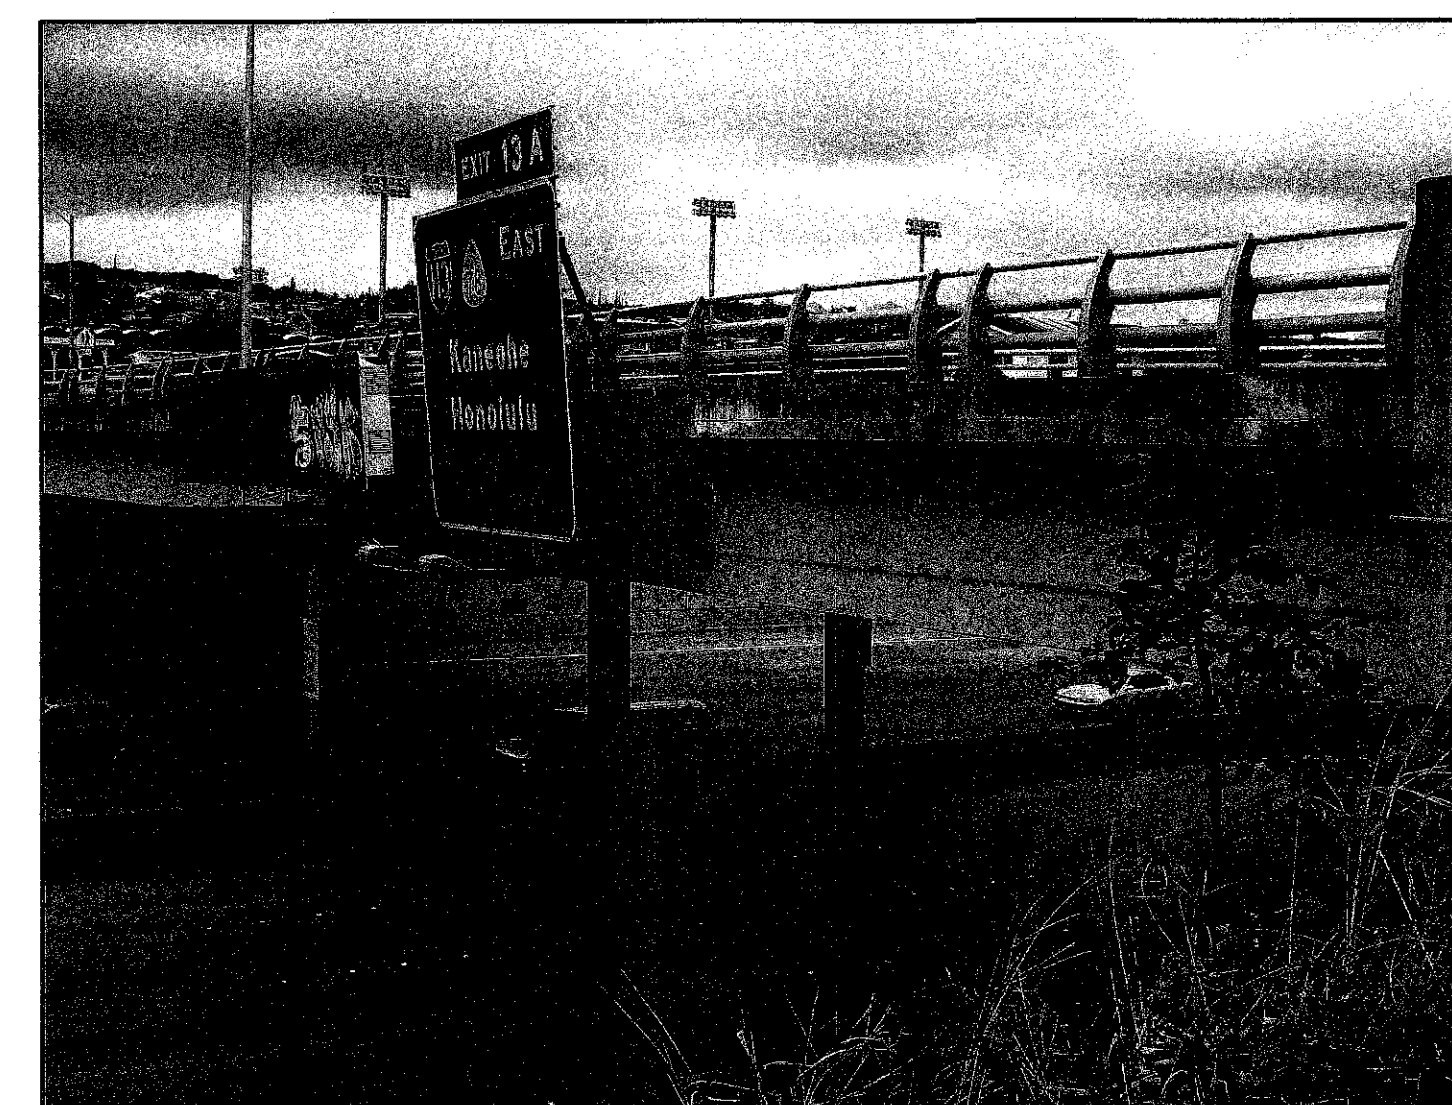

PICTURE 2 ROADWAY CROSS-SECTION
N.T.S.

LEGEND FOR AS-BUILT POSTINGS
Squiggly line for as-built deletion
Double line for as-built deletion
Roadway Text for as-built posting

- NOTES:
- SITE DETAILS FROM HDOT DRAWING I-H1-1(64)12 UNIT_011.
 - POWER SERVICING AVAILABLE FROM EXISTING HDOT DMS CABINET.
 - SCALE IS APPROXIMATE ONLY.
 - CAMERAS TO BE CENTERED OVER LANES AS SHOWN IN THE LANE LAYOUT.
 - 2" CONDUIT ABOVE GRADE SHALL BE SUPPORTED BY GALVANIZED UNISTRUT C/W P-CLAMPS SPACED EVERY 4'-0".
 - NEC APPROVED EXPANSION FITTINGS OR FLEXIBLE CONDUIT SHALL BE USED TO SPAN OVERPASS EXPANSION JOINTS.
 - JUNCTION BOXES ABOVE GRADE SHALL BE SUPPORTED BY UNISTRUT.

ALL EQUIPMENT IS EXISTING
UNLESS NOTED OTHERWISE


STATE OF HAWAII
DEPARTMENT OF TRANSPORTATION
HIGHWAYS DIVISION
SITE PLAN
NODE A - KAAMILO

FREEWAY MANAGEMENT SYSTEM PHASE 1B
TRAVELER INFORMATION SYSTEM, UNIT 3
ITS EQUIPMENT INSTALLATION

F.A.P. NO. IM-0300(115)

SCALE: 1"=20'-0" DATE: DEC 2008


SHEET No. E-02 OF 36 SHEETS

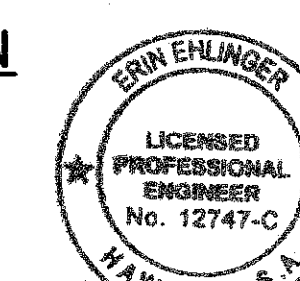


Erin Ehlinger
THIS WORK WAS PREPARED BY ME
OR UNDER MY SUPERVISION

"AS-BUILT"

FED. ROAD DIST. NO.	STATE	FEDERAL AID PROJ. NO.	FISCAL YEAR	SHEET NO.	TOTAL SHEETS
HAWAII	HAW.	IM-0300(115)	2009	9	36

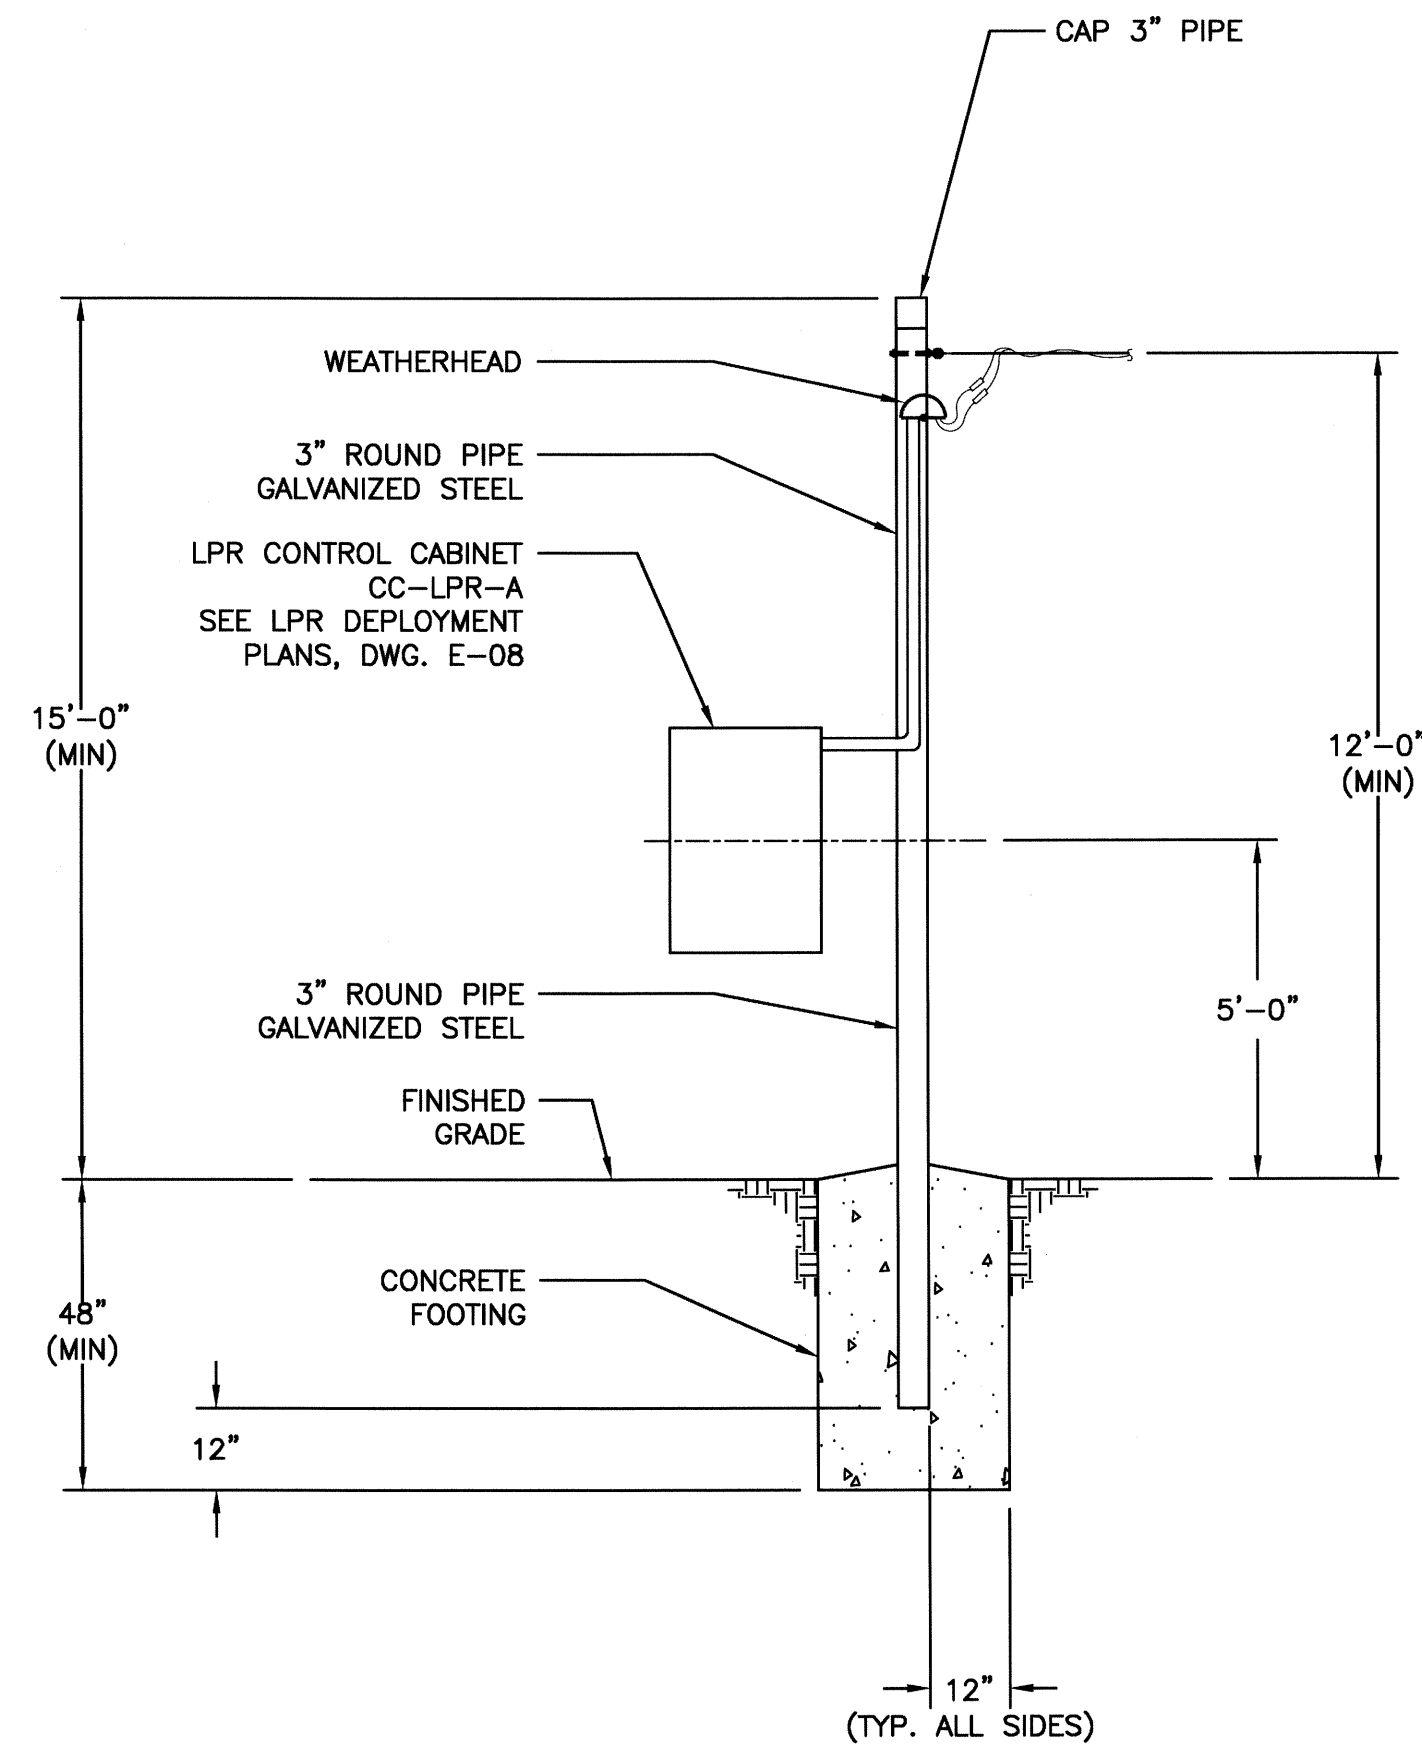


ELEVATION AT LPR CONTROL CABINET

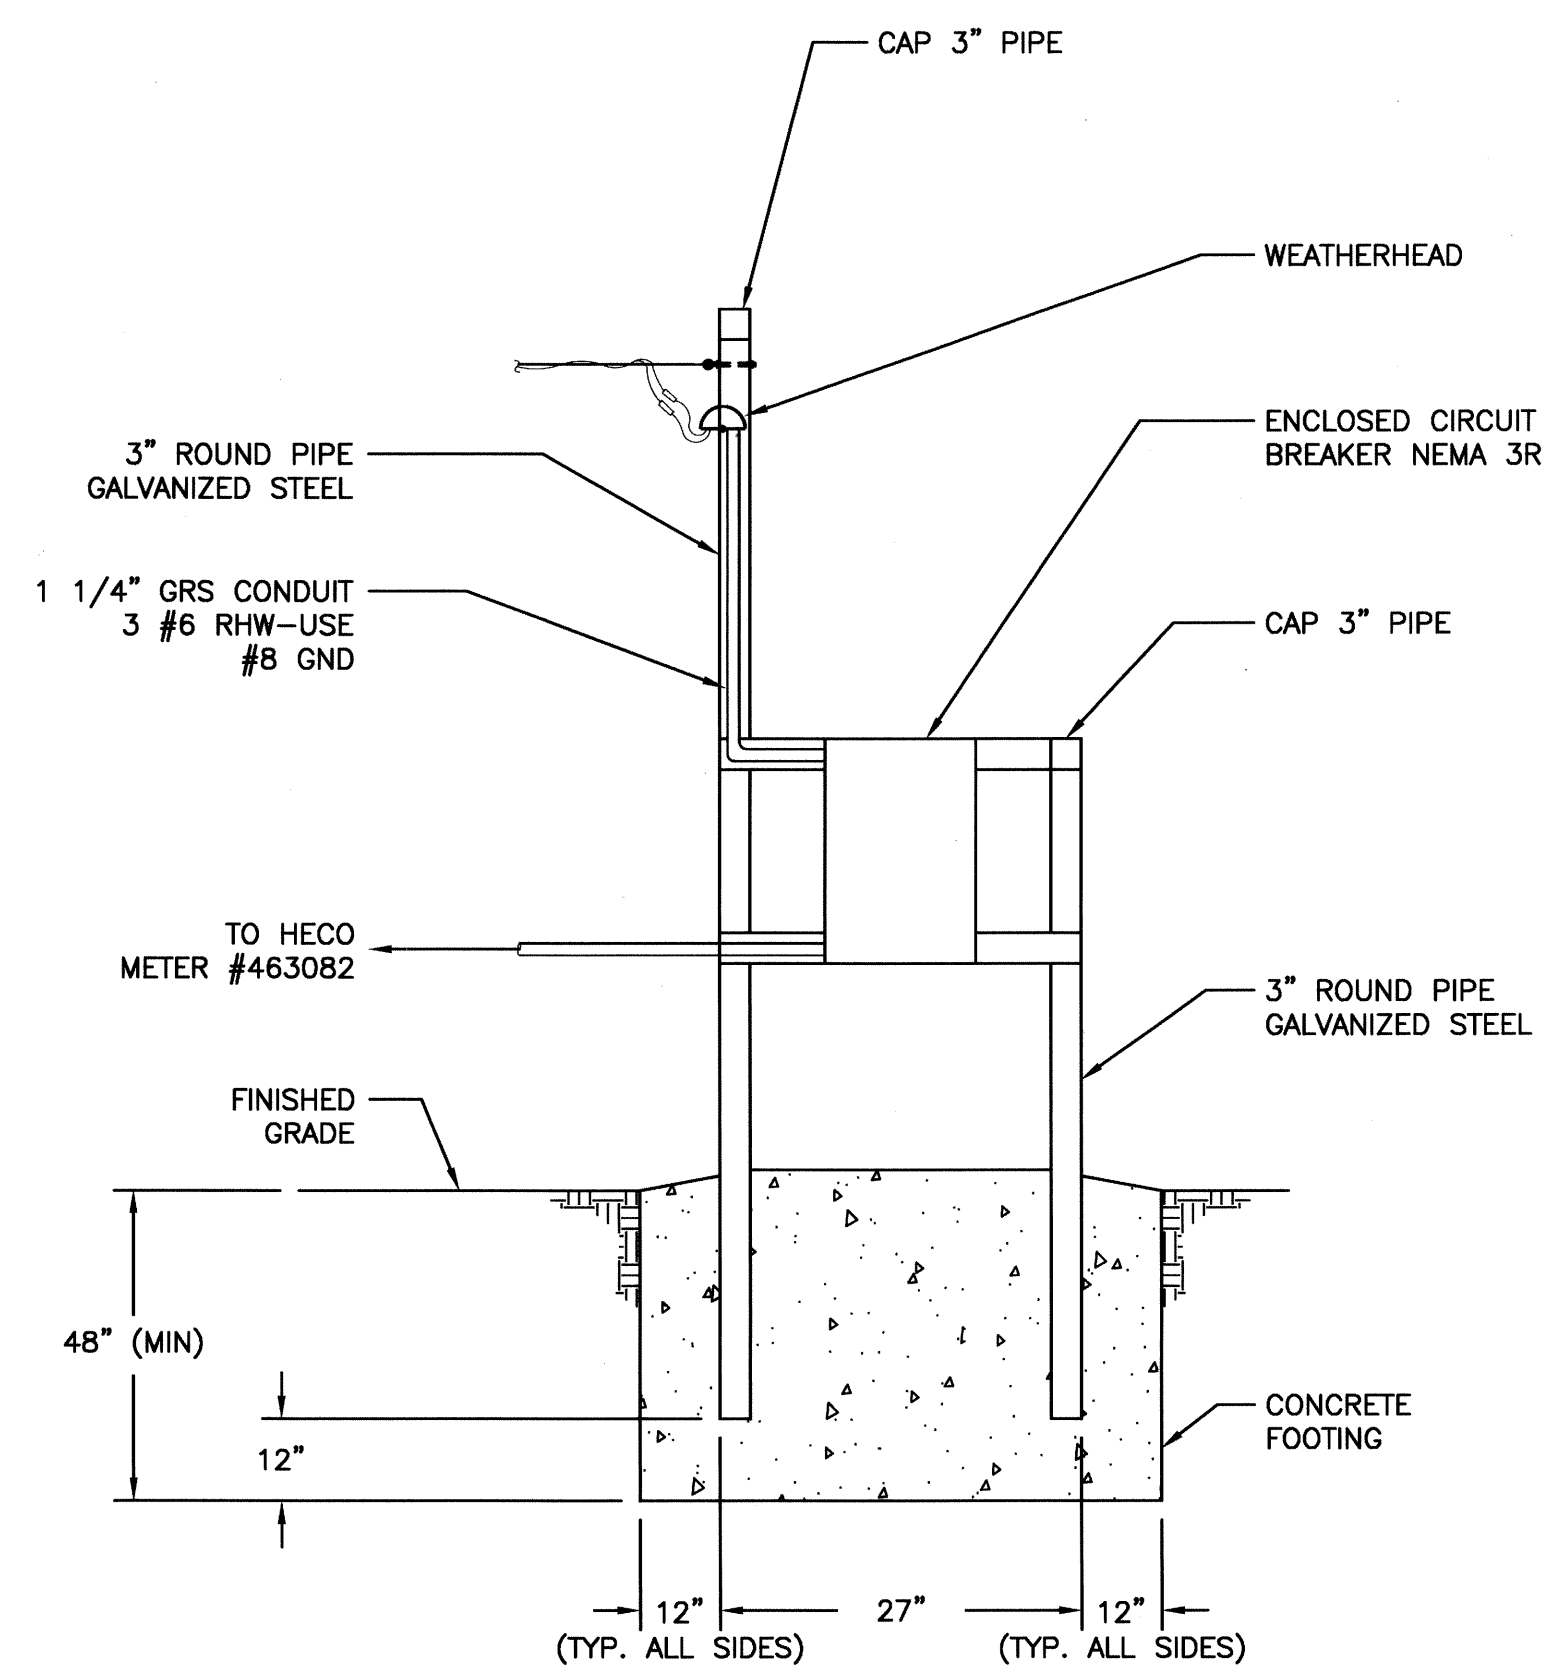

ELEVATION AT HECO METER # 463082

DETAIL **A** POLE ELEVATION
N.T.S. E-03

ALL EQUIPMENT IS PROPOSED
UNLESS NOTED OTHERWISE

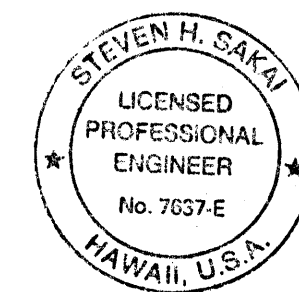

Steven H. Sakai
THIS WORK WAS PREPARED BY ME
OR UNDER MY SUPERVISION

STATE OF HAWAII
DEPARTMENT OF TRANSPORTATION
HIGHWAYS DIVISION

SERVICE ELEVATION NODE A - KAAMILO


FREEWAY MANAGEMENT SYSTEM PHASE 1B
TRAVELER INFORMATION SYSTEM, UNIT 3
ITS EQUIPMENT INSTALLATION

F.A.P. NO. IM-0300(115)

SCALE: NONE DATE: DEC 2008

SHEET No. E-03 OF 36 SHEETS

FED. ROAD DIST. NO.	STATE	FEDERAL AID PROJ. NO.	FISCAL YEAR	SHEET NO.	TOTAL SHEETS
HAWAII	HAW.	IM-0300(115)	2009	10	36

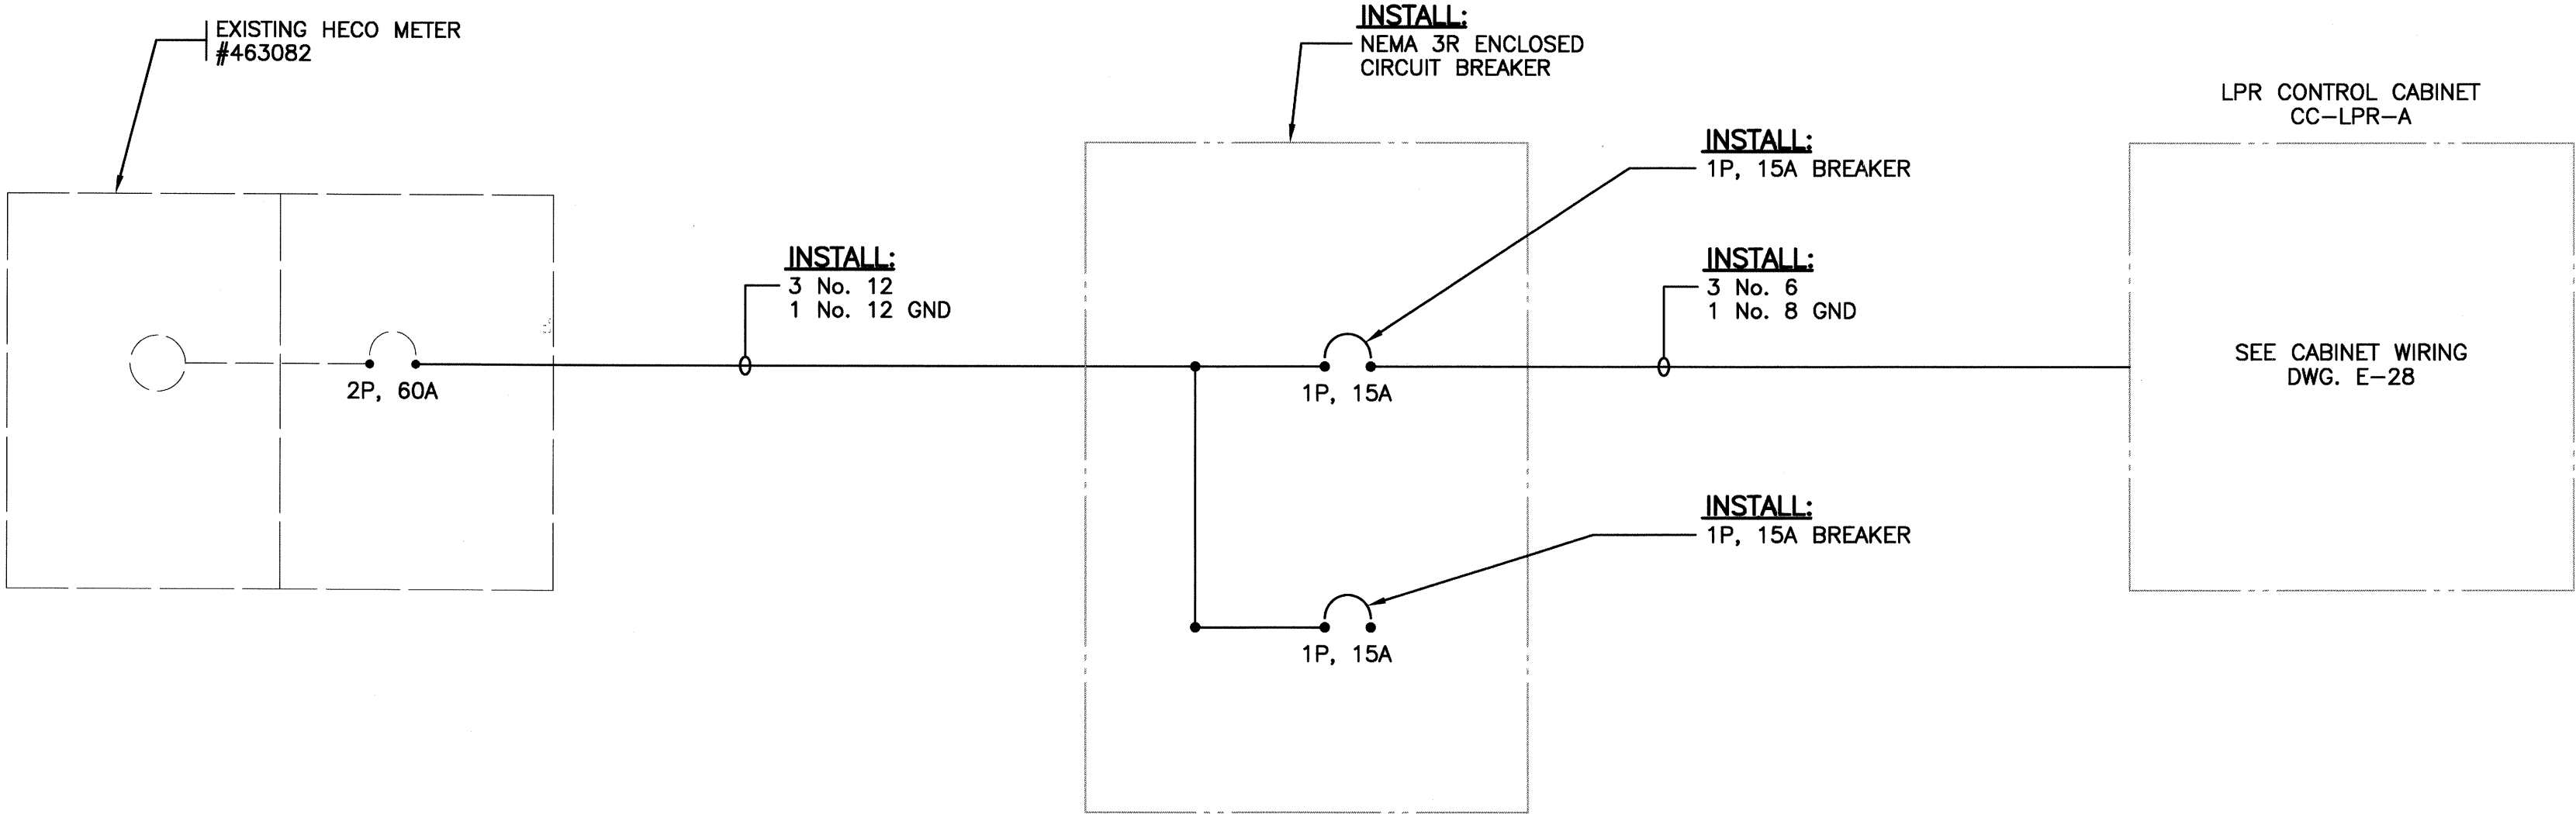


NOTES:

1. SEE SHEET E-03 FOR ELEVATION DETAILS.

DETAIL **(A)** NODE A -- KAAMILO ONE-LINE DIAGRAM
N.T.S. **(E-04)**

ALL EQUIPMENT IS EXISTING
UNLESS NOTED OTHERWISE

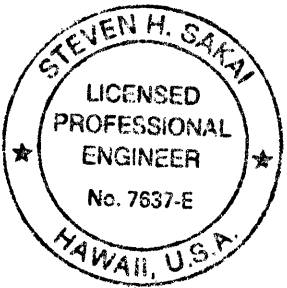

Steven H. Sakai
THIS WORK WAS PREPARED BY ME
OR UNDER MY SUPERVISION

STATE OF HAWAII
DEPARTMENT OF TRANSPORTATION
HIGHWAYS DIVISION

**SERVICE ONE-LINE DIAGRAM
NODE A - KAAMILO**

FREEWAY MANAGEMENT SYSTEM PHASE 1B
TRAVELER INFORMATION SYSTEM, UNIT 3
ITS EQUIPMENT INSTALLATION

F.A.P. NO. IM-0300(115)

SCALE: NONE DATE: DEC 2008

SHEET No. E-04 OF 36 SHEETS