



FED. ROAD DIST. NO.	STATE	FED. AID PROJ. NO.	FISCAL YEAR	SHEET NO.	TOTAL SHEETS
HAWAII	HAW.	1M-0300(138)	2014	16	220

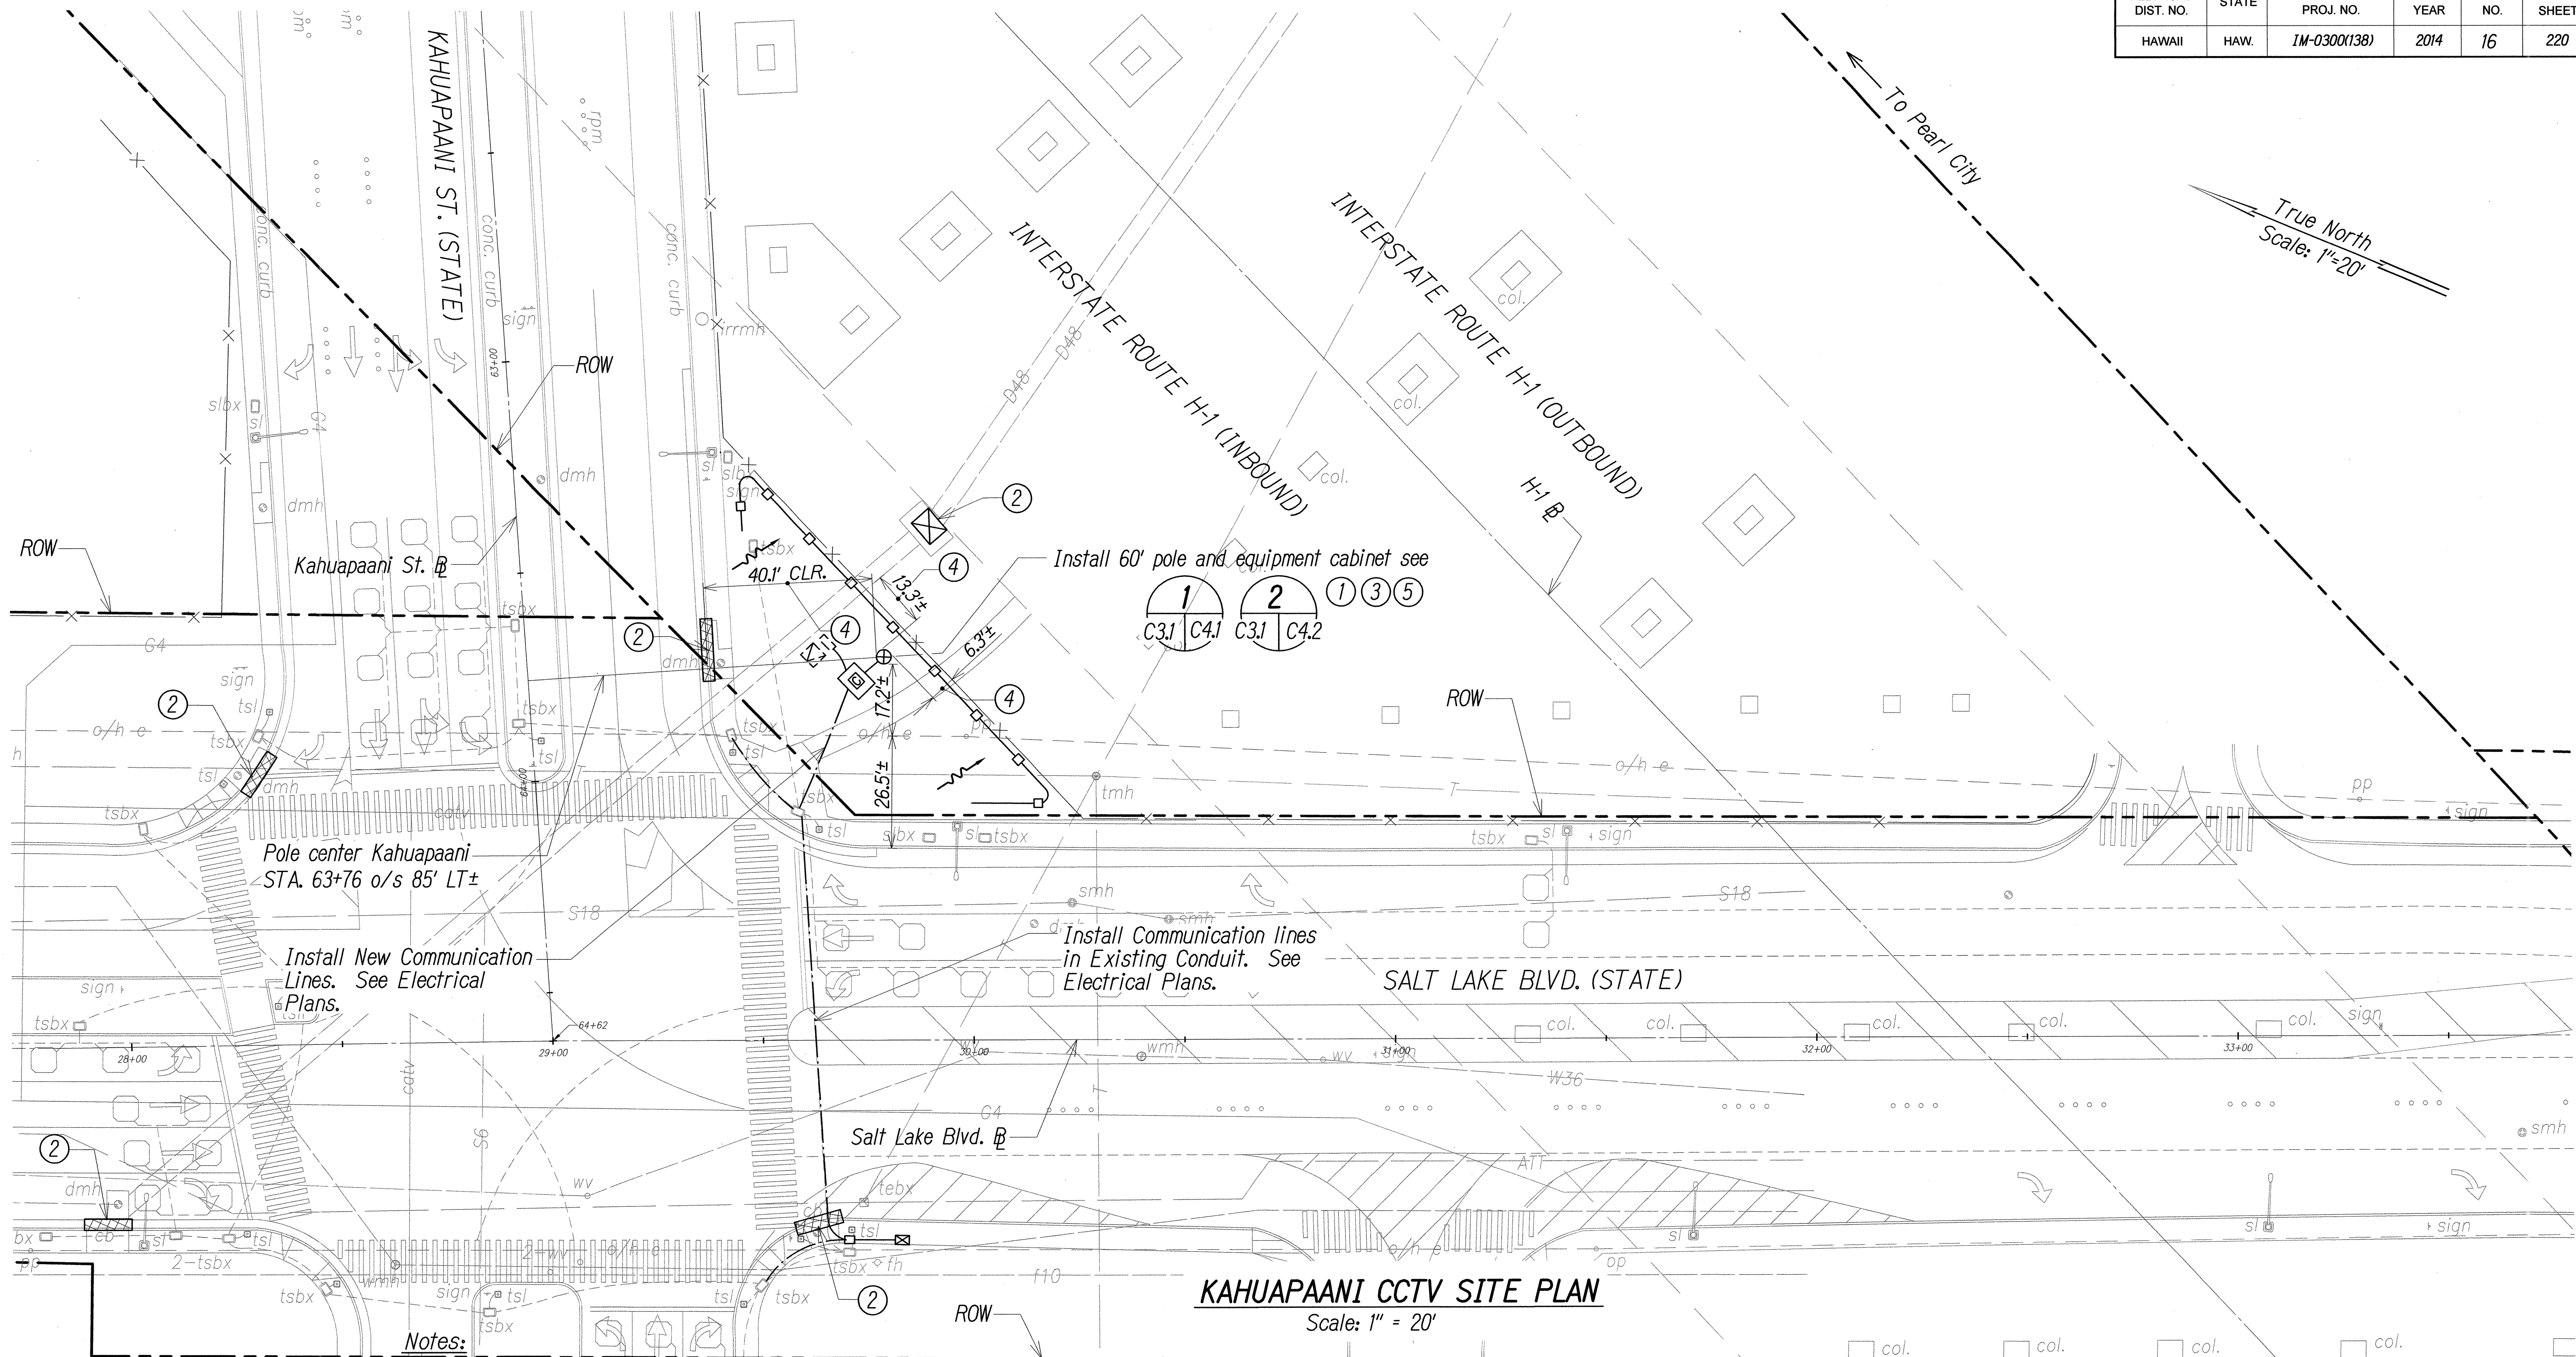

KAHUAPAANI CCTV SITE PLAN


Scale: 1" = 20'

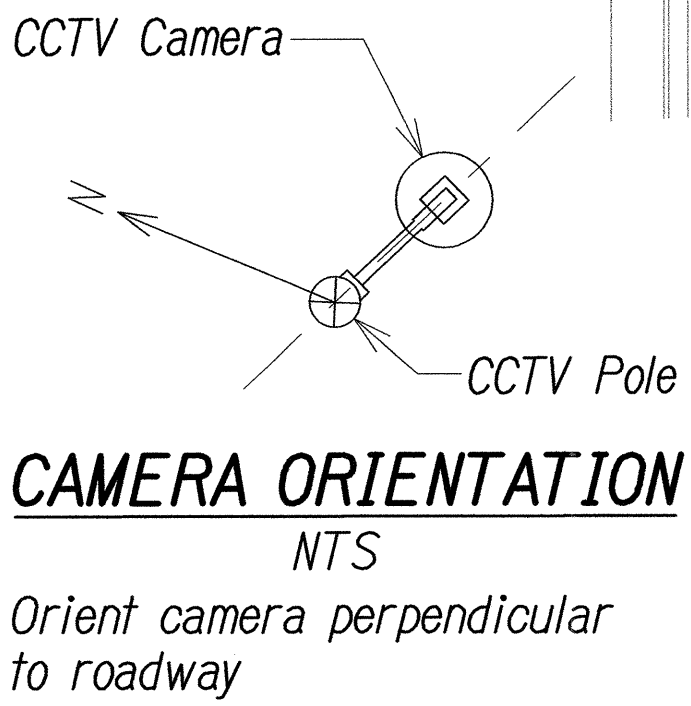

- Notes:**
- ① See Electrical Plans for electrical and communication service connections.
 - ② Exist. storm drain inlet or catch basin. Contractor to observe Best Management Practices and take measures required. Protect exist. storm drain inlets and catch basins located downstream of the project site with Best Management Practices. See Sheet C4.3 for details.
 - ③ Exist. grassed area or landscaping, Contractor to observe Best Management Practices. See detail on Sheet C4.3.
 - ④ Avoid exist. irrigation systems.
 - ⑤ See Structural Plans for details.

LEGEND:

- ⊗ CCTV Pole
- Equipment Cabinet
- Temporary Silt Fence
- ▨ Temporary Sediment Control Filter
- Flow Direction

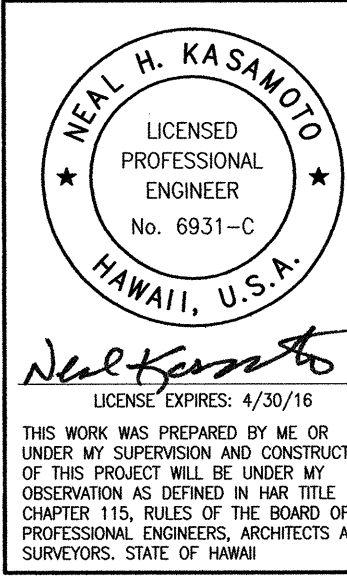


STATE OF HAWAII
DEPARTMENT OF TRANSPORTATION
HIGHWAYS DIVISION

KAHUAPAANI CCTV SITE PLAN

Freeway Management System, Interstate
H-1, H-2 & Moanalua Freeway (H-201)
Phase IC, Part 2
Federal Aid Project No. 1M-0300(138)

Scale: 1 in. = 20' Date: 8/7/14

FED. ROAD DIST. NO.	STATE	FED. AID PROJ. NO.	FISCAL YEAR	SHEET NO.	TOTAL SHEETS
HAWAII	HAW.	1M-0300(138)	2014	18	220

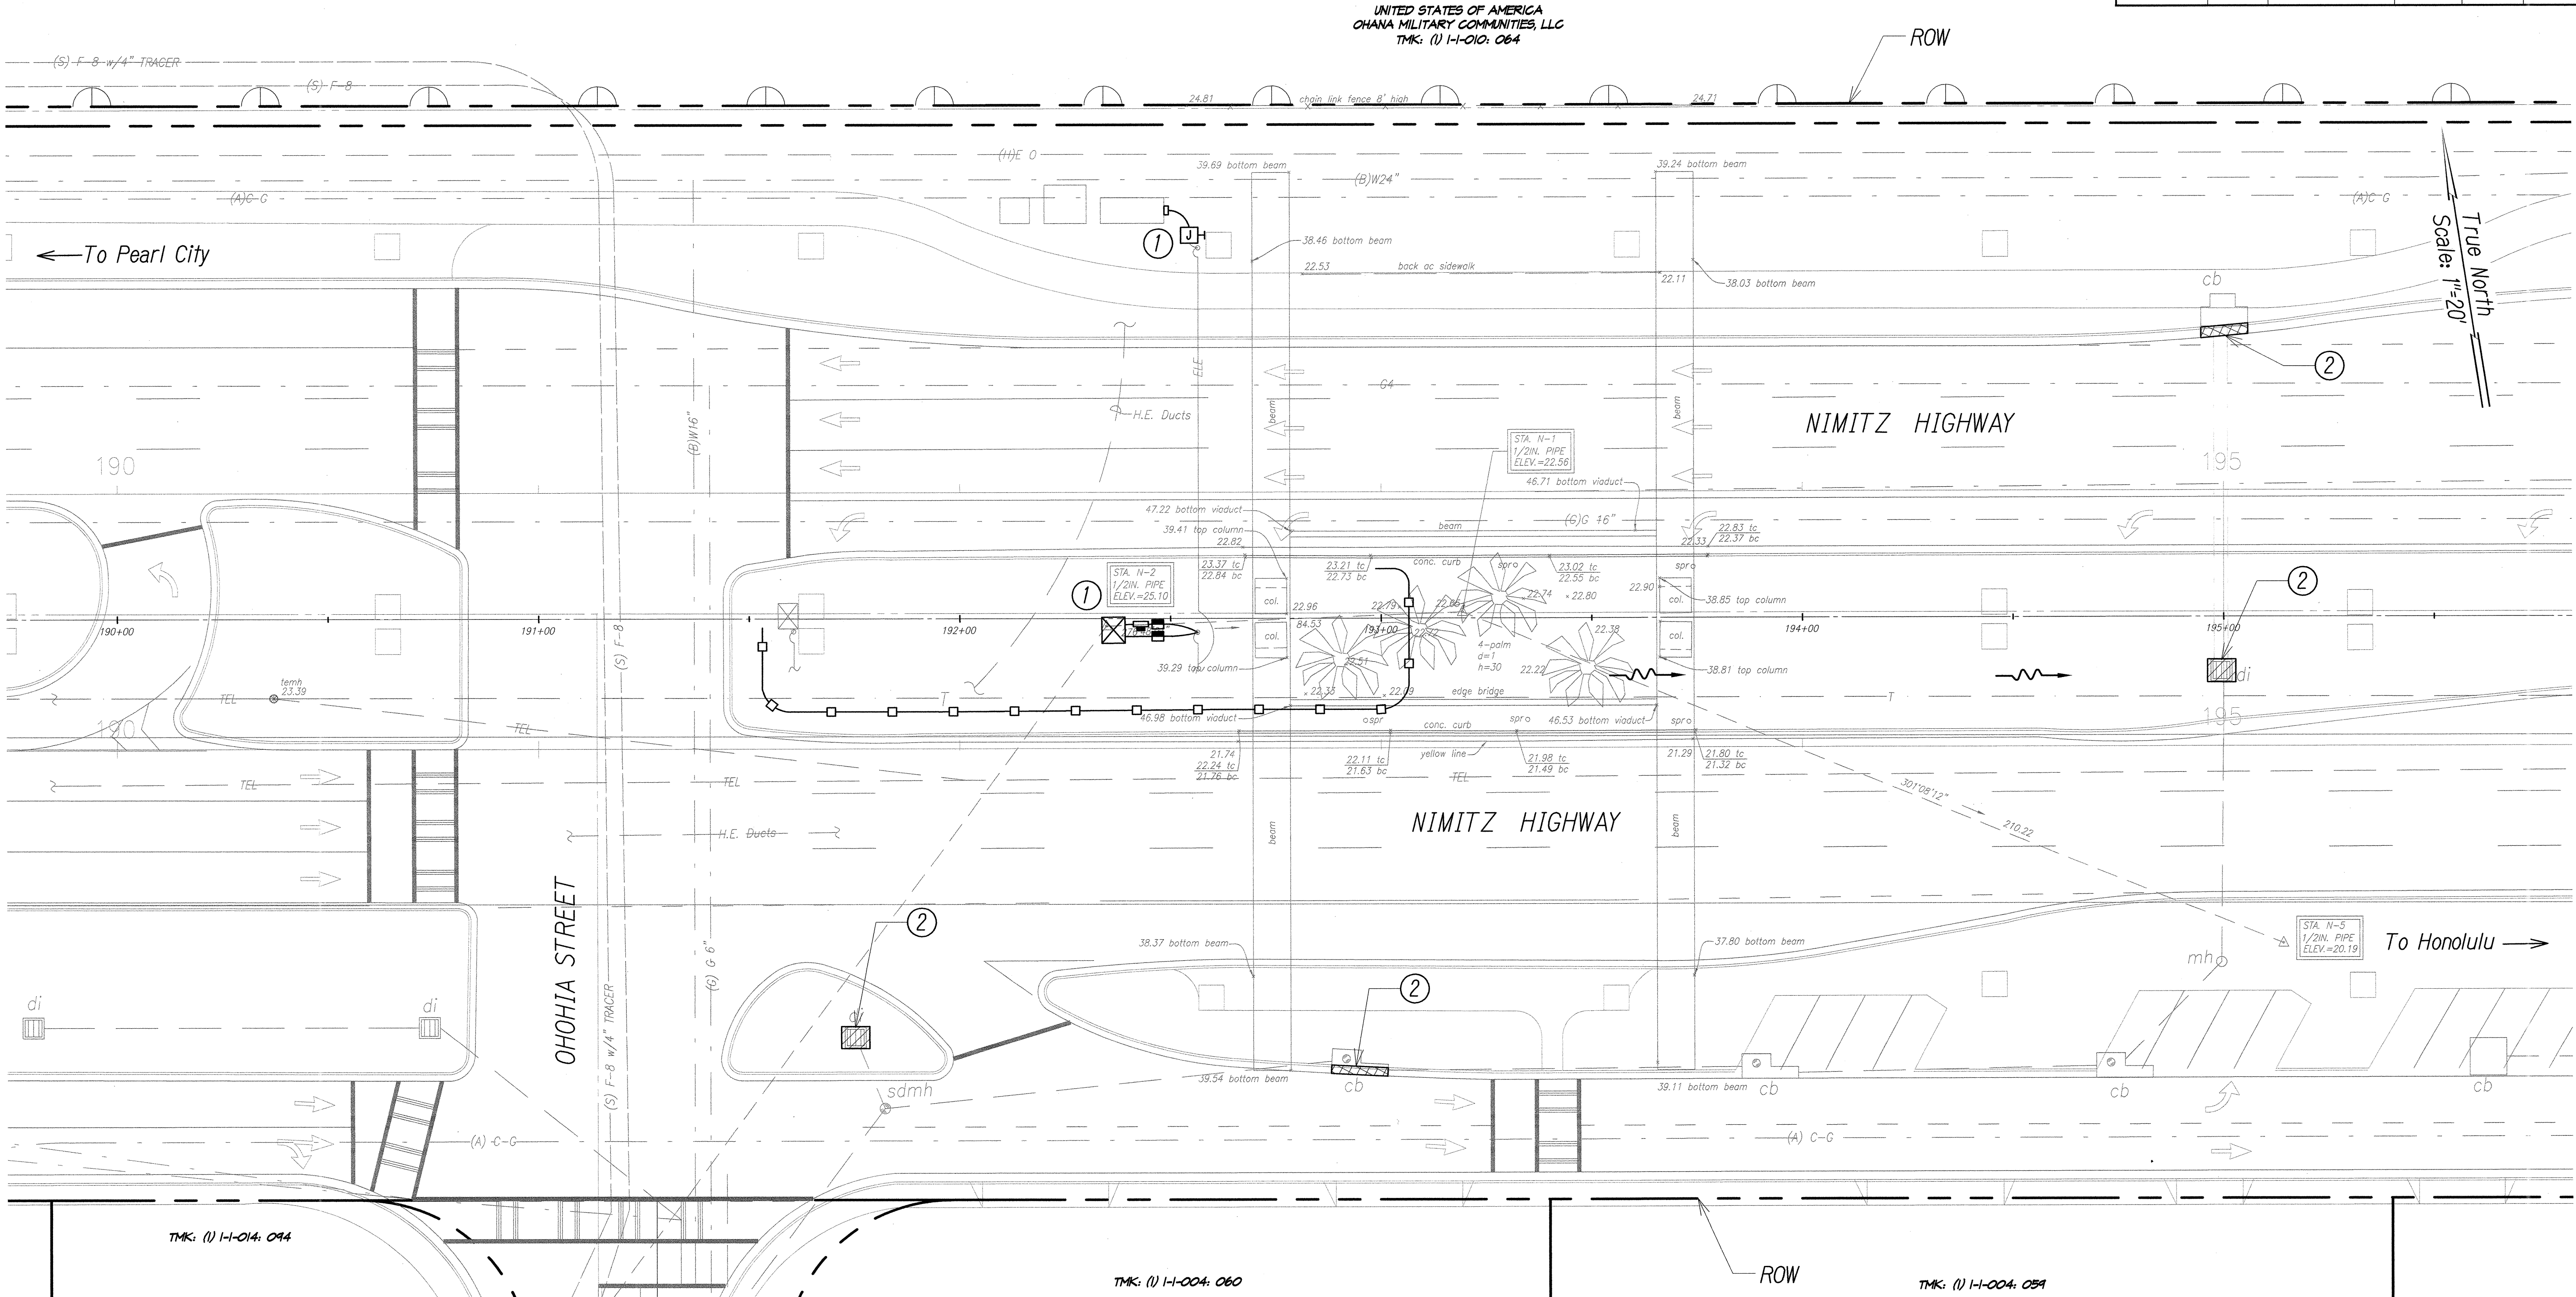

Notes:


- ① See Electrical Plans for electrical and communication service connections.
- ② Exist. storm drain inlet or catch basin. Contractor to observe Best Management Practices and take measures required. Protect exist. storm drain inlets and catch basins located downstream of the project site with Best Management Practices. See Sheet C4.3 for details.
- ③ Exist. grassed area or landscaping, Contractor to observe Best Management Practices. See detail on Sheet C4.3.
- ④ Avoid exist. irrigation systems.

AIRPORT SPLICE CABINET PLAN (NIMITZ)
Scale: 1" = 20'

LEGEND:

- □ □ Temporary Silt Fence
- ▨ Temporary Drain Inlet Protection
- ▩ Temporary Sediment Control Filter
- Flow Direction

LINE IS 2 INCHES AT FULL SIZE
(if not 2 inches: scale accordingly)

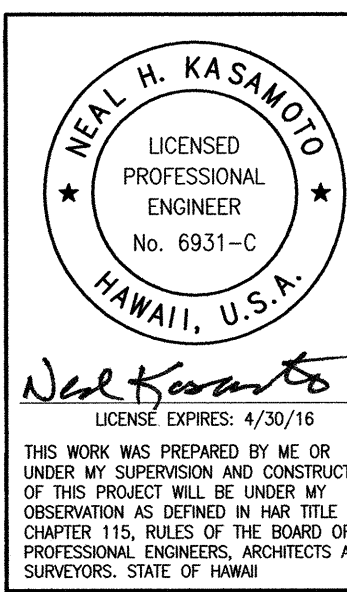

STATE OF HAWAII
DEPARTMENT OF TRANSPORTATION
HIGHWAYS DIVISION

OHOHIA SPLICE CABINET PLAN


Freeway Management System, Interstate
H-1, H-2 & Moanalua Freeway (H-201)
Phase 1C, Part 2
Federal Aid Project No. 1M-0300(138)

Scale: 1 in. = 20' Date: 8/7/14

SURVEY PLOTTED BY	DATE
DRAWN BY	
DESIGNED BY	
CHECKED BY	
ORIGINAL PLAN	
NOTEBOOK	
QUANTITIES BY	
CHECKED BY	
No.	

FILE: 96-46-96-46-27 DWG: C3.3 AIRPORT CCTV SPLICE CABINET -20 SCALE: DWG Oct 13, 2014-8:49 AM

FED. ROAD DIST. NO.	STATE	FED. AID PROJ. NO.	FISCAL YEAR	SHEET NO.	TOTAL SHEETS
HAWAII	HAW.	IM-0300(138)	2014	19	220

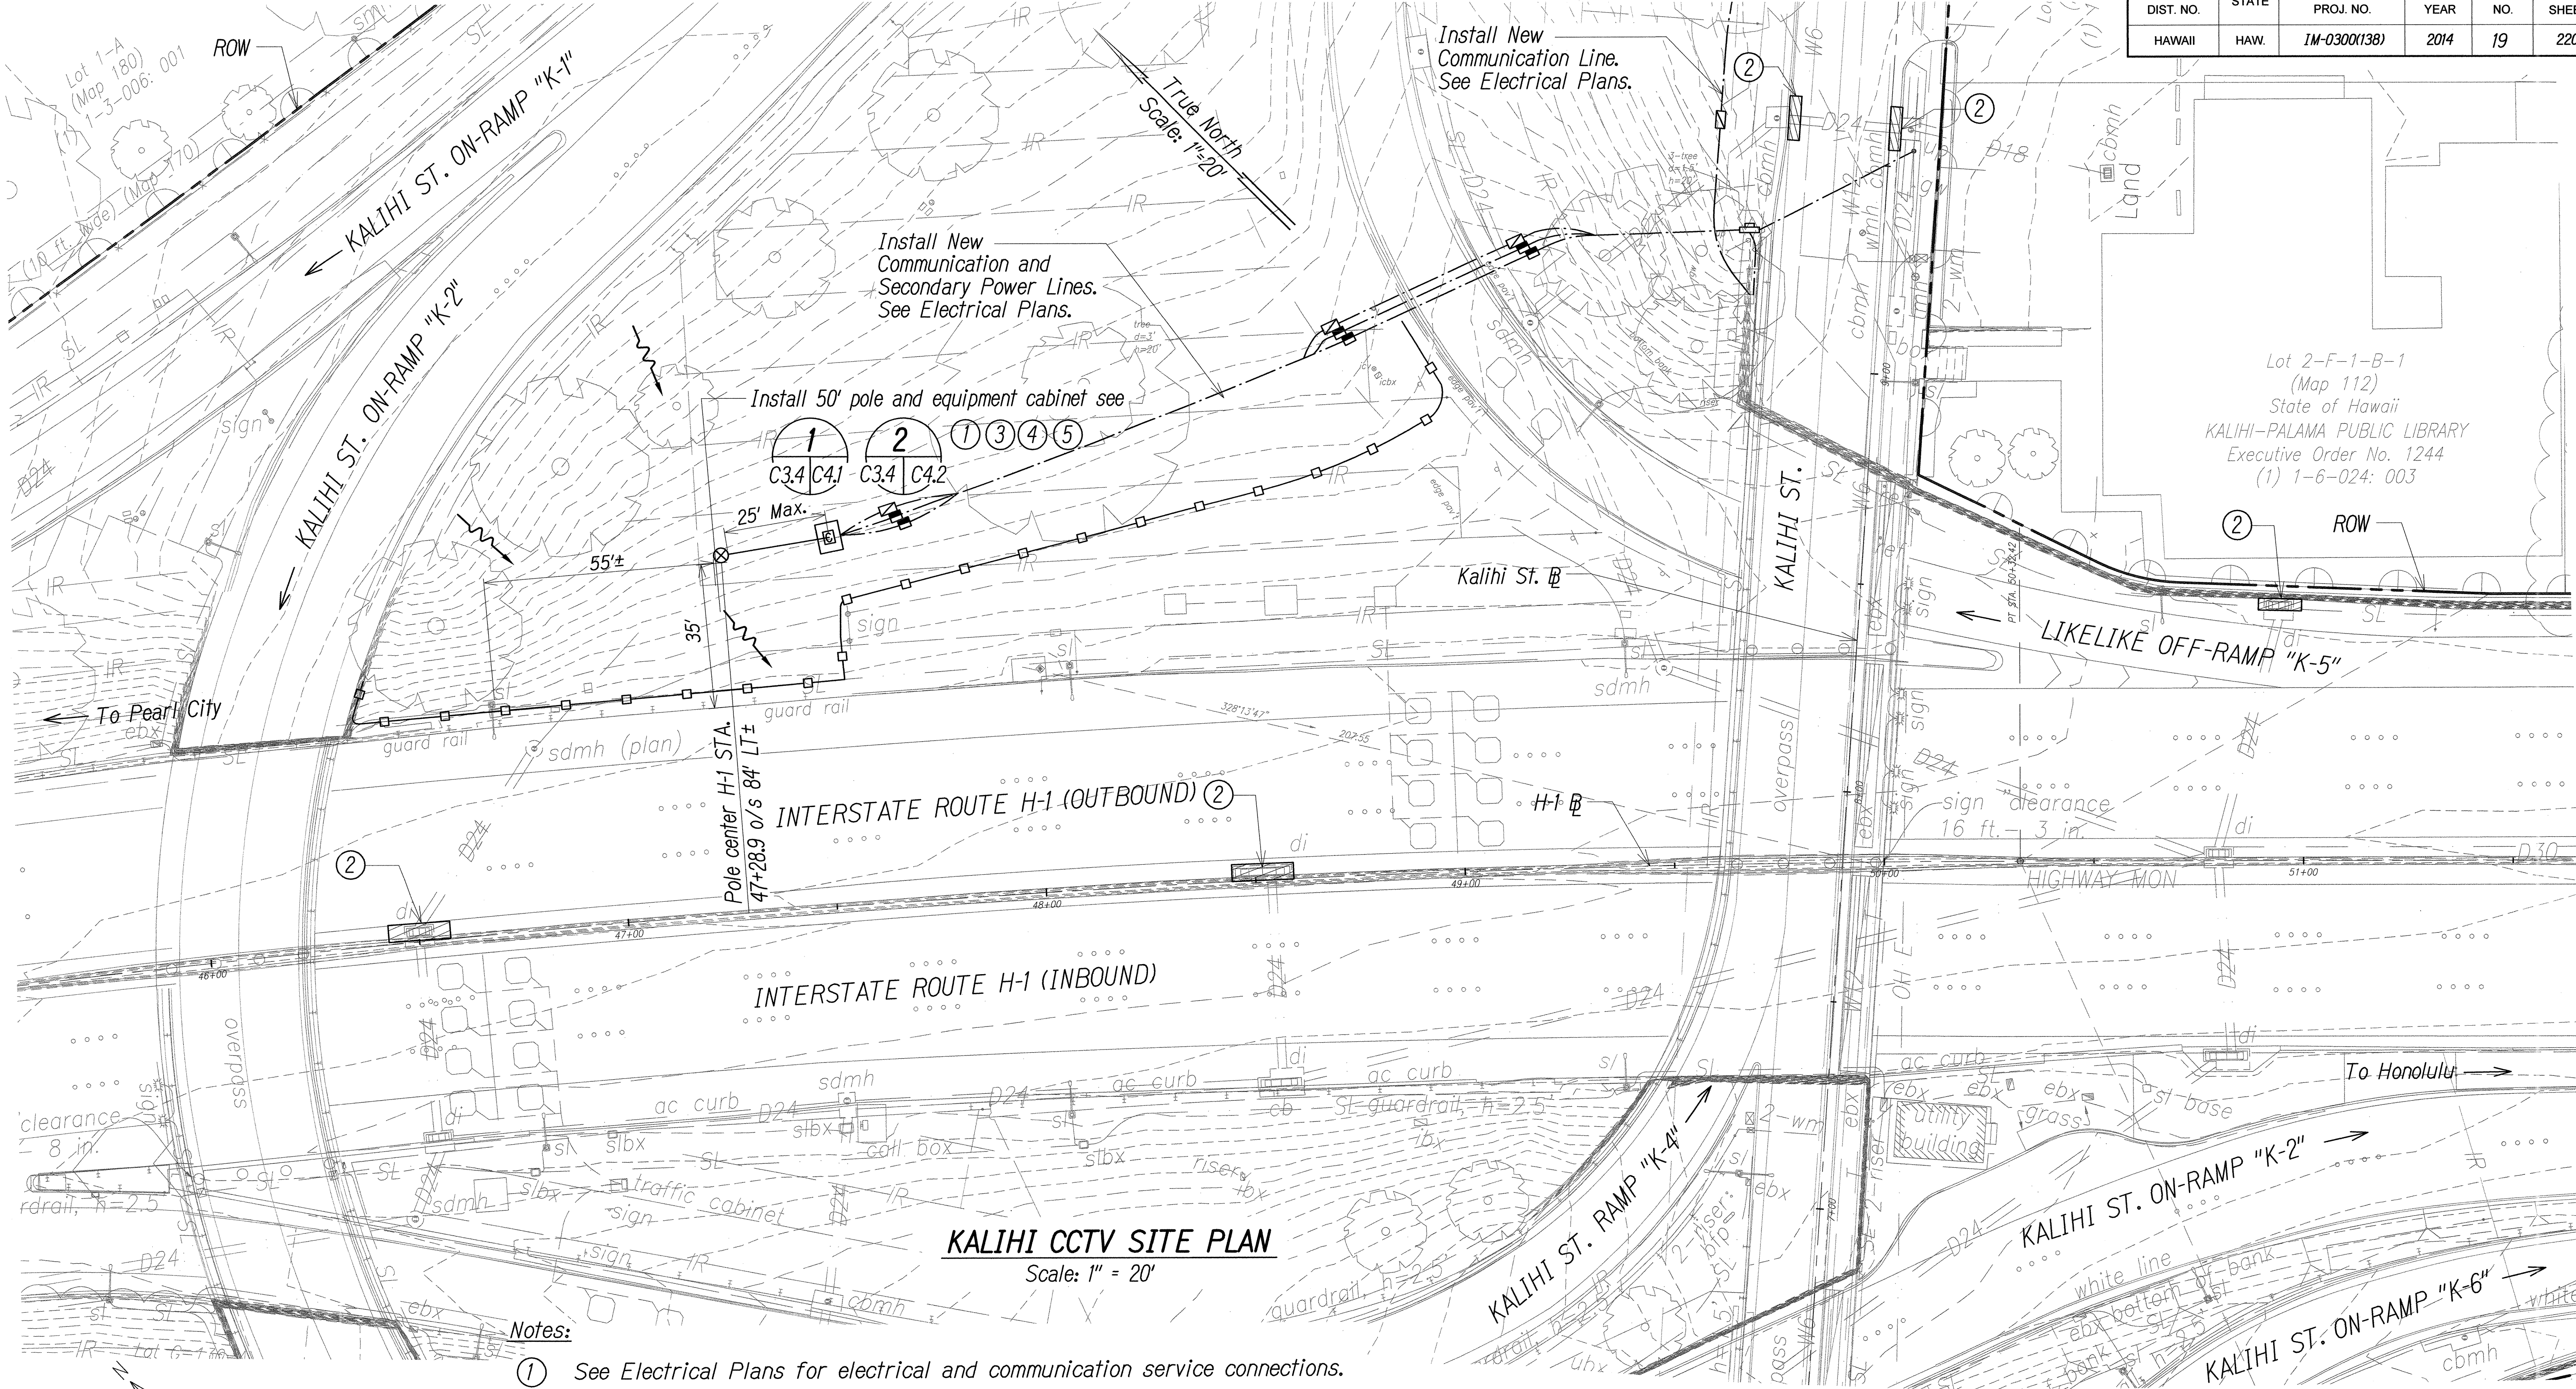

Lot 2-F-1-B-1
(Map 112)
State of Hawaii
KALIHI-PALAMA PUBLIC LIBRARY
Executive Order No. 1244
(1) 1-6-024: 003

- Notes:
- ① See Electrical Plans for electrical and communication service connections.
 - ② Exist. storm drain inlet or catch basin. Contractor to observe Best Management Practices and take measures required. Protect exist. storm drain inlets and catch basins located downstream of the project site with Best Management Practices. See Sheet C4.3 for details.
 - ③ Exist. grassed area or landscaping, Contractor to observe Best Management Practices. See detail on Sheet C4.3.
 - ④ Avoid exist. irrigation systems.
 - ⑤ See Structural Plans for details.

CAMERA ORIENTATION
NTS
Orient camera perpendicular to roadway

LEGEND:

- ⊗ CCTV Pole
- Equipment Cabinet
- Temporary Silt Fence
- ▨ Temporary Drain Inlet Protection
- Flow Direction

Scale: 1 in. = 20'

LINE IS 2 INCHES AT FULL SIZE
(if not 2 inches: scale accordingly)

NEAL H. KASAMOD
LICENSED PROFESSIONAL ENGINEER
No. 6931-C
HAWAII, U.S.A.

STATE OF HAWAII
DEPARTMENT OF TRANSPORTATION
HIGHWAYS DIVISION

KALIHI CCTV SITE PLAN

Freeway Management System, Interstate
H-1, H-2 & Moanalua Freeway (H-201)
Phase 1C, Part 2
Federal Aid Project No. IM-0300(138)



Scale: 1 in. = 20' Date: 8/7/14

SHEET No. C3.4 OF 9 SHEETS

SURVEY PLOTTED BY	DATE
DRAWN BY	
DESIGNED BY	
QUANTITIES BY	
CHECKED BY	
ORIGINAL PLAN	
NOTEBOOK	
No.	

FILE: \\96-46-46-96-46-27\DWG\C3.4 KALIHI CCTV-20 SCALE.DWG Oct 13, 2014 8:50 AM


FED. ROAD DIST. NO.	STATE	FED. AID PROJ. NO.	FISCAL YEAR	SHEET NO.	TOTAL SHEETS
HAWAII	HAW.	IM-0300(138)	2014	22	220

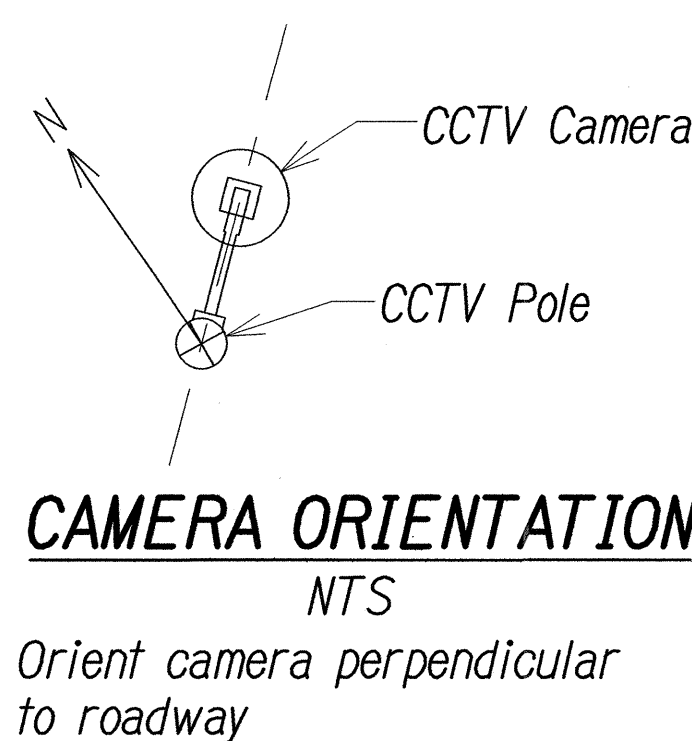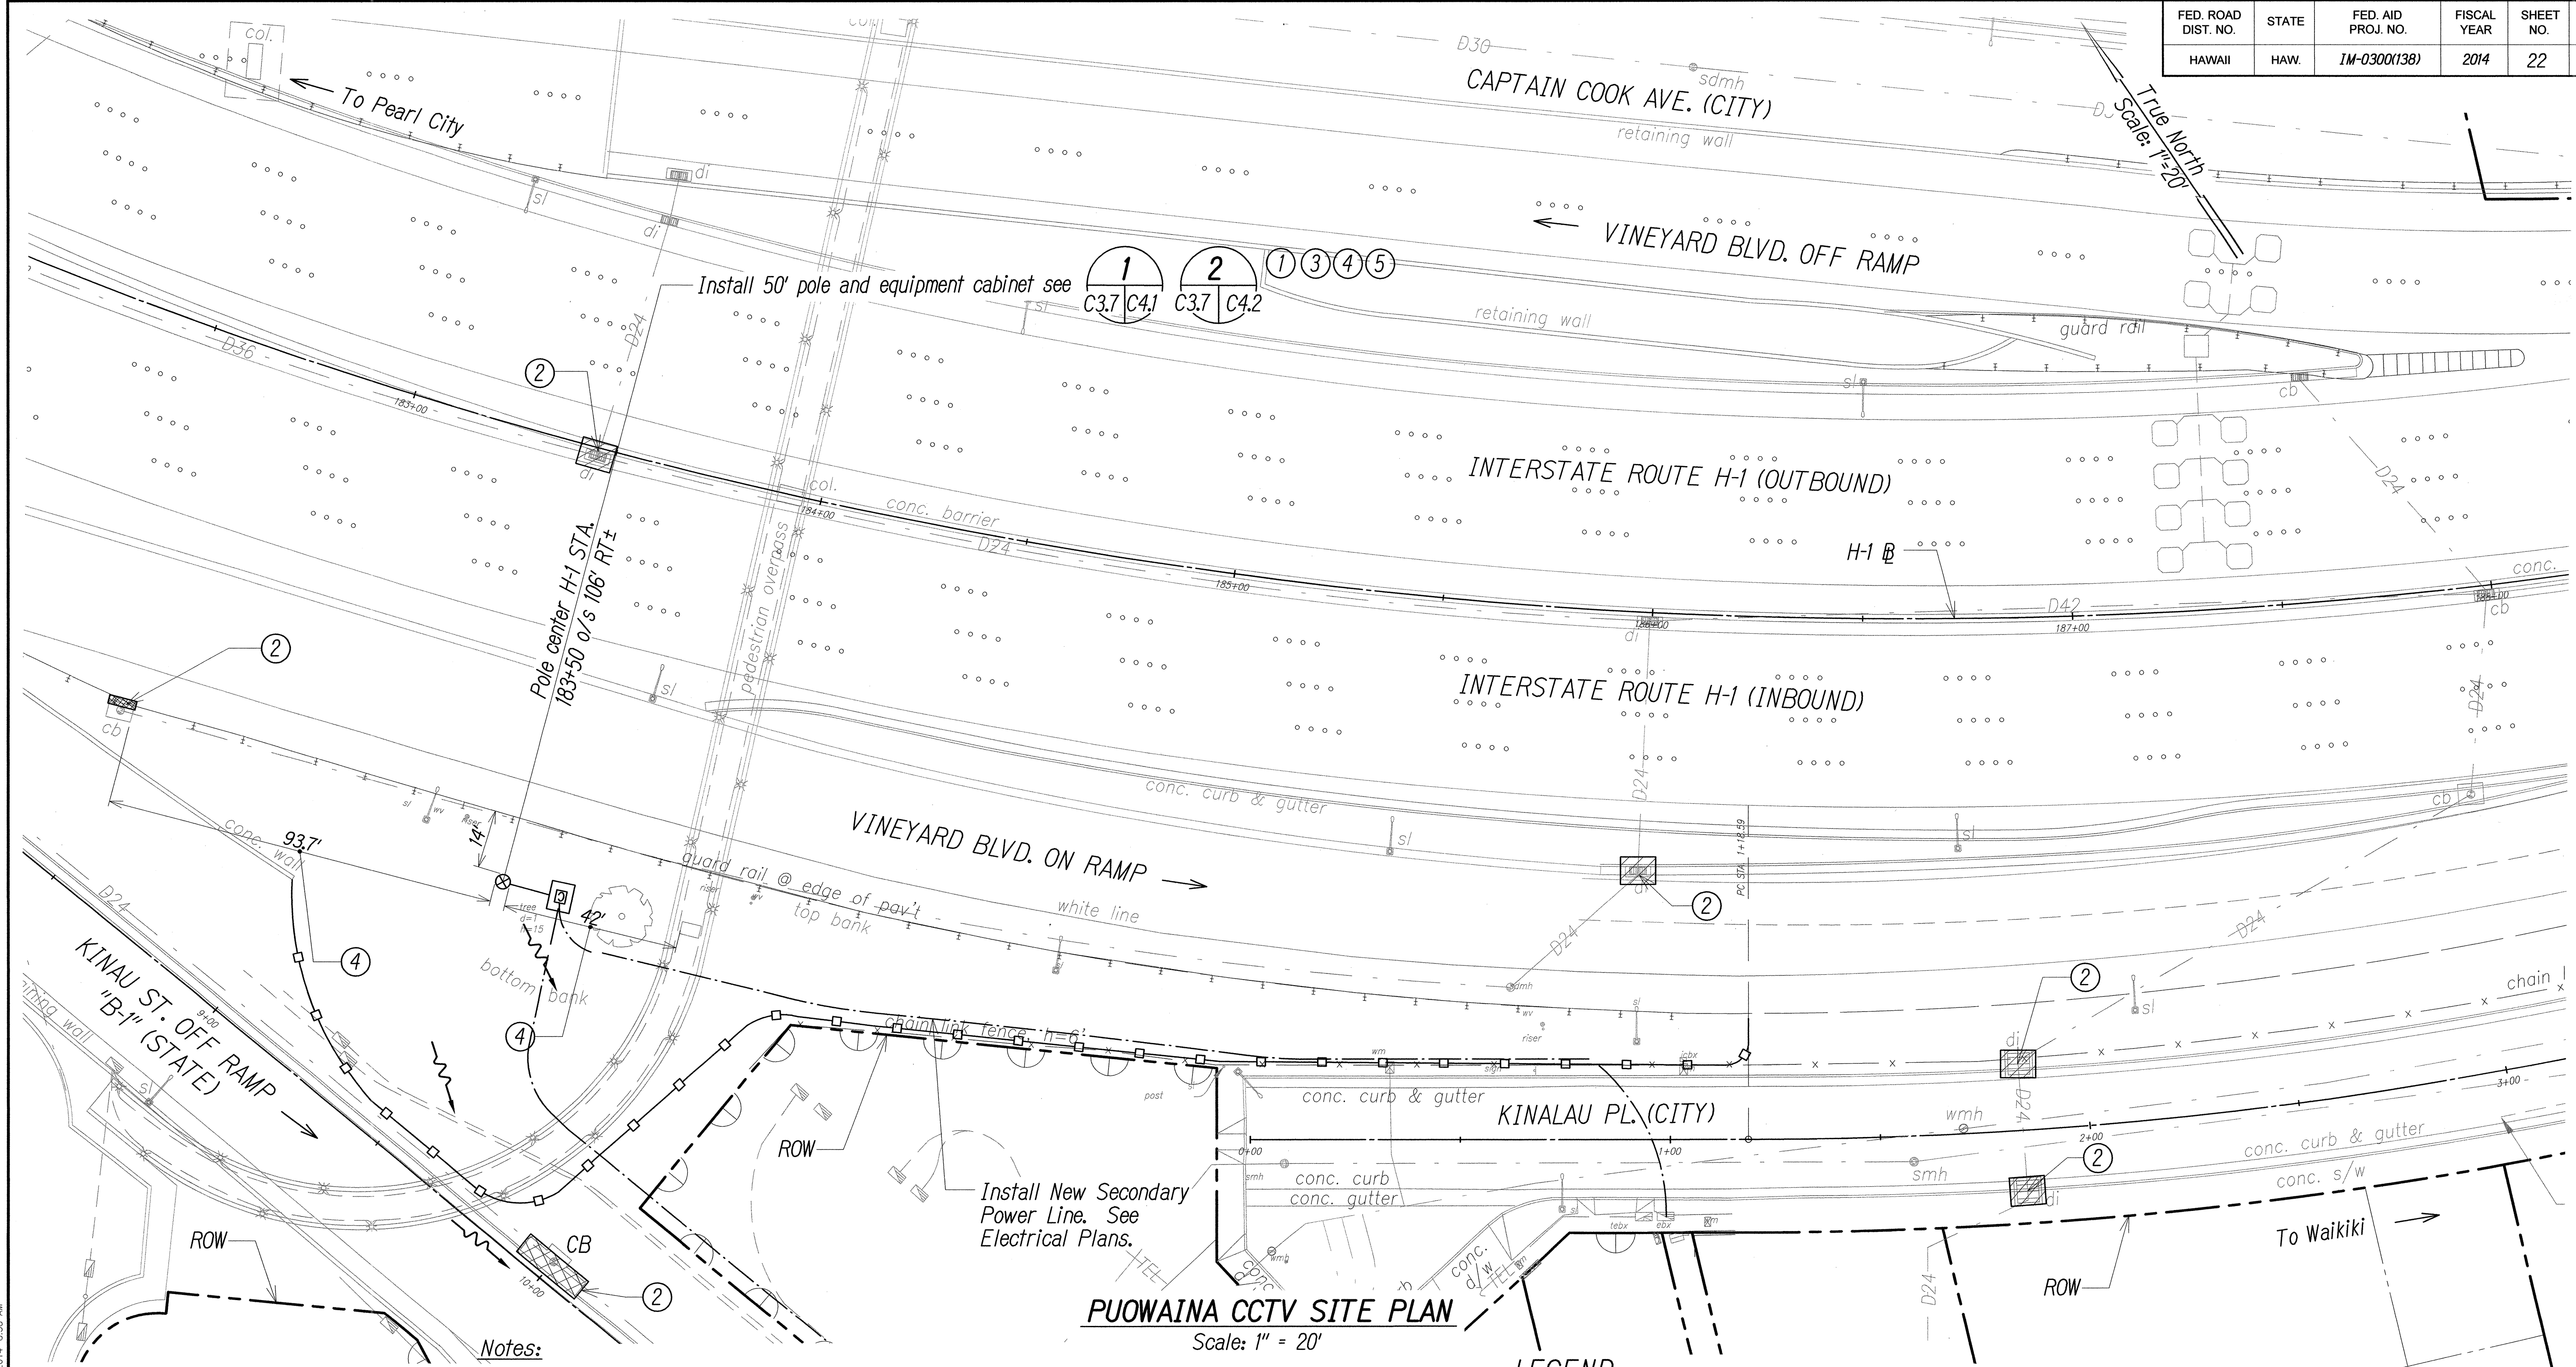

- Notes:**
- ① See Electrical Plans for electrical and communication service connections.
 - ② Exist. storm drain inlet or catch basin. Contractor to observe Best Management Practices and take measures required. Protect exist. storm drain inlets and catch basins located downstream of the project site with Best Management Practices. See Sheet C4.3 for details.
 - ③ Exist. grassed area or landscaping, Contractor to observe Best Management Practices. See detail on Sheet C4.3.
 - ④ Avoid exist. irrigation systems.
 - ⑤ See Structural Plans for details.

- LEGEND:**
- ⊗ CCTV Pole
 - Equipment Cabinet
 - Temporary Silt Fence
 - ▨ Temporary Sediment Control Filter
 - ▧ Temporary Drain Inlet Protection
 - Flow Direction

LINE IS 2 INCHES AT FULL SIZE
(if not 2 inches: scale accordingly)

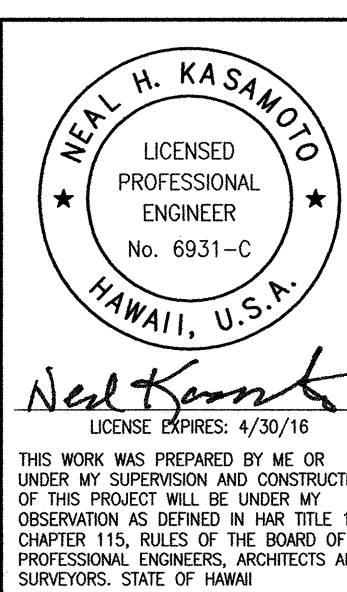

STATE OF HAWAII
DEPARTMENT OF TRANSPORTATION
HIGHWAYS DIVISION

PUOWAINA CCTV SITE PLAN

Freeway Management System, Interstate H-1, H-2 & Moanalua Freeway (H-201)
Phase 1C, Part 2
Federal Aid Project No. IM-0300(138)

Scale: 1 in. = 20' Date: 8/7/14

SURVEY PLOTTED BY	DATE
DRAWN BY	
DESIGNED BY	
CHECKED BY	
ORIGINAL PLAN	
NOTEBOOK	
No.	

FILE: 36-46-46B-4627.DWG C3.7 PUOWAINA CCTV-20 SCALE.DWG Oct 13, 2014-9:58 AM

FED. ROAD DIST. NO.	STATE	FED. AID PROJ. NO.	FISCAL YEAR	SHEET NO.	TOTAL SHEETS
HAWAII	HAW.	1M-0300(138)	2014	23	220


LEGEND:

- ⊗ CCTV Pole
- Equipment Cabinet
- Temporary Silt Fence
- ▨ Temporary Sediment Control Filter
- Flow Direction


Install 50' pole and equipment cabinet see C3.8 C4.1 C3.8 C4.2

Install New Communication and Electrical Lines. See Electrical Plans.

True North
Scale: 1"=20'

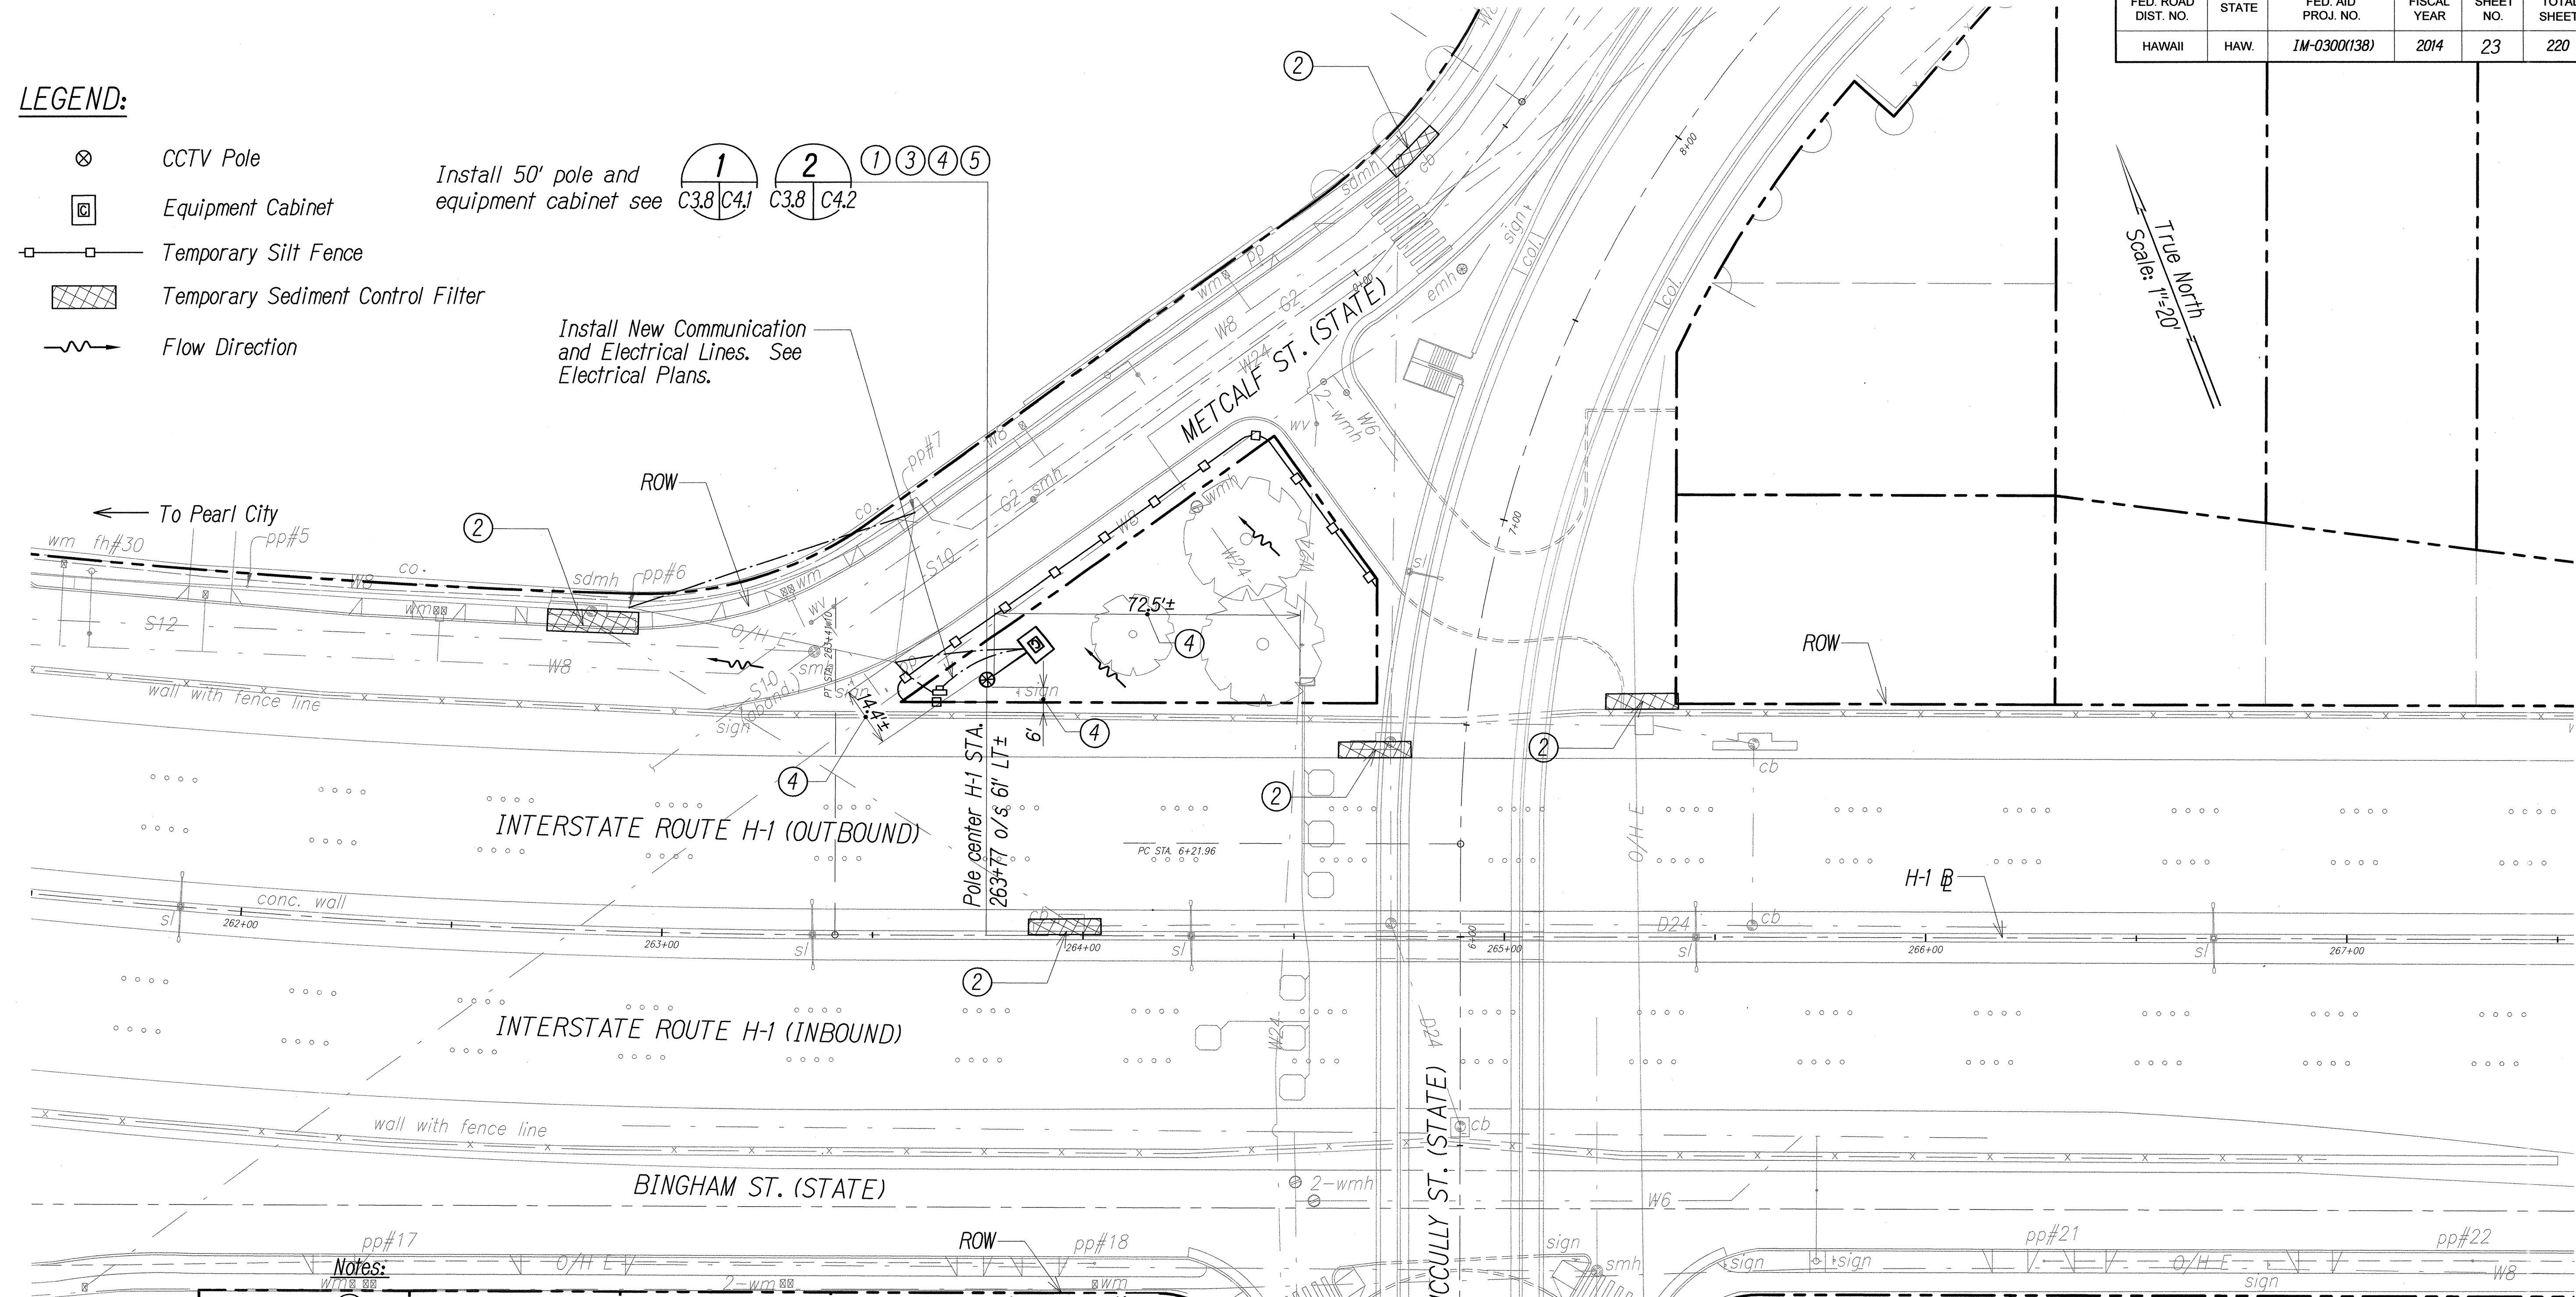


- Notes:
- ① See Electrical Plans for electrical and communication service connections.
 - ② Exist. storm drain inlet or catch basin. Contractor to observe Best Management Practices and take measures required. Protect exist. storm drain inlets and catch basins located downstream of the project site with Best Management Practices. See Sheet C4.3 for details.
 - ③ Exist. grassed area or landscaping, Contractor to observe Best Management Practices. See detail on Sheet C4.3.
 - ④ Avoid exist. irrigation systems.
 - ⑤ See Structural Plans for details.
 - ⑥ Trim trees as required, costs shall be incidental to the various contract items. Notify HDOT at least forty eight (48) hours in advance in order to contact the State landscape architect.

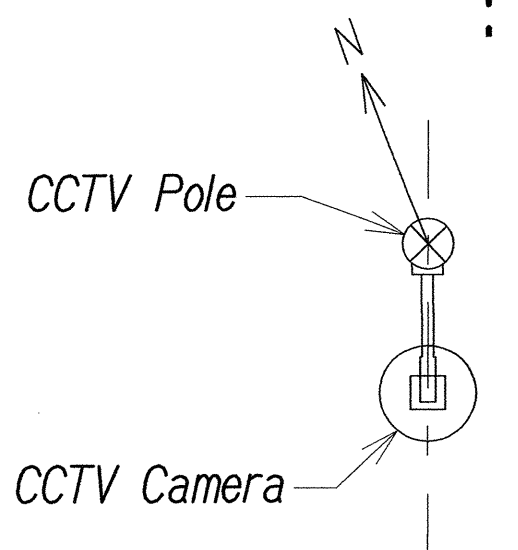

CAMERA ORIENTATION
NTS
Orient camera perpendicular to roadway

MCCULLY CCTV SITE PLAN
Scale: 1" = 20'

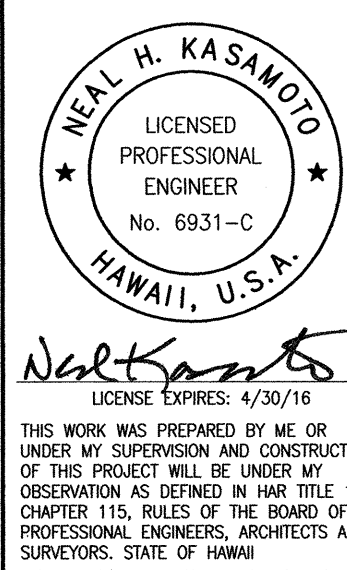

STATE OF HAWAII
DEPARTMENT OF TRANSPORTATION
HIGHWAYS DIVISION

MCCULLY CCTV SITE PLAN

Freeway Management System, Interstate H-1, H-2 & Moanalua Freeway (H-201)
Phase IC, Part 2
Federal Aid Project No. 1M-0300(138)



Scale: 1 in. = 20' Date: 8/7/14

SURVEY PLOTTED BY	DATE
DRAWN BY	
DESIGNED BY	
QUANTITIES BY	
CHECKED BY	
ORIGINAL PLAN	
NOTEBOOK	
NO.	

PKA\96-46-46-96-46-27.DWG C3.8 MCCULLY CCTV-20 SCALE DWG Oct 13, 2014-10:19 AM

LINE IS 2 INCHES AT FULL SIZE
(if not 2 inches: scale accordingly)

FED. ROAD DIST. NO.	STATE	FED. AID PROJ. NO.	FISCAL YEAR	SHEET NO.	TOTAL SHEETS
HAWAII	HAW.	1M-0300(138)	2014	24	220

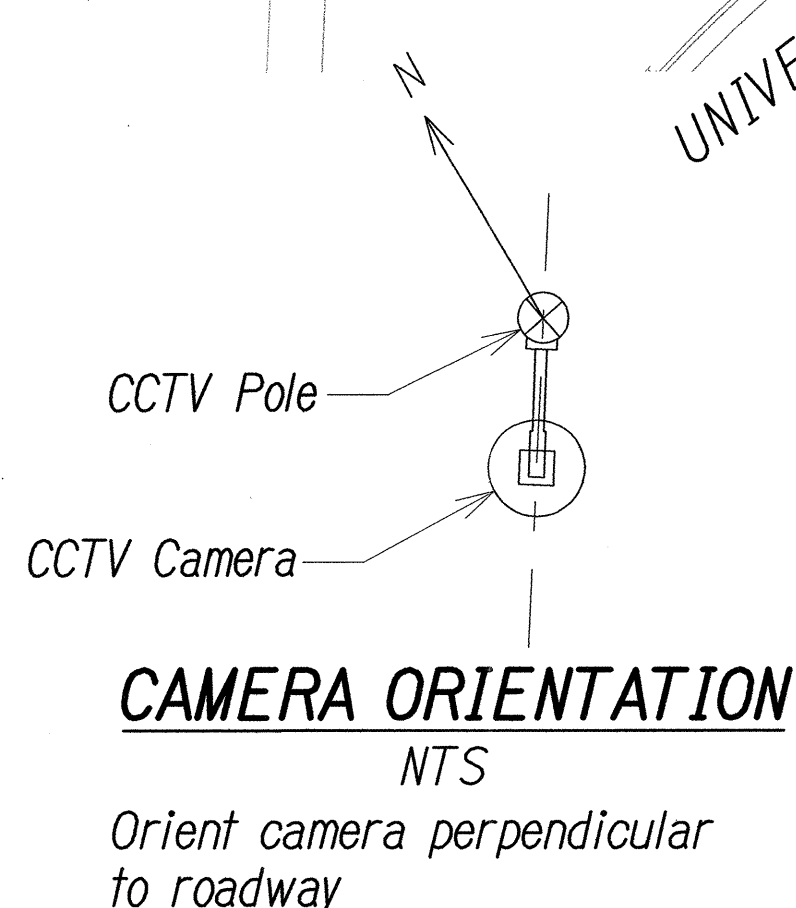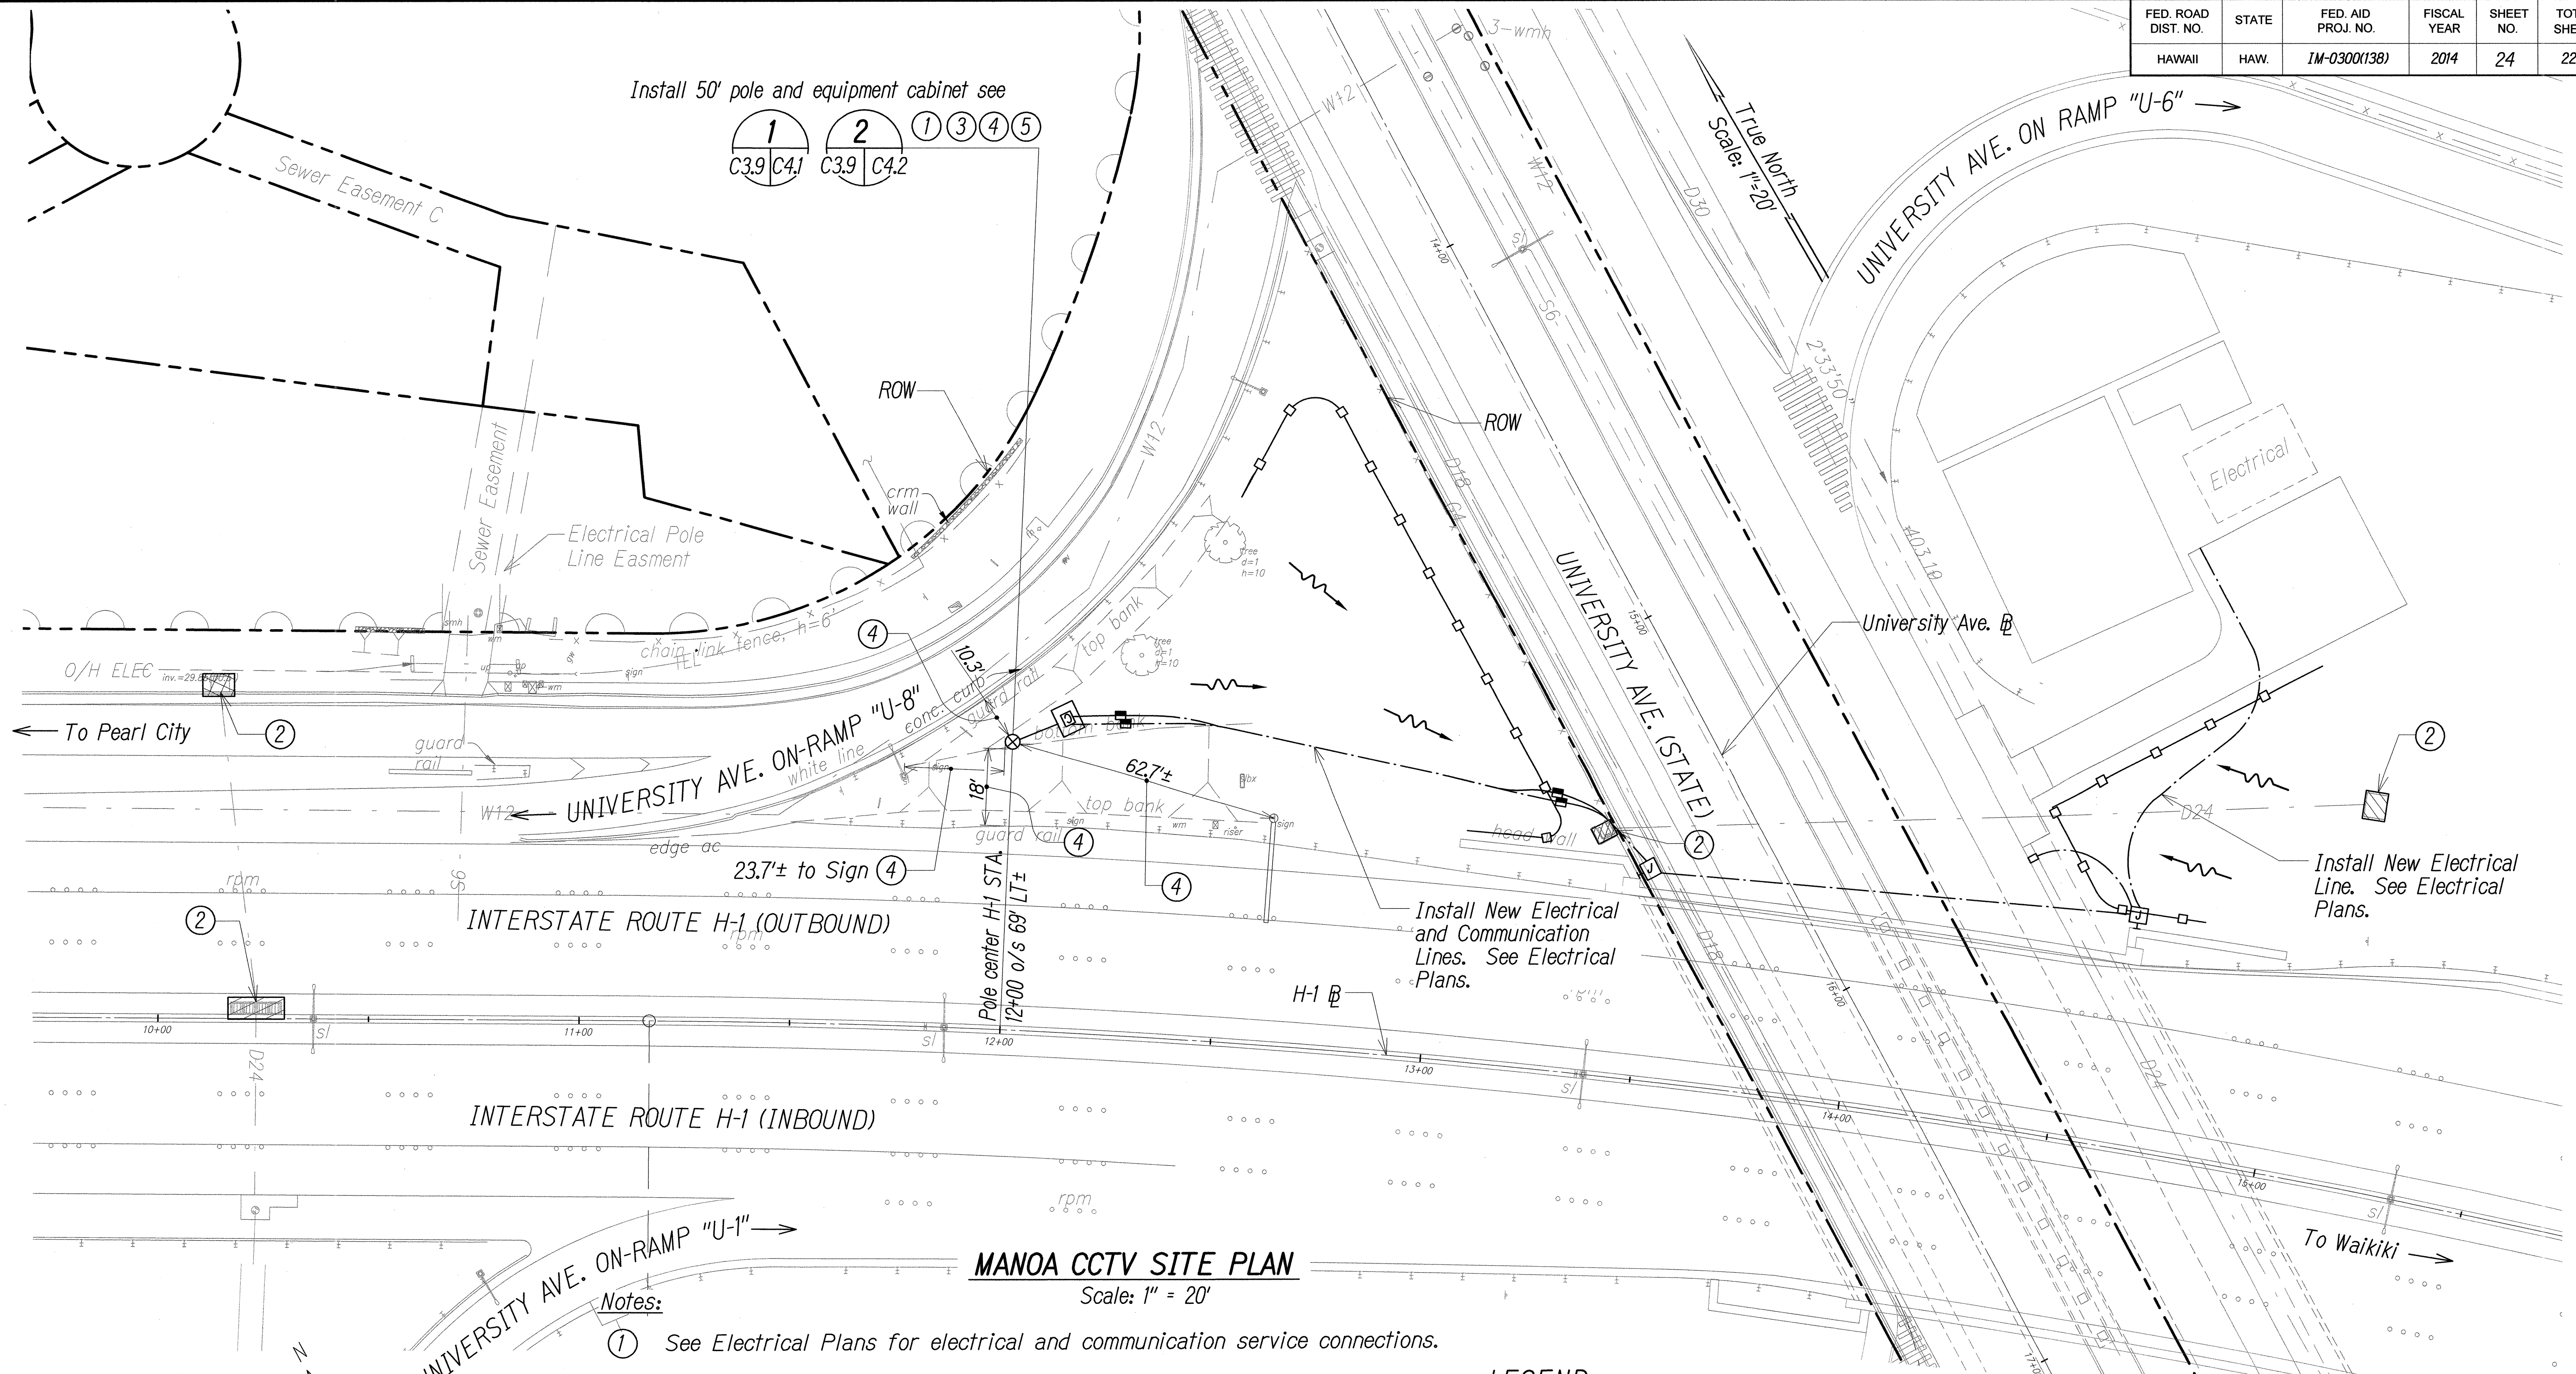

SURVEY PLOTTED BY	DATE
DRAWN BY	
DESIGNED BY	
QUANTITIES BY	
CHECKED BY	
ORIGINAL PLAN	
NOTED	
NO.	

FILE: 96-46-96-46-27.DWG C3.9 MANOA CCTV-20 SCALE.DWG Oct 13, 2014-9:00 AM

NEAL H. KASAMOTO
LICENSED PROFESSIONAL ENGINEER
No. 6931-C
HAWAII, U.S.A.
LICENSE EXPIRES: 4/30/16

STATE OF HAWAII
DEPARTMENT OF TRANSPORTATION
HIGHWAYS DIVISION

MANOA CCTV SITE PLAN

Freeway Management System, Interstate H-1, H-2 & Moanalua Freeway (H-201)
Phase 1C, Part 2
Federal Aid Project No. 1M-0300(138)

Scale: 1 in. = 20' Date: 8/7/14

SHEET No. C3.9 OF 9 SHEETS