

INDEX TO DRAWINGS	
SHEET NO.	DESCRIPTION
1	TITLE SHEET
2	STATE STANDARD PLAN SUMMARY
3-9	CONSTRUCTION NOTES & ABBREVIATIONS
10-11	LOCATION PLANS
12-15	VMS SITE PLANS
16-24	CCTV SITE PLANS
25-30	DETAILS
31-35	BMP SITE PLANS
36-62	COMMUNICATIONS PLANS
63-108	ELECTRICAL PLANS
109-162	STRUCTURAL PLANS
163-192	VMS TRAFFIC CONTROL PLAN
193-217	CCTV TRAFFIC CONTROL PLAN
218-220	STREET NAME SIGNS & DETAILS

STATE OF HAWAII

DEPARTMENT OF TRANSPORTATION

HIGHWAYS DIVISION

HONOLULU, HAWAII

"AS-BUILT" PLANS FOR

FREEWAY MANAGEMENT SYSTEM

INTERSTATE H-1, H-2 AND MOANALUA FREEWAY (H-201)



PHASE 1C, PART 2

FEDERAL-AID PROJECT NO. IM-0300(138)

DISTRICTS OF HONOLULU & EWA

ISLAND OF OAHU

FED. ROAD DIST. NO.	STATE	FEDERAL AID PROJ. NO.	FISCAL YEAR	SHEET NO.	TOTAL SHEETS
HAWAII	HAW.	IM-0300(138)	2014	1	220

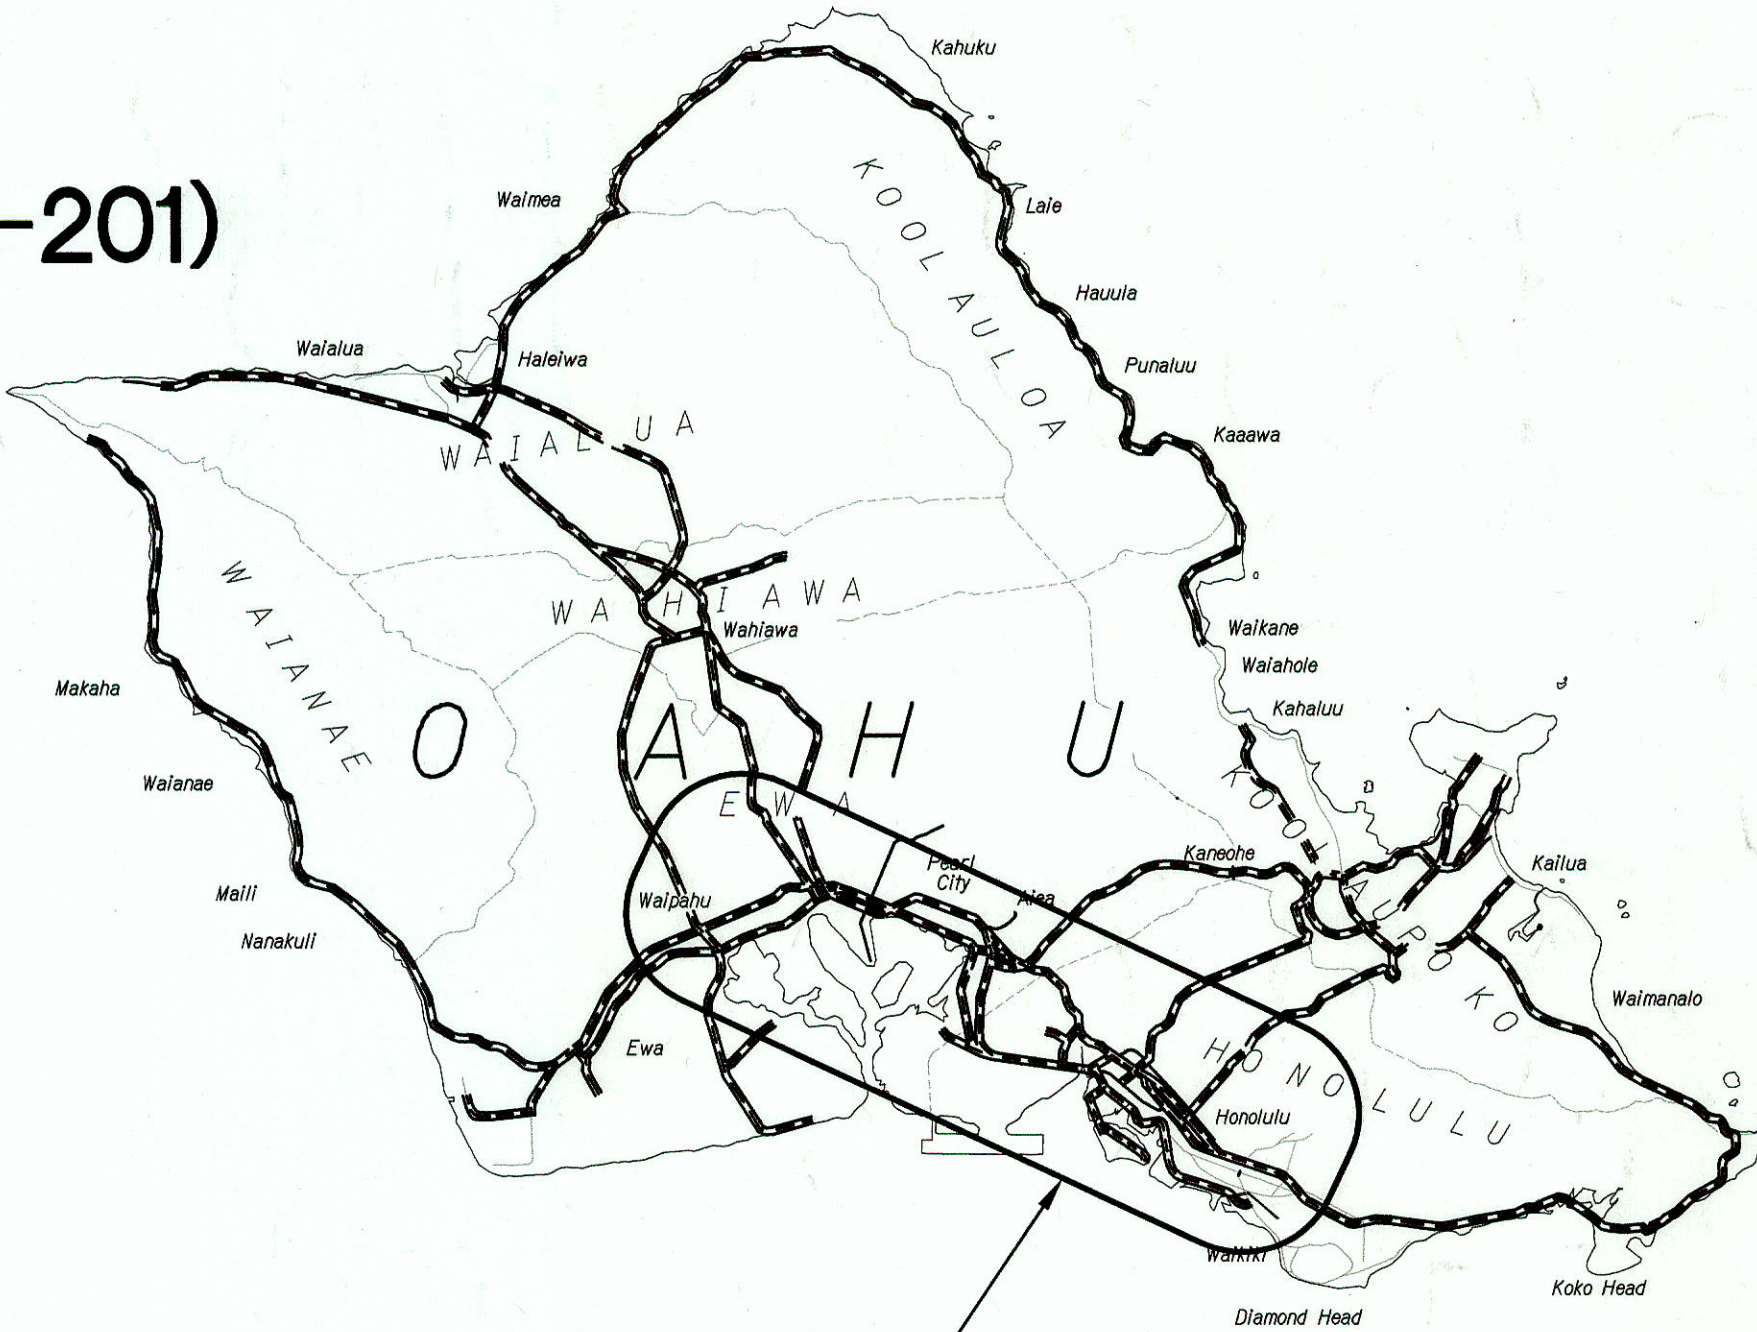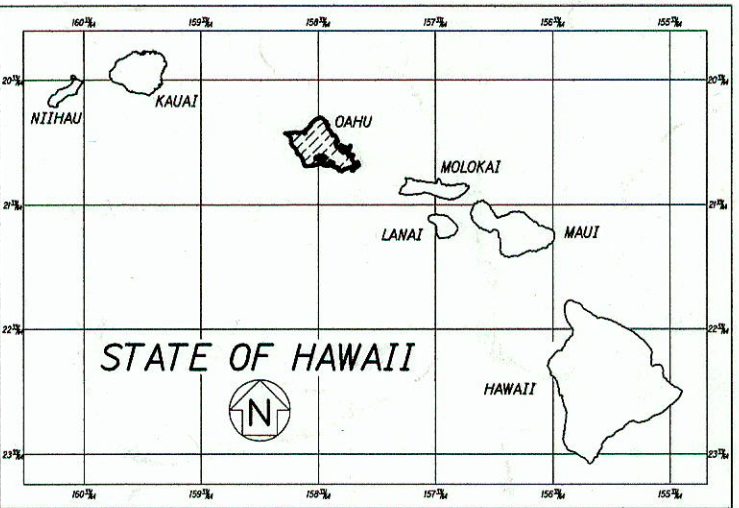

SCALE IN MILES

PROJECT LOCATION

FEDERAL AID PROJECTS PREVIOUSLY CONSTRUCTED OR UNDER CONSTRUCTION



H-1	MILE POST	7.08	TO	MILE POST	27.08
H-2	MILE POST	1.70	TO	MILE POST	1.80
H-201	MILE POST	2.94	TO	MILE POST	3.00

CHANGES MADE DURING CONSTRUCTION HAVE BEEN INCORPORATED ON THESE PLANS EXCEPT CHANGES IN THE ORIGINAL THEORETICAL QUANTITIES. FOR ACTUAL QUANTITIES, REFER TO PROJECT LEDGER AND/OR COMPUTATION BOOK.

RESIDENT ENGINEER 12/6/20 DATE

DEPARTMENT OF TRANSPORTATION
STATE OF HAWAII

APPROVED: *Amir A. J. Alarid* 9/10/14
for DIR. OF TRANSPORTATION DATE

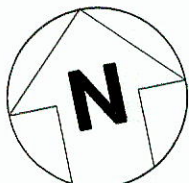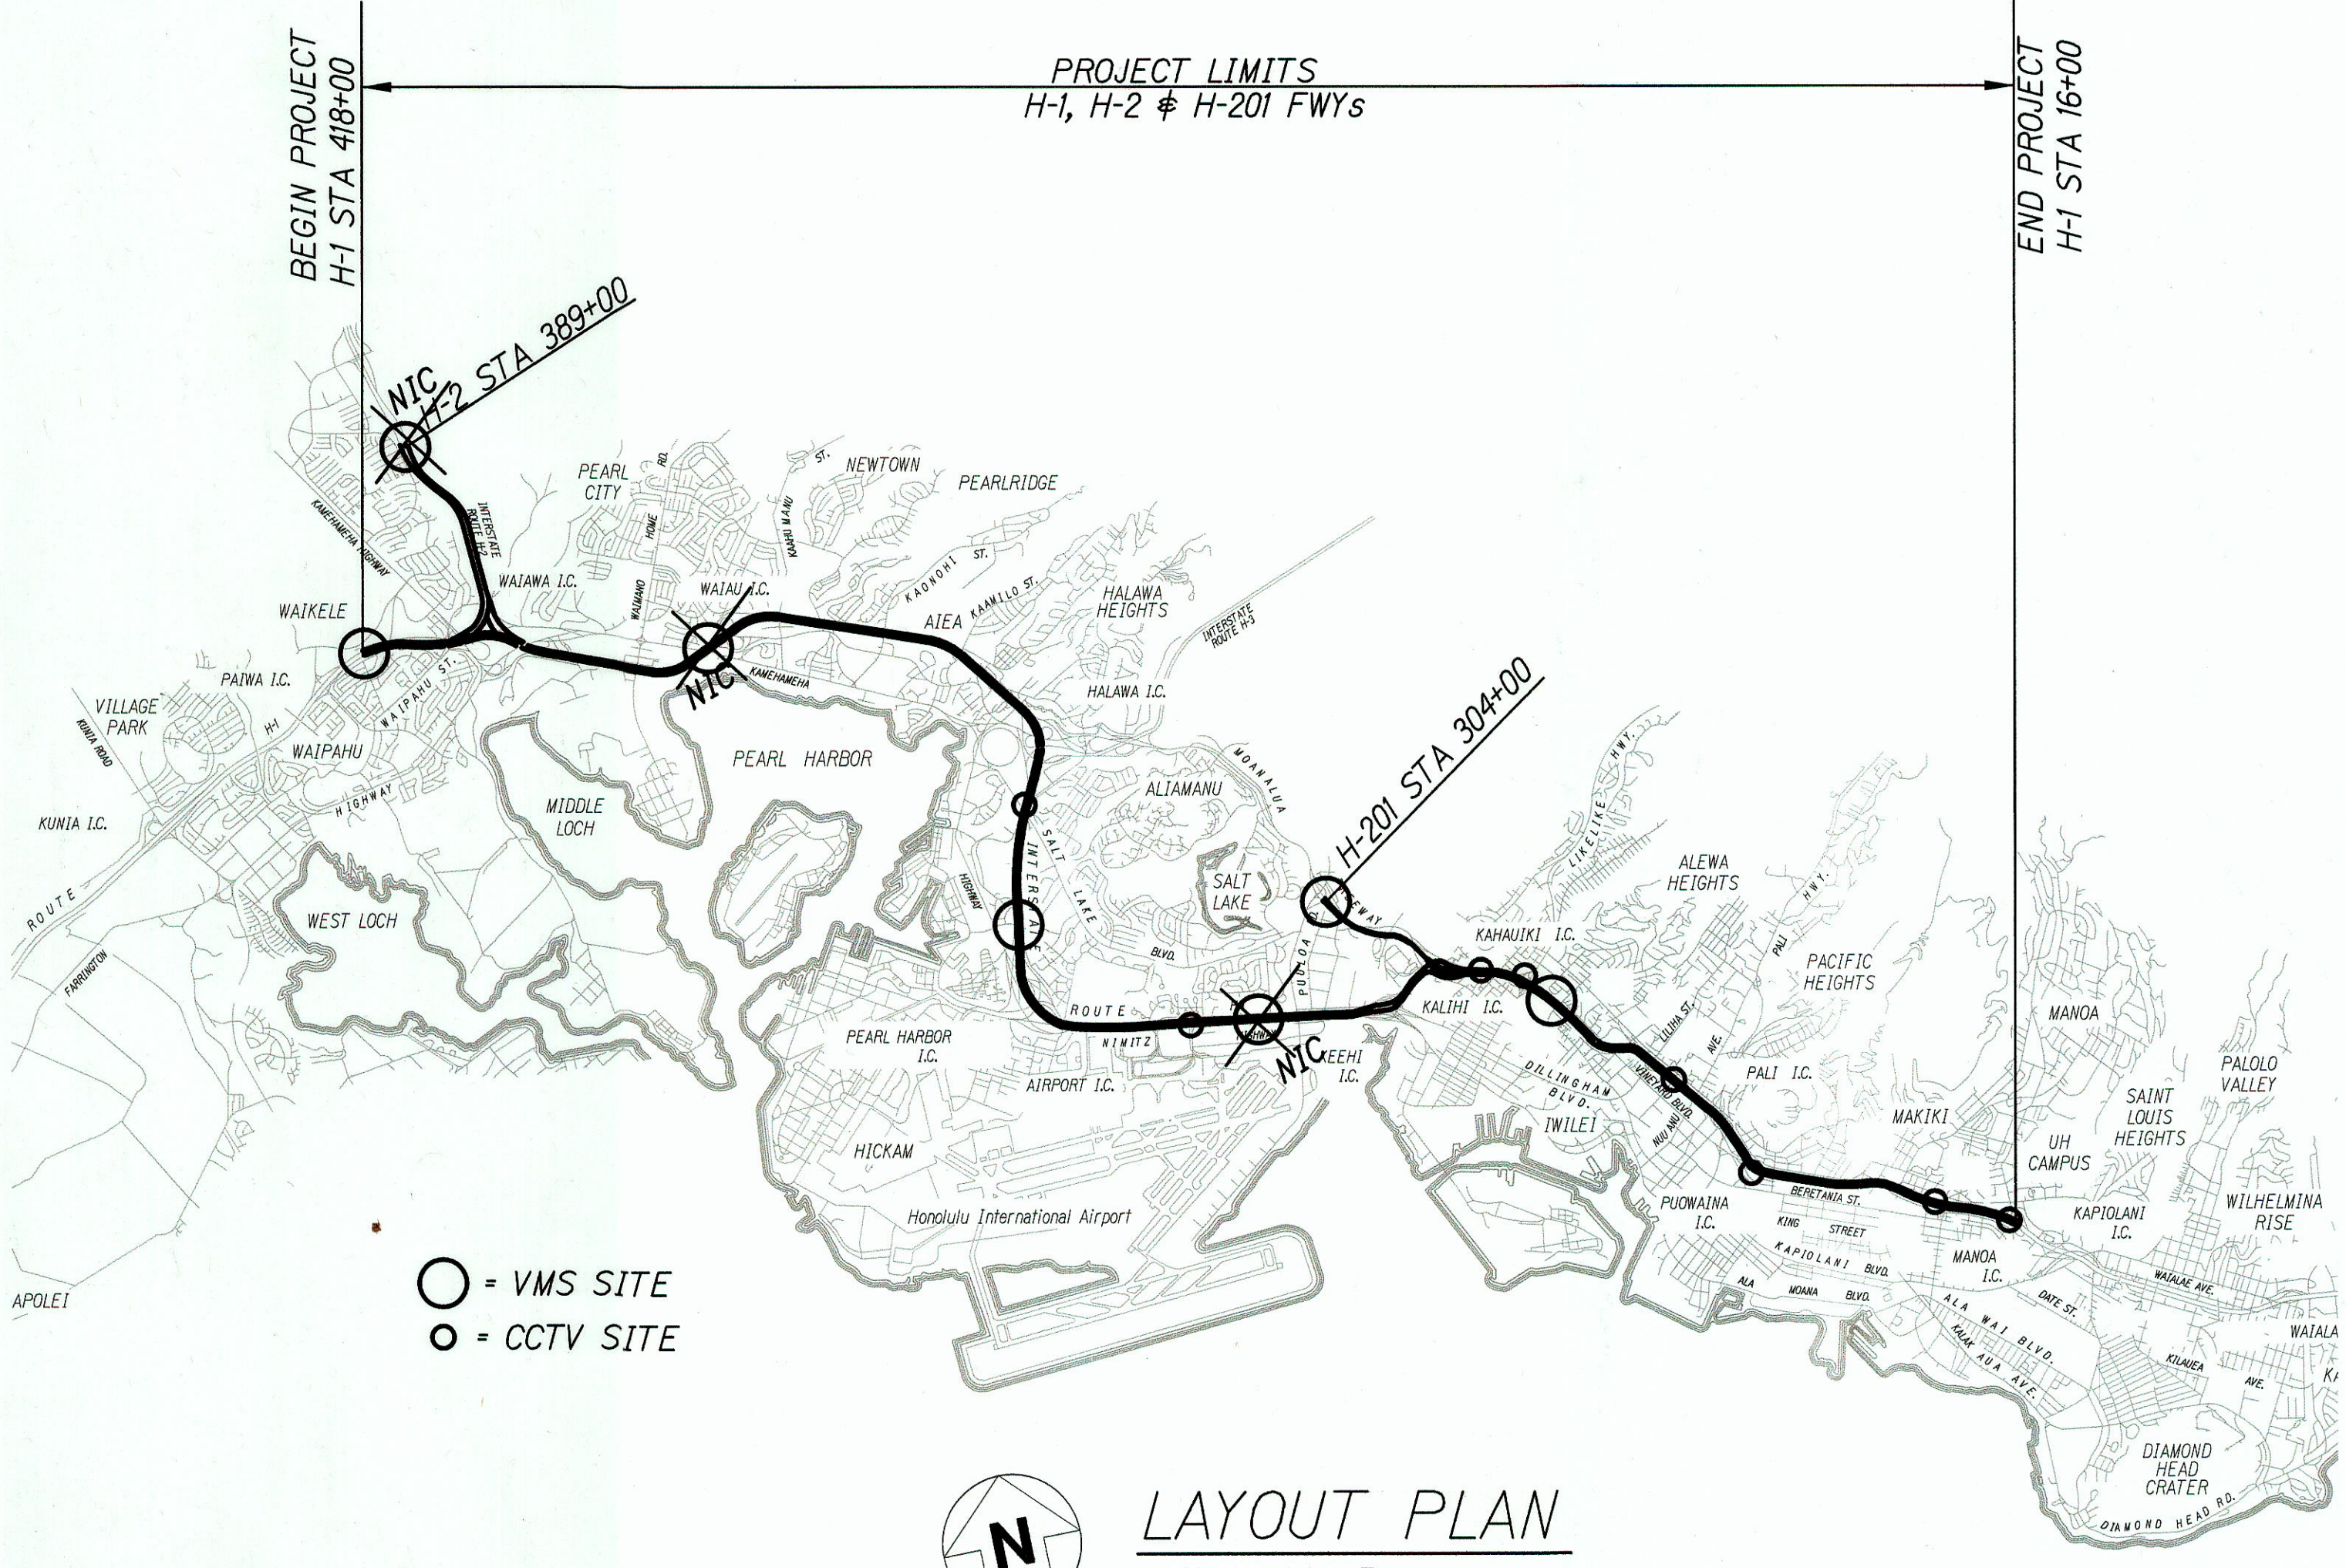

LAYOUT PLAN
NOT TO SCALE

SURVEY PLOTTED BY	DATE
DRAWN BY	
DESIGNED BY	
QUANTITIES BY	
CHECKED BY	
NO.	

X:\96-46\96-46.27\DWG\T-1 TITLE SHT.DWG Aug 21, 2014-11:08 AM

ATA DESIGNED BY _____ HWY-TO _____ P. S. & E. BY _____ PHONE _____ DATE _____