


DIST. NO.	STATE	PROJ. NO.	FISCAL YEAR	SHEET NO.	TOTAL SHEETS
OAHU	HAW.	NH-0300(160)	2018	15	186

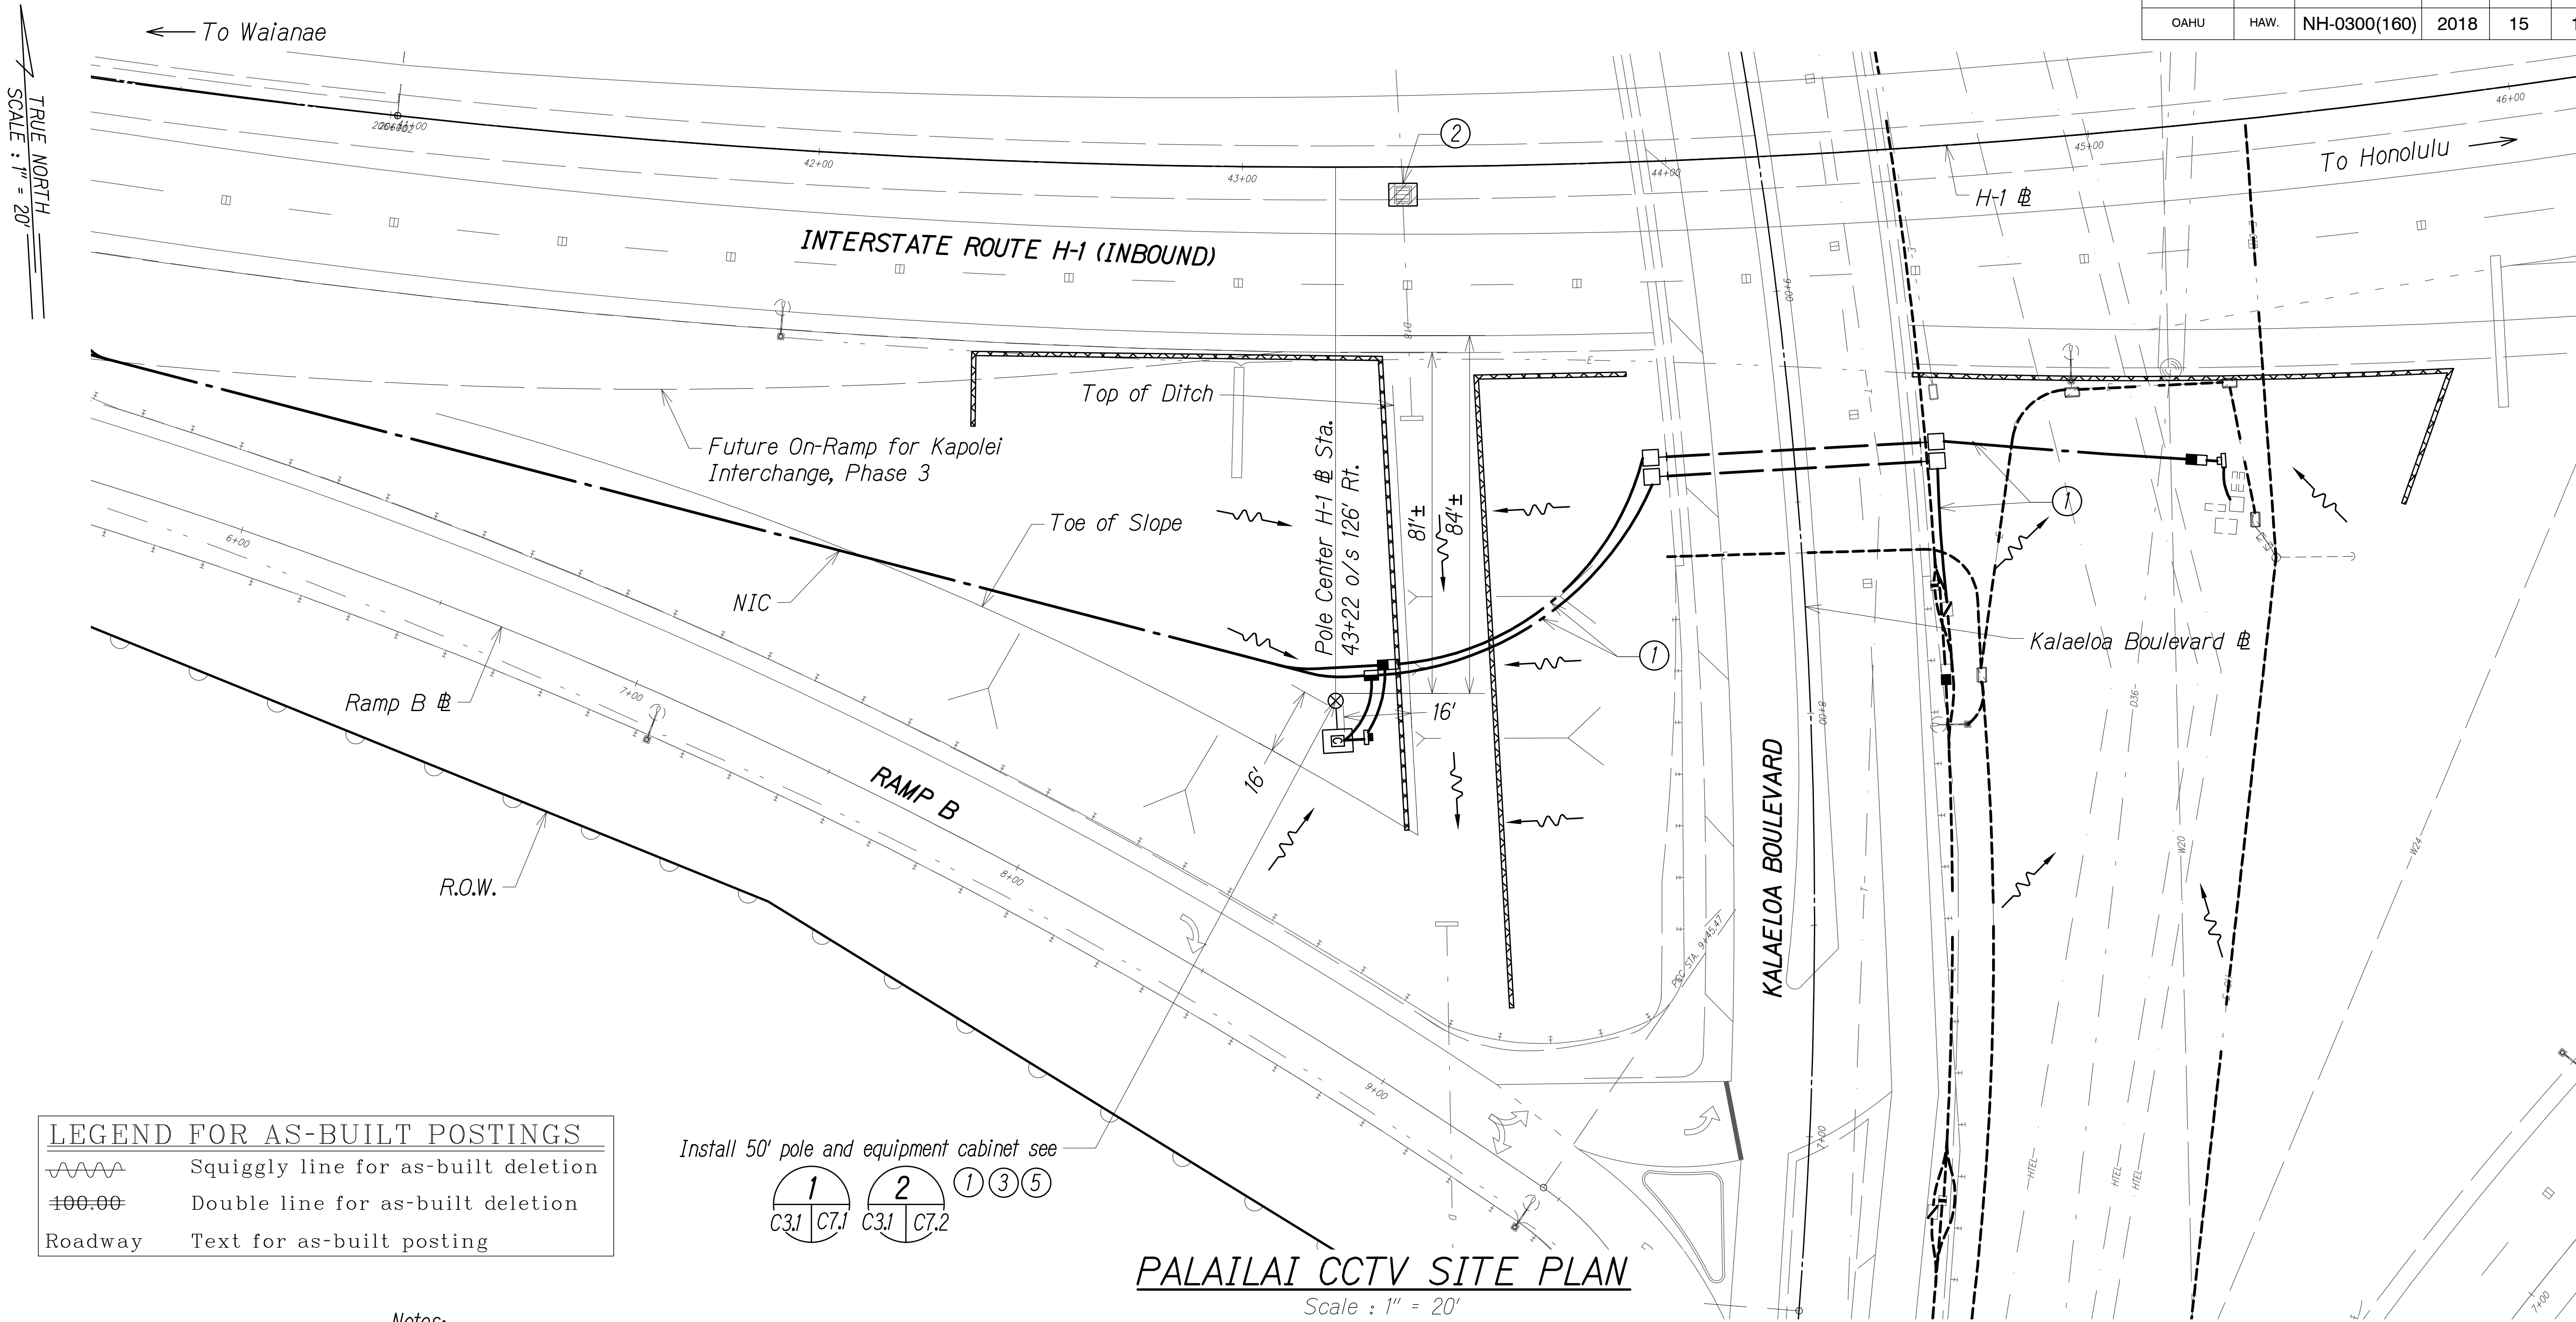

LEGEND FOR AS-BUILT POSTINGS	
	Squiggly line for as-built deletion
	Double line for as-built deletion
Roadway	Text for as-built posting

Install 50' pole and equipment cabinet see


C3.1 C7.1
C3.1 C7.2
1 3 5

PALAILAI CCTV SITE PLAN
Scale : 1" = 20'

- Notes:**
- ① See Electrical Plans for electrical and communication service connections.
 - ② Exist. storm drain inlet or catch basin. Contractor to observe Best Management Practices and take measures required. Protect exist. storm drain inlets and catch basins located downstream of the project site with Best Management Practices. See details on Sheet C7.9
 - ③ Exist. grassed area or landscaping, Contractor to observe Best Management Practices. See detail on Sheet C7.9
 - ④ Avoid exist. irrigation systems.
 - ⑤ See Structural Plans for details.

LEGEND:

- CCTV Pole
 - Equipment Cabinet
 - Temporary Fiber Roll
 - Temporary Sediment Control Filter
 - Flow Direction
- LINE IS 2 INCHES AT FULL SIZE
(if not 2 inches scale accordingly)

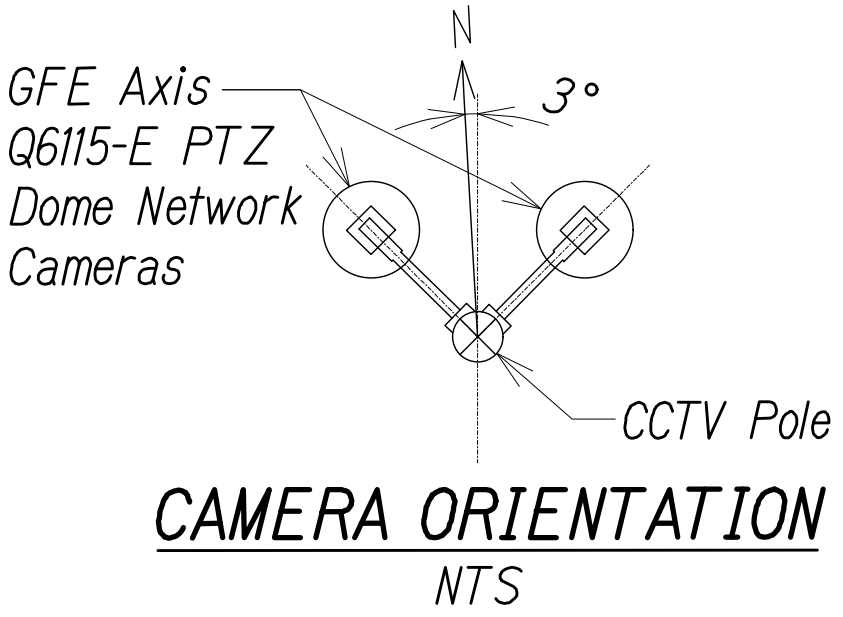

NEAL H. KASAMOTO
LICENSED PROFESSIONAL ENGINEER
No. 6931-C
HAWAII, U.S.A.

THIS WORK WAS PREPARED BY ME OR UNDER MY SUPERVISION AND CONSTRUCTION OF THIS PROJECT WILL BE UNDER MY OBSERVATION AS DEFINED IN H.A.R. TITLE 16, CHAPTER 115, RULES OF THE BOARD OF PROFESSIONAL ENGINEERS, ARCHITECTS AND SURVEYORS, STATE OF HAWAII.

Neal Kasamoto
APRIL 30, 2020
LIC. EXP. DATE

STATE OF HAWAII
DEPARTMENT OF TRANSPORTATION
HIGHWAYS DIVISION

PALAILAI CCTV SITE PLAN

*Freeway Management System
Phase 2*

Federal Aid Project No. NH-0300(160)


Scale: As Shown Date: June 29, 2018

SHEET No. C3.1 OF 25 SHEETS

DESIGNED BY	DATE
TRACED BY	
QUANTITIES BY	
CHECKED BY	
ORIGINAL PLAN	
NOTE BOOK	
No.	


PNV\2016\16-160\ENGINEERING\DWG\C3.1 PALAILAI CCTV.DWG Jun 16, 2022-1:12 PM

DIST. NO.	STATE	PROJ. NO.	FISCAL YEAR	SHEET NO.	TOTAL SHEETS
OAHU	HAW.	NH-0300(160)	2018	16	186

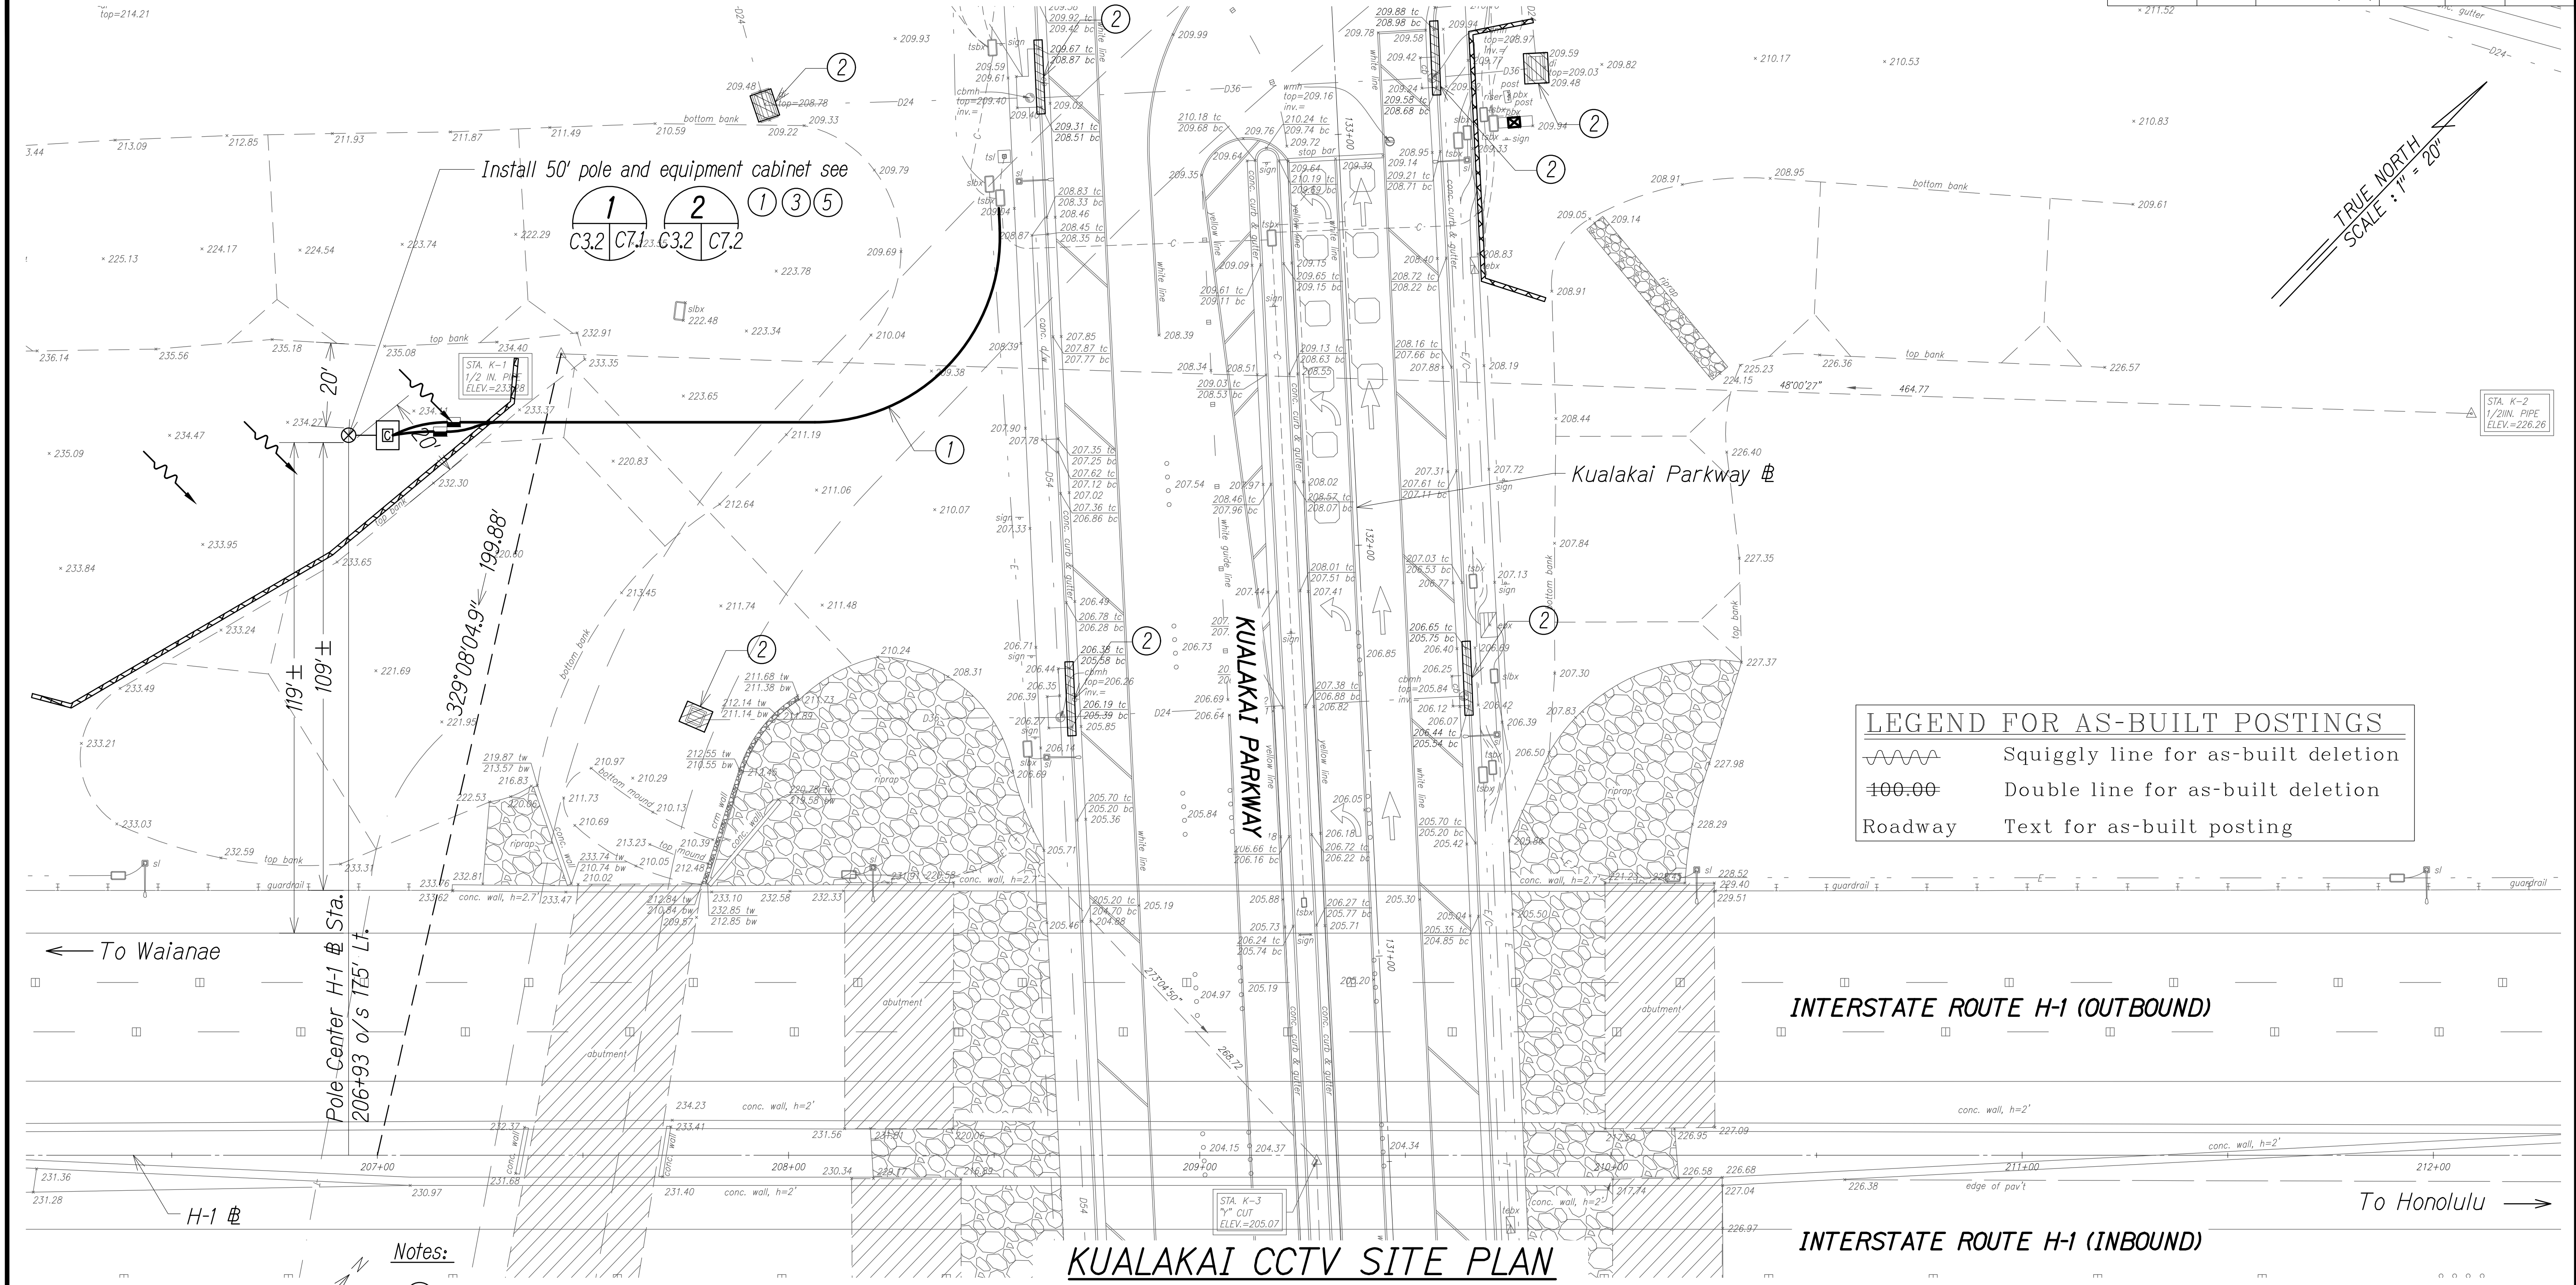

LEGEND FOR AS-BUILT POSTINGS	
	Squiggly line for as-built deletion
	Double line for as-built deletion
Roadway	Text for as-built posting

- Notes:
- ① See Electrical Plans for electrical and communication service
 - ② Exist. storm drain inlet or catch basin. Contractor to observe Best Management Practices and take measures required. Protect exist. storm drain inlets and catch basins located downstream of the project site with Best Management Practices. See details on Sheet C7.9
 - ③ Exist. grassed area or landscaping, Contractor to observe Best Management Practices. See detail on Sheet C7.9
 - ④ Avoid exist. irrigation systems.
 - ⑤ See Structural Plans for details.

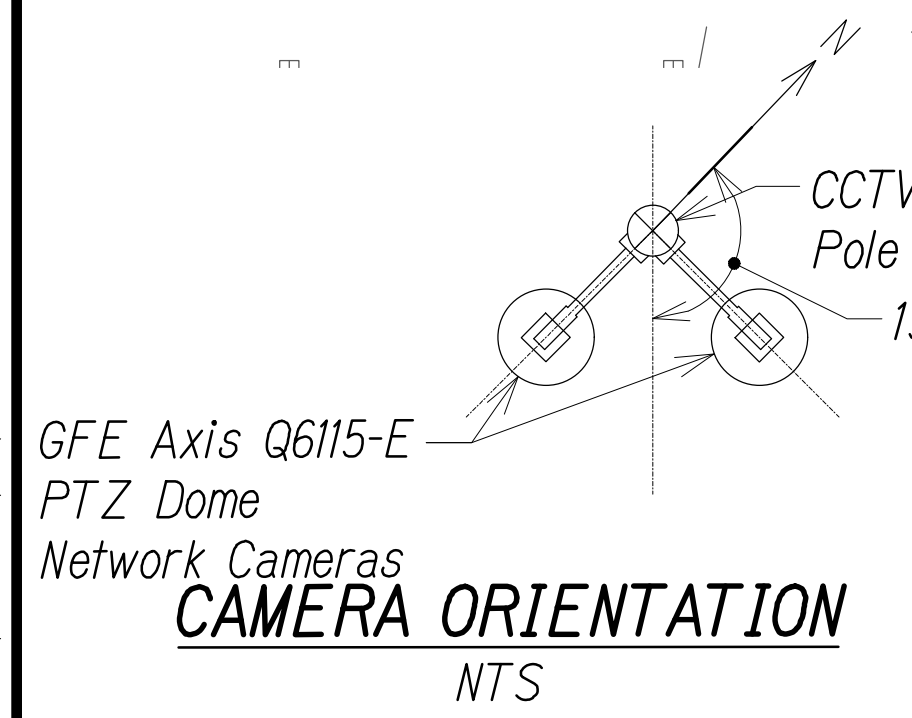

KUALAKAI CCTV SITE PLAN
Scale : 1" = 20'

LEGEND:	
	CCTV Pole
	Equipment Cabinet
	Temporary Fiber Roll
	Temporary Sediment Control Filter
	Flow Direction

LINE IS 2 INCHES AT FULL SIZE
(if not 2 inches: scale accordingly)

NEAL H. KASAMOTO
LICENSED PROFESSIONAL ENGINEER
No. 6931-C
HAWAII, U.S.A.
THIS WORK WAS PREPARED BY ME OR UNDER MY SUPERVISION AND CONSTRUCTION OF THIS PROJECT WILL BE UNDER MY OBSERVATION AS DEFINED IN HAWAII TITLE 16, CHAPTER 115, RULES OF THE BOARD OF PROFESSIONAL ENGINEERS, ARCHITECTS AND SURVEYORS, STATE OF HAWAII
APRIL 30, 2020
LIC. EXP. DATE

STATE OF HAWAII
DEPARTMENT OF TRANSPORTATION
HIGHWAYS DIVISION

KUALAKAI CCTV SITE PLAN

Freeway Management System
Phase 2
Federal Aid Project No. NH-0300(160)

Scale: As Shown Date: June 29, 2018

SHEET No. C3.2 OF 25 SHEETS

ORIGINAL PLAN	DATE
TRACED BY	
DESIGNED BY	
QUANTITIES BY	
CHECKED BY	
No.	

REV: 1/2016, 1/2018, 1/2019, 1/2020, 1/3378,

