


| INDEX TO DRAWINGS | |
|-------------------|------------------------------------|
| SHEET NO. | DESCRIPTION |
| 1 | TITLE SHEET |
| 2 | STATE STANDARD PLAN SUMMARY |
| 3 - 9 | CONSTRUCTION NOTES & ABBREVIATIONS |
| 10 - 12 | LOCATION PLANS |
| 13 - 14 | VMS SITE PLANS |
| 15 - 17 | CCTV SITE PLANS |
| 18 - 19 | SPEED READER SITE PLANS |
| 20 - 25 | CONDUIT BMP'S |
| 26 - 34 | DETAILS |
| 35 - 65 | COMMUNICATIONS PLANS |
| 66 - 126 | ELECTRICAL PLANS |
| 127 - 156 | STRUCTURAL PLANS |
| 157 - 159 | TRAFFIC CONTROL LOCATION MAPS |
| 160 - 186 | TRAFFIC CONTROL PLANS |

STATE OF HAWAII
DEPARTMENT OF TRANSPORTATION
HIGHWAYS DIVISION
HONOLULU, HAWAII
"AS-BUILT"
FREEWAY MANAGEMENT SYSTEM
INTERSTATE H-1, FARRINGTON HIGHWAY (RTE 93),
KAMEHAMEHA HIGHWAY (RTE 83), PALI AND
KALANIANA'OLE HIGHWAY (RTE 61)
PHASE 2
FEDERAL-AID PROJECT NO. NH-0300(160)
DISTRICTS OF HONOLULU, EWA & KOOLAUPOKO
ISLAND OF OAHU

| FED. ROAD DIST. NO. | STATE | FED. AID PROJ. NO. | FISCAL YEAR | SHEET NO. | TOTAL SHEETS |
|---------------------|-------|--------------------|-------------|-----------|--------------|
| OAHU | HAW. | NH-0300(160) | 2018 | 1 | 186 |

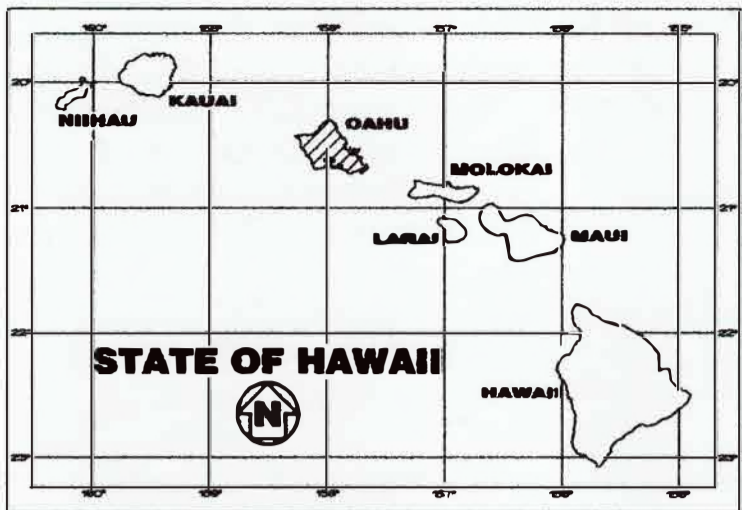


CHANGES HAVE BEEN MADE DURING CONSTRUCTION
HAVE BEEN NOTED ON THESE PLANS AND CHECKED BY:

RESIDENT ENGINEER

Apr 4, 2022

DATE

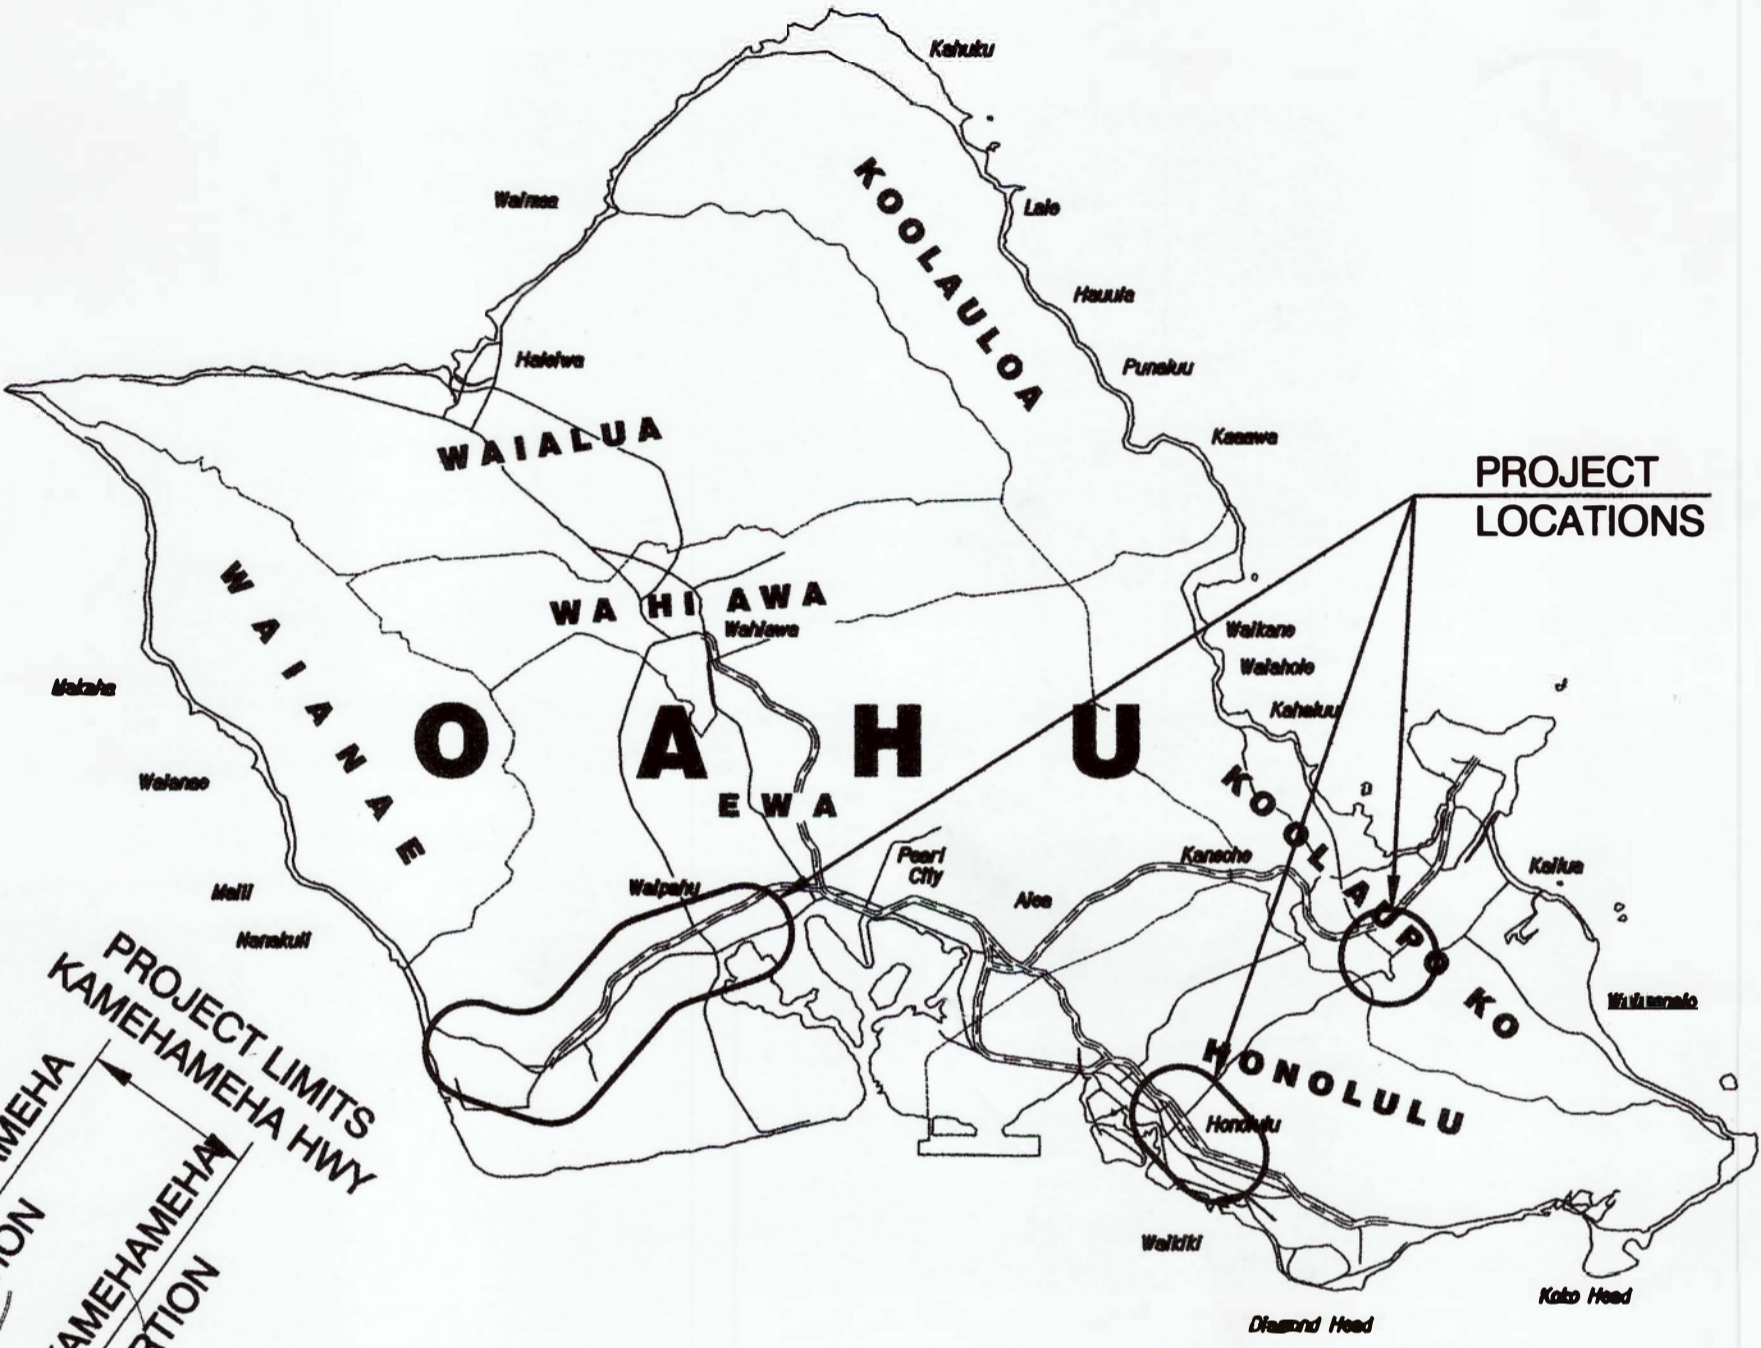

AS-BUILT DRAWINGS

DEC 14 2021

WASA ELECTRICAL SERVICES, INC.

PROJECT LIMITS
PALI/KALANIANA'OLE HWY
FEDERAL AID PROJECTS PREVIOUSLY CONSTRUCTED
OR UNDER CONSTRUCTION

H-1 MILE POST 0.00 TO MILE POST 5.50
MILE POST 21.20 TO MILE POST 22.00

FARRINGTON HWY.
(RTE 93) MILE POST 0.00 TO MILE POST 2.50

KAMEHAMEHA HWY.
(RTE 83) MILE POST 43.00 TO MILE POST 43.90

PALI/KALANIANA'OLE HWY.
(RTE 61) MILE POST 7.50 TO MILE POST 8.00

DEPARTMENT OF TRANSPORTATION
STATE OF HAWAII

APPROVED:

Director of Transportation

3/27/18
DATE

LAYOUT PLAN



| | |
|---------------|------|
| ORIGINAL PLAN | DATE |
| NOTED BY | |
| DESIGNED BY | |
| CHECKED BY | |
| NO. | |

FWY 2018-16-048 ENGINEERING DWG-T-1 TITLE SHEET DWG Jun 25, 2018-2:01 PM

Austin Tsutsumi and Associates, Inc. HWY-TO JUNE 2018
MANAGED BY PHONE DATE