


DIST. NO.	STATE	PROJ. NO.	FISCAL YEAR	SHEET NO.	TOTAL SHEETS
OAHU	HAW.	NH-0300(160)	2018	14	186

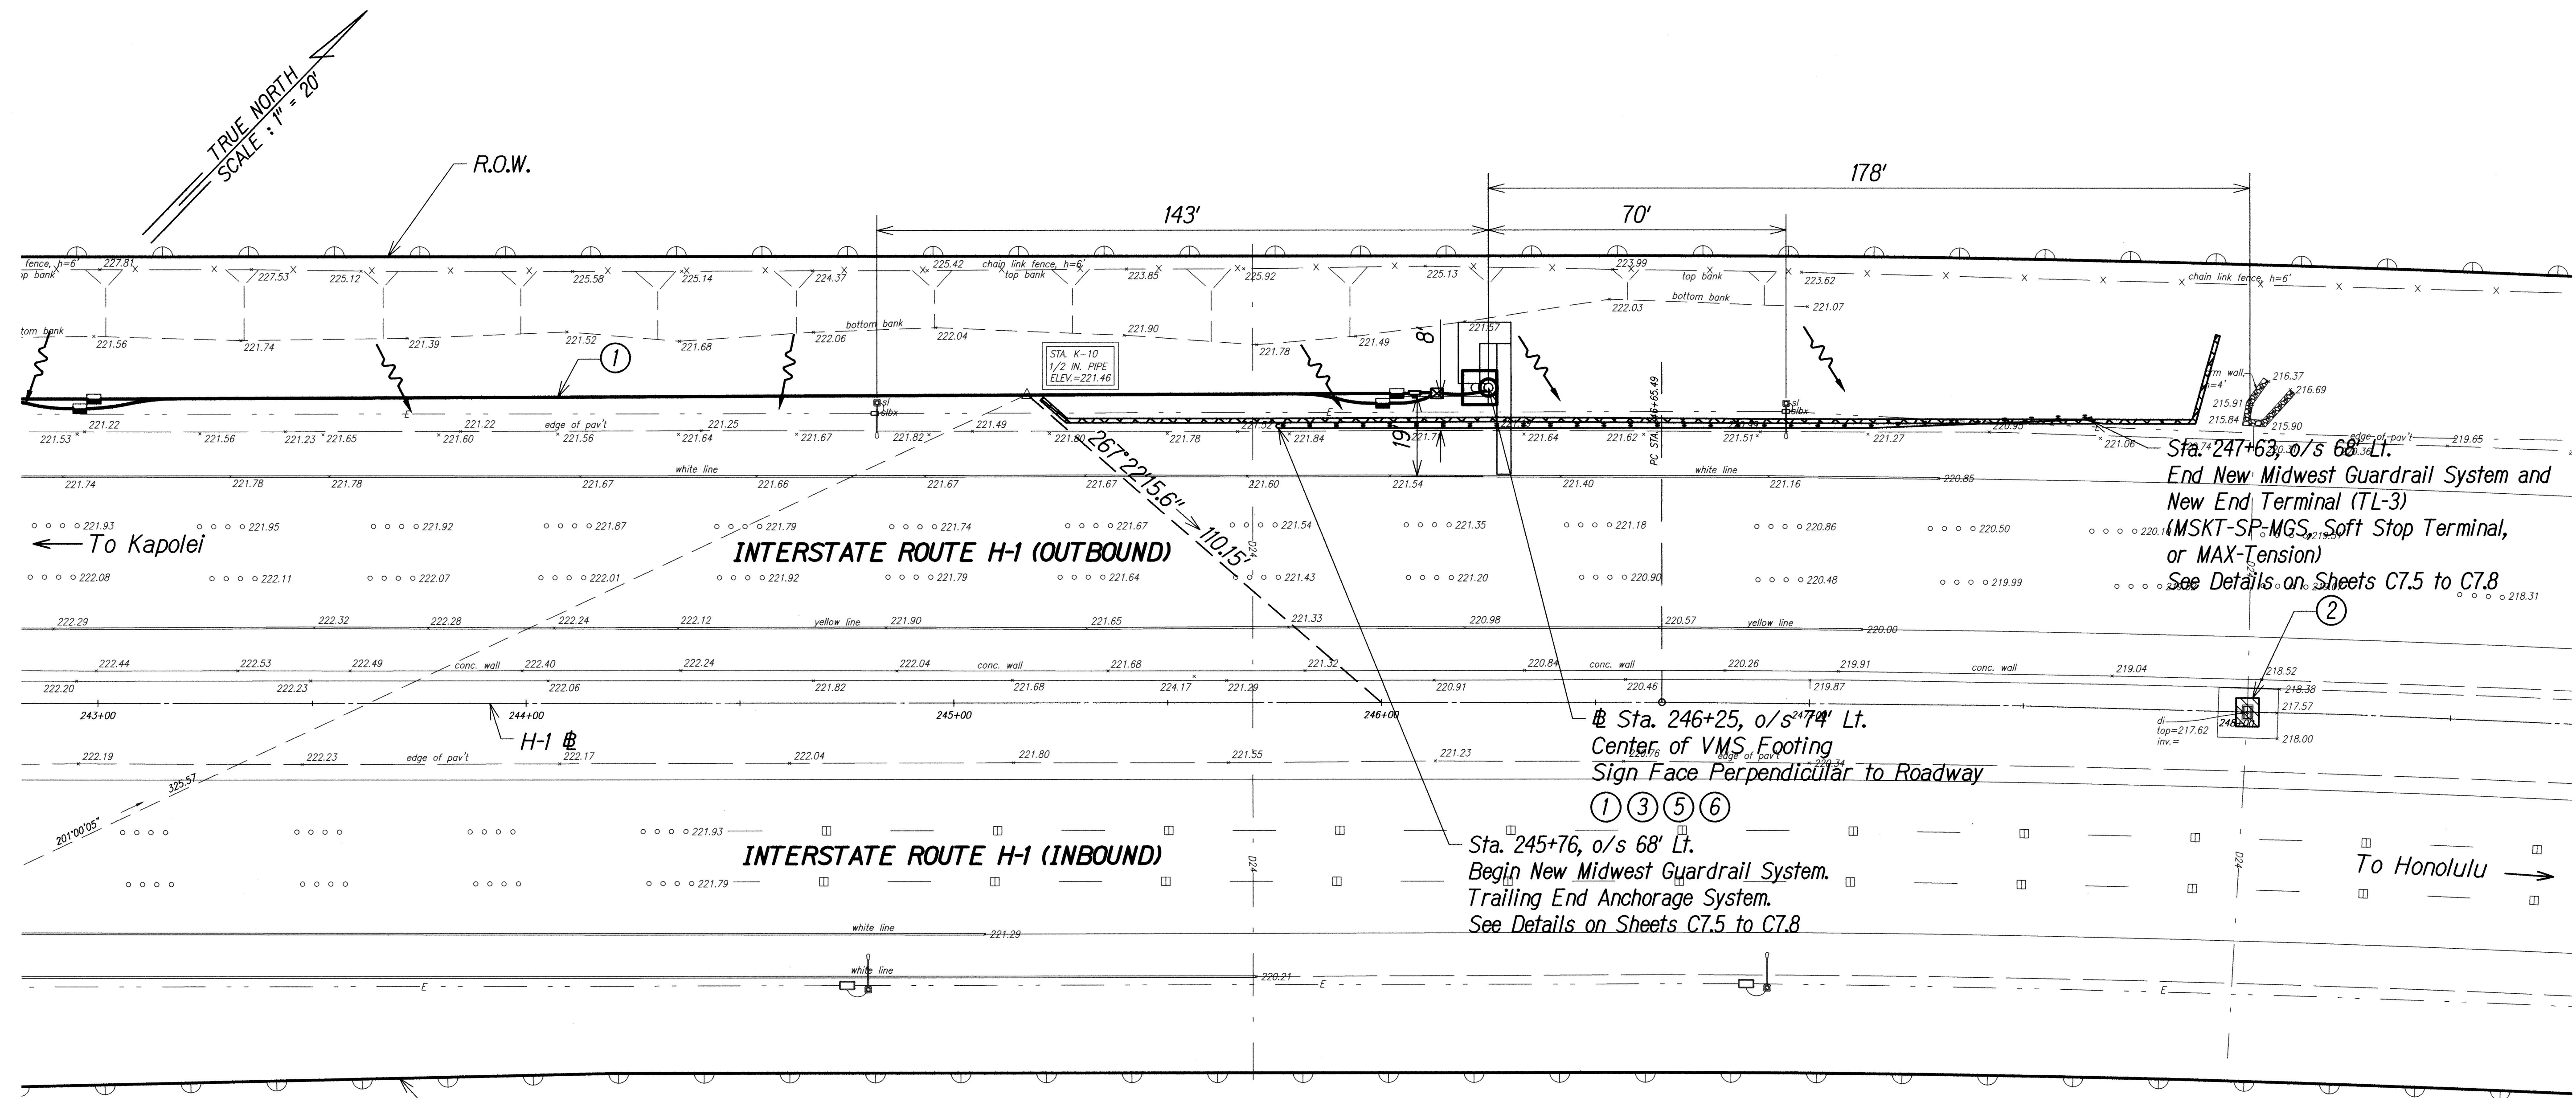

KUALAKAI VMS SITE PLAN

Scale : 1" = 20'

Notes:

- ① See Electrical Plans for electrical and communication service connections.
- ② Exist. storm drain inlet or catch basin. Contractor to observe Best Management Practices and take measures required. Protect exist. storm drain inlets and catch basins located downstream of the project site with Best Management Practices. See details on Sheet C7.9
- ③ Exist. grassed area or landscaping, Contractor to observe Best Management Practices. See detail on Sheet C7.9
- ④ Avoid exist. irrigation systems.
- ⑤ See Structural Plans for details
- ⑥ Contractor to verify existing topography elevations prior to construction.

LEGEND:

- Temporary Fiber Roll
- Flow Direction
- Temporary Sediment Control Filter

0 1 2
LINE IS 2 INCHES AT FULL SIZE
(if not 2 inches scale accordingly)



THIS WORK WAS PREPARED BY ME OR UNDER MY SUPERVISION AND CONSTRUCTION OF THIS PROJECT WILL BE UNDER MY OBSERVATION AS DEFINED IN H.A.R. TITLE 16, CHAPTER 115, RULES OF THE BOARD OF PROFESSIONAL ENGINEERS, ARCHITECTS AND SURVEYORS, STATE OF HAWAII

APRIL 30, 2020
LIC. EXP. DATE

STATE OF HAWAII
DEPARTMENT OF TRANSPORTATION
HIGHWAYS DIVISION

KUALAKAI VMS SITE PLAN

Freeway Management System
Phase 2
Federal Aid Project No. NH-0300(160)

Scale: As Shown Date: June 29, 2018

SHEET No. C2.2 OF 25 SHEETS

ORIGINAL PLAN	DATE
DRAWN BY	
TRACED BY	
DESIGNED BY	
CHECKED BY	
NO.	

PR-11-2018-16-049-ENGINEERING.DWG C2.2 KUALAKAI VMS.DWG Jun 25, 2018-2:02 PM

