



DIST. NO.	STATE	PROJ. NO.	FISCAL YEAR	SHEET NO.	TOTAL SHEETS
OAHU	HAW.	NH-0300(175)R	2021	12	73

NOTES:

1. Refer to *Electrical Plans* for communication and power conduit routing and splice cabinets.
2. Refer to *Structural Plans* for fall protection to be installed on existing VMS signs.

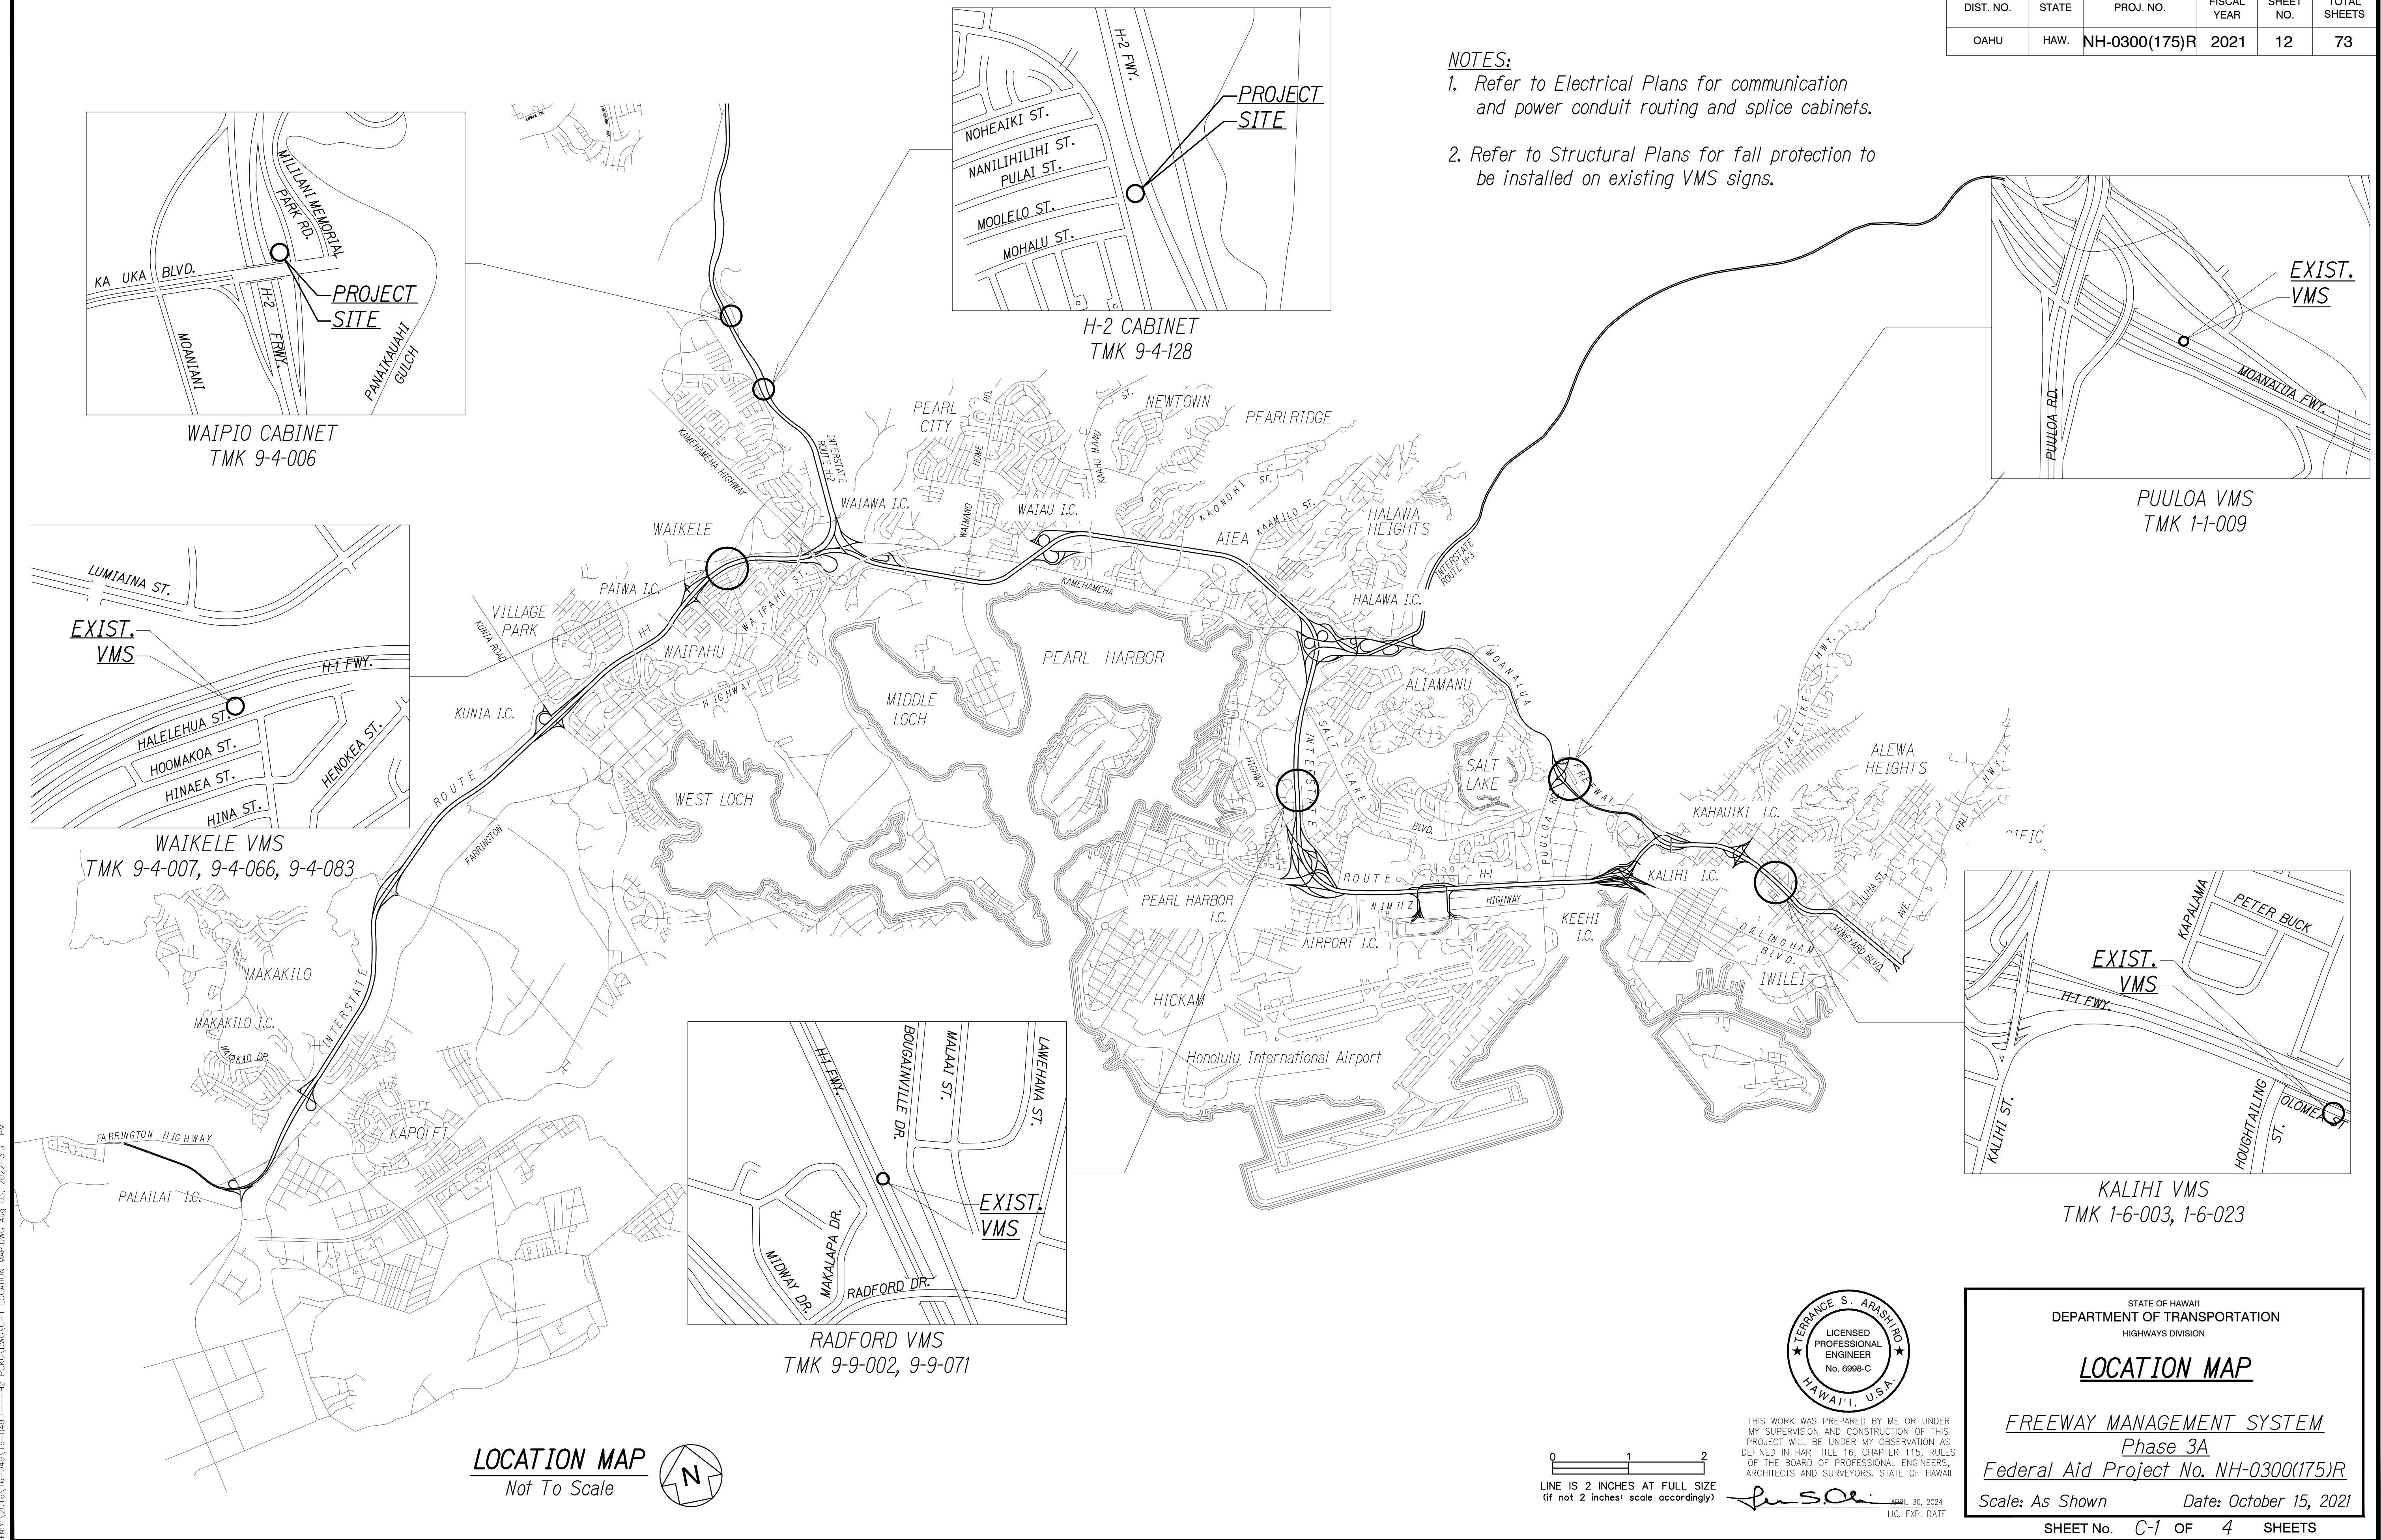

LOCATION MAP
Not To Scale



LINE IS 2 INCHES AT FULL SIZE
(if not 2 inches: scale accordingly)



THIS WORK WAS PREPARED BY ME OR UNDER MY SUPERVISION AND CONSTRUCTION OF THIS PROJECT WILL BE UNDER MY OBSERVATION AS DEFINED IN HAR TITLE 16, CHAPTER 115, RULES OF THE BOARD OF PROFESSIONAL ENGINEERS, ARCHITECTS AND SURVEYORS, STATE OF HAWAII

Sen S. Oh APRIL 30, 2024
LIC EXP DATE

LOCATION OF HAWAII
DEPARTMENT OF TRANSPORTATION
HIGHWAYS DIVISION

LOCATION MAP

FREEWAY MANAGEMENT SYSTEM
Phase 3A
Federal Aid Project No. NH-0300(175)R

Scale: As Shown *Date: October 15, 2021*

SHEET No. *C-1* OF *4* SHEETS