
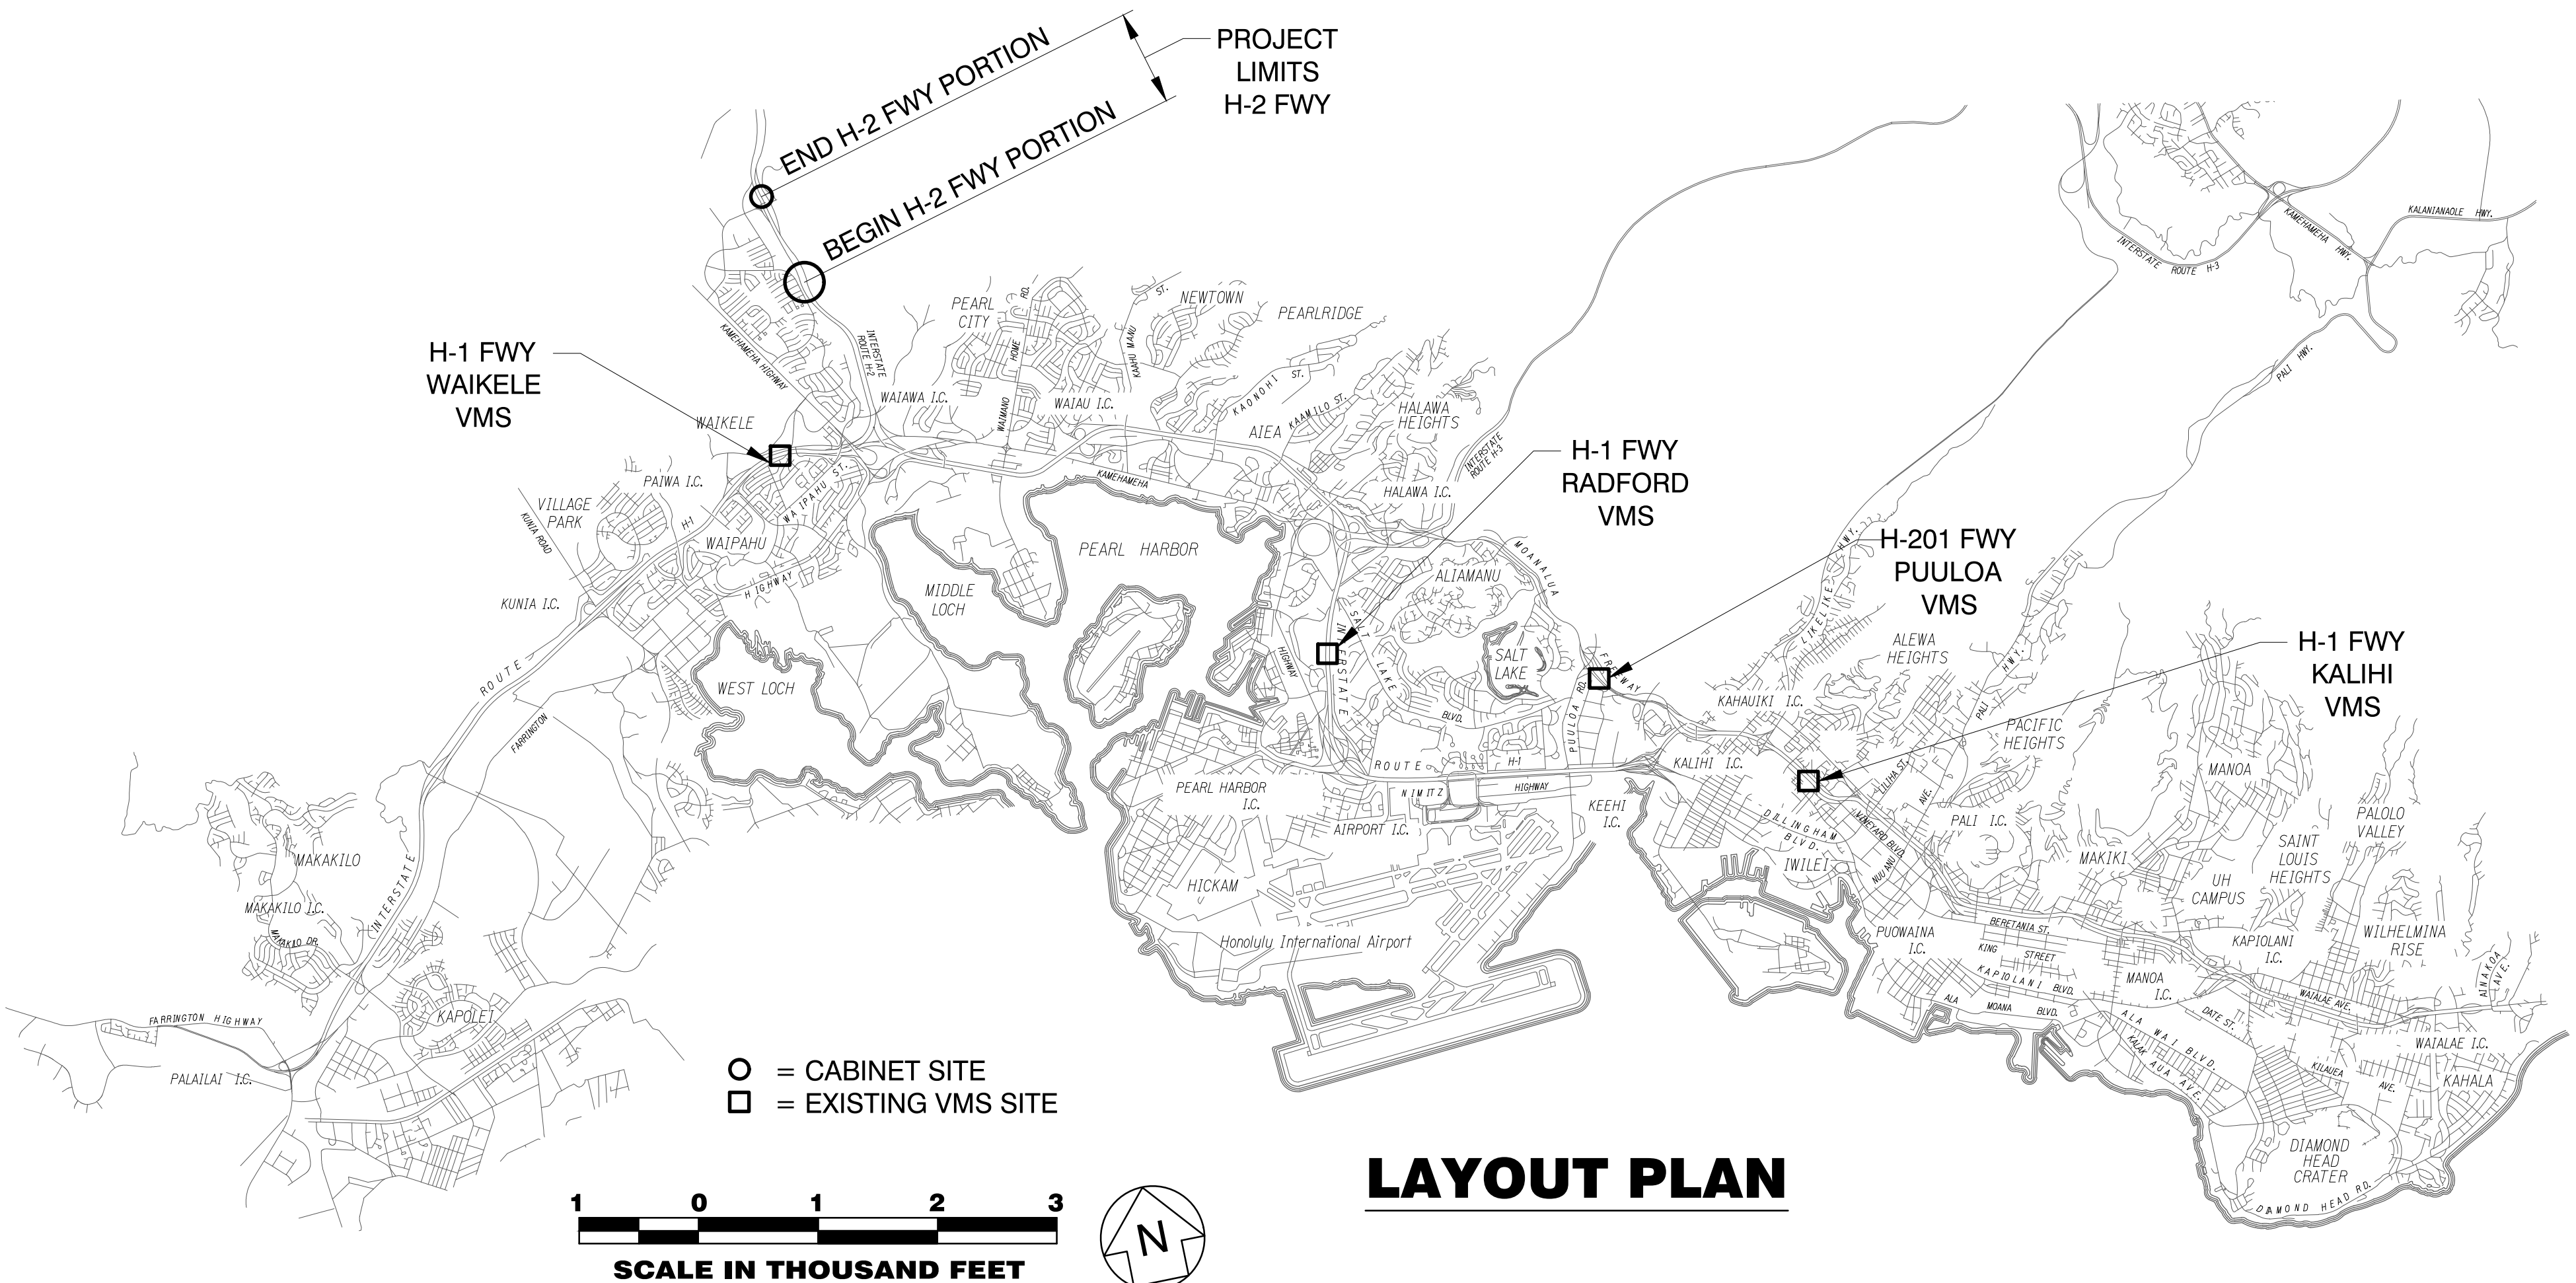
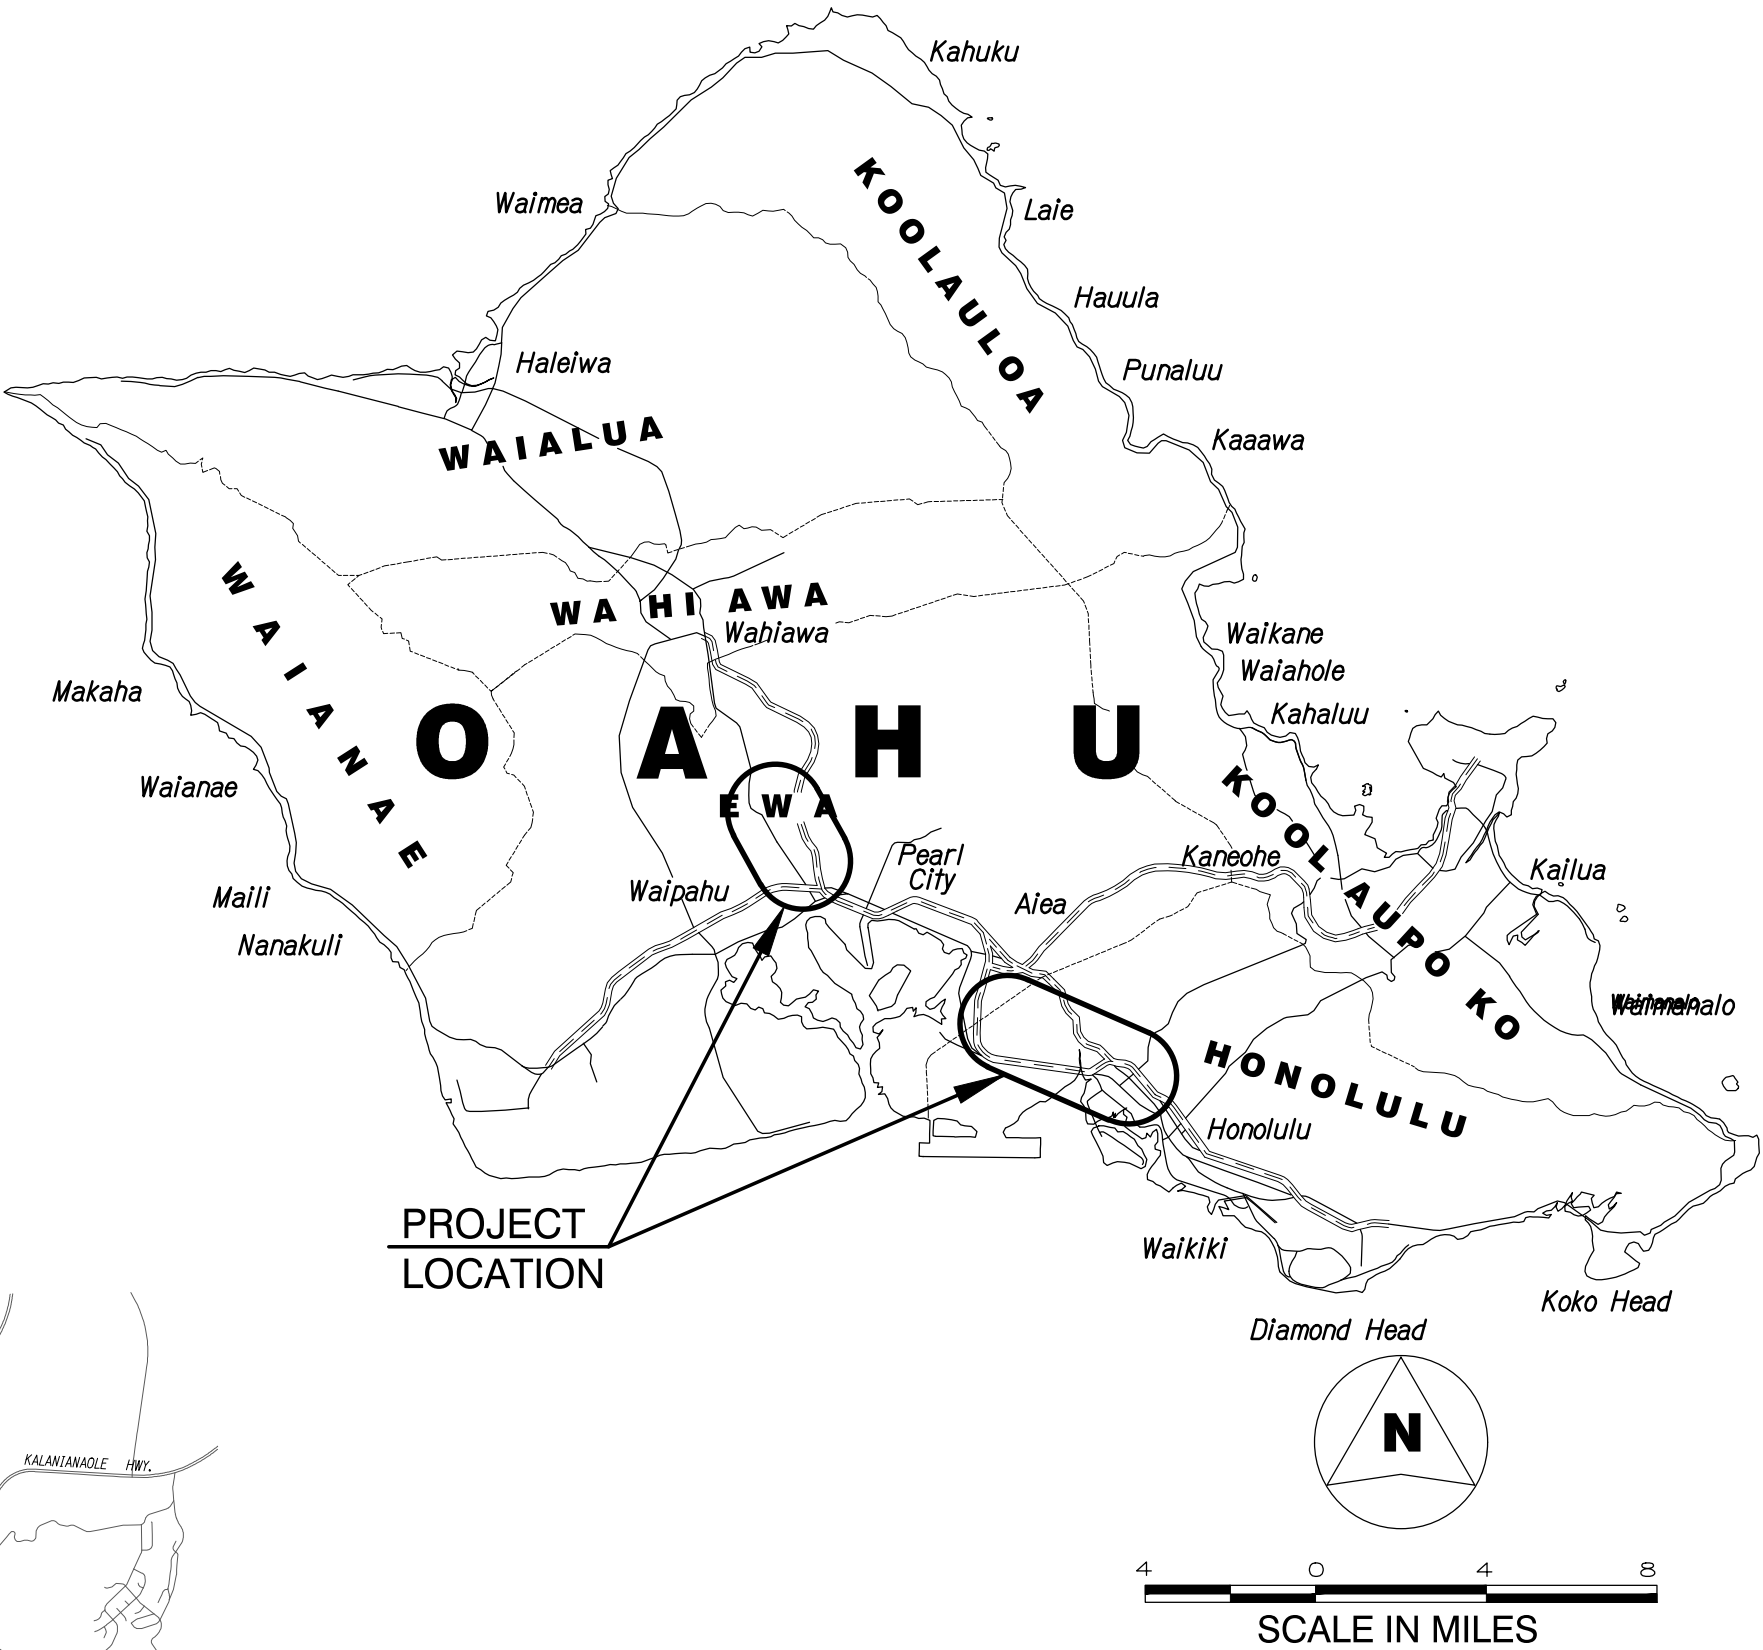


	INDEX TO DRAWINGS
SHEET NO.	DESCRIPTION
1	TITLE SHEET
2	STATE STANDARD PLANS SUMMARY
3	GENERAL CONSTRUCTION NOTES
4 - 6	WATER POLLUTION & EROSION CONTROL NOTES
7 - 11	CONSTRUCTION NOTES & ABBREVIATIONS
12	LOCATION MAP
13	H-2 CABINET SITE PLAN
14	WAIPIO CABINET SITE PLAN
15	EROSION CONTROL DETAILS
16 - 27	COMMUNICATIONS PLANS
28	TRAFFIC CONTROL LOCATION MAPS
29 - 34	TRAFFIC CONTROL PLANS
35 - 48	ELECTRICAL PLANS
49 - 73	STRUCTURAL PLANS

STATE OF HAWAII
DEPARTMENT OF TRANSPORTATION
HIGHWAYS DIVISION
HONOLULU, HAWAII

FREEWAY MANAGEMENT SYSTEM
PHASE 3A
FEDERAL-AID PROJECT NO. NH-0300(175)R
DISTRICTS OF HONOLULU & EWA
ISLAND OF OAHU

FED. ROAD DIST. NO.	STATE	FED. AID PROJ. NO.	FISCAL YEAR	SHEET NO.	TOTAL SHEETS
OAHU	HAW.	NH-0300(175)R	2021	1	73

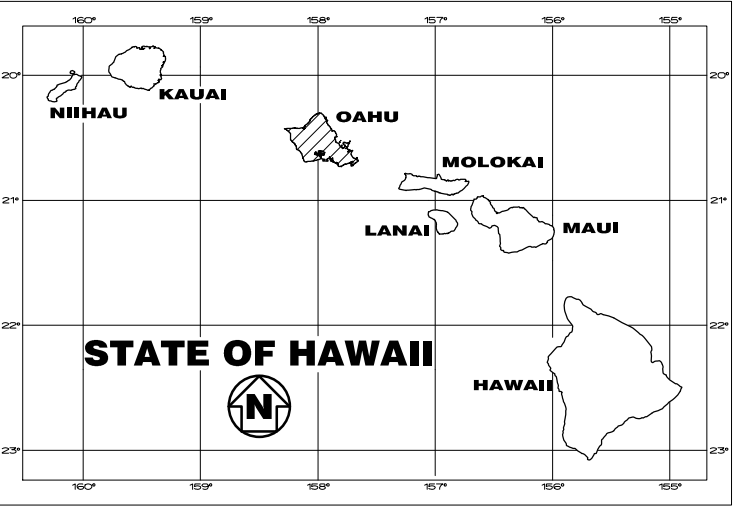

FEDERAL AID PROJECTS PREVIOUSLY CONSTRUCTED OR UNDER CONSTRUCTION

H-2 MILE POST 1.50 TO MILE POST 3.00

DEPARTMENT OF TRANSPORTATION STATE OF HAWAII	
APPROVED:	Aug 9, 2022
DIR. OF TRANSPORTATION	DATE

for

ORIGINAL PLAN	SURVEY PLOTTED BY	DATE
NOTE BOOK	DRAWN BY	
	DESIGNED BY	
	QUANTITIES BY	
	CHECKED BY	

PNX\2016\16-049\16-049-1--H2 PKG\DWG\1-1 TITLE SH.DWG Aug 03, 2022-3:31 PM

Austin Tsutsumi and Associates, Inc. HWY-TO
DESIGNED BY MANAGED BY
692-7675 PHONE
OCT 2021 DATE