




FED. ROAD DIST. NO.	STATE	FED. AID PROJ. NO.	FISCAL YEAR	SHEET NO.	TOTAL SHEETS
OAHU	HAW.	NH-0300(152)	2021	1	170

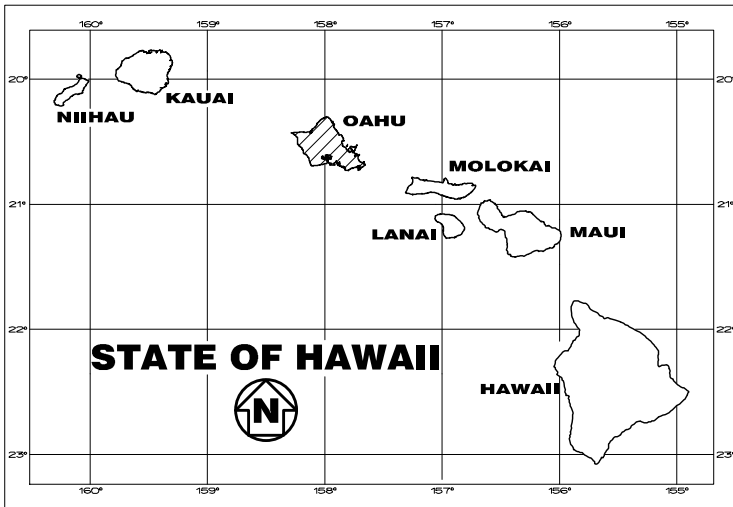


STATE OF HAWAII
DEPARTMENT OF TRANSPORTATION
HIGHWAYS DIVISION
HONOLULU, HAWAII

FREEWAY MANAGEMENT SYSTEM
PHASE 3, UNIT 1
FEDERAL-AID PROJECT NO. NH-0300(152)
DISTRICTS OF HONOLULU & EWA
ISLAND OF OAHU

INDEX TO DRAWINGS	
SHEET NO.	DESCRIPTION
1	TITLE SHEET
2	STATE STANDARD PLAN SUMMARY
3 - 10	CONSTRUCTION NOTES
11	CCTV LOCATION MAP
12 - 13	CCTV SITE PLANS
14 - 15	CCTV DETAILS
16 - 26	BMP PLANS
27	BMP DETAILS
28 - 57	COMMUNICATIONS PLANS
58 - 118	TRAFFIC CONTROL PLANS
119 - 150	ELECTRICAL PLANS
151 - 157	HDD PLAN AND PROFILE
158 - 162	BORING LOGS
163 - 170	STRUCTURAL PLANS

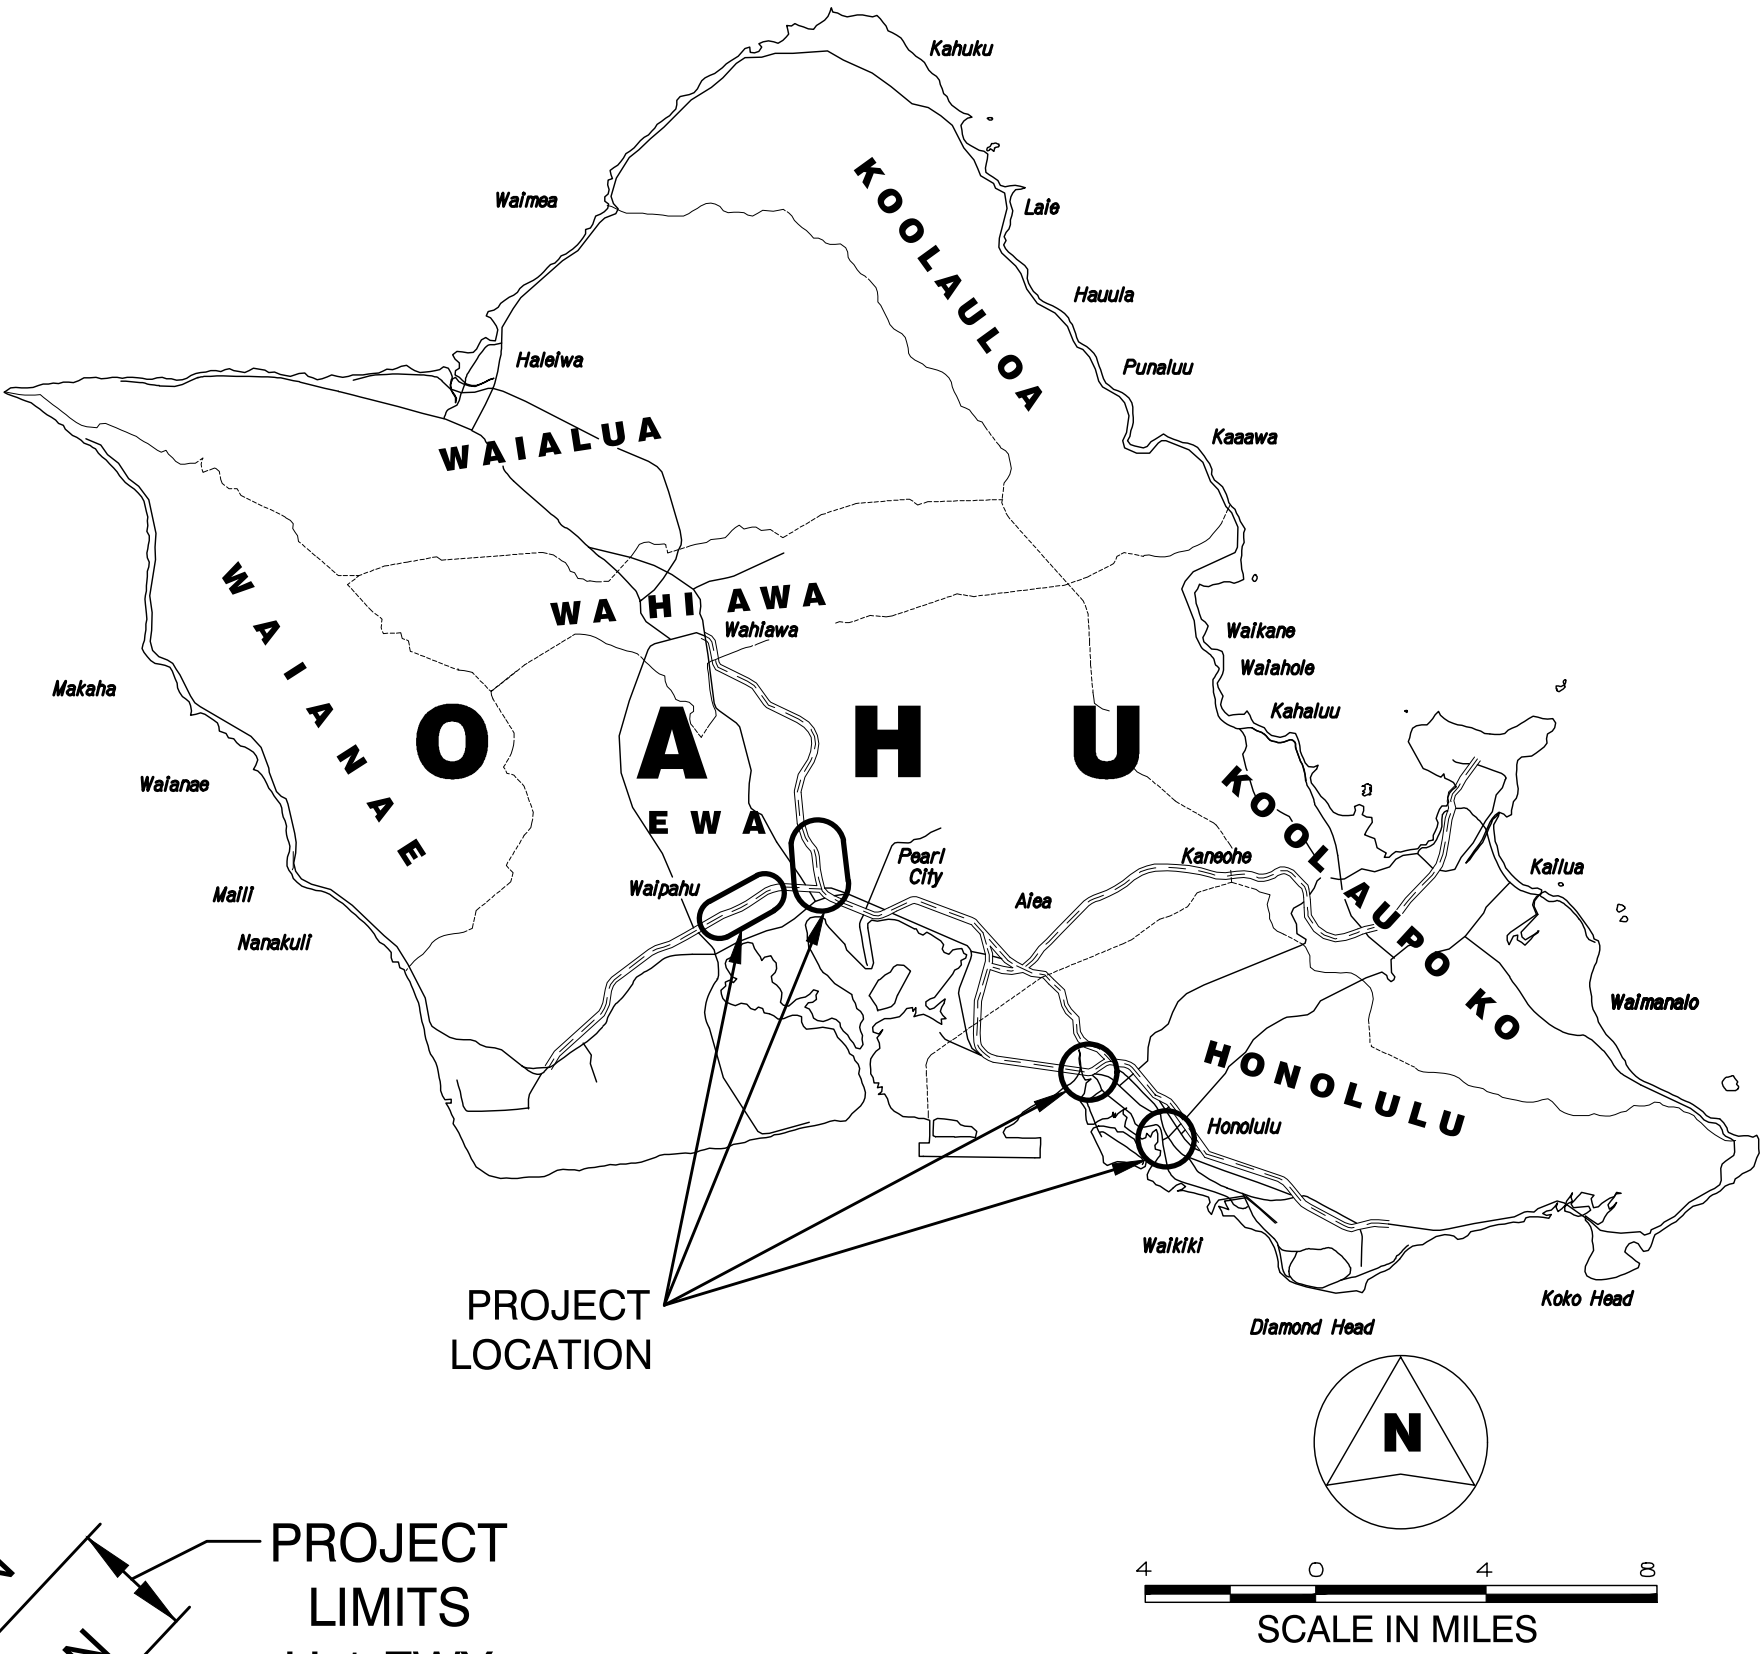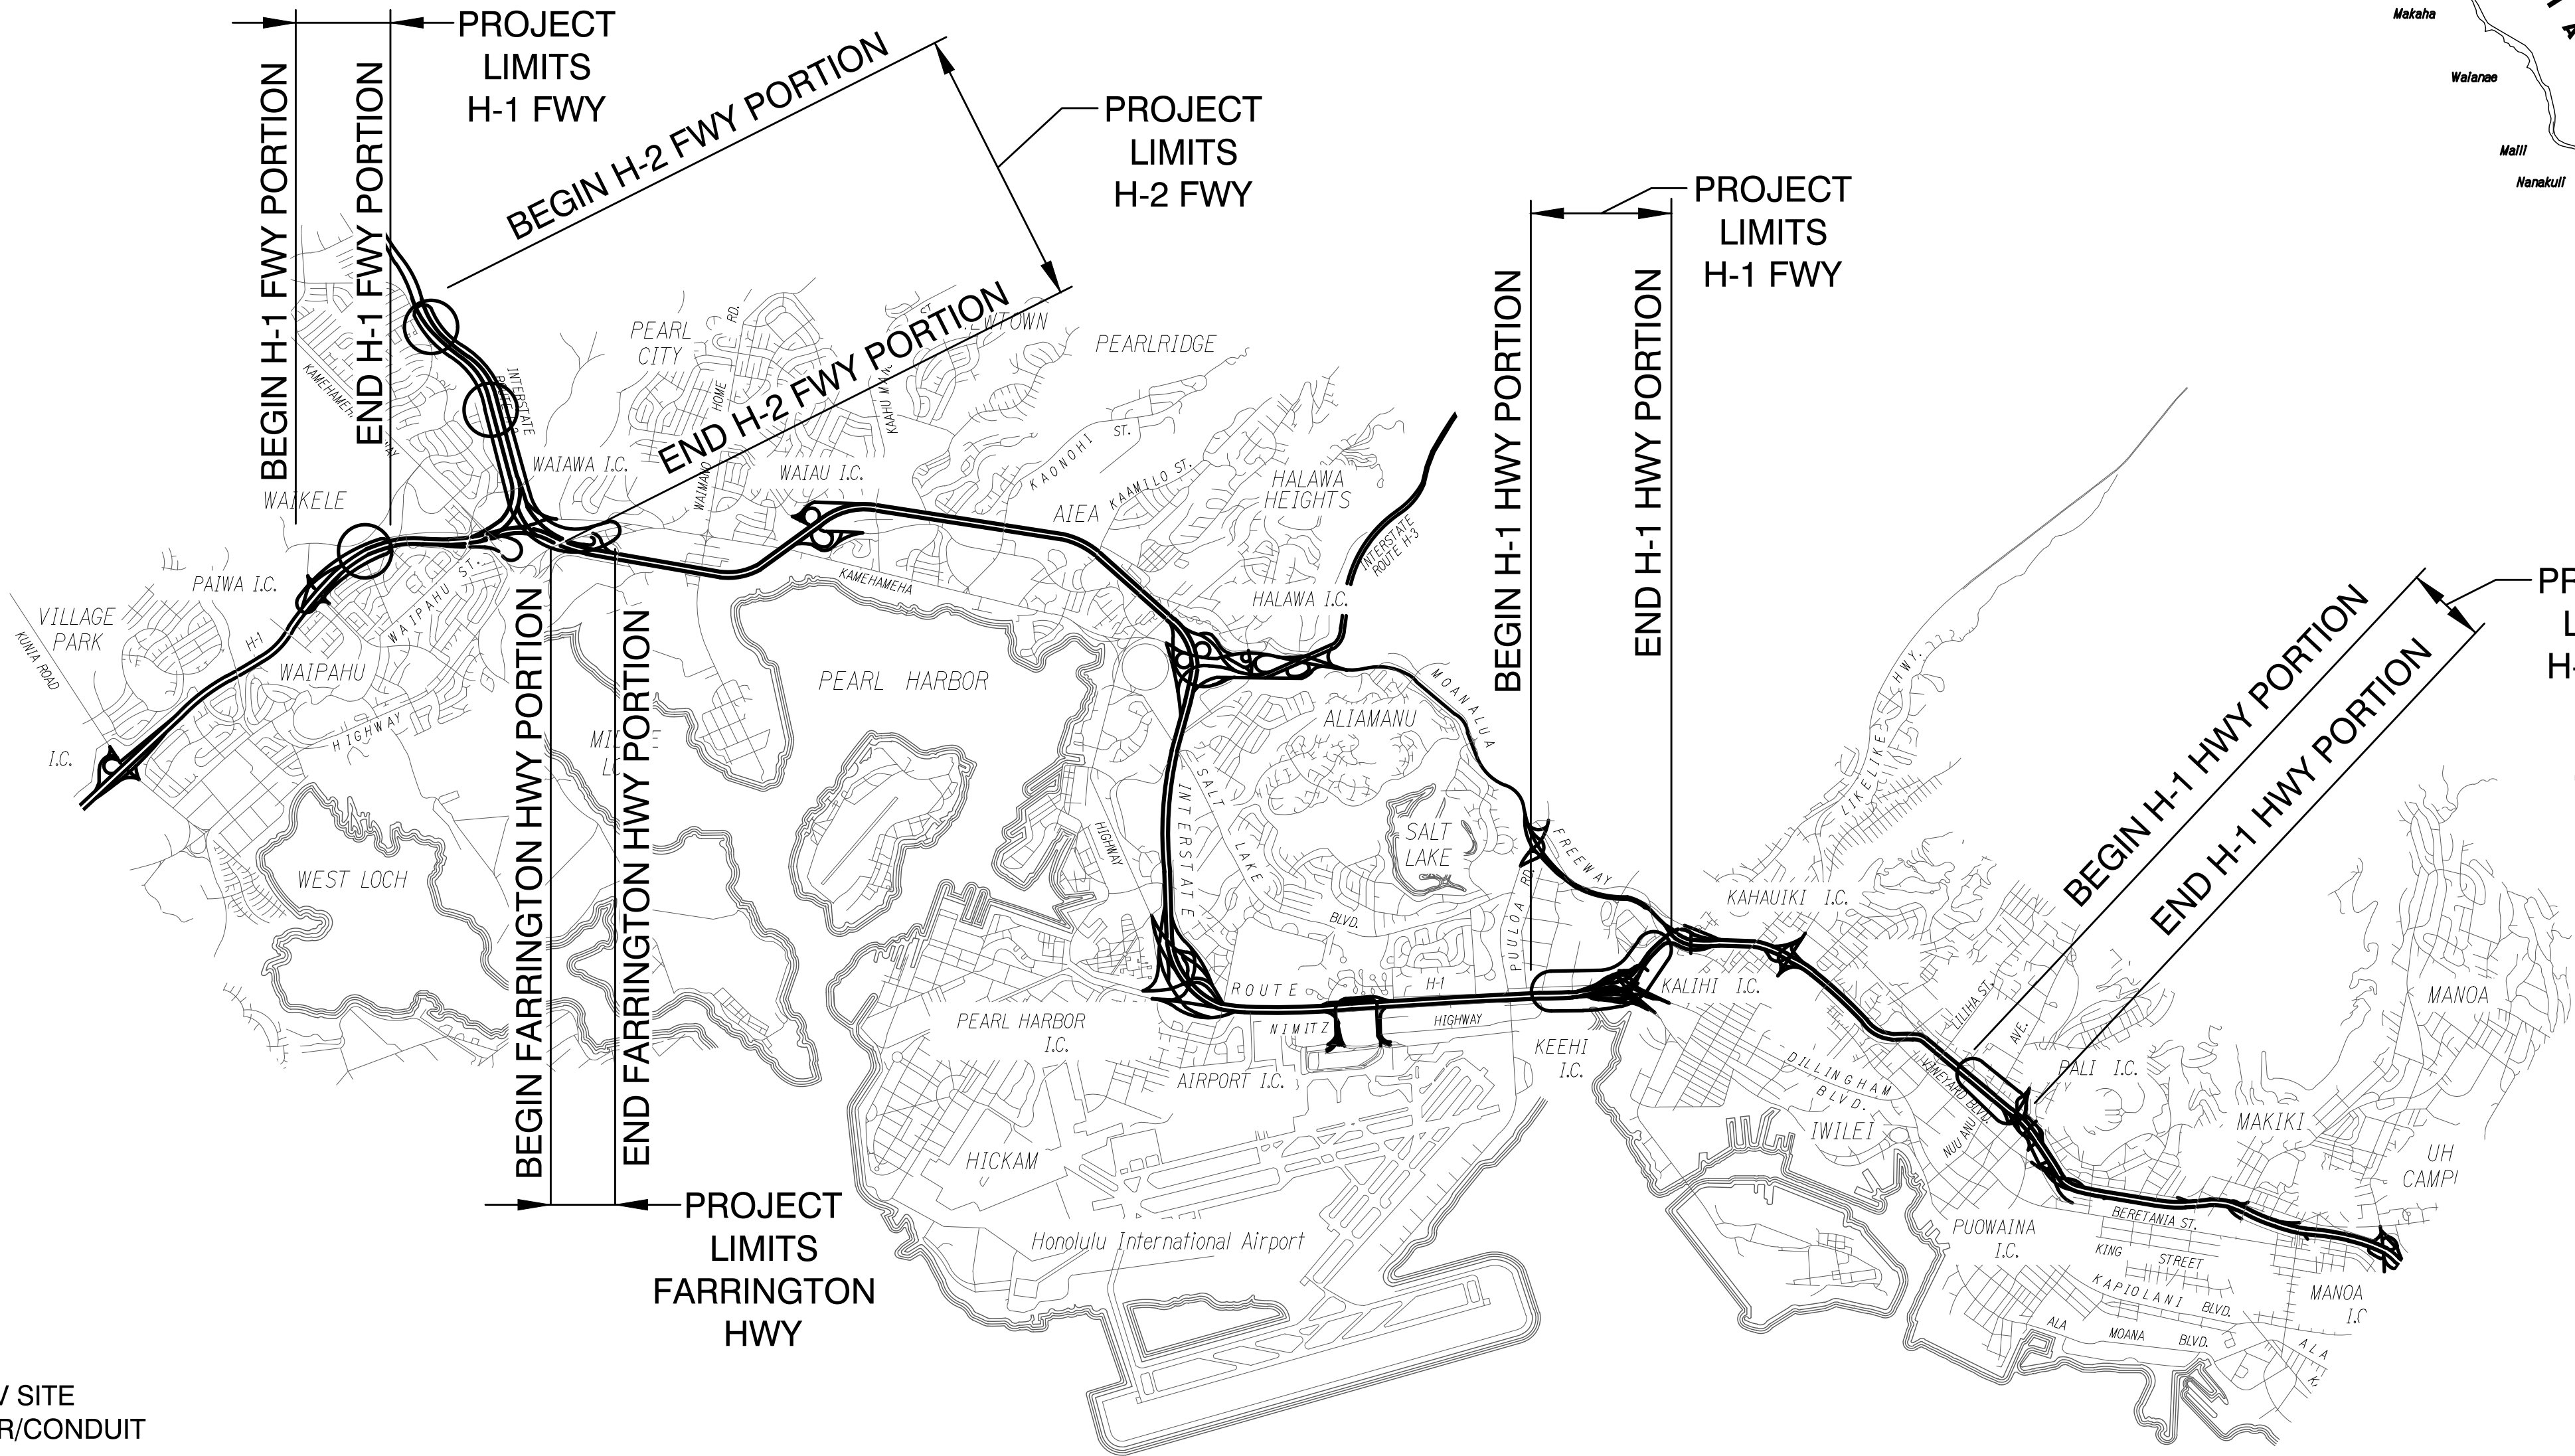

FEDERAL AID PROJECTS PREVIOUSLY CONSTRUCTED OR UNDER CONSTRUCTION			
H-1	MILE POST 7.07	TO	MILE POST 7.67
	MILE POST 17.94	TO	MILE POST 18.85
	MILE POST 21.04	TO	MILE POST 21.41
H-2	MILE POST 0.00	TO	MILE POST 1.72
FARRINGTON HWY (RTE 99)	MILE POST 17.66	TO	MILE POST 17.89

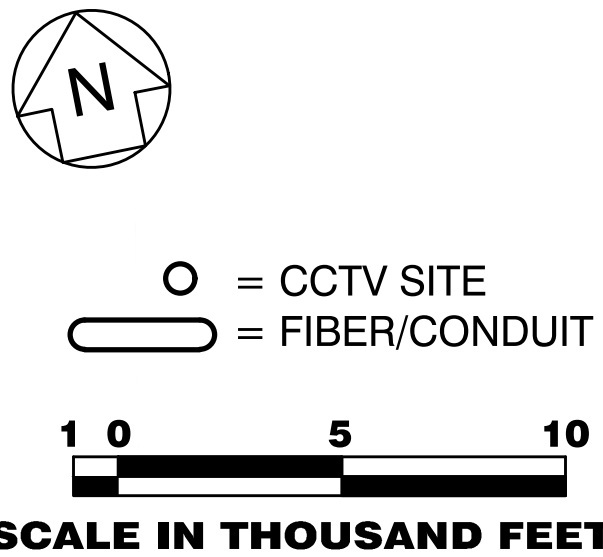

LAYOUT PLAN

ORIGINAL PLAN	SURVEY PLOTTED BY	DATE
NOTE BOOK	DRAWN BY	
	DESIGNED BY	
	CHECKED BY	

PNX\2019\19-201 FMS PHASE 3\1 UNIT 1\DWG1-1 TITLE SHT.DWG-Jul 16, 2021-9:41 AM

Austin Tsutsumi and Associates, Inc. HWY-TO JUNE 2021
DESIGNED BY MANAGED BY PHONE DATE

DEPARTMENT OF TRANSPORTATION STATE OF HAWAII	
APPROVED:	Jul 21, 2021
DIR. OF TRANSPORTATION	DATE