

| INDEX TO DRAWINGS | |
|-------------------|-------------------------------|
| SHEET NO. | DESCRIPTION |
| 1 | TITLE SHEET |
| 2 | DETAILED INDEX & LEGEND |
| 3 | STANDARD PLANS SUMMARY |
| 4-14 | NOTES |
| 15-16 | LOCATION MAPS |
| 17-26 | DETAILS |
| 27-53 | CIVIL PLANS ① |
| 54-59 | TYPICAL TRAFFIC CONTROL PLANS |
| 60-79 | ELECTRICAL PLANS |
| | |
| | |

Plan Sht. No. ① C.O. 53 S-1 is a supplementary sheet to this project, added during Addendum & "AS-BUILT" posting. TOTAL SHEET COUNT after Addendum & "AS-BUILT" posting is 79 sheets.

STATE OF HAWAII

DEPARTMENT OF TRANSPORTATION

HIGHWAYS DIVISION

HONOLULU, HAWAII

"AS-BUILT"

PLANS FOR

PEDESTRIAN FACILITIES AND ADA COMPLIANCE


AT VARIOUS LOCATIONS ON OAHU, UNIT 3

FEDERAL AID PROJECT NO. CMAQ-0300(94)

DISTRICTS OF WAIALUA, KOOLAULO, AND KOOLAUPOKO

ISLAND OF OAHU

| FED. ROAD DIST. NO. | STATE | FEDERAL - AID PROJ. NO. | FISCAL YEAR | SHEET NO. | TOTAL SHEETS |
|---------------------|-------|-------------------------|-------------|-----------|--------------|
| HAWAII | HAW. | CMAQ-0300(94) | 2004 | 1 | 79 |

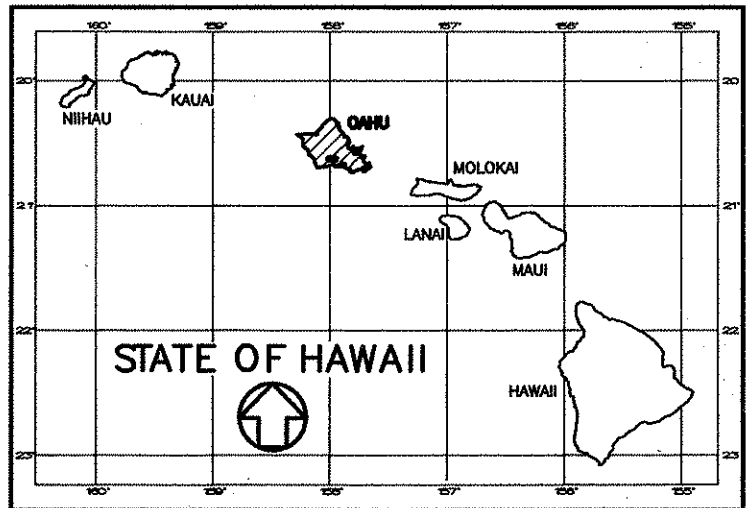

PROJECT SITES

- ① Farrington Hwy.; Route 930
MILE POST 5.90 TO MILE POST 6.13
- ② Kaneohe Bay Dr., Mokapu Blvd.; Route 65
MILE POST 0.11 TO MILE POST 3.24
- ③ Likelike Hwy.; Route 63
MILE POST 41.35 TO MILE POST 41.38
- ④ Kamehameha Hwy.; Route 83
MILE POST 41.76 TO MILE POST 42.12
- ⑤ Kahekili Hwy.; Route 83
MILE POST 36.04 TO MILE POST 40.46
- ⑥ Kamehameha Hwy.; Route 83
MILE POST 18.23


CHANGES MADE DURING CONSTRUCTION HAVE BEEN INCORPORATED ON THESE PLANS EXCEPT CHANGES IN THE ORIGINAL THEORETICAL QUANTITIES. FOR ACTUAL QUANTITIES, REFER TO PROJECT LEDGER AND/OR COMPUTATION BOOK.

Marvin C. H. [Signature]
RESIDENT ENGINEER

11-08-2007
DATE

| | |
|---|---------|
| DEPARTMENT OF TRANSPORTATION STATE OF HAWAII | |
| APPROVED: | 4/12/04 |
| DIR. OF TRANSPORTATION | DATE |

"AS-BUILT" 1

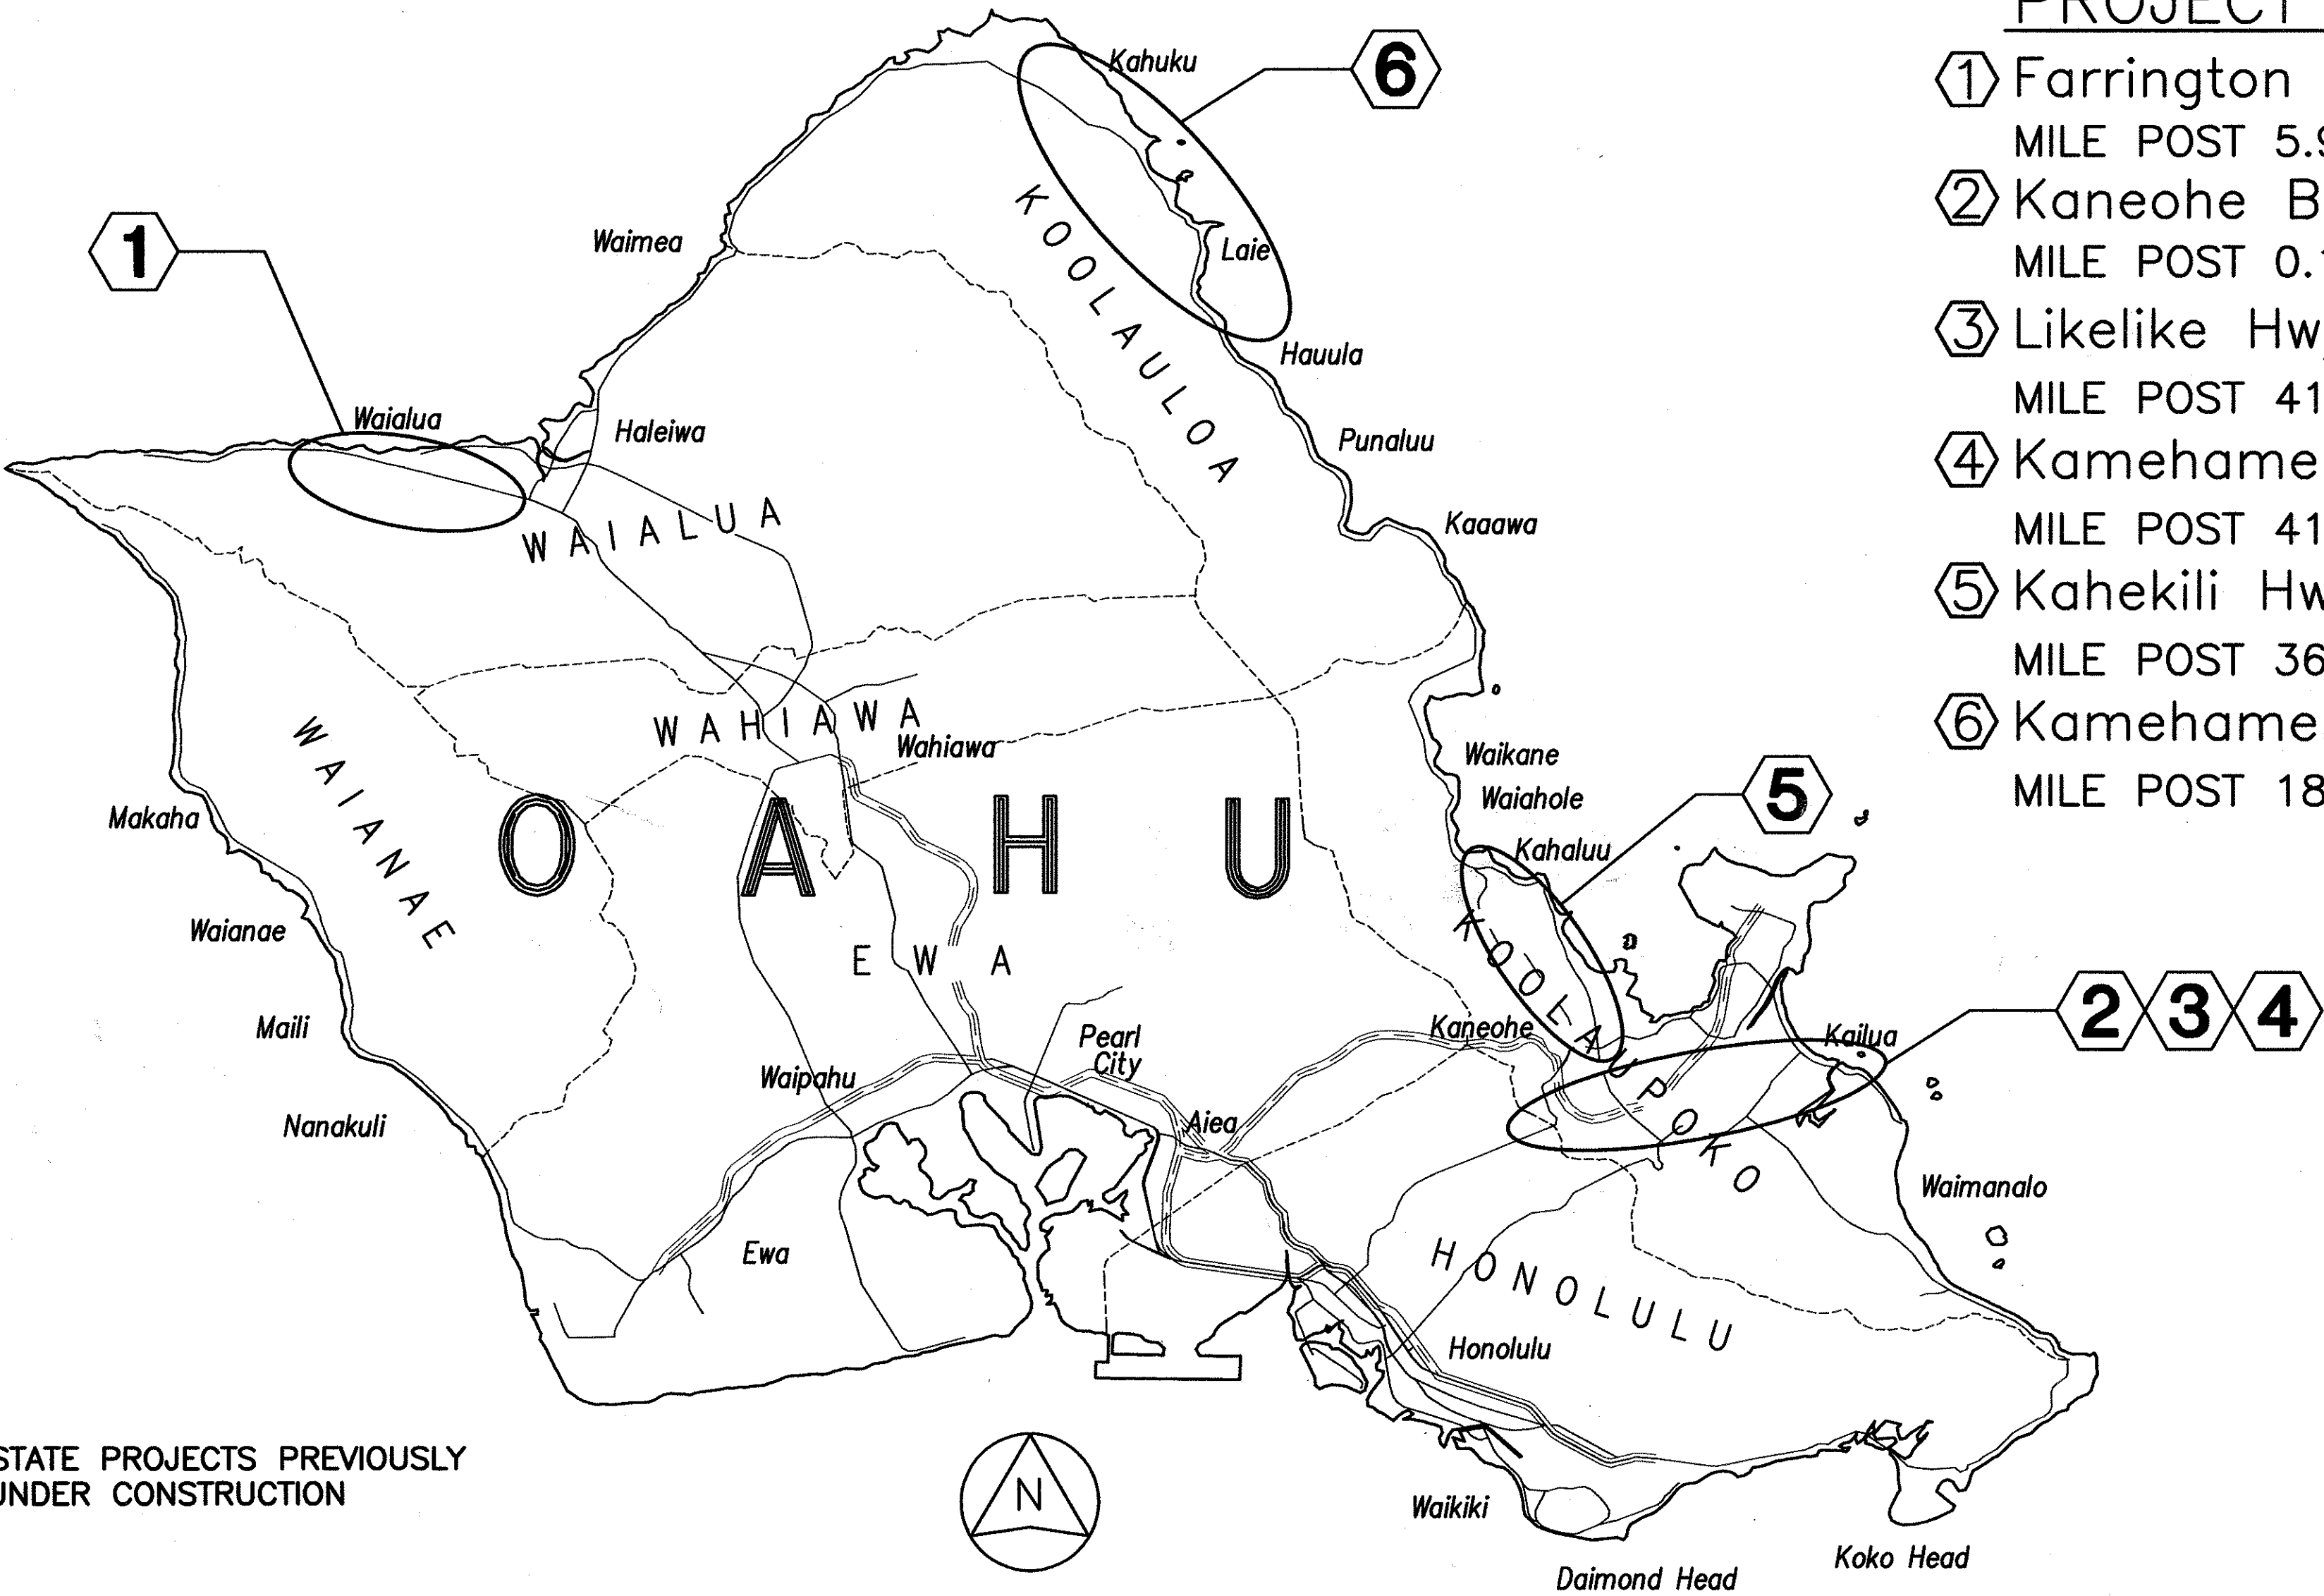

FEDERAL AID INTERSTATE PROJECTS PREVIOUSLY CONSTRUCTED OR UNDER CONSTRUCTION

| | |
|-------------------|------|
| ORIGINAL PLAN | DATE |
| SURVEY PLOTTED BY | |
| DRAWN BY | |
| TRACED BY | |
| QUANTITIES BY | |
| CHECKED BY | |
| No. | |

SATO & ASSOCIATES, INC.

DESIGNED BY

HWY-DD

692-7570

PHONE

AUGUST 2004

DATE