

INDEX OF DRAWINGS	
SHEET NO.	DESCRIPTION
1	TITLE SHEET
2 - 3	DETAILED INDEX
4	STANDARD PLANS SUMMARY
5 - 15	NOTES
16 - 17	LOCATION MAPS
18 - 30	DETAILS
31 - 117	CIVIL PLANS ①②③④⑤⑥⑦
118 - 123	TYPICAL TRAFFIC CONTROL PLANS
124 - 163	ELECTRICAL PLANS

STATE OF HAWAII
DEPARTMENT OF TRANSPORTATION
HIGHWAYS DIVISION
HONOLULU, HAWAII
"AS-BUILT"
PLANS FOR
PEDESTRIAN FACILITIES AND ADA COMPLIANCE
VARIOUS LOCATIONS ON OAHU, UNIT 6
FEDERAL AID PROJECT NO. CMAQ-0300(97)

FED. ROAD DIST. NO.	STATE	FED. AID PROJ. NO.	FISCAL YEAR	SHEET NO.	TOTAL SHEETS
HAWAII	HAW.	CMAQ-0300(97)	2004	1	163

63
99
7241
7310
7345
7350
7351
7415


Plan Sht. Nos. ① C.O. 33 S-1, ② C.O. 69 S-1, ③ C.O. 70 S-1, ④ C.O. 76 S-1, ⑤ C.O. 77 S-1, ⑥ C.O. 80 S-1, and ⑦ C.O. 81 S-1 are supplementary sheets to this project, added during Addendum & "AS-BUILT" postings.

TOTAL SHEET COUNT after Addendum & "AS-BUILT" posting is 170 sheets.

DISTRICT OF HONOLULU
ISLAND OF OAHU

PROJECTS SITES

- ① Kamehameha Hwy. (Route 99)
Mile Post 21.54 TO Mile Post 23.19
② Radford Dr. (Route 7351)
Mile Post 0 TO Mile Post 0.23
③ Bougainville Dr. (Route 7350)
Mile Post 0.32 TO Mile Post 0.40
④ Puuloa Rd./Salt Lake Blvd. (Route 7310)
Mile Post 0.68
⑤ Middle St. (Route 7415)
Mile Post 0.01 TO Mile Post 0.51
⑥ Halawa Hts. Rd./Kahuapaani St. (Route 7241)
Mile Post 0 TO Mile Post 1.36
Mile Post 0 TO Mile Post 0.96
⑦ Jarret White Rd. (Route 7345)
Mile Post 0.19 TO Mile Post 0.54
⑧ Kalihi St./Likelike Hwy. (Route 63)
Mile Post 0.10 TO Mile Post 0.74
Mile Post 1.03 TO Mile Post 2.14

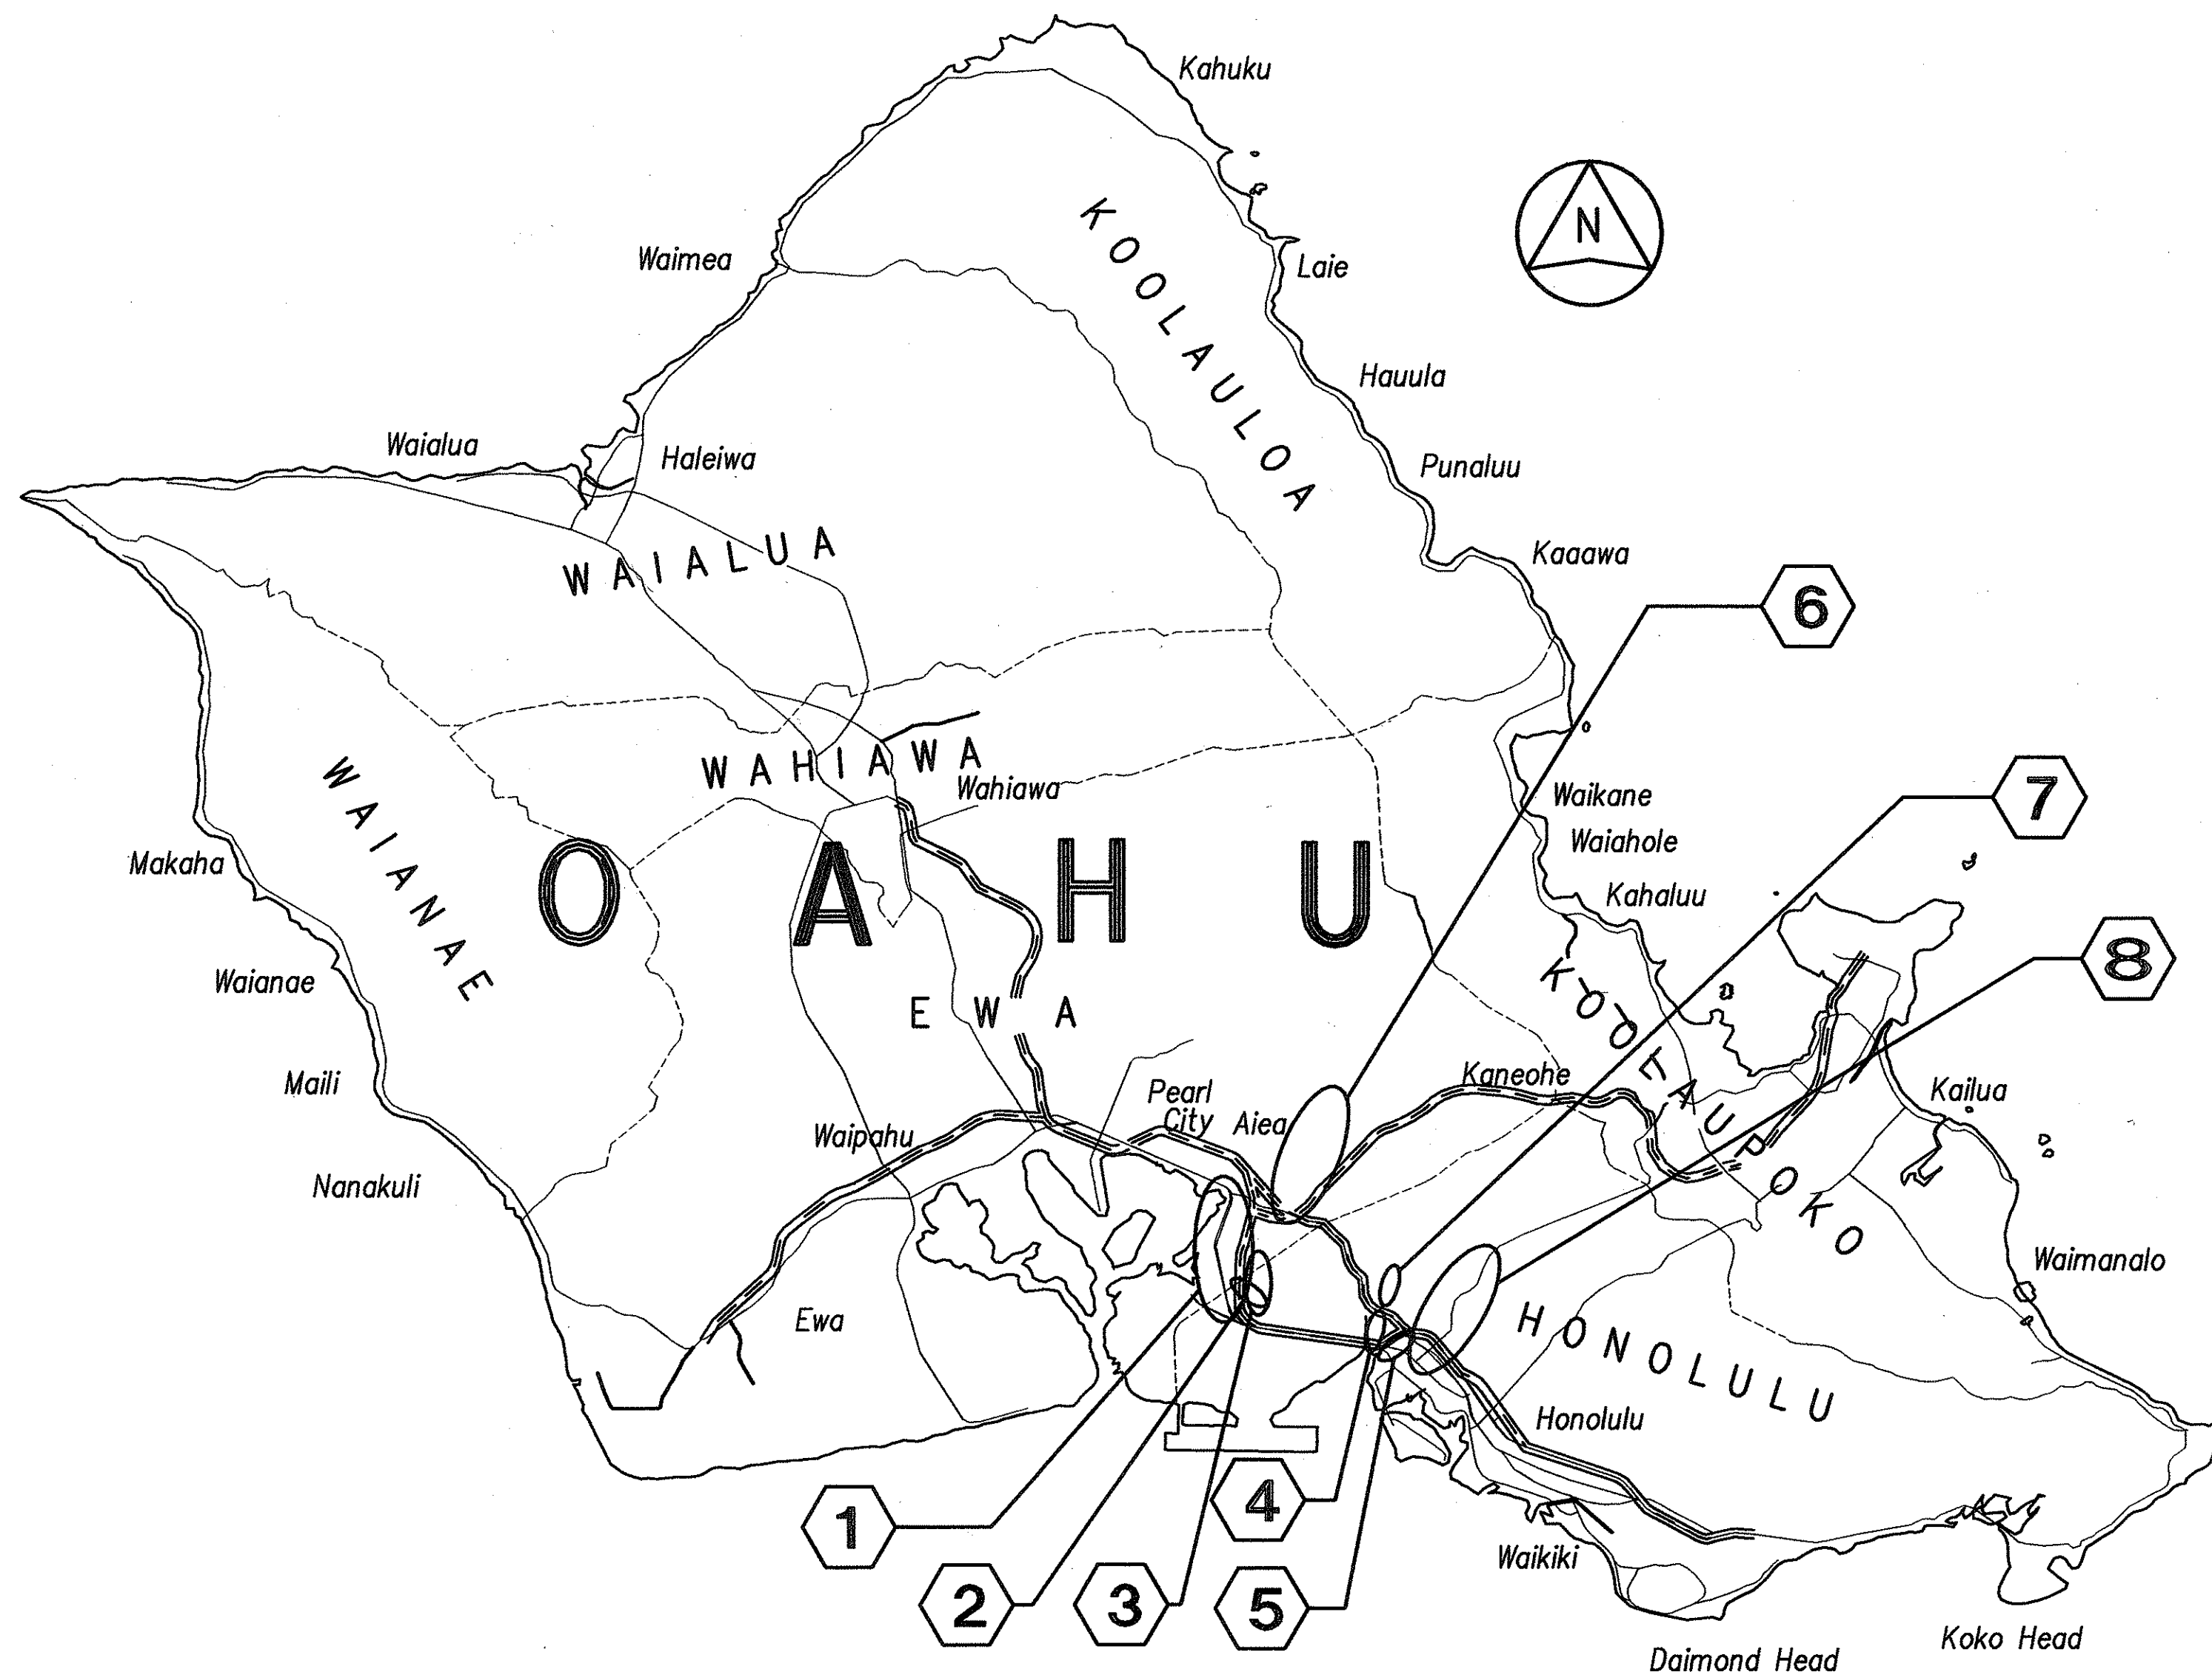

CHANGES MADE DURING CONSTRUCTION HAVE BEEN INCORPORATED ON THESE PLANS EXCEPT CHANGES IN THE ORIGINAL THEORETICAL QUANTITIES. FOR ACTUAL QUANTITIES, REFER TO PROJECT LEDGER AND/OR COMPUTATION BOOK.

Marion C. H. [Signature]
RESIDENT ENGINEER

11-08-2007
DATE

FEDERAL AID INTERSTATE PROJECTS PREVIOUSLY CONSTRUCTED OR UNDER CONSTRUCTION

DEPARTMENT OF TRANSPORTATION
STATE OF HAWAII
APPROVED:
[Signature]
DIR. OF TRANSPORTATION

8.24
DATE

"AS-BUILT"