

INDEX TO DRAWINGS	
SHEET NO.	DESCRIPTION
1	TITLE SHEET
2	STANDARD PLANS SUMMARY
3-5	GENERAL NOTES, LEGEND & ABBREVIATIONS
6-13	UTILITY NOTES
14-17	WATER POLLUTION AND EROSION CONTROL NOTES AND DETAILS
18	GENERAL LAYOUT PLAN
19-20	CONSTRUCTION PHASING PLANS
21-27	ROADWAY CONSTRUCTION PLANS AND DETAILS
28-30	DESTINATION SIGN FRAME LAYOUT
31-36	SIGN PANEL DETAILS
37-121	TRAFFIC CONTROL NOTES AND PLANS
122-185	STRUCTURAL PLANS
186-189	BORING LOGS
190-197	ELECTRICAL PLANS

STATE OF HAWAII

DEPARTMENT OF TRANSPORTATION

HIGHWAYS DIVISION

HONOLULU, HAWAII

PLANS FOR

INTERSTATE ROUTE H-1 AND H-201




DESTINATION SIGN UPGRADE/REPLACEMENT, PHASE 3B

FEDERAL-AID PROJECT NO. NH-0300(205)

DISTRICT OF HONOLULU

ISLAND OF OAHU

FED. ROAD DIST. NO.	STATE	FED. AID PROJ. NO.	FISCAL YEAR	SHEET NO.	TOTAL SHEETS
HAWAII	HAW.	NH-0300(205)	2024	1	197

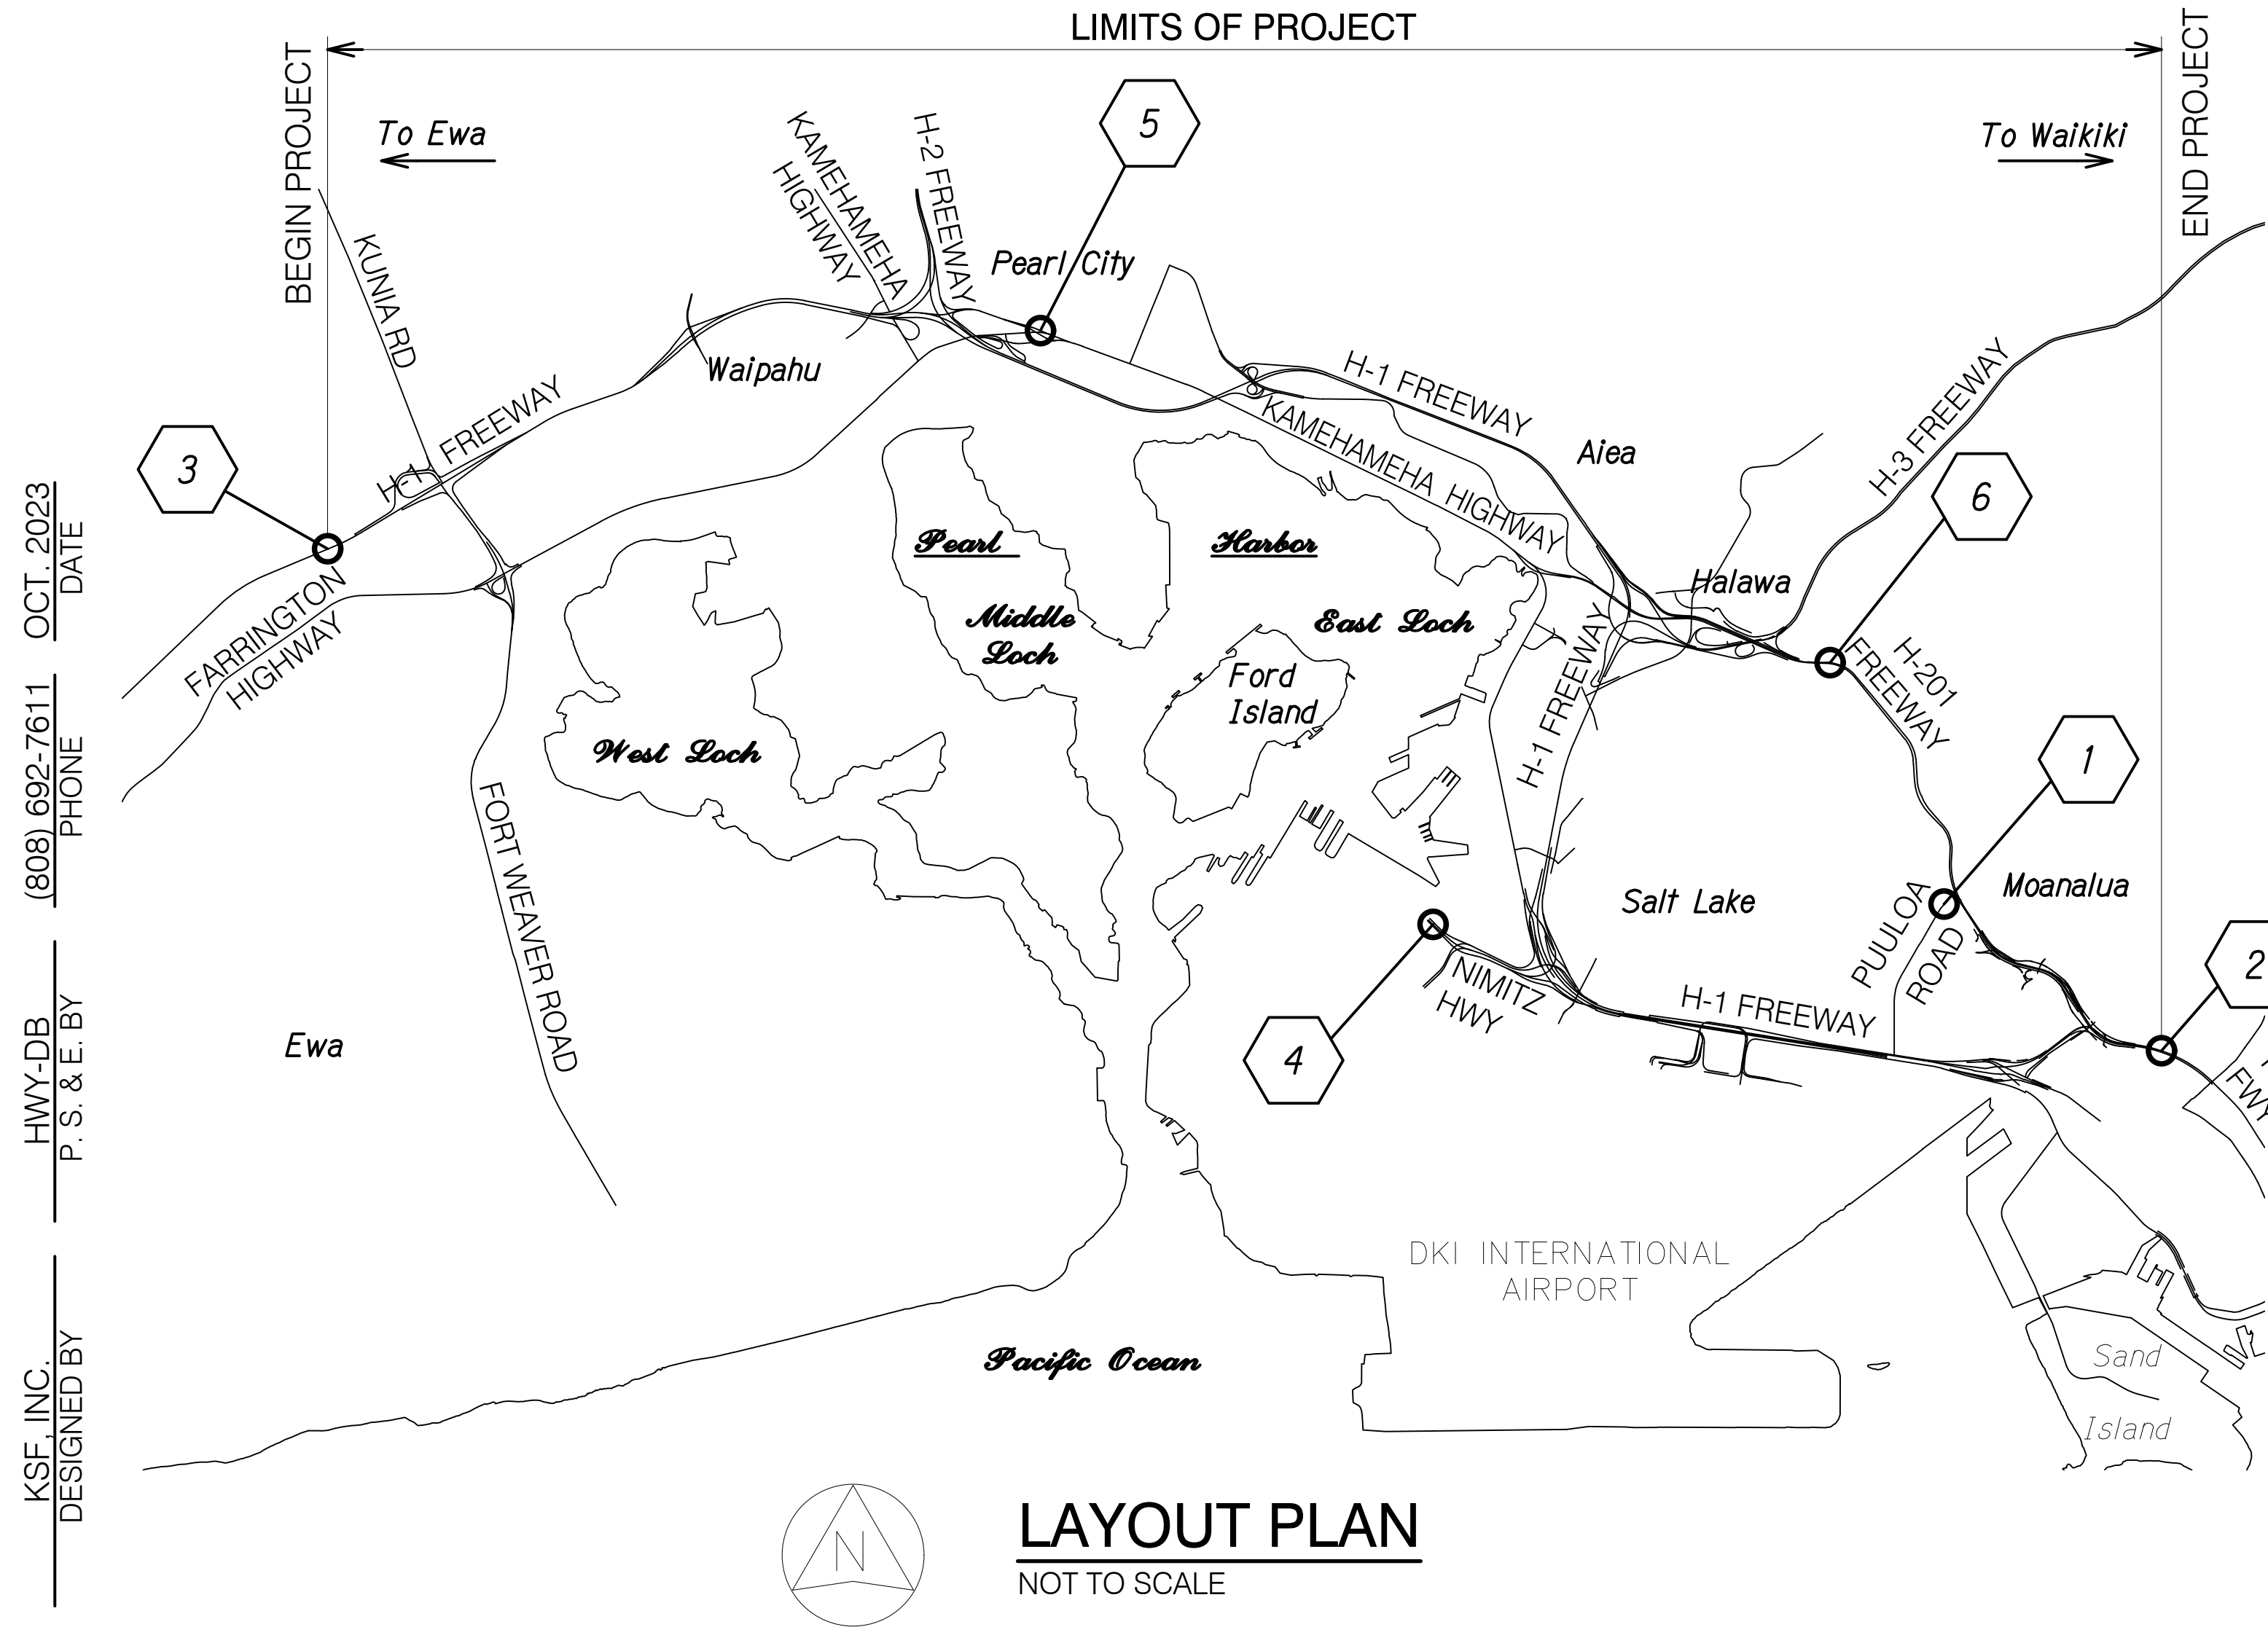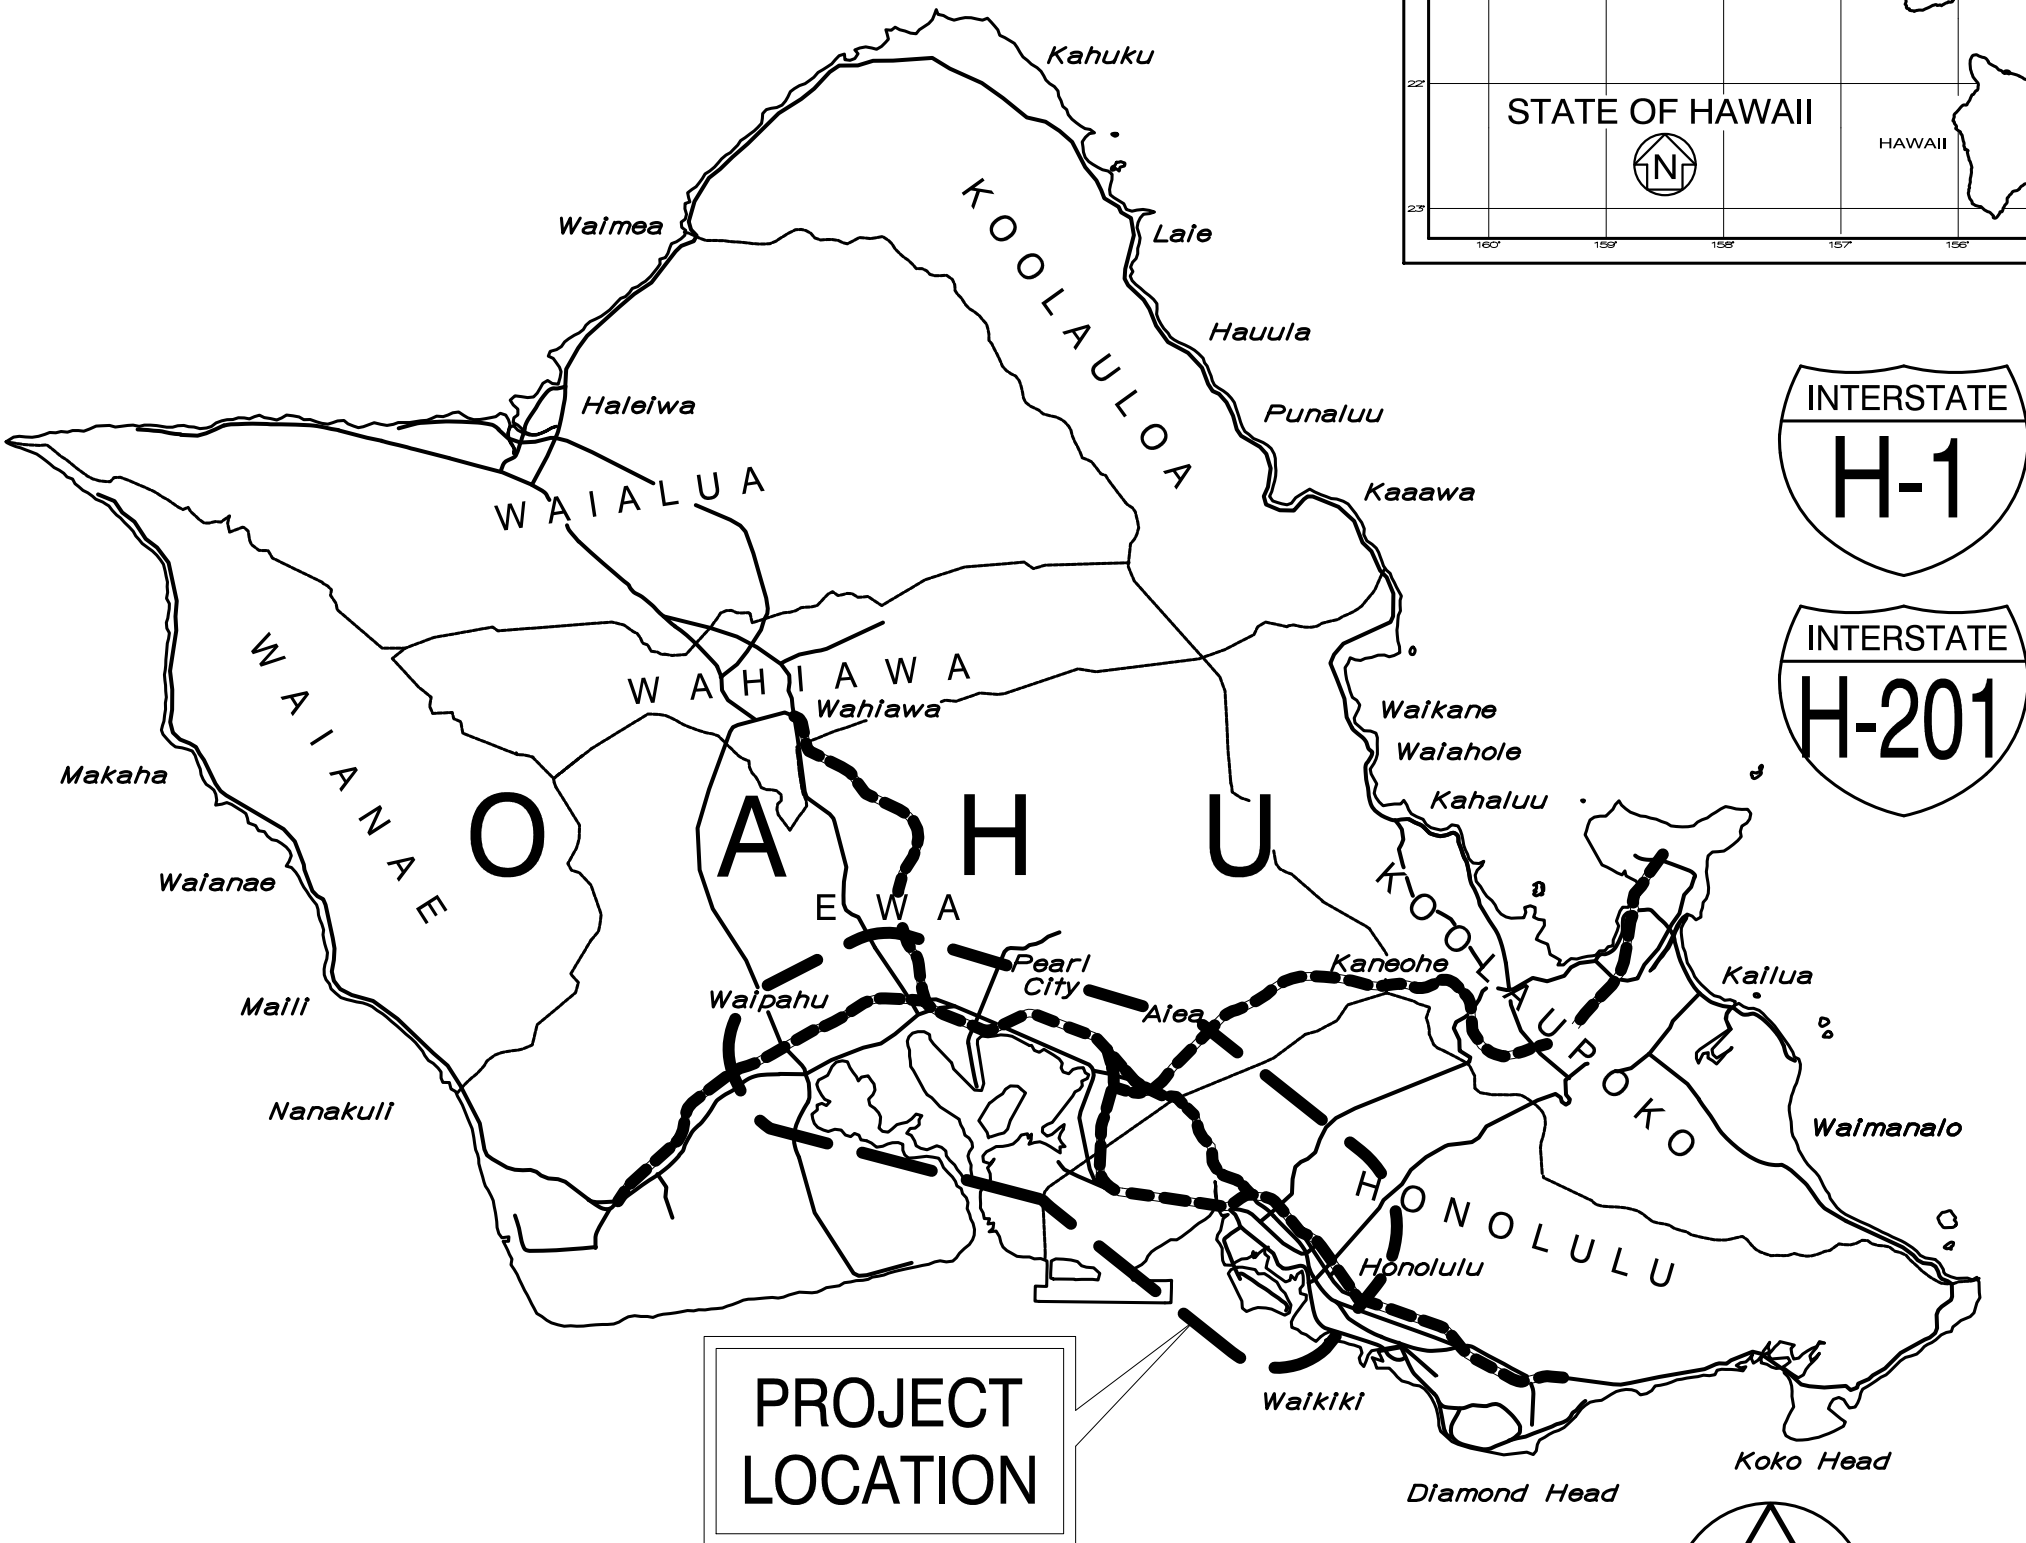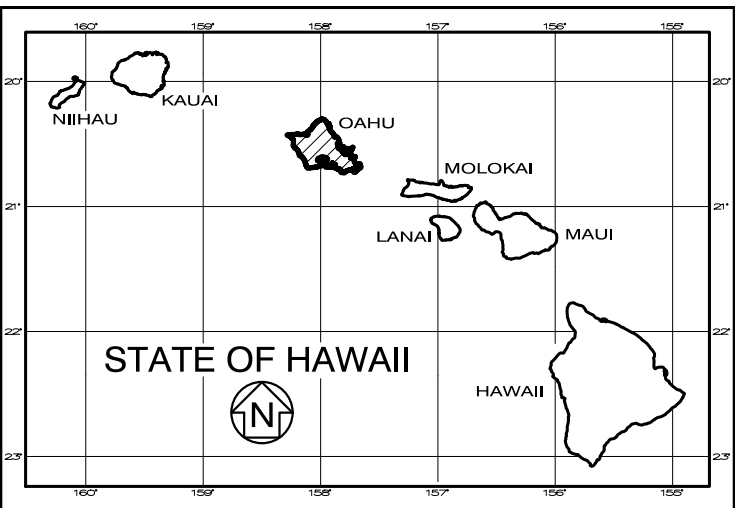

- 1
- SIGN H201R - 874
ROUTE 7310
PUULOA ROAD, NORTHBOUND
BEGIN MILEPOST = 0.74
END MILEPOST = 0.74
- 2
- SIGN H1WB - 421
INTERSTATE ROUTE H-1
WESTBOUND
BEGIN MILEPOST = 19.39
END MILEPOST = 19.39
- 3
- SIGN H1EB - 104
INTERSTATE ROUTE H-1
EASTBOUND
BEGIN MILEPOST = 4.59
END MILEPOST = 4.59
- 4
- SIGN H1EBR - 260
ROUTE 92
KAM-NIMITZ HIGHWAY
BEGIN MILEPOST = 0.10
END MILEPOST = 0.10
- 5
- SIGN H2NBR - 722
ROUTE 99
KAMEHAMEHA HIGHWAY
BEGIN MILEPOST = 17.8
END MILEPOST = 17.8
- 6
- SIGN 78WB - 853
INTERSTATE ROUTE H-201
MOANALUA FREEWAY
BEGIN MILEPOST = 1.55
END MILEPOST = 1.55

1	2	3	4	5	6
RTE. 7310	INTERSTATE RTE. H-1 WB	INTERSTATE RTE. H-1 EB	RTE. 92	RTE. 99	INTERSTATE RTE. H-201

2023 ADT	24,200	113,400	63,100	11,300	22,900	83,800
2033 ADT	26,200	127,700	74,300	12,300	23,600	88,100
2043 ADT	28,100	141,900	85,400	13,300	24,000	92,200
2033 DHV	2,090	8,940	5,570	2,710	2,120	6,610
2043 DHV	2,250	9,930	6,410	2,930	2,160	6,920
Des K	8.0	7.0	7.5	22.0	9.0	7.5
Des D	100/0	100/0	100/0	100/0	100/0	100/0
Des T	5.5	4.0	7.0	7.5	1.0	3.5
T24	6.5	4.0	7.5	9.0	2.5	4.0

DEPARTMENT OF TRANSPORTATION

STATE OF HAWAII

APPROVED:

For

Nov 24, 2023

DATE