




FED. ROAD DIST. NO.	STATE	PROJECT NO.	FISCAL YEAR	SHEET NO.	TOTAL SHEETS
HAWAII	HAW.	STP-1500(35)	2008	34	41

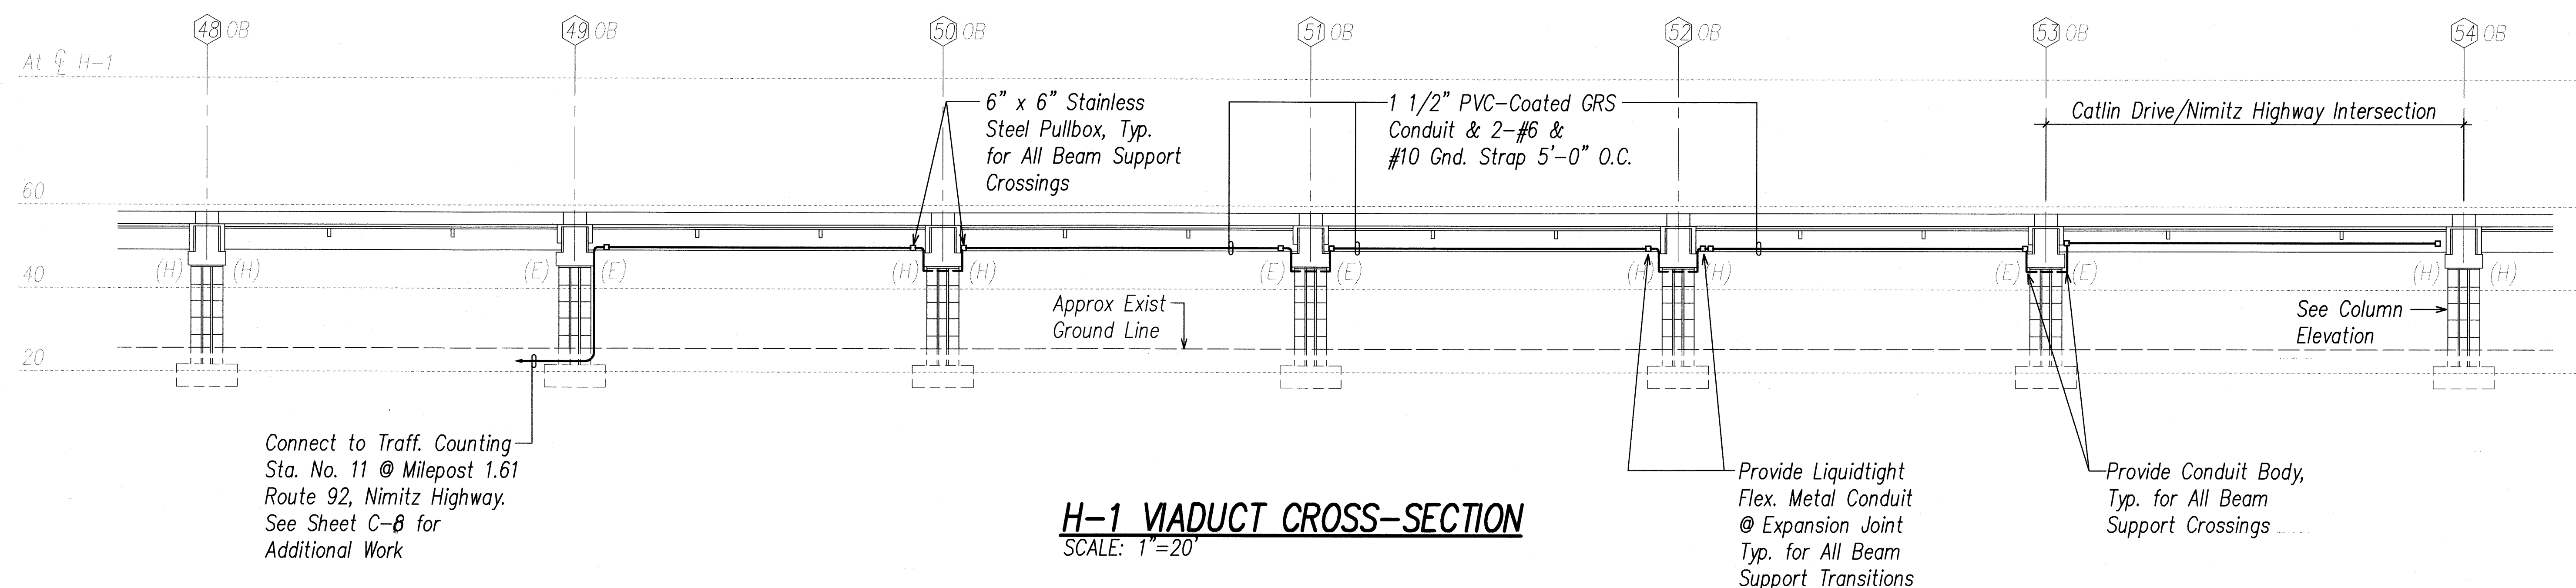



H-1 VIADUCT CROSS-SECTION
SCALE: 1"=20'

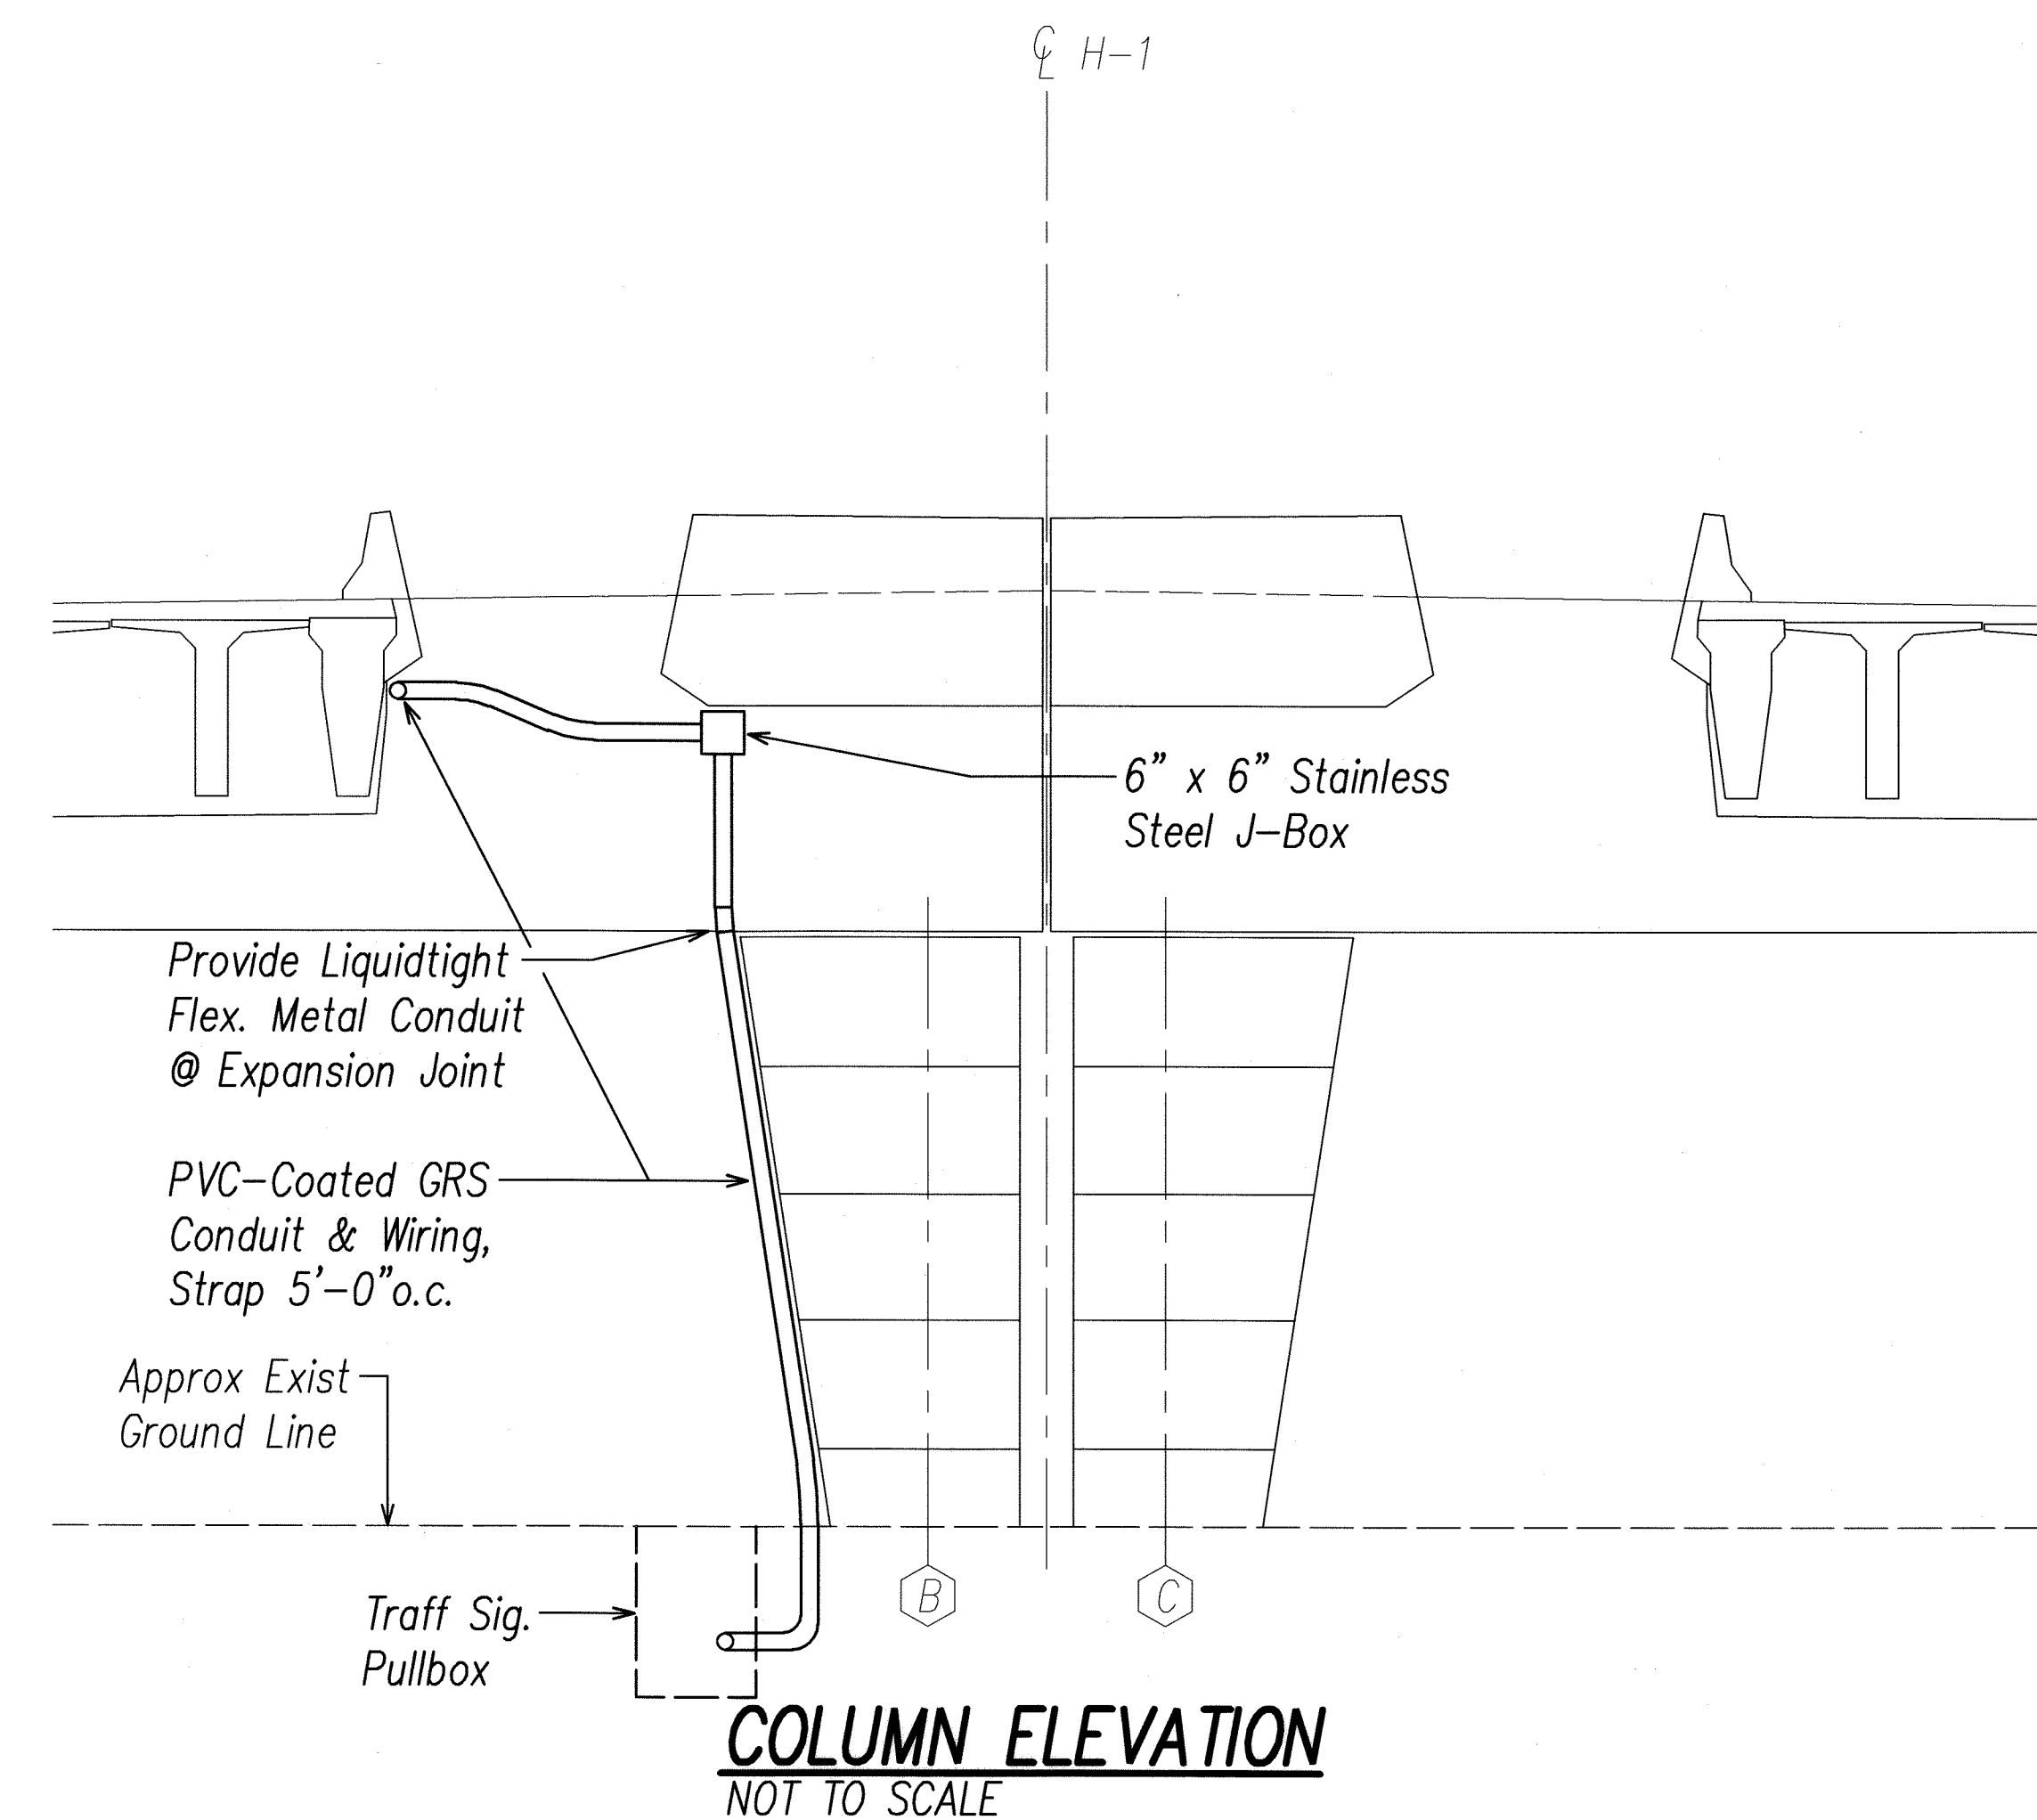

COLUMN ELEVATION
NOT TO SCALE

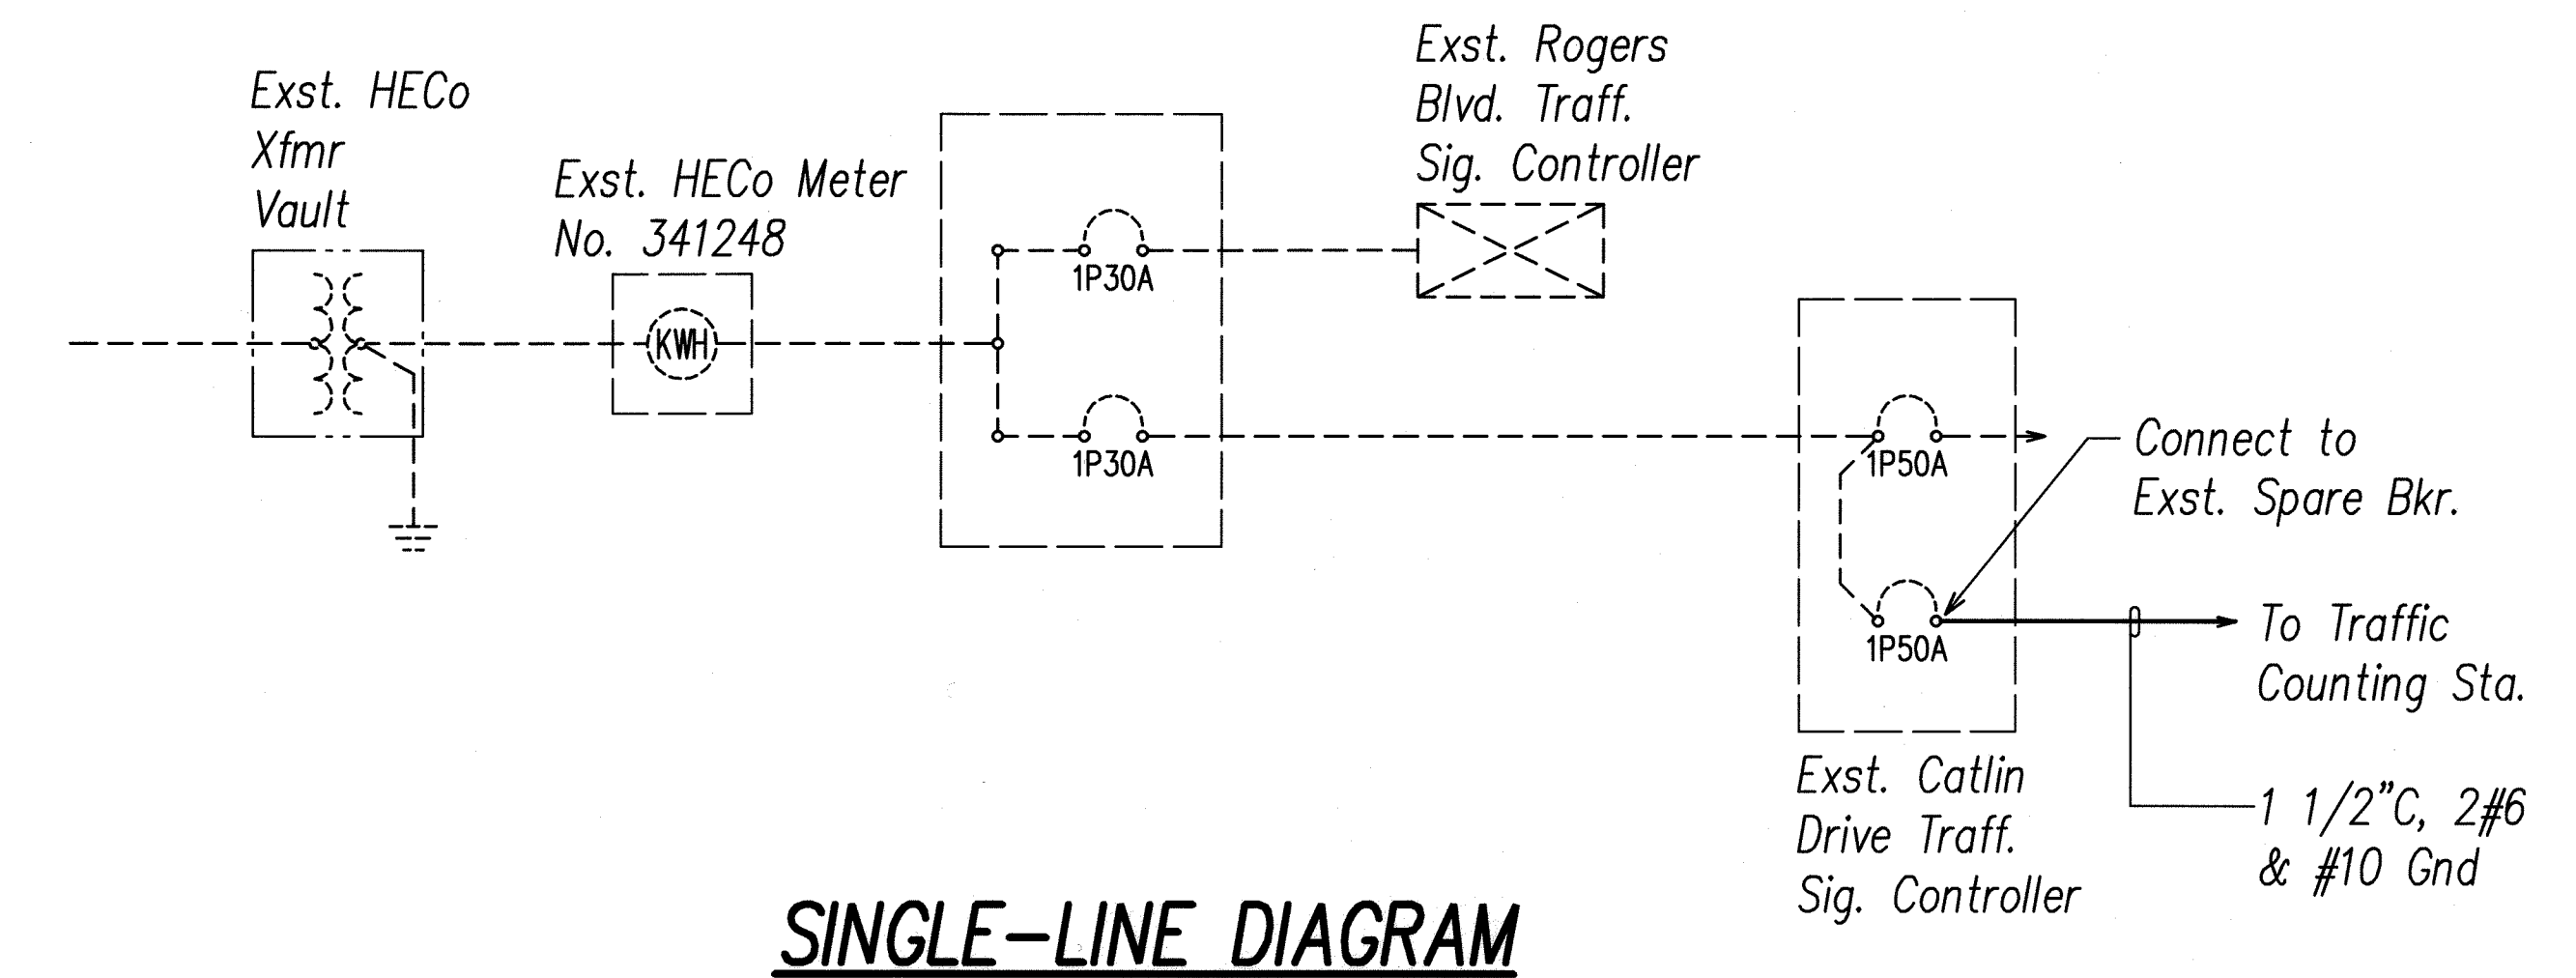

SINGLE-LINE DIAGRAM

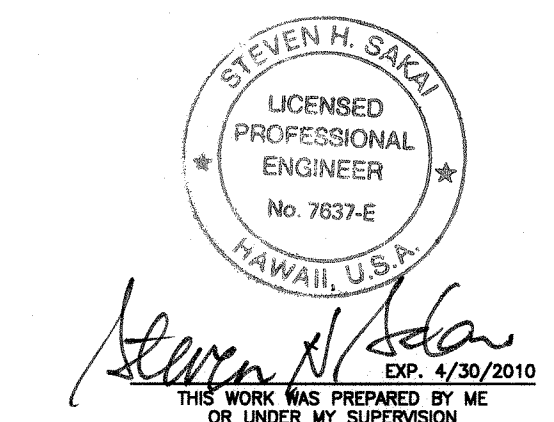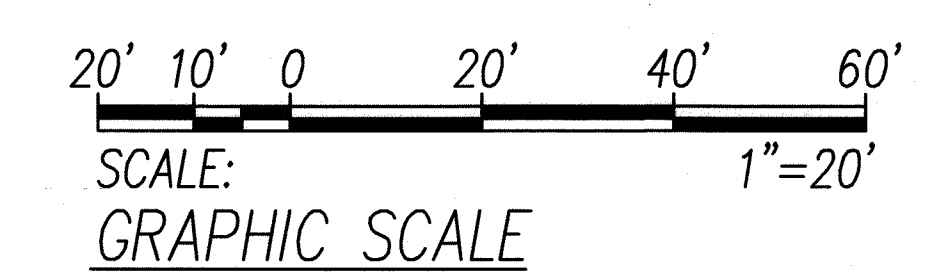

STATE OF HAWAII
DEPARTMENT OF TRANSPORTATION
HIGHWAYS DIVISION
DECK SECTIONS

TRAFFIC COUNTING STATIONS
AT VARIOUS LOCATIONS
F.A.P. NO. STP-1500(35)
Scale: As Noted Date: June 2008

SURVEY PLOTTED BY	DATE
DRAWN BY	
TRACED BY	
CHECKED BY	
QUANTITIES BY	
CHECKED BY	
ORIGINAL PLAN	
NOTE BOOK	
No.	

LAST REV. 06/17/08 BY UC 4439 BY RN PLOT 5/1/10
2. QUANTITIES CHECKED BY UC 4439 BY RN PLOT 5/1/10
3. JKH-DECK-SECTIONS