

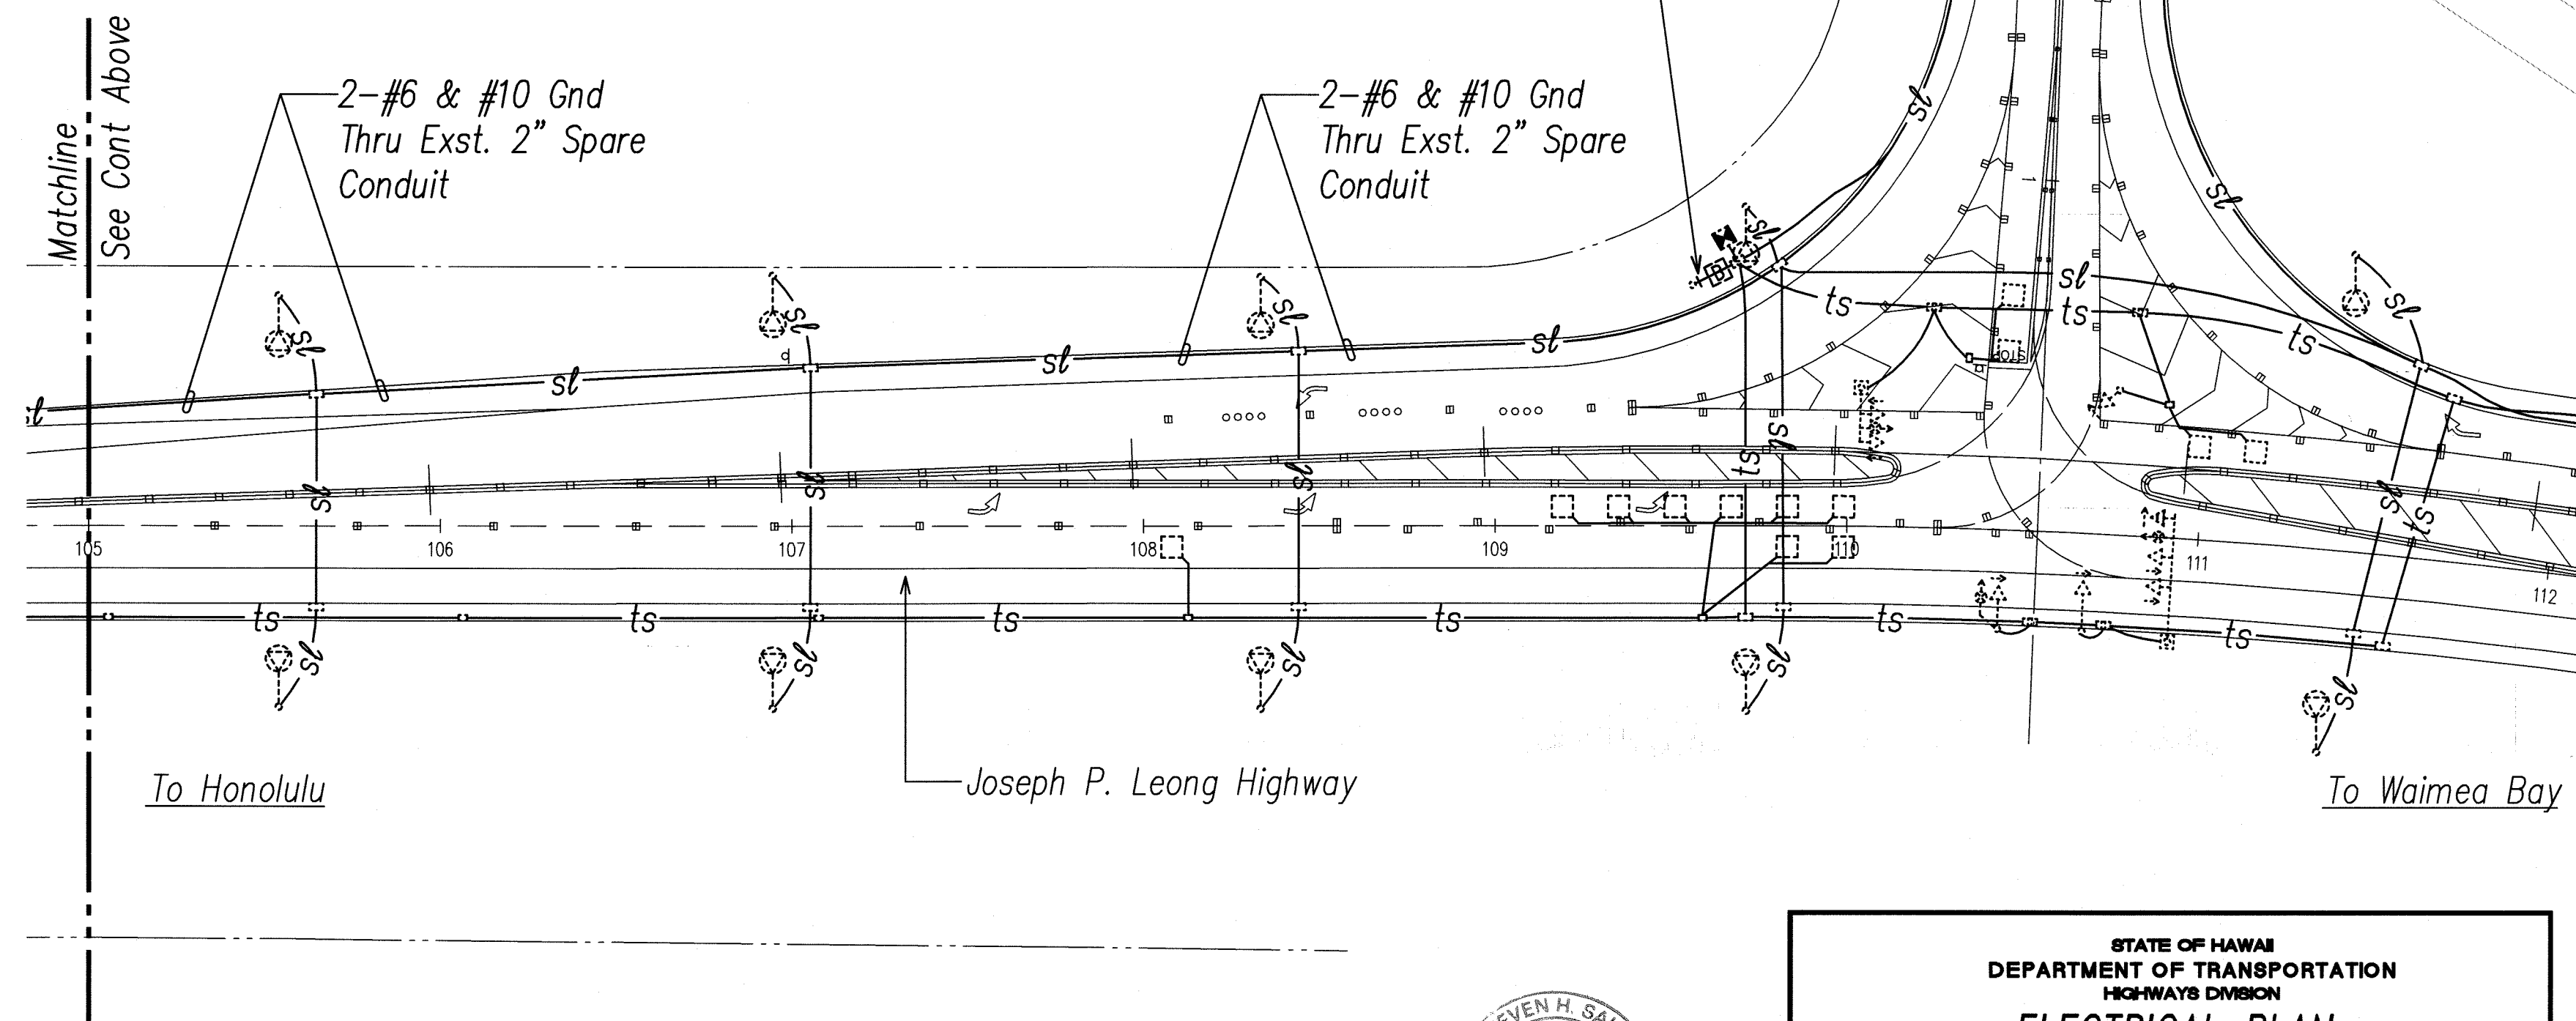
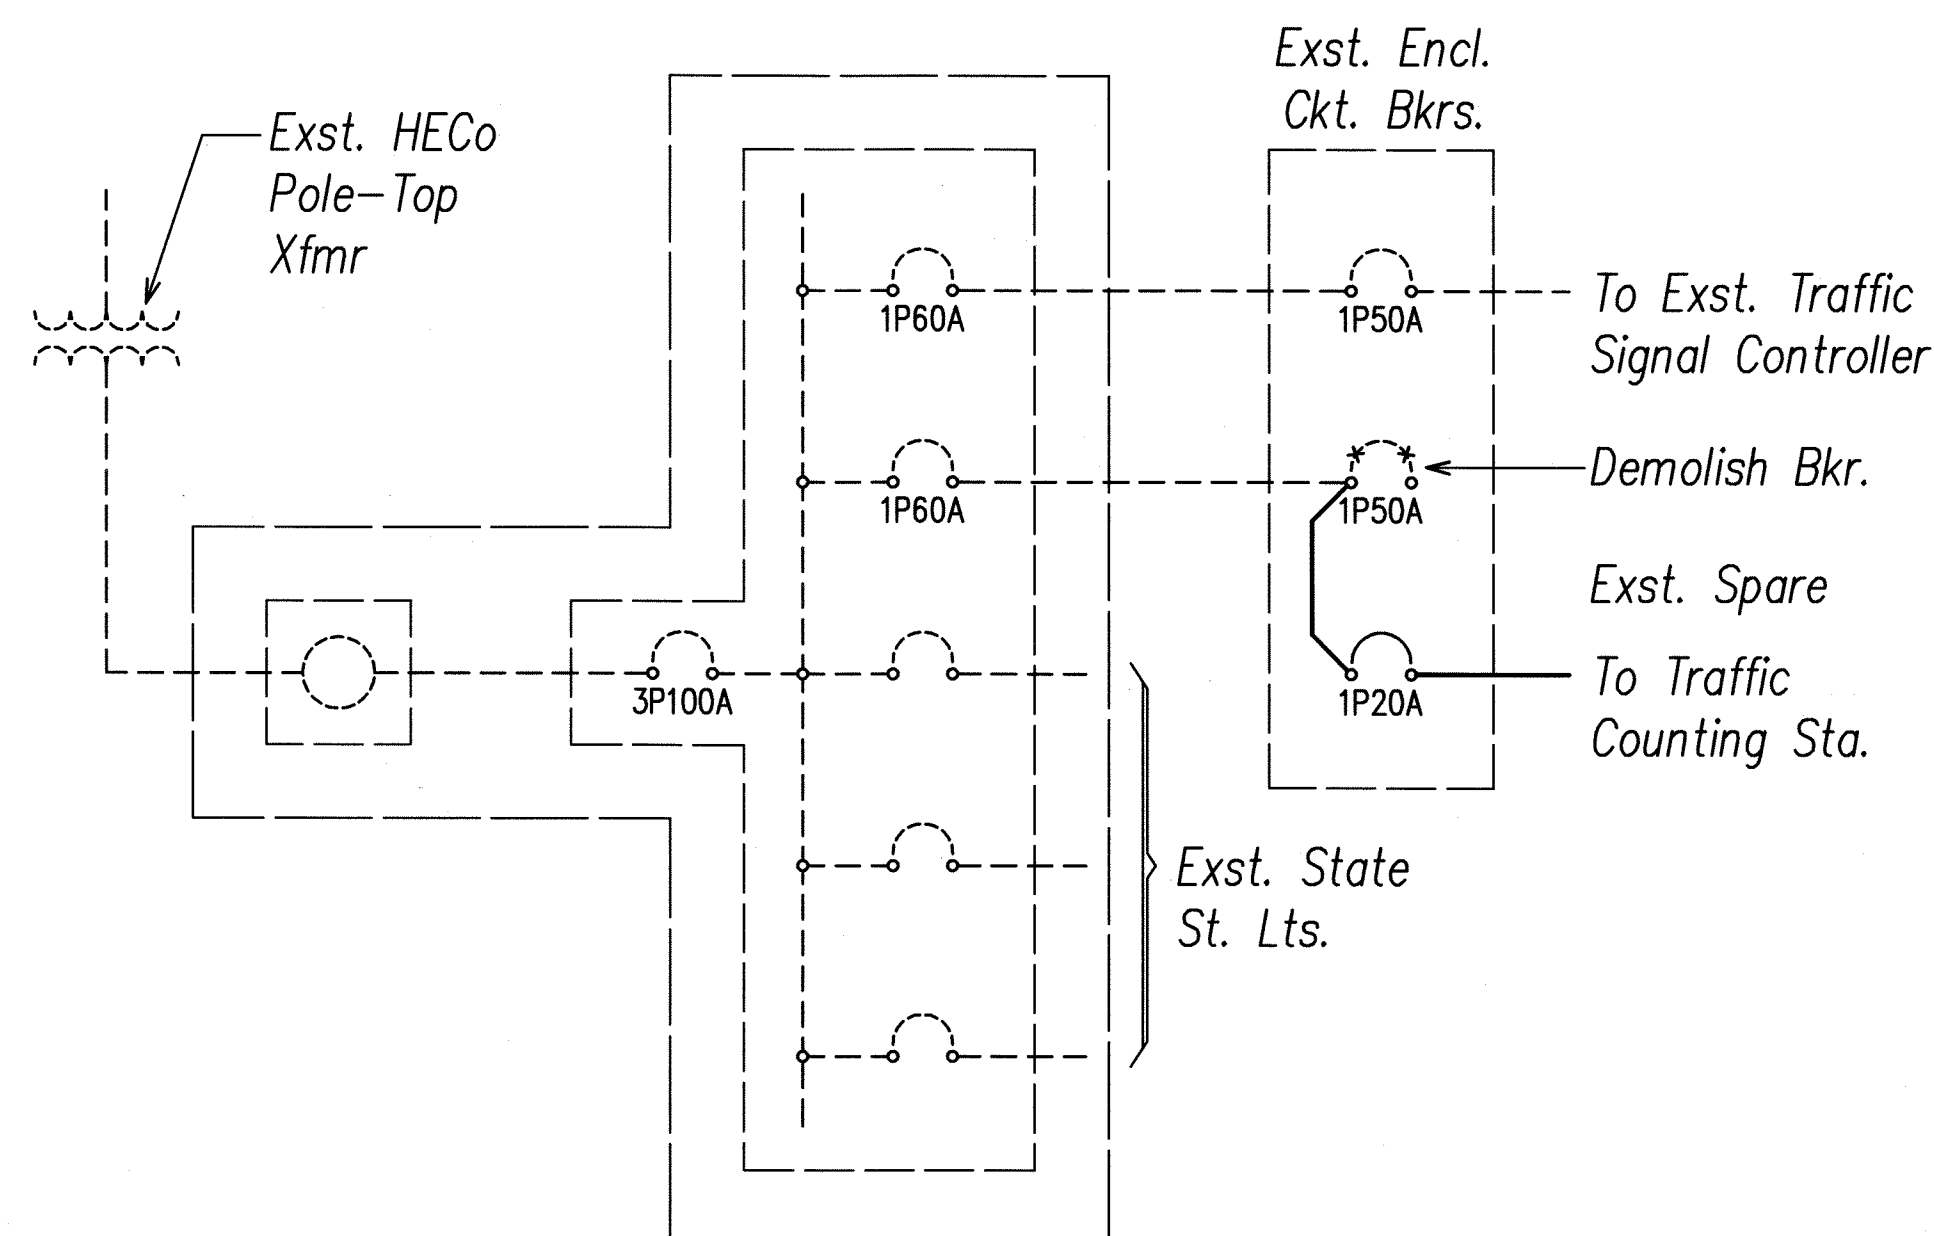
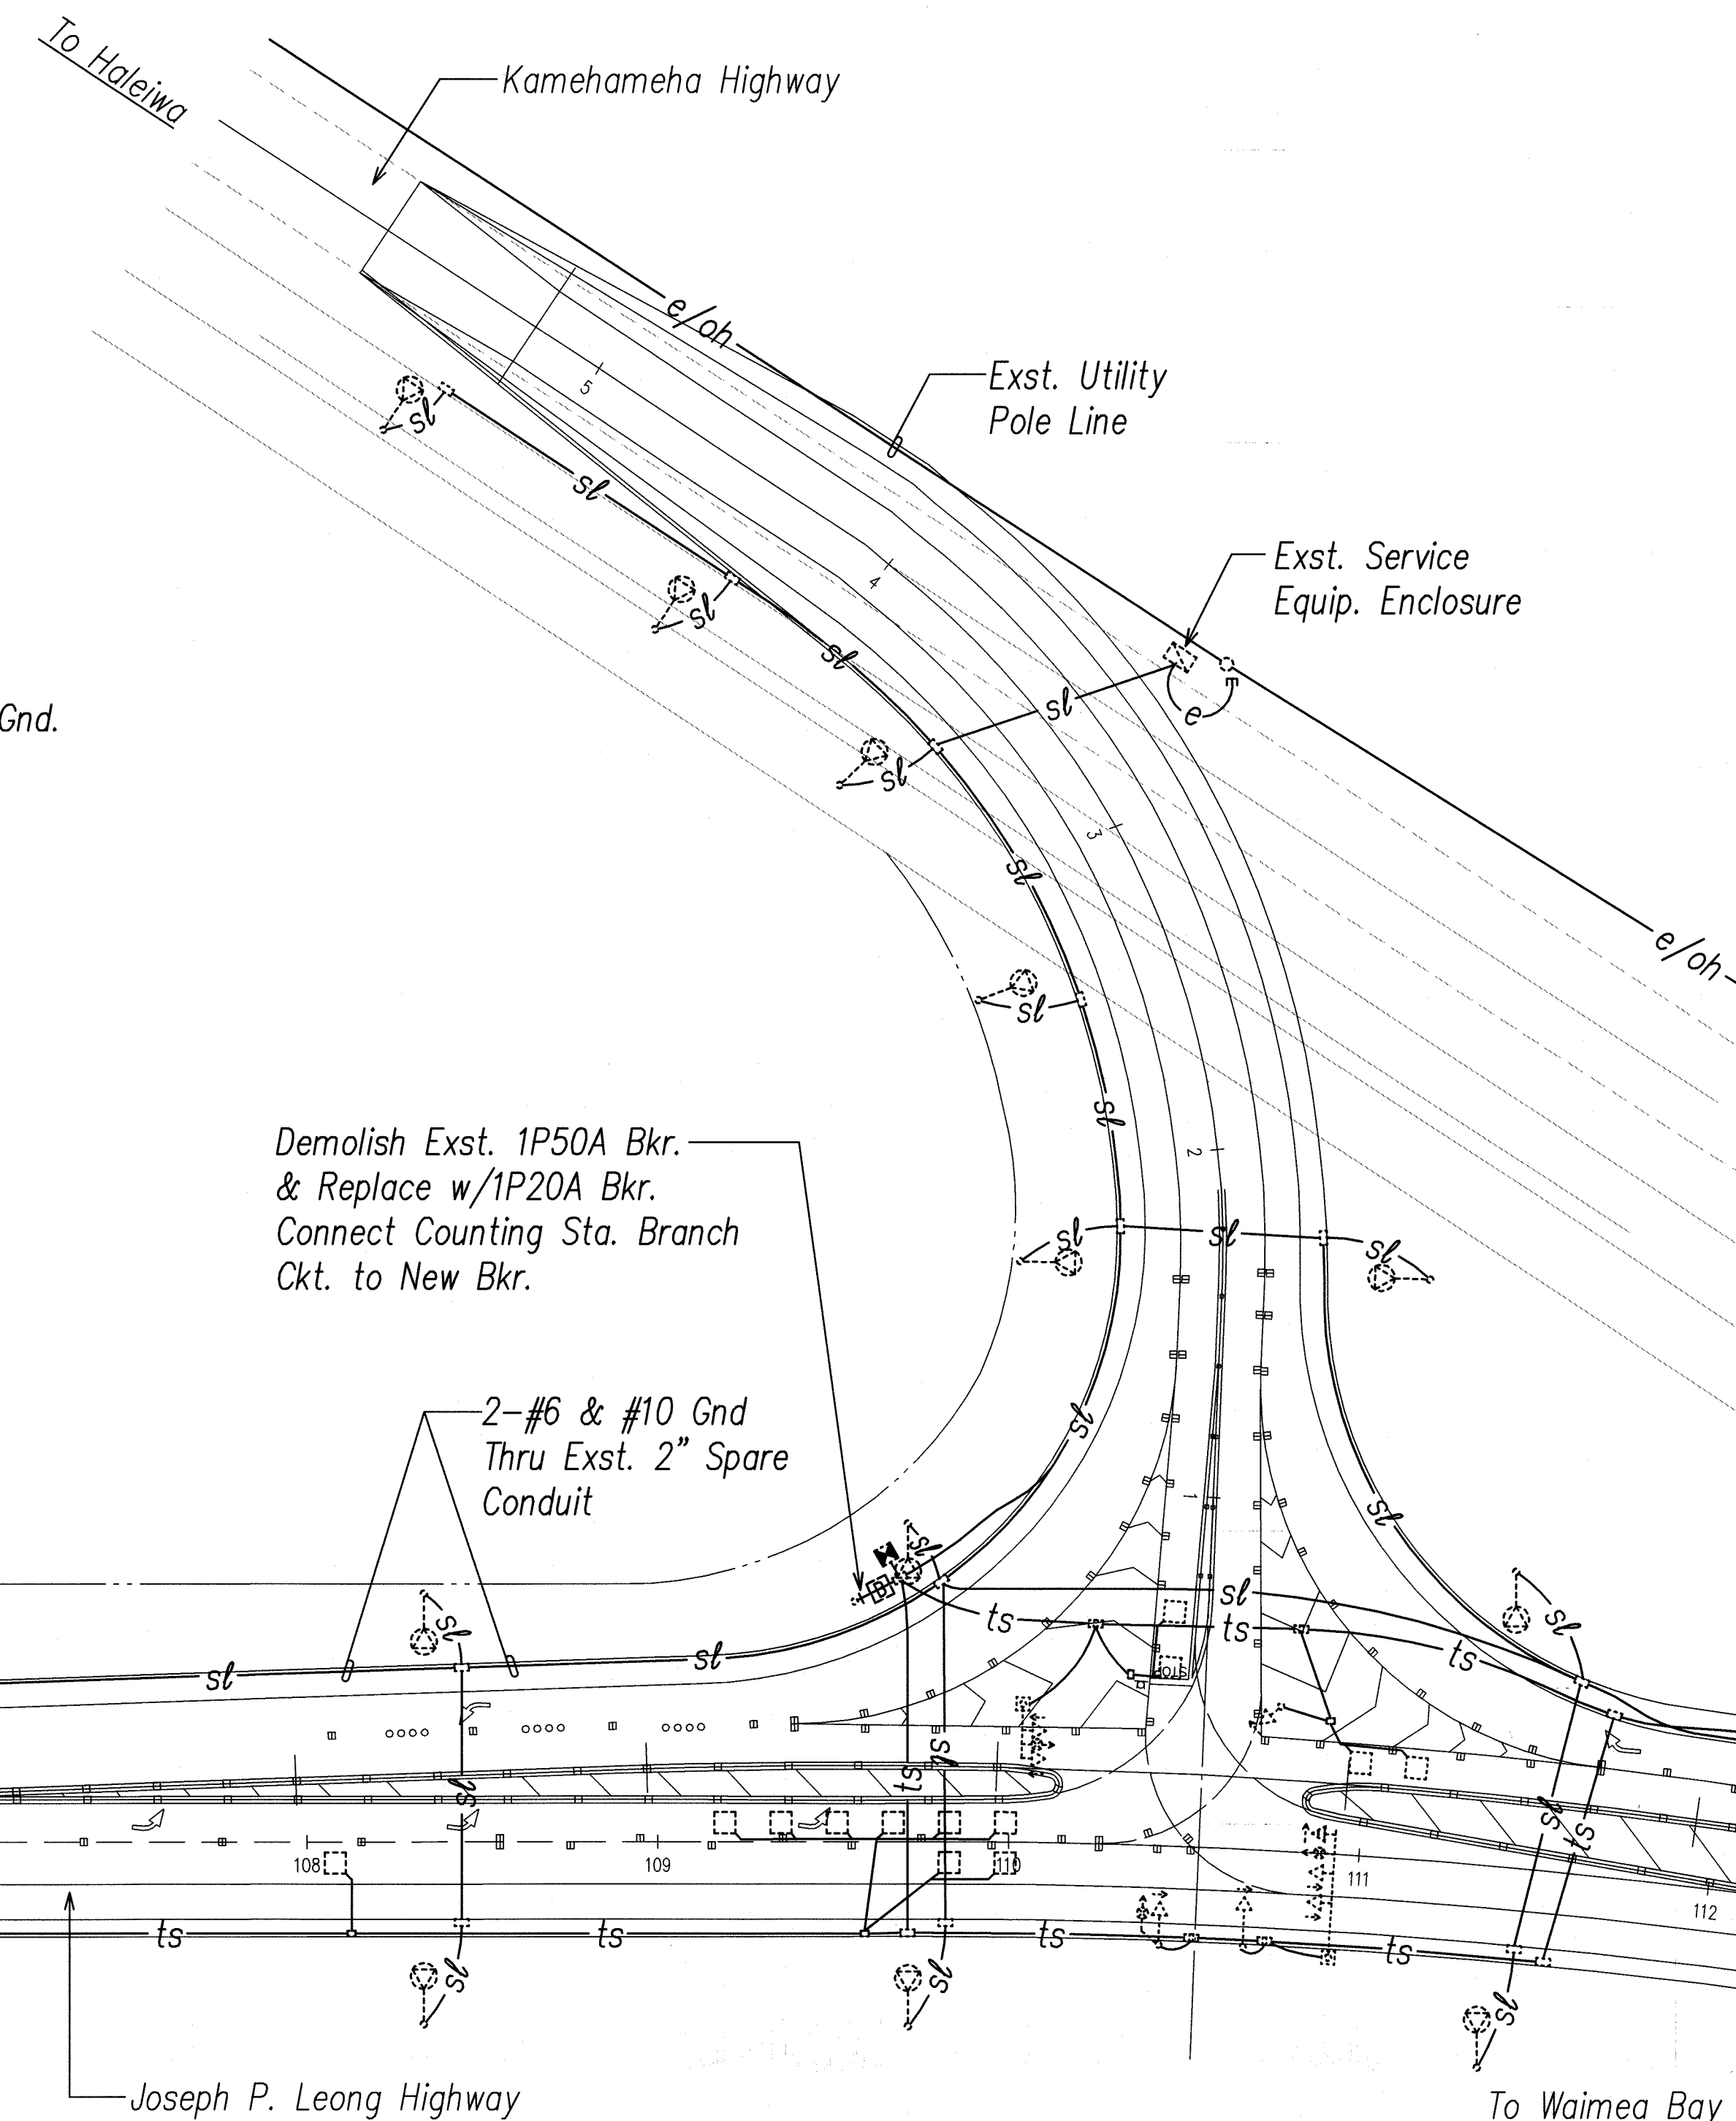


FED. ROAD DIST. NO.	STATE	PROJECT NO.	FISCAL YEAR	SHEET NO.	TOTAL SHEETS
HAWAII	HAW.	STP-1500(35)	2008	32	41


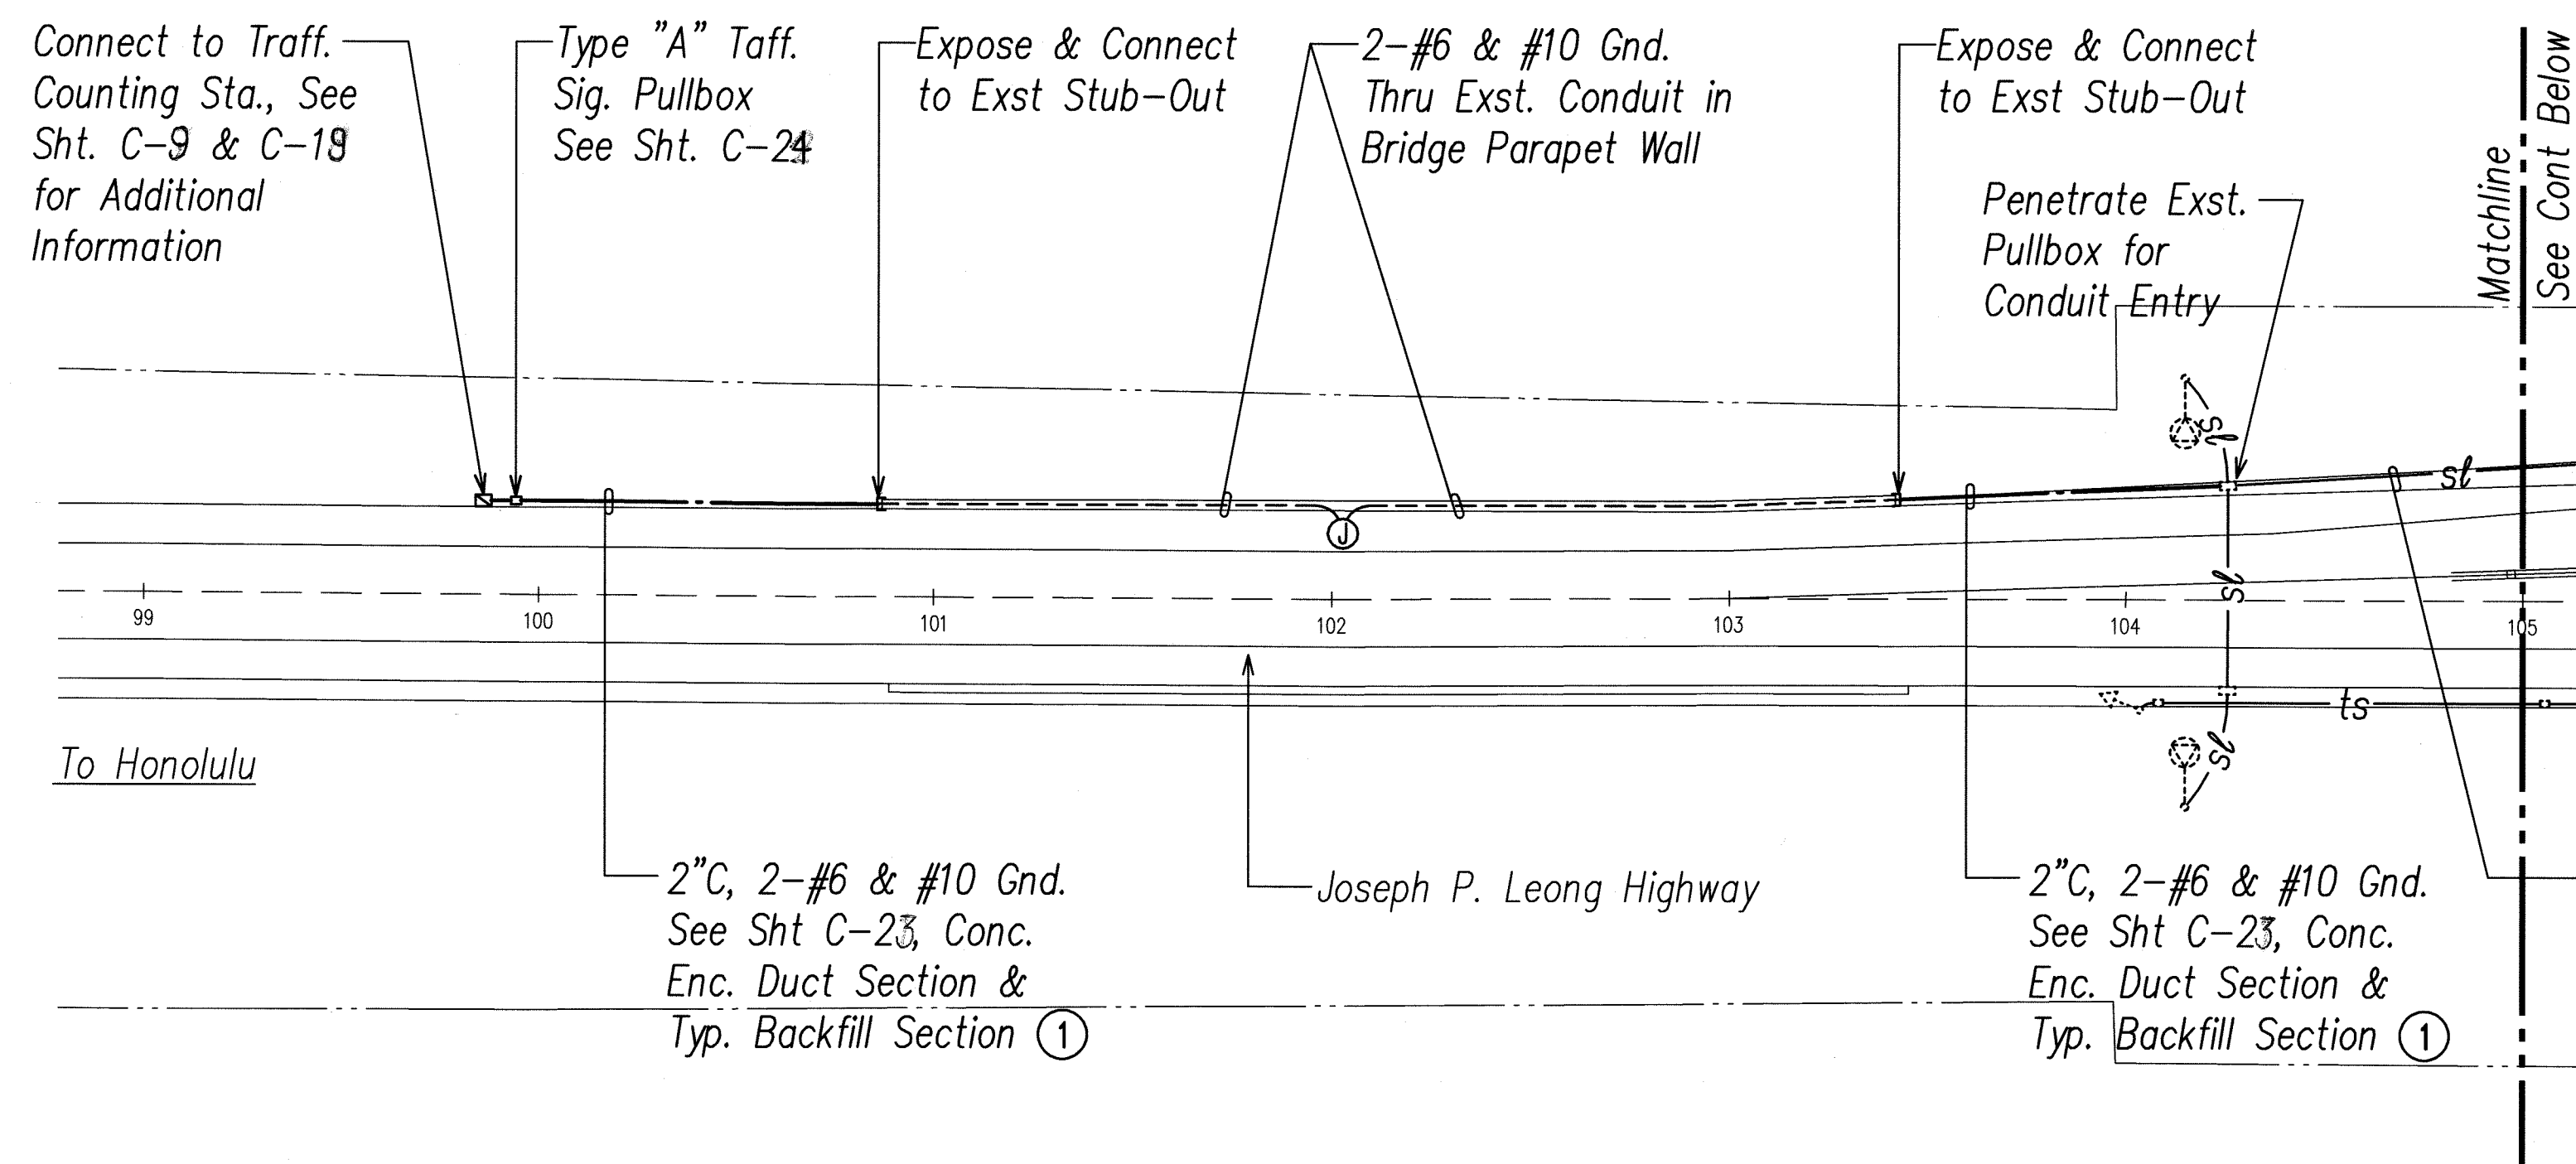


SURVEY PLOTTED BY	DATE
DRAWN BY	
TRACED BY	
QUANTITIES BY	
CHECKED BY	
NO.	

LAST SAVE: 06/17/08 10:34:49 BY: JN PLOT SET: 1-40
 C:\WORK\PROJECTS\STP-1500(35)\ELECTRICAL\JOSEPH LEONG HWY ST-1500-BACKGROUND_XBRI-ALL-ELEC

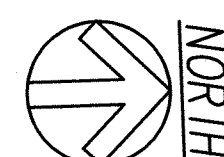

**JOSEPH P. LEONG HIGHWAY
 ROUTE 83, M.P. 1.630, OAHU
 ELECTRICAL PLAN**
 SCALE: 1"=40'

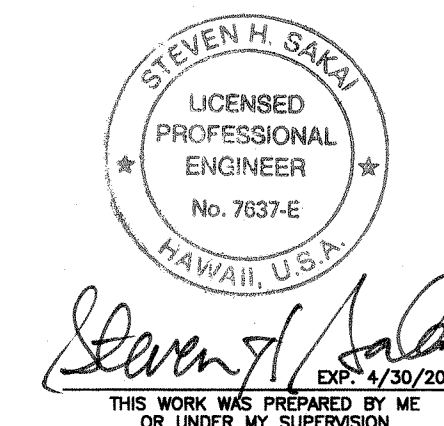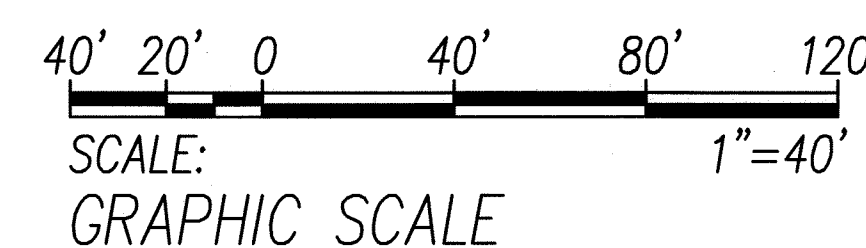

STATE OF HAWAII
 DEPARTMENT OF TRANSPORTATION
 HIGHWAYS DIVISION


ELECTRICAL PLAN

TRAFFIC COUNTING STATIONS
 AT VARIOUS LOCATIONS
 F.A.P. NO. STP-1500(35)

Scale: As Noted Date: June 2008

SHEET No. E-1 OF 7 SHEETS

FED. ROAD DIST. NO.	STATE	PROJECT NO.	FISCAL YEAR	SHEET NO.	TOTAL SHEETS
HAWAII	HAW.	STP-1500(35)	2008	33	41

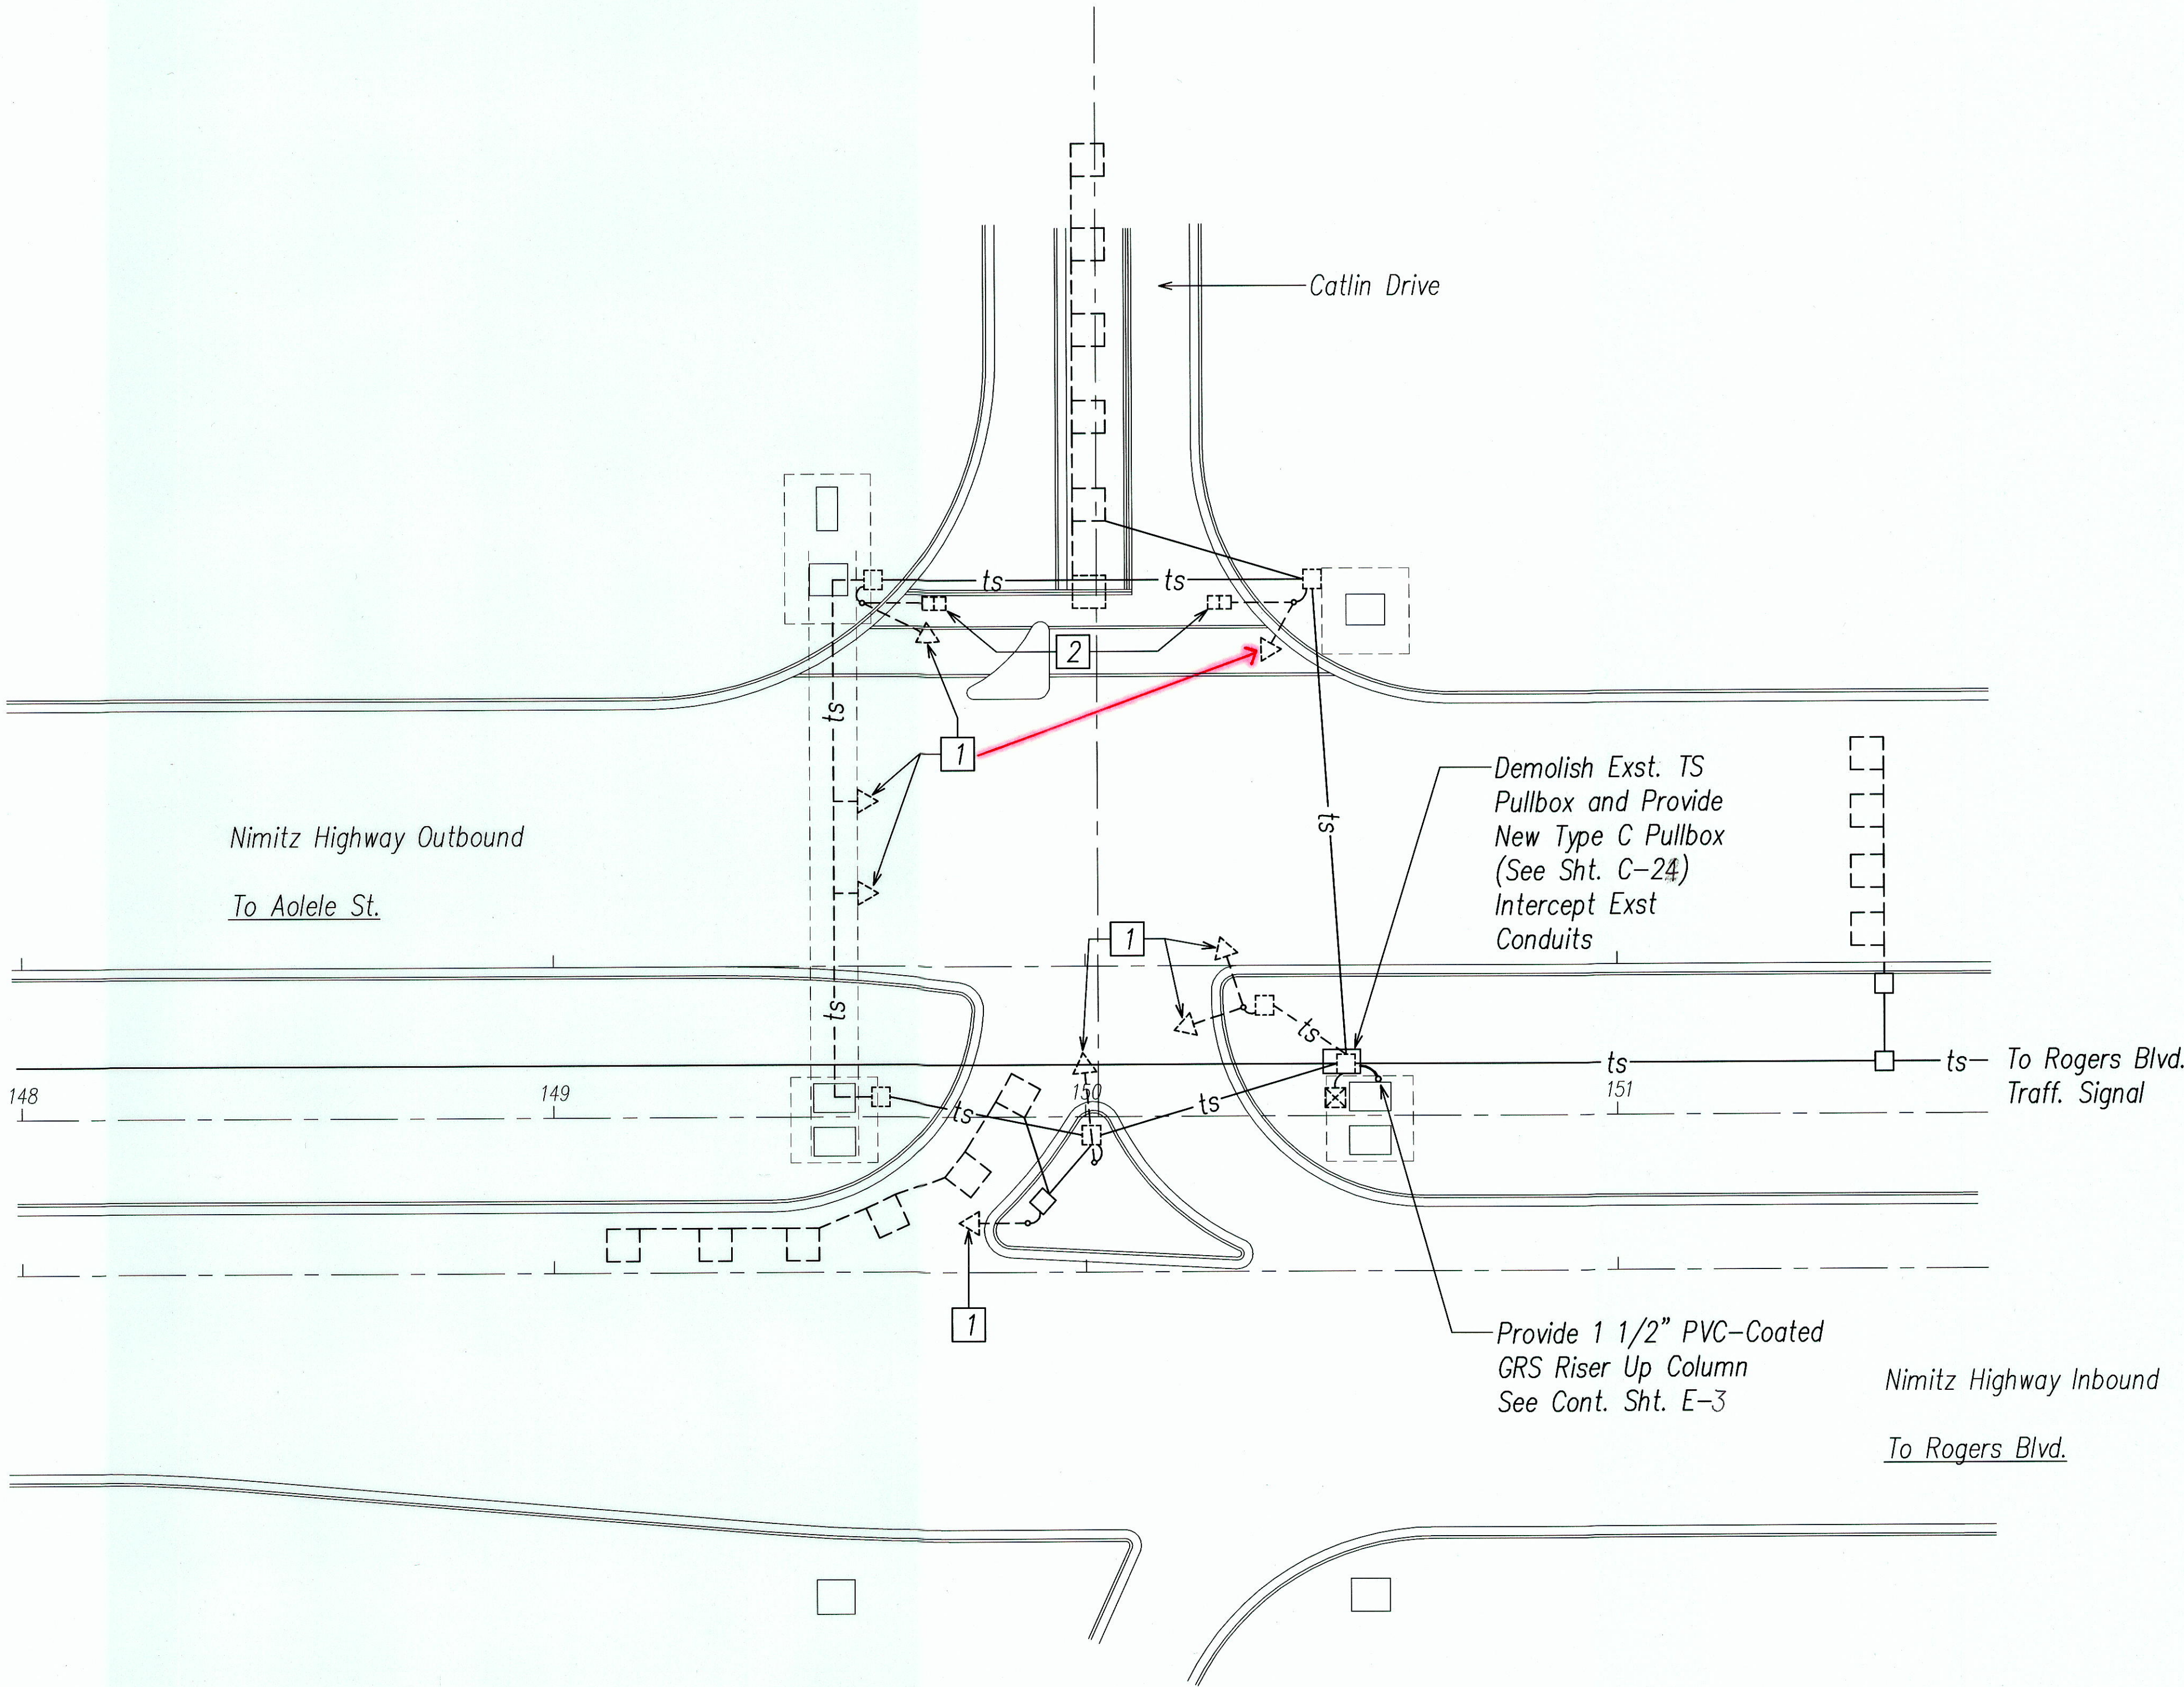



- NOTES:
- Replace Exst. Incandescent Red-Yellow-Green (R-Y-G) Lamps with LED Lamps. Contractor Shall Field Verify Quantity and Type of Lamps (i.e. Green Ball vs. Green Arrow) Prior to ordering replacement Lamps. Lawfully Dispose of Lamps.
 - Remove Exst. PED Signal Heads. Provide LED Count-down PED Signals. Salvage PED Signals and Deliver to City Dept. of Transportation Svcs. Baseyard in Manana.

ORIGINAL PLAN	DATE
DESIGNED BY	
CHECKED BY	
NOTED BY	
NO.	

LAST SAVE: 08/17/08 @ 03:44:47 PM BY: JN PLOT: 00 1-20
Z:\VADO\PROJECTS\2003\1E-02_26037_Plan02.dwg XREF: XREF-PARTIAL-INTERSECTION



STATION NUMBER 11, ROUTE 92
MP 1.61, OAHU
ELECTRICAL PLAN
 SCALE: 1"=20'

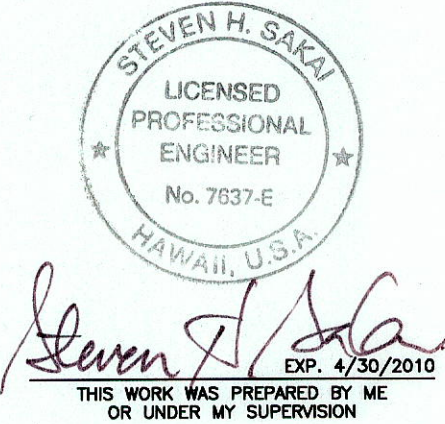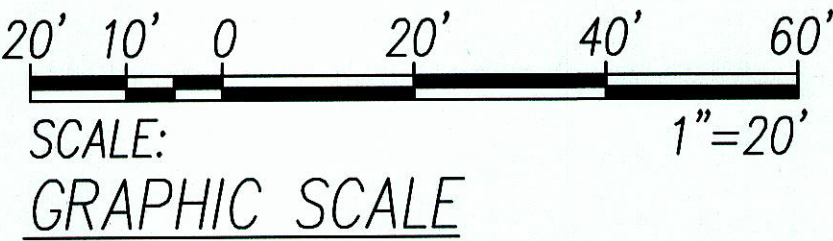

STATE OF HAWAII
DEPARTMENT OF TRANSPORTATION
HIGHWAYS DIVISION
ELECTRICAL PLAN

TRAFFIC COUNTING STATIONS
AT VARIOUS LOCATIONS
F.A.P. NO. STP-1500(35)
Scale: As Noted Date: June 2008

SHEET No. E-2 OF 7 SHEETS

"AS-BUILT"