


INDEX TO DRAWINGS	
SHEET NO.	DESCRIPTION
1	TITLE SHEET
2	STANDARD PLANS SUMMARY
3	CONSTRUCTION NOTES AND LEGEND
4-7	CONSTRUCTION NOTES
8-11	GENERAL PLAN
12-13	TRAFFIC COUNTING STATION PLANS - KAUAI
14-17 ①	TRAFFIC COUNTING STATION PLANS - OAHU
18-20	TRAFFIC COUNTING STATION PLANS - HAWAII
21-24	TRAFFIC COUNTING STATION PLANS - MAUI
25	TRAFFIC COUNTING STATION PLANS - LANAI
26-29	TRAFFIC COUNTING STATION DETAILS
30	TRENCH DETAILS
31	PULLBOX DETAILS
32-33	ELECTRICAL PLAN
34	DECK SECTION
35	HECO AND HTO SERVICE DETAILS
36	HELCO AND HTO SERVICE DETAILS
37	KIUC AND HTO SERVICE DETAILS
38	MECO AND HTO SERVICE DETAILS
39	TRAFFIC CONTROL PLANS NOTES
40-41	TRAFFIC CONTROL PLANS

Sheet No. ① C.O. 175-1 is a Supplementary Sheet to this Project. Total Sheet count After "AS-BUILT" Posting is 42 Sheets.

STATE OF HAWAII
DEPARTMENT OF TRANSPORTATION
HIGHWAYS DIVISION
HONOLULU, HAWAII
"AS-BUILT"
PLANS FOR
TRAFFIC COUNTING STATIONS AT
VARIOUS LOCATIONS
FEDERAL AID PROJECT NO. STP-1500(35)
ISLANDS OF KAUAI, OAHU, HAWAII, MAUI, AND LANAI

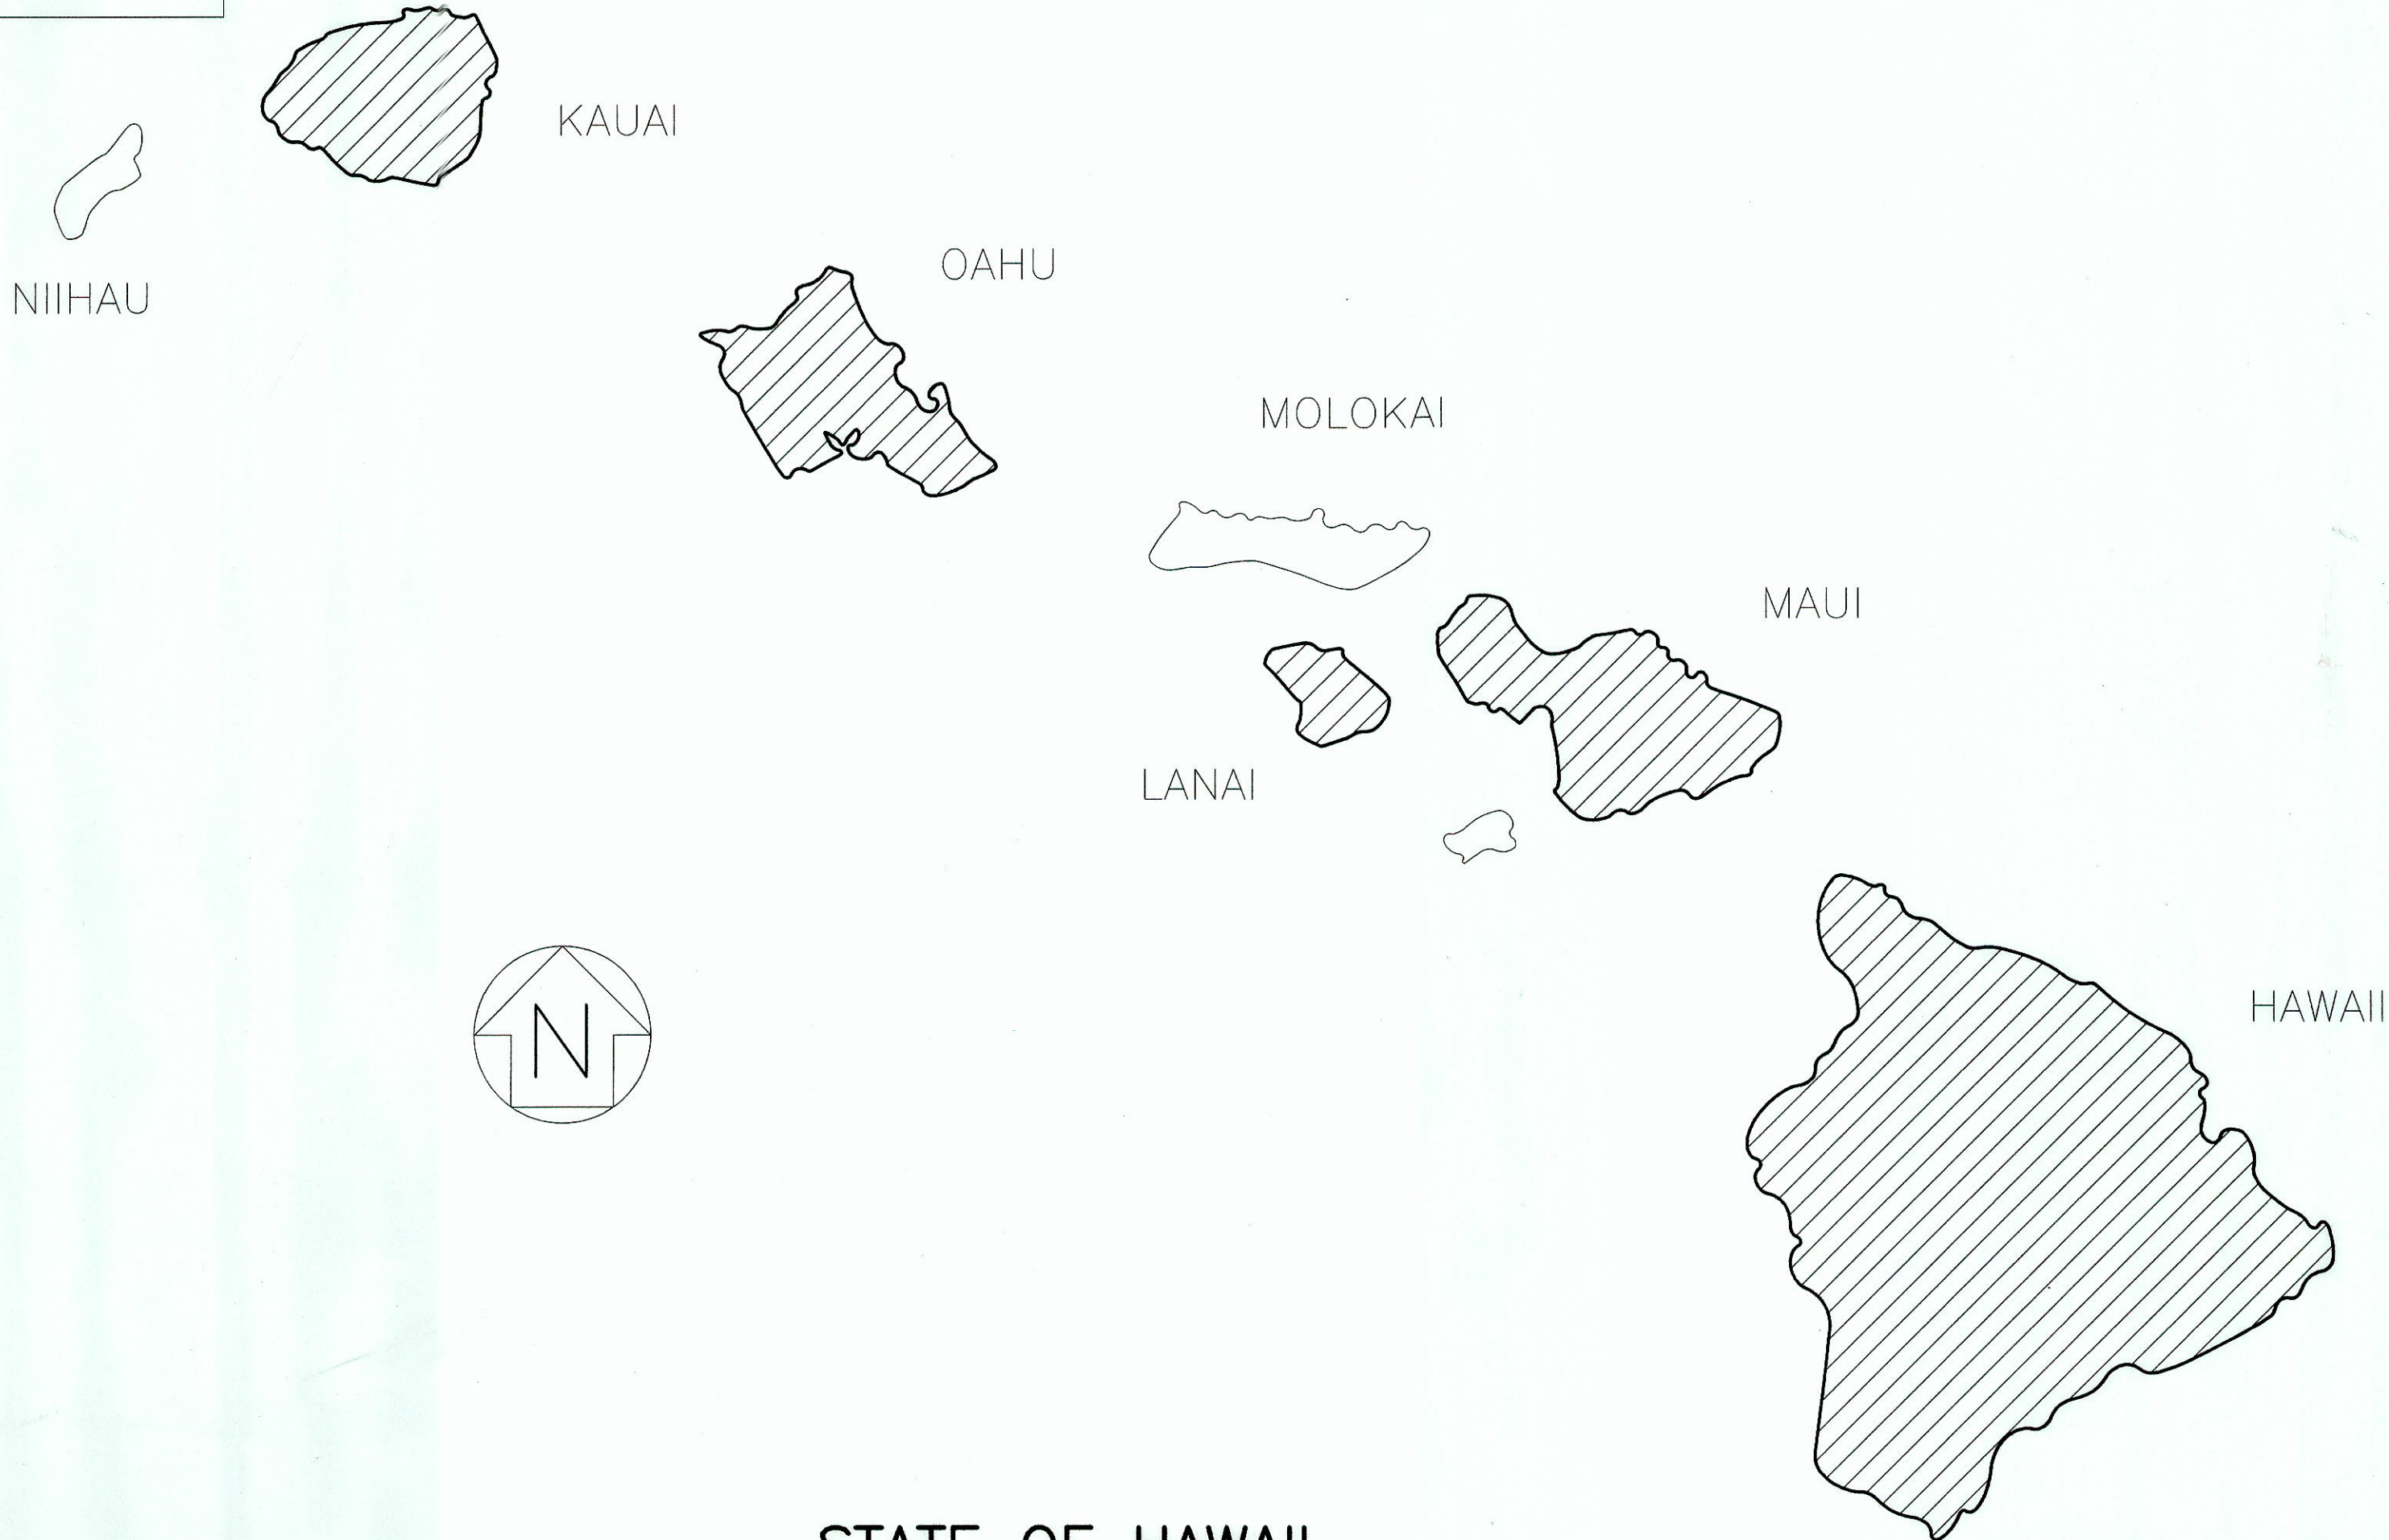

STATE OF HAWAII
NOT TO SCALE

FED. ROAD DIST. NO.	STATE	PROJECT NO.	FISCAL YEAR	SHEET NO.	TOTAL SHEETS
HAWAII	HAW.	STP-1500(35)	2008	1	41

ATA DESIGNED BY
HWY-DS 692-7544
MANAGED BY
JUNE 2008
DATE

CHANGES MADE DURING CONSTRUCTION HAVE BEEN INCORPORATED ON THESE PLANS EXCEPT CHANGES IN THE ORIGINAL THEORETICAL QUANTITIES. FOR ACTUAL QUANTITIES, REFER TO PROJECT LEDGER AND/OR COMPUTATION BOOK.

DEPARTMENT OF TRANSPORTATION STATE OF HAWAII	
APPROVED:	
<i>[Signature]</i> DIR. OF TRANSPORTATION	7-3-08 DATE