


FED. ROAD DIST. NO.	STATE	PROJ. NO.	FISCAL YEAR	SHEET NO.	TOTAL SHEETS
HAWAII	HAW.	HWY-0-02-08	2014	A2213	57

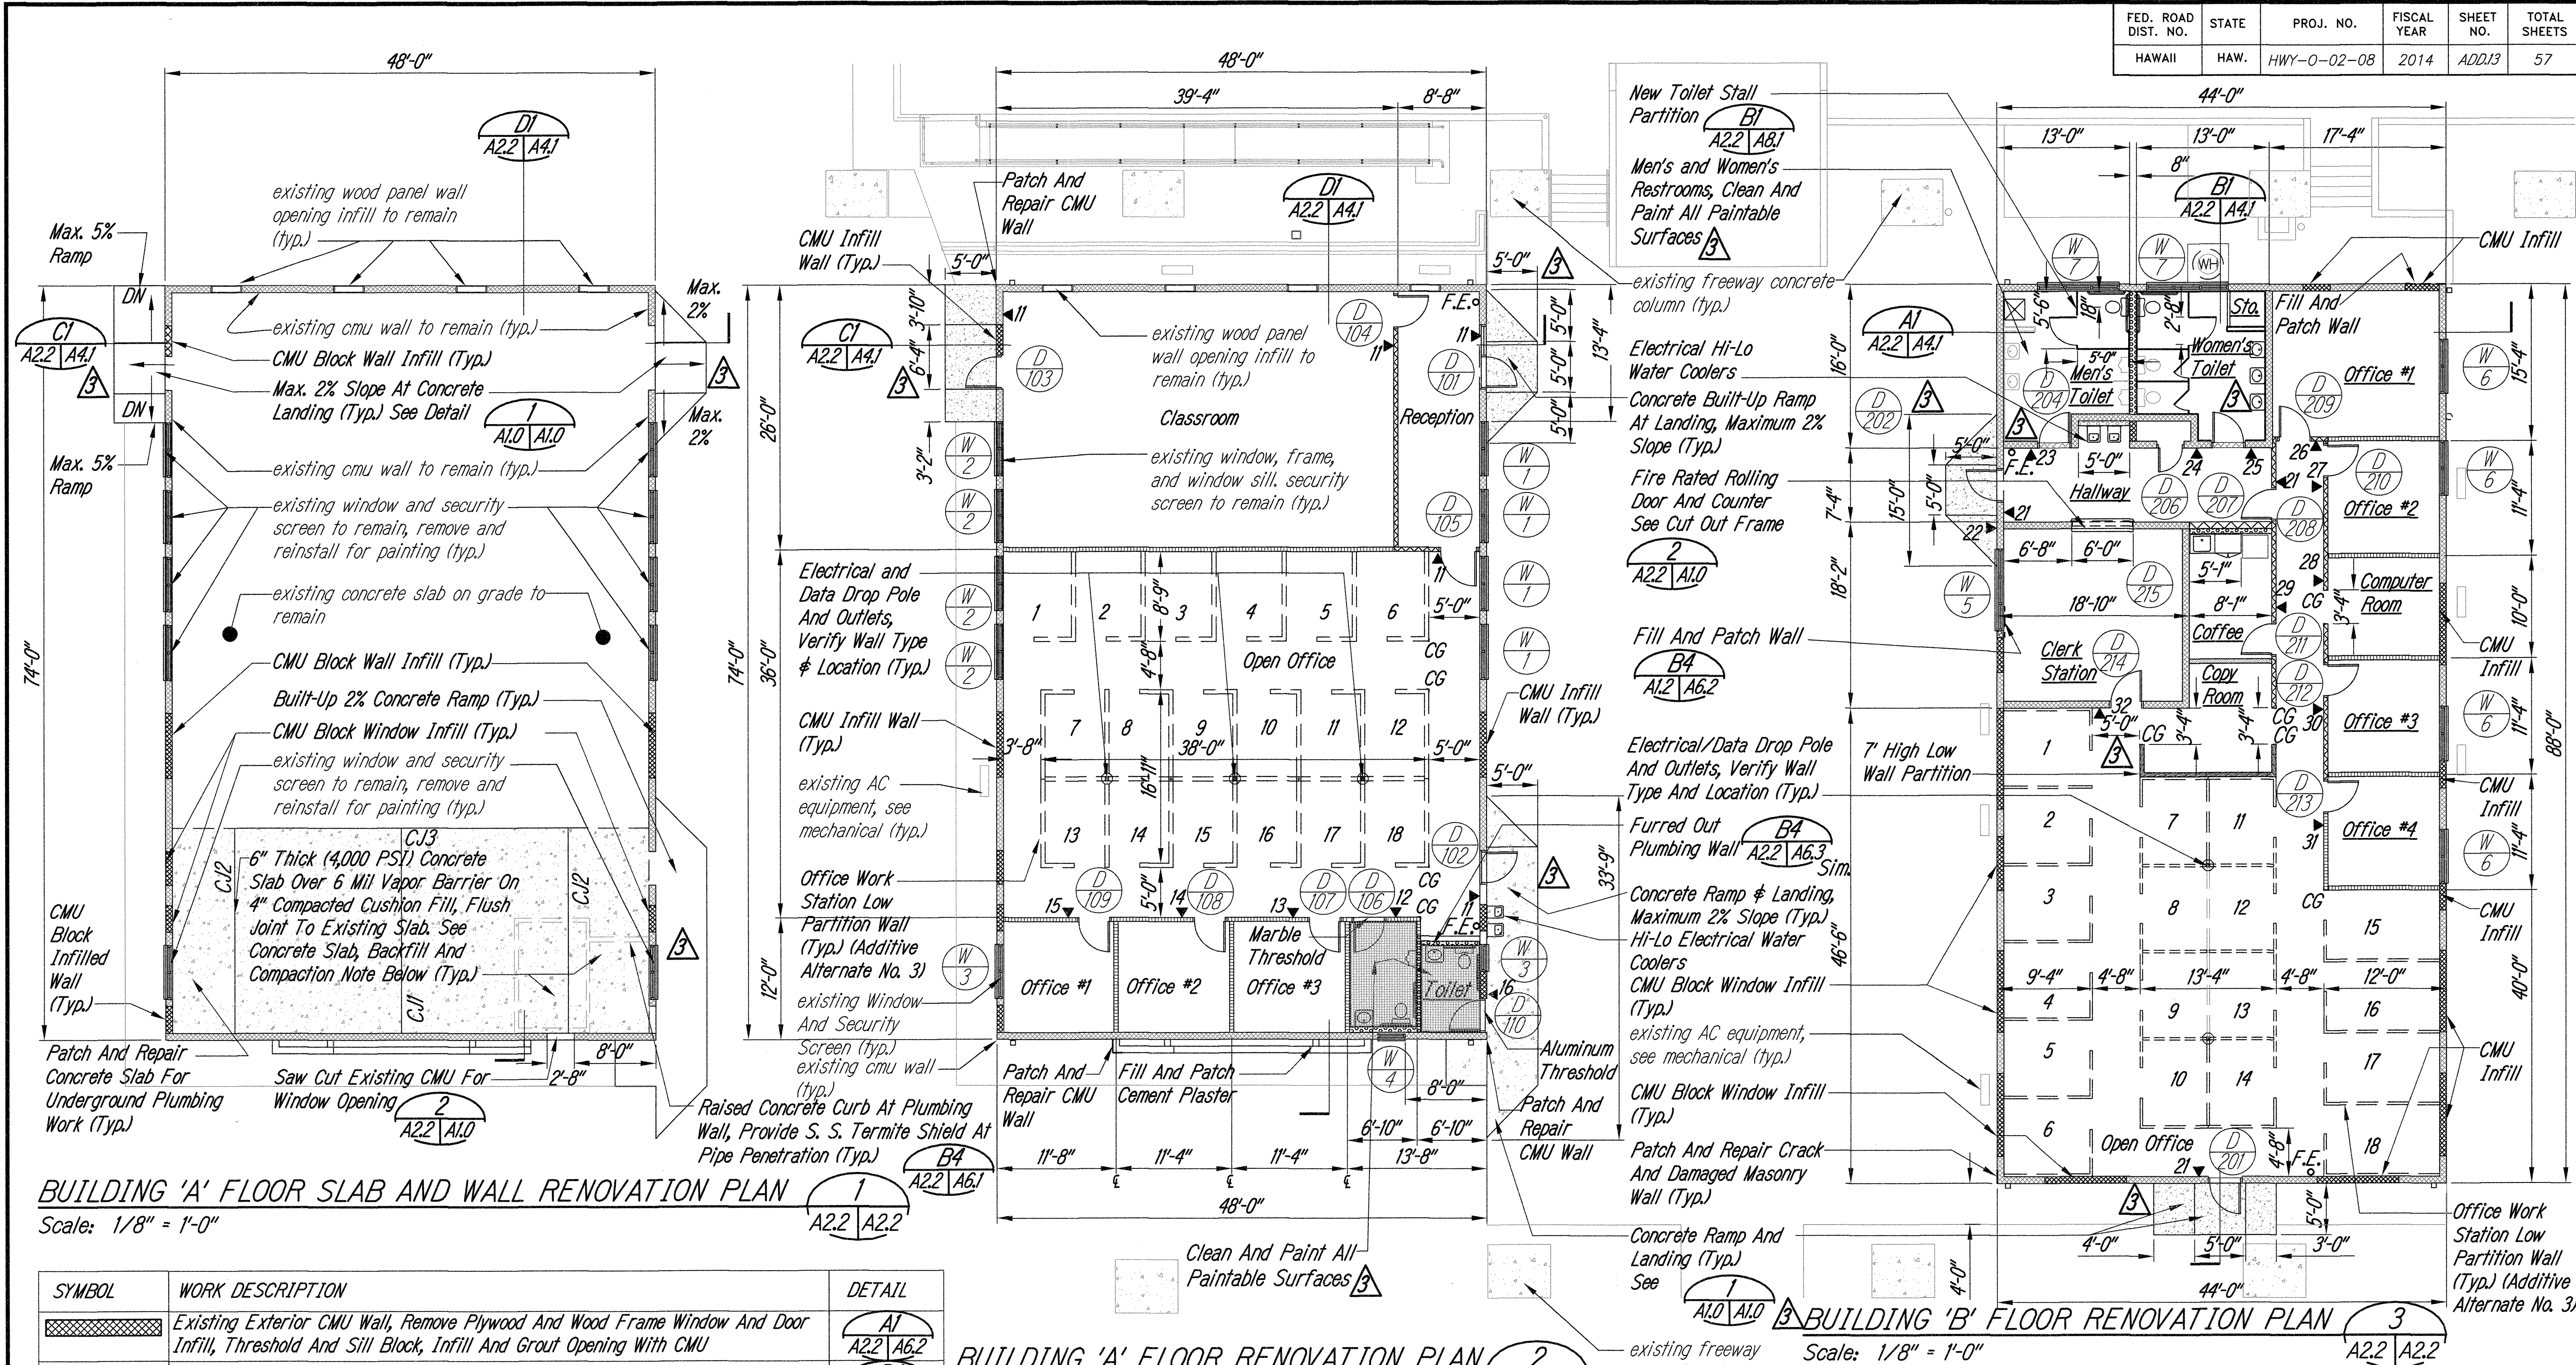

BUILDING 'A' FLOOR SLAB AND WALL RENOVATION PLAN

Scale: 1/8" = 1'-0"

BUILDING 'A' FLOOR RENOVATION PLAN


Scale: 1/8" = 1'-0"

BUILDING 'B' FLOOR RENOVATION PLAN

Scale: 1/8" = 1'-0"

SYMBOL	WORK DESCRIPTION	DETAIL
	Existing Exterior CMU Wall, Remove Plywood And Wood Frame Window And Door Infill, Threshold And Sill Block, Infill And Grout Opening With CMU	
	Existing CMU Wall To Remain, Patch Cracks And Damages. Saw Cut And Infill Wall Where Indicated	
	Corridor Fire Rated Full Height Gypsum Board Wall	
	Full Height Gypsum Board Partition Wall	
	Ceiling Height Gypsum Board Wall	
	Gypsum Board Furred Out Plumbing Wall	
	7' High Top Open Wall Partition	
	Office Work Station Low Wall Partition (Additive Alternate No. 3)	
	Sign With Number, See Signage Schedule	
	CG 4' In Length Corner Guard	

CONCRETE SLAB, BACKFILL AND COMPACTION NOTE:
 Concrete Slab Shall be 4,000 PSI Fibermesh Mixed Concrete, Reinforced With 1-#4 Rebar at 12" O. C. Each Way Dowelled Into Existing Slab On 6 Mil Polyethelene Moisture Barrier, Tape All Lap Joints. Provide A Minimum 4" Thick Compacted Cushion Fill Consisting Of Open-Grade Gravel (ASTM C33, No. 67 gradation) Below The Slabs. Backfill Under New Interior Floor Concrete Slab Where Required Shall be Non-Expansive Clear Structural Fill Compacted To 90% Relative Compaction In 8" Lifts As Determined By ASTM D 1557 Test.

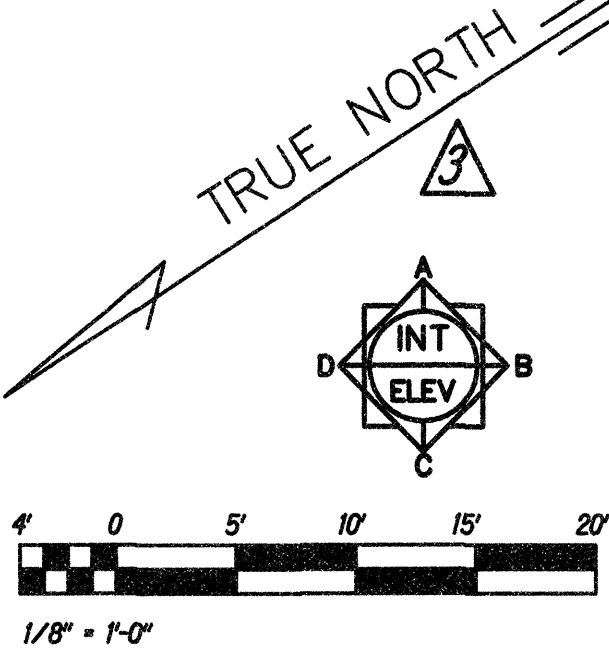

6/5/2014

DATE

Revised Restrooms And Ramps

REVISION

STATE OF HAWAII

DEPARTMENT OF TRANSPORTATION

HIGHWAYS DIVISION

BUILDING A & B

FLOOR RENOVATION PLANS

MOTOR VEHICLE SAFETY OFFICE

RENOVATION

Project No. HWY-0-02-08

Scale: As Noted

Date: APRIL, 2014

SHEET No. A22 OF 57 SHEETS

FED. ROAD DIST. NO.	STATE	PROJ. NO.	FISCAL YEAR	SHEET NO.	TOTAL SHEETS
HAWAII	HAW.	HWY-0-02-08	2014	14	57

CEILING AND SOFFIT DEMOLITION NOTE

Existing Ceiling And Soffit Conditions And Ceiling And Soffit Mounted Elements Were Not Completely Shown In Ceiling Plan For Clarity. Contractor Shall Be Responsible For Field Verifying Existing Conditions, Demolish And Remove All Existing Ceiling And Soffit System And Other Ceiling And Soffit Mounted Elements Not Required For Renovation Work.

Building 'A'

Demolish And Remove All Existing Lay-In Acoustical Ceiling Tiles All Drop In Ceiling Mounted Light Fixtures, Fire Alarm System, Conduits, Wirings, Junction Boxes, Connections Not Required For Renovation Work.

Existing Building 'A' Suspended Metal Ceiling Grid System To Be Reused, Cut And Remove Portion Of Existing Suspended Grid System For New Gypsum Board Ceiling And Partition Wall. Dismantle And Remove All Damaged And Missing Ceiling Grid And Suspended Cable And Wiring System For Replacement.

Existing Cement Plaster Soffit To Remain, Demolish And Remove All Recessed Soffit Mounted Light Fixtures, Housing, Abandoned Conduits, Wirings, Junction Boxes, Connections. Saw Cut And Remove Portion Of Existing Cement Plaster And Wire Mesh For Installation of Soffit Light Fixture, Nailer Frame, Mansard Fascia Metal Panel And Trim. Remove All Loose And Damaged Cement Plaster And Mesh Soffit For Repair And Reconstruction.

Building 'B'

Demolish And Remove All Existing Lay-In Acoustical Ceiling Tiles And All Drop In Ceiling Light Fixtures, Existing Suspended Metal Ceiling Grid System, Fire Alarm System, All Abandoned Conduits, Wirings, Junction Boxes, Connections And Ceiling Mounted Elements Not Required For Renovation Work.

Existing Cement Plaster Soffit To Remain, Demolish And Remove All Recessed Soffit Mounted Light Fixtures, Housing, Abandoned Conduits, Wirings, Junction Boxes, Connections. Saw Cut And Remove Portion Of Existing Cement Plaster And Wire Mesh For Installation of Soffit Light Fixture, Nailer Frame, Mansard Fascia Metal Panel And Trim. Remove All Loose And Damaged Cement Plaster And Mesh Soffit For Repair And Reconstruction.



BUILDING 'A' CEILING DEMOLITION PLAN


Scale: 1/8" = 1'-0"

1
A2.3 | A2.3

BUILDING 'B' CEILING DEMOLITION PLAN



Scale: 1/8" = 1'-0"

2
A2.3 | A2.3

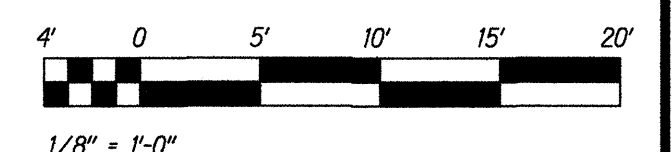

STATE OF HAWAII DEPARTMENT OF TRANSPORTATION HIGHWAYS DIVISION	
BUILDING A & B CEILING DEMOLITION PLANS	
MOTOR VEHICLE SAFETY OFFICE RENOVATION	
Project No. HWY-0-02-08	
Scale: As Noted	Date: APRIL, 2014
SHEET No. A2.3 OF 57 SHEETS	

FED. ROAD DIST. NO.	STATE	PROJ. NO.	FISCAL YEAR	SHEET NO.	TOTAL SHEETS
HAWAII	HAW.	HWY-0-02-08	2014	ADD.15	57

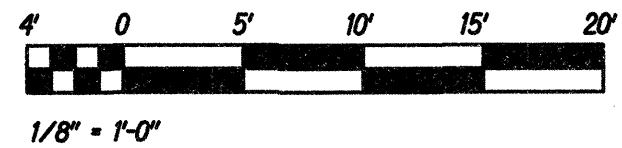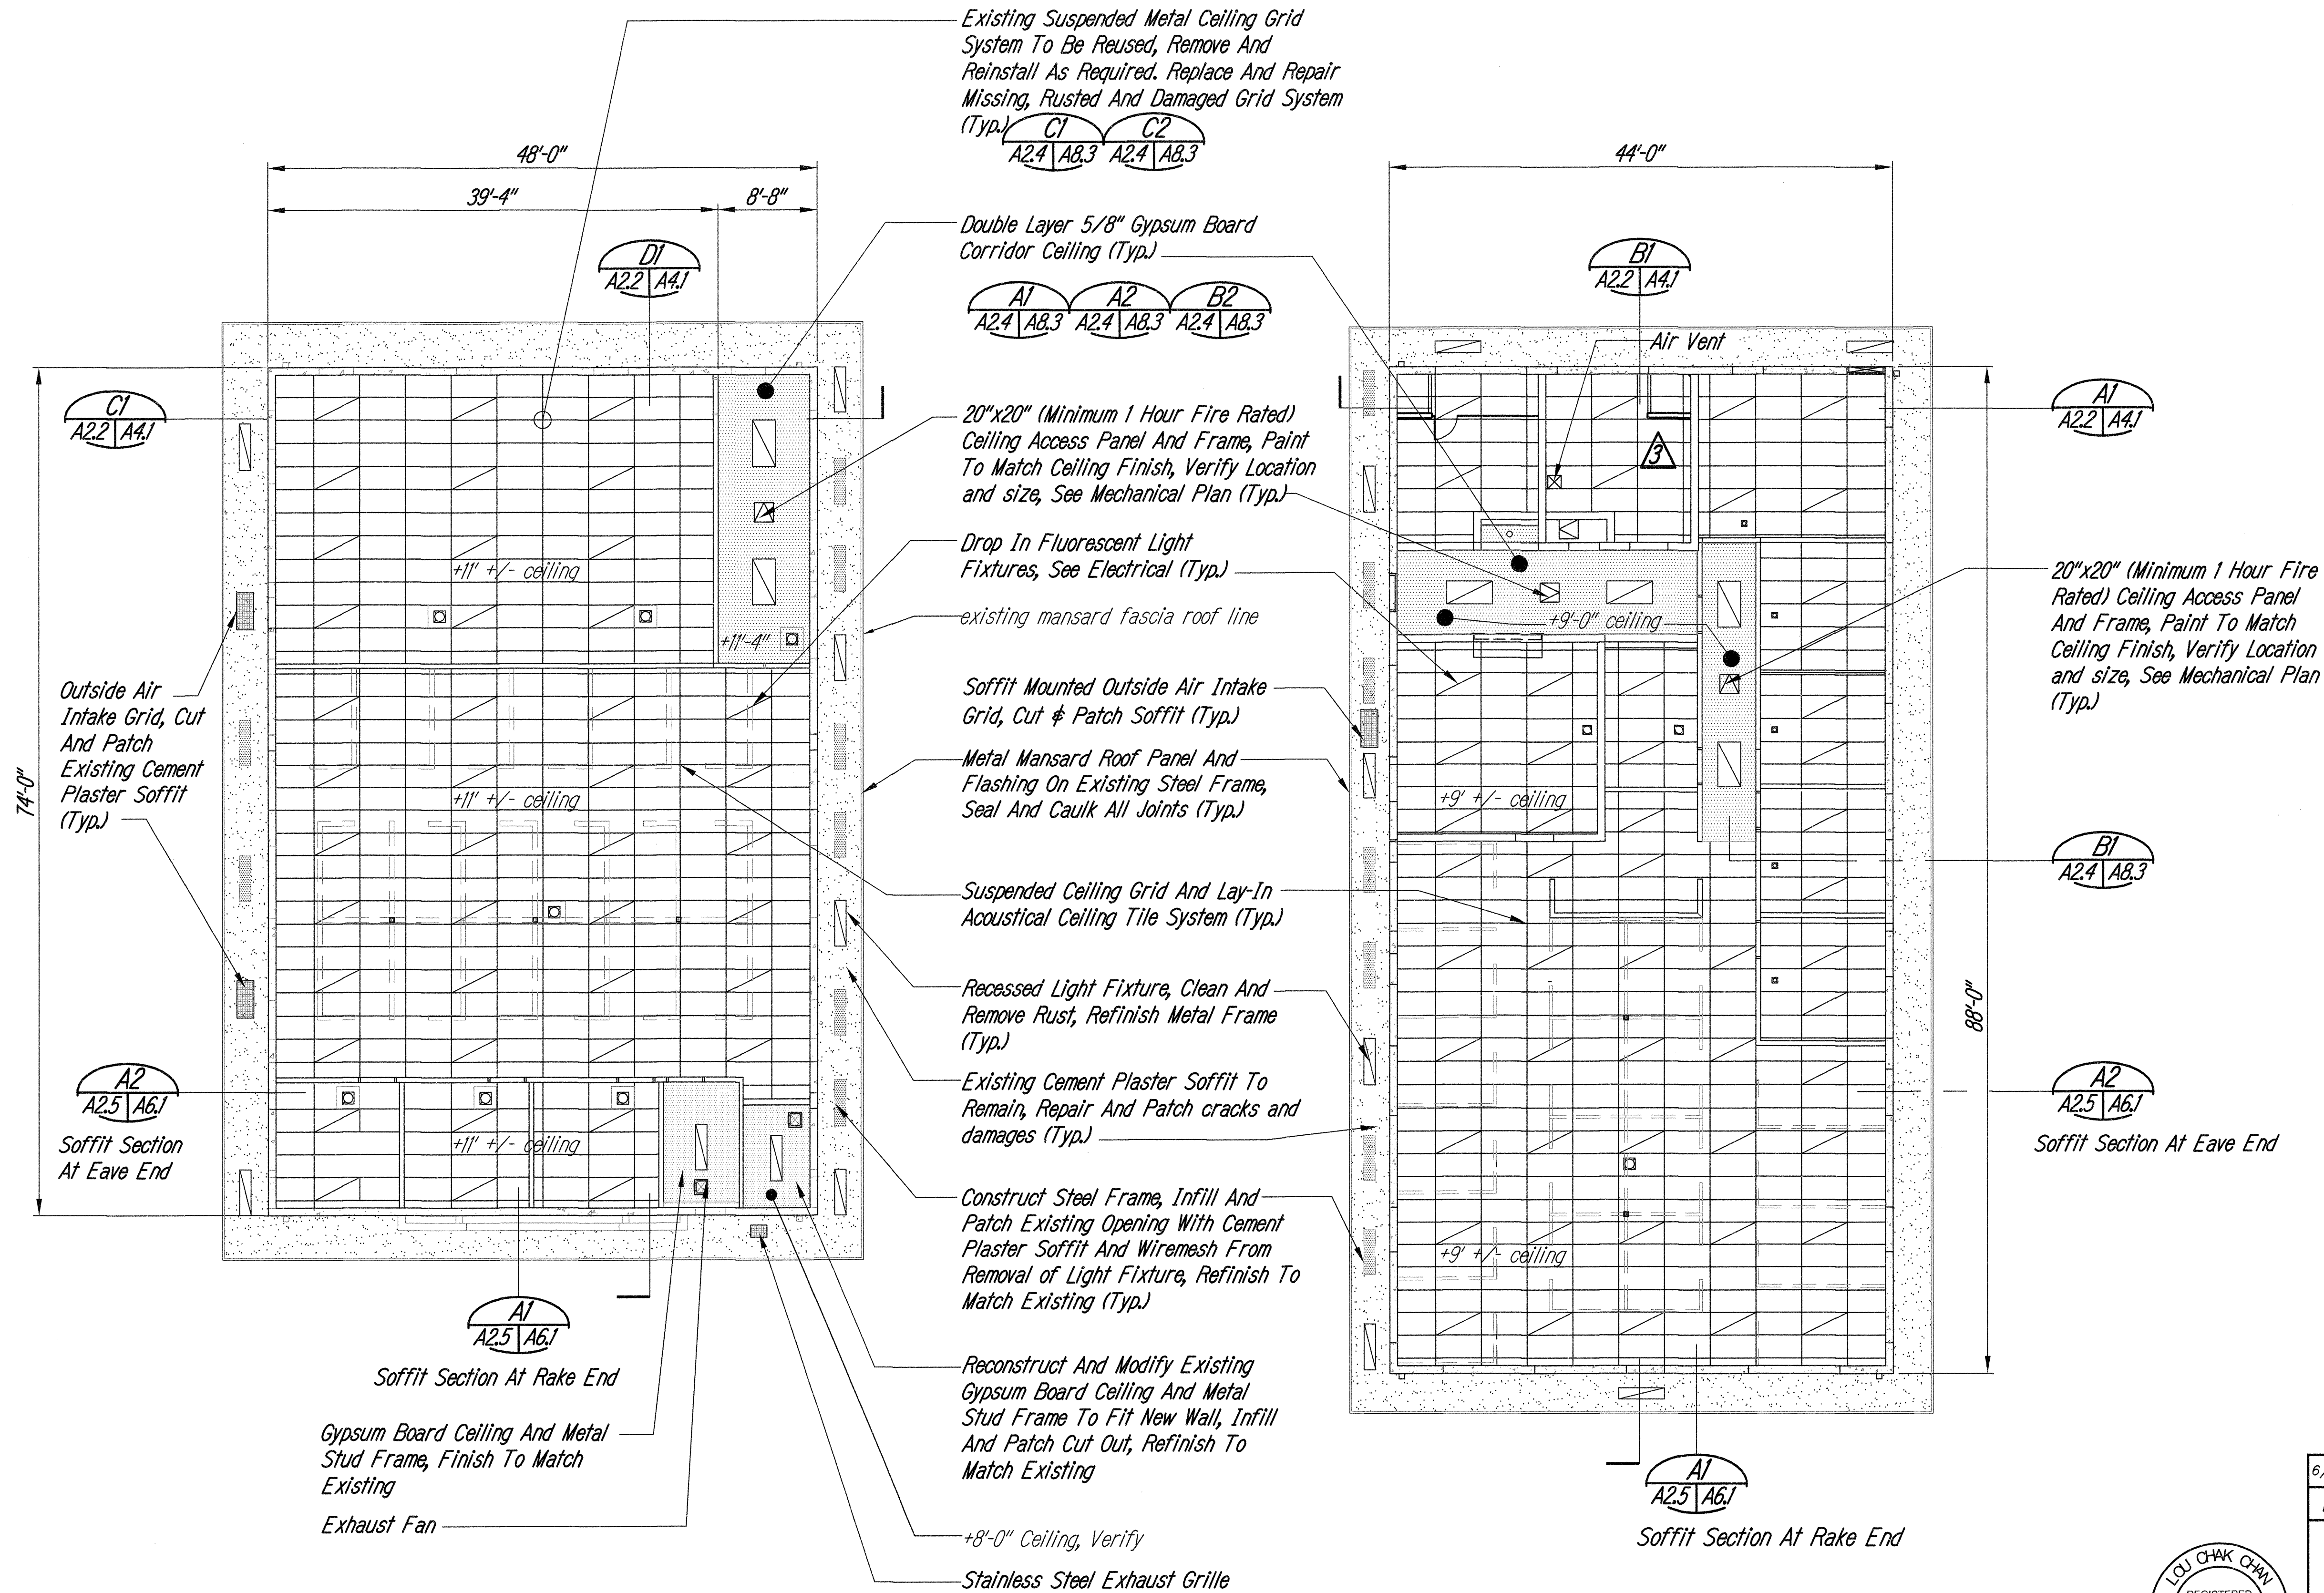

SURVEY PLOTTED BY	DATE
DRAWN BY	
DESIGNED BY	
QUANTITIES BY	
CHECKED BY	
ORIGINAL PLAN	
NOTE BOOK	
No.	

BUILDING 'A' CEILING RENOVATION PLAN 1
Scale: 1/8" = 1'-0" A2.4 A2.4


BUILDING 'B' CEILING RENOVATION PLAN 2
Scale: 1/8" = 1'-0" A2.4 A2.4




Signature
EXPIRATION DATE OF THE LICENSE 4/30/2018
THIS WORK WAS PREPARED BY
ME OR UNDER MY SUPERVISION

6/5/2014	Revised Restroom Ceiling
DATE	REVISION
STATE OF HAWAII DEPARTMENT OF TRANSPORTATION HIGHWAYS DIVISION	
BUILDING A & B CEILING RENOVATION PLANS	
MOTOR VEHICLE SAFETY OFFICE RENOVATION	
Project No. HWY-0-02-08	
Scale: As Noted	Date: APRIL, 2014
SHEET No. A24 OF 57 SHEETS	

FED. ROAD DIST. NO.	STATE	PROJ. NO.	FISCAL YEAR	SHEET NO.	TOTAL SHEETS
HAWAII	HAW.	HWY-0-02-08	2014	16	57

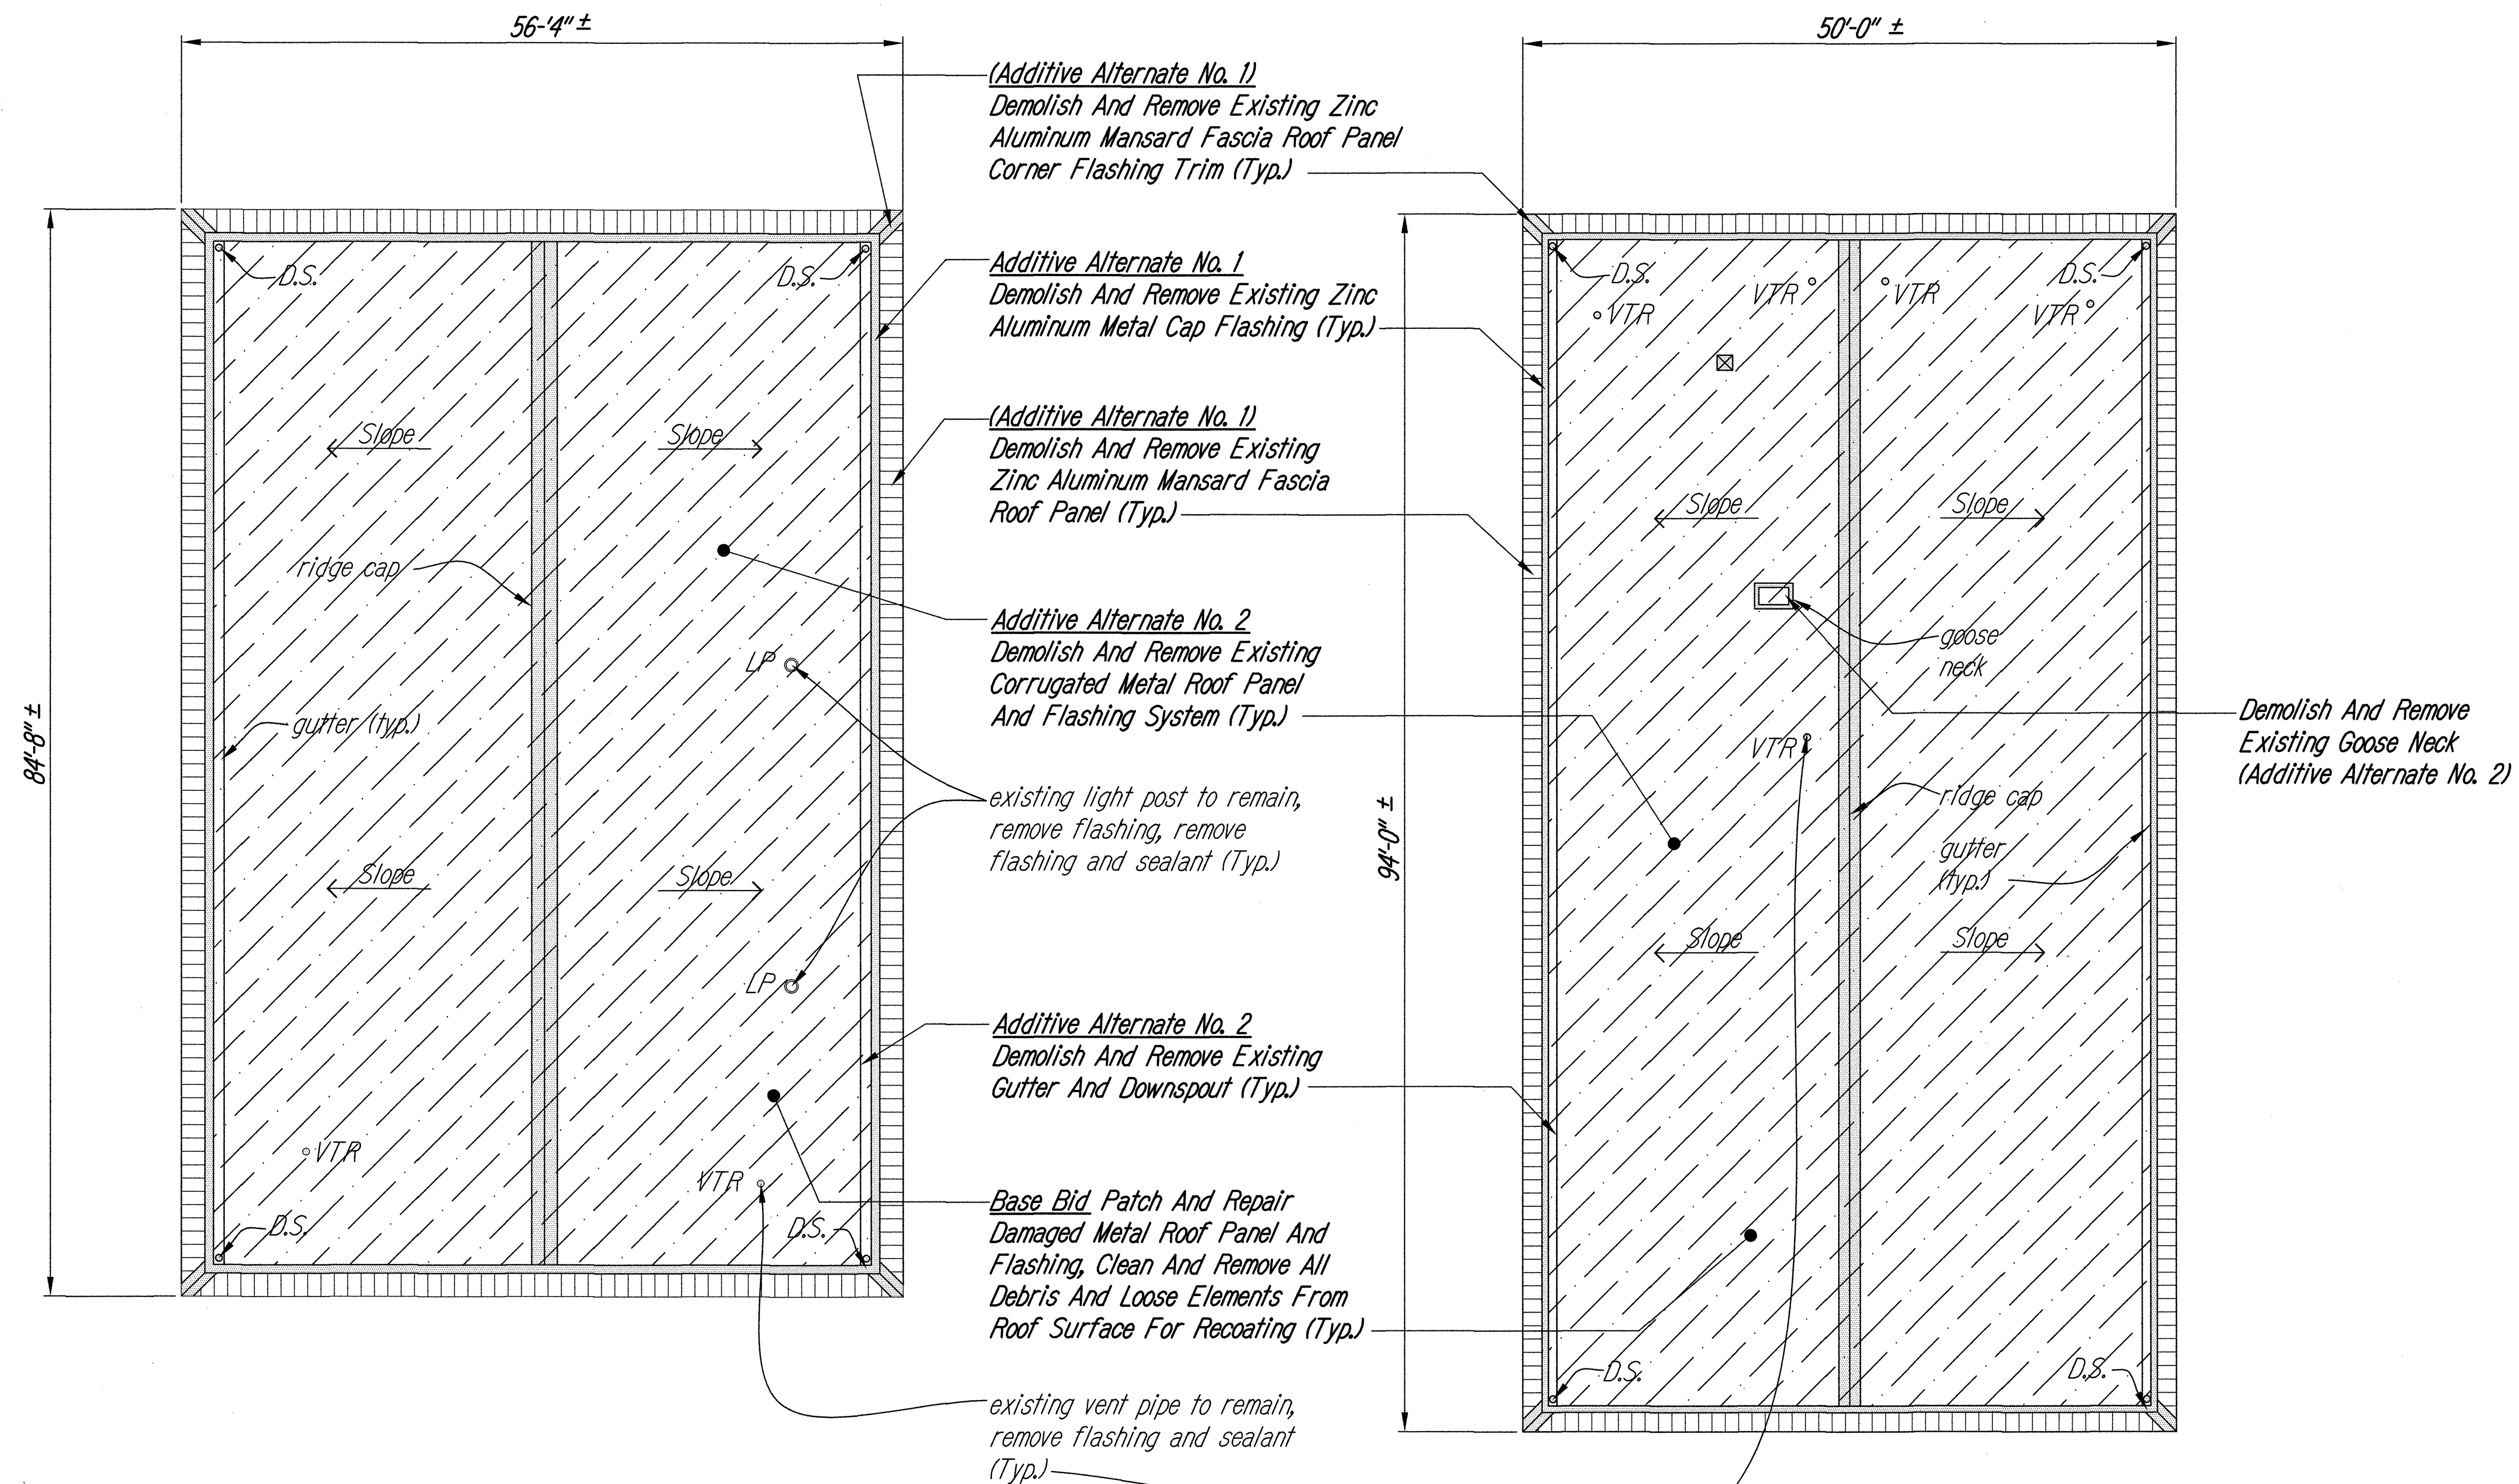

SURVEY PLOTTED BY	DATE
DRAWN BY	
DESIGNED BY	
CHECKED BY	
NOTE BOOK	
No.	

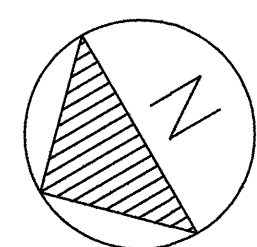

BUILDING A ROOF DEMOLITION PLAN
Scale: 1/8" = 1'-0"


1
A2.5 A2.5

BUILDING B ROOF DEMOLITION PLAN
Scale: 1/8" = 1'-0"

2
A2.5 A2.5



EXPIRATION DATE OF THE LICENSE 4/30/2016
THIS WORK WAS PREPARED BY
ME OR UNDER MY SUPERVISION

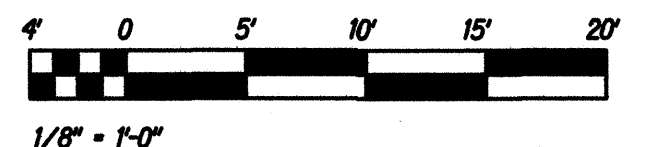

STATE OF HAWAII
DEPARTMENT OF TRANSPORTATION
HIGHWAYS DIVISION


**BUILDING A & B
ROOF DEMOLITION PLANS**

**MOTOR VEHICLE SAFETY OFFICE
RENOVATION**

Project No. HWY-0-02-08
Scale: As Noted Date: APRIL, 2014


SHEET No. A2.5 OF 57 SHEETS

FED. ROAD DIST. NO.	STATE	PROJ. NO.	FISCAL YEAR	SHEET NO.	TOTAL SHEETS
HAWAII	HAW.	HWY-0-02-08	2014	17	57

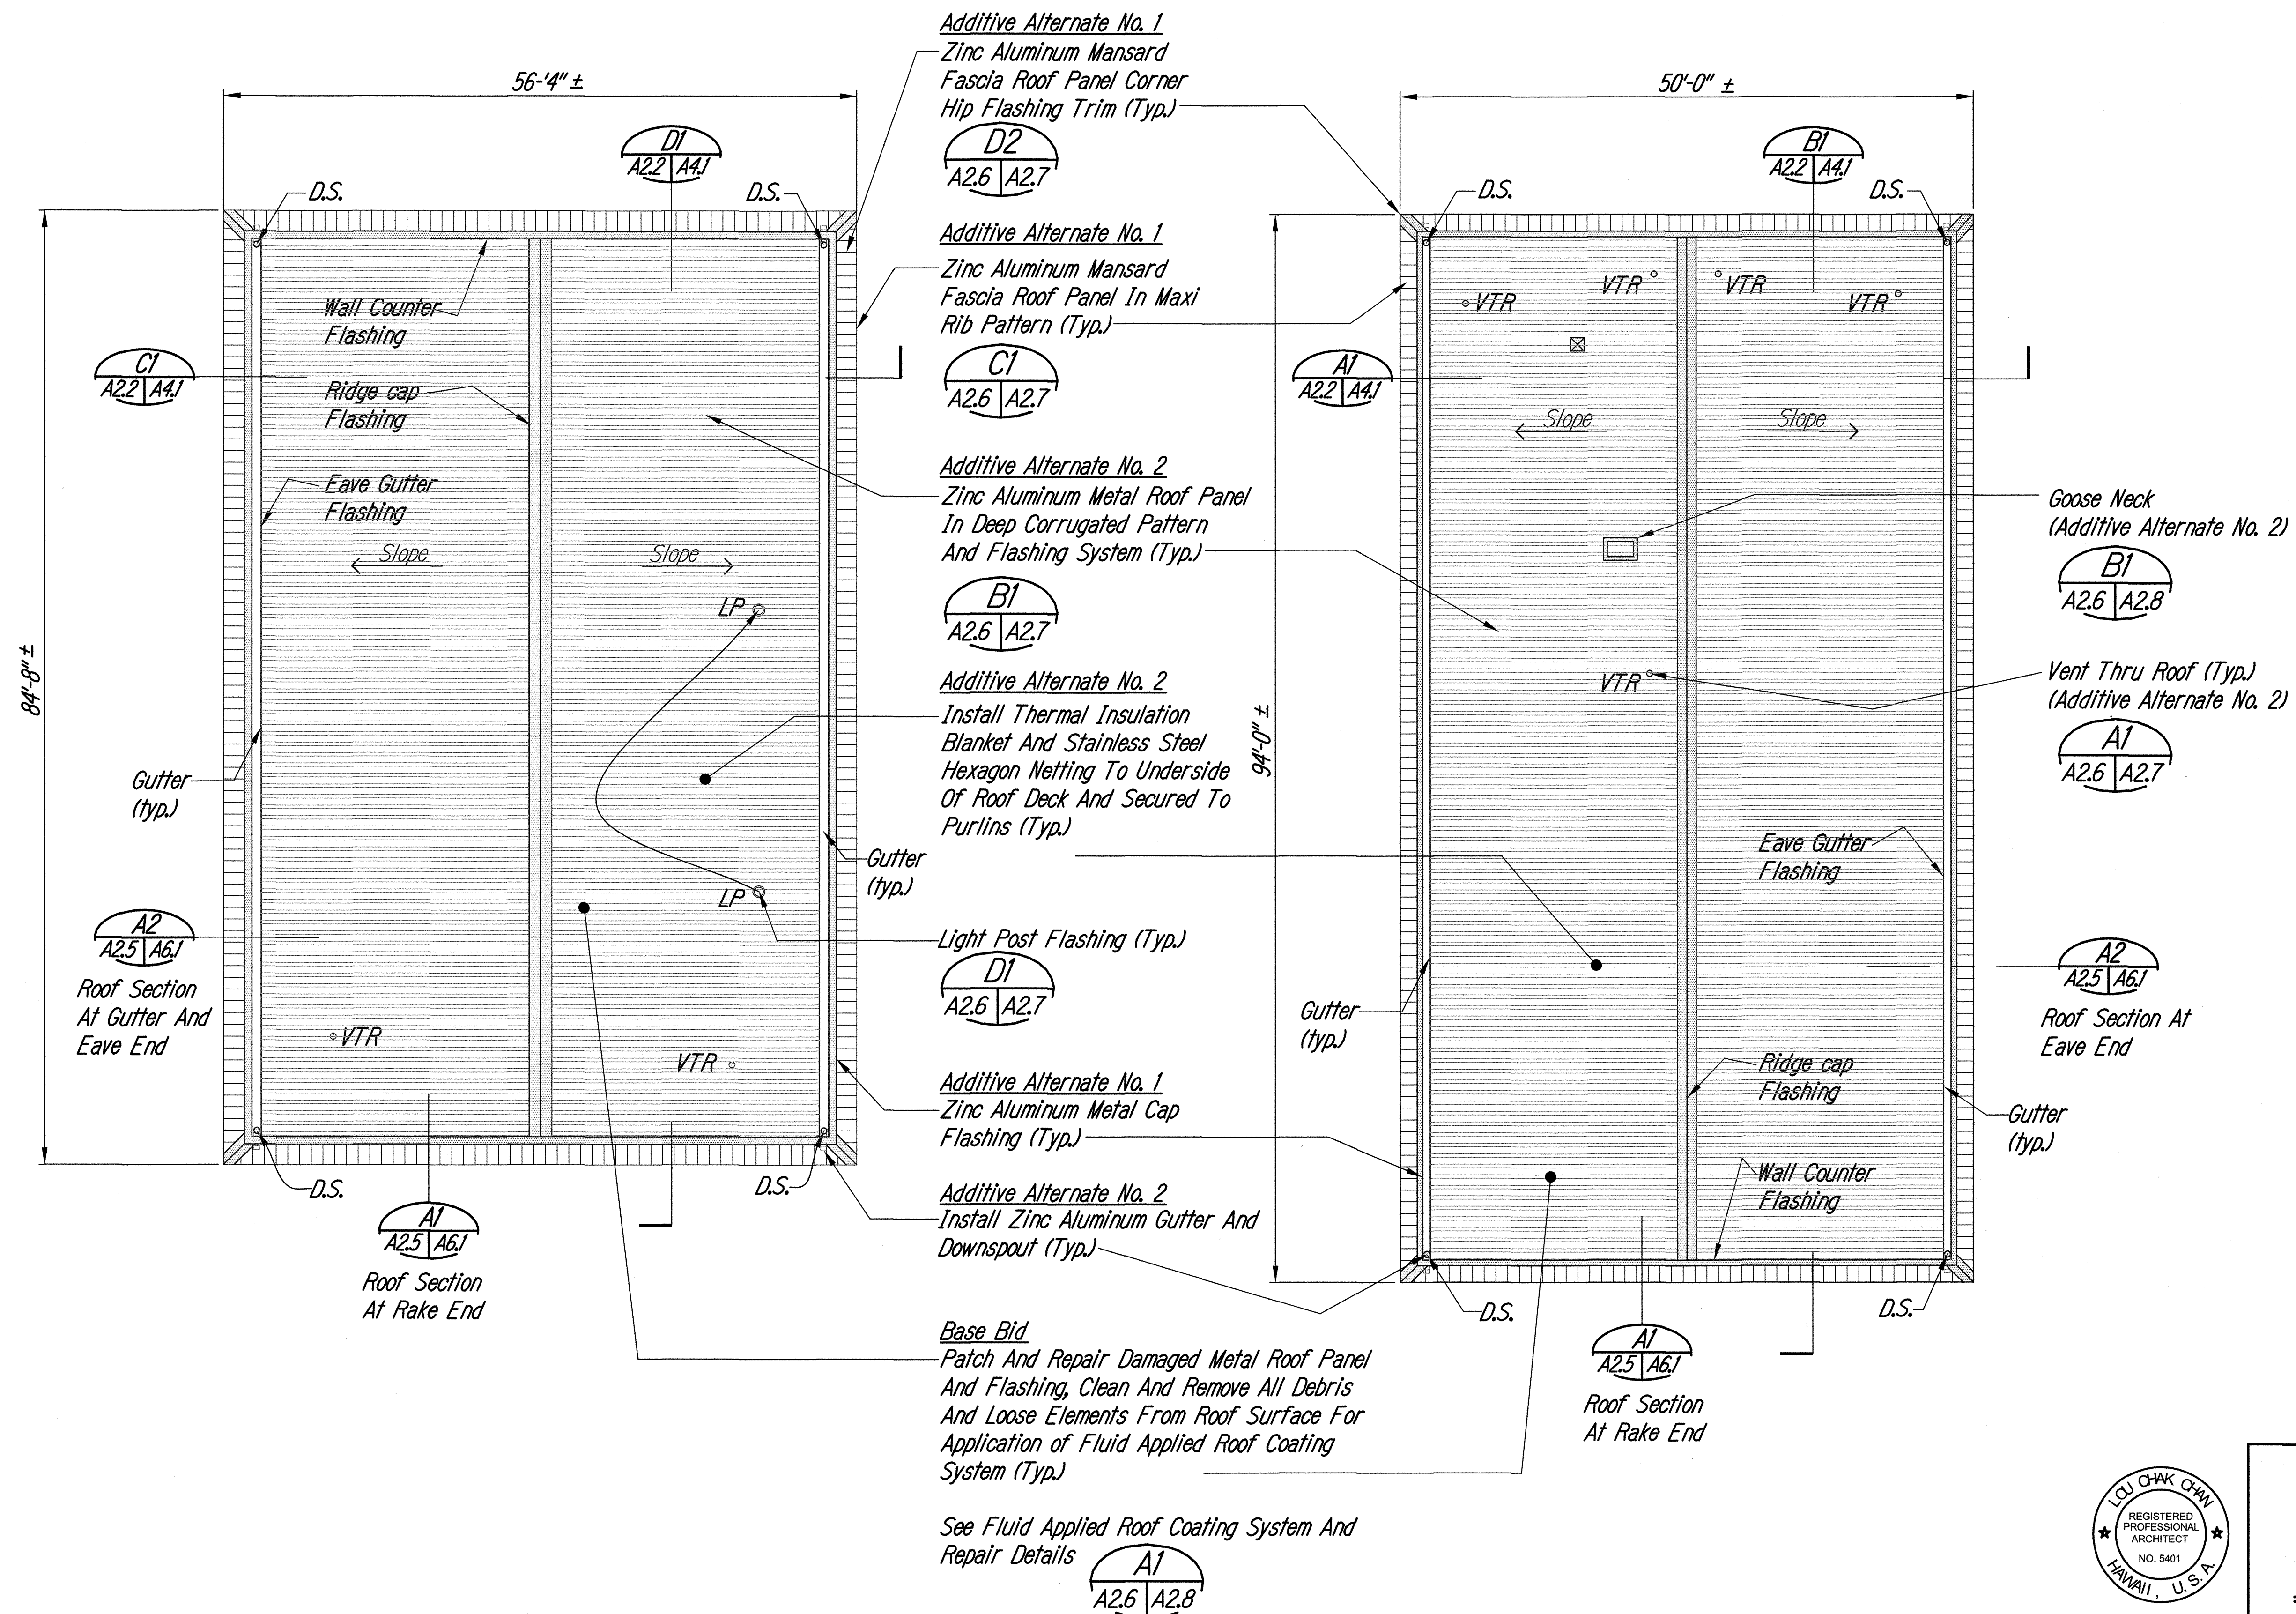

BUILDING A ROOF RENOVATION PLAN
 Scale: 1/8" = 1'-0"
 1
 A2.6 A2.6

BUILDING B ROOF RENOVATION PLAN
 Scale: 1/8" = 1'-0"
 2
 A2.6 A2.6

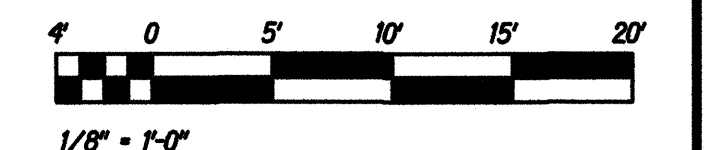

STATE OF HAWAII
 DEPARTMENT OF TRANSPORTATION
 HIGHWAYS DIVISION

**BUILDING A & B
 ROOF RENOVATION PLANS**

MOTOR VEHICLE SAFETY OFFICE
 RENOVATION
 Project No. HWY-0-02-08

Scale: As Noted Date: APRIL, 2014

SHEET No. A2.6 OF 57 SHEETS