

INDEX TO DRAWINGS	
SHEET NO.	DESCRIPTION
1	TITLE SHEET
2-4	GENERAL NOTES
5-11	SITE PLANS AND DETAILS
12-17	DEMOLITION AND RENOVATION PLANS
18-19	ROOFING DETAILS
20-22	EXTERIOR ELEVATIONS AND SECTIONS
23-27	INTERIOR ELEVATIONS
28-31	WALL SECTIONS AND DETAILS
32-38	SCHEDULES AND DETAILS
39-46	MECHANICAL PLANS
47-57	ELECTRICAL PLANS

STATE OF HAWAII

DEPARTMENT OF TRANSPORTATION

HIGHWAYS DIVISION

HONOLULU, HAWAII

PLANS FOR



MOTOR VEHICLE SAFETY OFFICE

RENOVATION

PROJECT NO. HWY-0-02-08

DISTRICT OF EWA



ISLAND OF OAHU

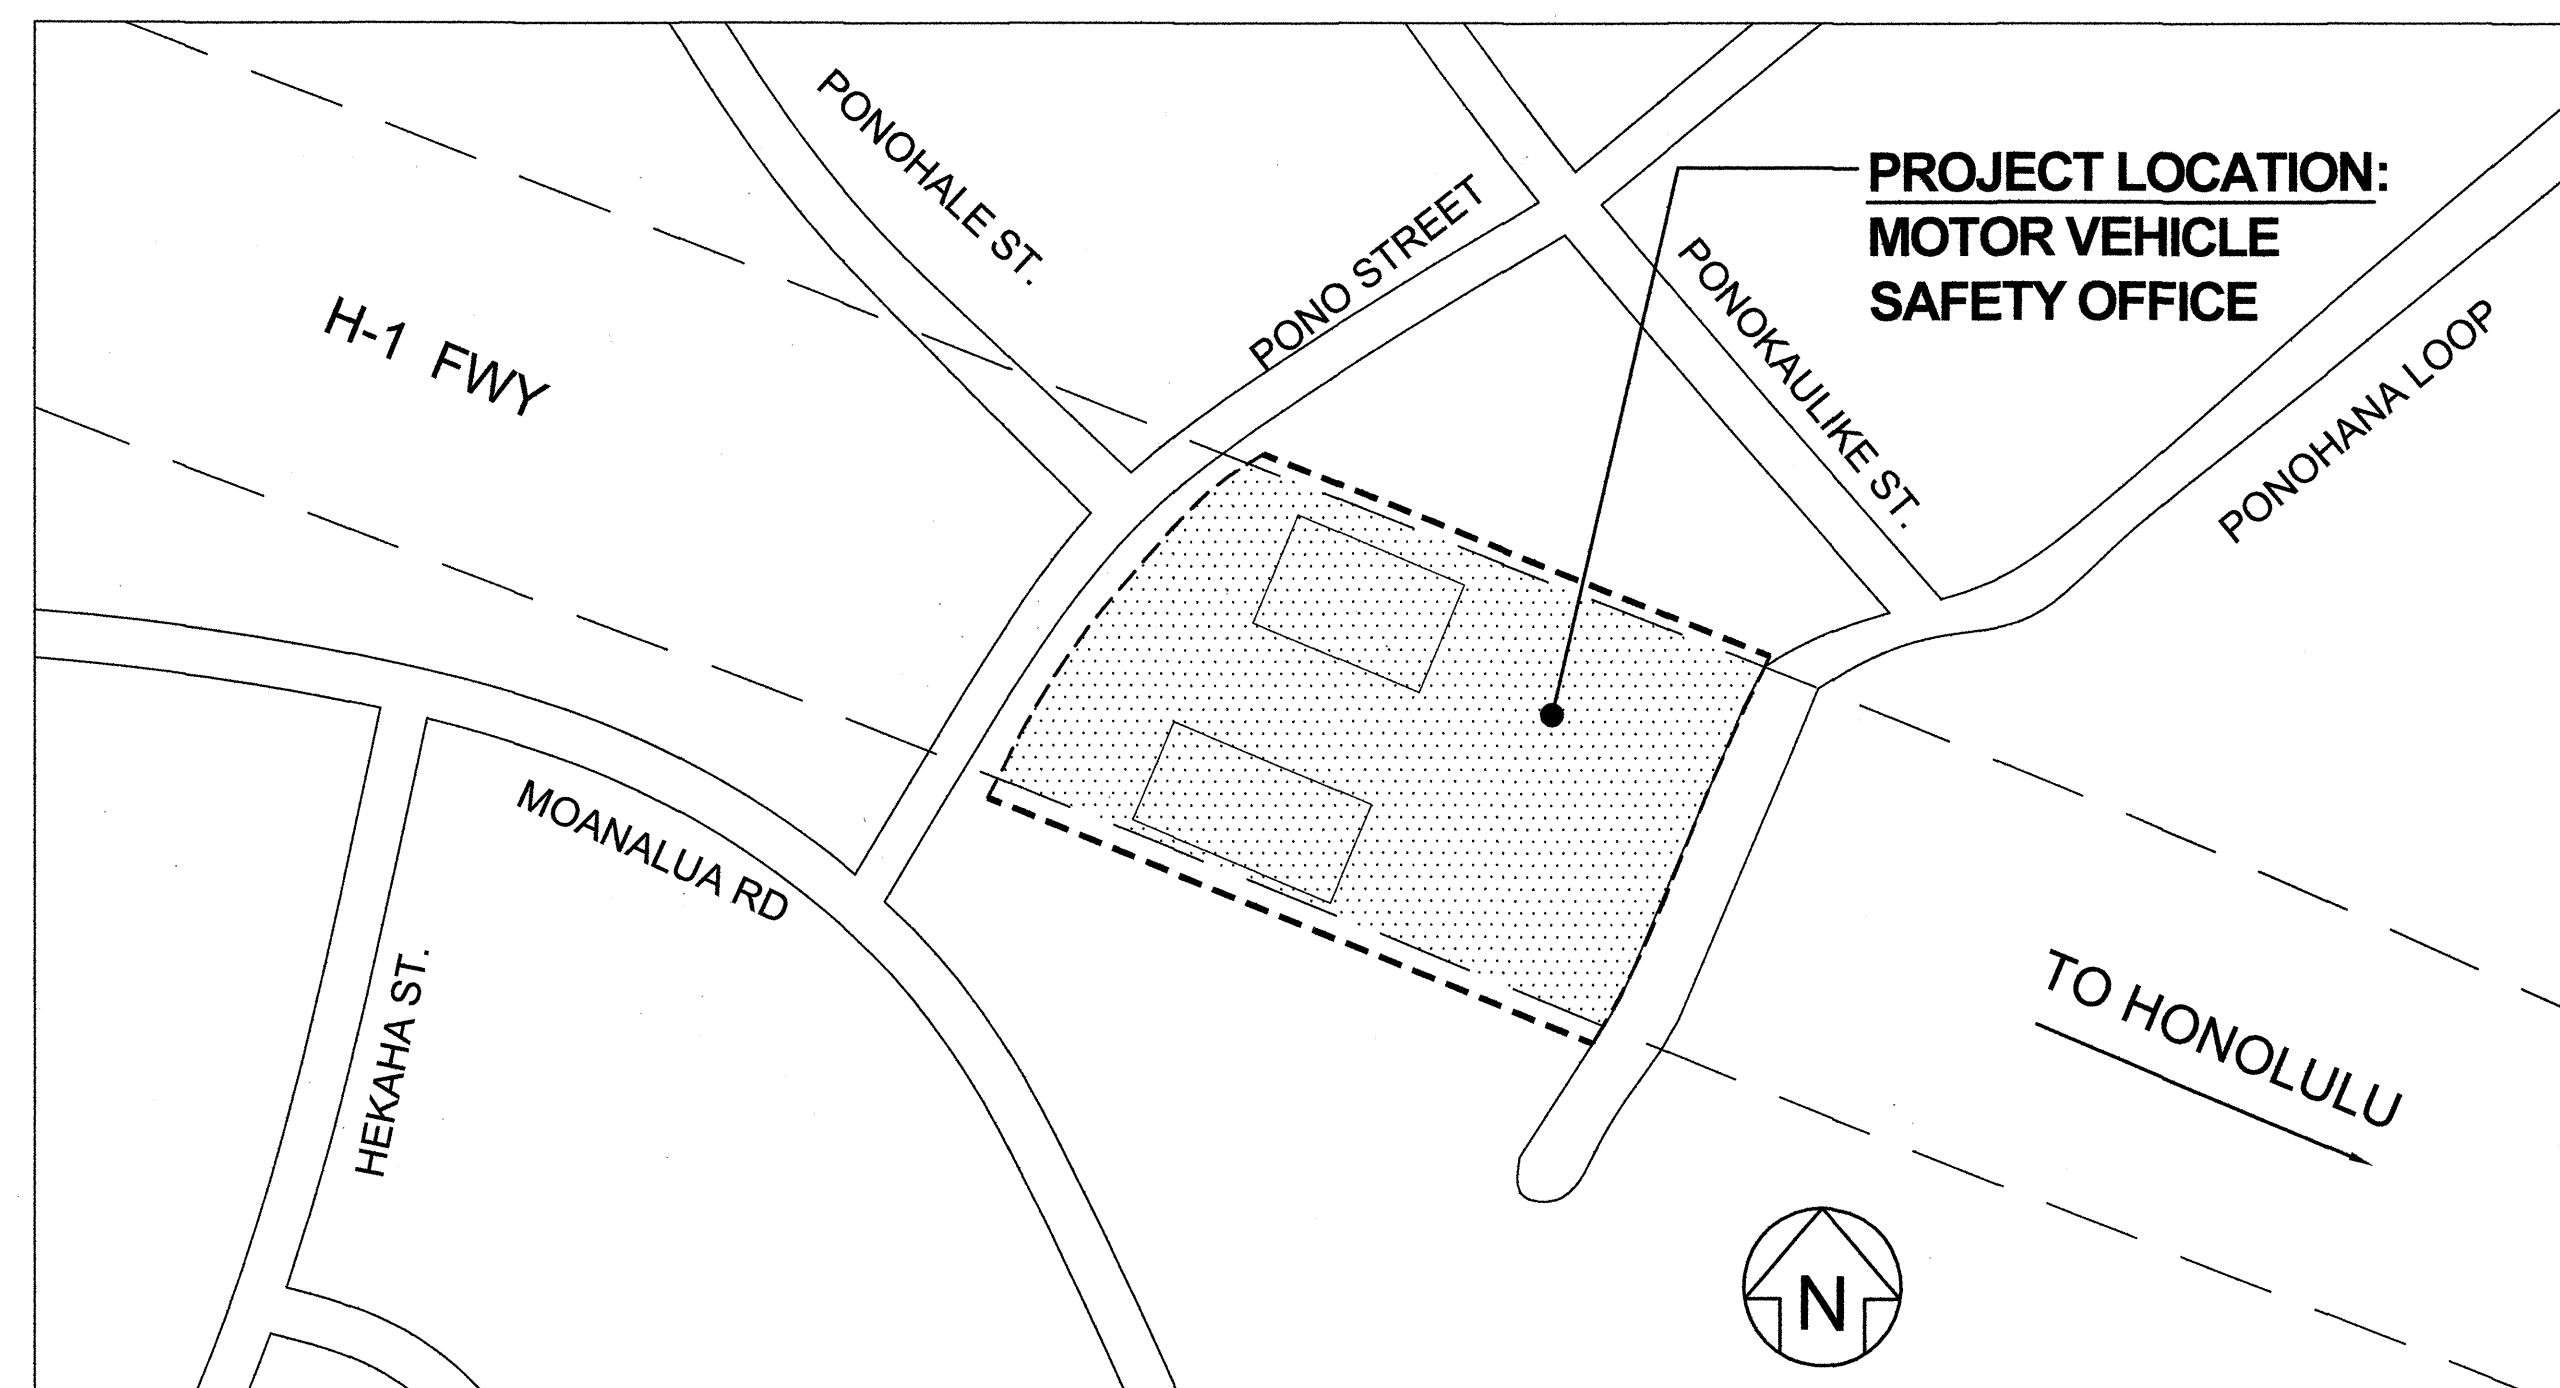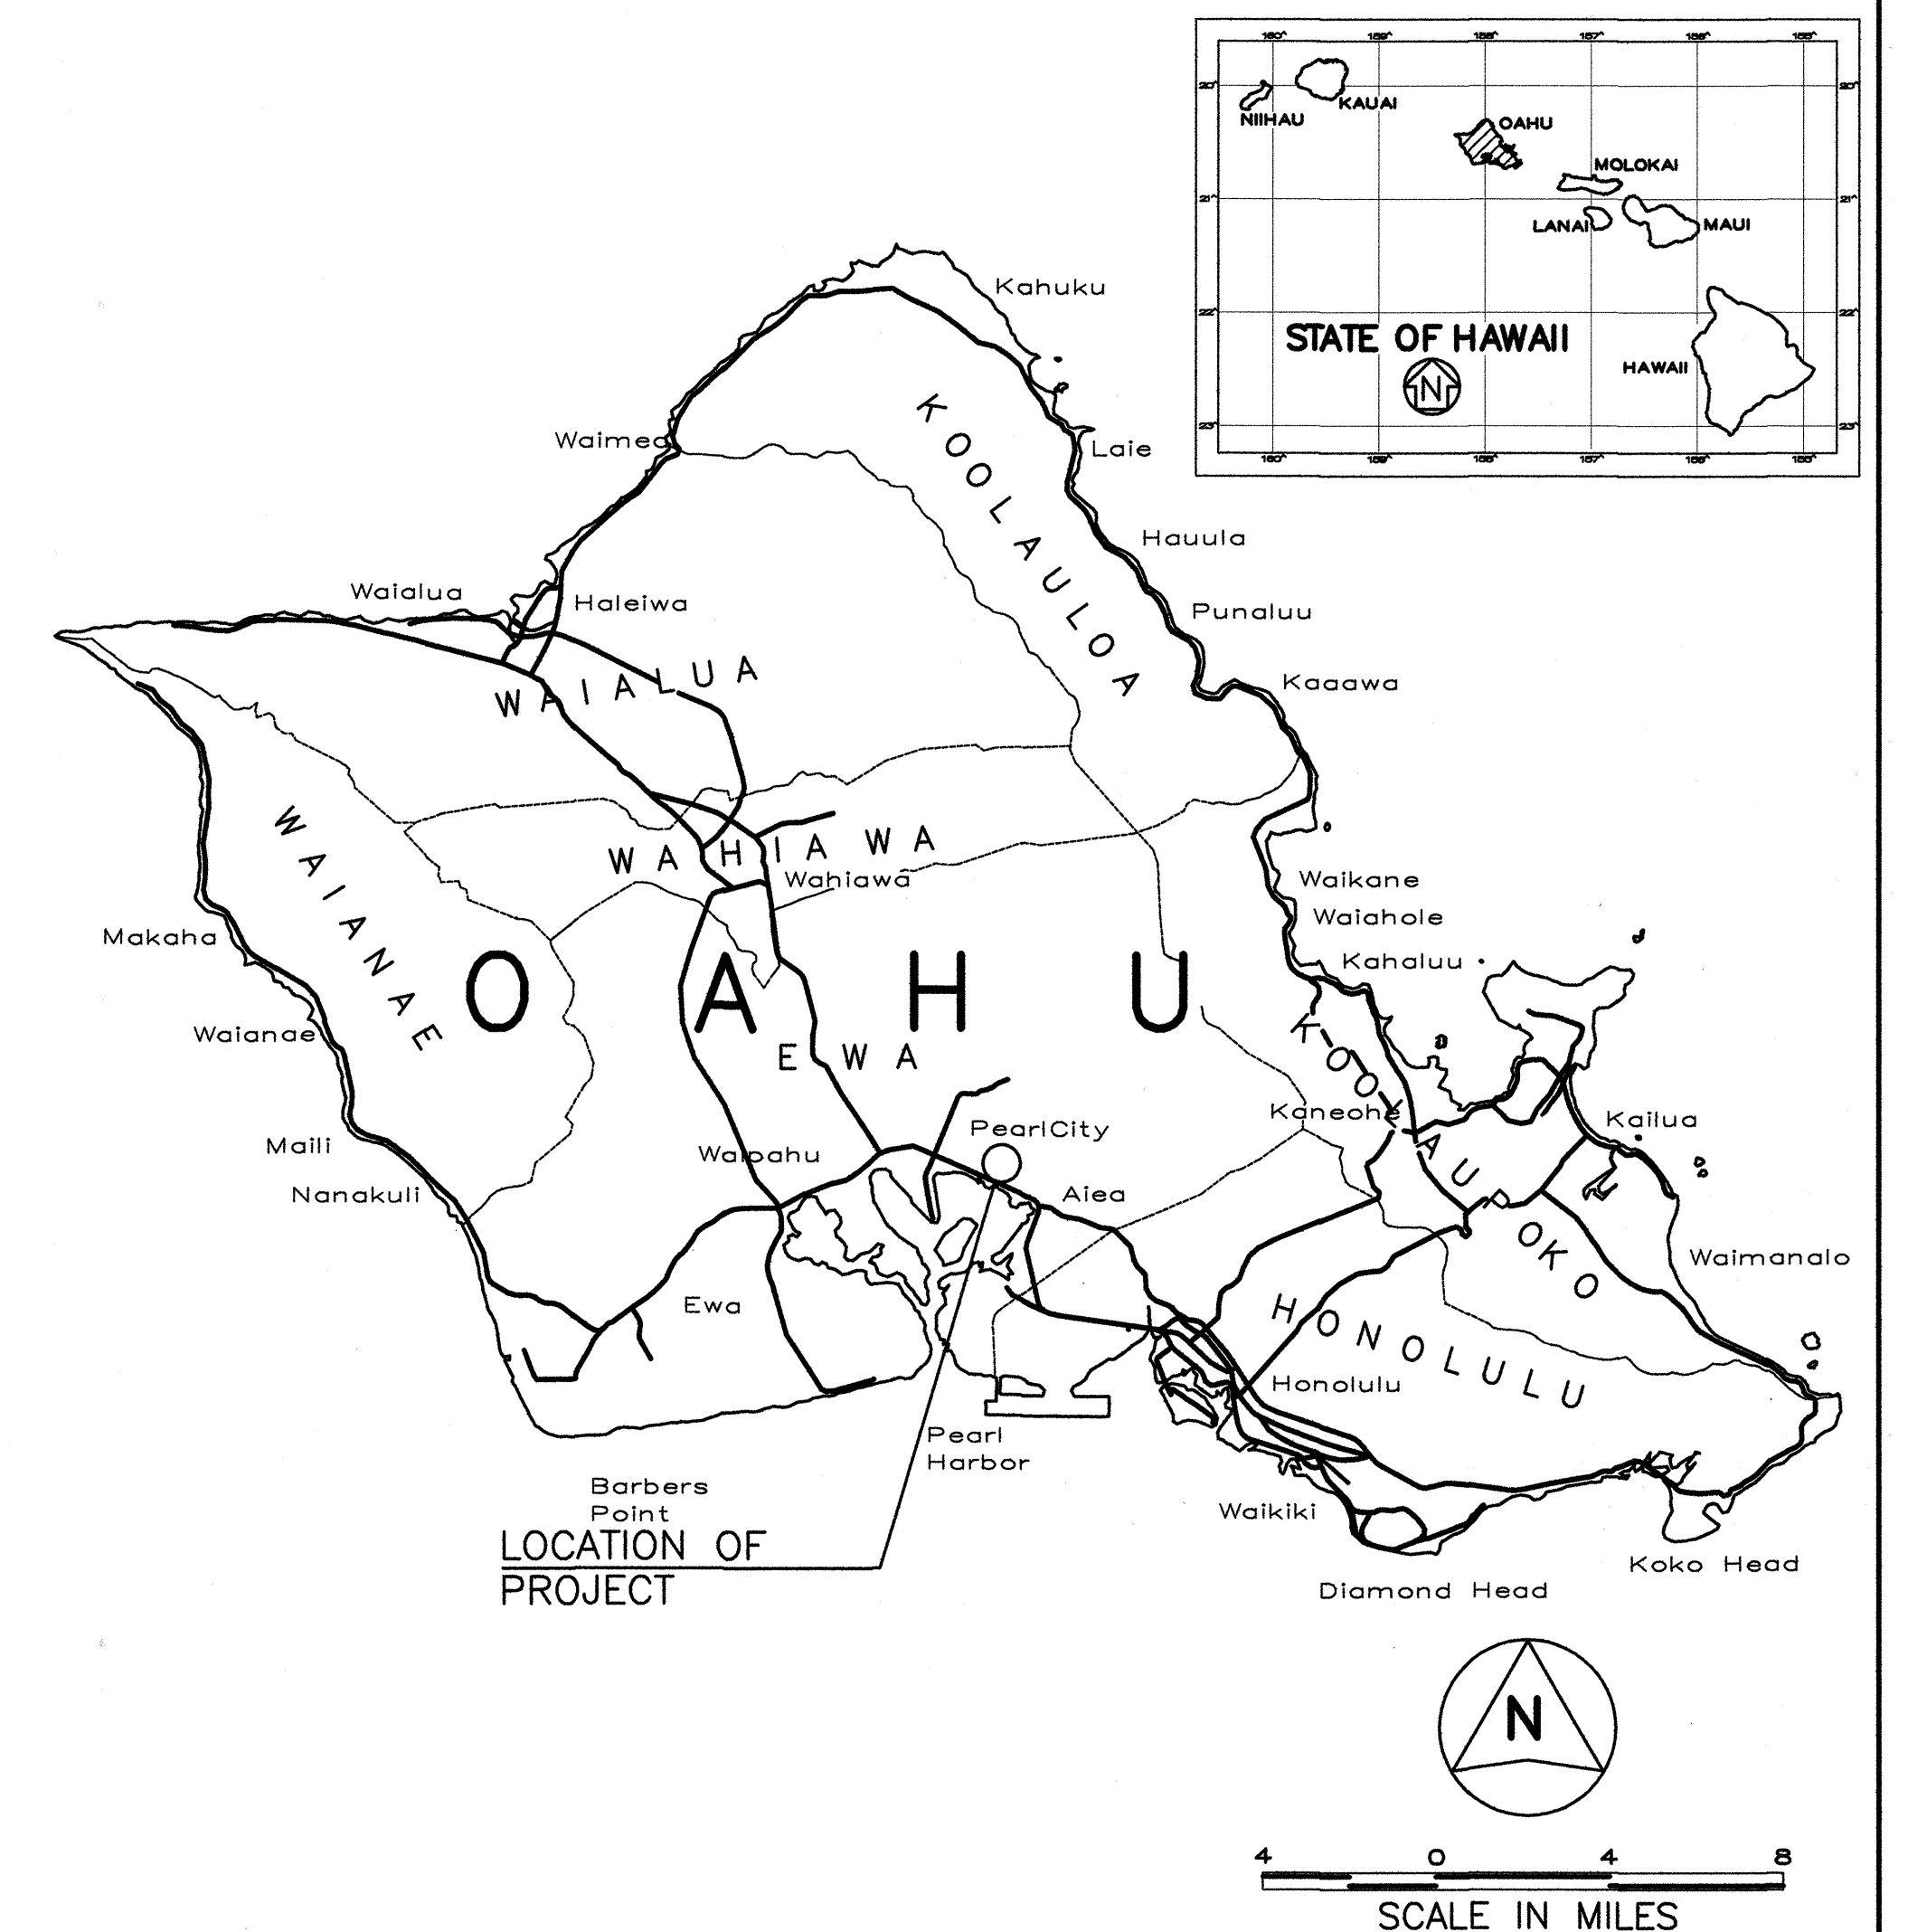

LOCATION PLAN

NOT TO SCALE

FED. ROAD DIST. NO.	STATE	PROJ. NO.	FISCAL YEAR	SHEET NO.	TOTAL SHEETS
HAWAII	HAW.	HWY-0-02-08	2014	1	57

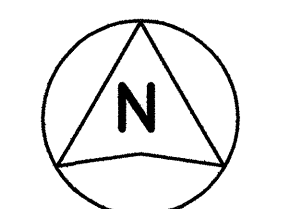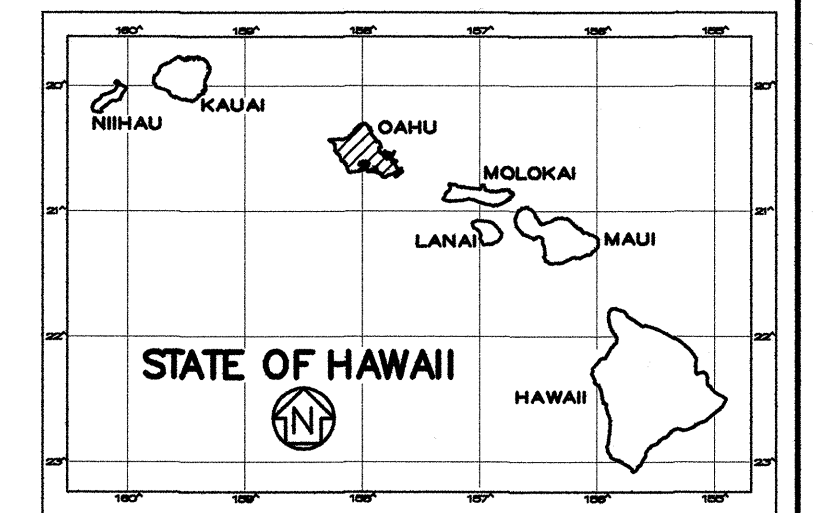

4 0 4 8

SCALE IN MILES

DEPARTMENT OF TRANSPORTATION

STATE OF HAWAII

APPROVED:

Alvin A. Yarusli 4/30/14

for DIR. OF TRANSPORTATION DATE

LOU CHAN & ASSOCIATES

DESIGNED BY

HWY-DS 692-7544 APRIL 2014

MANAGED BY PHONE DATE