

FED. ROAD DIST. NO.	STATE	PROJ. NO.	FISCAL YEAR	SHEET NO.	TOTAL SHEETS
HAWAII	HAW.	HWY-0-02-08R	2016	69	69

INDEX TO DRAWINGS	
SHEET NO.	DESCRIPTION
1	TITLE SHEET
2-5	GENERAL NOTES
6-8	ADDITIVE ALTERNATES PLAN
9-15	SITE PLANS AND DETAILS
16-23	DEMOLITION AND RENOVATION PLANS
24-26	EXTERIOR ELEVATIONS AND SECTIONS
27-31	INTERIOR ELEVATIONS
32-39	WALL SECTIONS, CEILING & ROOF DET.
40-45	SCHEDULES AND DETAILS
46-48	STRUCTURAL PLANS
49-57	MECHANICAL PLANS
58-69	ELECTRICAL PLANS

STATE OF HAWAII

DEPARTMENT OF TRANSPORTATION

HIGHWAYS DIVISION

HONOLULU, HAWAII

PLANS FOR



MOTOR VEHICLE SAFETY OFFICE

RENOVATION

PROJECT NO. HWY-0-02-08R

DISTRICT OF EWA

ISLAND OF OAHU

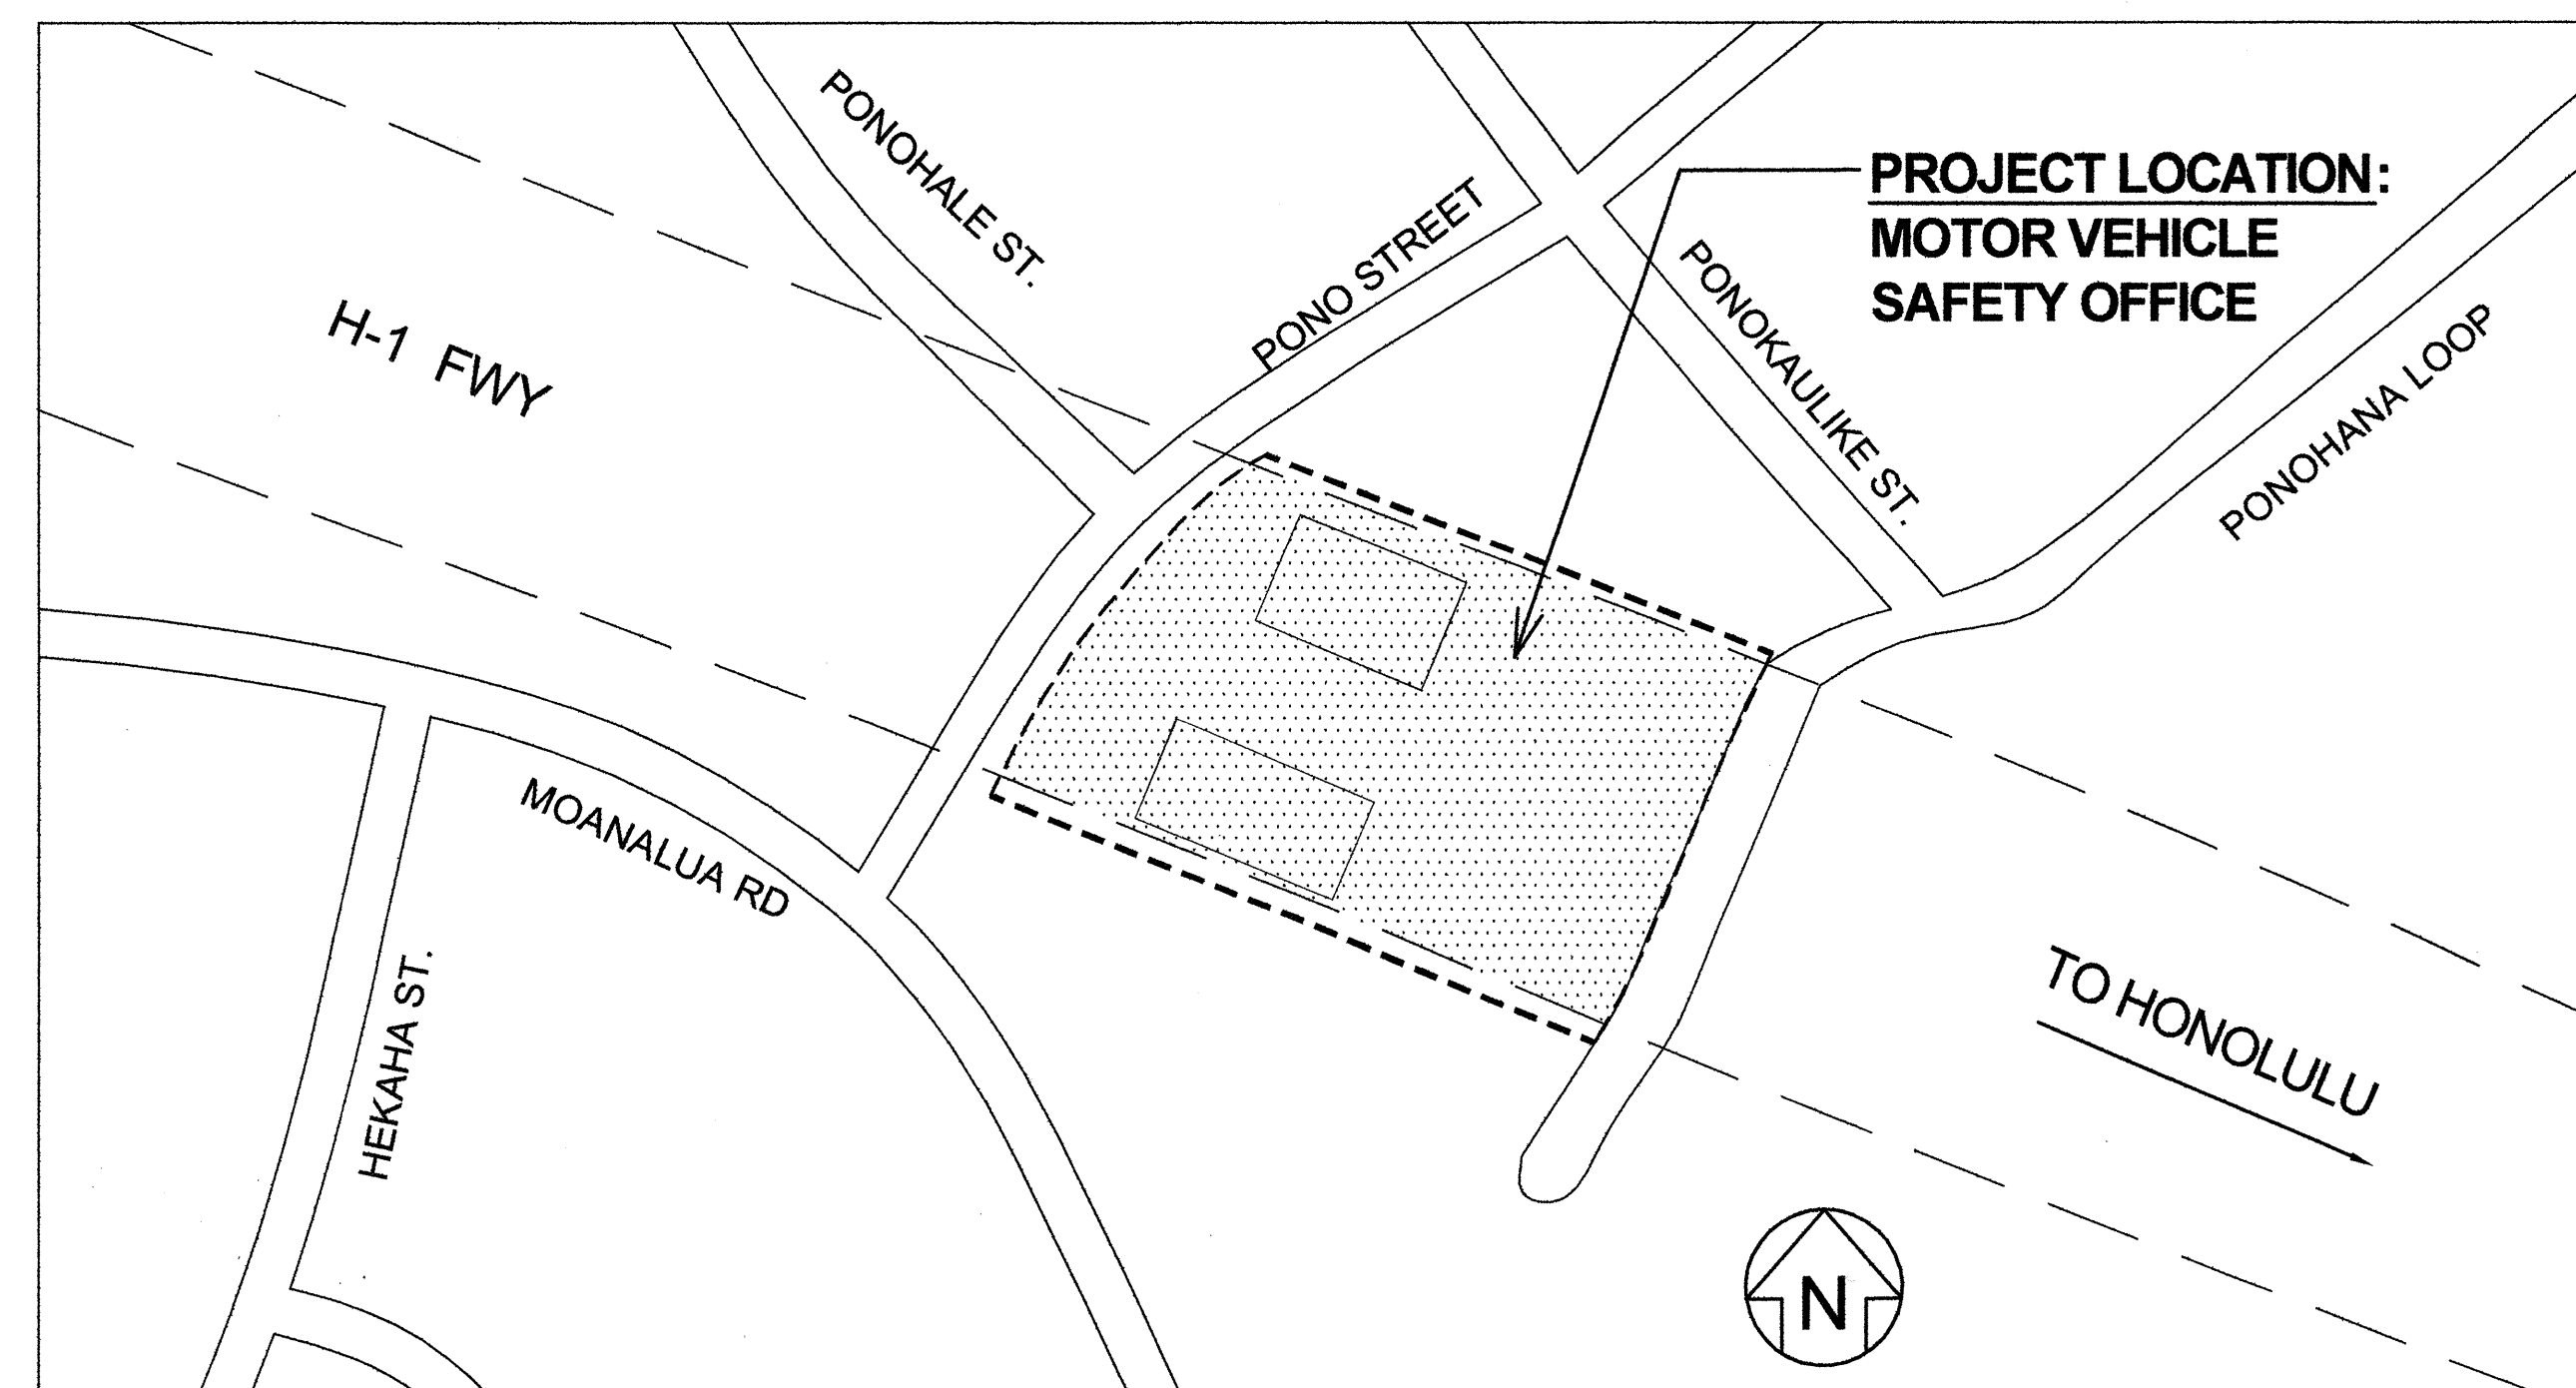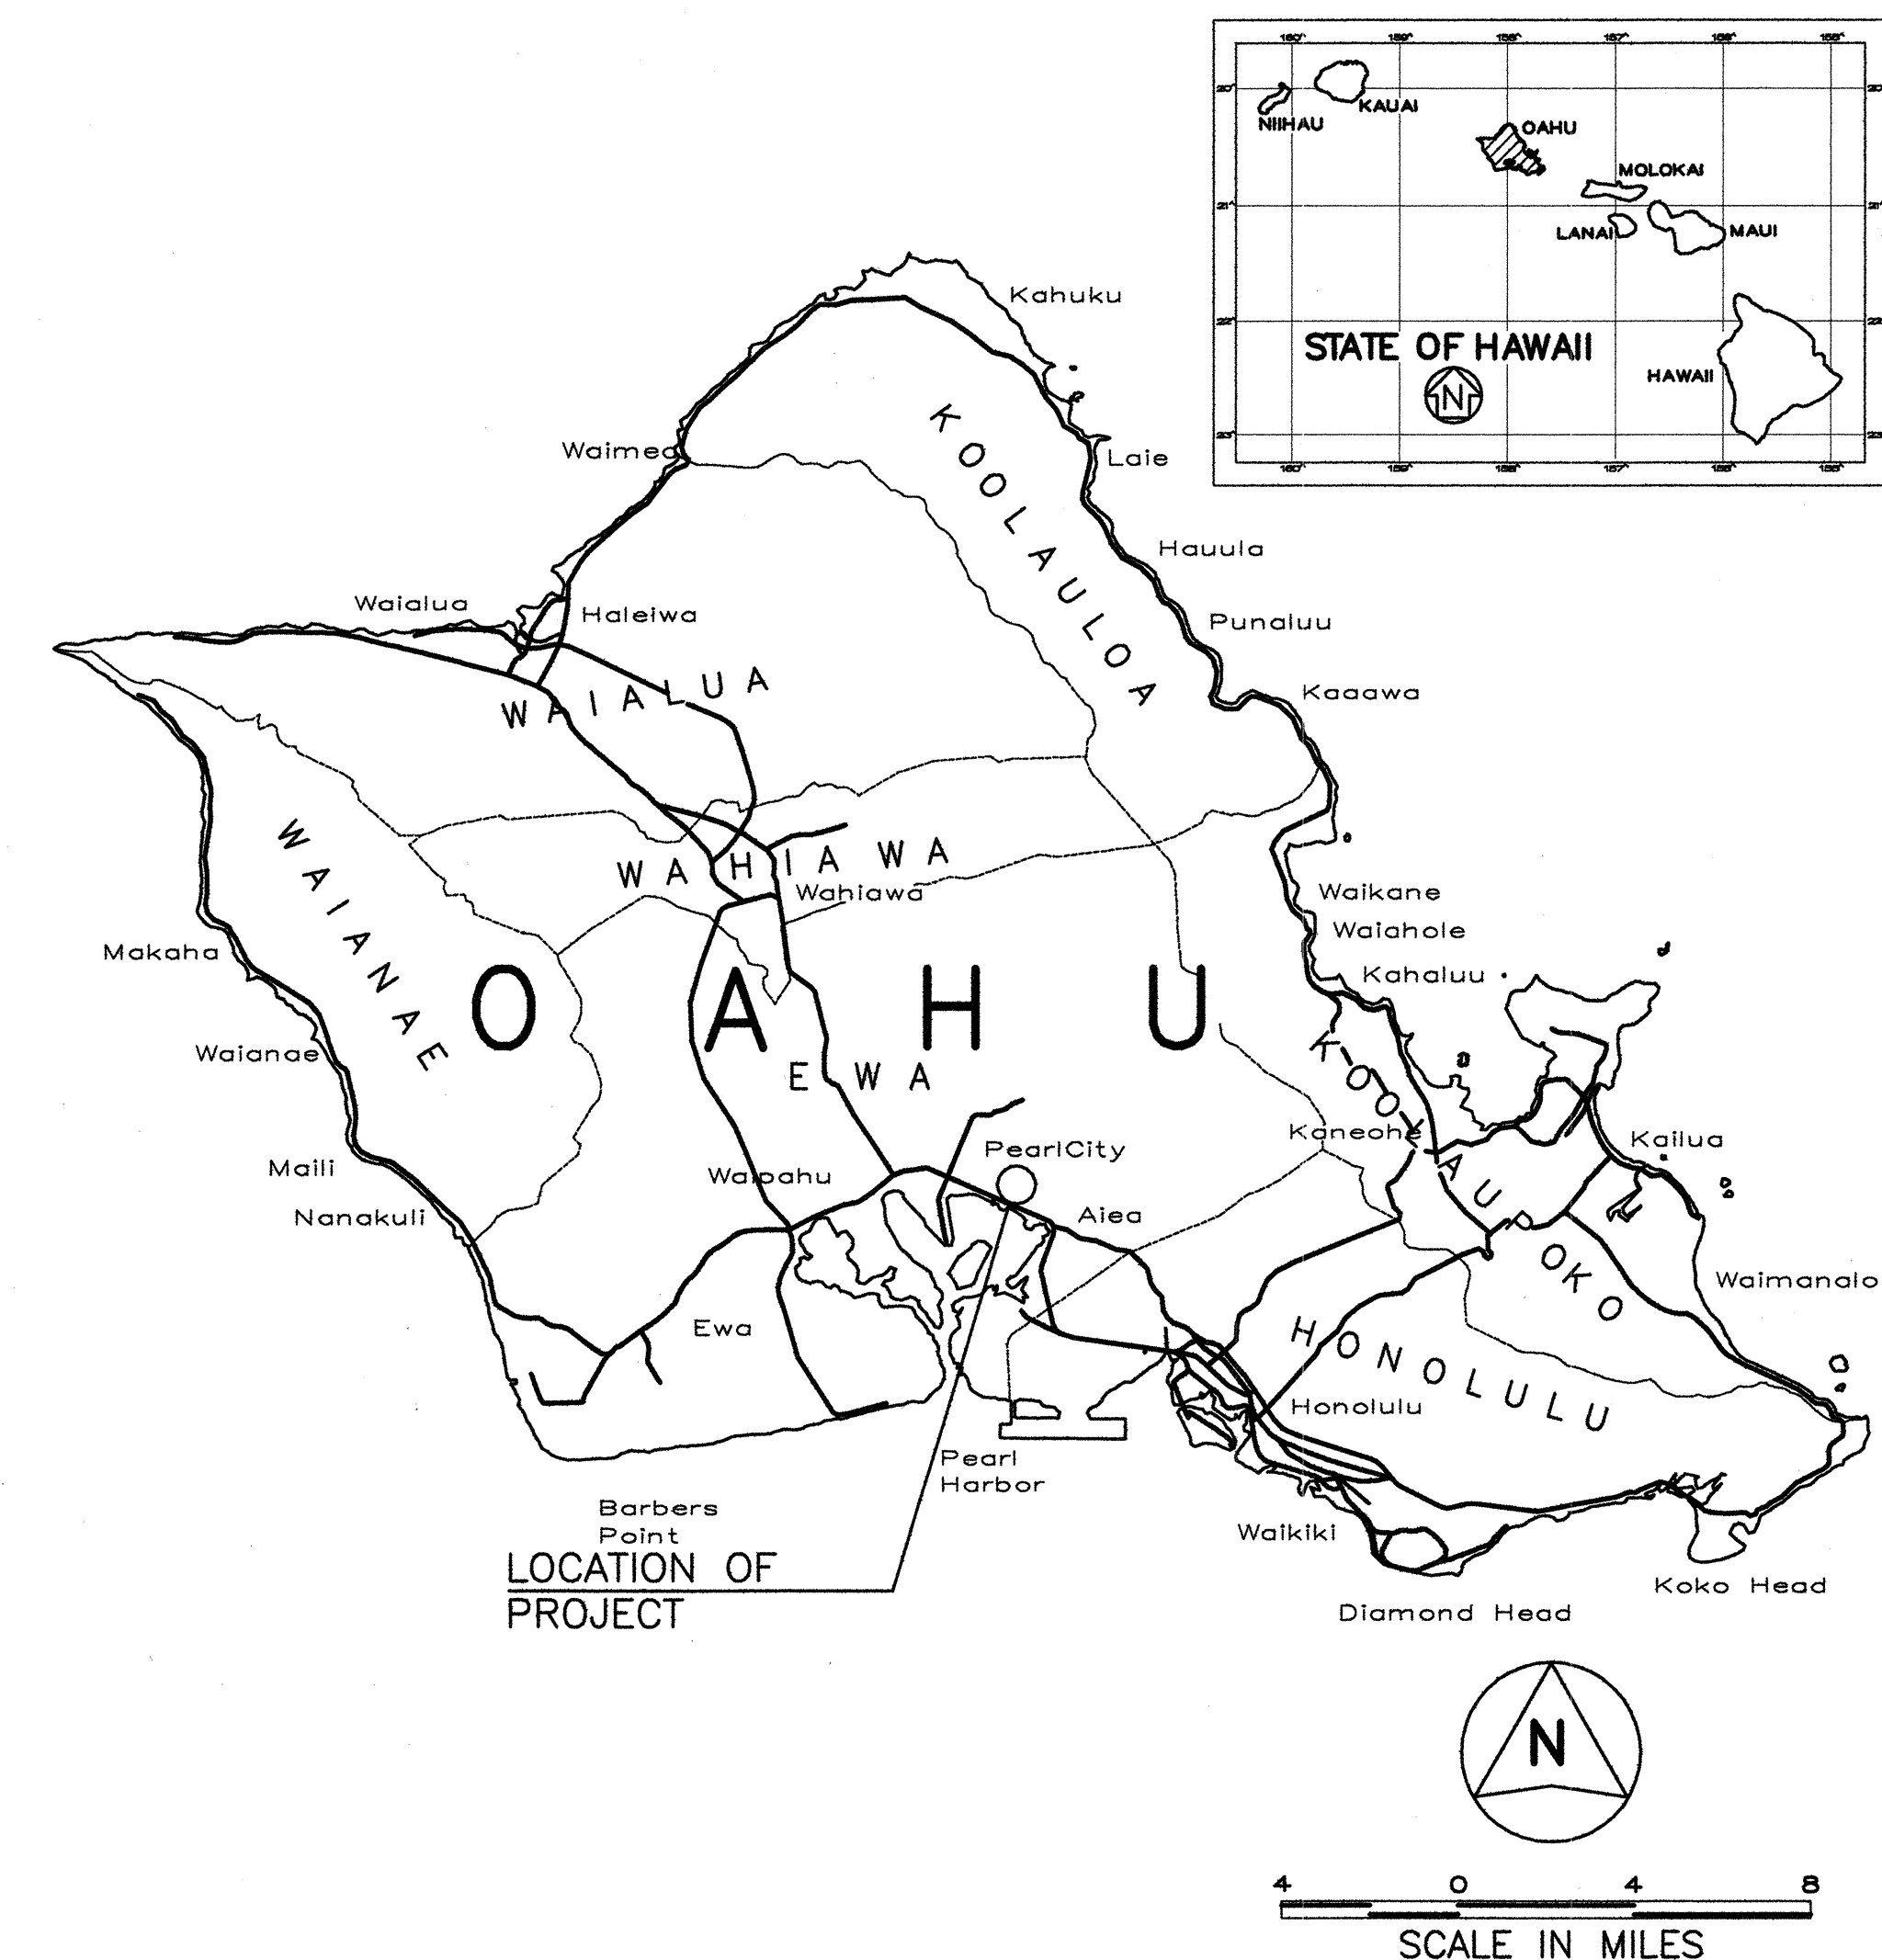

LOCATION PLAN

NOT TO SCALE

DEPARTMENT OF TRANSPORTATION STATE OF HAWAII	
APPROVED:	
<i>[Signature]</i>	5-5-16
DIR. OF TRANSPORTATION	DATE

LOU CHAN & ASSOCIATES

DESIGNED BY

HWY-DS

MANAGED BY

(808)692-7544

PHONE

APRIL 2016

DATE