


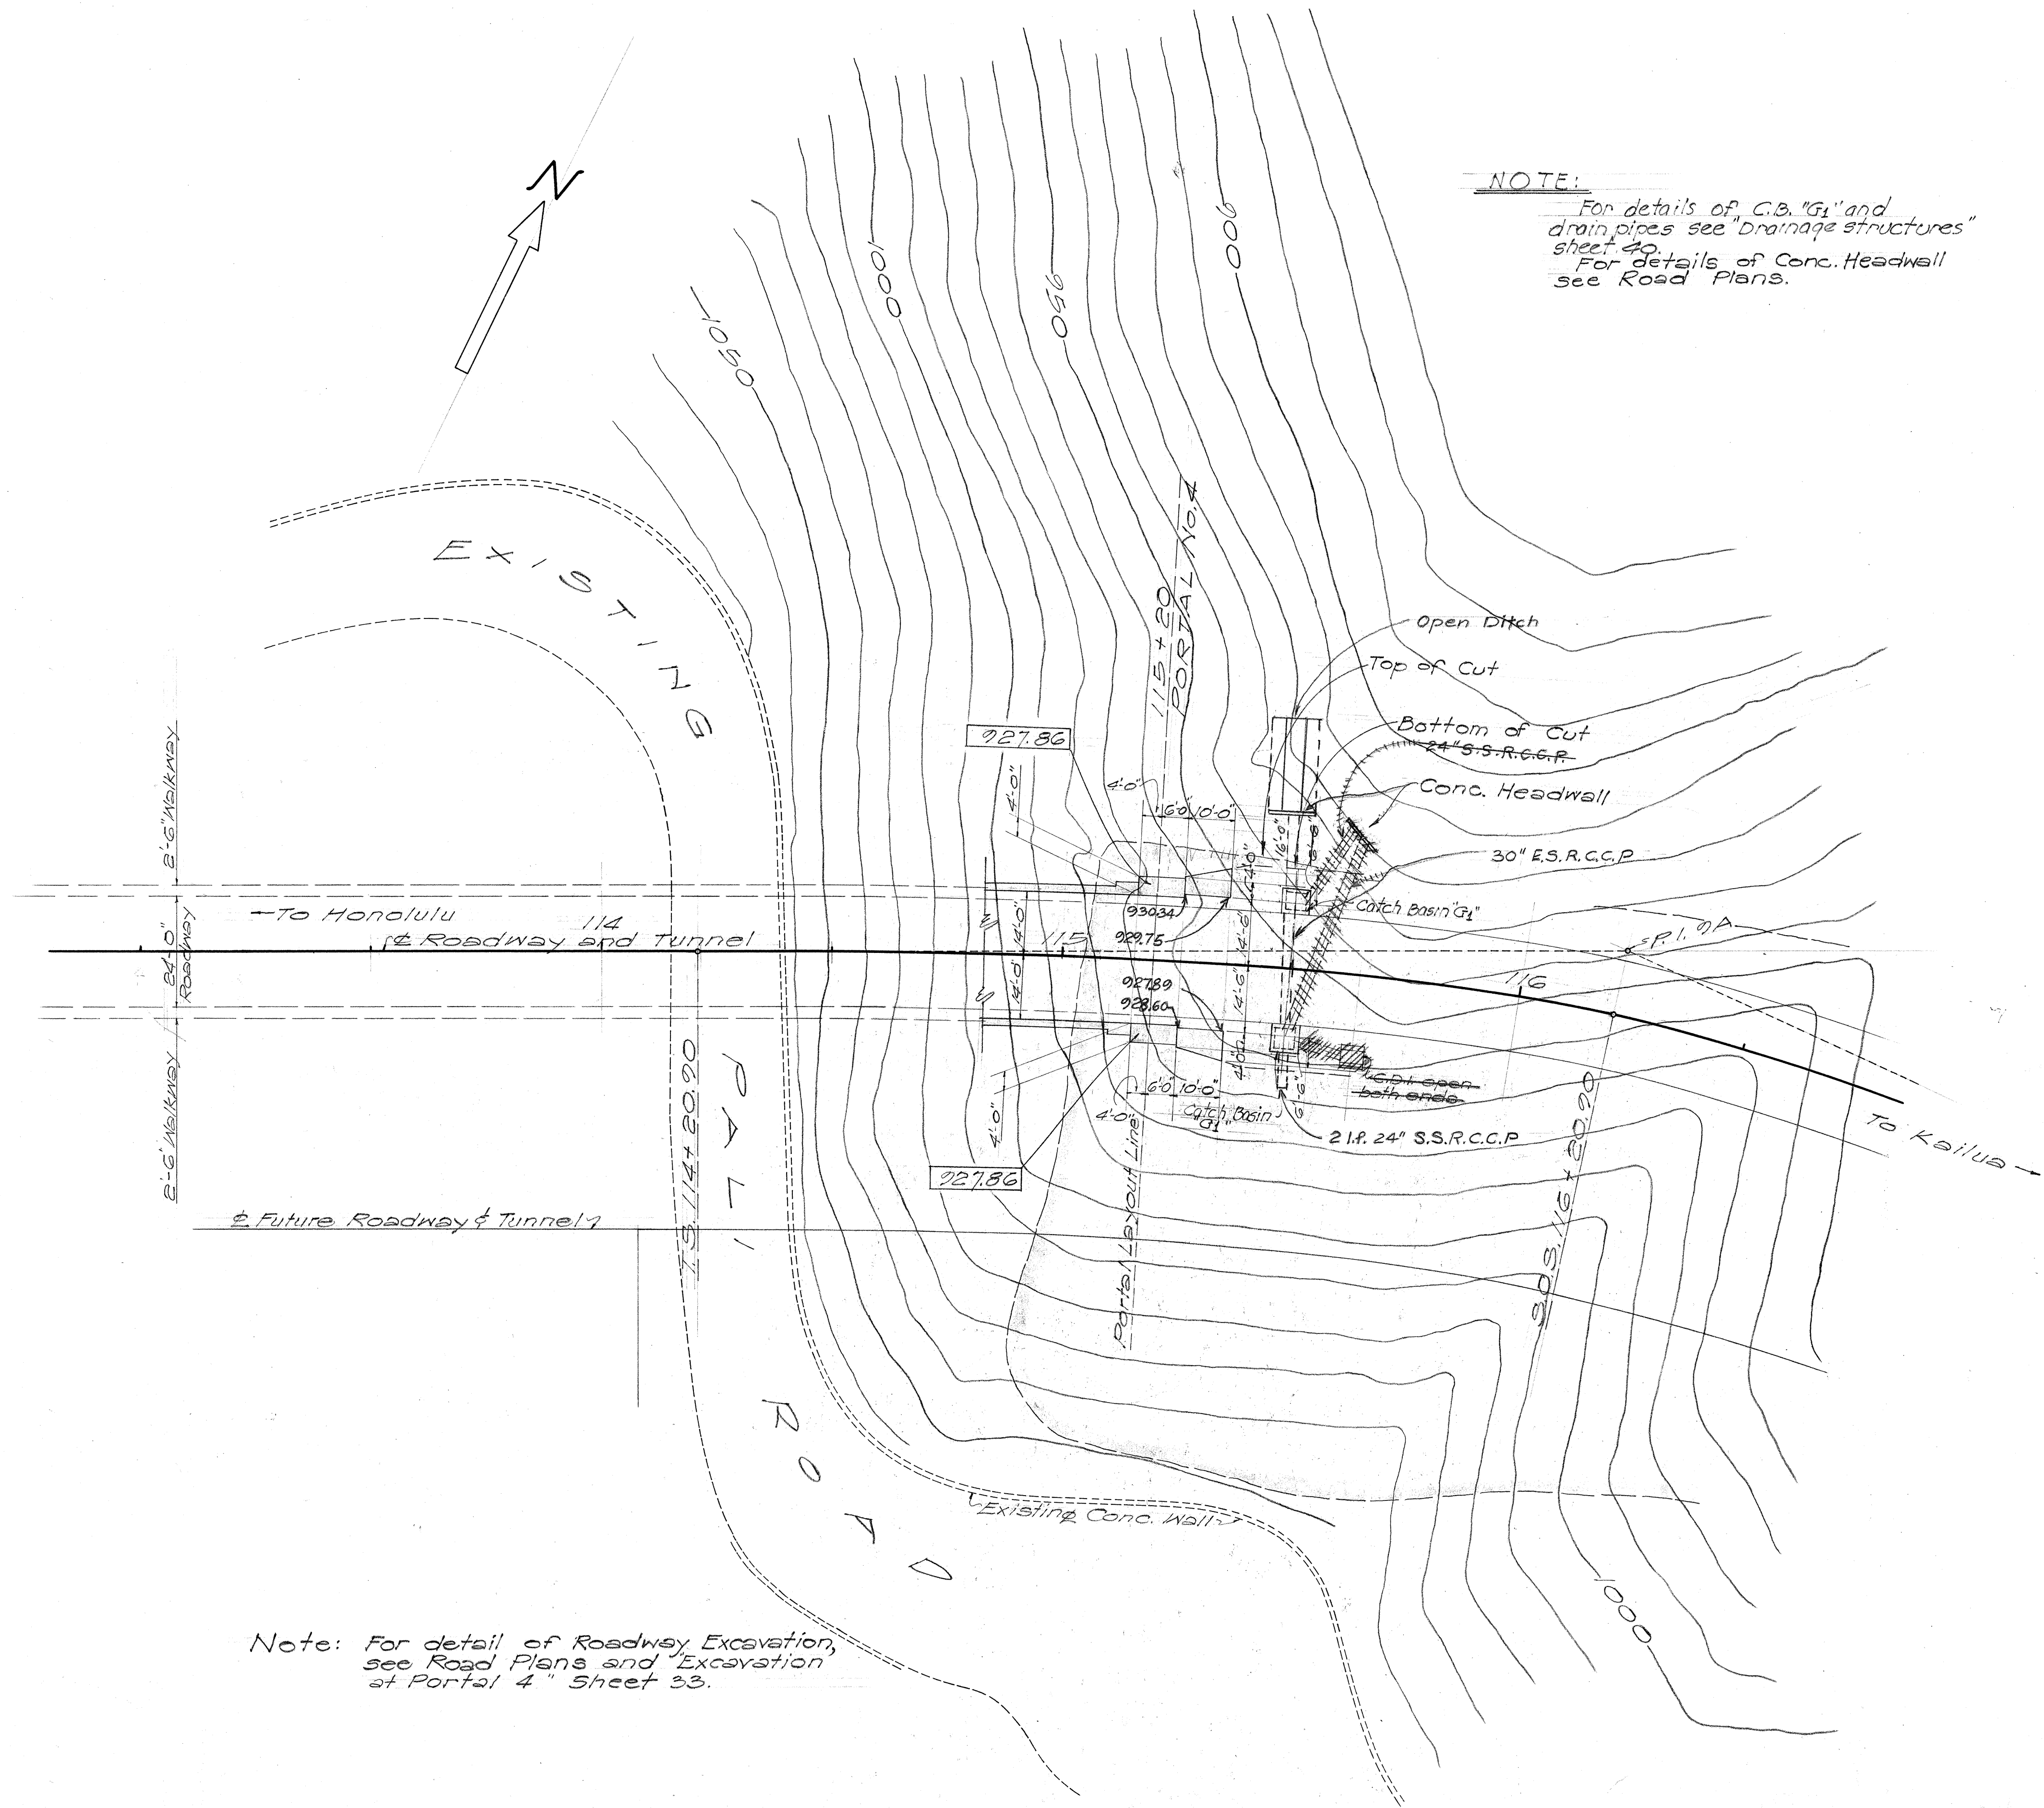

NOTE:
For details of C.B. "G1" and
drain pipes see "Drainage structures"
sheet 40.
For details of Conc. Headwall
see Road Plans.

NOTE:
Footings Elevation indicated
thus: 927.86


Note: For detail of Roadway Excavation,
see Road Plans and "Excavation"
at Portal 4 "Sheet 33.

TERRITORIAL HIGHWAY DEPARTMENT
TERRITORY OF HAWAII
FOUNDATION PLAN AT
PORTAL 4
NUUANU PALI TUNNELS
PALI ROAD
PROJ. NO. SEIG(5)
Scale: 1" = 20'-0" June 1954


SHEET No. 30 OF 42 SHEETS

5508.30


SURVEY PLOTTED BY: DATE: 5/29/54
DESIGNED BY: J. P. Brown
DRAWN BY: J. P. Brown
NOTE BOOK NO.:
QUANTITIES CHECKED BY:
CHECKED BY: J. P. Brown

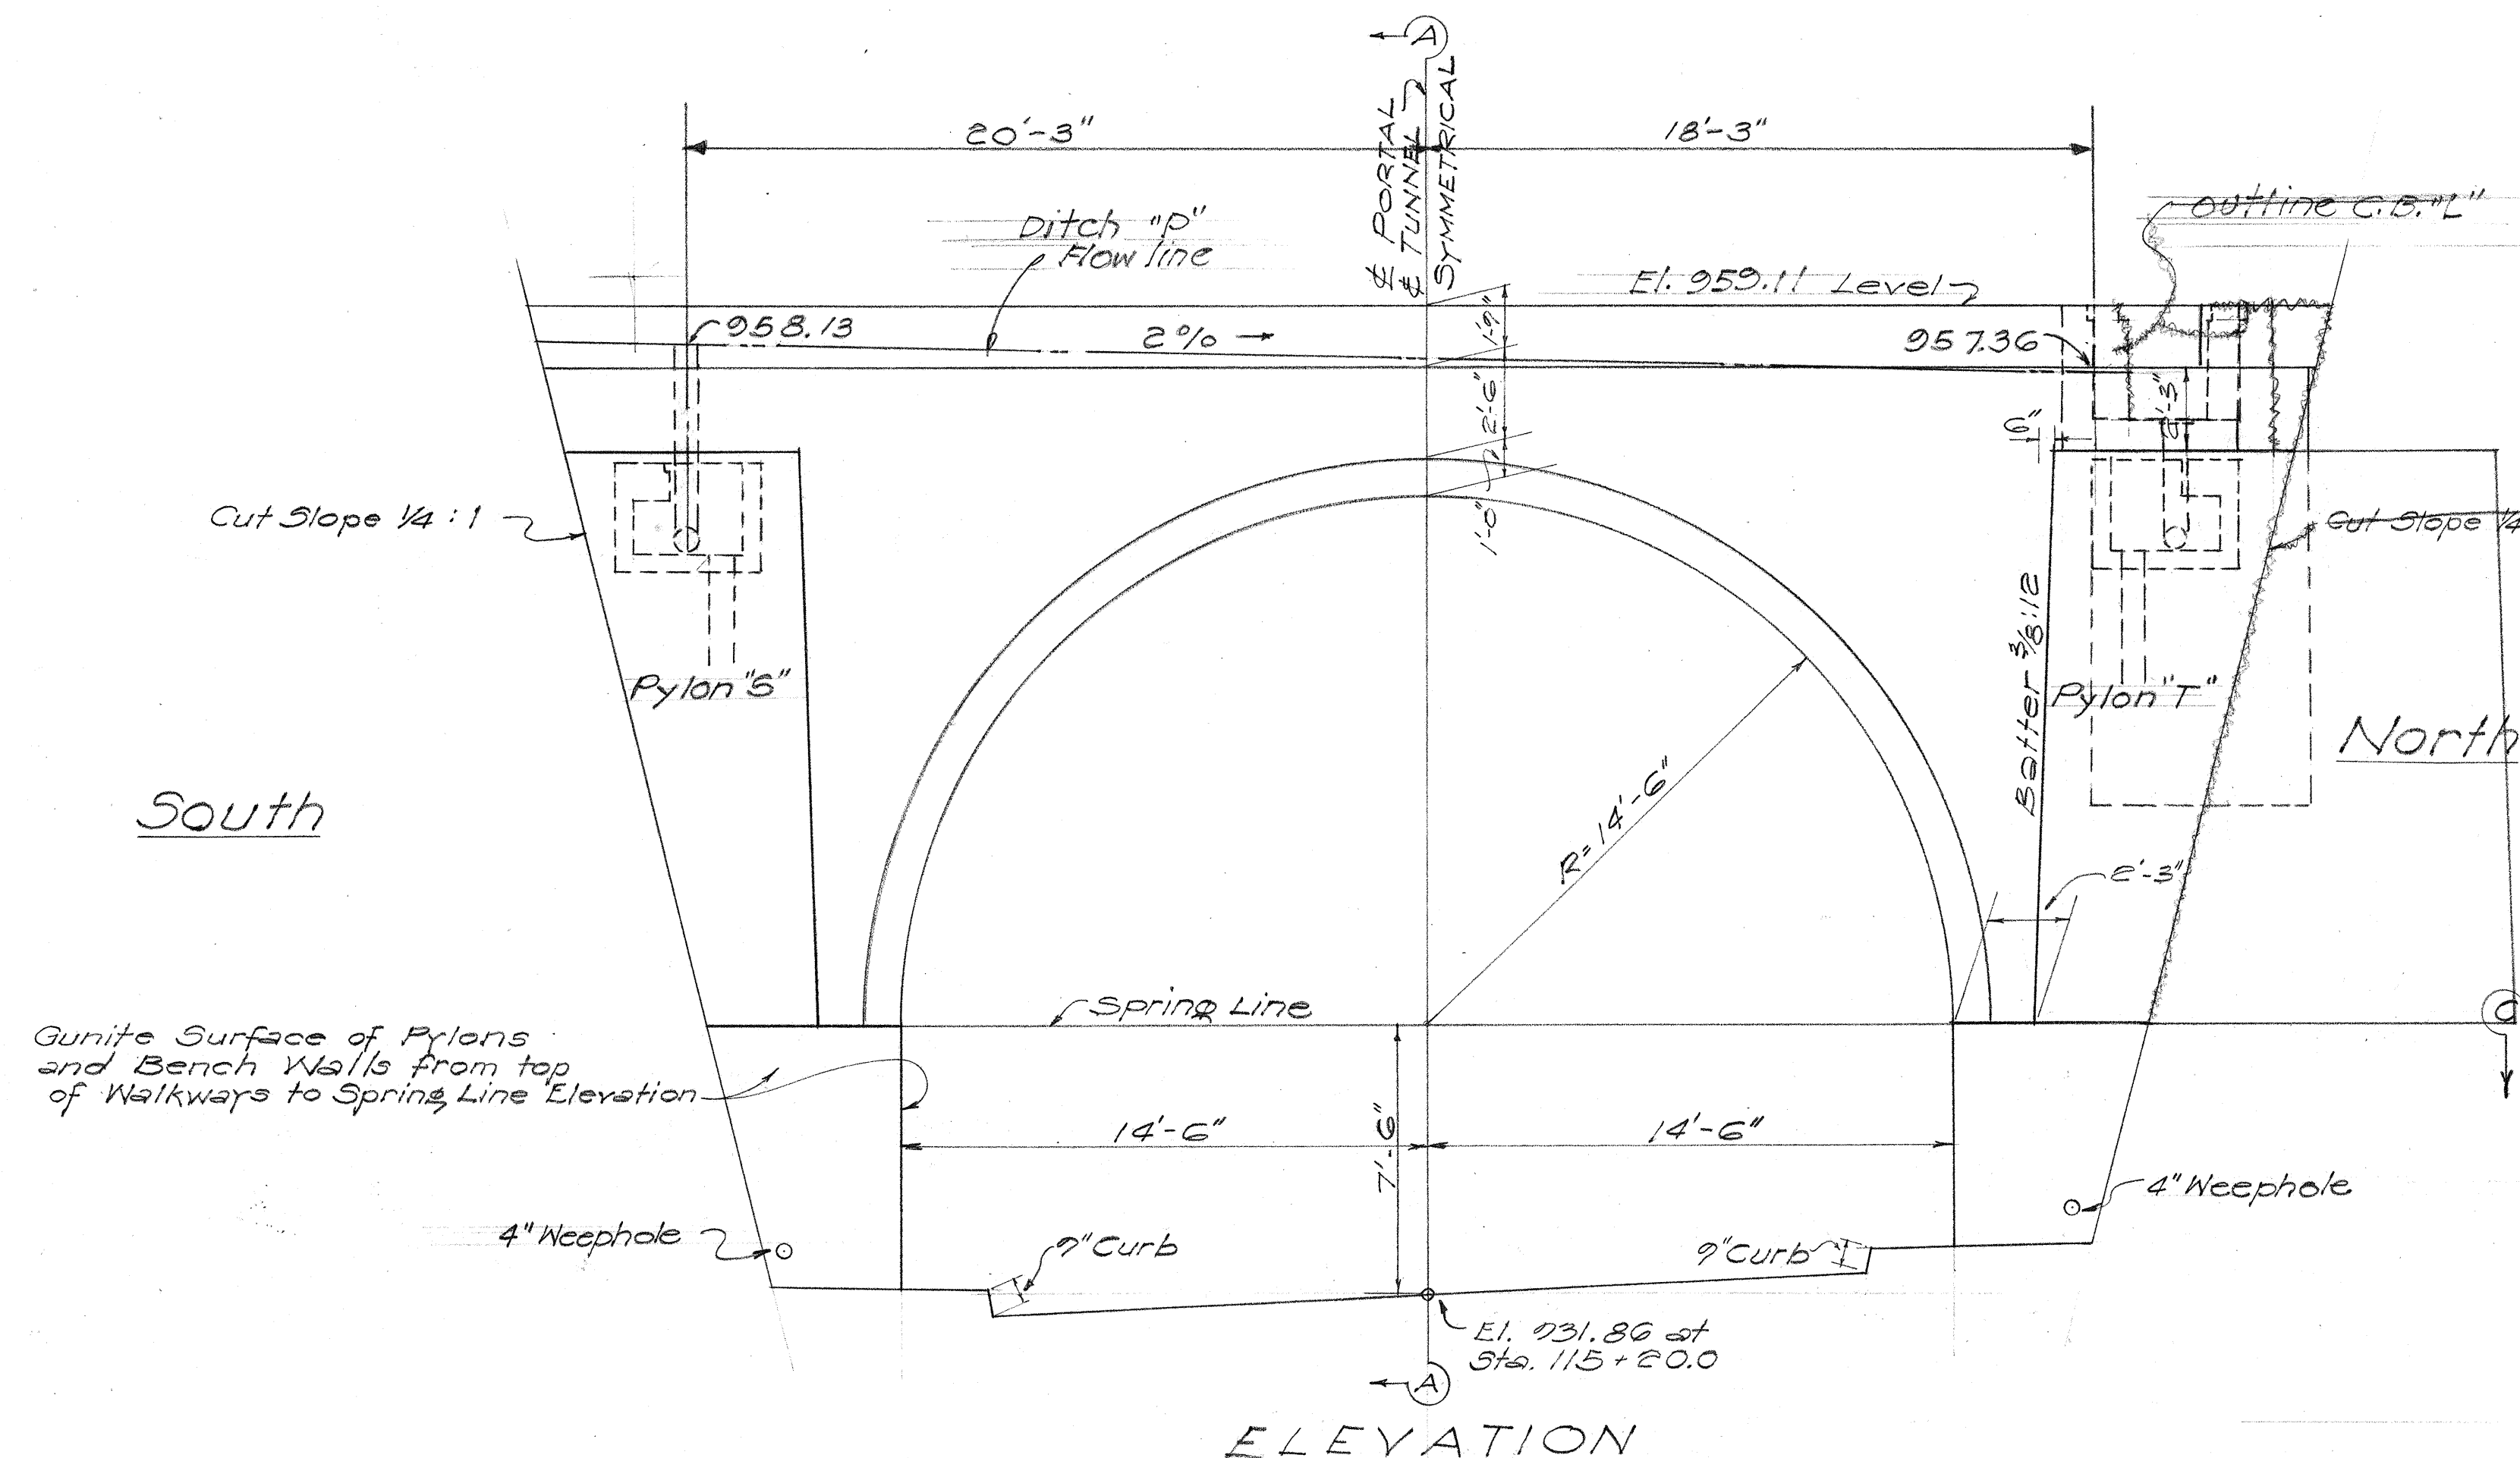


Reinforcement and anchor bolt in end bench wall is similar to that shown on "Detail of Pylon 'H'" sheet 17

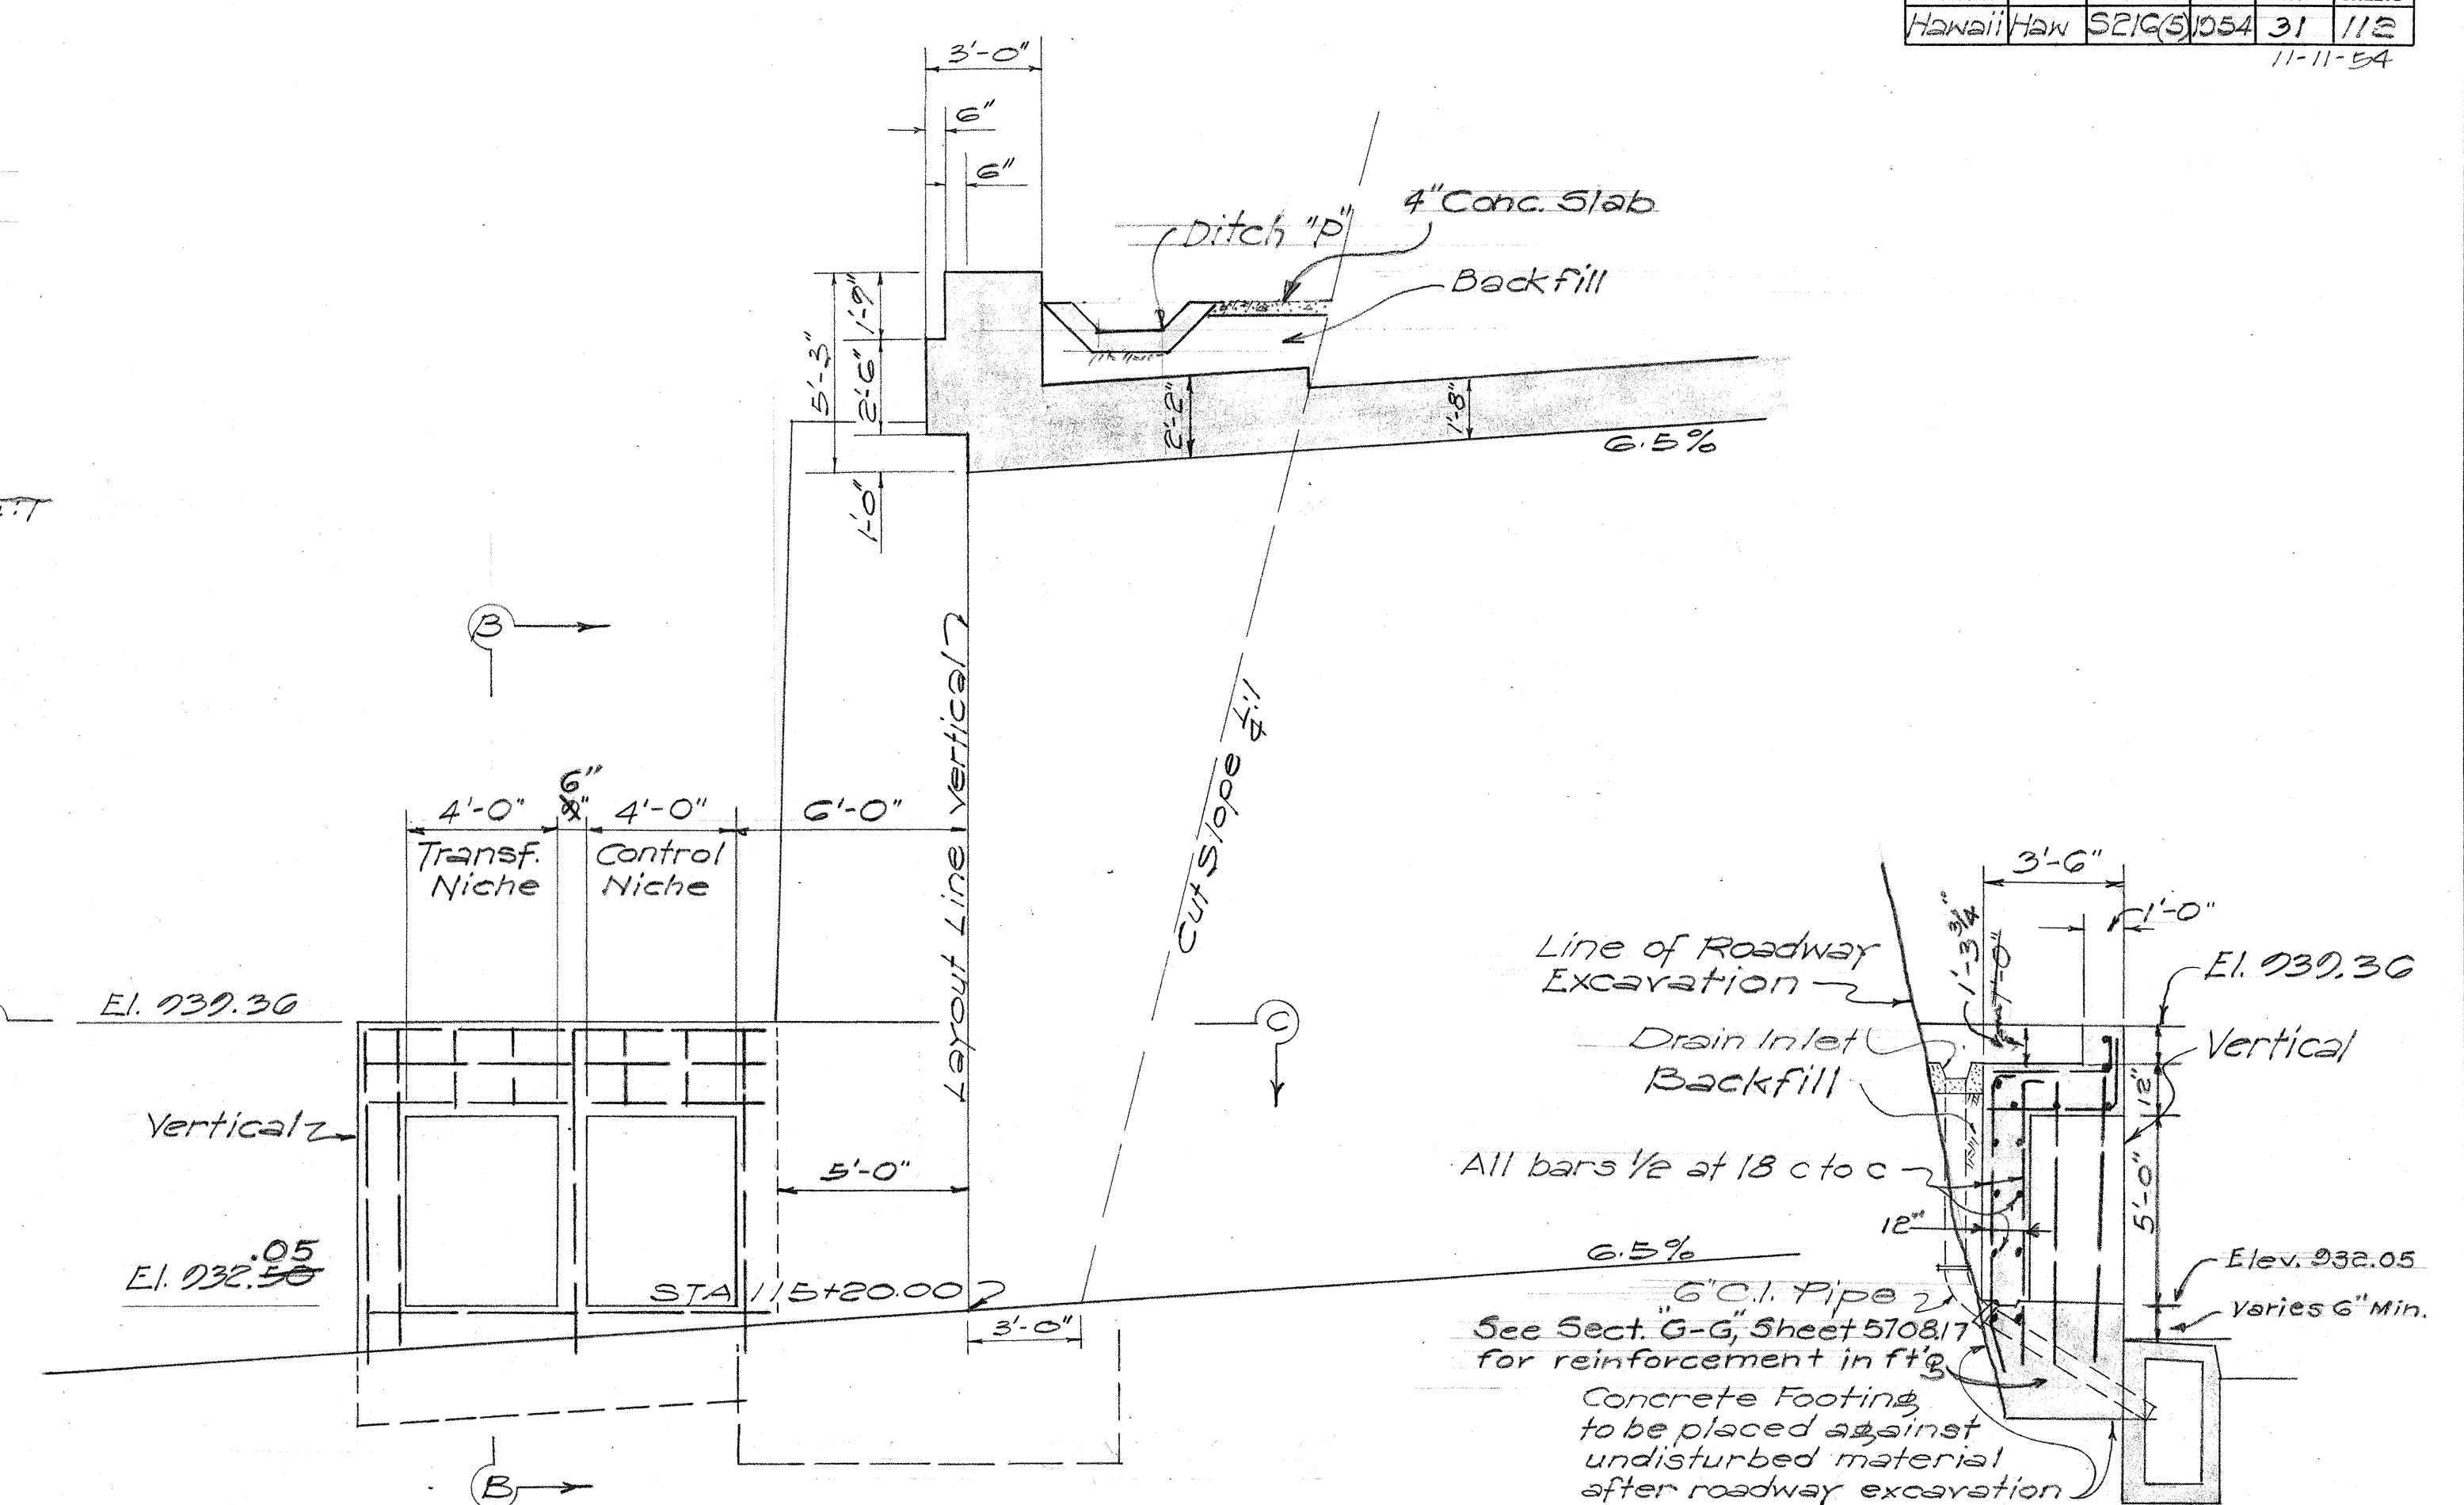

Note: Dimensions of transfer and control niches may be changed to fit electrical details; see "Portal #2 and #4 Electrical Plan" sheet 46.

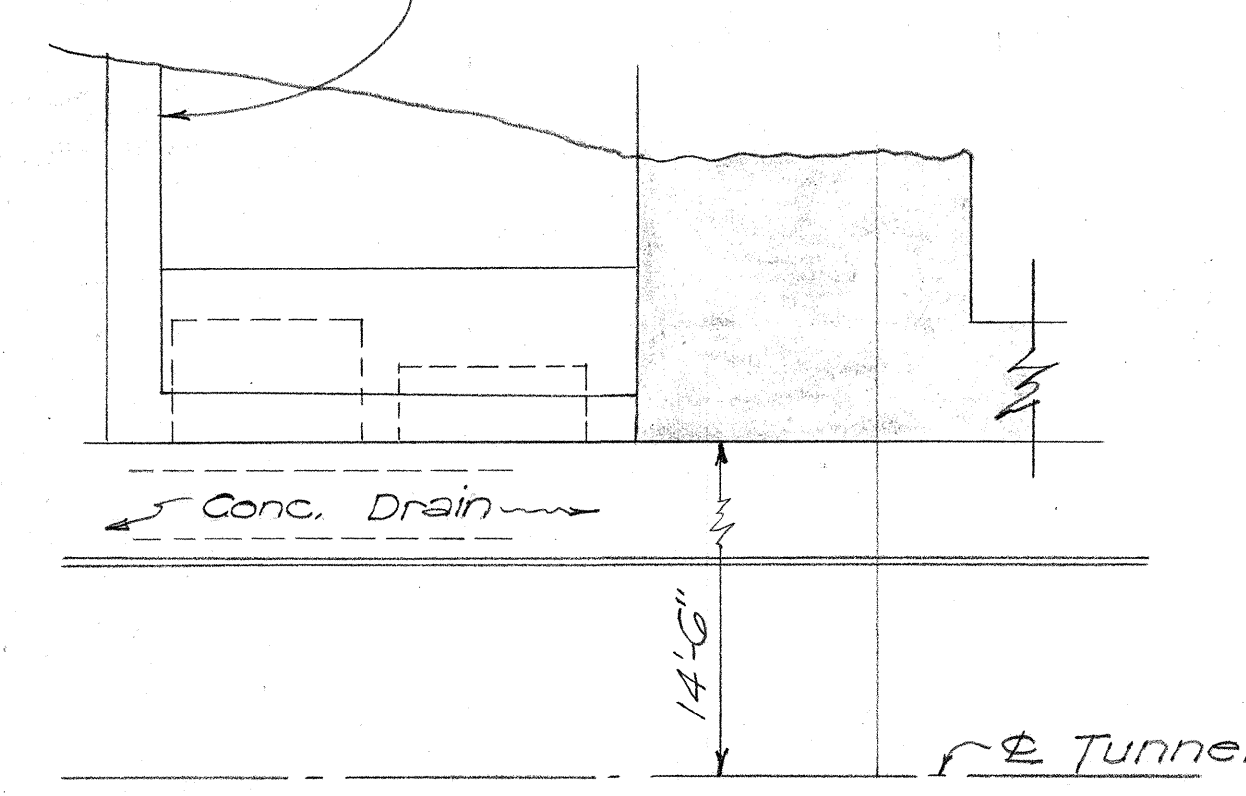

Note: Pylons 'S' and 'T' are similar to Pylon 'H' see "Detail of Pylon 'H'" sheet 17. For details of Ditch 'P' and Catch Basins 'L' and 'M' see "Drainage Structures" sheet 45.

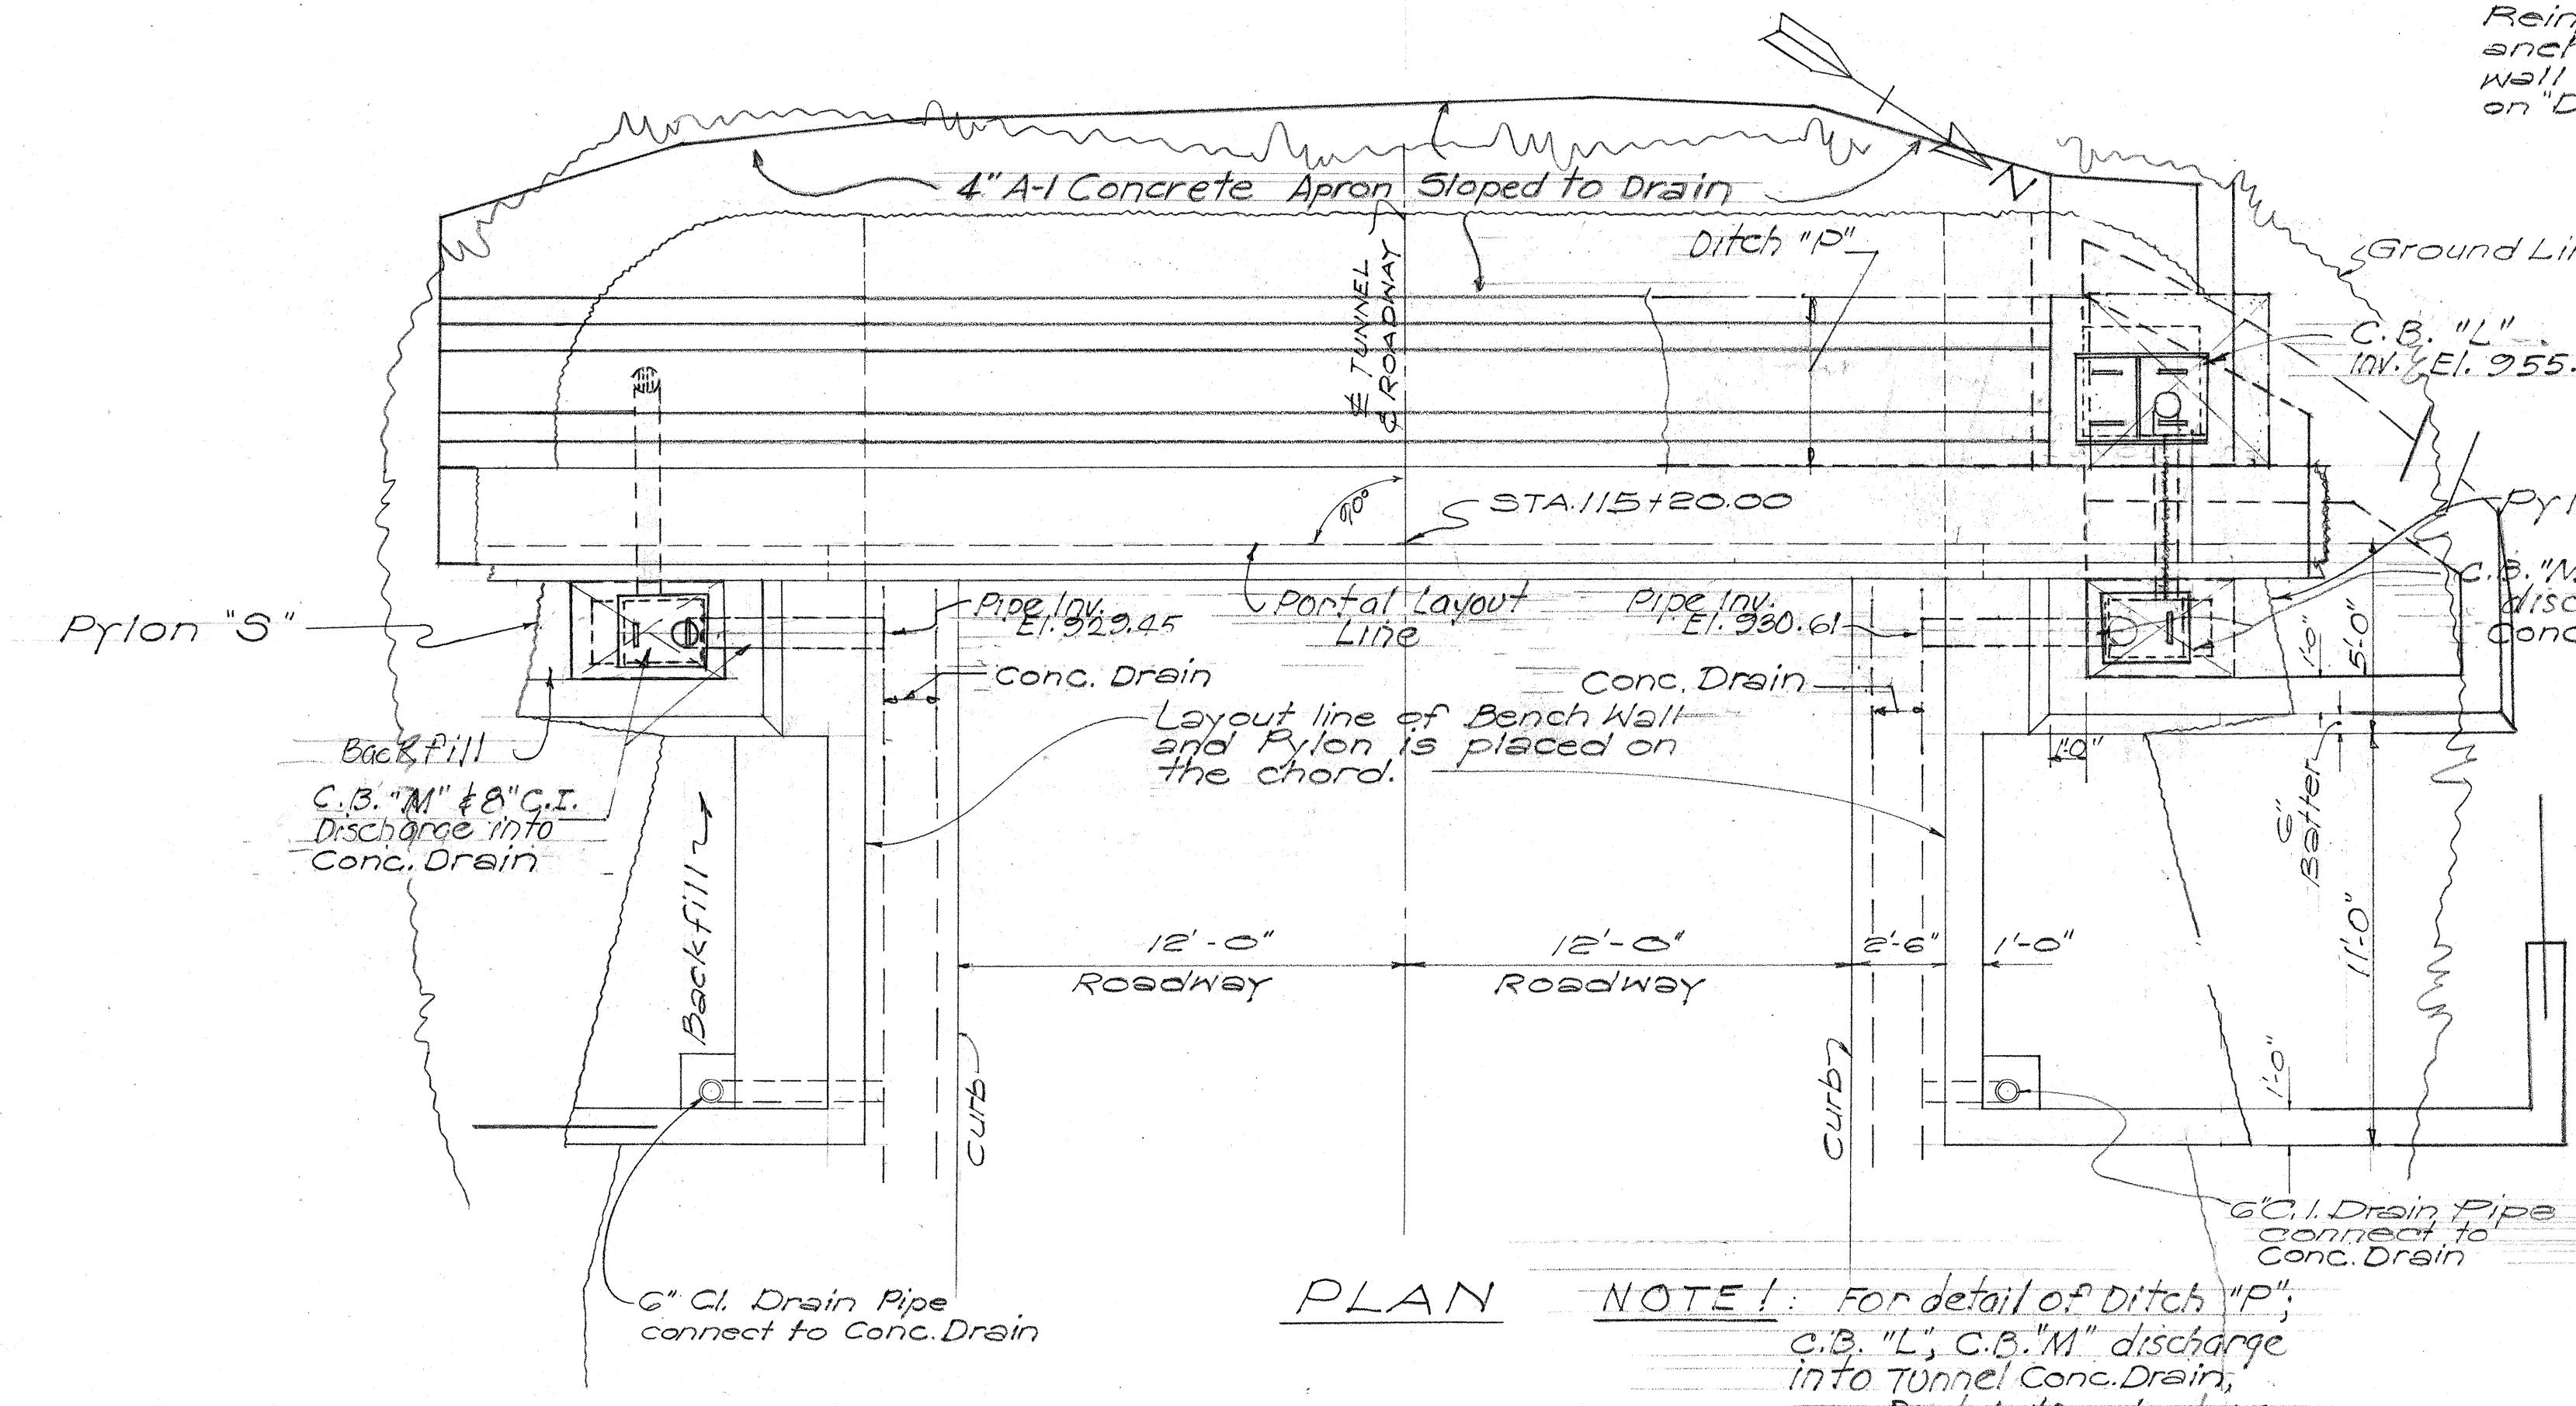

NOTE: For detail of Ditch 'P'; C.B. 'L', C.B. 'M' discharge into Tunnel Conc. Drain; see Portal #2 sheet 15.

DESIGNED BY	DATE
DRIVEN BY	3-34
TRACED BY	
QUANTITIES CHECKED BY	
NOTED BY	
NO.	

TERRITORIAL HIGHWAY DEPARTMENT
TERRITORY OF HAWAII

PORTAL 4
NUUANU PALI TUNNELS
PALI ROAD

PROJ. No. 5219(5)
Scale: 1" = 1'-0" June 1954