



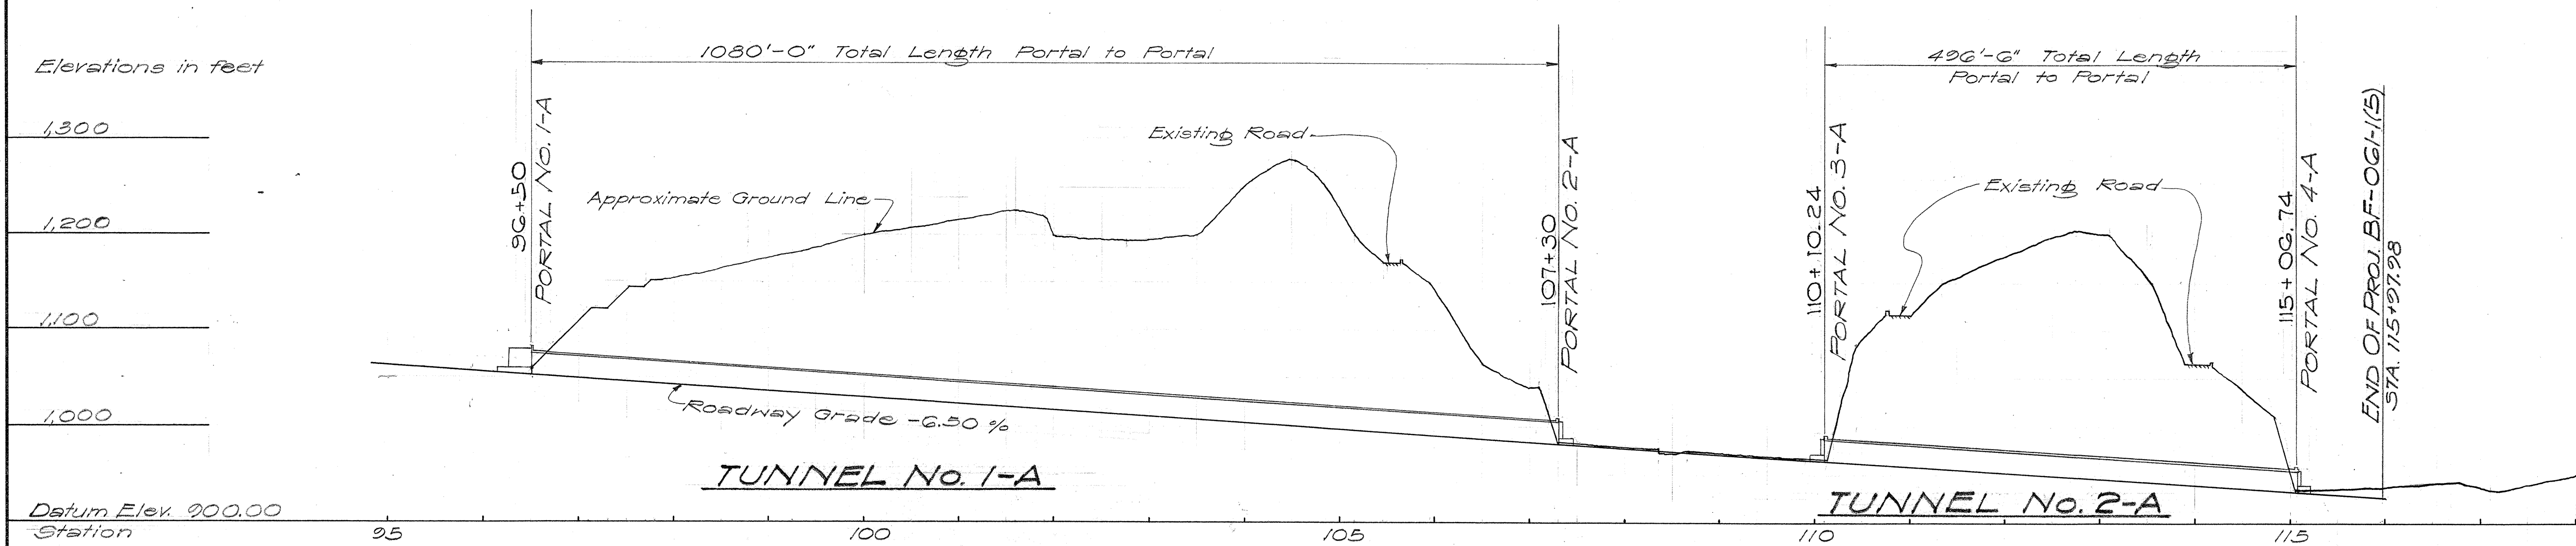

SECTION ALONG &

NOTE:

Indicated tunnel portals, sites, and structures, including pylons for both Tunnels 1-A and 2-A may be modified if the engineer considers subsurface or field conditions encountered during construction warrant.

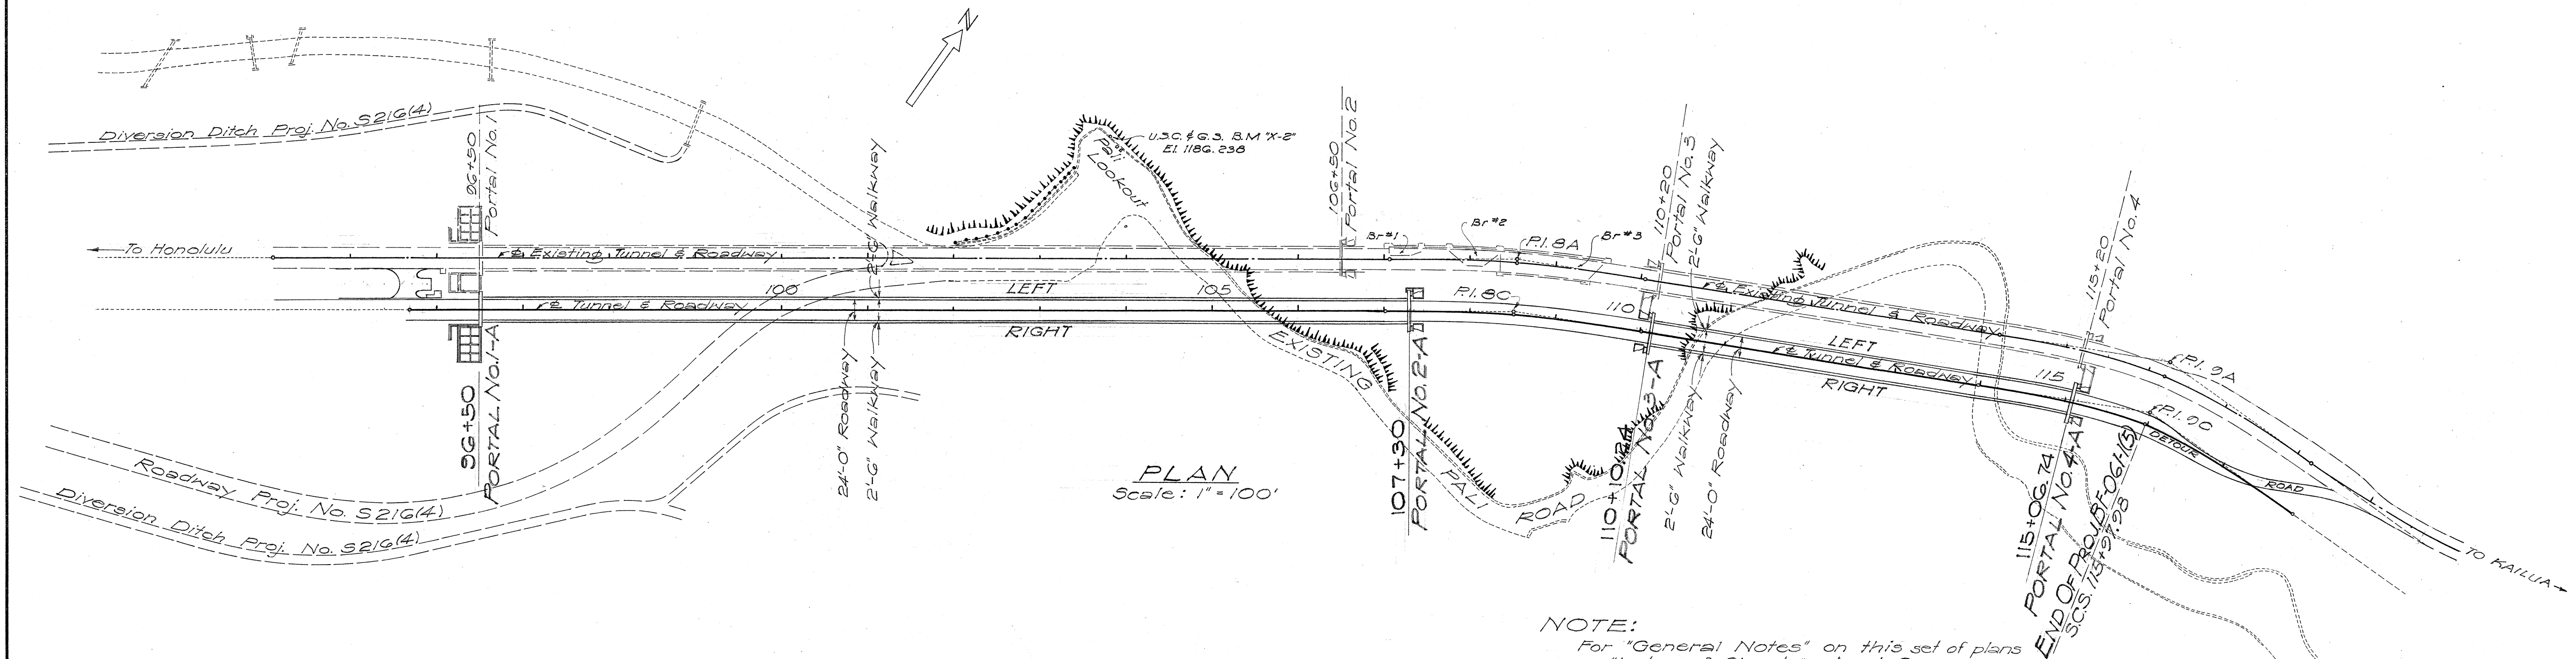

NOTE:

For "General Notes" on this set of plans see "Index of Sheets", sheet 2.
For Details of Lighting see Electrical Plans, sheets 43 to 55 inclusive.
For Details of Road see Road Plans, sheets 56 to 60 inclusive.

TERRITORIAL HIGHWAY DEPARTMENT
TERRITORY OF HAWAII

GENERAL PLANS
TUNNEL NOS. 1-A & 2-A

PALI ROAD
OUTBOUND TUNNELS
PROJ. No. BF-061(15)

Scale: 1"=100' Oct. 1956

SHEET No. OF SHEETS

5596.3

SURVEY PLOTTED BY	DATE
DESIGNED BY	10-56
DRAWN BY	10-56
CHECKED BY	7-57
NOTE BOOK	
No.	