


ELECTRICAL SYMBOLS

- CEILING LIGHT
- CEILING NIGHT LIGHT
- H BRACKET LIGHT
- H BRACKET NIGHT LIGHT
- H CLOCK OUTLET, 1/2"
- H RECP. DUPLEX 15A 125V, SAFETY TYPE
- H RECP. DUPLEX 15A 125V, GRD. TYPE, 3 WIRE
- H WALL SWITCH 1P 20A 125V, CONTROLLING OUTLET "A"
- H THREE-WAY SWITCH, 20A 125V
- H WATER HEATER CONNECTION
- H PROGRAM CLOCK (REINSTALL)
- CONCEALED CONDUIT RUN IN WALL OR CEILING, 2 WIRES
- CONCEALED RUN IN FLOOR SLAB
- OR UNDER FLOOR, 2 WIRES
- EXPOSED EMT RUN, 2 WIRES INDICATED
- TYPE UF CABLE IN WOOD PARTITIONS & JAMES,
- TYPE AC OTHERWISE
- JUNCTION BOX
- EXISTING OUTLET TO BE BLANKED OUT.


NOTES

1. REMOVE ALL ACCESSIBLE EXISTING WIRING INCLUDING RACEWAYS, CABLES, DEVICES & FIXTURES. MATERIAL REMOVED SHALL BECOME THE PROPERTY OF THE CONTRACTOR.
2. PROVIDE BLANK COVERS AND PLATES FOR ABANDONED BOXES IMBEDDED IN STRUCTURE. PAINT TO MATCH SURROUNDING FINISH.
3. APPLY ZINC-CHROMATE PRIMER AND 2 COATS ENAMEL PAINT ON EXPOSED RACEWAYS TO MATCH SURROUNDING FINISH.
4. PROVIDE CAST METAL OUTLET BOX TO RECEIVE FIXTURE CANOPY WHERE RACEWAY IS EXPOSED.
5. IN EXIST PORTION OF BLDG. NEW RECEPTACLE BOXES TO BE FLUSH MOUNTED BY CHANNELING HOLLOW BLOCK WALL.
6. SEE PLOT PLAN, SHEET NO. 1 FOR ALL EXTERIOR WIRING.
7. GROOVE CHANNELS IN WOODWORK FOR CABLE RUNS OR INSTALL WOOD MOLDING AS DIRECTED.

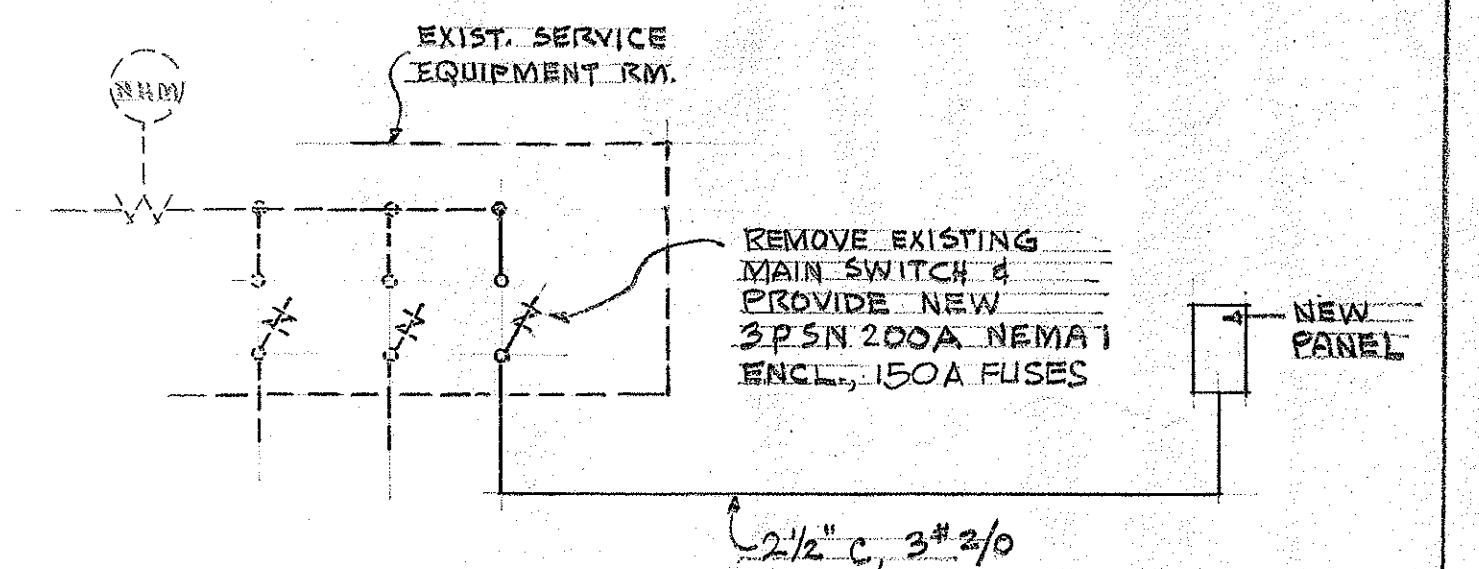


SINGLE-LINE DIAGRAM

NO SCALE.

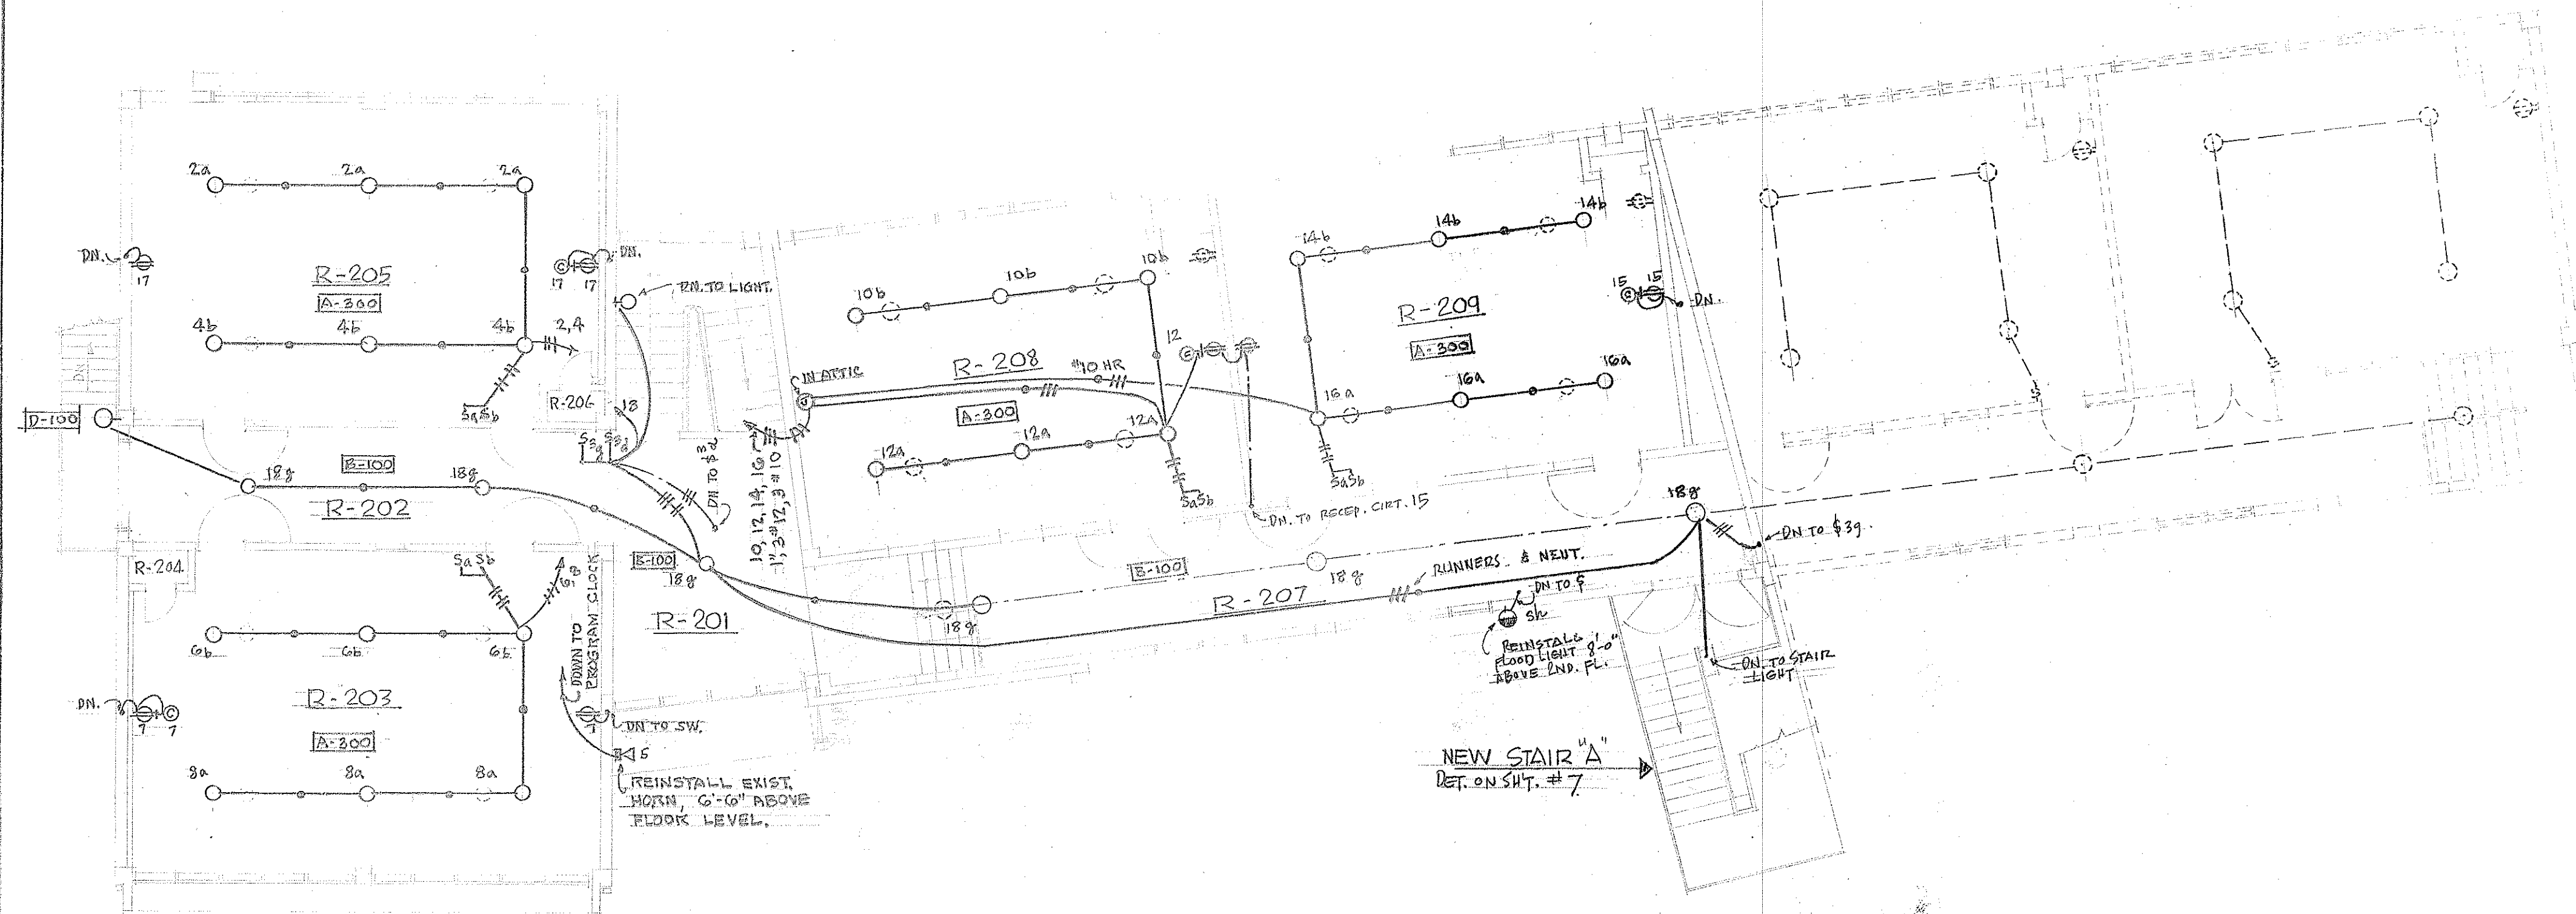

SECOND FLOOR ELECTRICAL LAYOUT

SCALE: 1/8" = 1'-0"

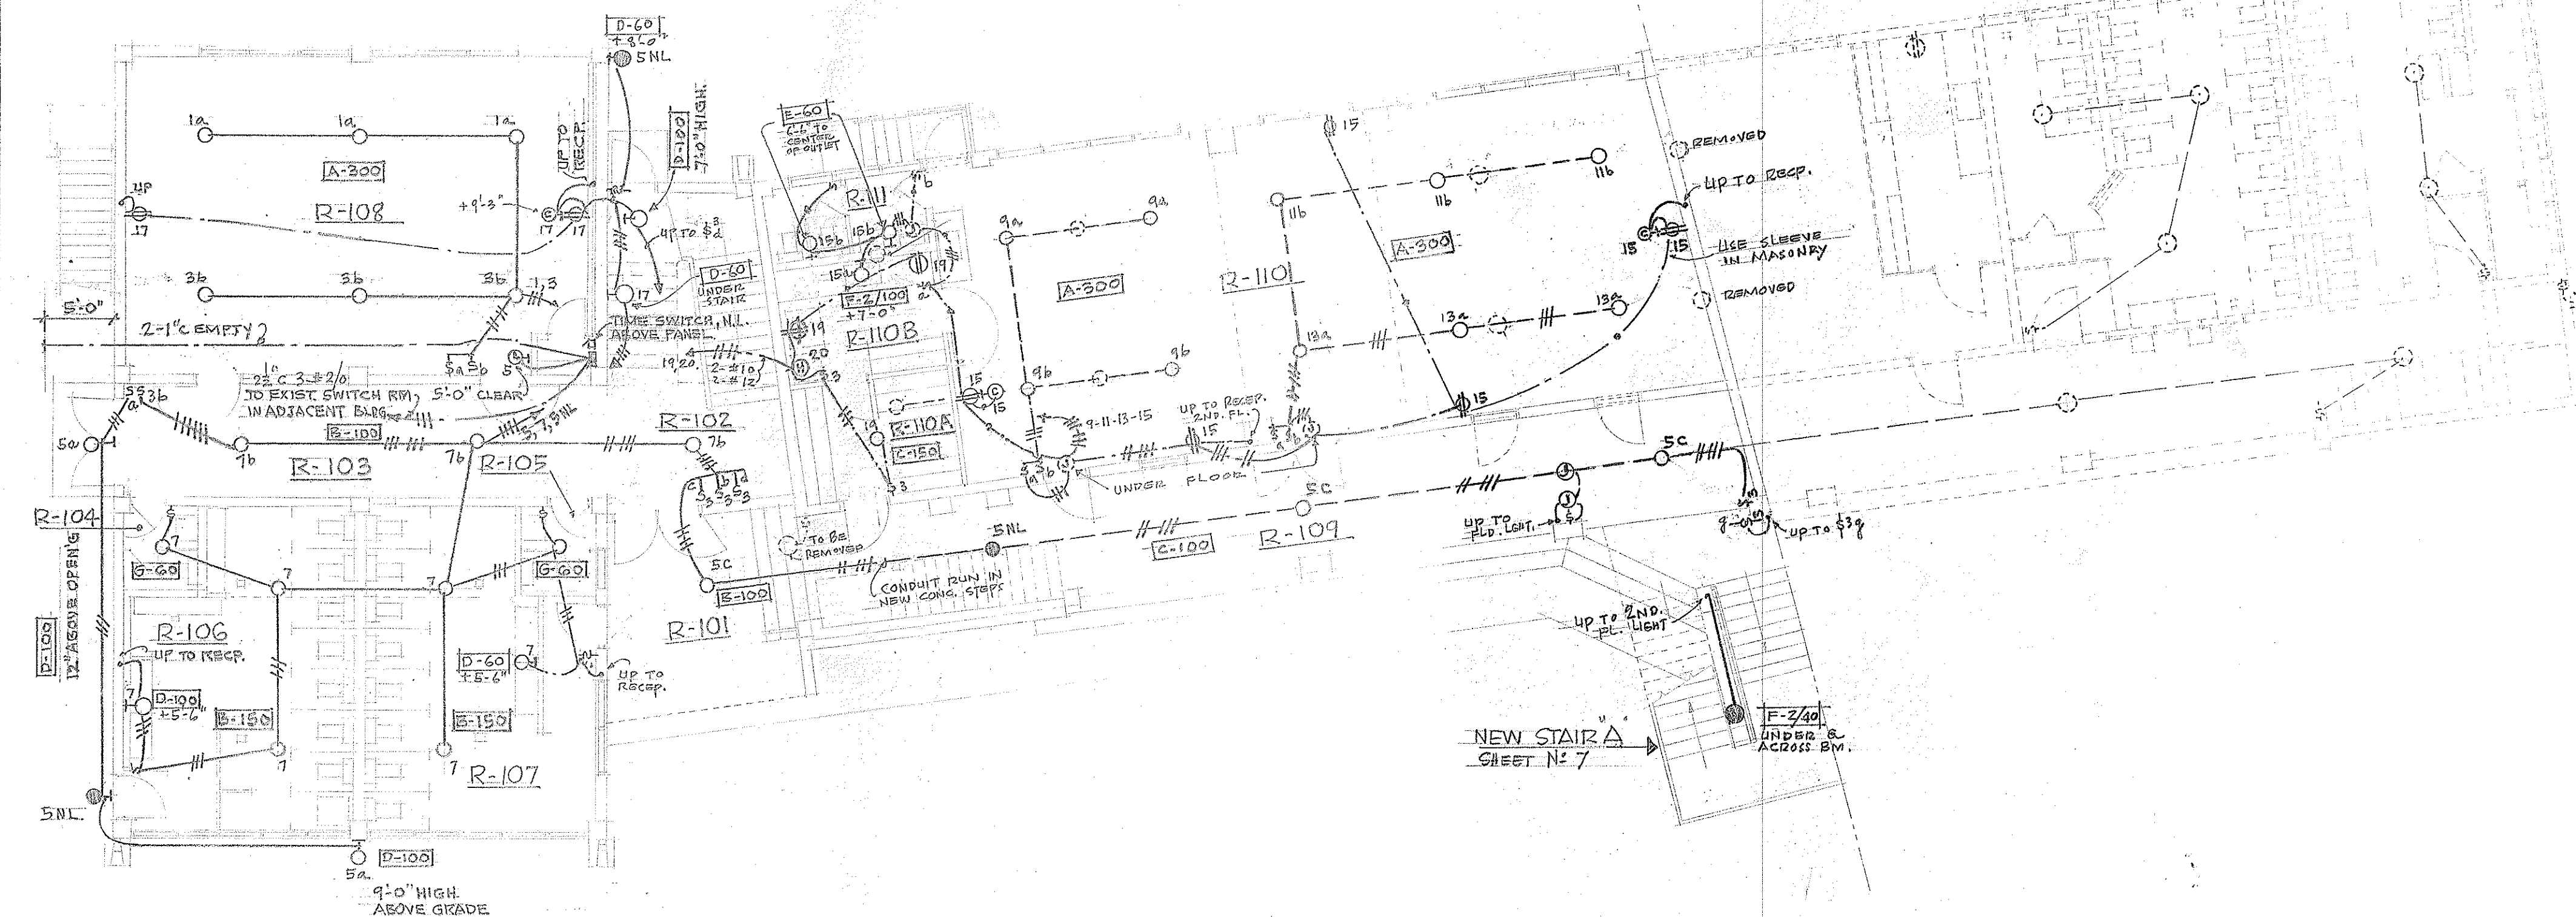

FIRST FLOOR ELECTRICAL LAYOUT

SCALE: 1/8" = 1'-0"

TERRITORIAL HIGHWAY DEPARTMENT TERRITORY OF HAWAII		
REHABILITATION OF CERTAIN EXISTG. IMPROVE- MENTS ON SCHOOL PREMISES OF HONPA HONGWANJI MISSION OF HAWAII FORT ST. HONOLULU, T.H. IN CONNECTION WITH NUUANU HIGHWAY PROJECT NO BU-OG1-1-(6)		
DATE JULY 1958	ROBERT T. KATSUYOSHI-ARCHITECT HEGO FUCHINO - ENGINEER 215 N. GREEN ST. HONOLULU, T.H.	SHEET 17 OF 18 SHEETS