



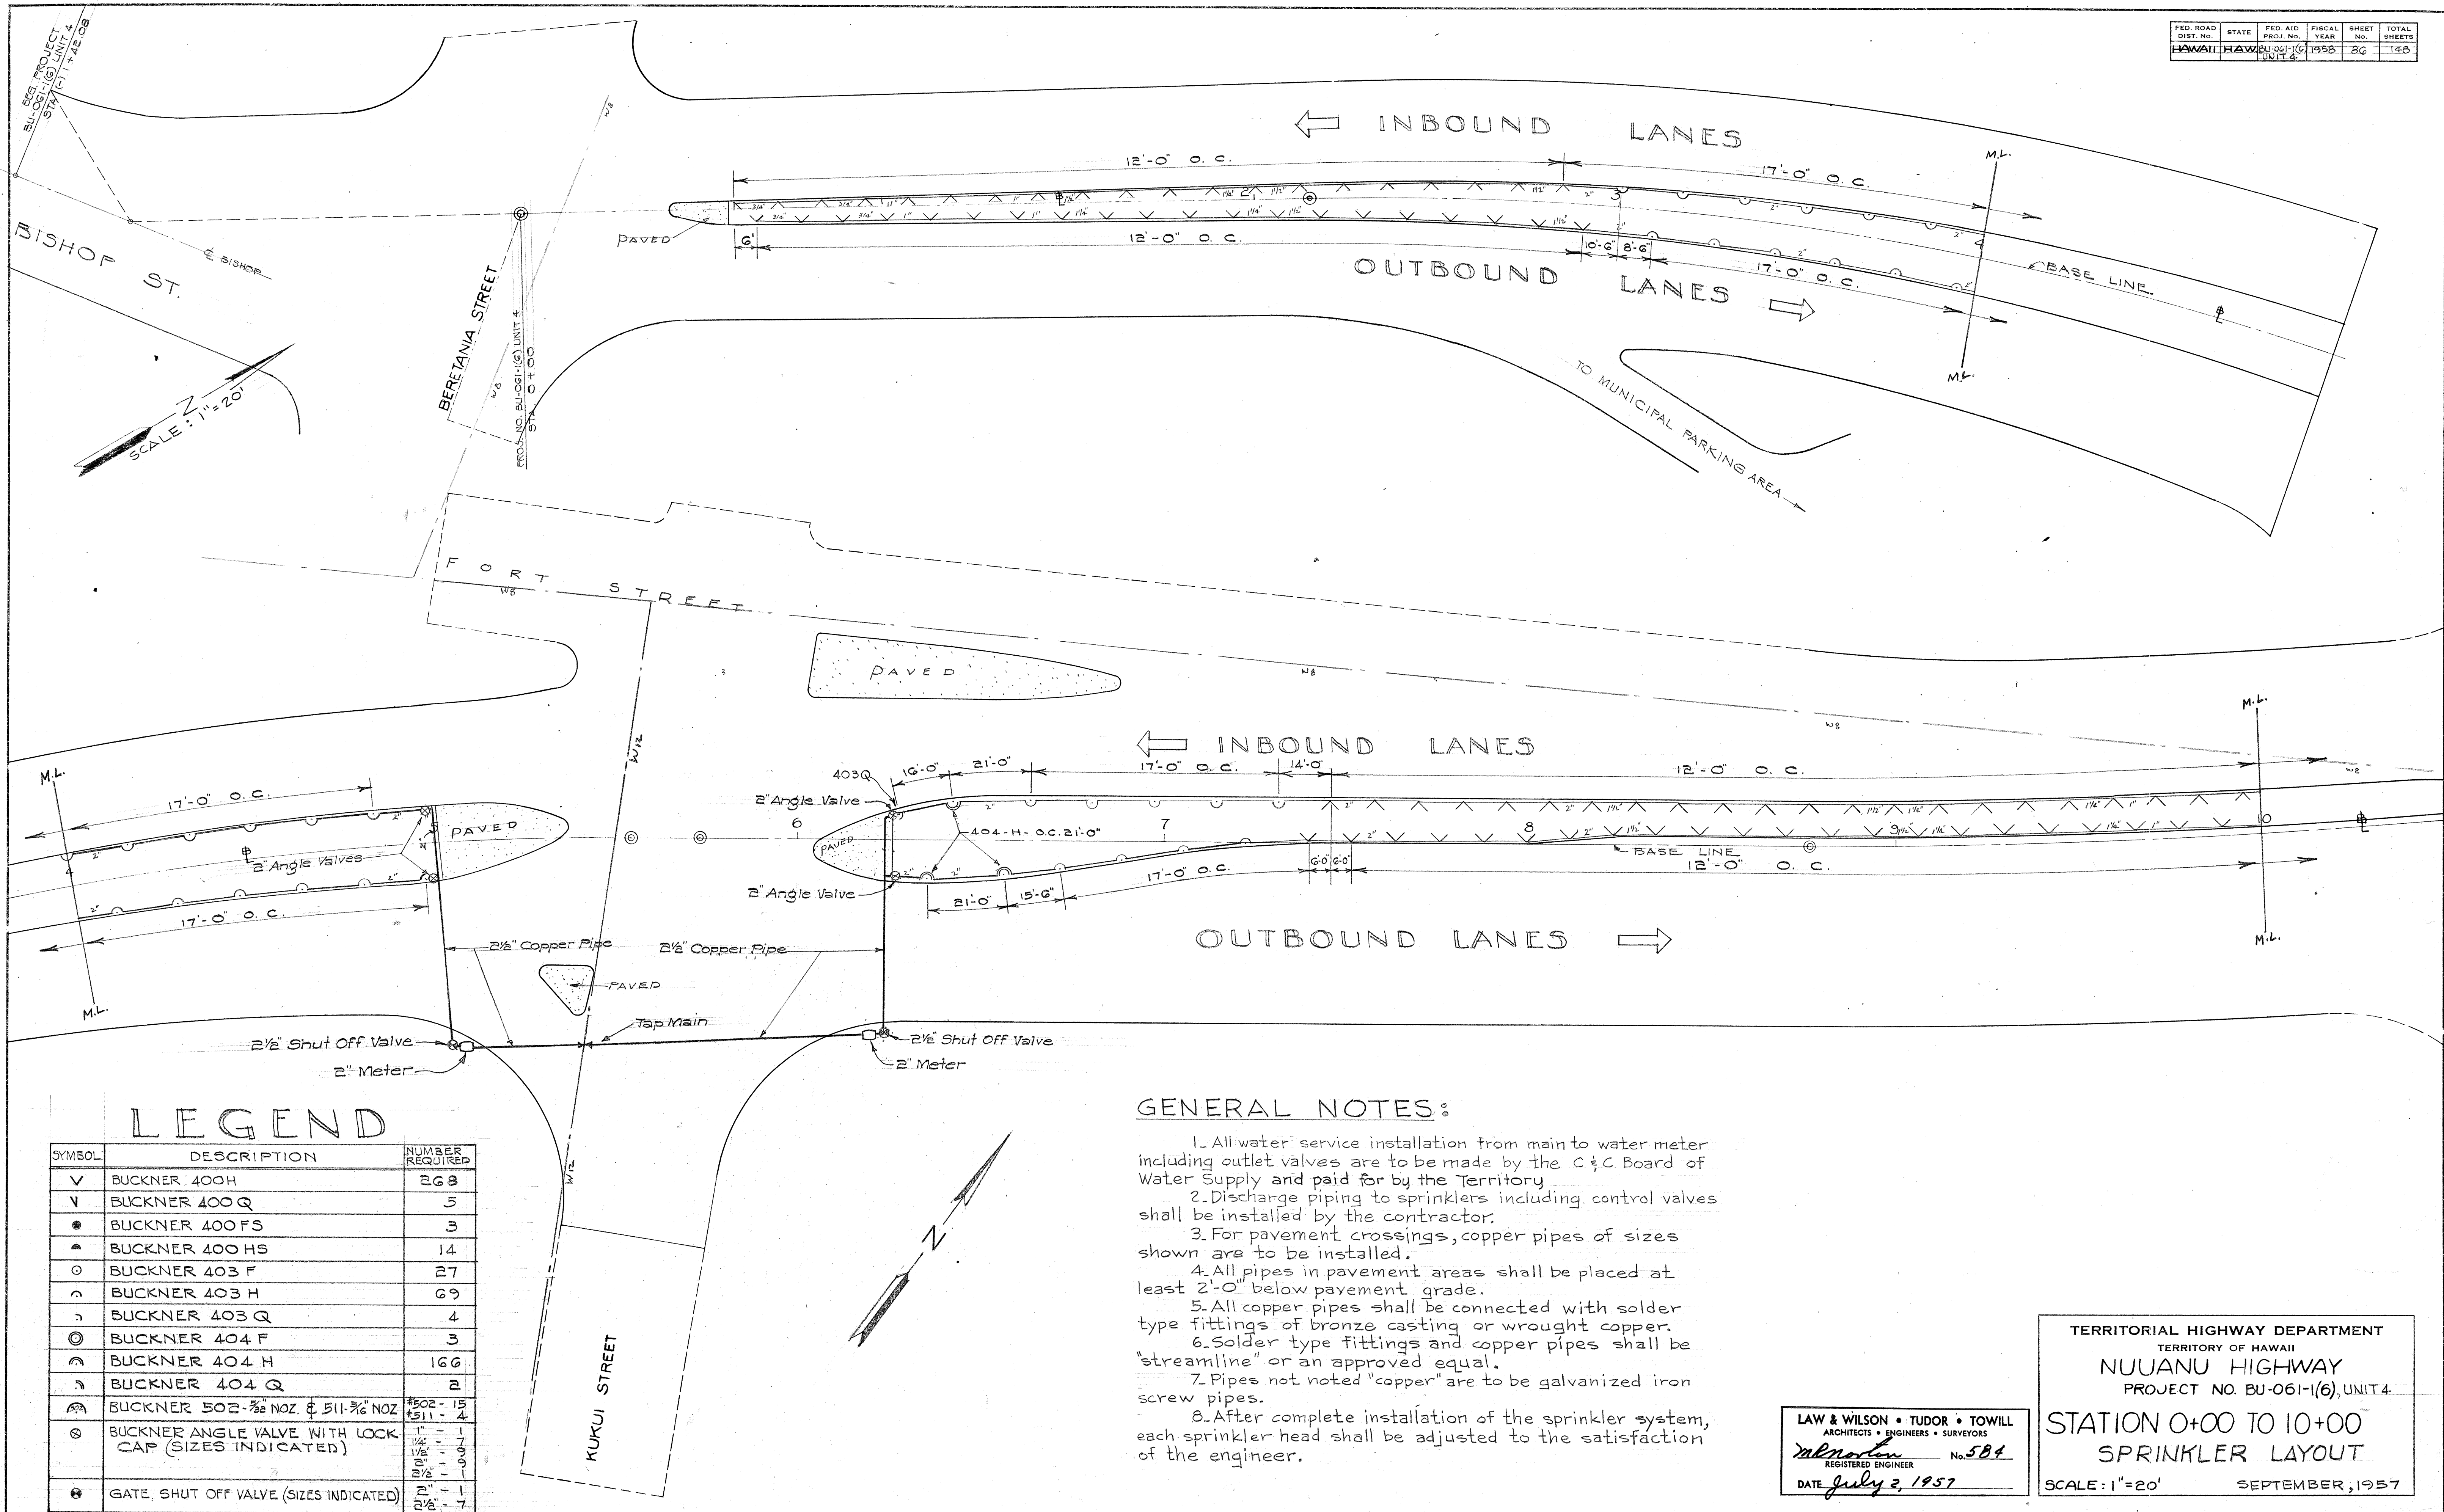

FED. ROAD DIST. NO.	STATE	FED. AID PROJ. NO.	FISCAL YEAR	SHEET NO.	TOTAL SHEETS
HAWAII	HAW.	BU-06118	1958	27	148
		UNIT 4			

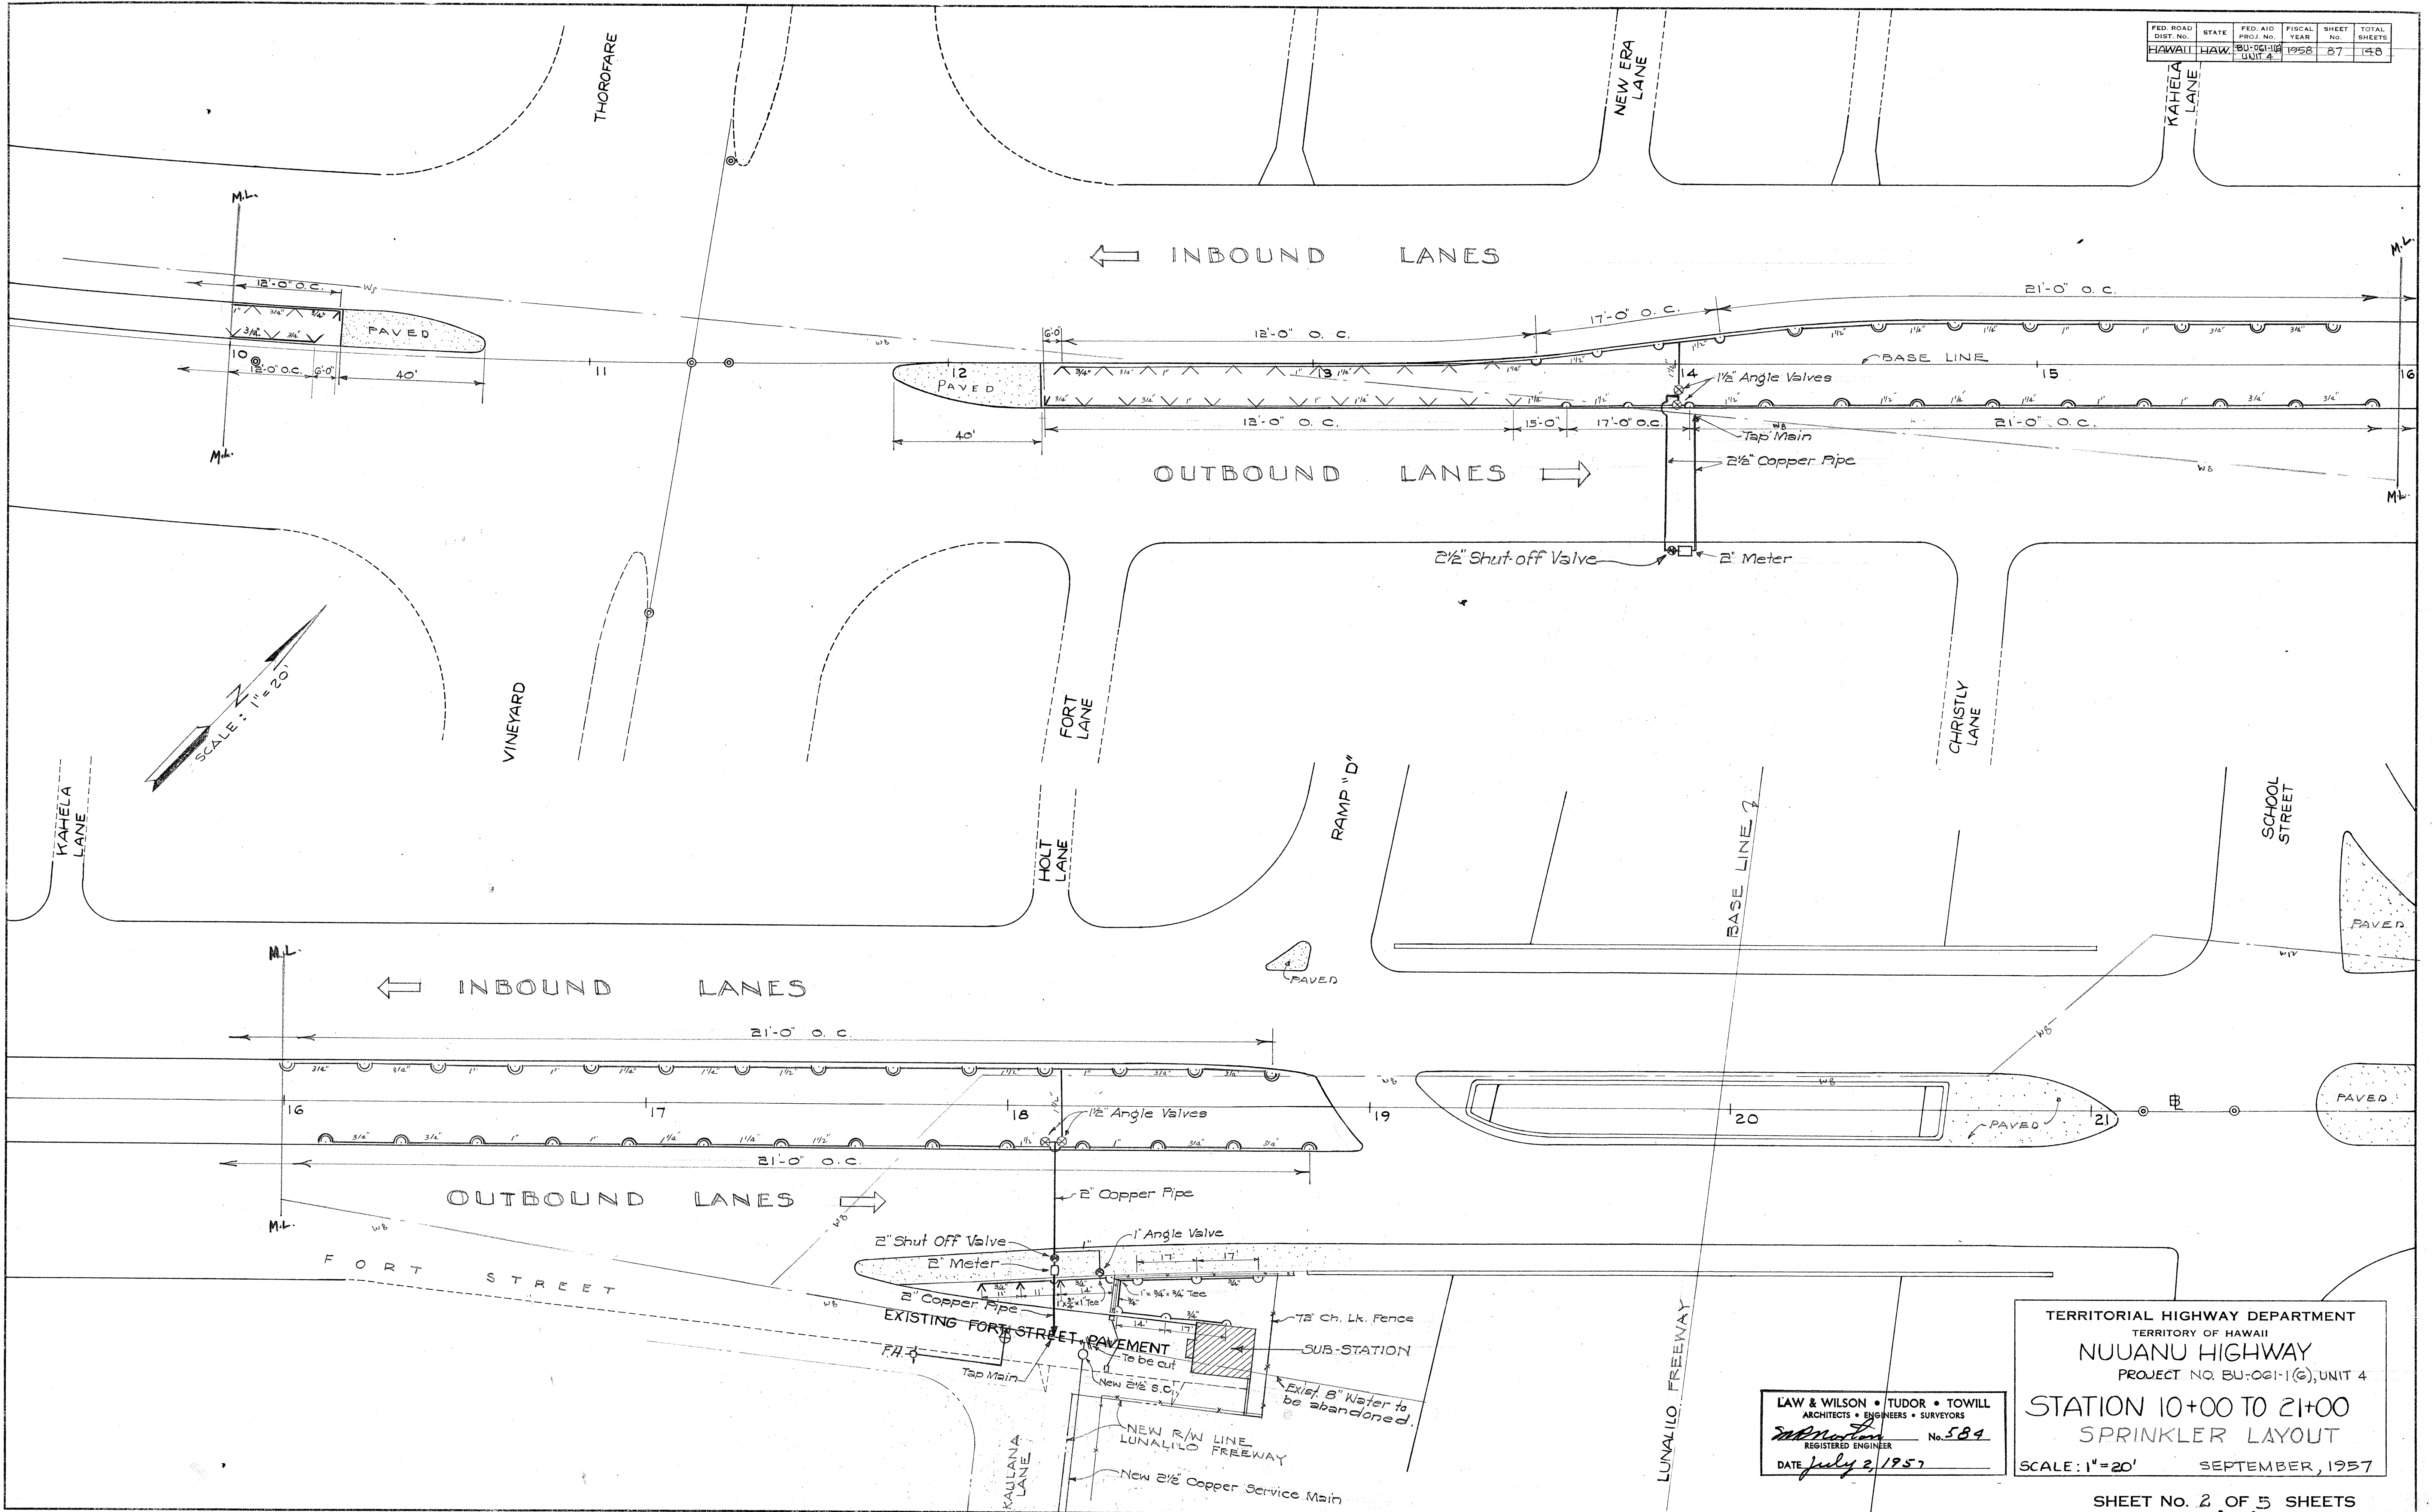

DESIGNED BY	DATE
DRAWN BY	4-30-57
TRACED BY	
QUANTITIES CHECKED BY	
CHECKED BY	
NO.	


LAW & WILSON • TUDOR • TOWILL
ARCHITECTS • ENGINEERS • SURVEYORS
REGISTERED ENGINEER No. 584
DATE July 2, 1957

TERRITORIAL HIGHWAY DEPARTMENT
TERRITORY OF HAWAII
NUUANU HIGHWAY
PROJECT NO. BU-0611-1(G), UNIT 4
STATION 10+00 TO 21+00
SPRINKLER LAYOUT
SCALE: 1"=20' SEPTEMBER, 1957

SHEET No. 2 OF 5 SHEETS

FED. ROAD DIST. NO.	STATE	FED. AID PROJ. NO.	FISCAL YEAR	SHEET NO.	TOTAL SHEETS
HAWAII	HAWAII	BU-061(1)(6)	1956	80	140

DATE	4-23-57
SURVEY PLOTTED BY	
DESIGNED BY	
TRACED BY	D.R.
QUANTITIES BY	
CHECKED BY	SY
ORIGINAL PLAN	
NOTE BOOK	
No.	

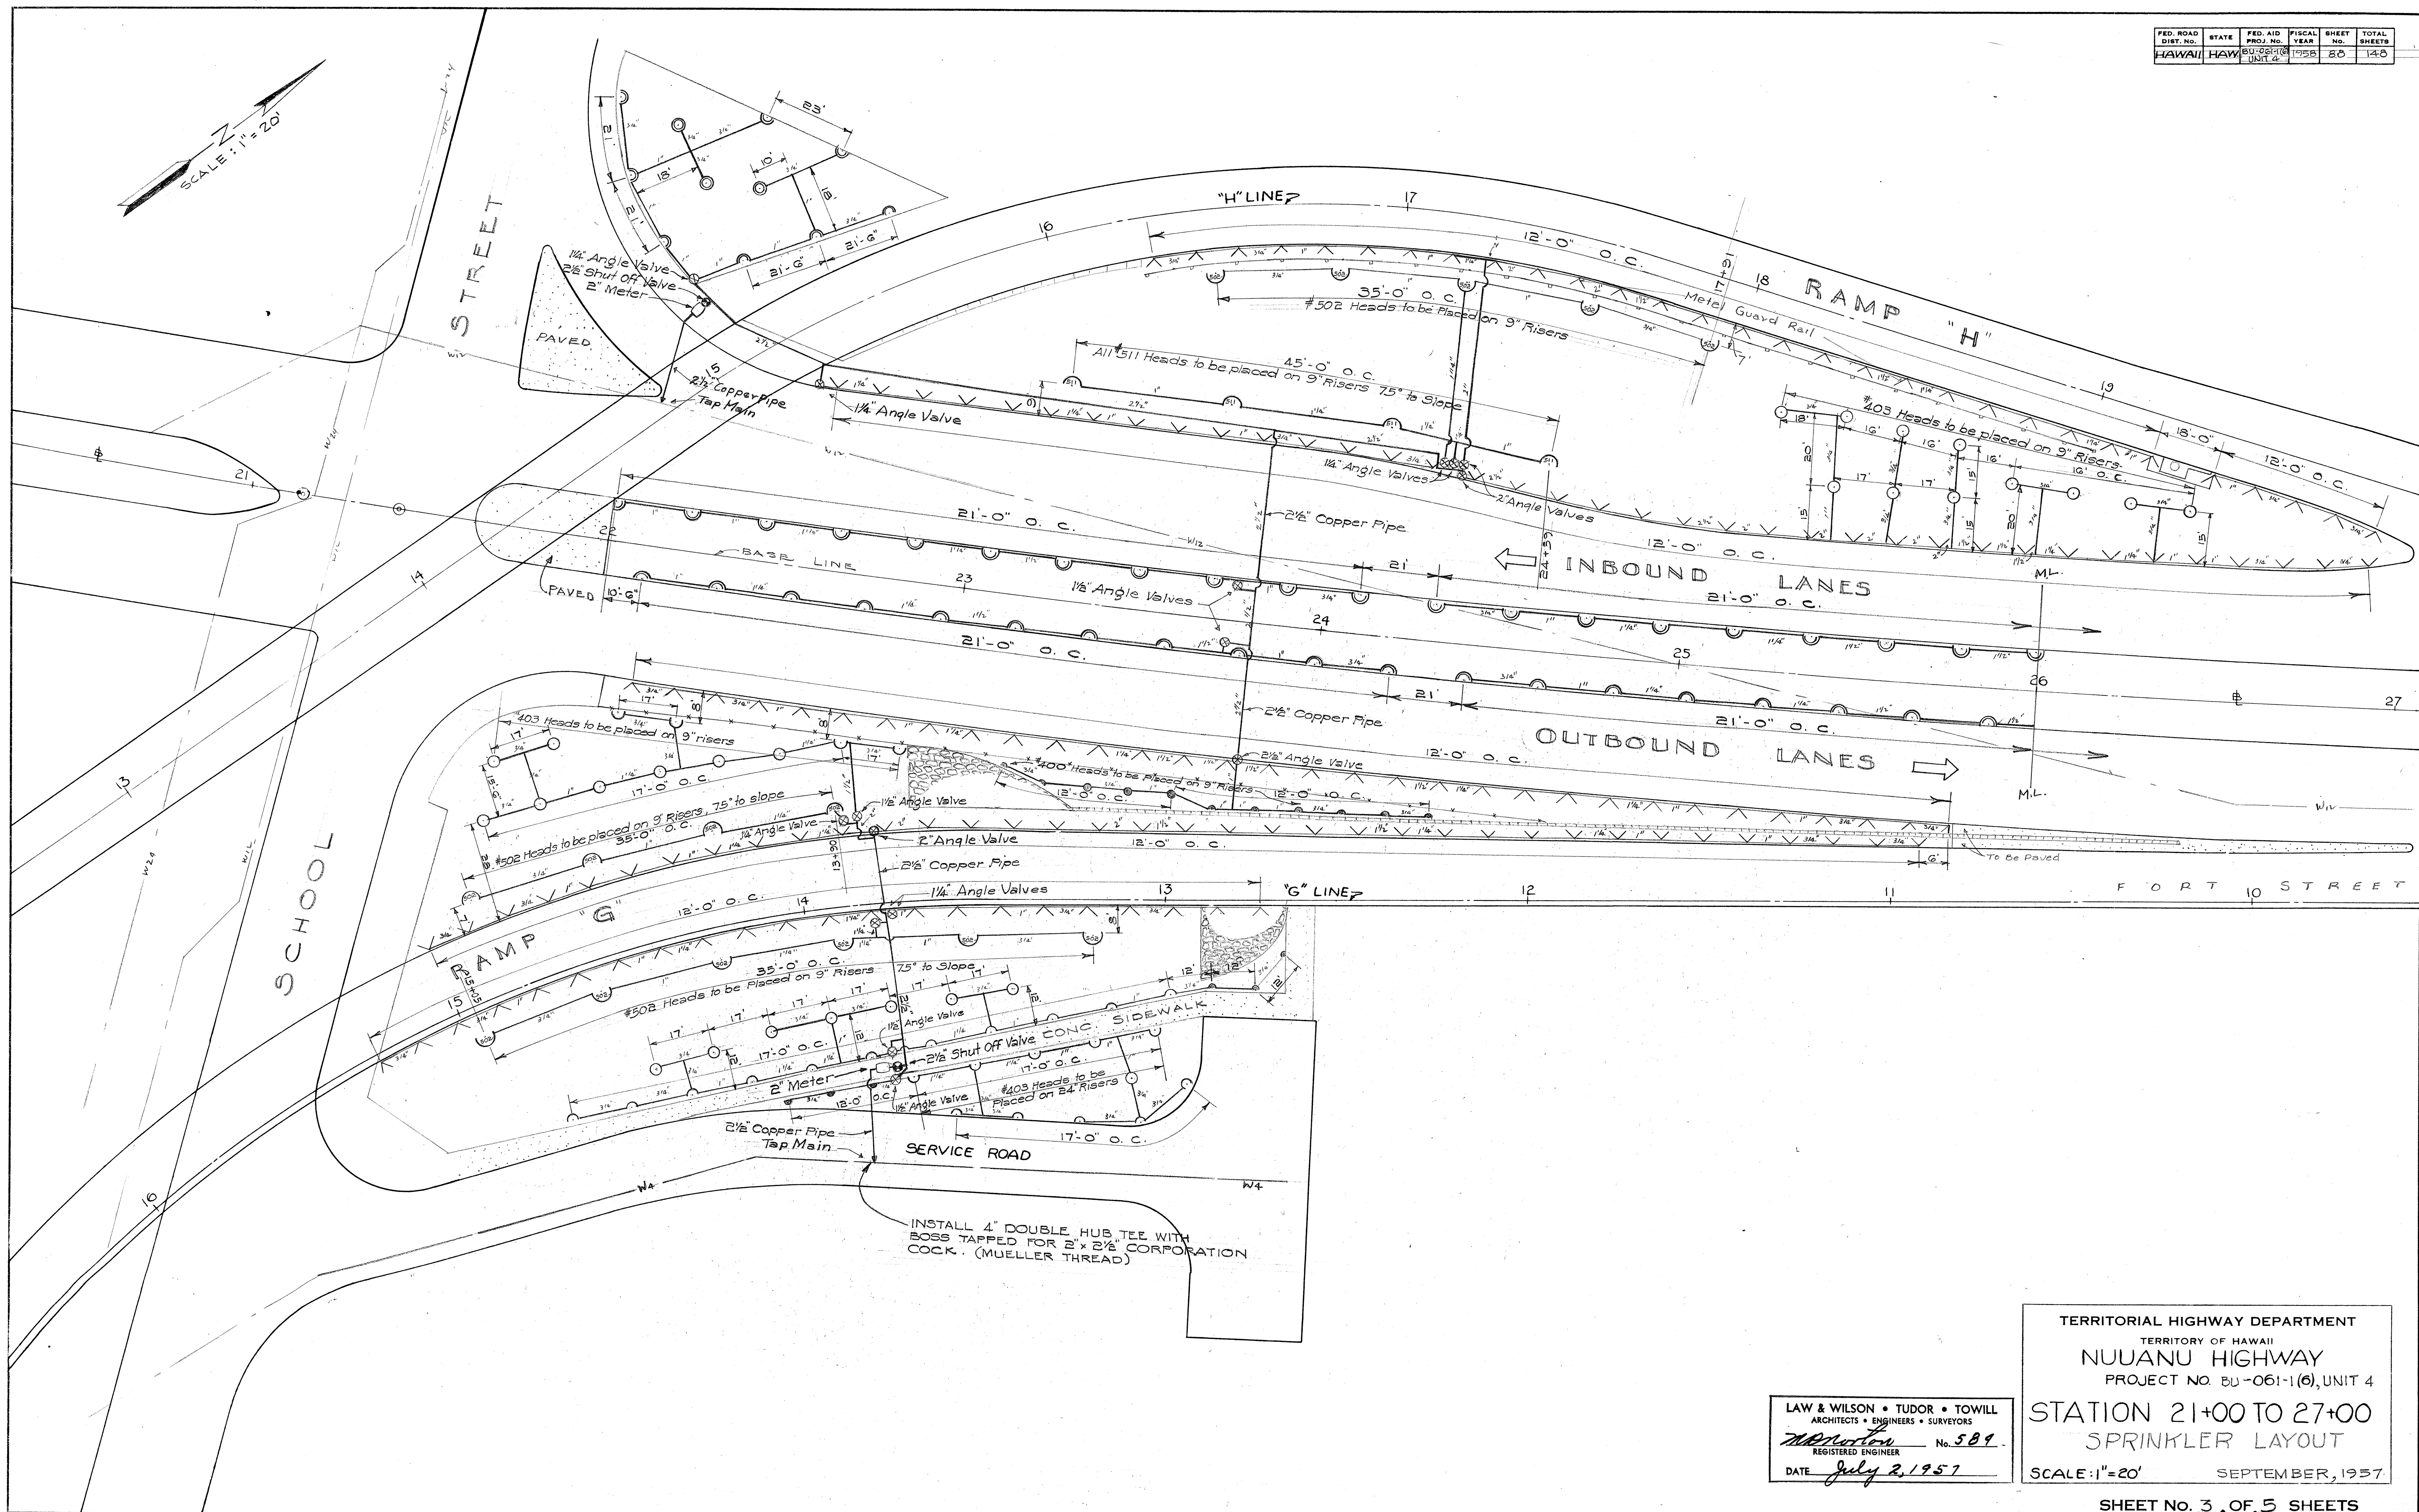

LAW & WILSON • TUDOR • TOWILL
ARCHITECTS • ENGINEERS • SURVEYORS
W. W. Wilson
REGISTERED ENGINEER No. 581
DATE July 2, 1957


TERRITORIAL HIGHWAY DEPARTMENT
TERRITORY OF HAWAII
NUUANU HIGHWAY
PROJECT NO. BU-061-1(6), UNIT 4
STATION 21+00 TO 27+00
SPRINKLER LAYOUT
SCALE: 1"=20' SEPTEMBER, 1957

SHEET NO. 3 OF 5 SHEETS

.S146 (2).SS 174

FED. ROAD DIST. NO.	STATE	FED. AID PROJ. NO.	FISCAL YEAR	SHEET NO.	TOTAL SHEETS
HAWAII	HAWAII	BU-061-1(6)	UNIT 4	87	148

ORIGINAL PLAN	DESIGNED BY	DATE
NOTE BOOK	TRACED BY	4-29-57
No.	QUANTITIES BY	
	QUANTITIES CHECKED BY	
	CHECKED BY	SY

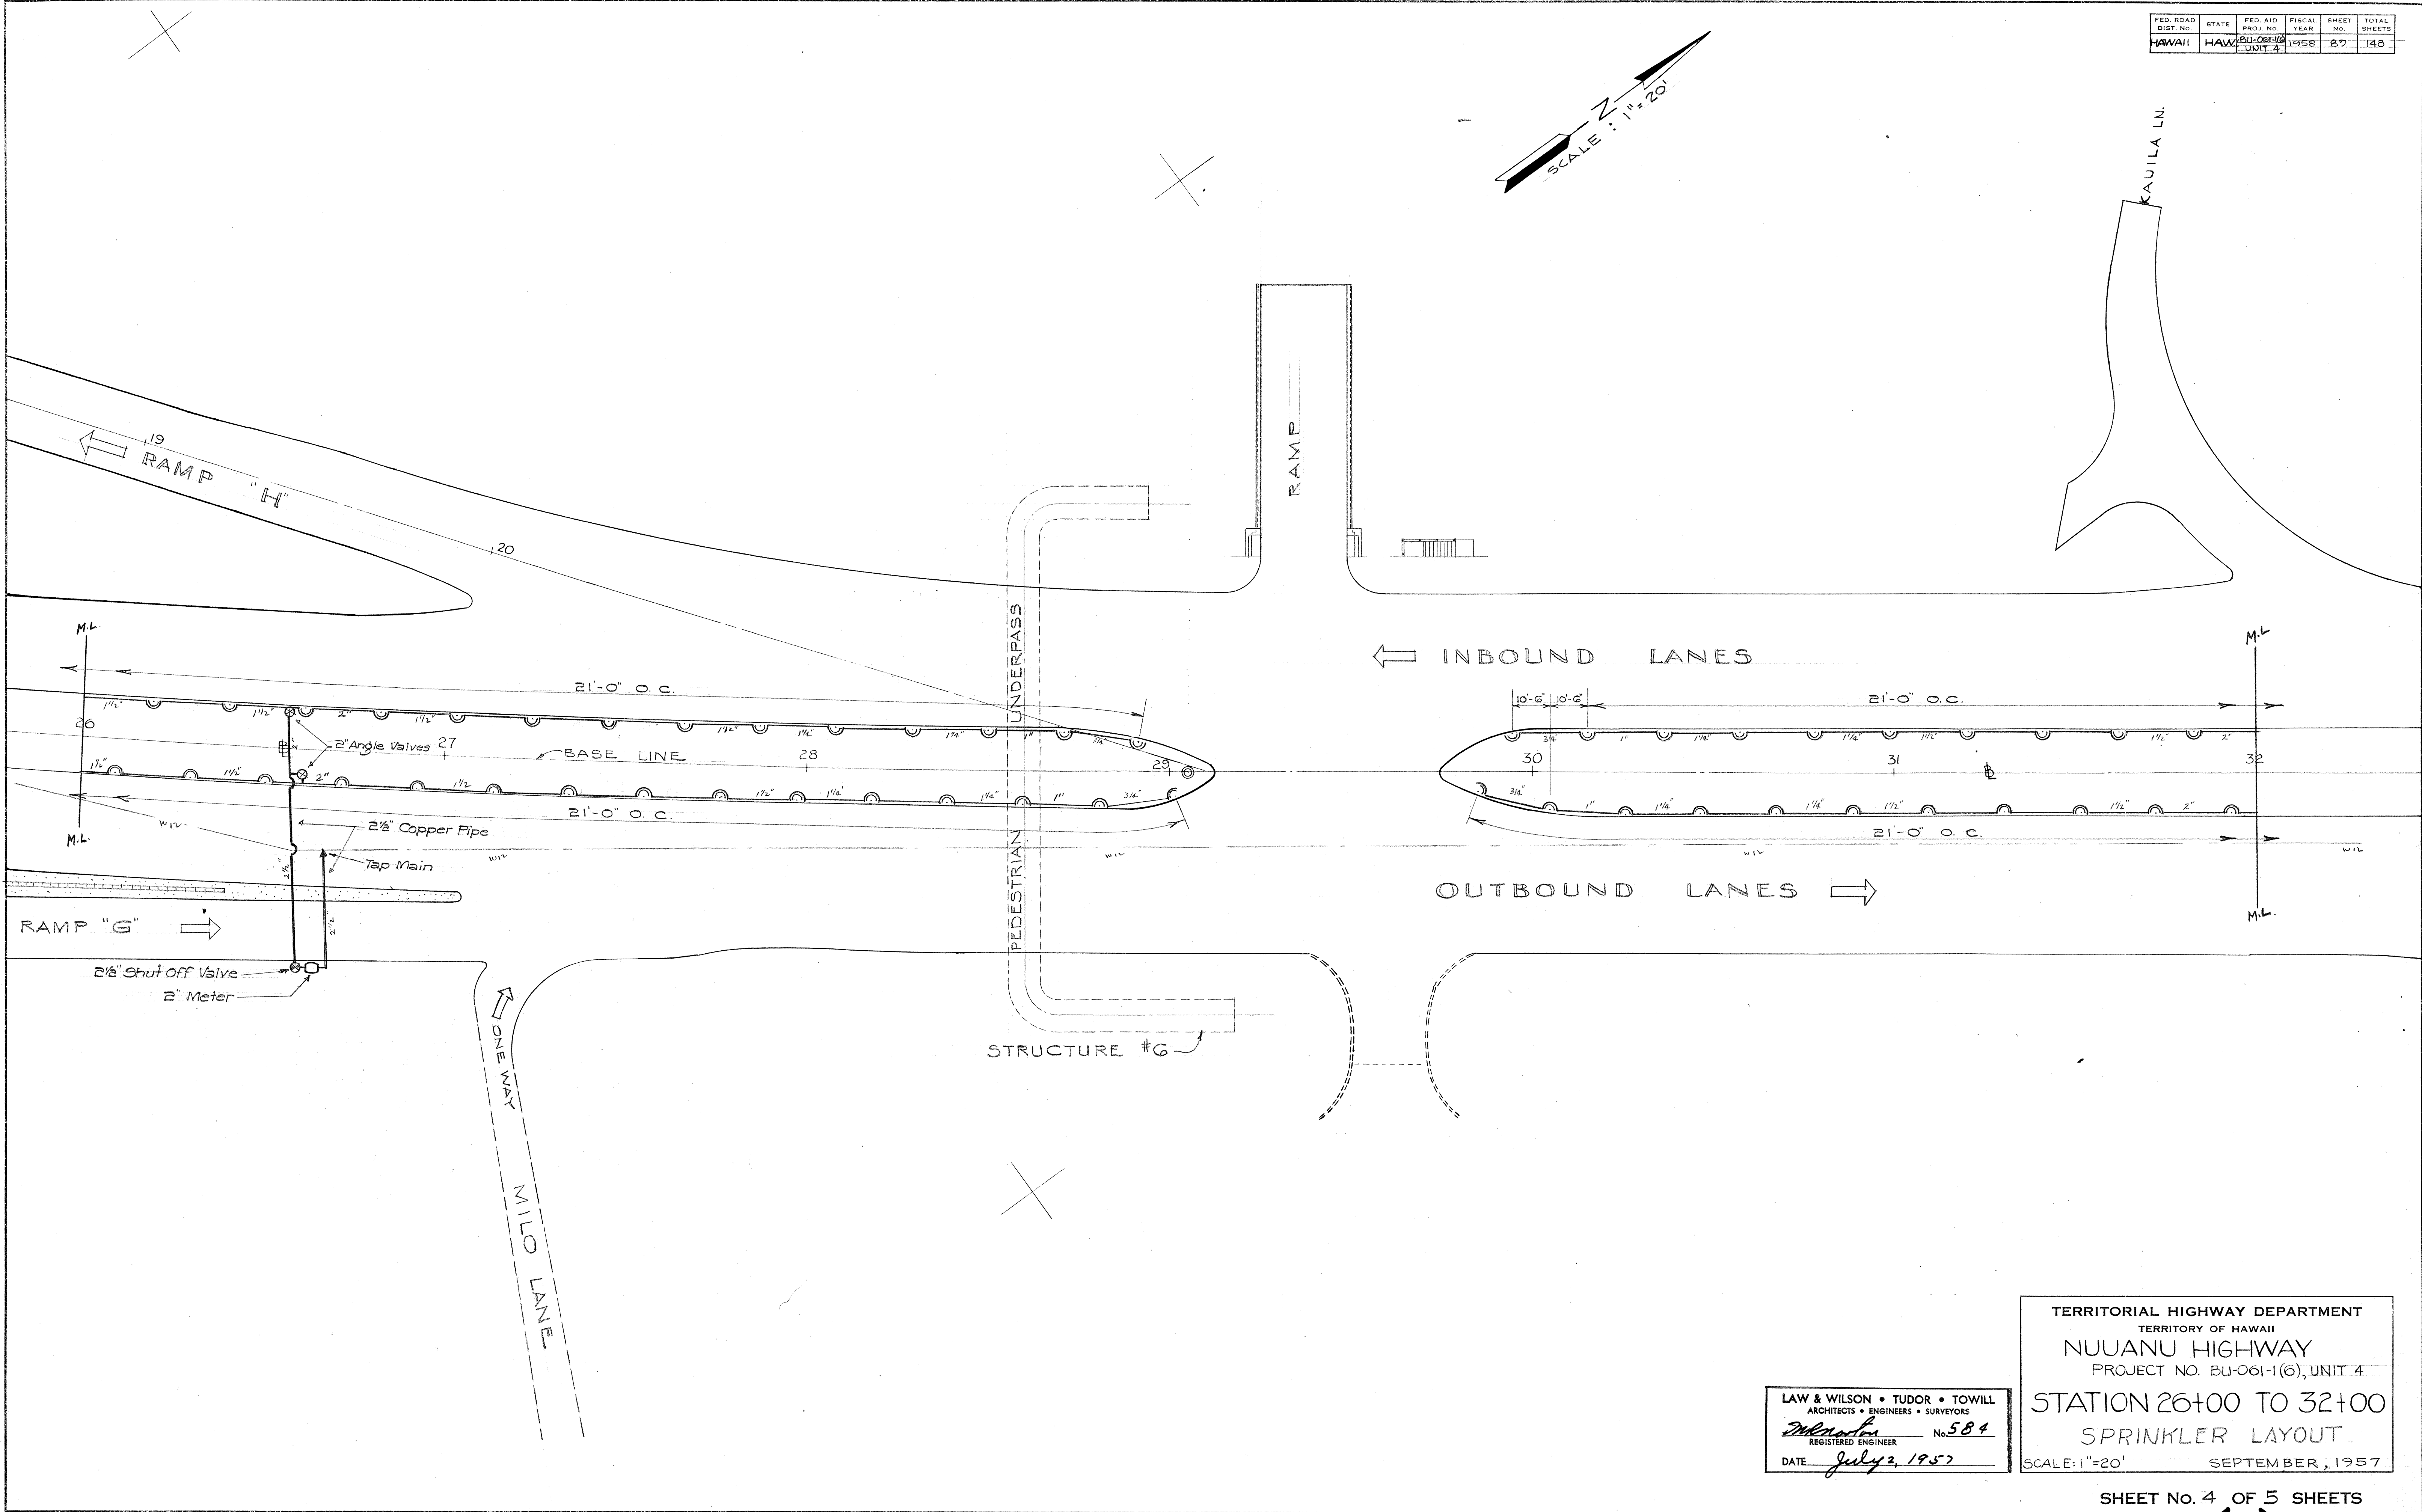

LAW & WILSON • TUDOR • TOWILL
ARCHITECTS • ENGINEERS • SURVEYORS
T. Tudor No. 584
REGISTERED ENGINEER
DATE July 2, 1957


TERRITORIAL HIGHWAY DEPARTMENT
TERRITORY OF HAWAII
NUUANU HIGHWAY
PROJECT NO. BU-061-1(6), UNIT 4
STATION 26+00 TO 32+00
SPRINKLER LAYOUT
SCALE: 1"=20' SEPTEMBER, 1957

SHEET No. 4 OF 5 SHEETS

.8146 (2).89 175

FED. ROAD DIST. NO.	STATE	FED. AID PROJ. NO.	FISCAL YEAR	SHEET NO.	TOTAL SHEETS
HAWAII	HAW	BU-061-1(6)	1958	70	148

END OF PROJ. BU-061-1(6)
 STA. 34 + 96.47

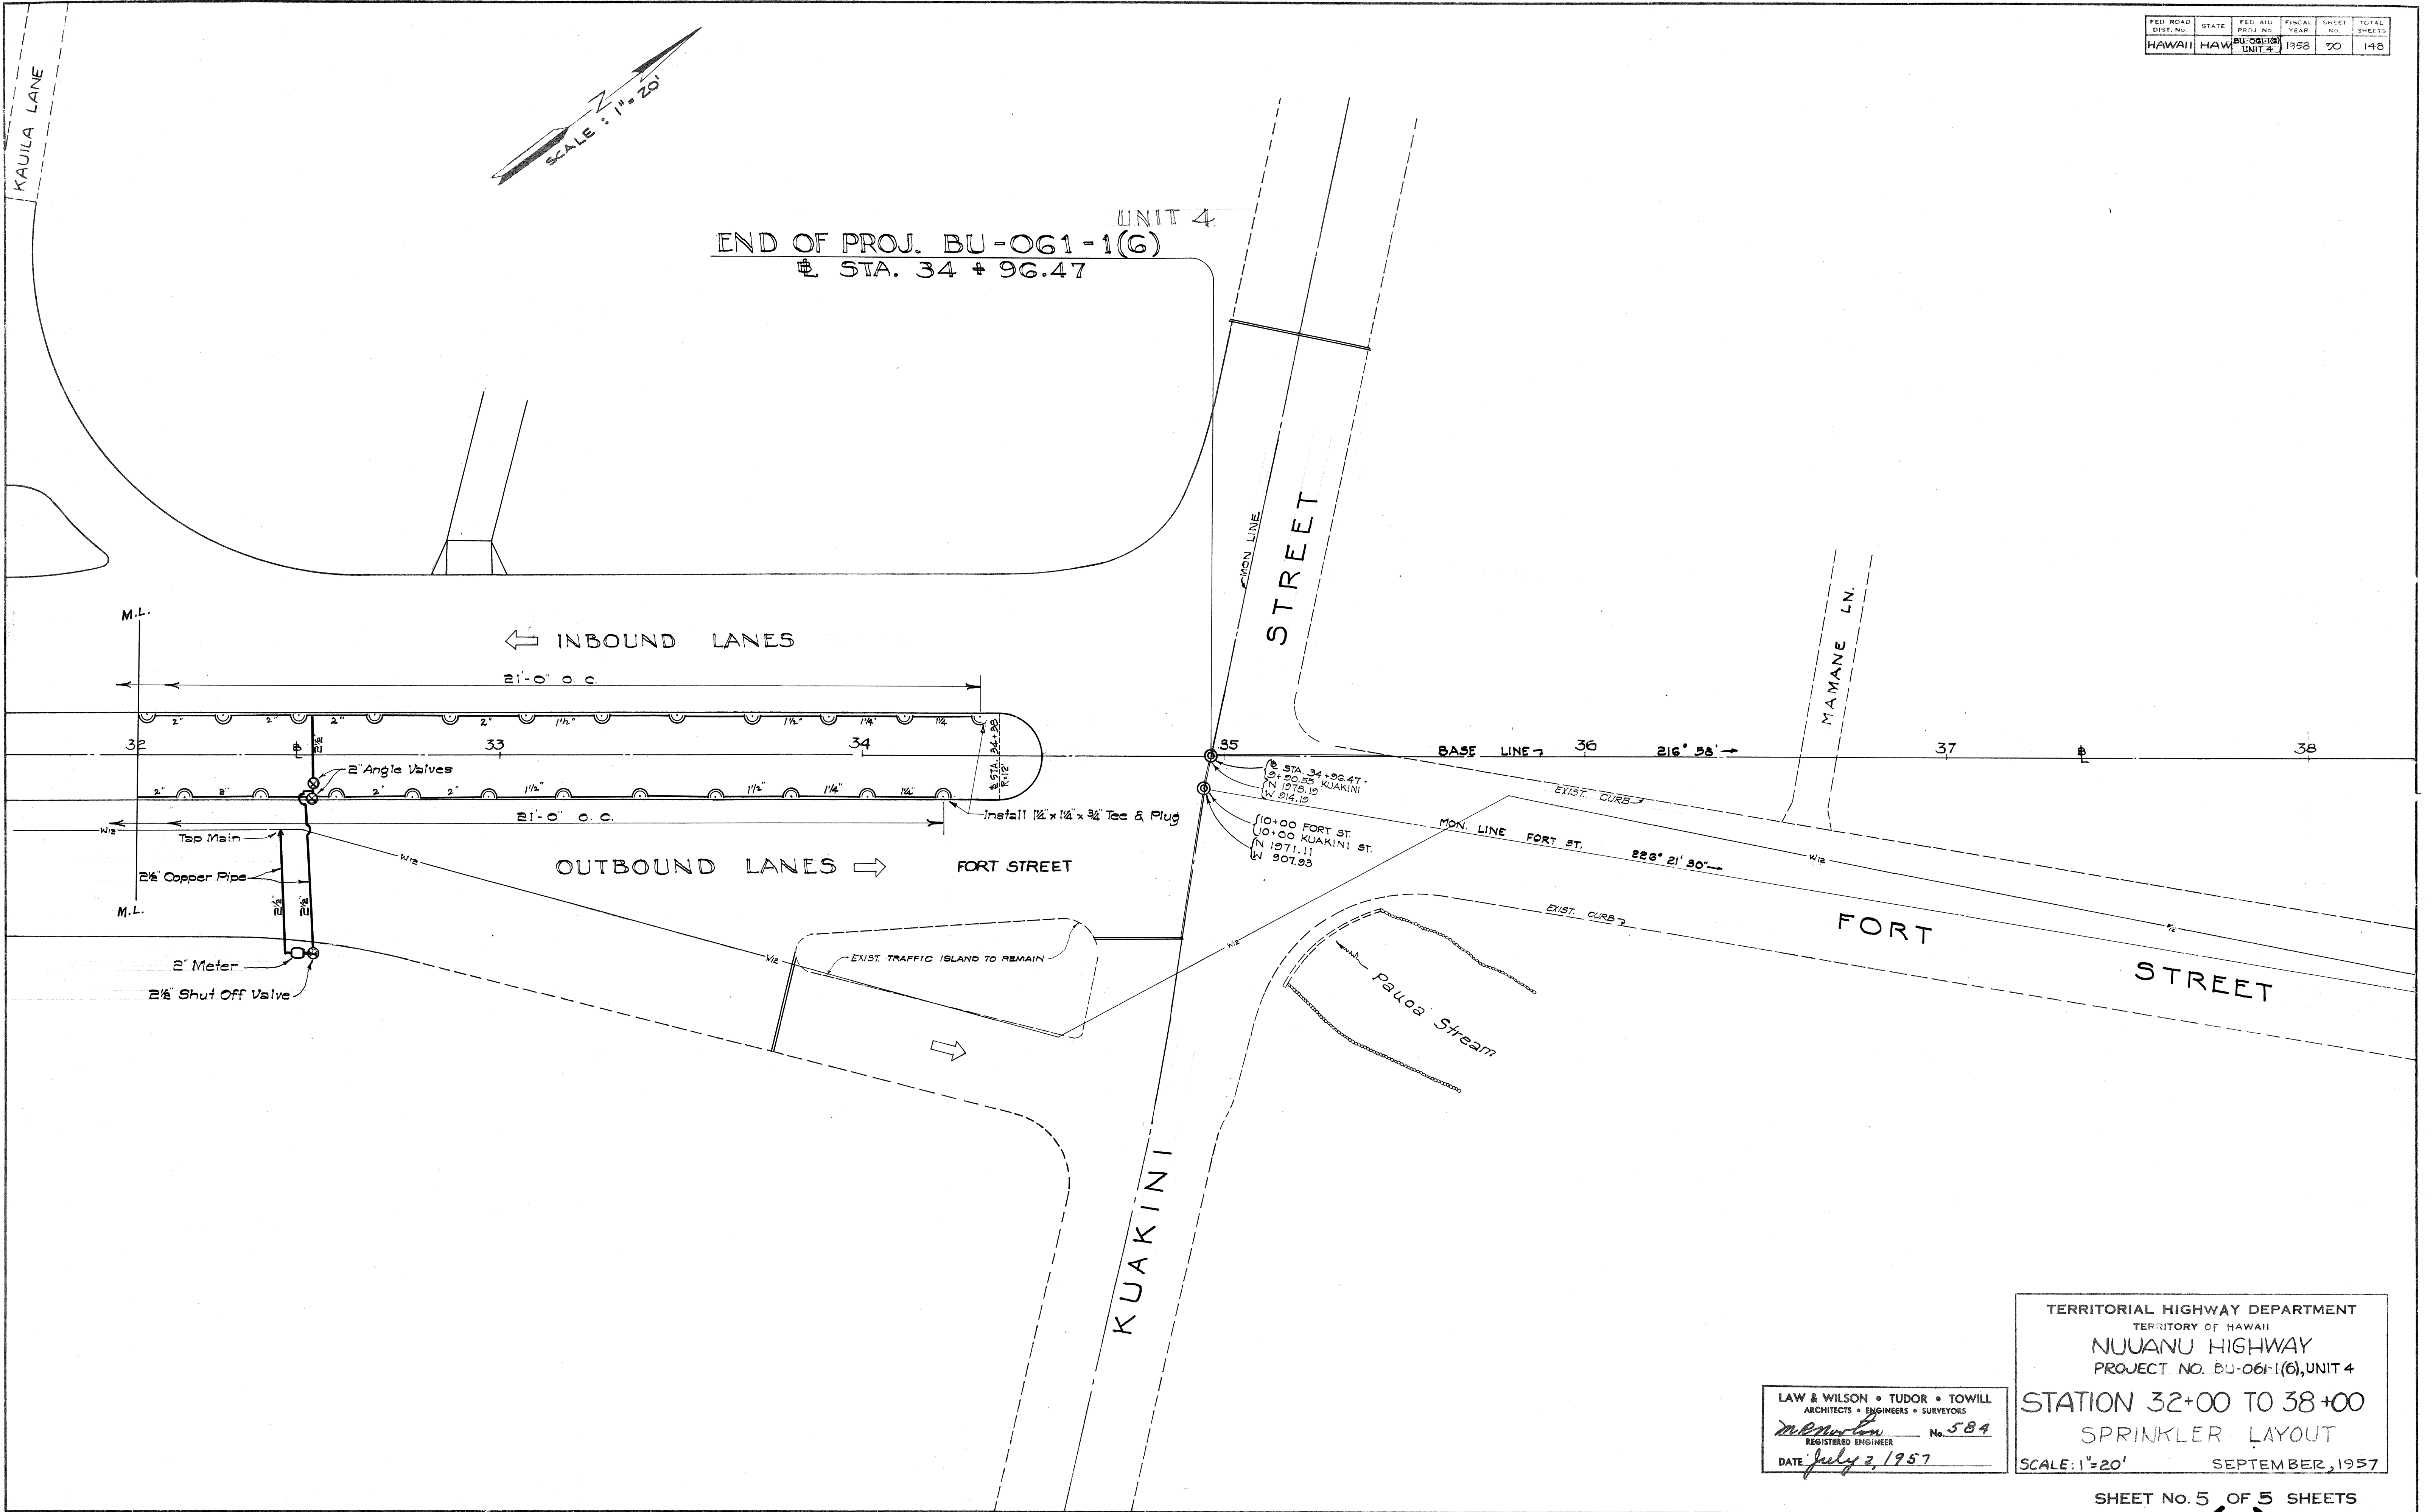

SURVEYED BY	DATE
DRAWN BY	9-11-56
TRACED BY	9-11-57
QUANTITIES CHECKED BY	
CHECKED BY	

TERRITORIAL HIGHWAY DEPARTMENT
 TERRITORY OF HAWAII
 NUUANU HIGHWAY
 PROJECT NO. BU-061-1(6), UNIT 4
 STATION 32+00 TO 38+00
 SPRINKLER LAYOUT
 SCALE: 1"=20'
 SEPTEMBER, 1957

LAW & WILSON • TUDOR • TOWILL
 ARCHITECTS • ENGINEERS • SURVEYORS
W. P. Wilson
 REGISTERED ENGINEER No. 584
 DATE July 2, 1957

SHEET NO. 5 OF 5 SHEETS

.8146 (2).90 176