

INDEX TO DRAWINGS		COMPOSITE
SHEET NO.	DESCRIPTION	SHEET NO.
1	TITLE SHEET	2
2 - 5	TYPICAL SECTIONS	8 - 11
6 - 8	PLAN & PROFILE	15 - 17
9 - 15	DETAIL PLAN OF ROADWAY	25 - 31
16 - 20	PAVEMENT GRADE PLANS	39 - 43
21 - 23	REVISION TO MUNICIPAL PARKING AREA NO. 2	44 - 46
24 - 25	CONSTRUCTION PHASE PLANS	47 - 48
26 - 31	CONCRETE RETAINING WALLS HONPA HONGWANJI STAIRWAY AND RAMP	59 - 64
32 - 33	MISCELLANEOUS DETAILS	67
34	DETAIL OF MANHOLES	68
35	SIGNAL CORPS MANHOLE	69
36	HAWAIIAN ELECTRIC COMPANY SUB-STATION	76
37	UTILITIES	88 - 106, 98A, 98B, 113 - 120
38 - 64, 48A, 48B	HIGHWAY LIGHTING	131 - 136
65 - 70	TRAFFIC SIGNAL SYSTEM	138 - 140
71 - 73	TRAFFIC SIGNS	148 - 154
74 - 80	LANDSCAPE PLANS	161 - 165
81 - 85	SPRINKLER LAYOUT	172 - 176
86 - 90	CROSS SECTIONS	195 - 207
91 - 103	STRUCTURE NO. 1	236 - 246
104 - 114	STRUCTURE NO. 2	247 - 263
115 - 131	STRUCTURE NO. 6	264 - 269
132 - 137	STRUCTURE NO. 10	270 - 278
138 - 146	STANDARD BRIDGE DETAILS	279 - 280


TERRITORY OF HAWAII
TERRITORIAL HIGHWAY DEPARTMENT
HONOLULU, OAHU, T. H.
AS BUILT
PLANS OF
NUUANU HIGHWAY
FEDERAL AID PROJECT NO. BU-O61-I (6)
UNIT 4
DISTRICT OF HONOLULU
ISLAND OF OAHU

SCALES


Plan 1"=50' & 1"=20'
Profile Horiz. 1"=50'
Profile Vert. 1"=10'
X Section Horiz. 1"=10'
X Section Vert. 1"=10'

NOTE:
ALL CHANGES MADE DURING CONSTRUCTION
HAVE BEEN NOTED ON THESE TRACINGS IN
RED AND CHECKED BY:

R. T. Saraki
PROJECT ENGINEER
6-25-63
DATE

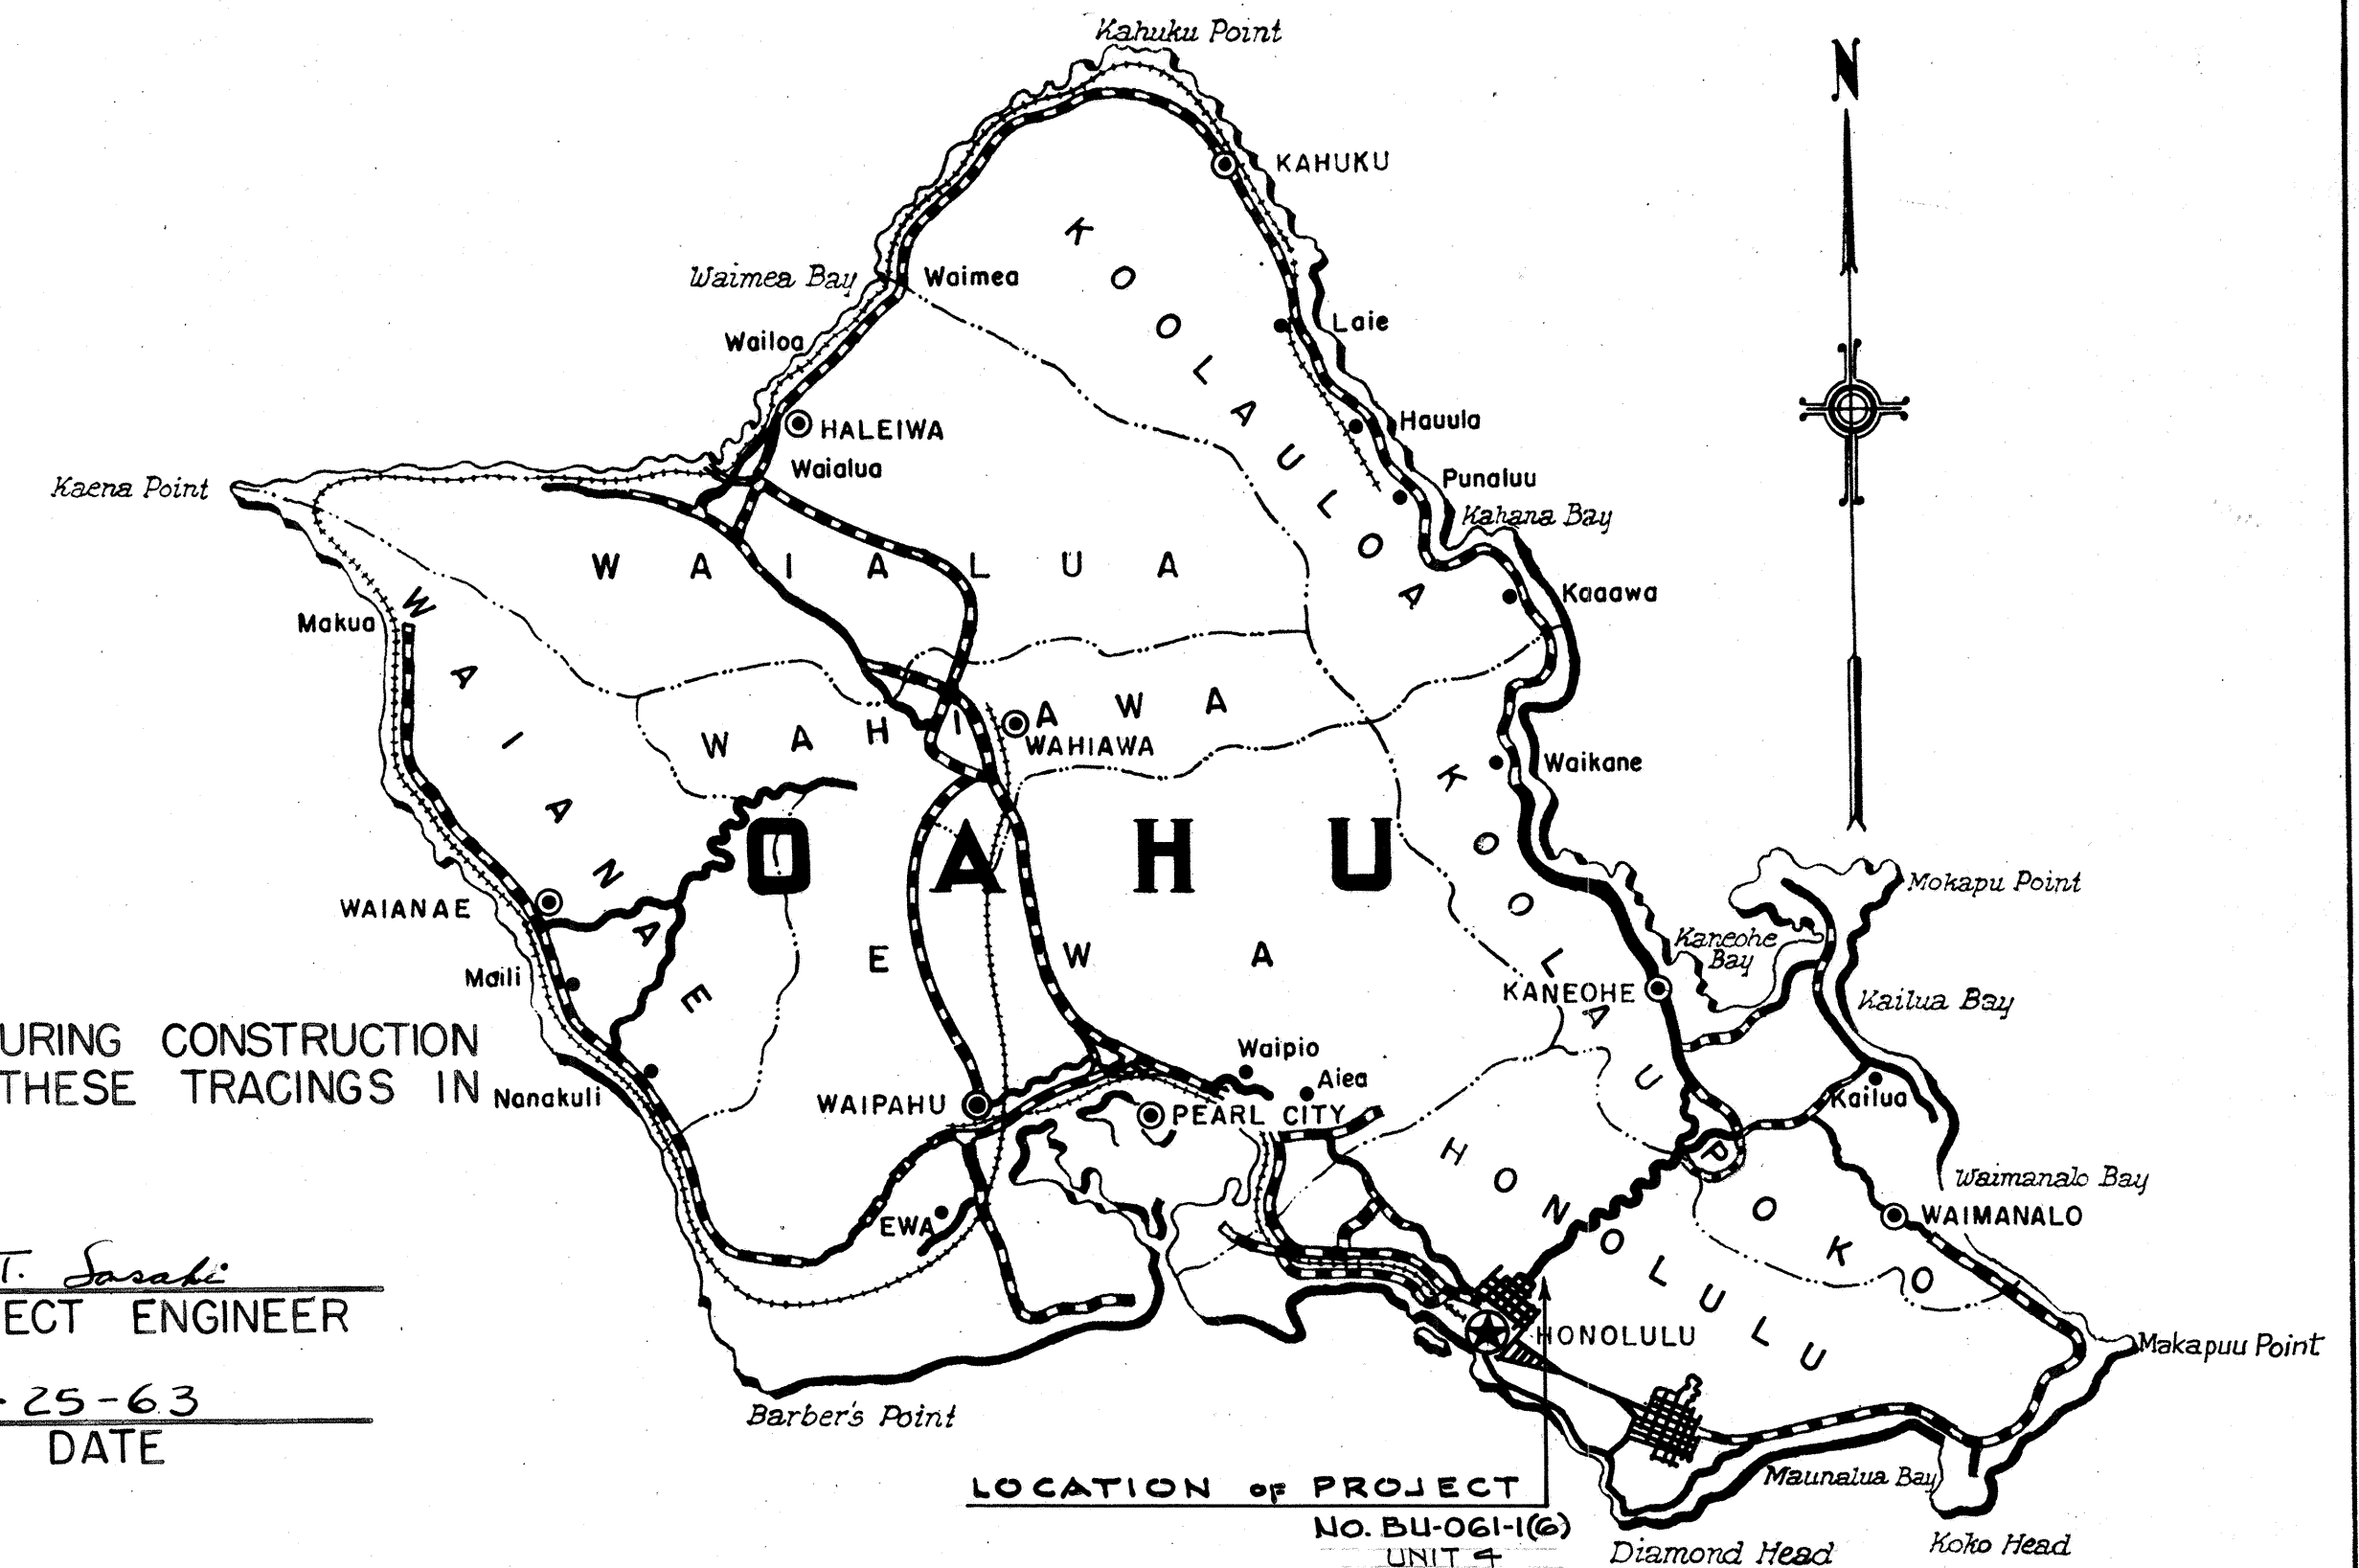

Federal Aid Projects Previously Constructed Or Under Construction

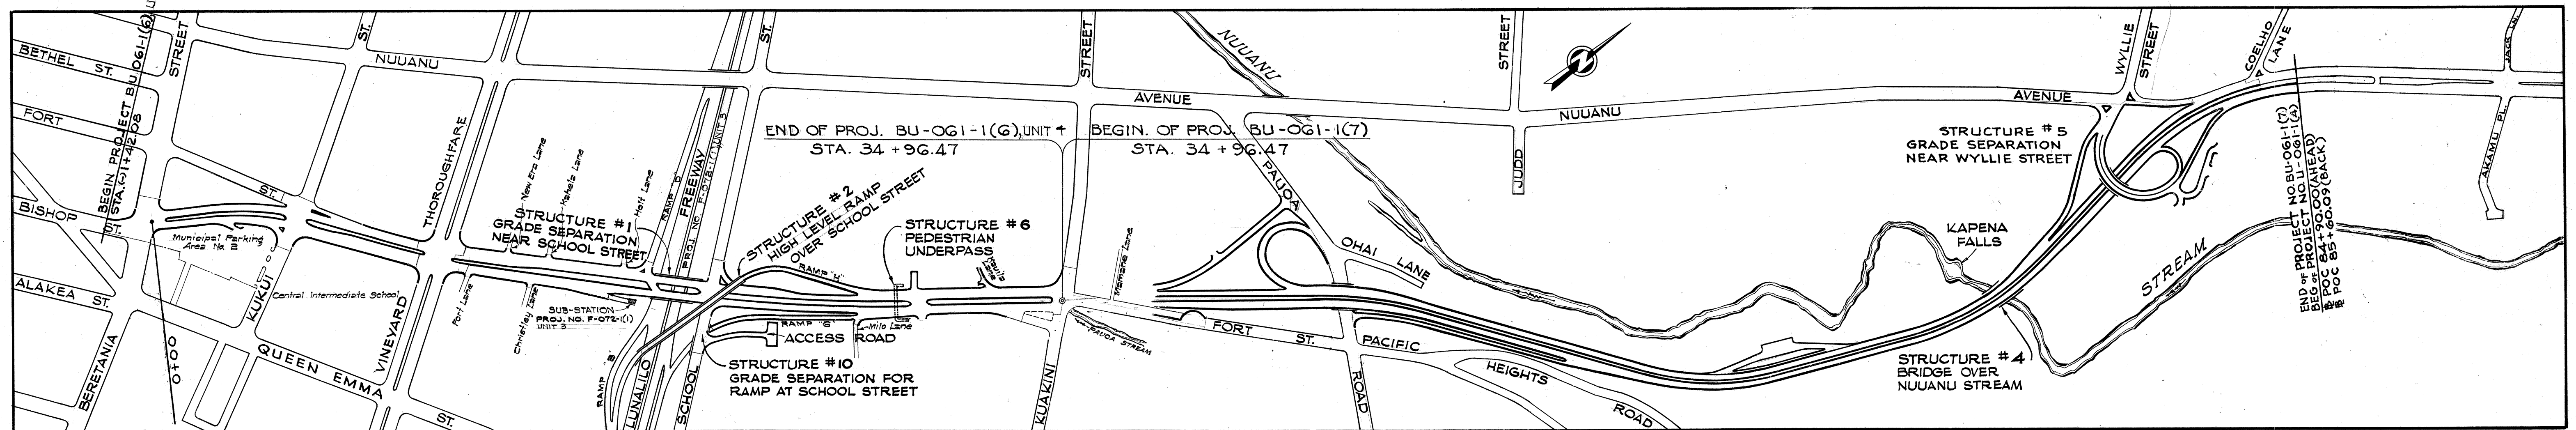

GROSS LENGTH OF PROJECT 0.689 MILE
BRIDGE 0.026 MILE
NET LENGTH OF PROJECT 0.663 MILE

LAYOUT PLAN
SCALE: 1"=300'

DATE
SURVEY PLOTTED BY
DESIGNED BY
DRAWN BY
NOTED BY
QUANTITIES CHECKED BY
CHECKED BY
No.

LAW & WILSON • TIDOR • TOWILL
ARCHITECTS • ENGINEERS & SURVEYORS
James B. Wilson 379
DATE: SEP 1967

APPROVED Wm. W. W. W. DATE 11/24/68
TERRITORIAL HIGHWAY ENGINEER

DEPARTMENT OF COMMERCE
BUREAU OF PUBLIC ROADS
APPROVED: _____
DIVISION ENGINEER DATE

SHEET No. OF SHEETS

.S146 (2).1