


FED. ROAD DIST. NO.	STATE	FED. AID PROJ. NO.	FISCAL YEAR	SHEET NO.	TOTAL SHEETS
HAWAII	HAW	BU-061-1(7) UNIT 5	1960	75	176

SCALE: 1" = 20'

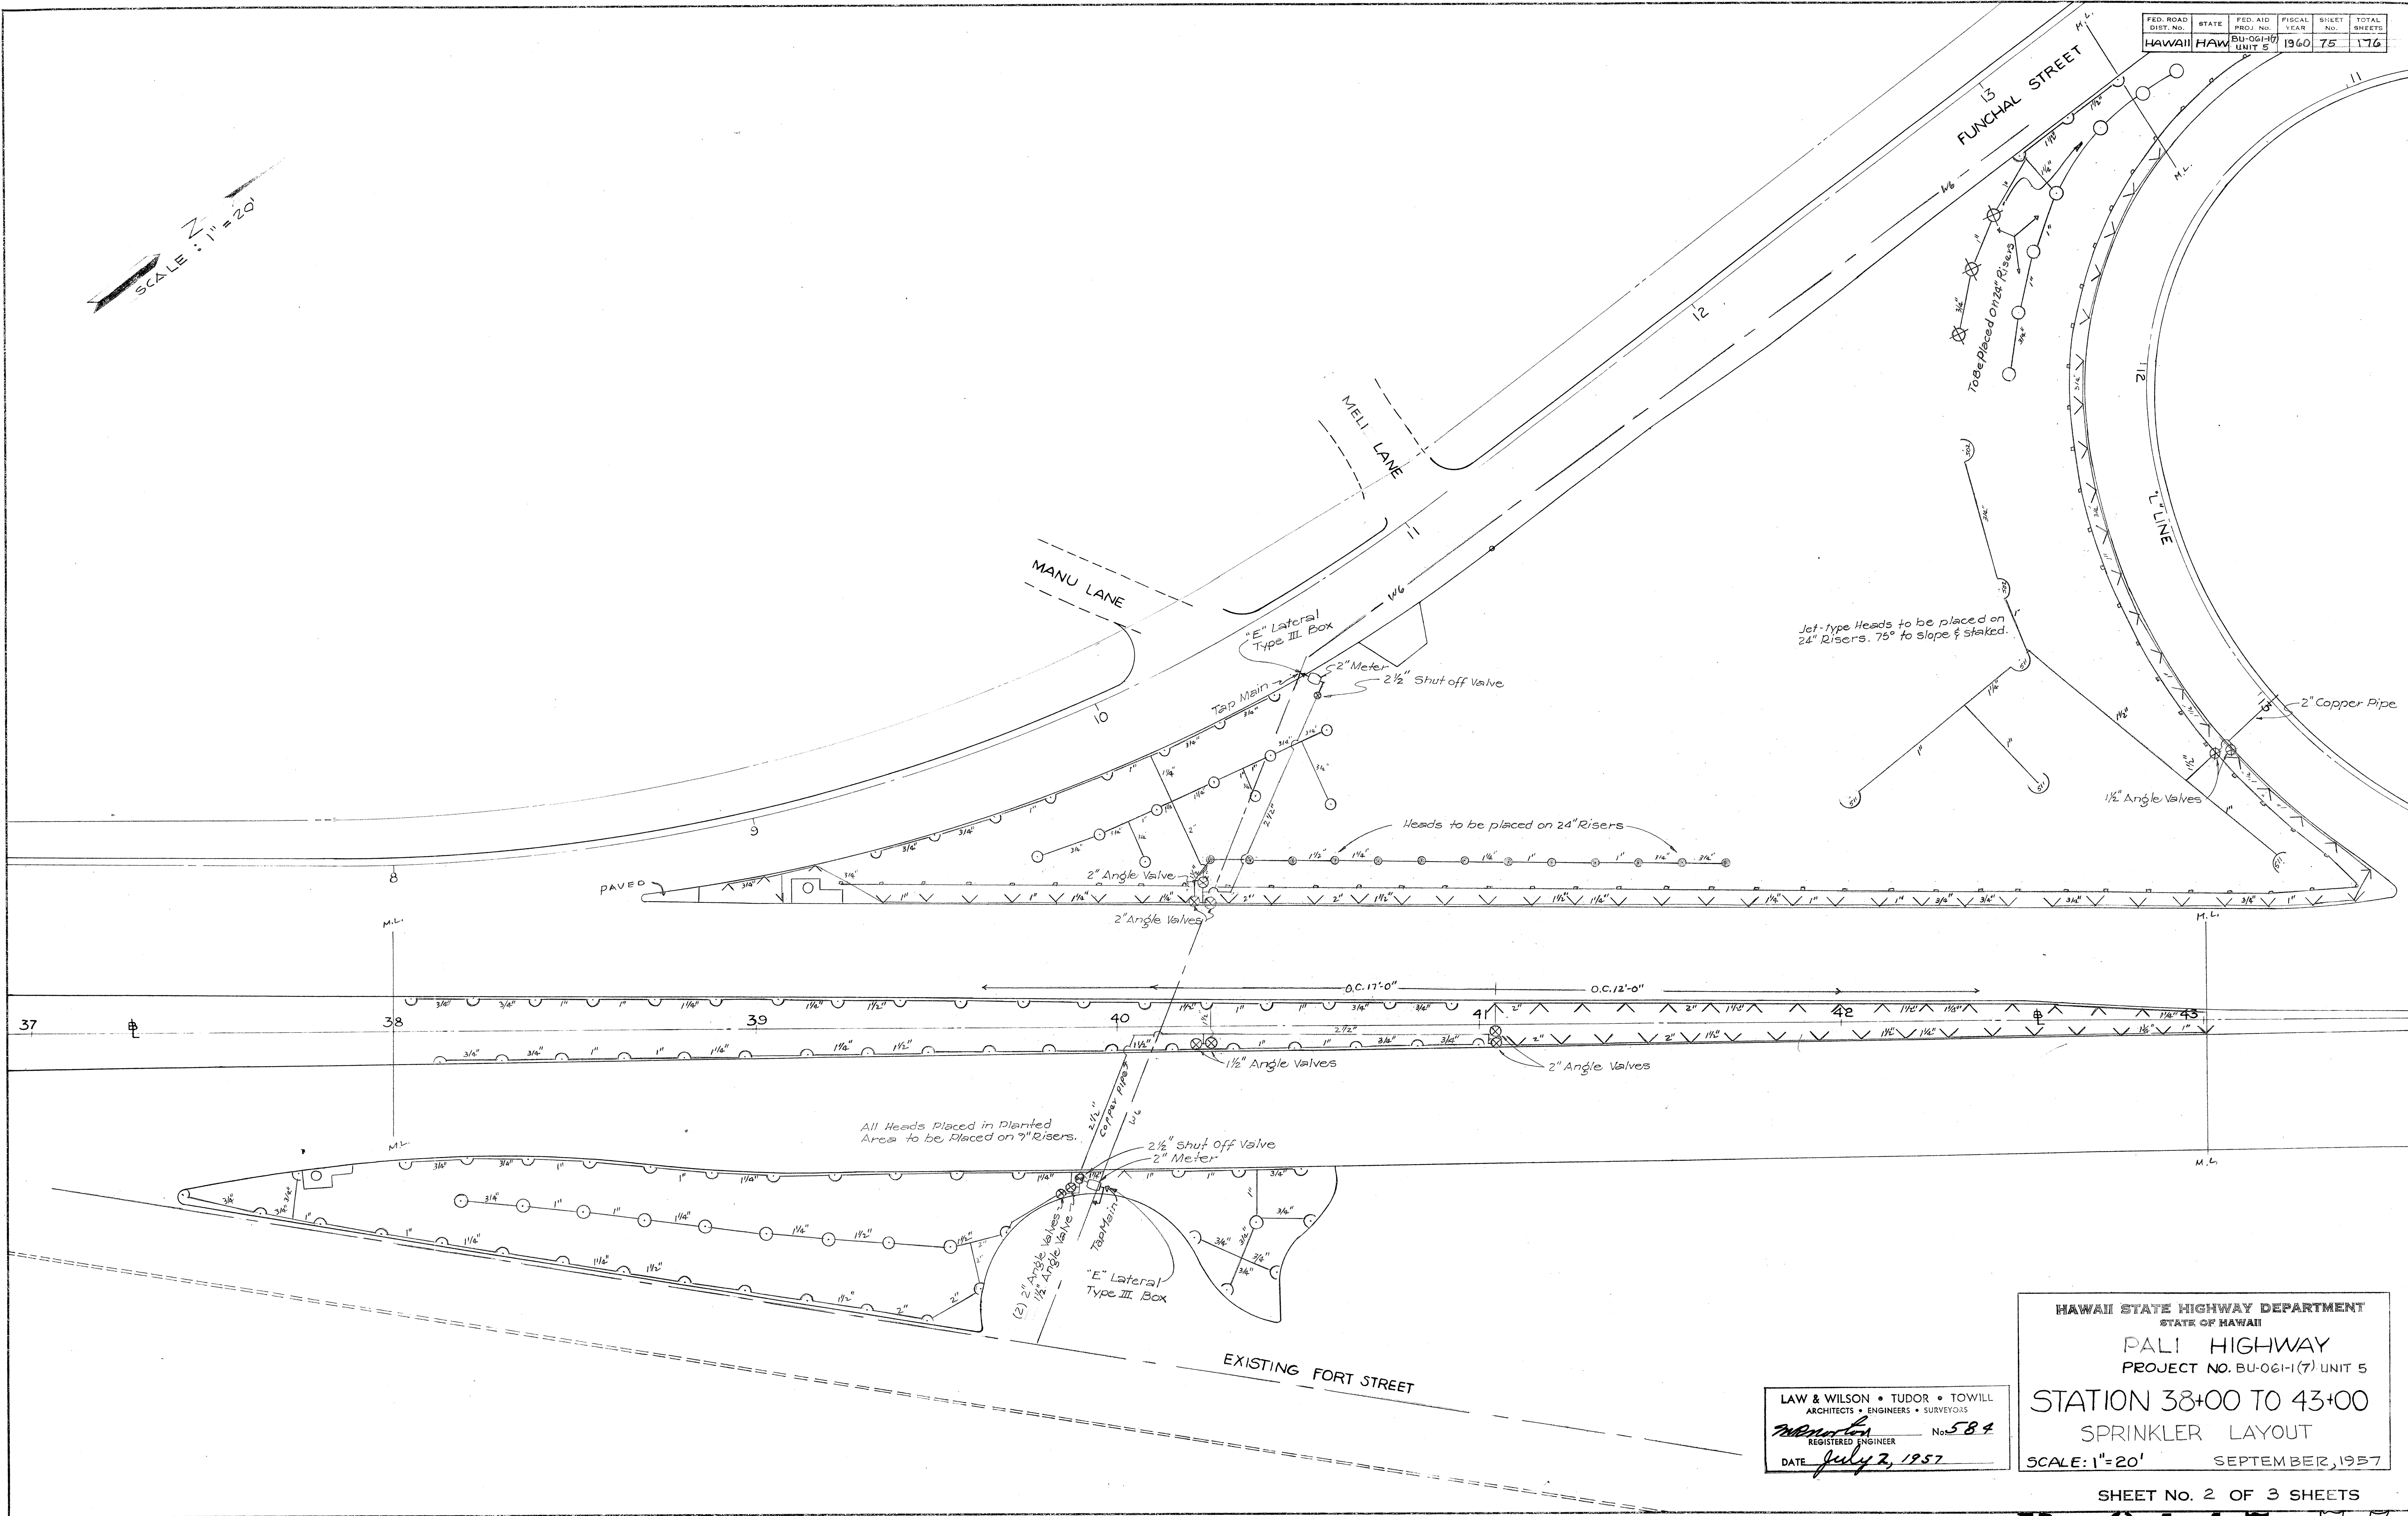

SURVEY PLOTTED BY	DATE
PLAN	4-30-57
TRACED BY	
QUANTITIES CHECKED BY	
CHECKED BY	

LAW & WILSON • TUDOR • TOWILL
ARCHITECTS • ENGINEERS • SURVEYORS
REGISTERED ENGINEER No. 584
DATE July 2, 1957


HAWAII STATE HIGHWAY DEPARTMENT
STATE OF HAWAII
PALI HIGHWAY
PROJECT NO. BU-061-1(7) UNIT 5
STATION 38+00 TO 43+00
SPRINKLER LAYOUT
SCALE: 1" = 20' SEPTEMBER, 1957

SHEET NO. 2 OF 3 SHEETS

B.S147.75

FED. ROAD DIST. NO.	STATE	FED. AID PROJ. NO.	FISCAL YEAR	SHEET NO.	TOTAL SHEETS
HAWAII	HAWAII	BU-0611(7)	1960	76	176

ORIGINAL PLAN	DATE
SURVEY PLOTTED BY	5-2-57
DRAWN BY	
DESIGNED BY	
QUANTITIES CHECKED BY	
CHECKED BY	

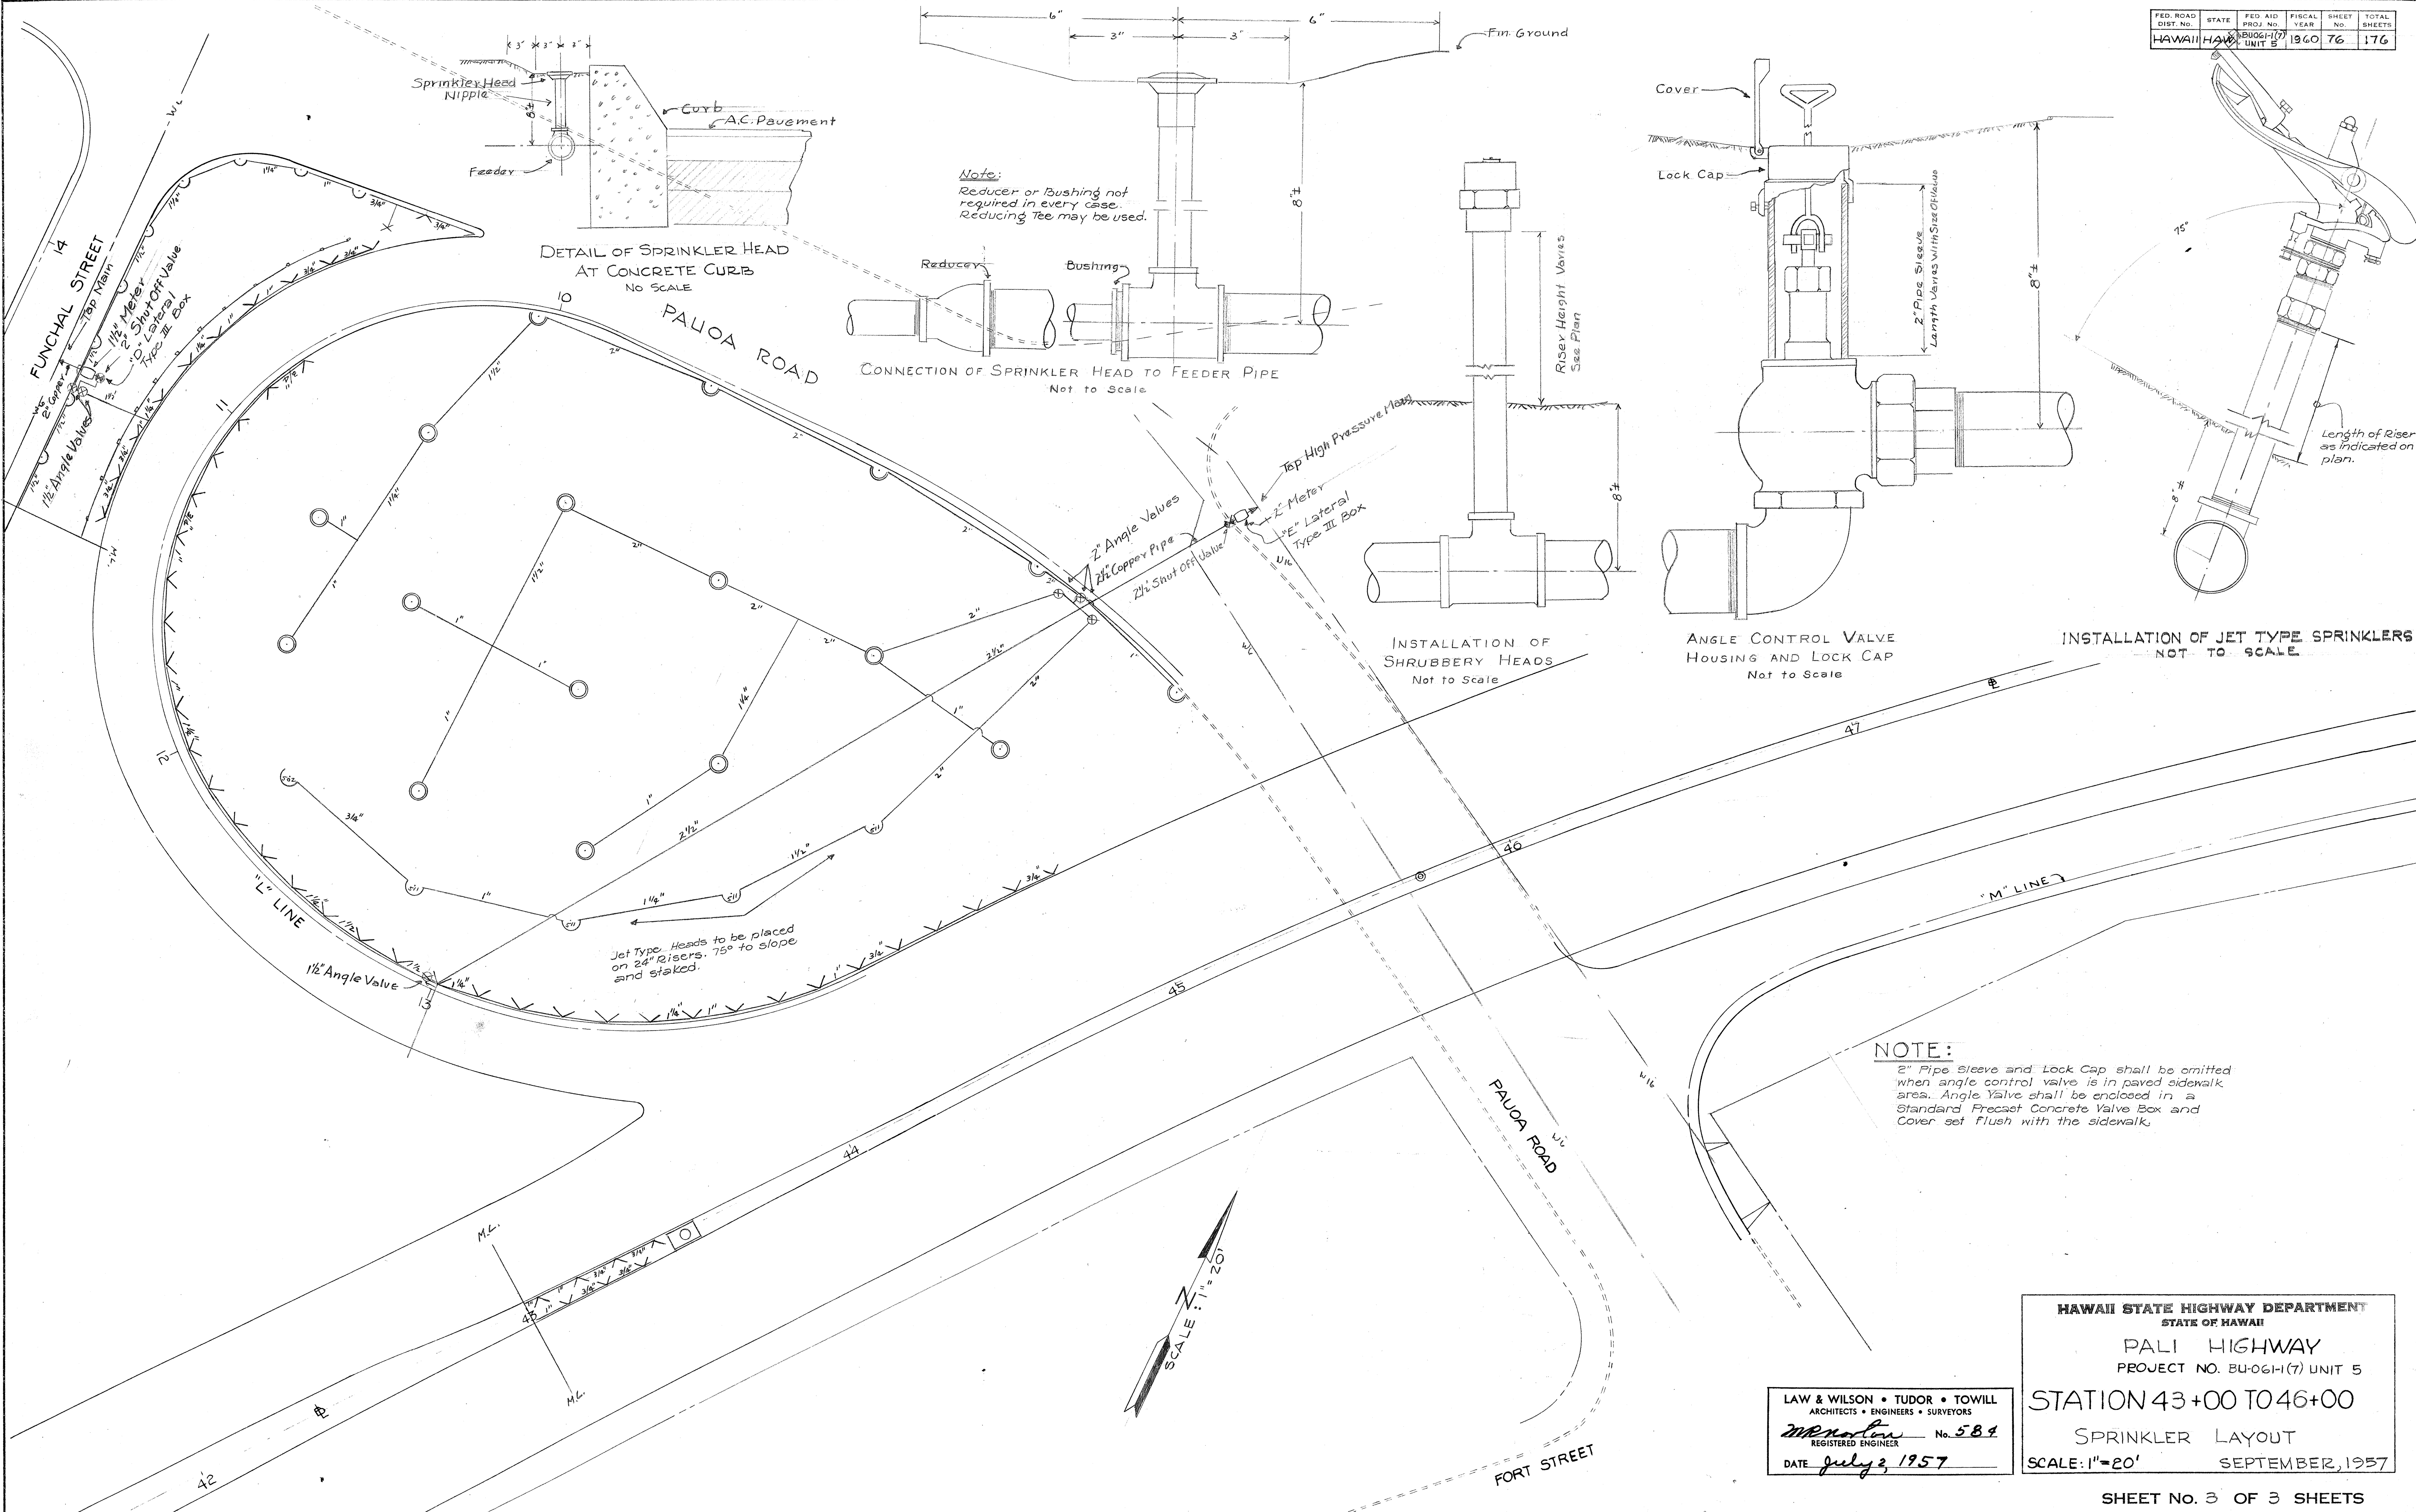

LAW & WILSON • TUDOR • TOWILL
ARCHITECTS • ENGINEERS • SURVEYORS
W. P. Wilson
REGISTERED ENGINEER No. 584
DATE July 2, 1957

HAWAII STATE HIGHWAY DEPARTMENT
STATE OF HAWAII
PALI HIGHWAY
PROJECT NO. BU-0611(7) UNIT 5
STATION 43+00 TO 46+00
SPRINKLER LAYOUT
SCALE: 1"=20' SEPTEMBER, 1957

B. S. 147.76