
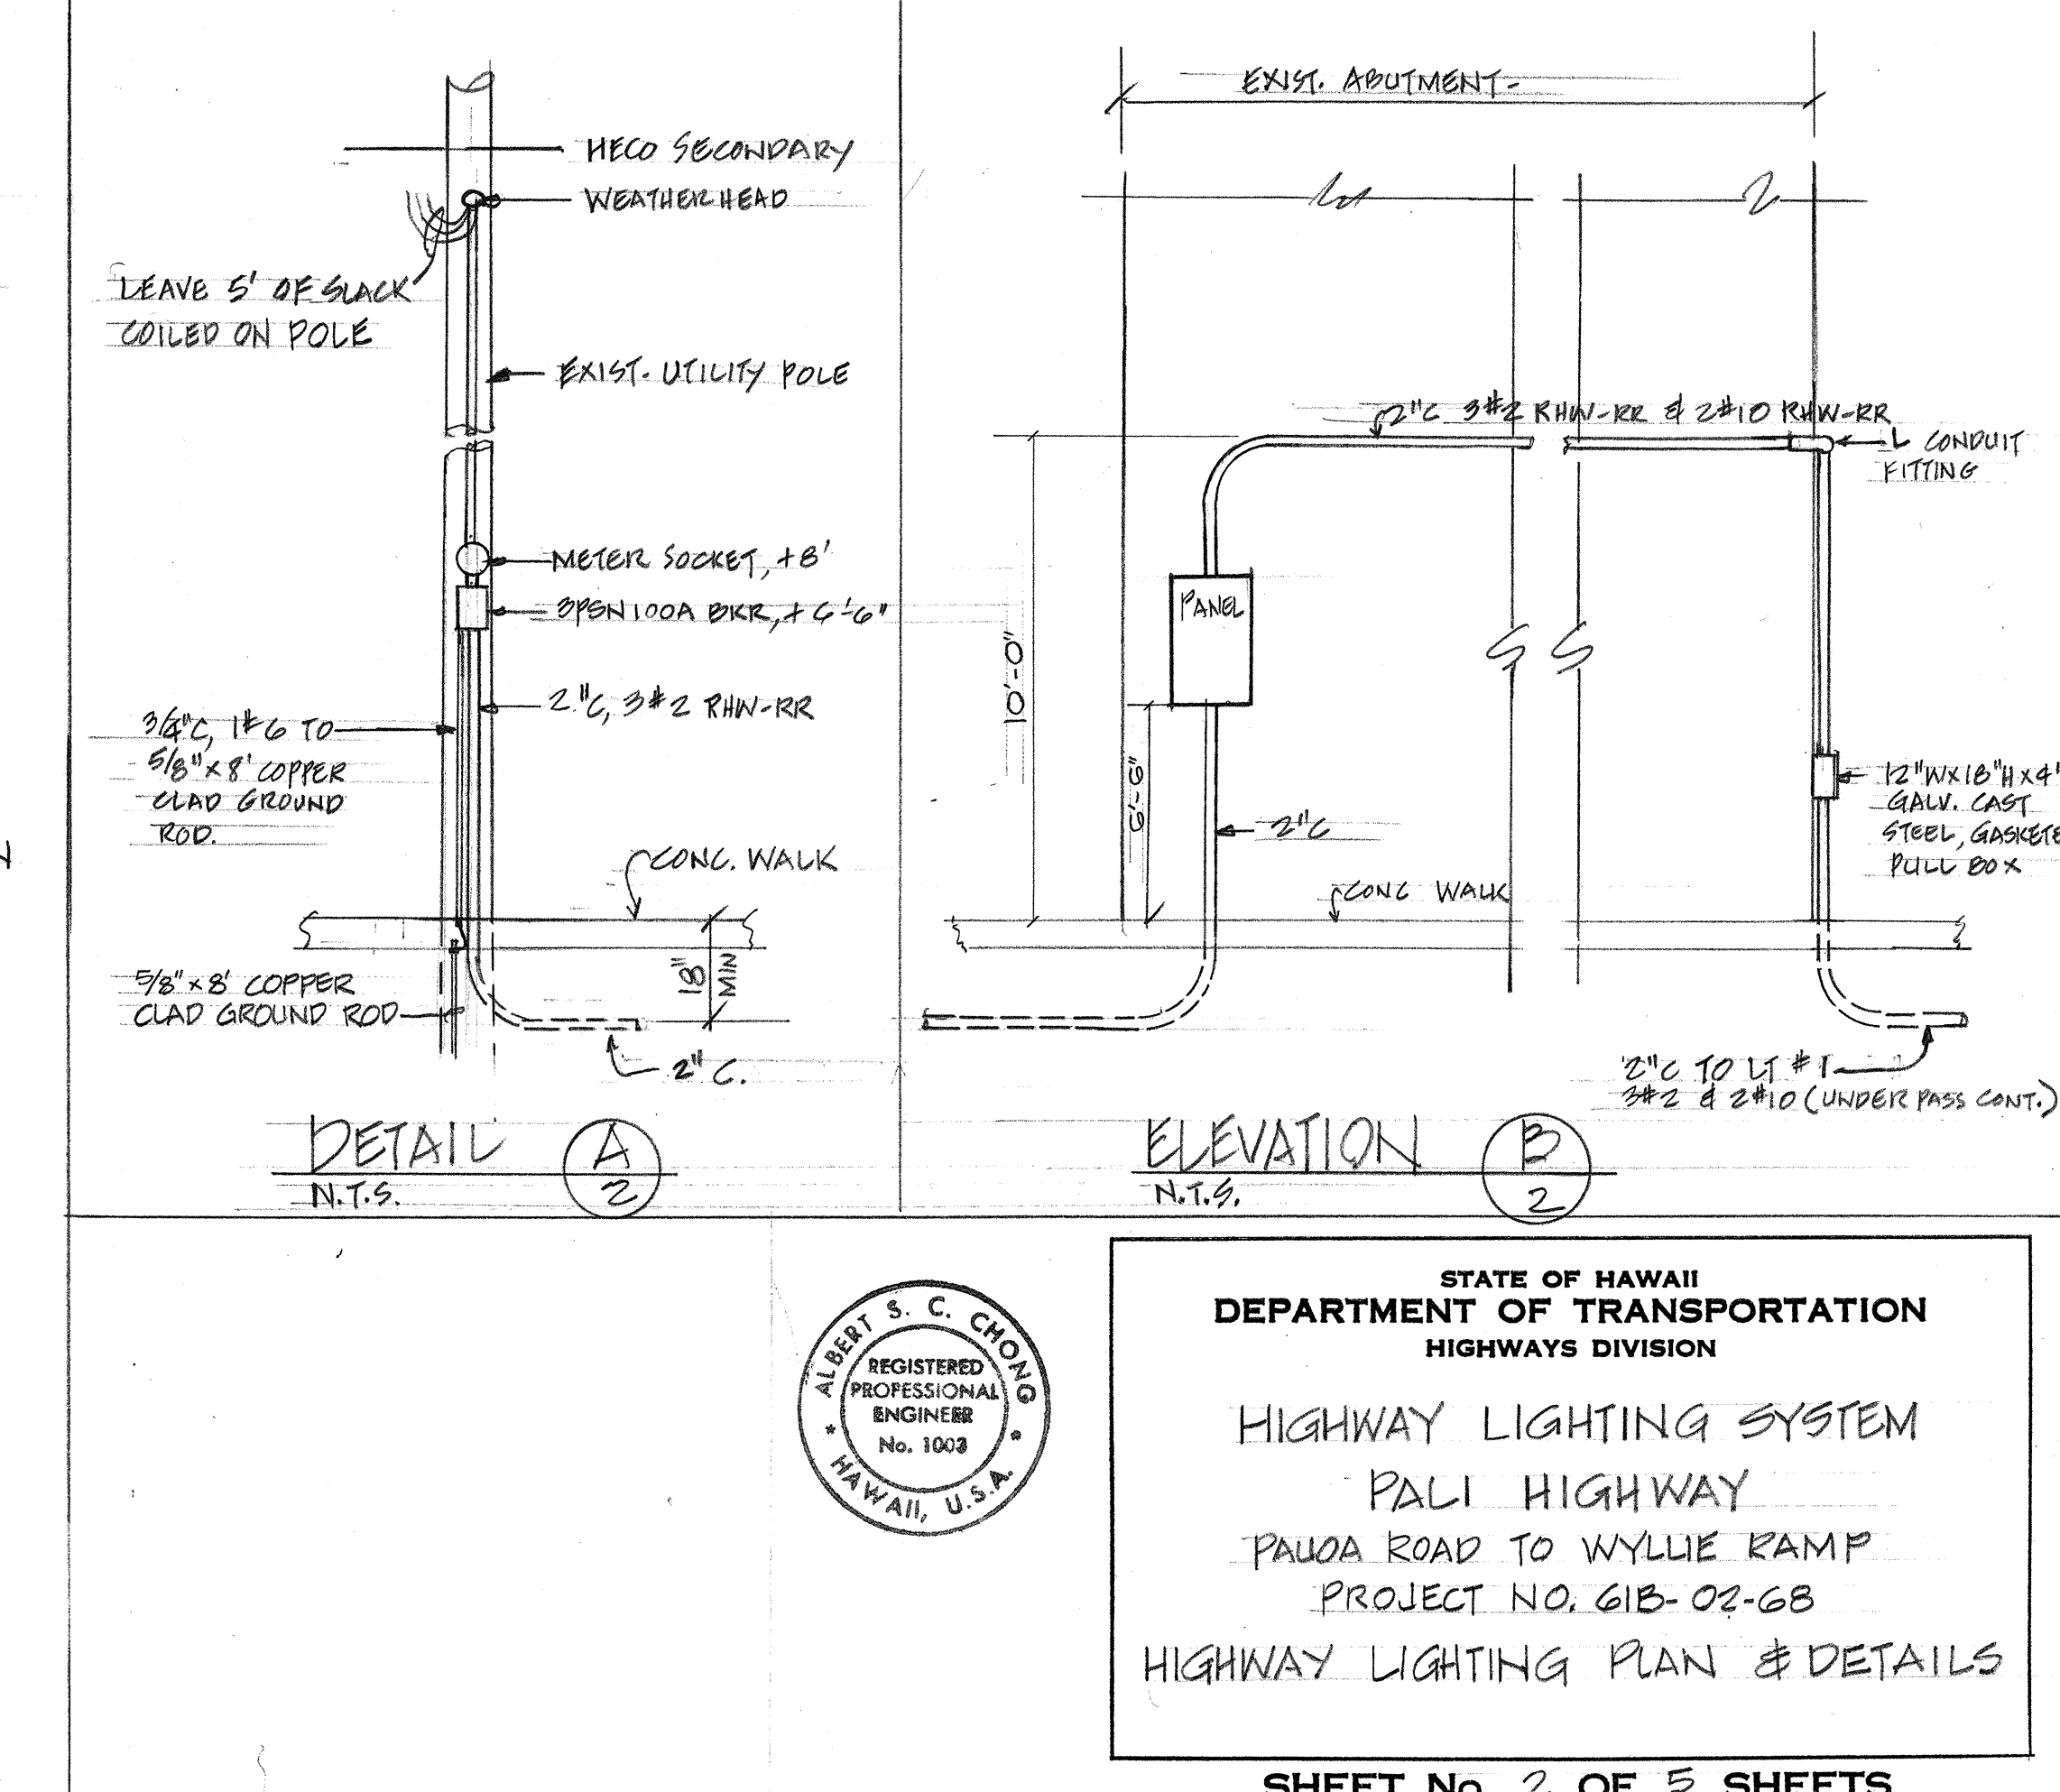
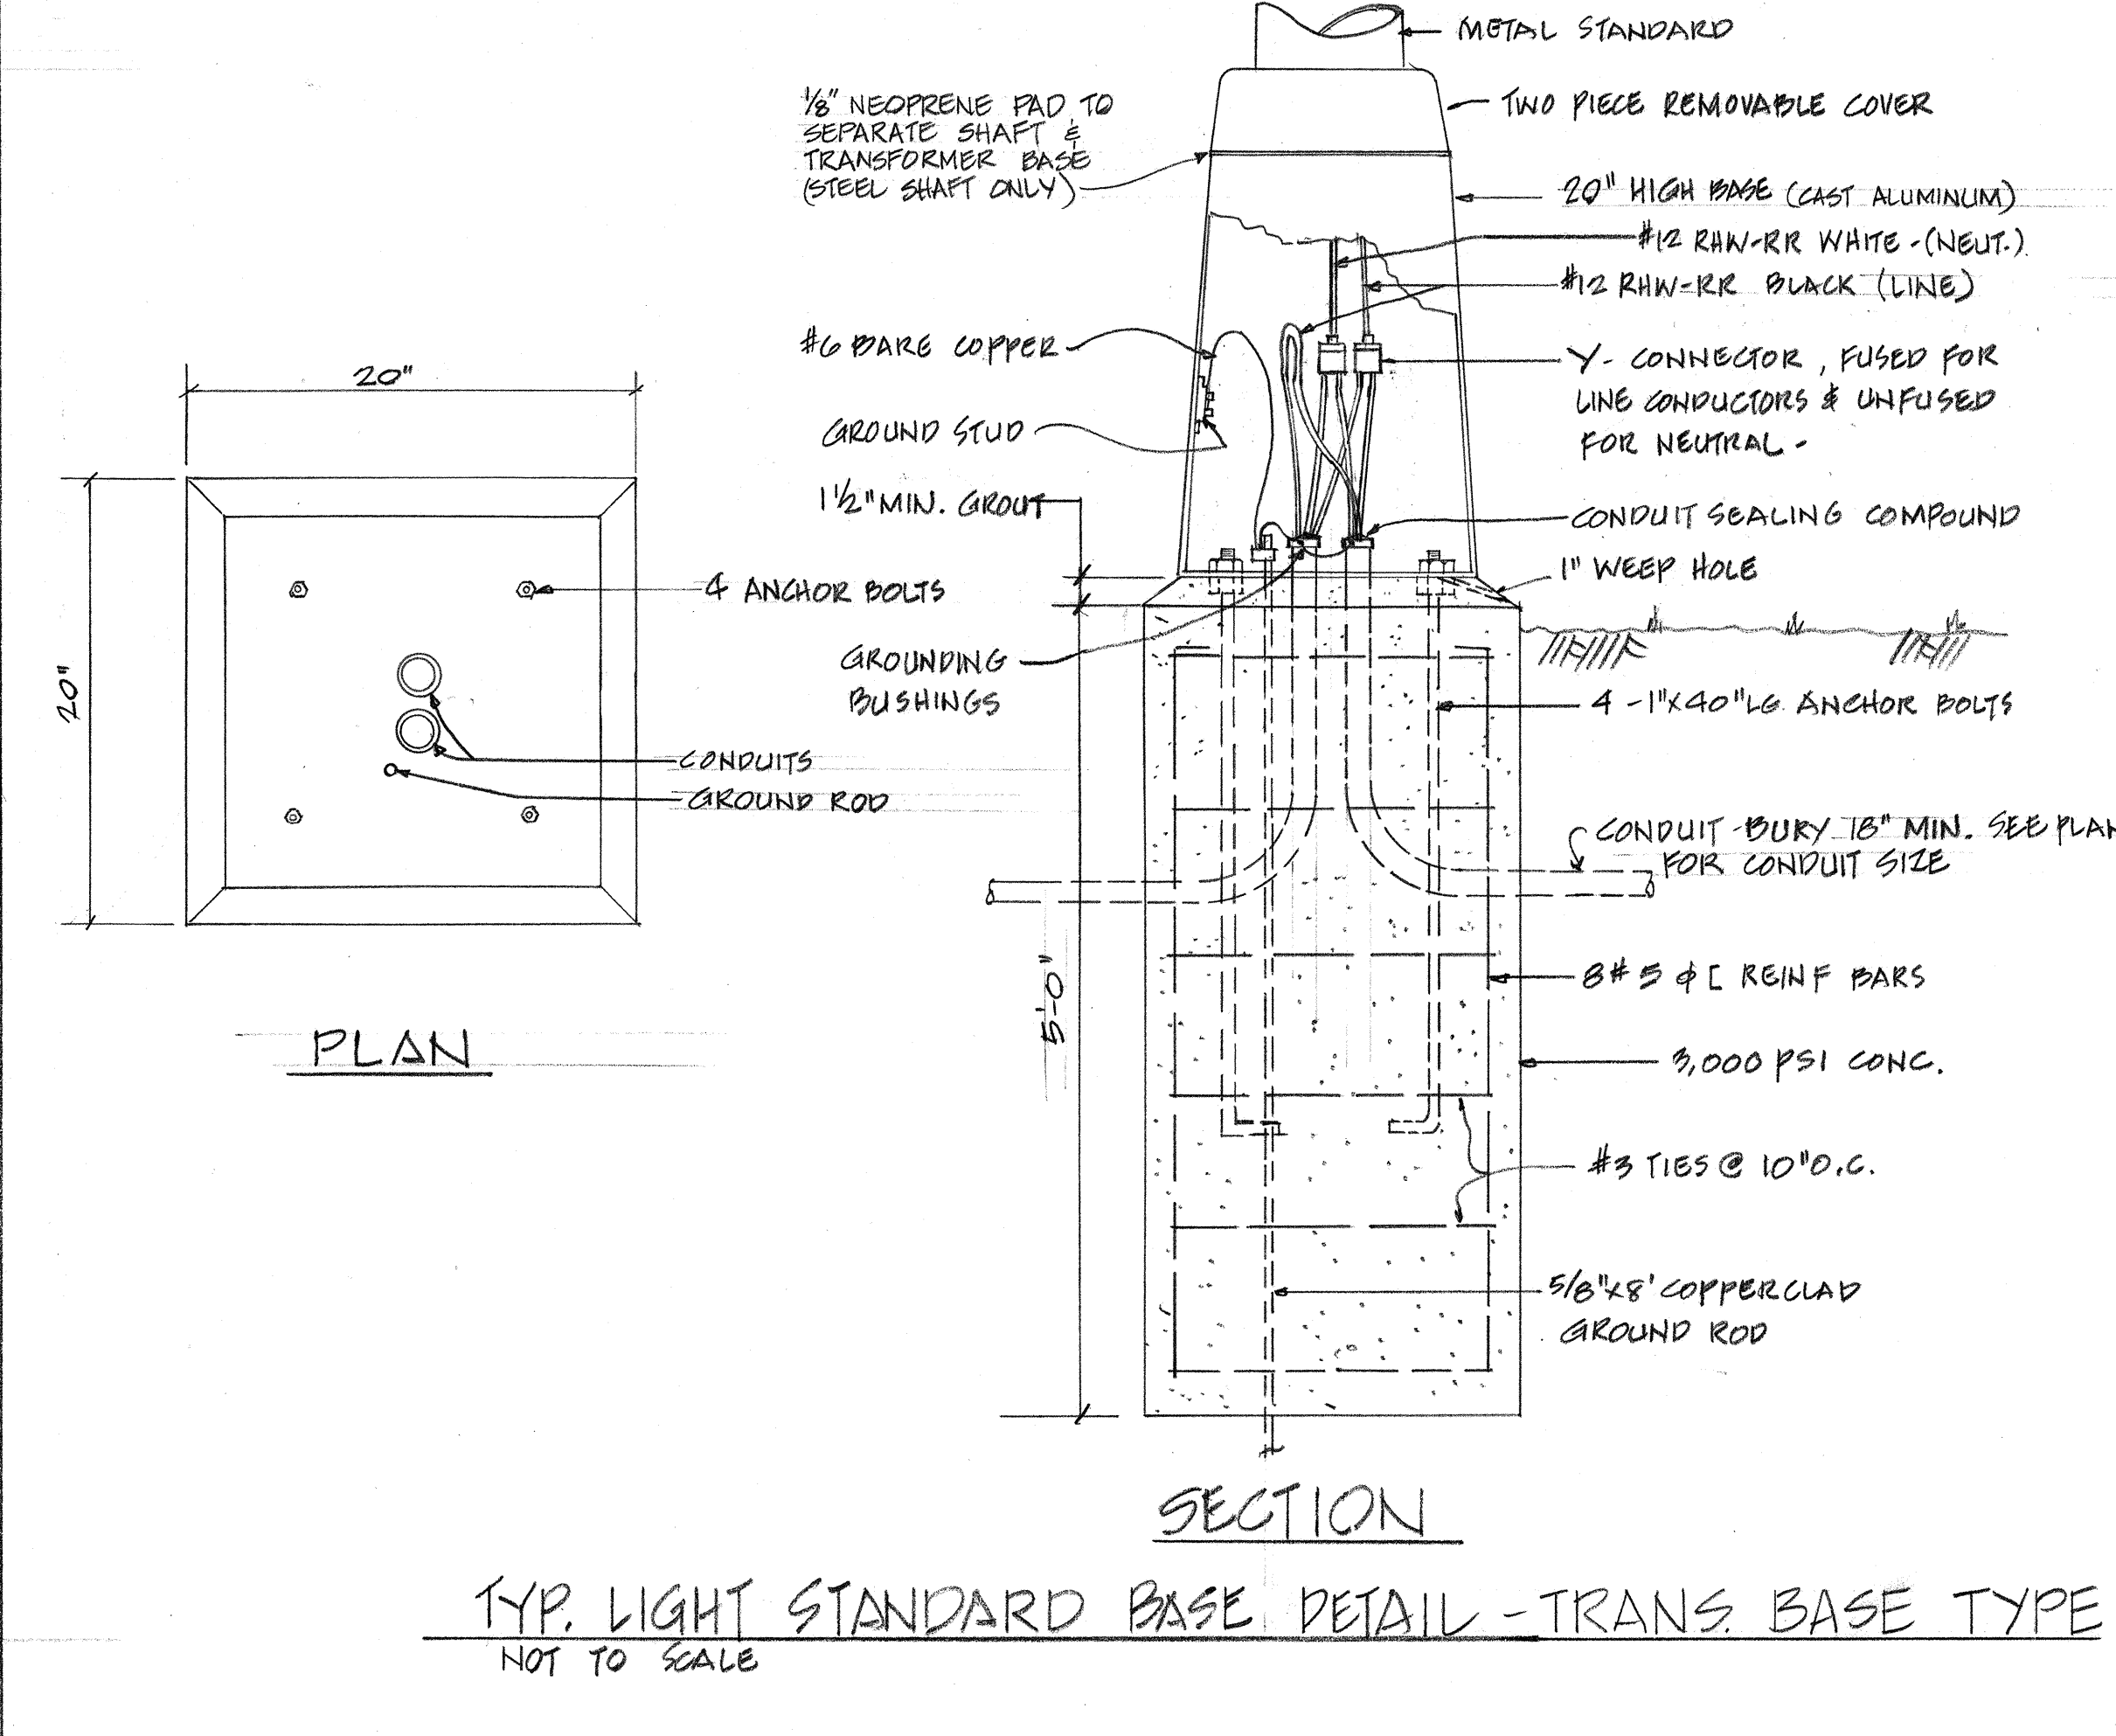
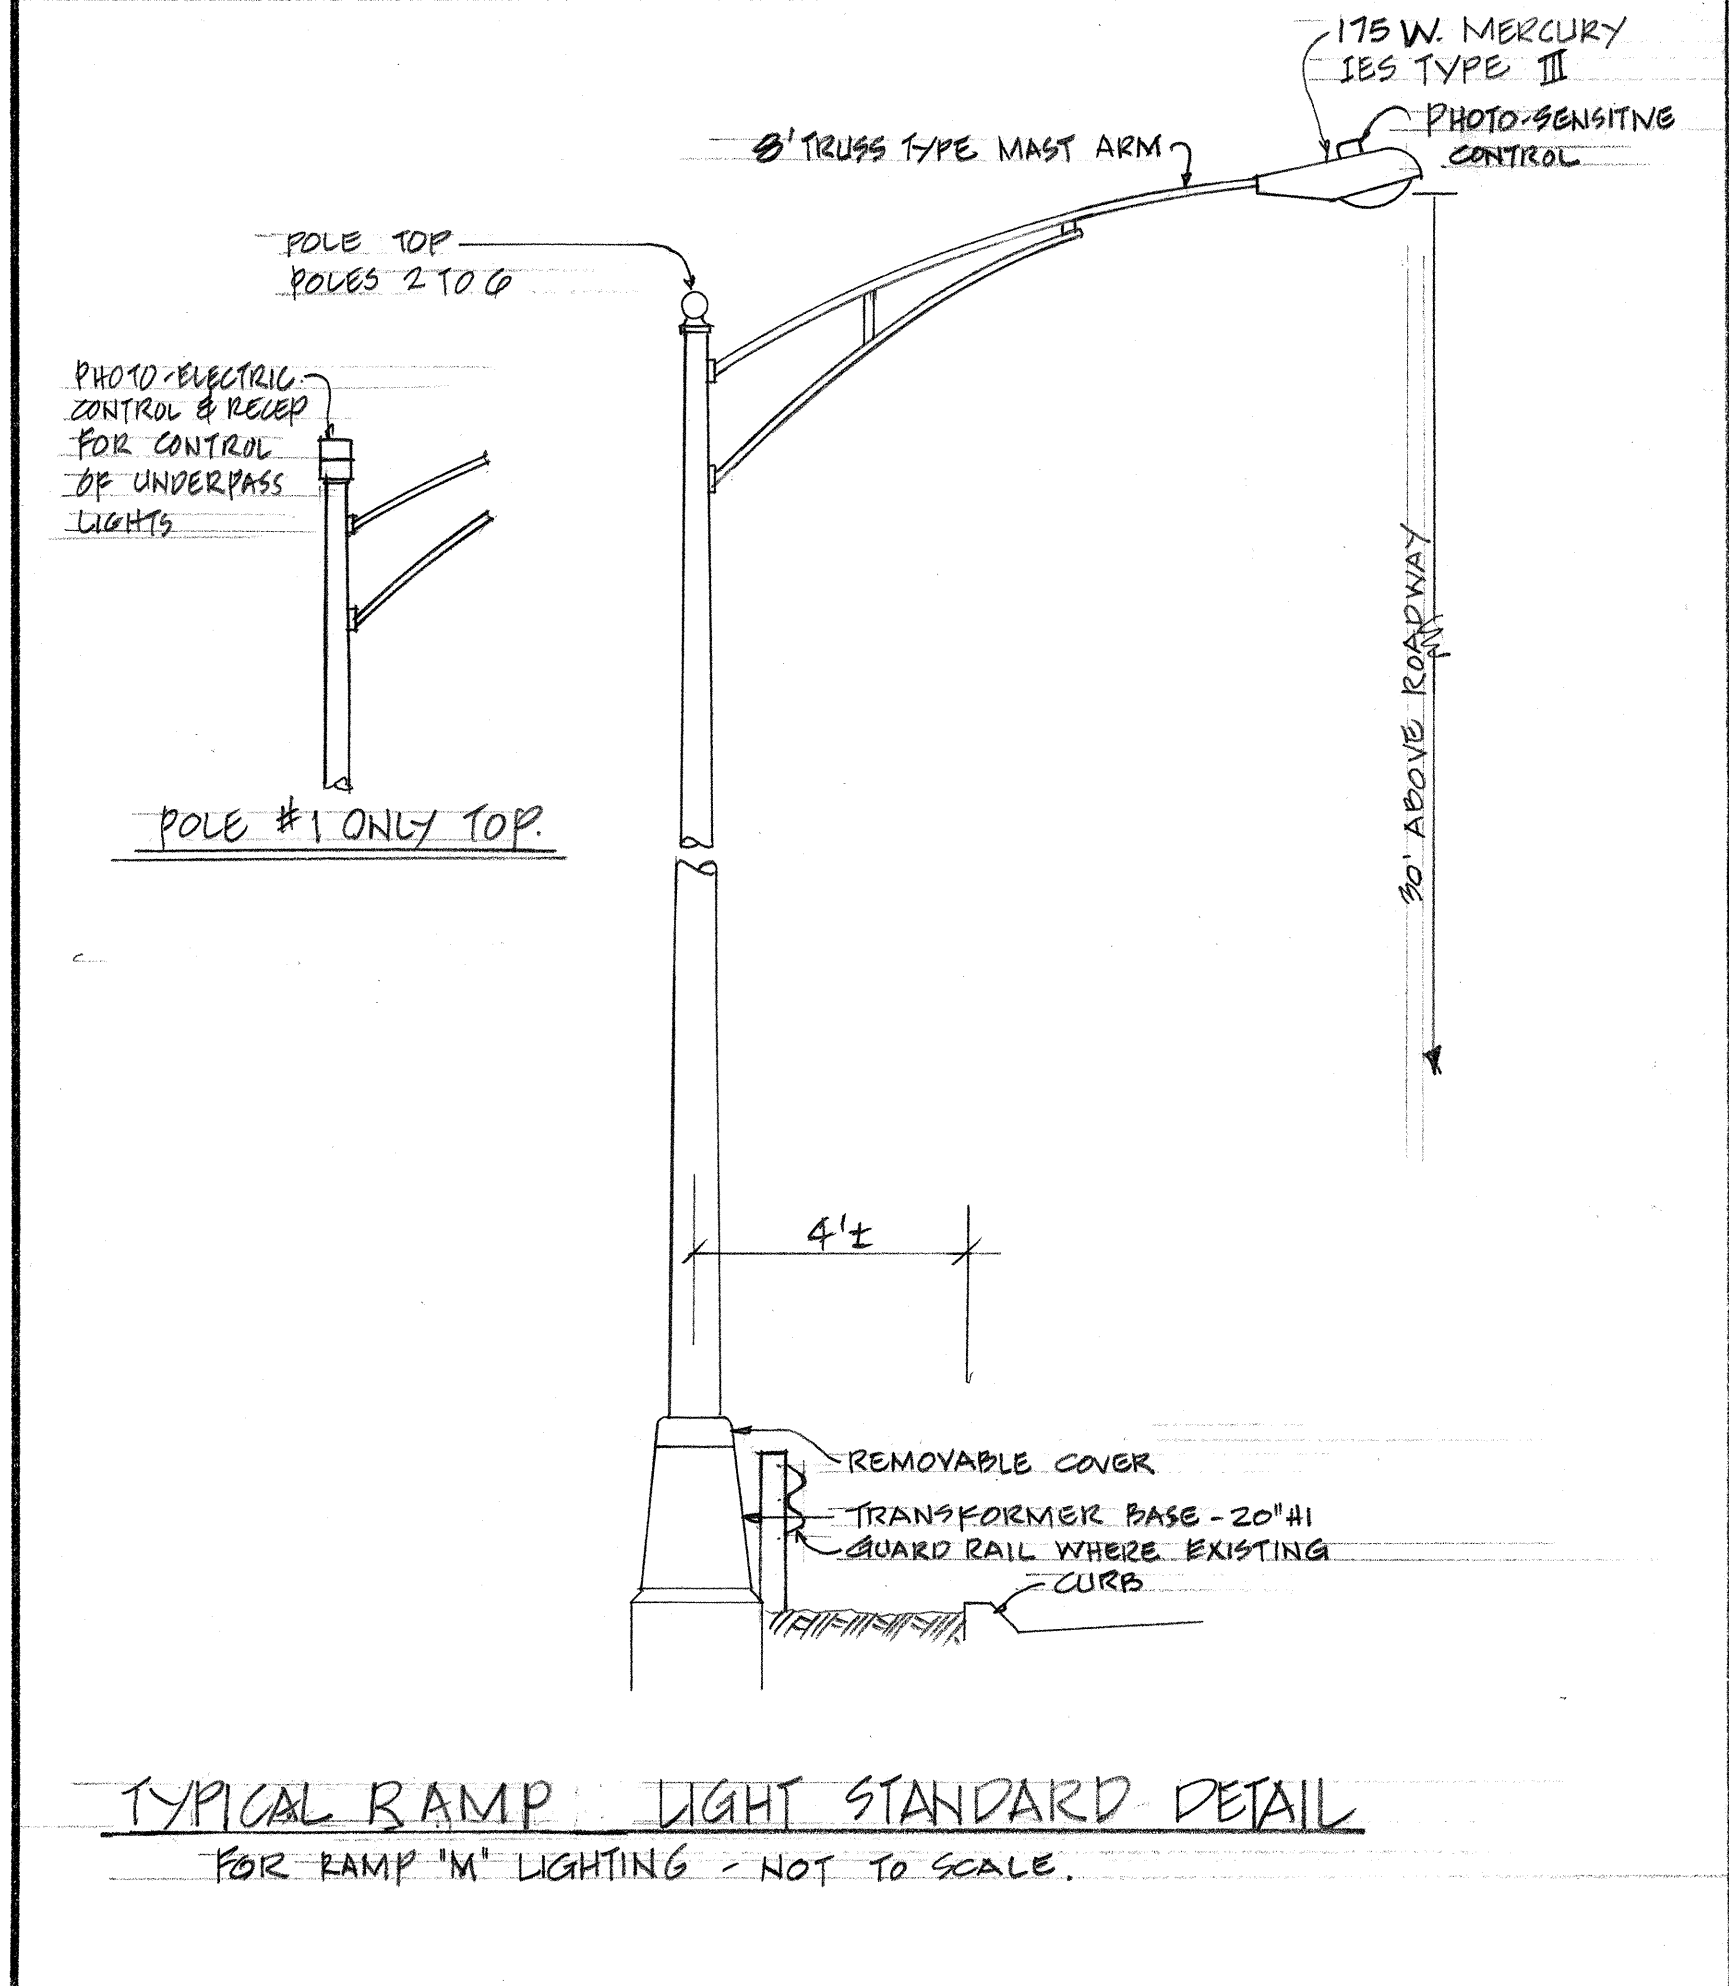
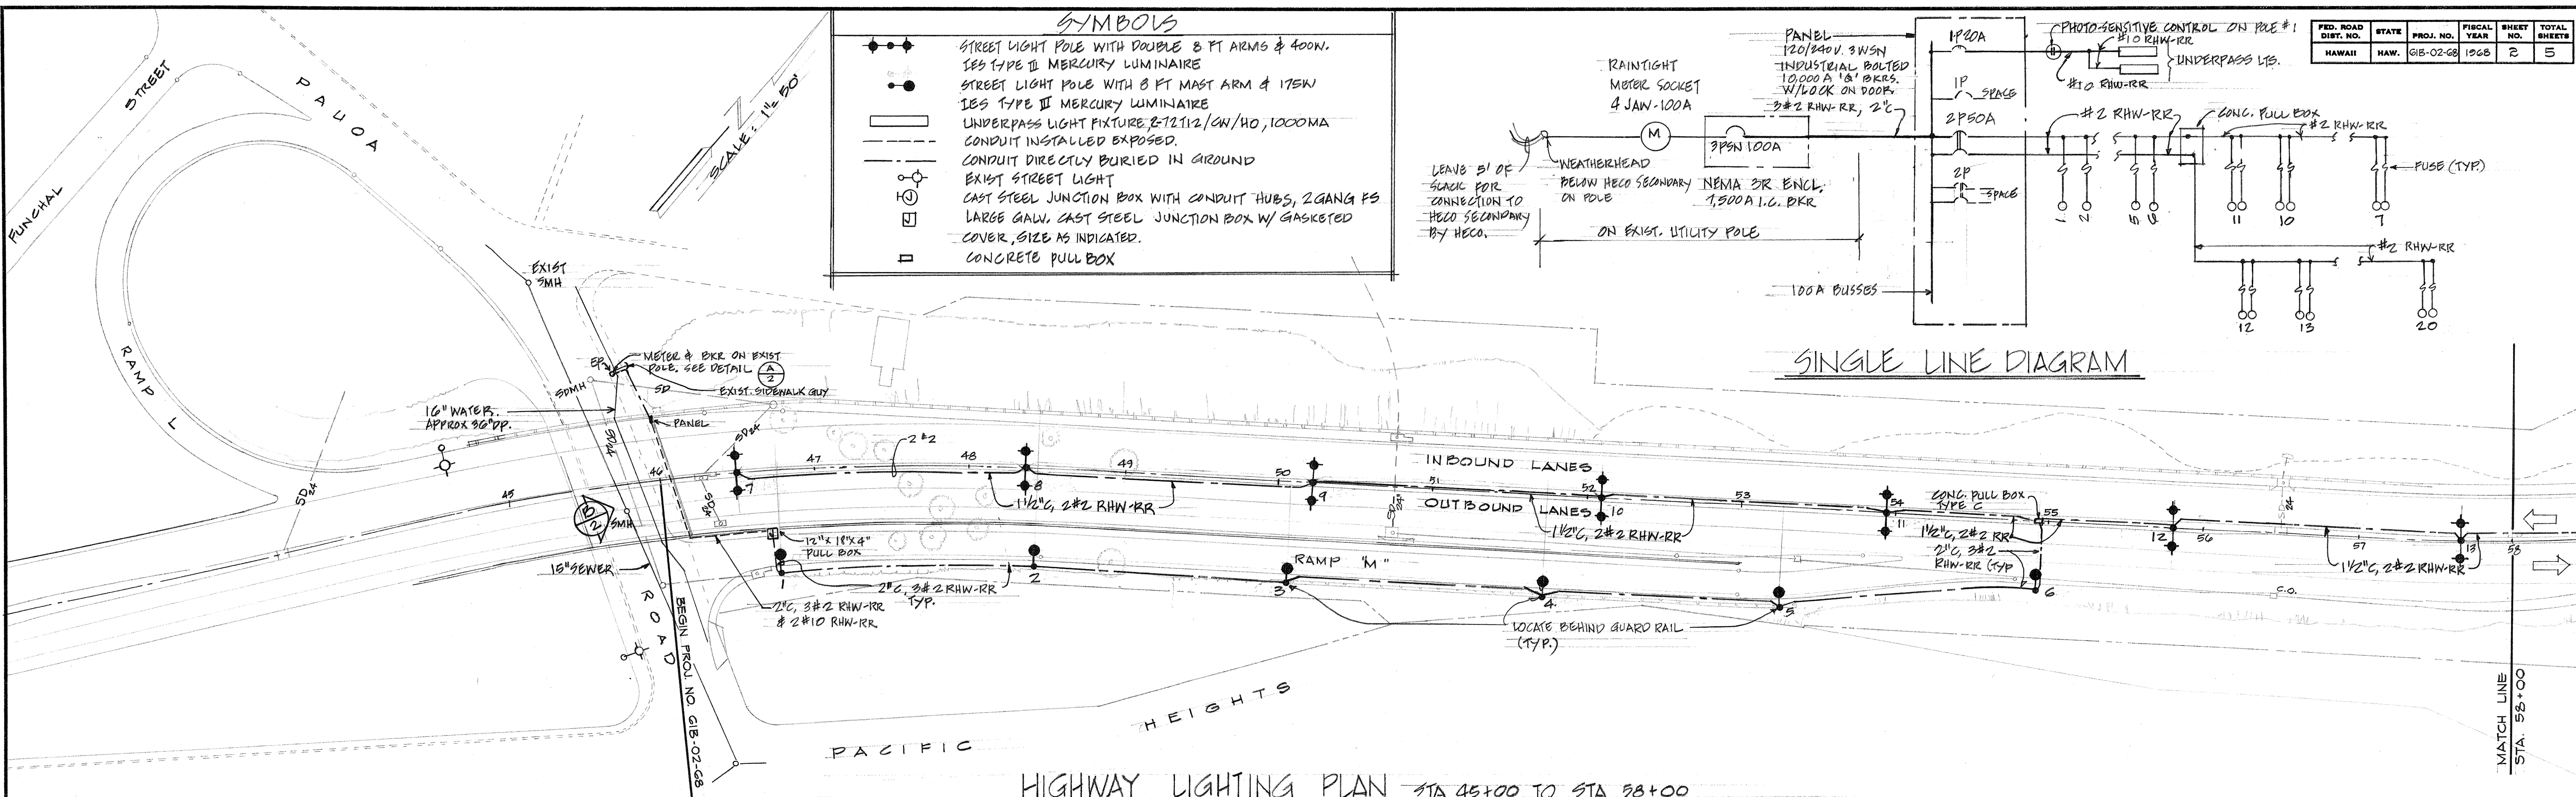



FED. ROAD DIST. NO.	STATE	PROJ. NO.	FISCAL YEAR	SHEET NO.	TOTAL SHEETS
HAWAII	HAW.	615-02-68	1968	2	5

SYMBOLS

- STREET LIGHT POLE WITH DOUBLE 8 FT ARMS & 400W. IES TYPE II MERCURY LUMINAIRE
- STREET LIGHT POLE WITH 8 FT MAST ARM & 175W IES TYPE II MERCURY LUMINAIRE
- UNDERPASS LIGHT FIXTURE 2-12 1/2" CW/HO, 1000MA CONDUIT INSTALLED EXPOSED
- CONDUIT DIRECTLY BURIED IN GROUND
- EXIST. STREET LIGHT
- CAST STEEL JUNCTION BOX WITH CONDUIT HUBS, 2 GANG FS
- LARGE GALV. CAST STEEL JUNCTION BOX W/ GASKETED COVER, SIZE AS INDICATED
- CONCRETE PULL BOX

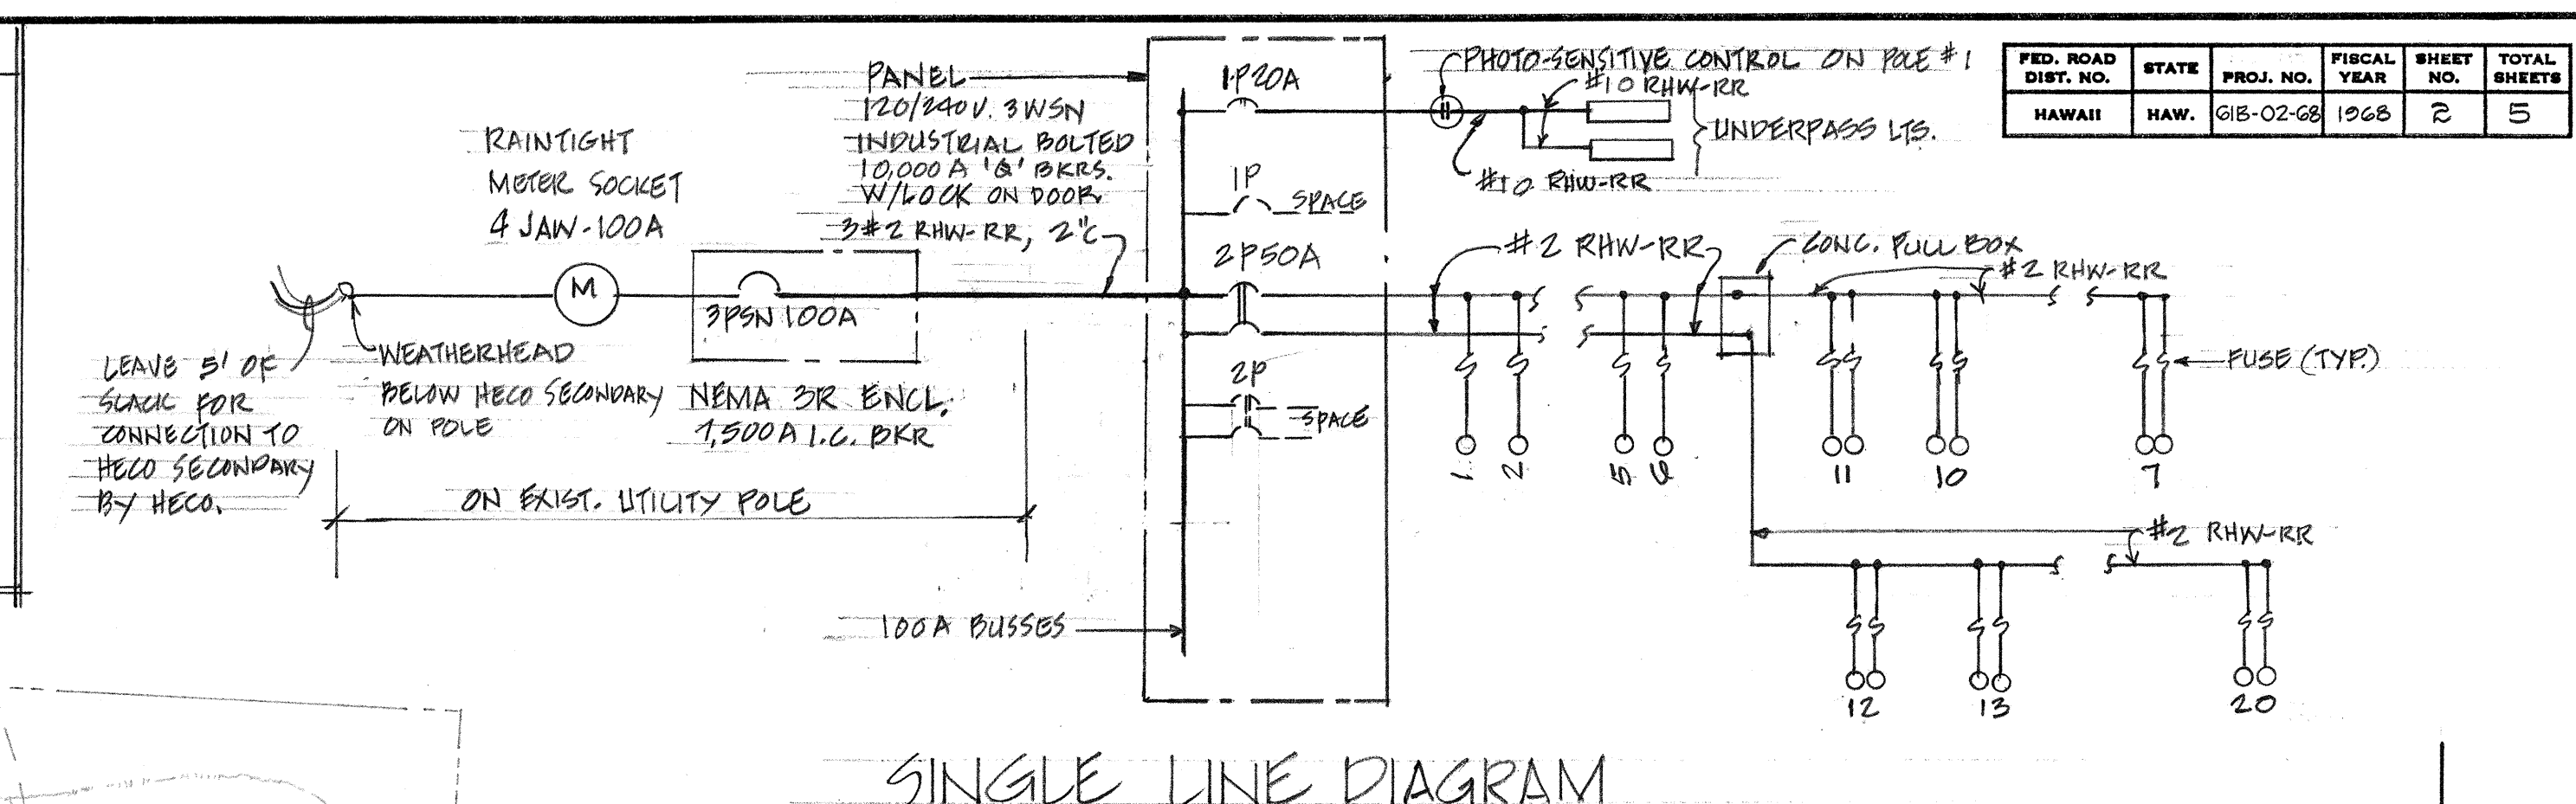

ORIGINAL PLAN	DATE
DRAWN BY	
DESIGNED BY	
CHECKED BY	
NO.	

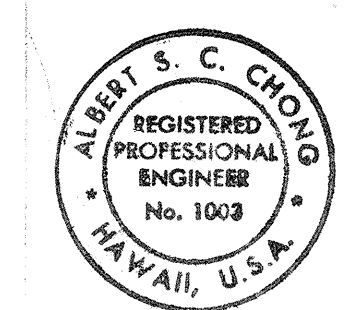


STATE OF HAWAII
DEPARTMENT OF TRANSPORTATION
HIGHWAYS DIVISION


HIGHWAY LIGHTING SYSTEM
PALI HIGHWAY
PAUOA ROAD TO WYLLIE RAMP
PROJECT NO. 615-02-68
HIGHWAY LIGHTING PLAN & DETAILS

SHEET No. 2 OF 5 SHEETS


FED. ROAD DIST. NO.	STATE	PROJ. NO.	FISCAL YEAR	SHEET NO.	TOTAL SHEETS
HAWAII	HAW.	G18-02-CB	1968	3	5

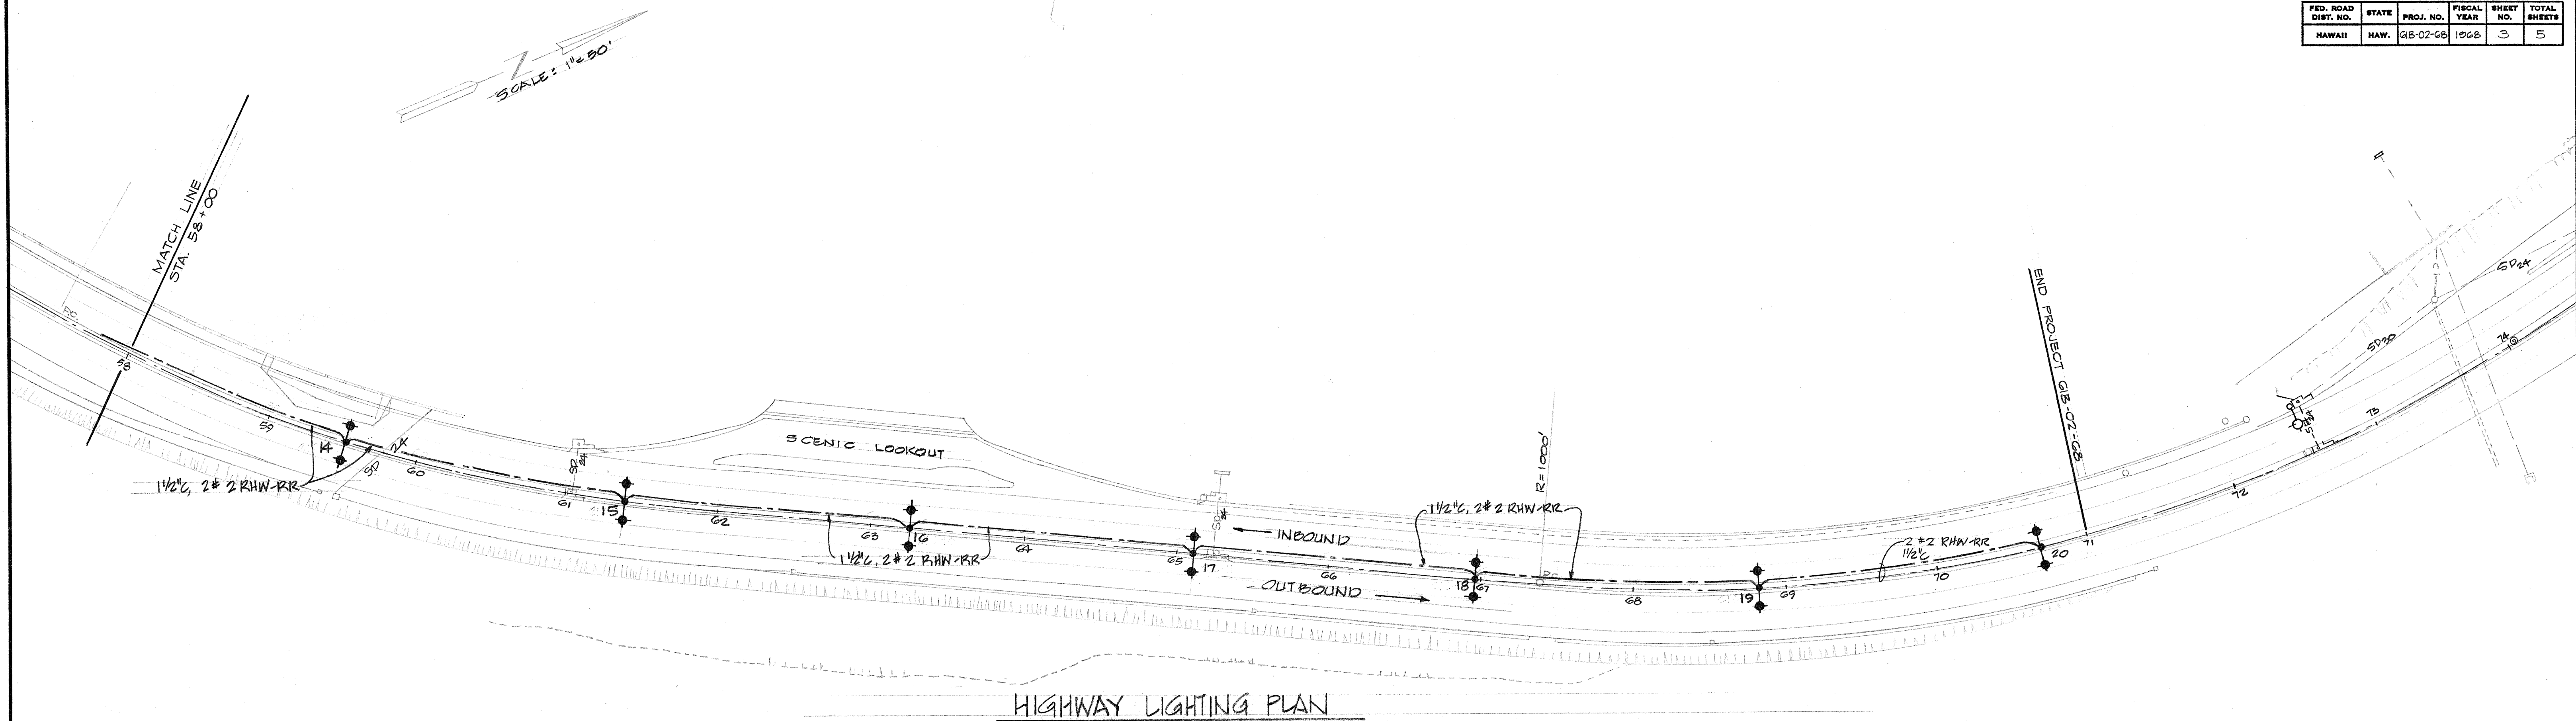


HIGHWAY LIGHTING PLAN

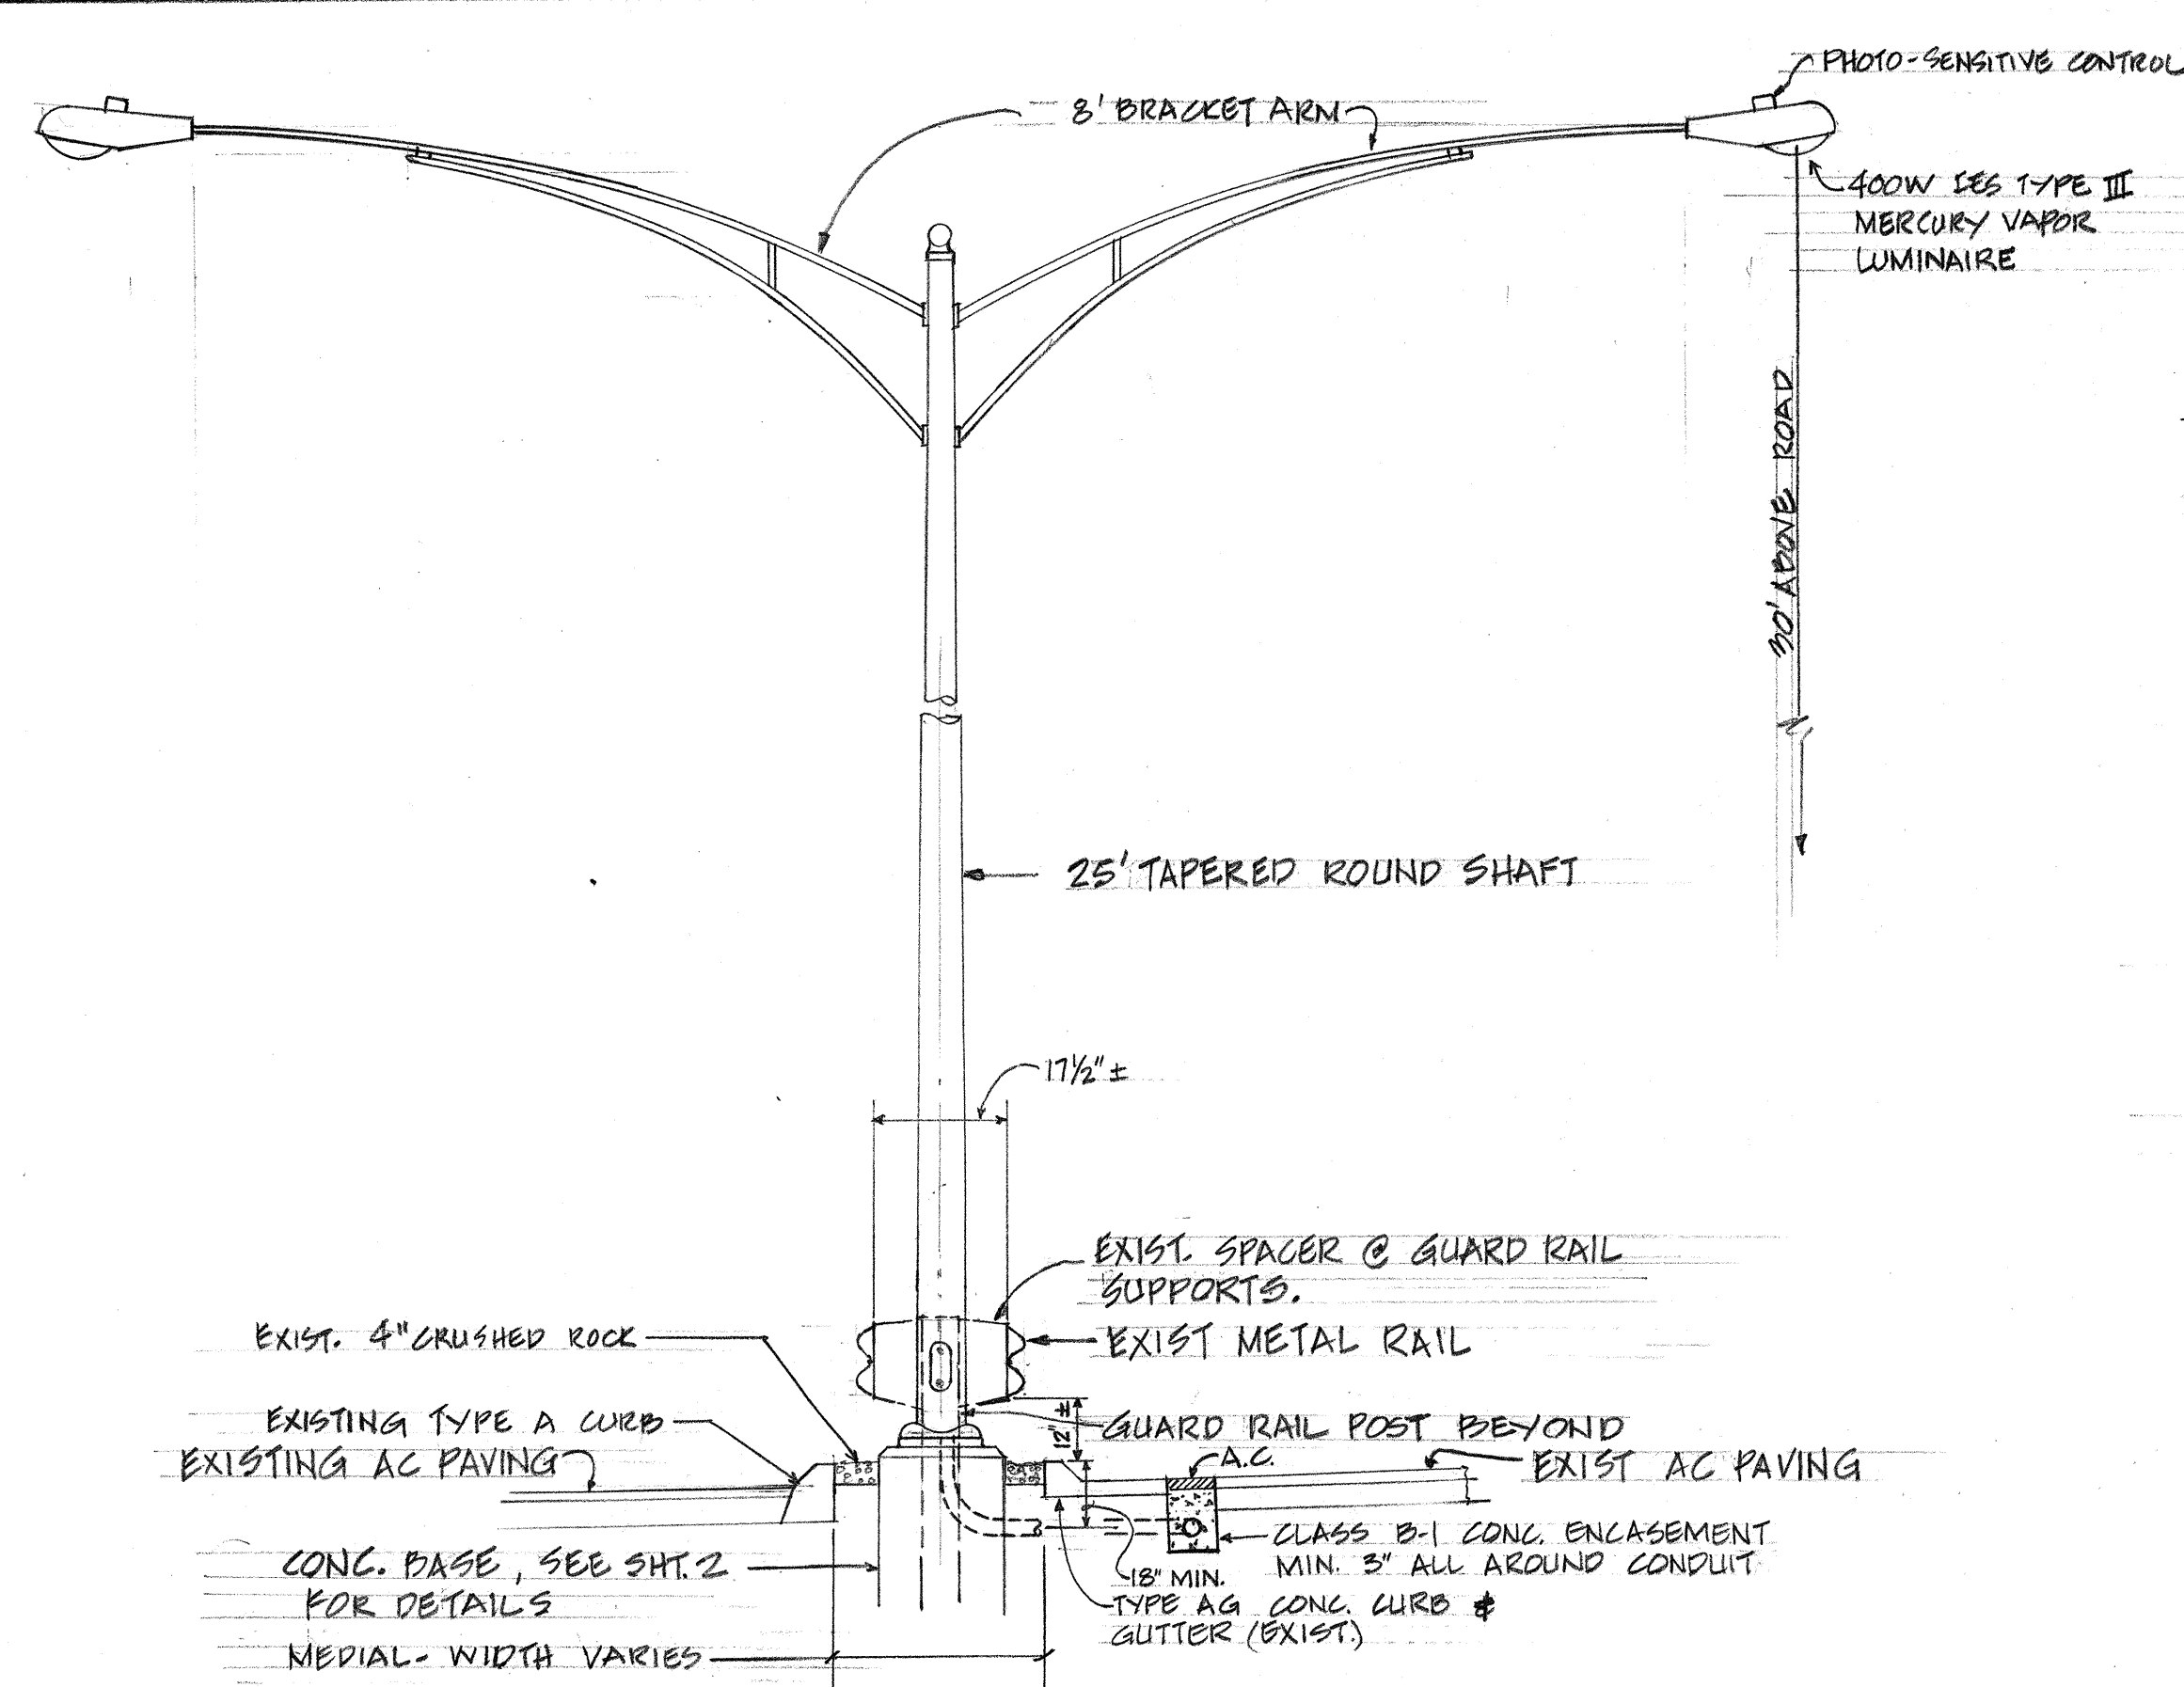

TYPICAL HIGHWAY LIGHT STANDARD IN MEDIAN DETAIL
NOT TO SCALE

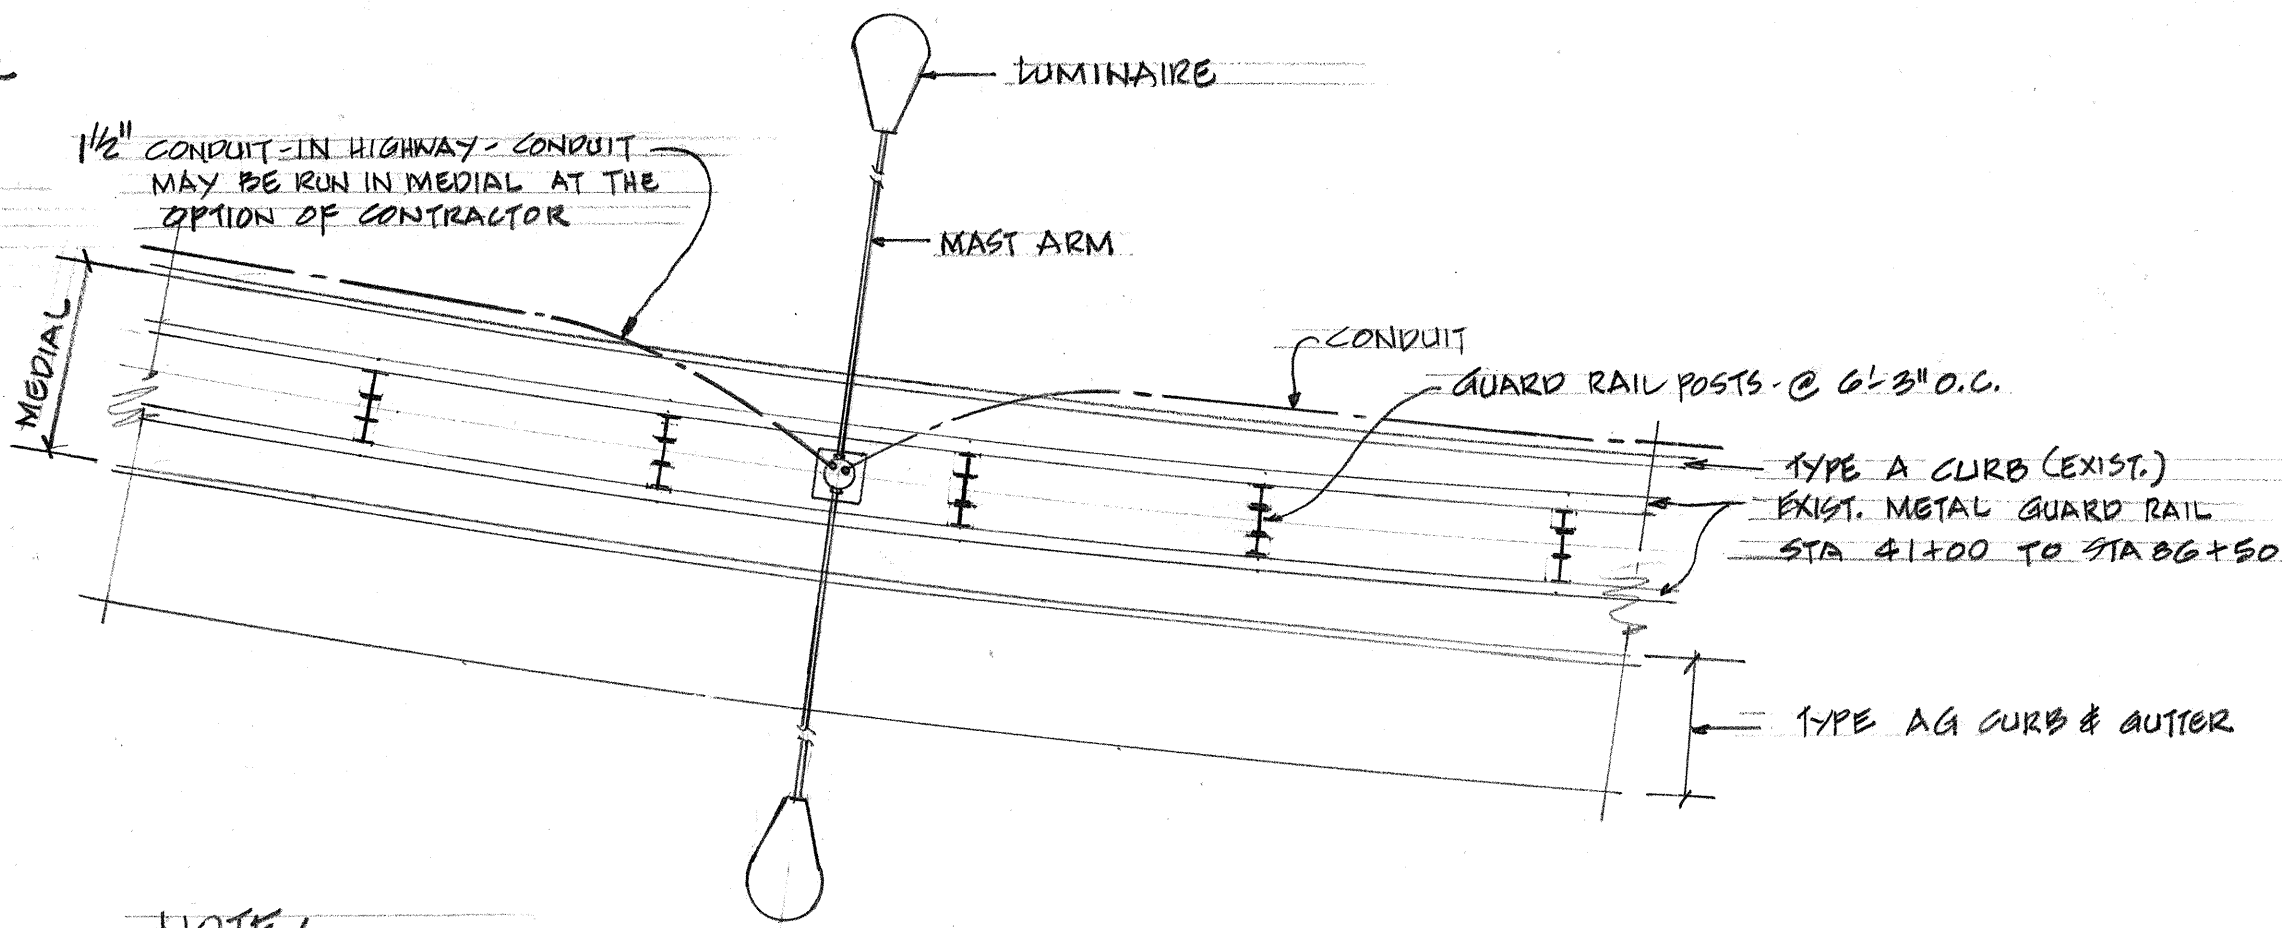


NOTE:
1. CONTRACTOR TO CUT ROAD PAVEMENT & CURB AS REQD TO
INSTALL CONDUIT. RESTORE CURB & PAVEMENT TO EXIST.
CONDITION: TRENCH SHALL BE BACKFILLED WITH CONCRETE UP TO THE
BASE COURSE & TOPPED WITH A.C. PAVEMENT OF THICKNESS EQUAL
TO EXISTING PAVEMENT.
ENLARGED HIGHWAY PLAN
NOT TO SCALE

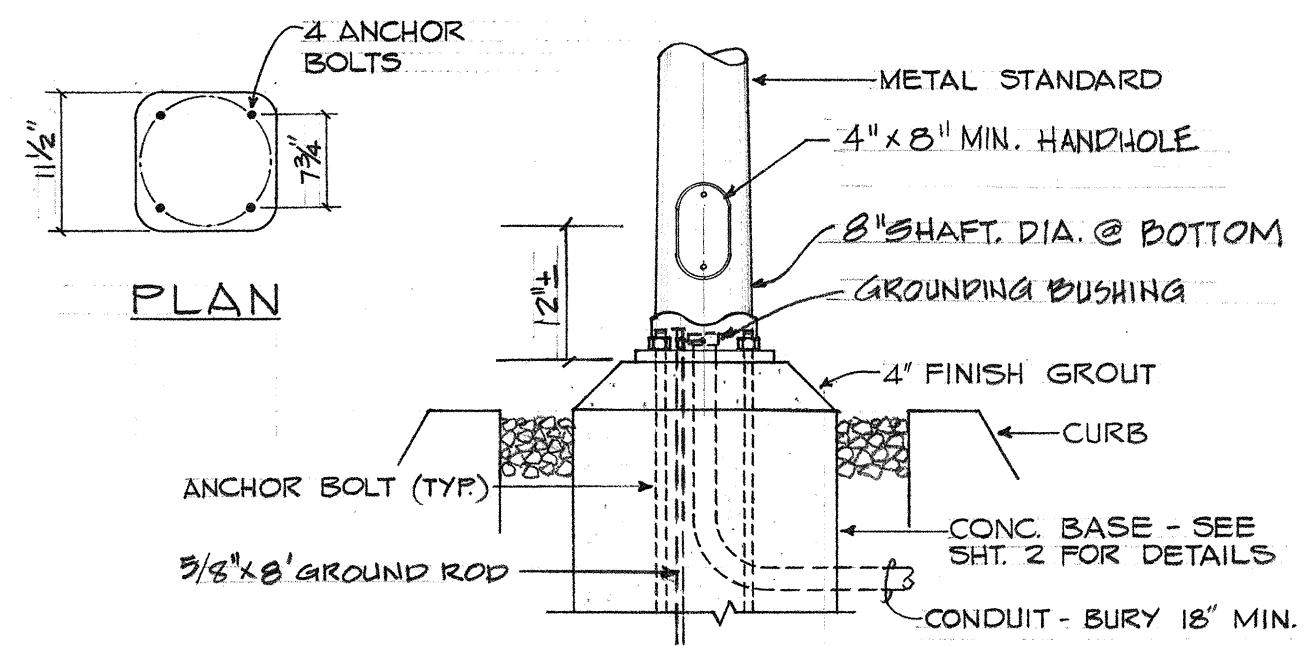

SECTION
ANCHOR BASE DETAIL
NOT TO SCALE

ORIGINAL PLAN	DATE
SURVEY PLOTTED BY	
DRAWN BY	
DESIGNED BY	
CHECKED BY	
NOTE BOOK	
No.	

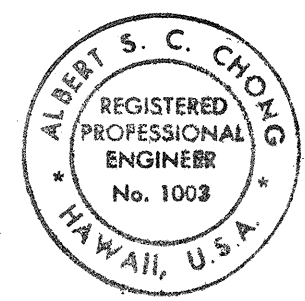

STATE OF HAWAII
DEPARTMENT OF TRANSPORTATION
HIGHWAYS DIVISION

HIGHWAY LIGHTING SYSTEM
PALI HIGHWAY
PAHOA ROAD TO WYLIE RAMP
PROJECT NO. G18-02-CB
HIGHWAY LIGHTING PLAN & DETAILS

SHEET No. 3 OF 5 SHEETS