




FED. ROAD DIST. NO.	STATE	PROJ. NO.	FISCAL YEAR	SHEET NO.	TOTAL SHEETS
HAWAII	HAW.	G1B-02-68	1968	4	5

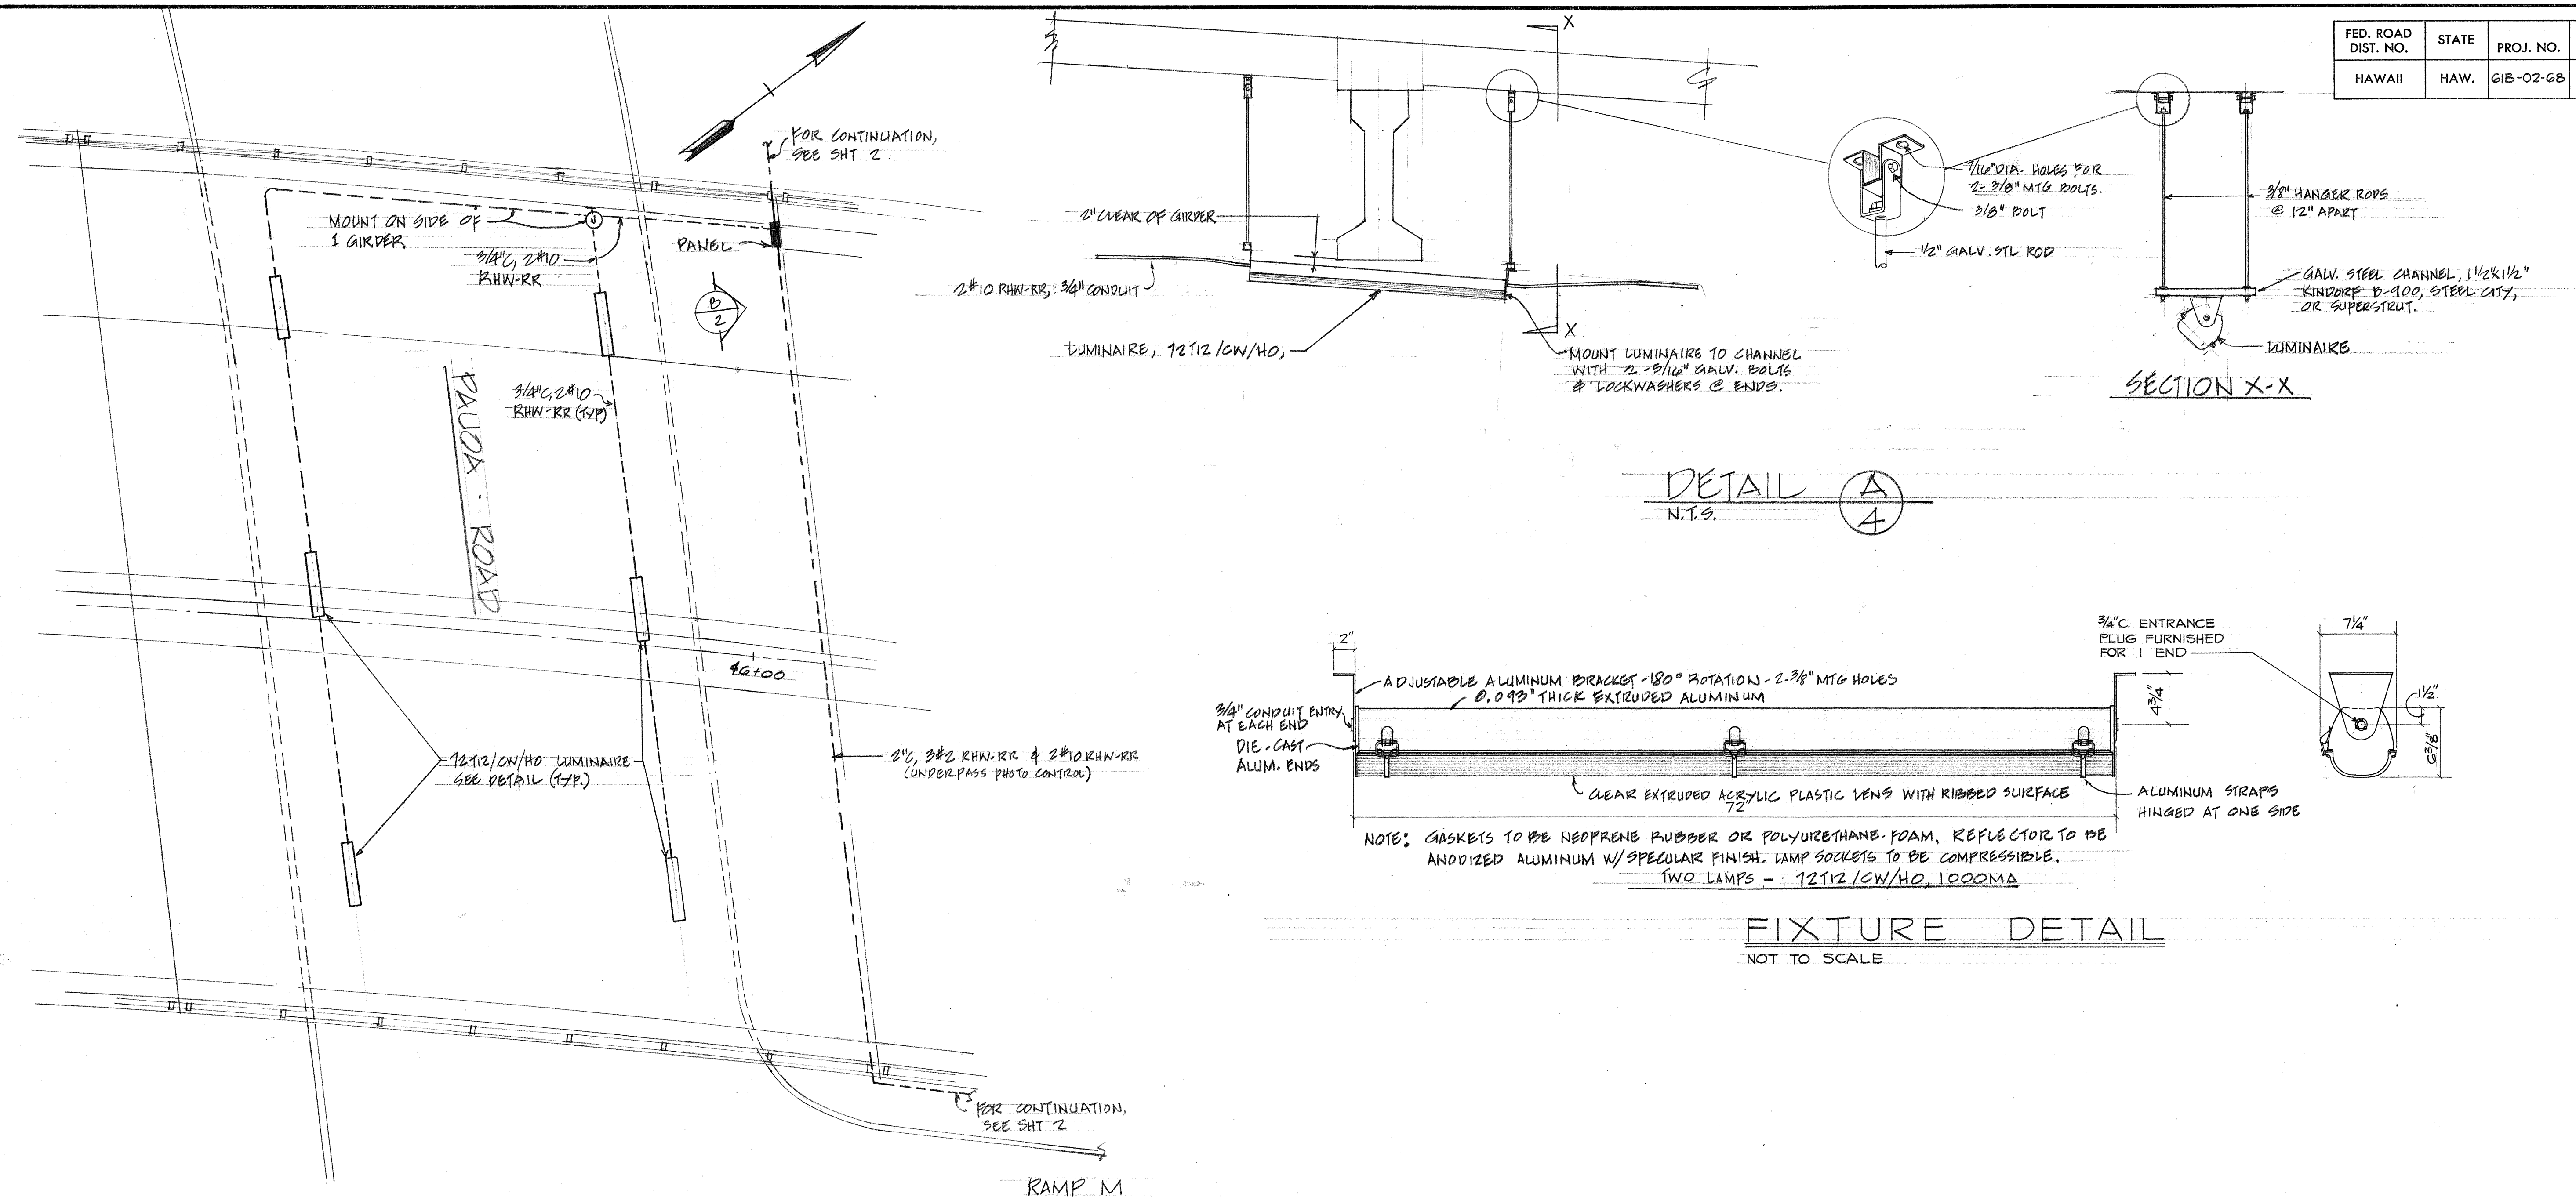

UNDERPASS LIGHTING PLAN
SCALE: 1/8" = 1'-0"


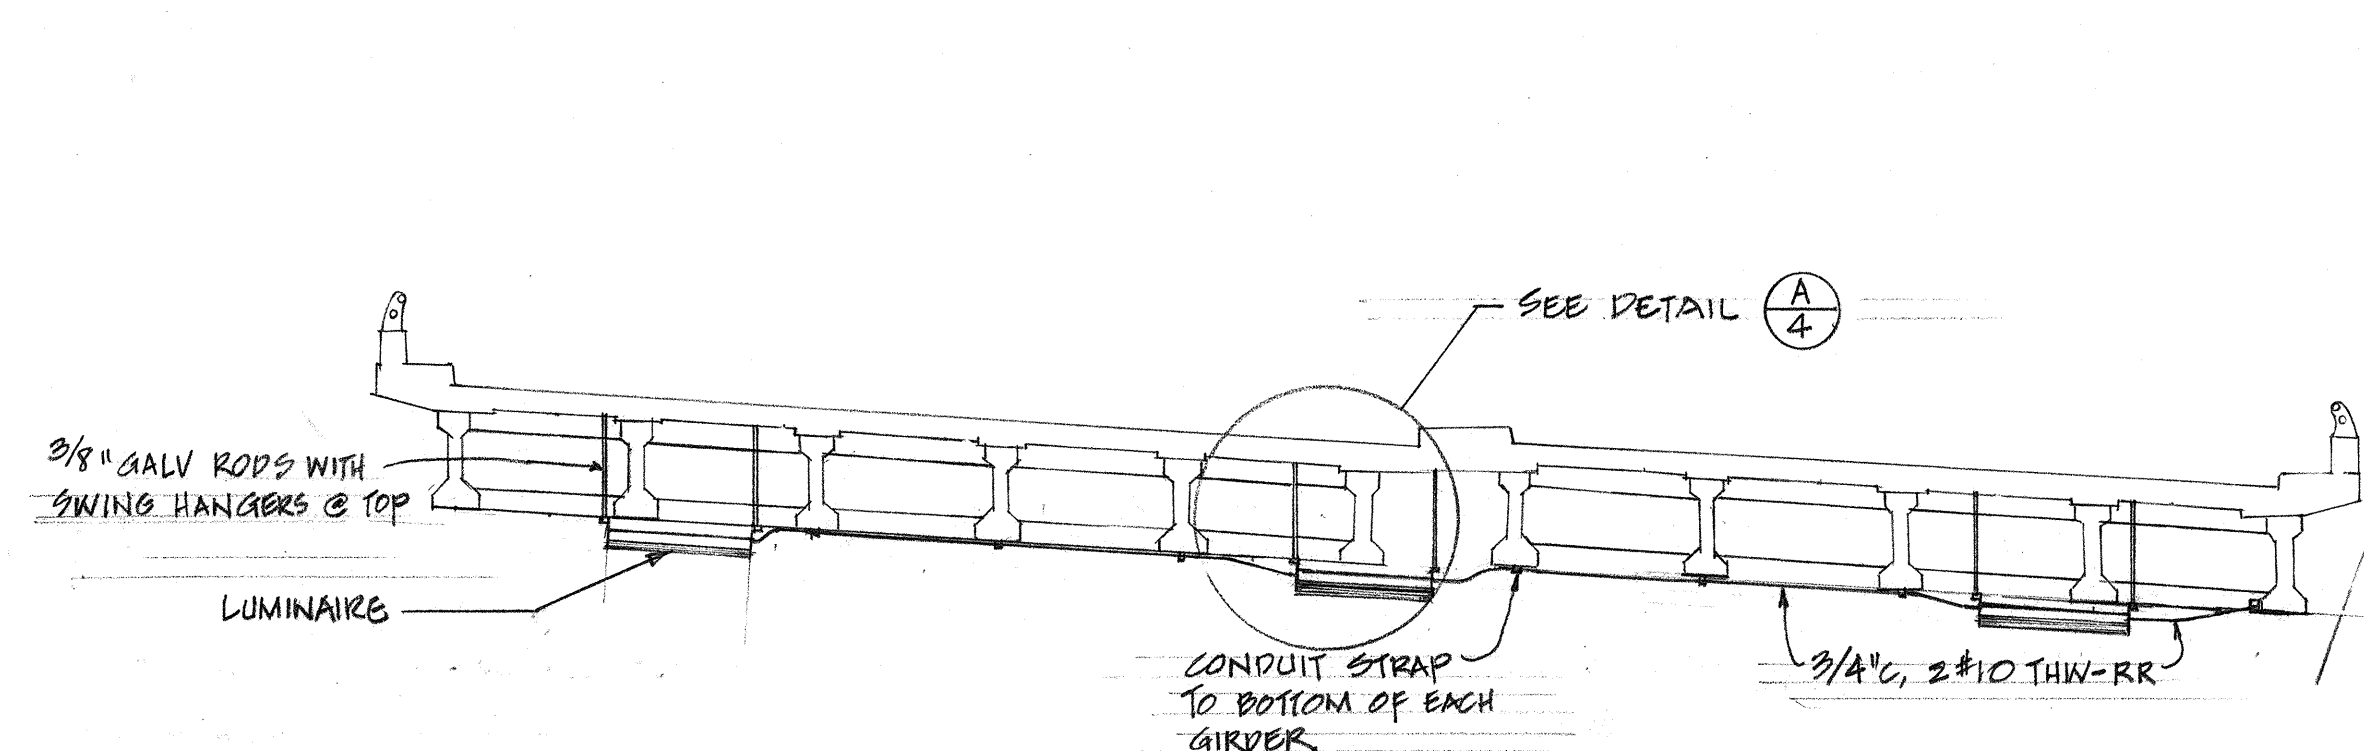


TRANSVERSE SECTION
SCALE: 1/8" = 1'-0"

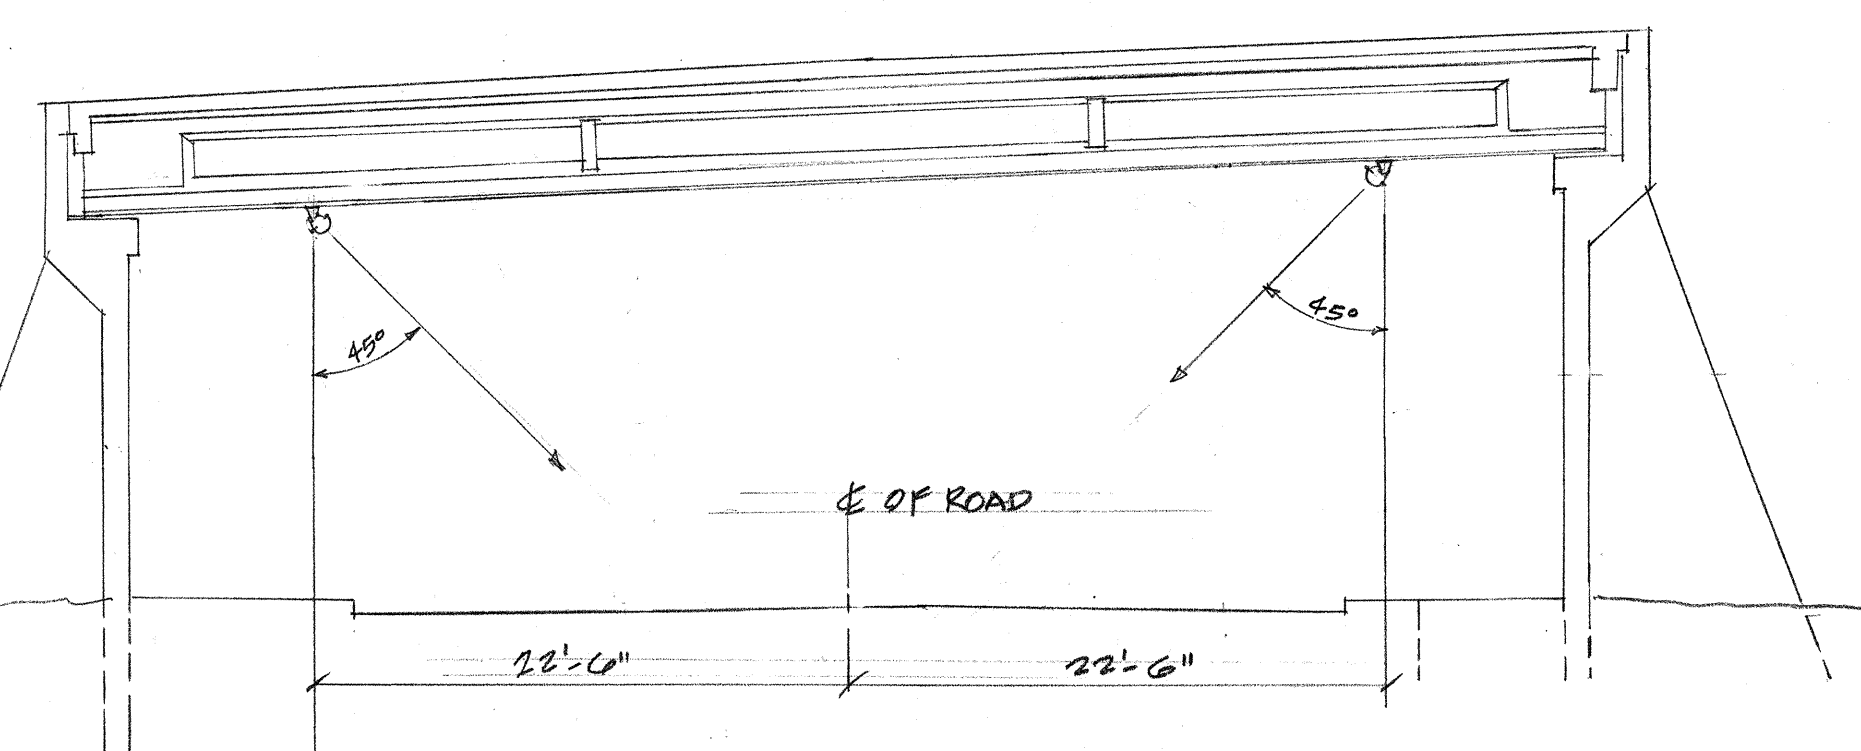

LONGITUDINAL SECTION
SCALE: 1/8" = 1'-0"

FIXTURE DETAIL
NOT TO SCALE

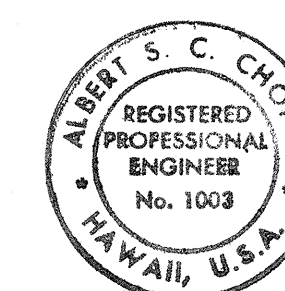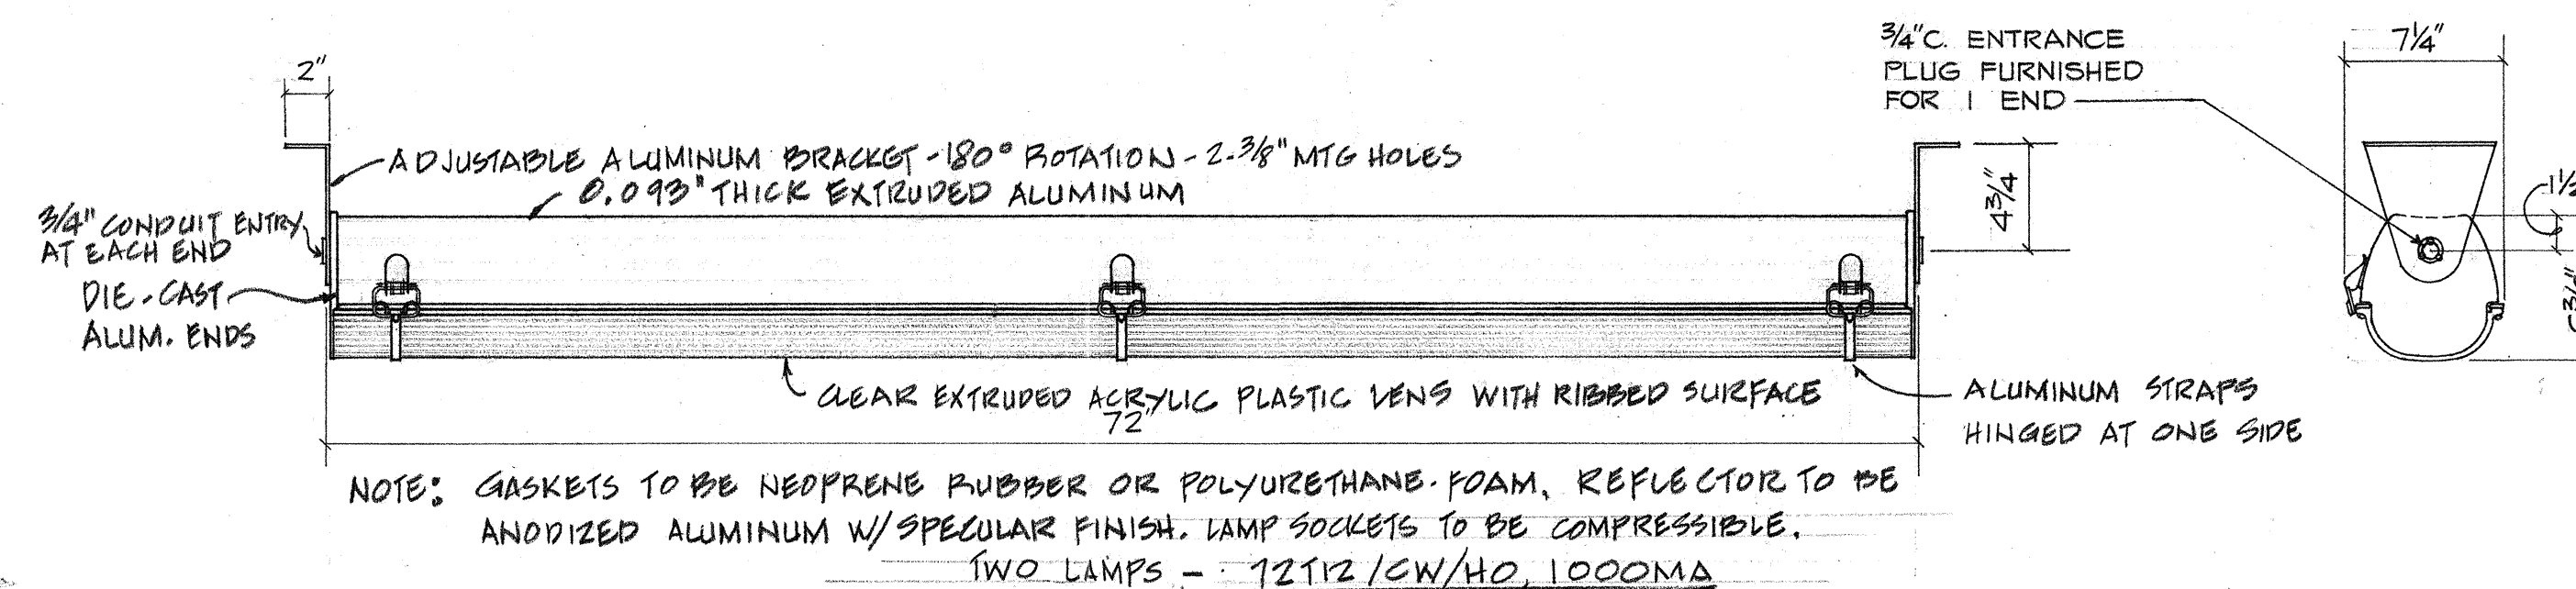

STATE OF HAWAII
DEPARTMENT OF TRANSPORTATION
HIGHWAYS DIVISION

HIGHWAY LIGHTING SYSTEM
PALI HIGHWAY
PAUOA ROAD TO WYLLIE RAMP
PROJECT NO. G1B-02-68

UNDERPASS LIGHTING PLAN & DETAILS