


FED. ROAD DIST. NO.	STATE	FED. AID PROJ. NO.	FISCAL YEAR	SHEET NO.	TOTAL SHEETS
HAWAII	HAW.	61D-01-85	1988	7	29

NOTES: (ADDITIONAL)


10 REMOVE EXST. BKR. PROVIDE 3P50A BKR.

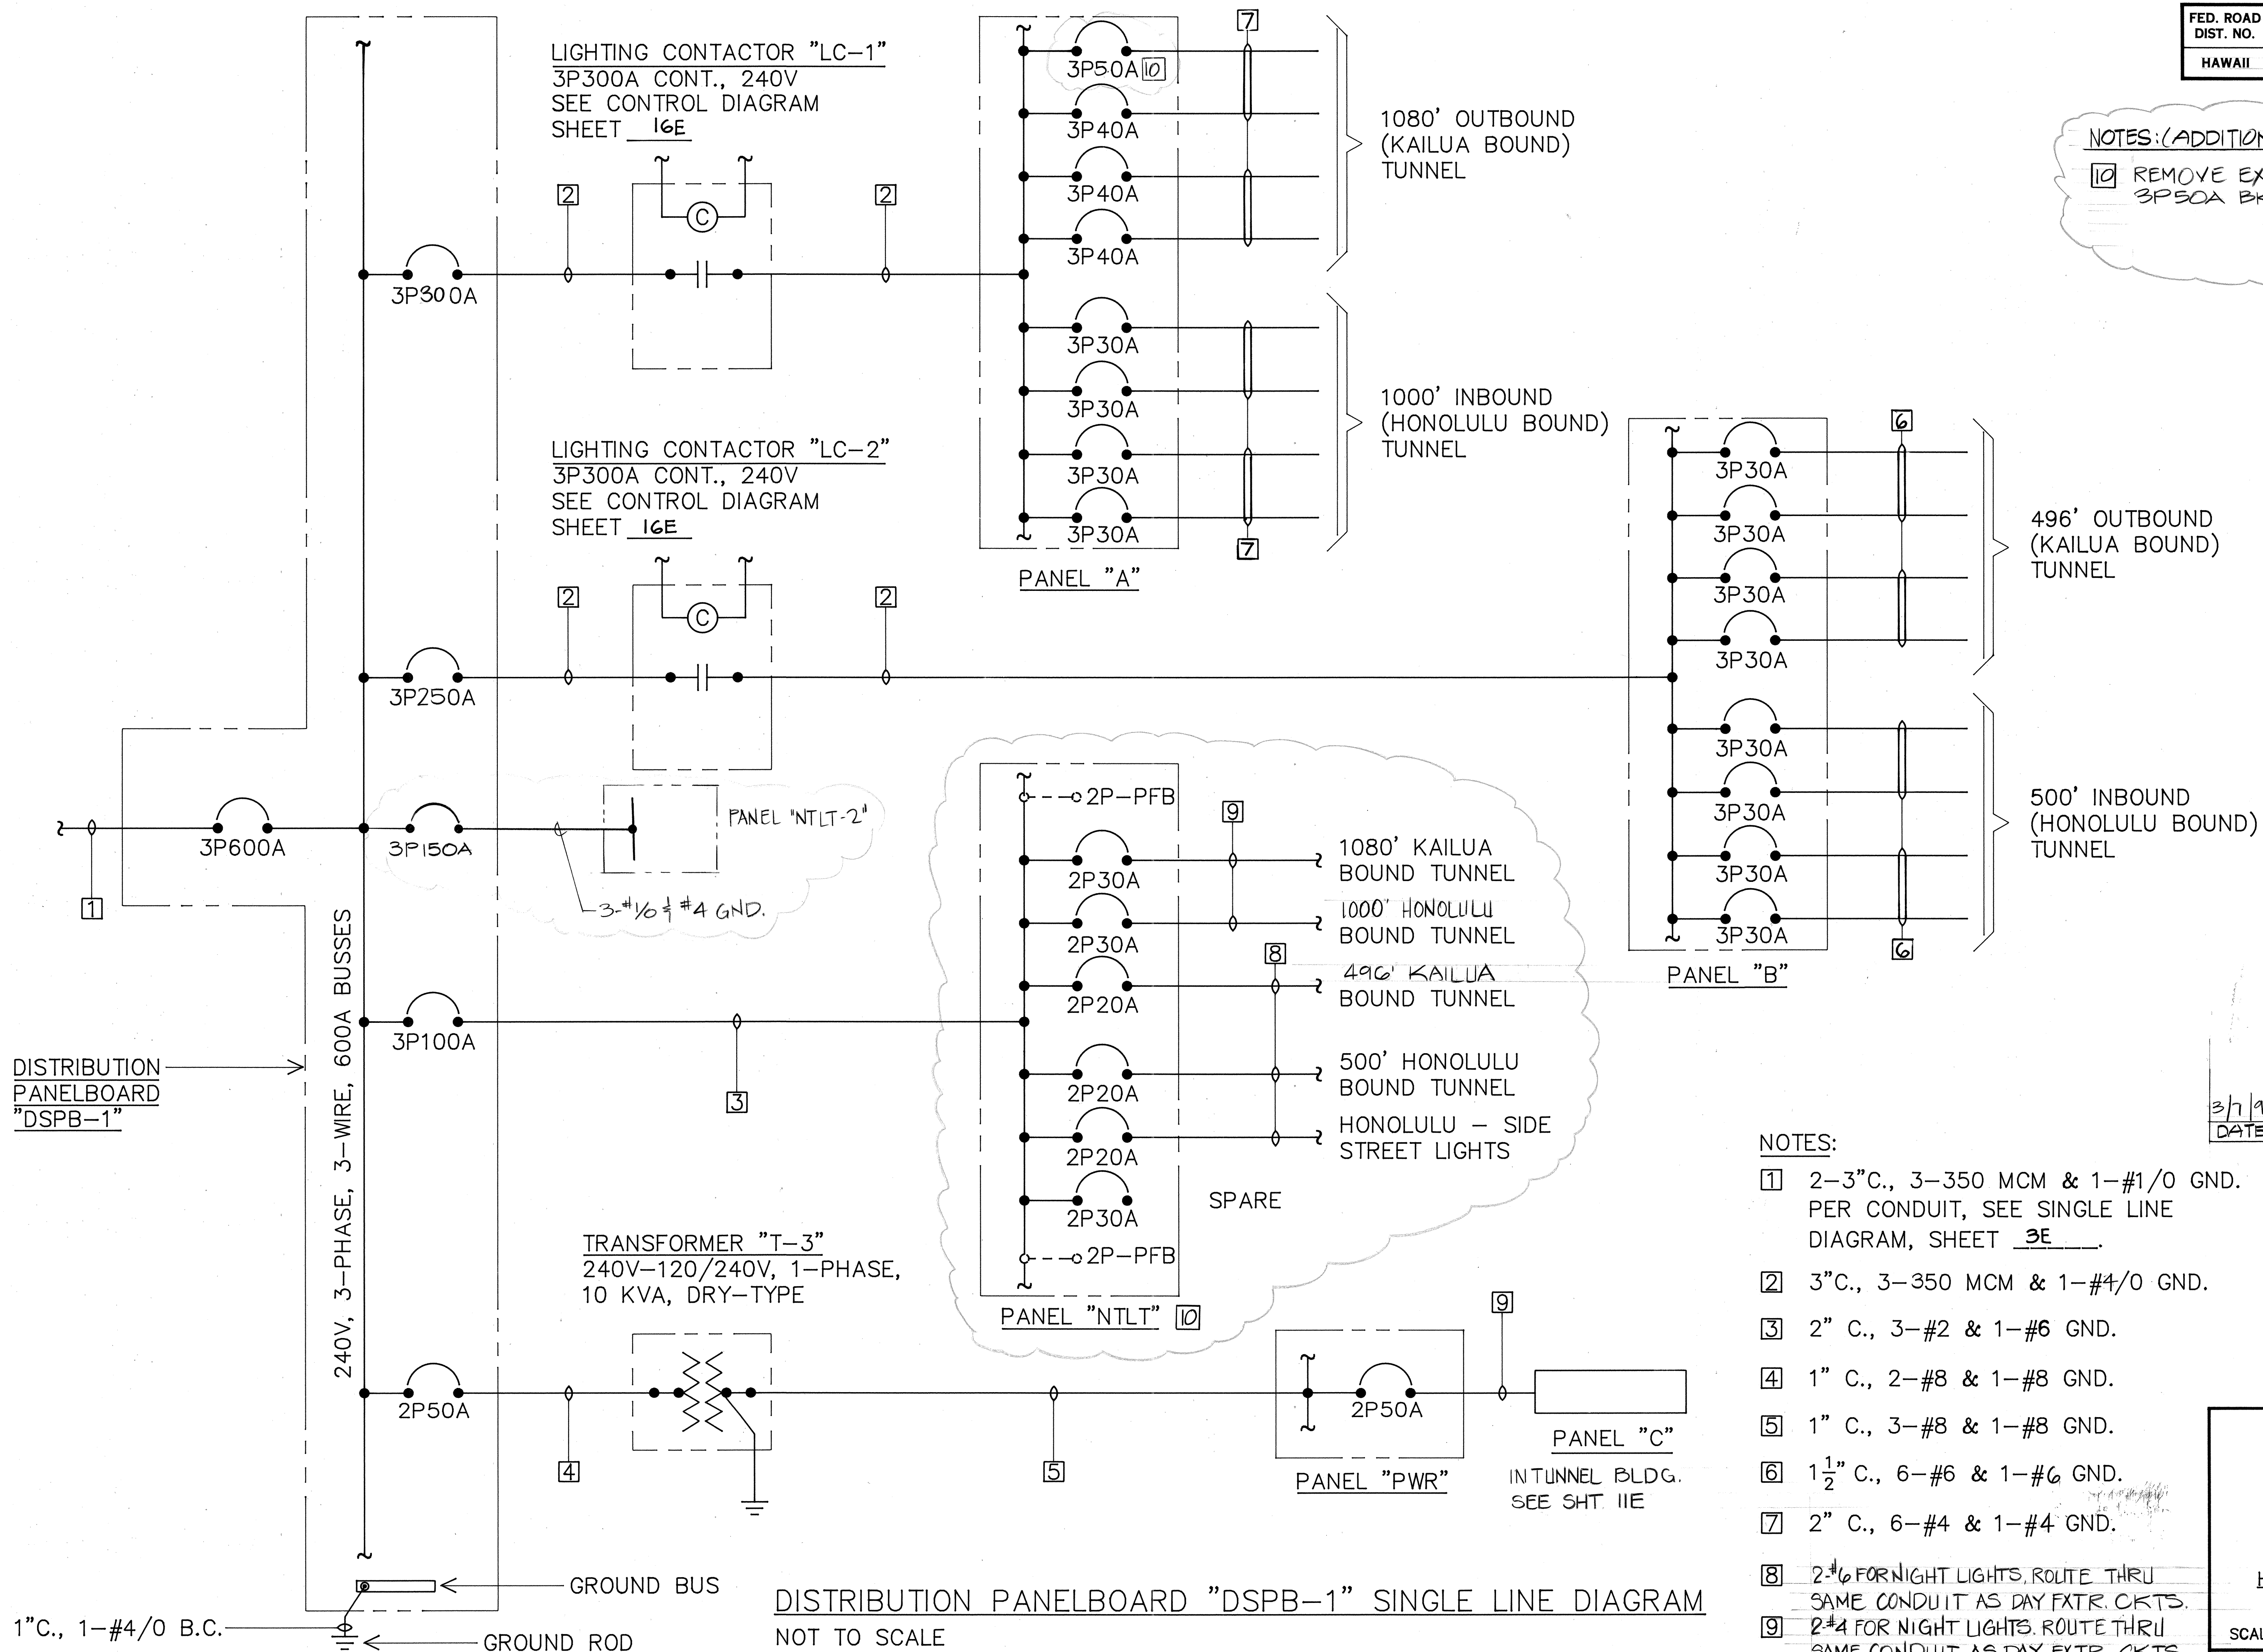

NOTES:

- 2-3"C., 3-350 MCM & 1-#1/0 GND. PER CONDUIT, SEE SINGLE LINE DIAGRAM, SHEET 3E.
- 3"C., 3-350 MCM & 1-#4/0 GND.
- 2" C., 3-#2 & 1-#6 GND.
- 1" C., 2-#8 & 1-#8 GND.
- 1" C., 3-#8 & 1-#8 GND.
- 1 1/2" C., 6-#6 & 1-#6 GND.
- 2" C., 6-#4 & 1-#4 GND.
- 2-#6 FOR NIGHT LIGHTS, ROUTE THRU SAME CONDUIT AS DAY FXTR. CKTS.
- 2-#4 FOR NIGHT LIGHTS, ROUTE THRU SAME CONDUIT AS DAY FXTR. CKTS.

3/7/91	CHANGED CKT BKR., ADDED BKR. 1 PANEL "NTLT-2"
DATE	REVISION

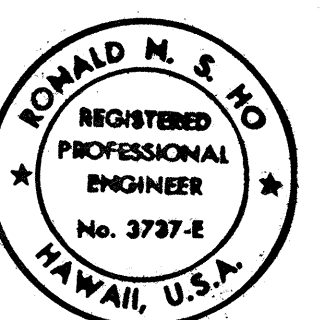

THIS WORK WAS PREPARED BY ME OR UNDER MY SUPERVISION.
12/20/87

STATE OF HAWAII DEPARTMENT OF TRANSPORTATION HIGHWAYS DIVISION DISTRIBUTION PANELBOARD "DSPB-1" DIAGRAM PALI HIGHWAY TUNNELS HIGHWAY LIGHTING IMPROVEMENTS PROJECT NO. 61D-01-85 SCALE: NONE DATE: JUL., 1987 SHEET No. 4E OF 29 SHEETS

DISTRIBUTION PANELBOARD "DSPB-1" SINGLE LINE DIAGRAM
NOT TO SCALE