



FED. ROAD DIST. NO.	STATE	FED. AID PROJ. NO.	FISCAL YEAR	SHEET NO.	TOTAL SHEETS
HAWAII	HAW.	61D-01-85	1988	8	29

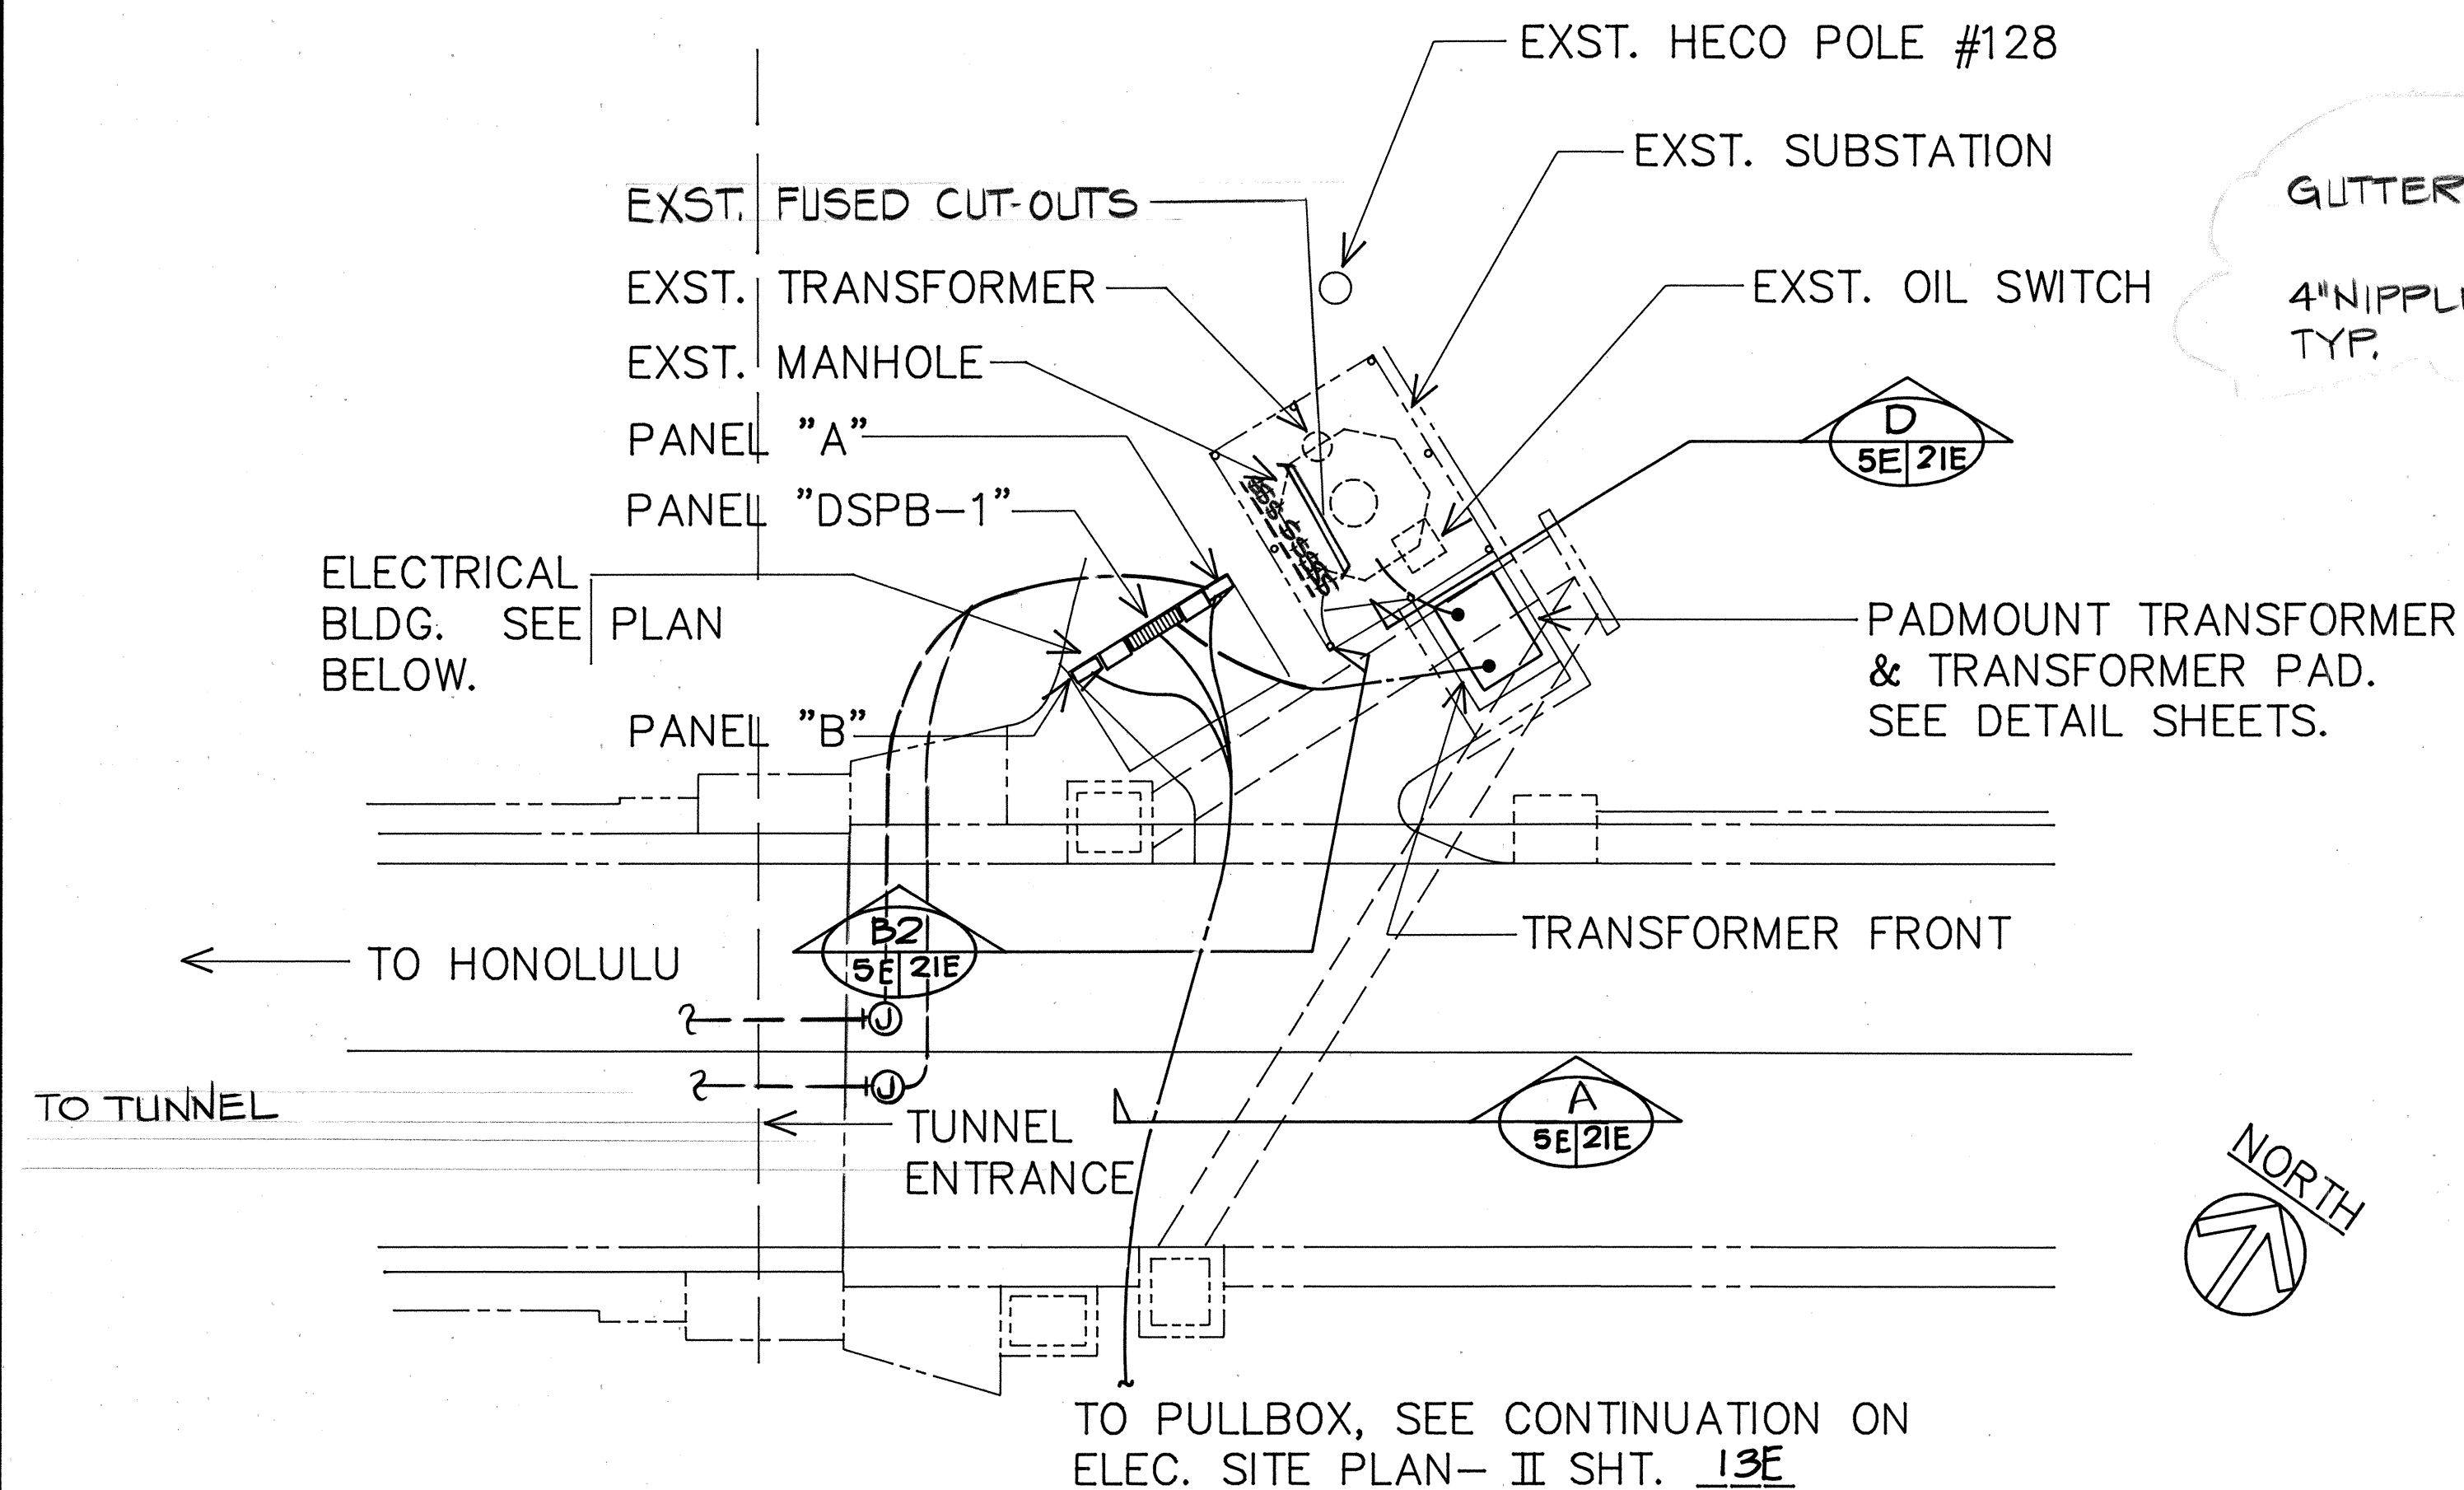

NOTE: SEE ELECTRICAL SITE PLAN SHEET 4.


ELECTRICAL BLDG. SITE PLAN

SCALE: 1" = 10'-0"

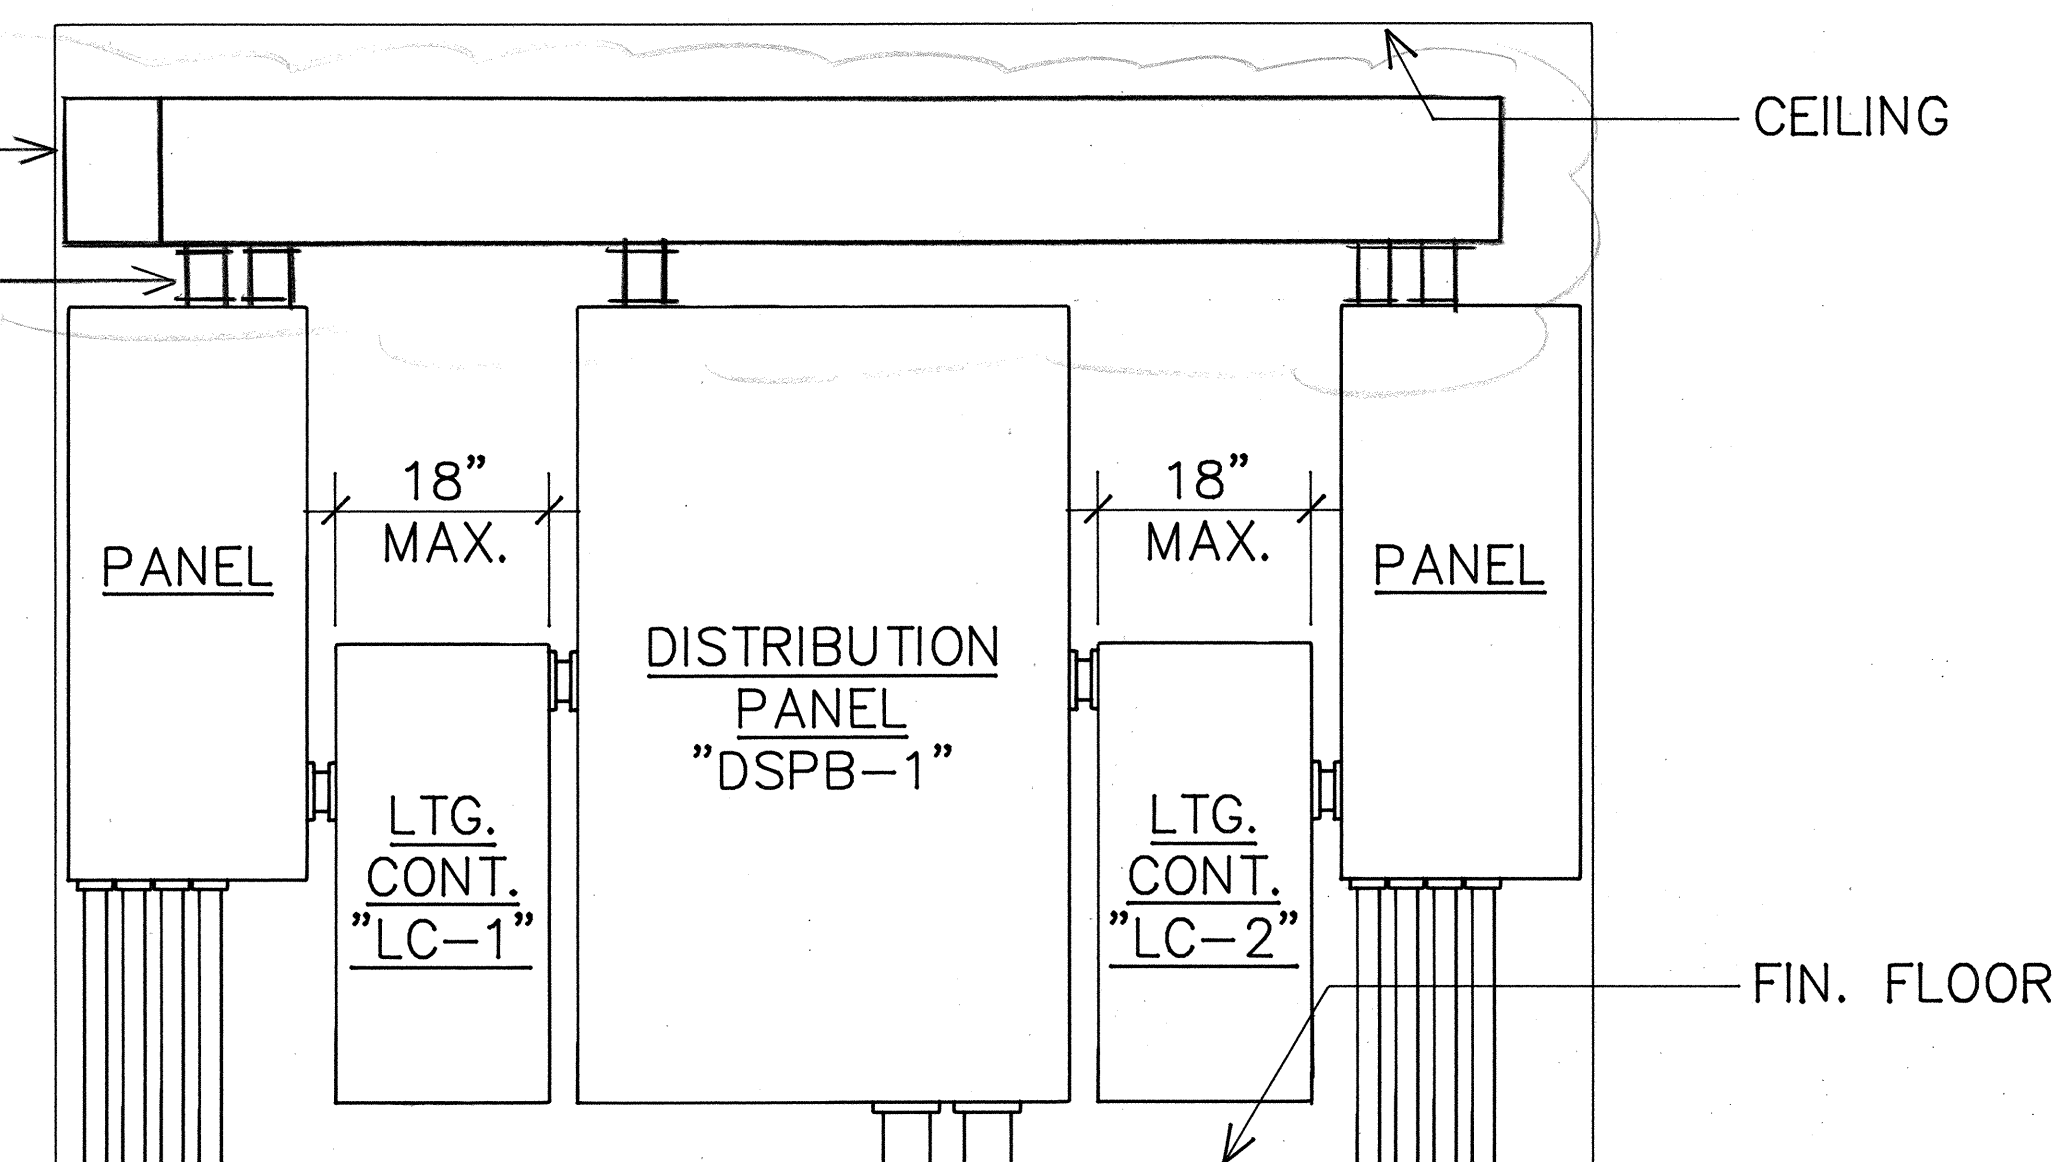


ELEC. BLDG. WEST ELEVATION

SCALE: $3/4" = 1'-0"$

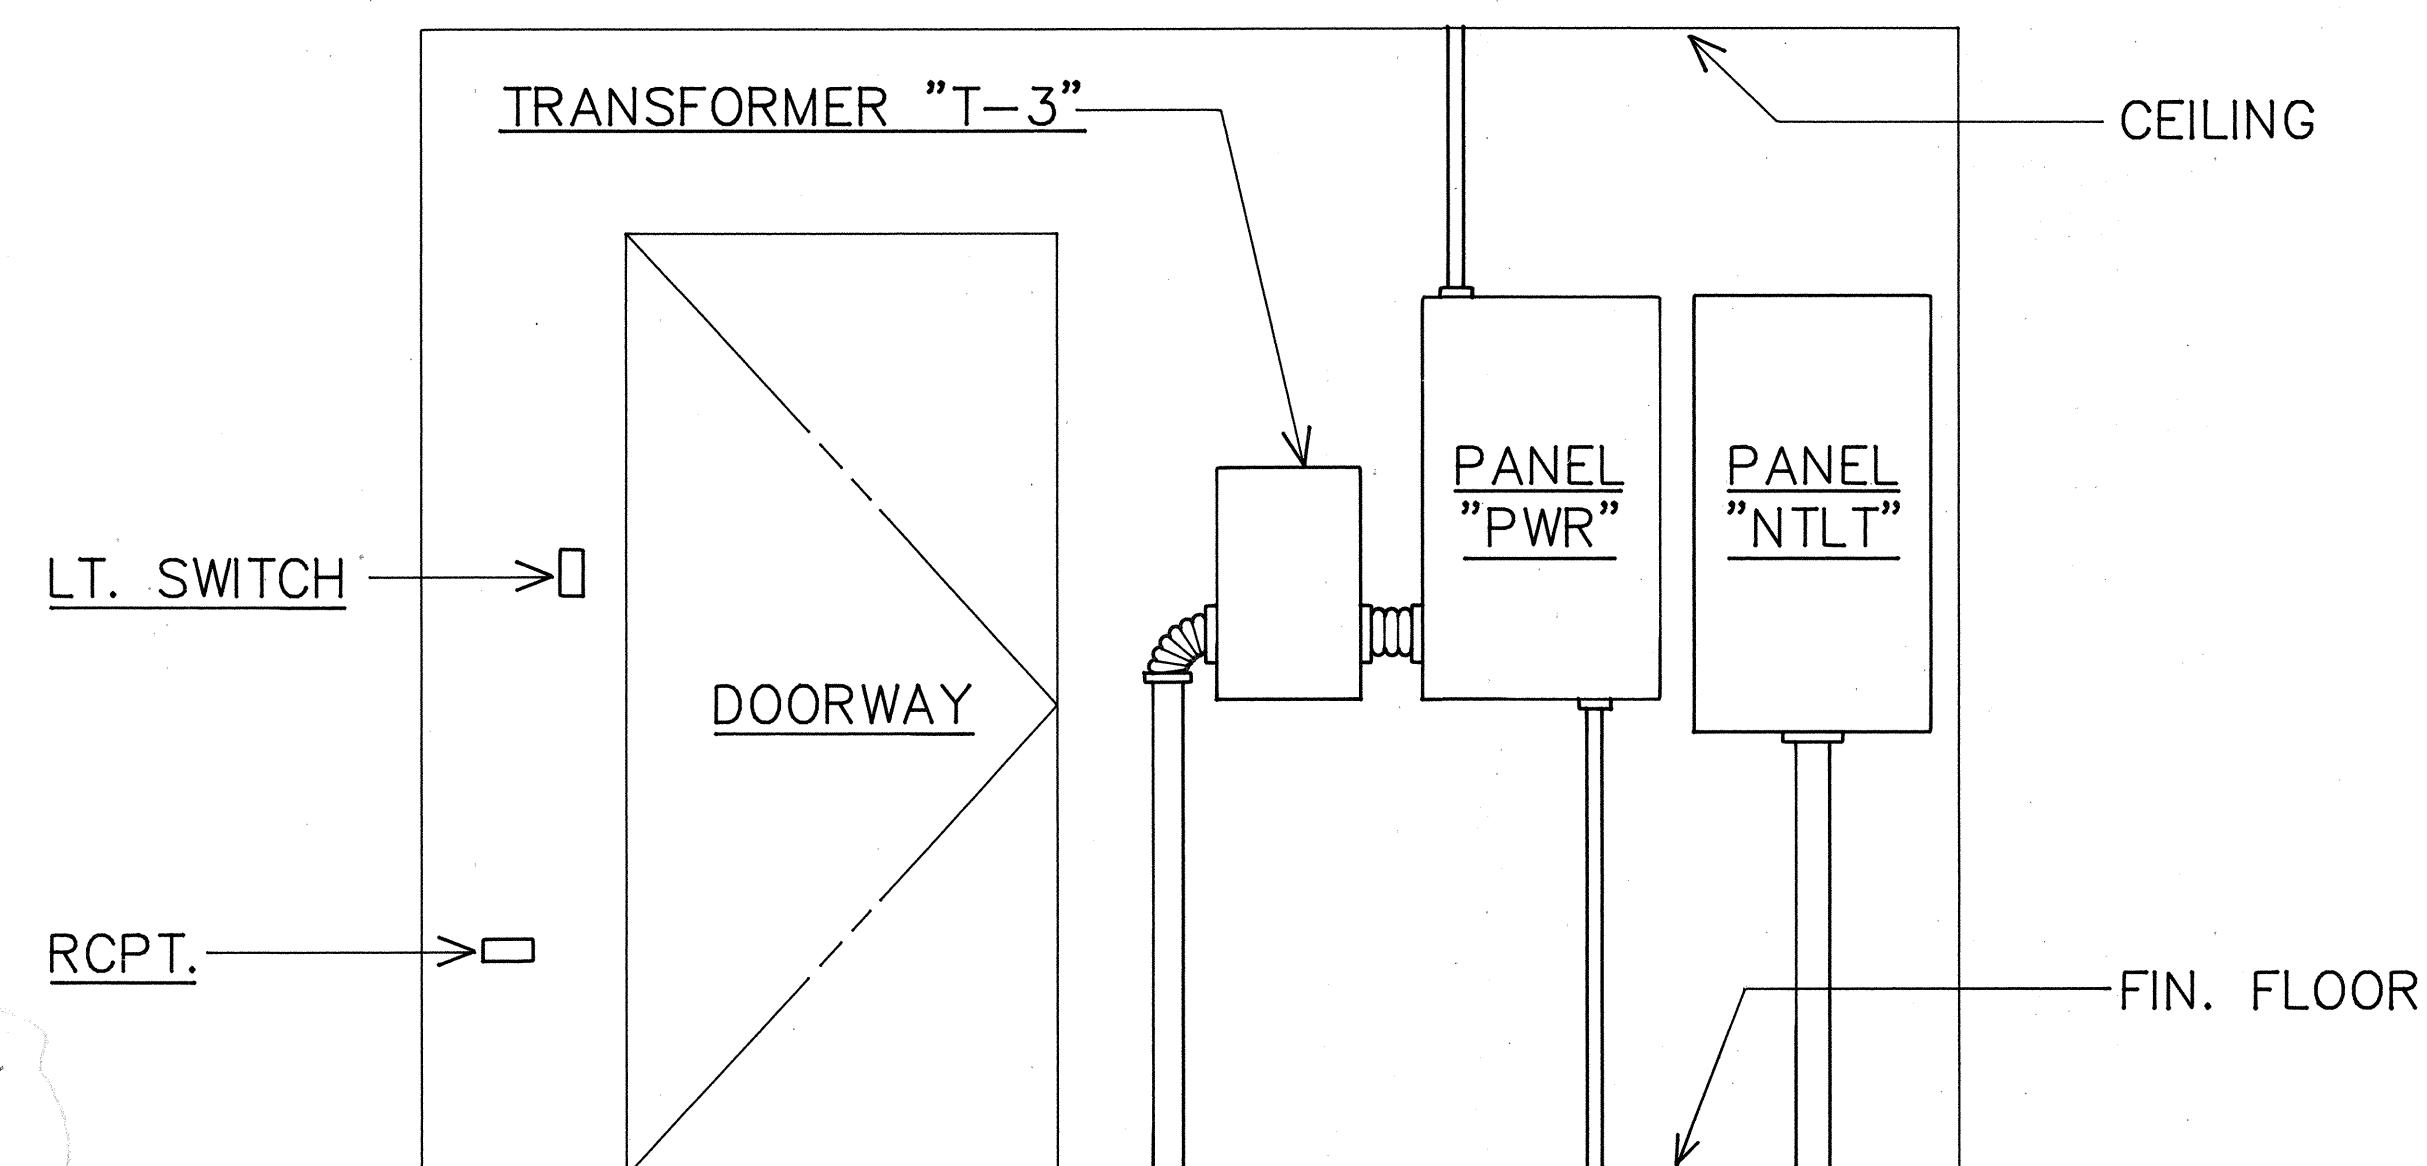

ELEC. BLDG. EAST ELEVATION

SCALE: $3/4" = 1'-0"$

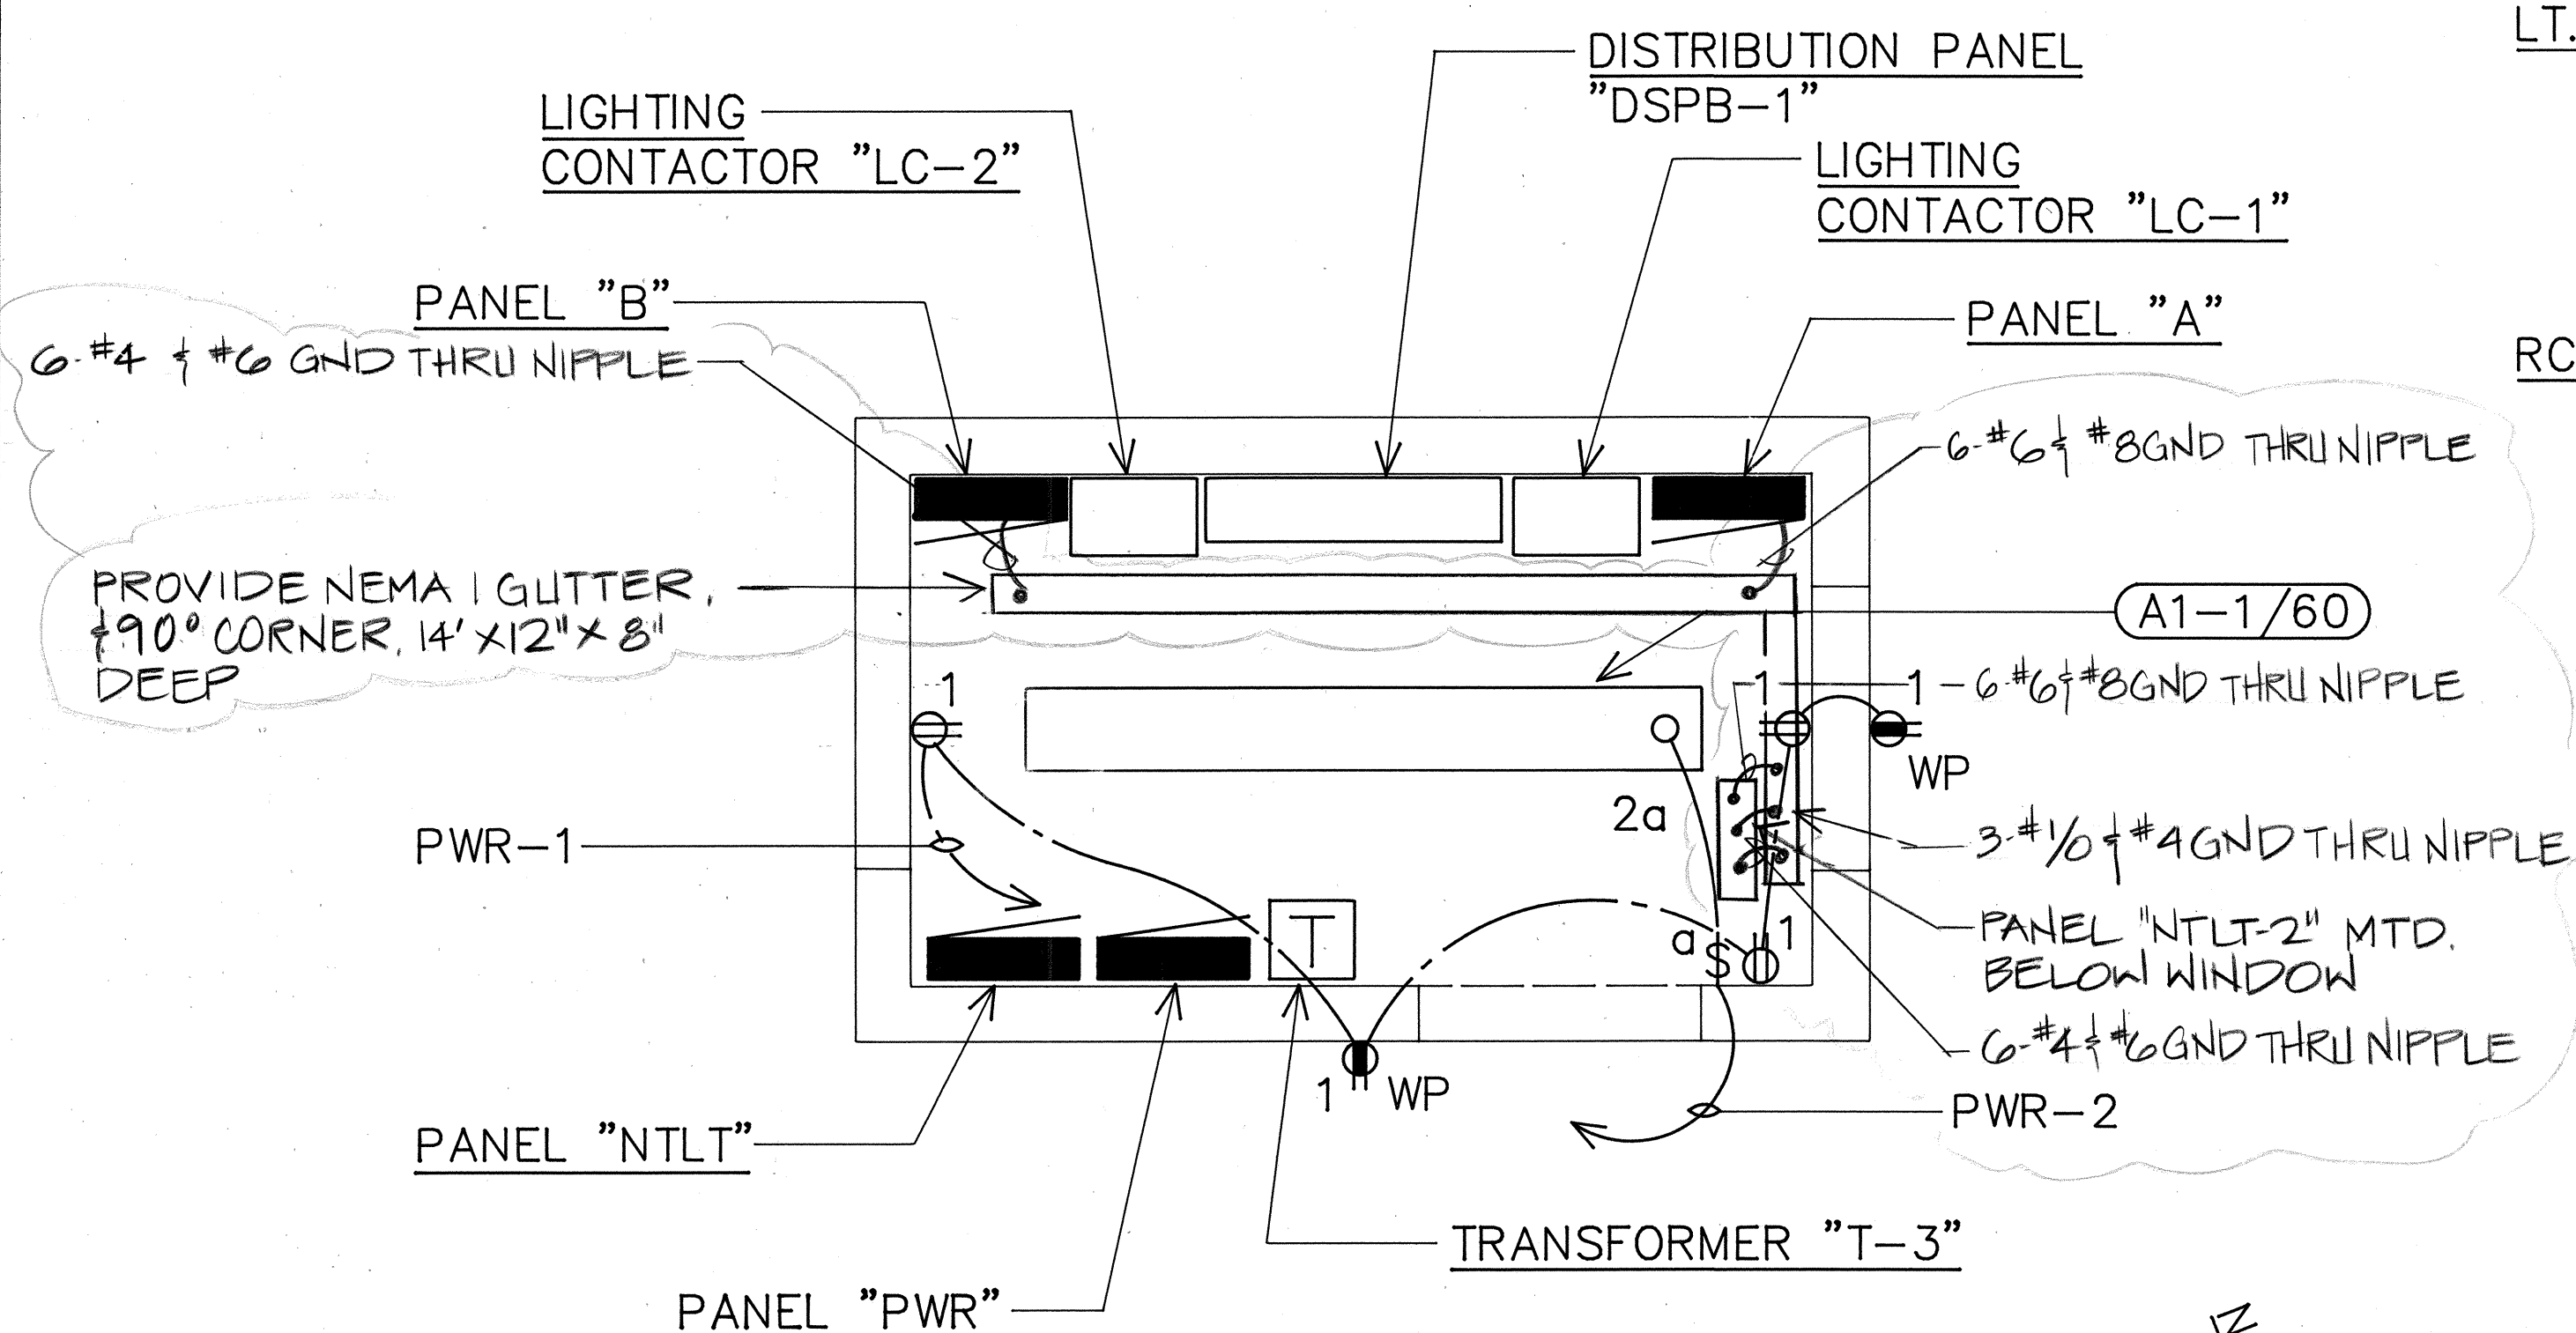


ELECTRICAL BLDG. PLAN

SCALE: 1/2" = 1'-0"

12" 0 1' 2' 3' 4' 5' 6' 7'

SCALE: $\frac{1}{2}" = 1' - 0"$

GRAPHIC SCALES

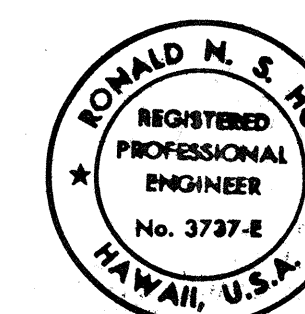

THIS WORK WAS PREPARED BY ME
OR UNDER MY SUPERVISION,
Ronald N. [Signature]
12/26/87

STATE OF HAWAII
DEPARTMENT OF TRANSPORTATION
HIGHWAYS DIVISION

ELECTRICAL BLDG. PLANS, ELEVATIONS

PALI HIGHWAY TUNNELS
HIGHWAY LIGHTING IMPROVEMENTS
PROJECT NO. 61D-01-85

SCALE: AS NOTED DATE: JUL., 1987

SHEET No.5E OF 29 SHEETS

C.O.8

3/7/91	ADDED PANEL "NT LT-2", GUTTER
DATE	REVISION