


FED. ROAD DIST. NO.	STATE	FED. AID PROJ. NO.	FISCAL YEAR	SHEET NO.	TOTAL SHEETS
HAWAII	HAW.	61D-01-85	1988	14	29

1000' INBOUND
(HONOLULU BOUND)
TUNNEL EXIT

1080' OUTBOUND
(KAILUA BOUND)
TUNNEL ENTRANCE

CUT CONDUIT ENTERING
CONC. SLAB OR ROOF,
TAGE WIRES AND CAP
CONDUIT. REMOVE WIRING
FROM EXPOSED CONDUIT
& ENCLOSURES.

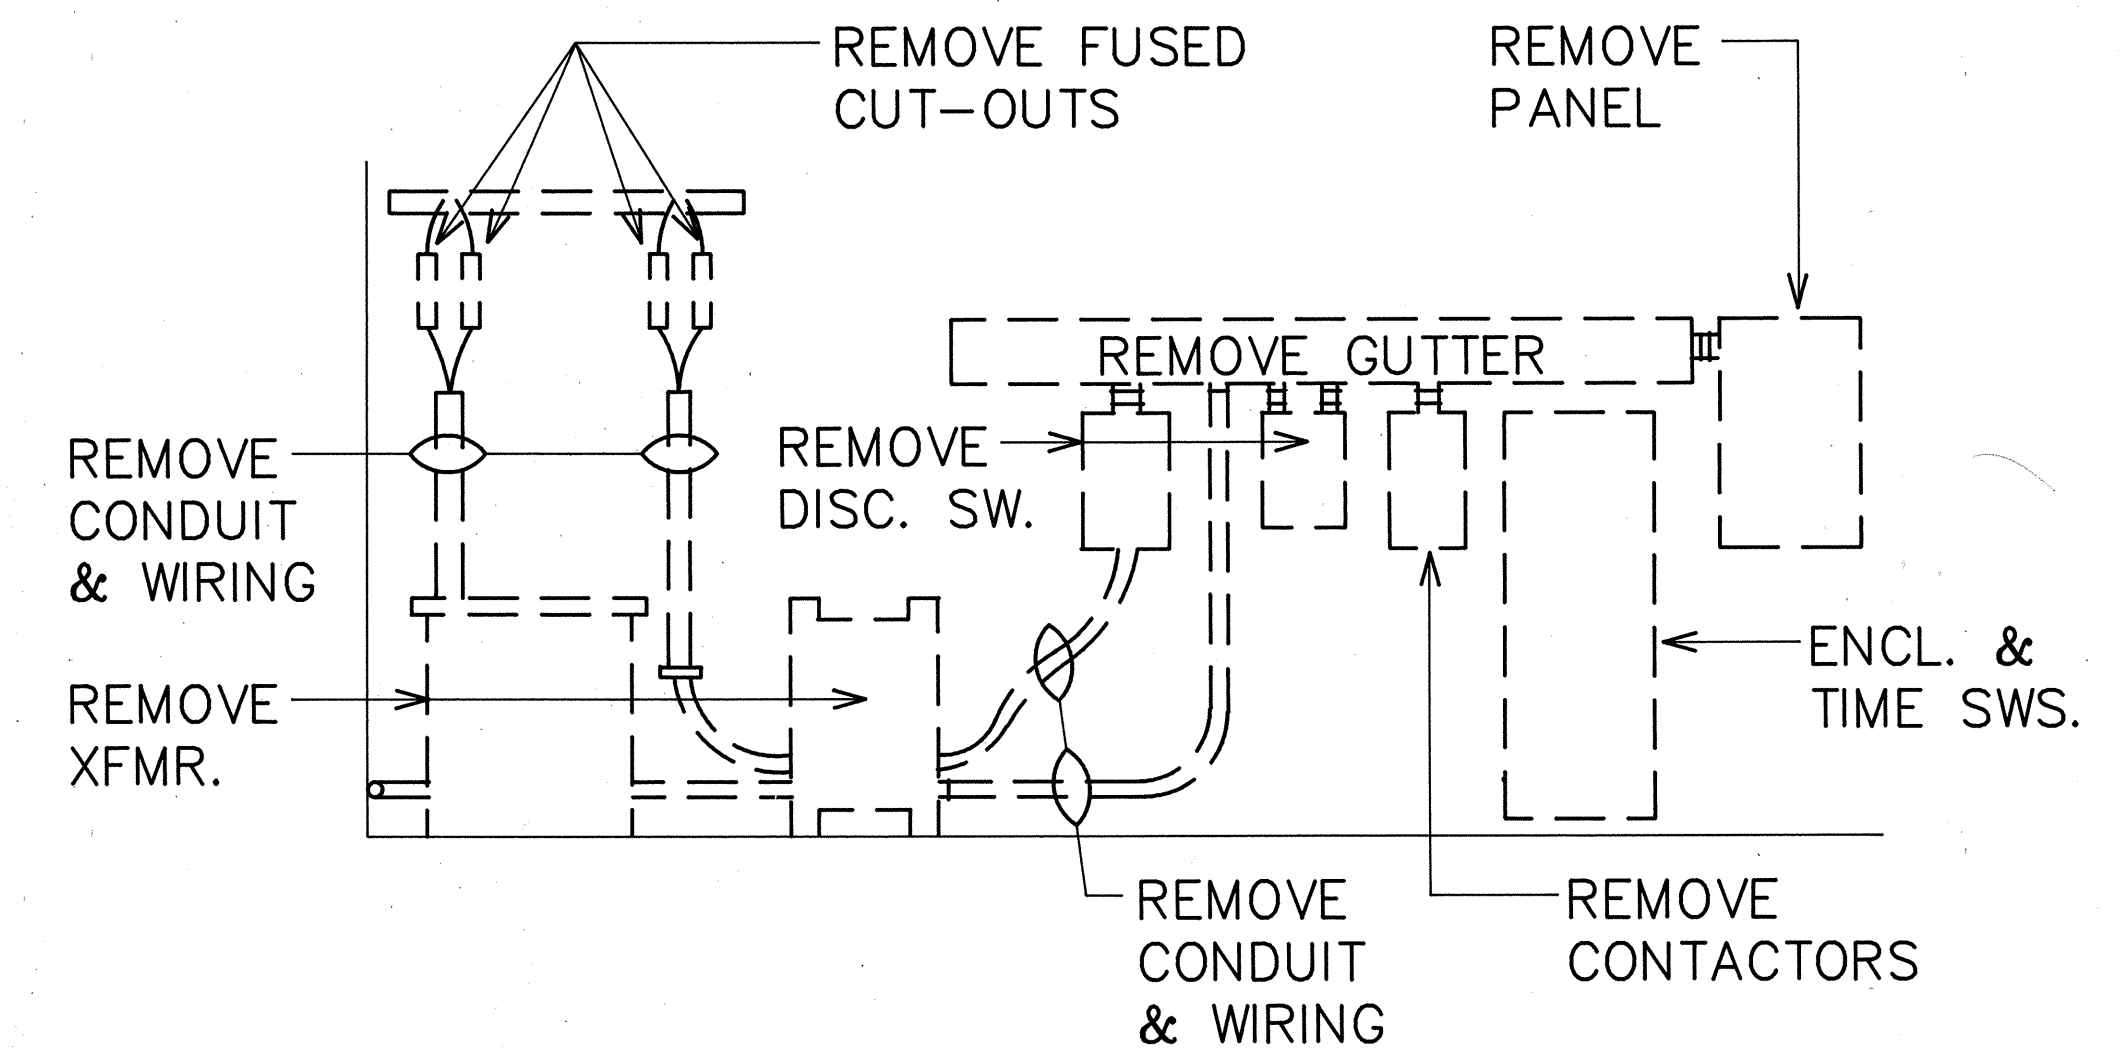

A TUNNEL BLDG. EAST ELEVATION
NOT TO SCALE

1000' INBOUND
(HONOLULU BOUND)
TUNNEL EXIT


1080' OUTBOUND
(KAILUA BOUND)
TUNNEL ENTRANCE

SECOND FLOOR

TUNNEL BLDG. ELEC. DEMOLITION PLAN

SCALE: 1/4" = 1'-0"

PENETRATE WALL
FOR CONDUIT, PATCH
TO MATCH EXST.

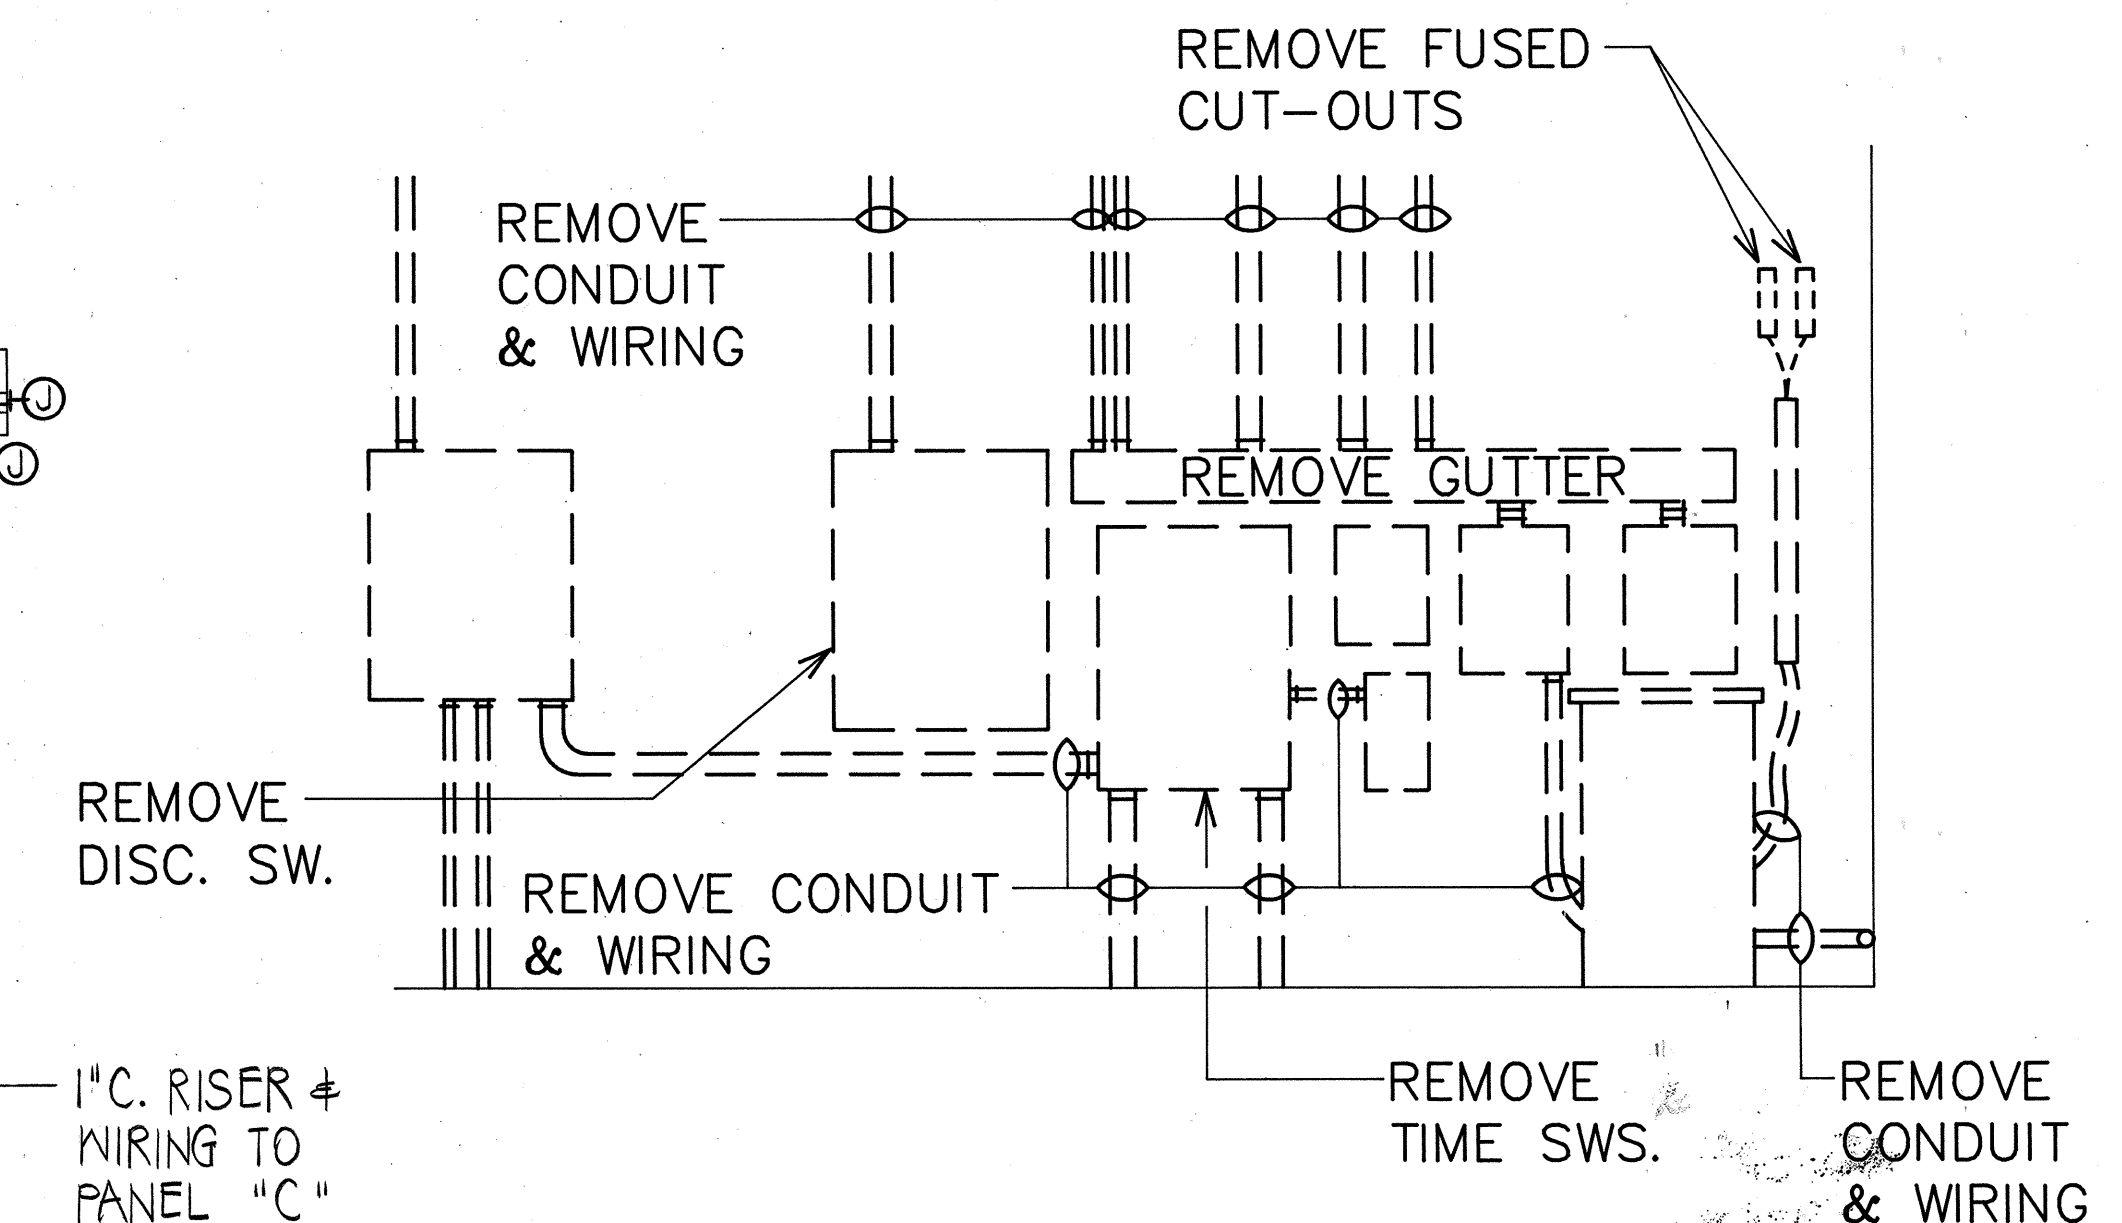

B TUNNEL BLDG. NORTH ELEVATION
NOT TO SCALE

UP TO SECOND
FLOOR

1/2" RISER &
WIRING TO
SECOND FLOOR

FROM GND. FLOOR
3-WAY SWITCH

SECOND FLOOR


TUNNEL BLDG. REVISED ELECTRICAL PLAN

SCALE: 1/4" = 1'-0"

4' 2' 0' 4' 8' 12'

SCALE: 1/4" = 1'-0"

GRAPHIC SCALE

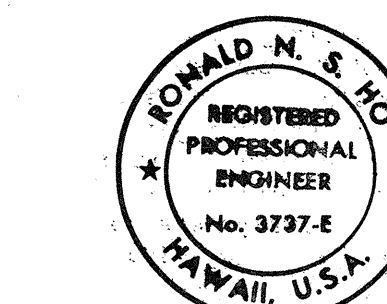

THIS WORK WAS PREPARED BY ME
OR UNDER MY SUPERVISION.
Ronald N. S. Ho
1/23/87

STATE OF HAWAII
DEPARTMENT OF TRANSPORTATION
HIGHWAYS DIVISION
TUNNEL BLDG. ELEC. DEMO.
& REVISED ELEC. PLANS
& NORTH & EAST ELEVATIONS
PALI HIGHWAY TUNNELS
HIGHWAY LIGHTING IMPROVEMENTS
PROJECT NO. 61D-01-85
SCALE: AS SHOWN DATE: APR., 1987
SHEET No. IIE OF 29 SHEETS