

FED. ROAD DIST. NO.	STATE	PROJ. NO.	FISCAL YEAR	SHEET NO.	TOTAL SHEETS
HAWAII	HAW.	HWY-0-10-98	1999	4	13

1	0+65
2	1
3	5'
4	8'
5	TB
6	27.5'

1	2+15
2	2
3	5'
4	8'
5	TB
6	27.5'

1	3+48
2	3
3	3.5'
4	8'
5	TB
6	27.5'

1	4+94
2	4
3	3.5'
4	8'
5	TB
6	27.5'

1	6+37
2	5
3	3.5'
4	8'
5	TB
6	27.5'

CG20-2A
(48" X 24")

END
ROAD WORK

Install with Posts

Begin Project
Project No. HWY-0-10-98
Sta 0+65

PALI HIGHWAY

ROAD
WORK
AHEAD

CW20-1Ad
(48" X 48")

Install with Posts

Electrical Service Equipment
See plan 1/5


Existing HECO
Transformer Vault
No. 452

MATCH LINE "A" STA 6+75
SEE CONT. SHT. 5

NOTES

- 1 Ductline to cross over existing water/sewage/drainage line.
- 2 2'x4' Elec handhole per HECO standard drawing no. 30-2005/0011249.
- 3 Remove existing lighting circuit cables and abandon underground duct. This work shall be incidental to the removal of street lighting standards of Note 5.
- 4 Remove existing pullbox, backfill to match existing grade, and regrass.
- 5 Remove street lighting standard and demolish concrete foundation per spec Section 622.
- 6 Coordinate with HECO for the duct connection to the transformer vault enclosure.
- 7 Provide 3 #4 secondary service cables. Coordinate with HECO for the cable installation inside the transformer vault.
- 8 Disconnect circuit of Note 3 at existing street lighting standard.
- 9 Existing street light circuits from electrical service equipment across Pali Highway.
- 10 Existing circuits to street lights along west side of Pali Highway.

ELECTRICAL PLAN 1
SCALE: 1"=20'

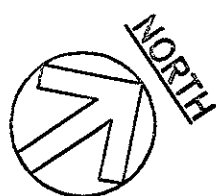

20' 10' 0 20' 40' 60'
SCALE: 1"=20'
GRAPHIC SCALE

STATE OF HAWAII
DEPARTMENT OF TRANSPORTATION
HIGHWAYS DIVISION
ELECTRICAL PLAN 1


WAOKANAKA STREET
INSTALLATION OF HIGHWAY LIGHTS
PROJECT NO. HWY-0-10-98

SCALE: AS NOTED DATE: JAN 1999
SHEET No. 4 OF 13 SHEETS

AS-BUILT

4


FED. ROAD DIST. NO.	STATE	PROJ. NO.	FISCAL YEAR	SHEET NO.	TOTAL SHEETS
HAWAII	HAW.	HWY-0-10-98	1999	6	13

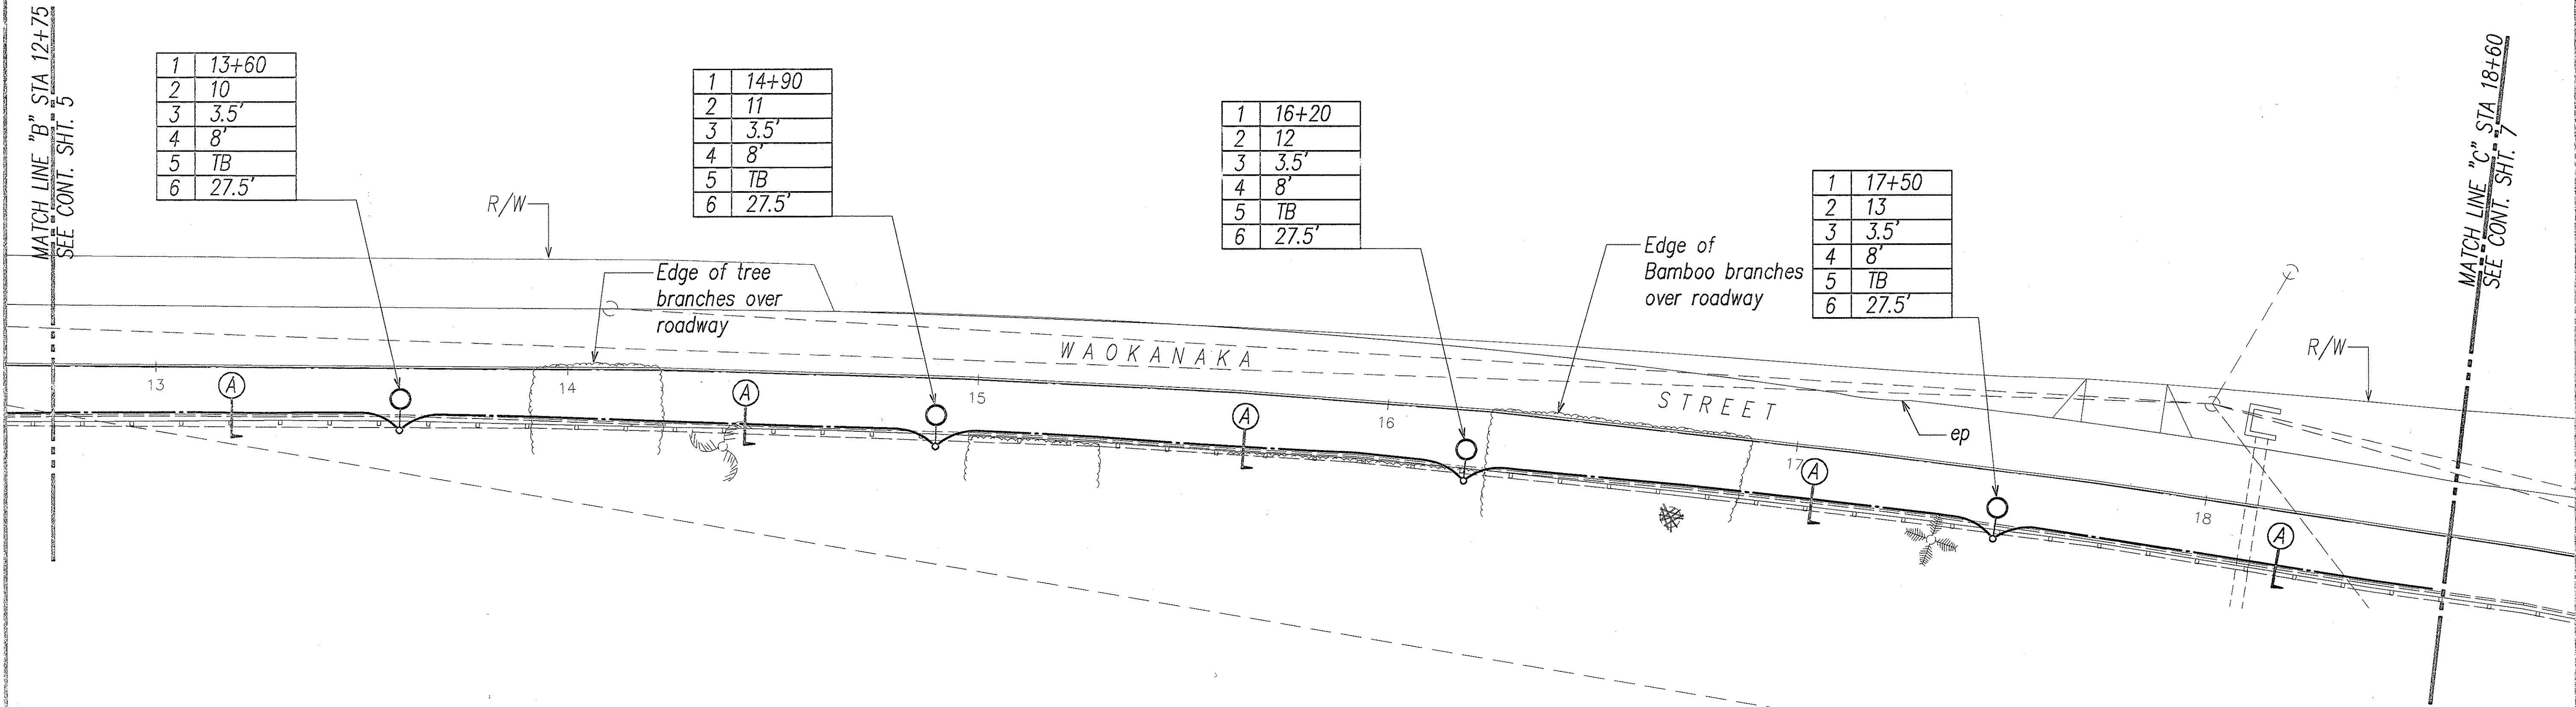

ORIGINAL PLAN	SURVEY PLOTTED BY	DATE
NOTE BOOK	DRAWN BY	
	DESIGNED BY	
	CHECKED BY	
	APPROVED BY	

LAST SAVE: 01/24/99 @ 10:17:17 PM
Z:\ACAD\PROJECTS\0189\0189PLAN3.DWG PLOT: 01/25/99


ELECTRICAL PLAN III
SCALE: 1"=20'

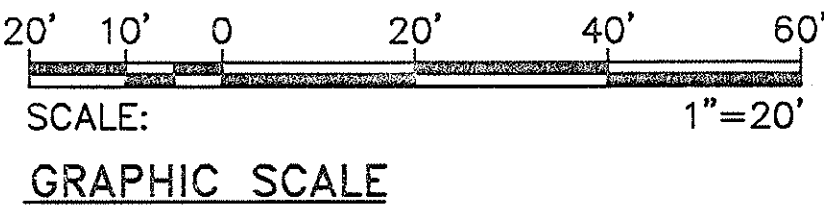

STATE OF HAWAII
DEPARTMENT OF TRANSPORTATION
HIGHWAYS DIVISION
ELECTRICAL PLAN III


WAOKANAKA STREET
INSTALLATION OF HIGHWAY LIGHTS
PROJECT NO. HWY-0-10-98

SCALE: AS NOTED
DATE: JAN 1999
SHEET No. 6 OF 13 SHEETS

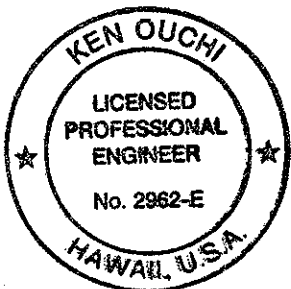

THIS WORK WAS PREPARED BY ME
OR UNDER MY SUPERVISION.
R. Ouchi
RONALD N. S. HO & ASSOC., INC.
ELECTRICAL ENGINEERS

FED. ROAD DIST. NO.	STATE	PROJ. NO.	FISCAL YEAR	SHEET NO.	TOTAL SHEETS
HAWAII	HAW.	HWY-0-10-98	1999	7	13

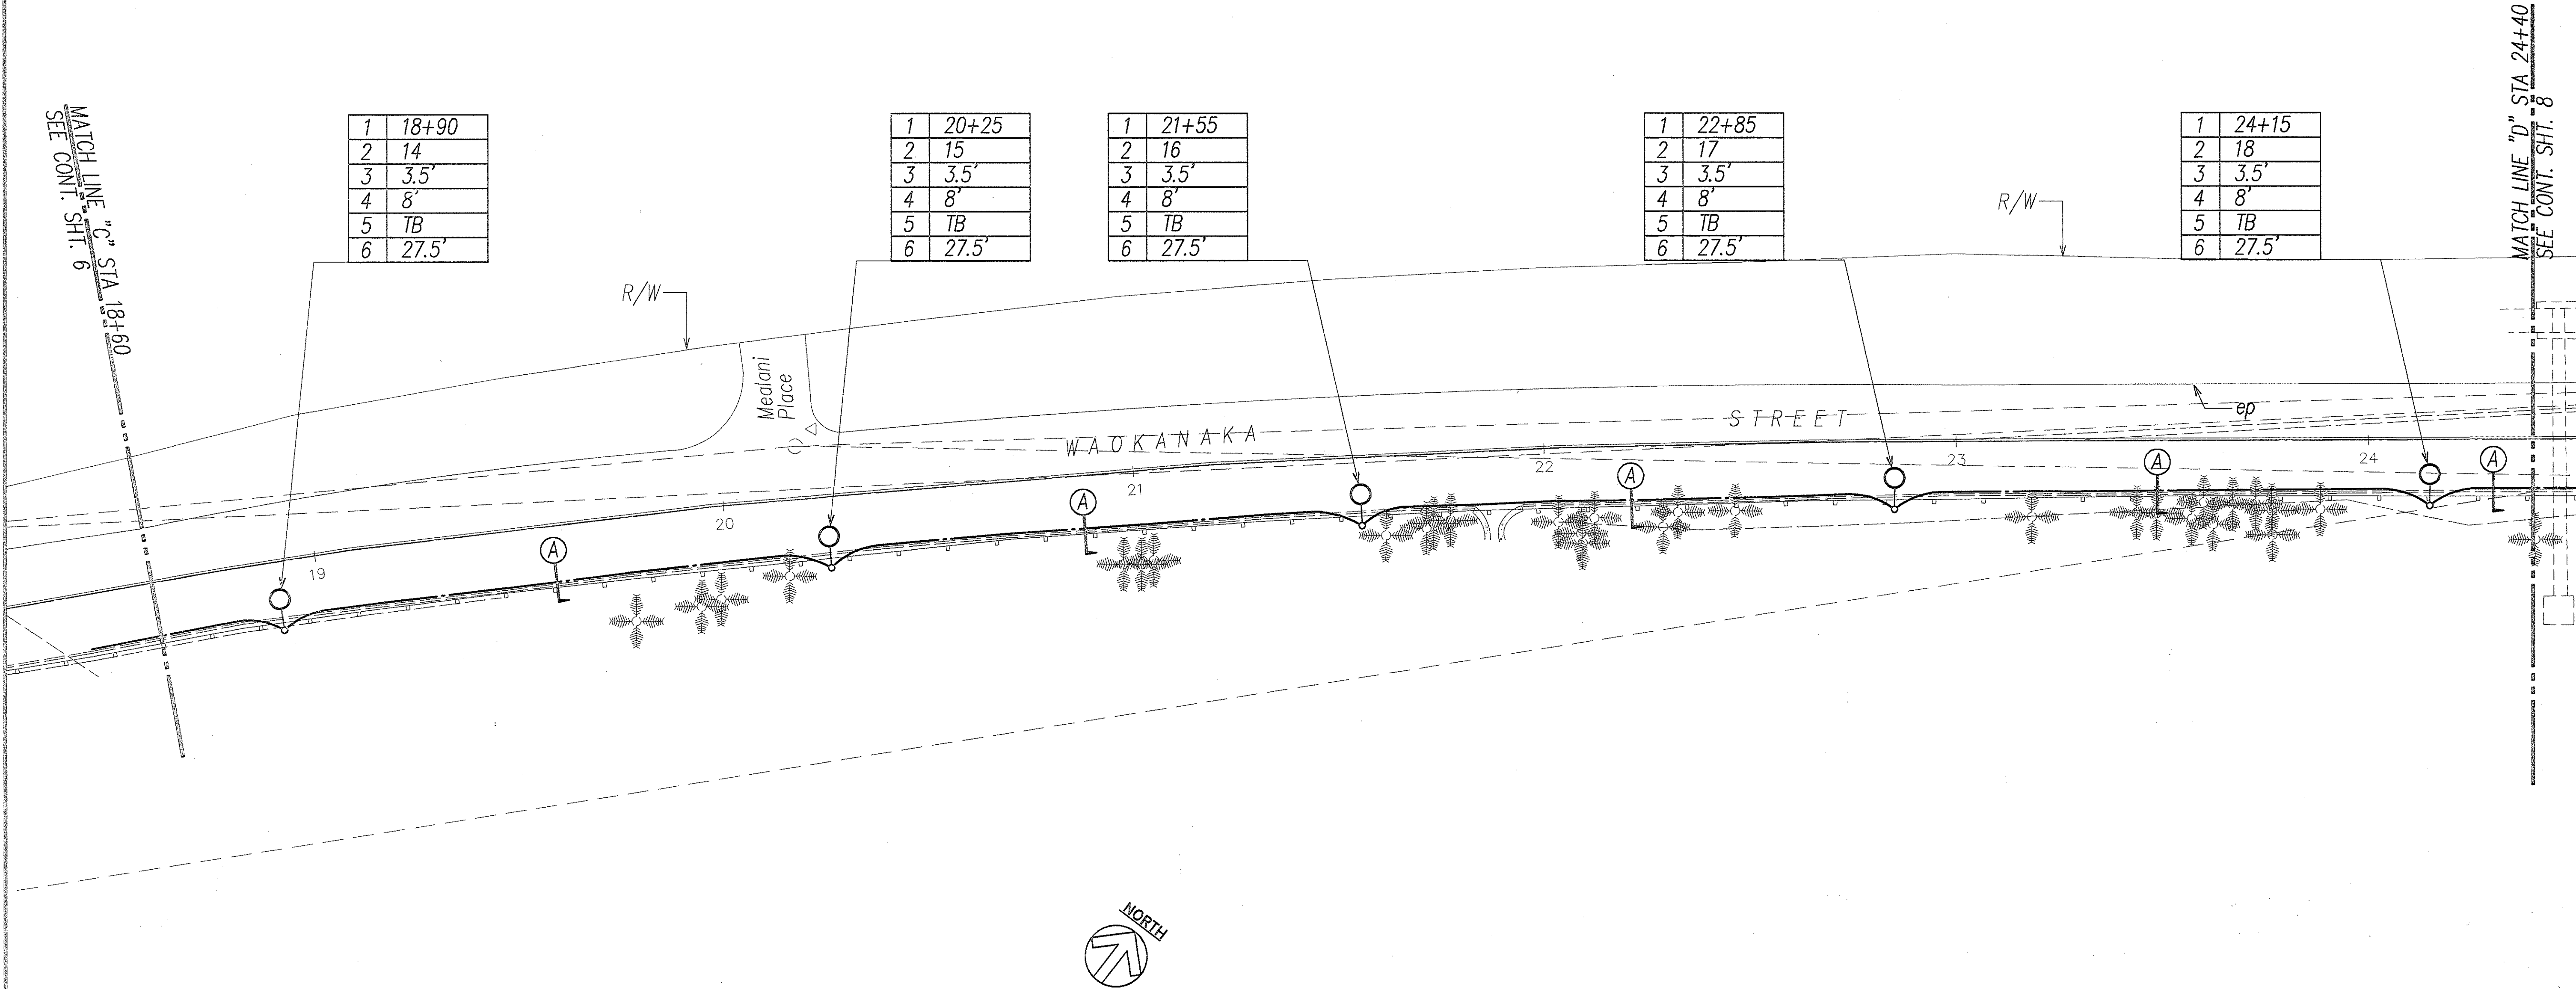

1	18+90
2	14
3	3.5'
4	8'
5	TB
6	27.5'

1	20+25
2	15
3	3.5'
4	8'
5	TB
6	27.5'

1	21+55
2	16
3	3.5'
4	8'
5	TB
6	27.5'


1	22+85
2	17
3	3.5'
4	8'
5	TB
6	27.5'

1	24+15
2	18
3	3.5'
4	8'
5	TB
6	27.5'

ORIGINAL PLAN	SURVEY PLOTTED BY	DATE
NOTE BOOK	DRAWN BY	
	DESIGNED BY	
	CHECKED BY	

LAST SAVE: 01/24/99 10:16:22 AM
Z:\ACAD\PROJECTS\0108\172\PLM\4. SHEET 7 OF 13


ELECTRICAL PLAN IV
SCALE: 1"=20'

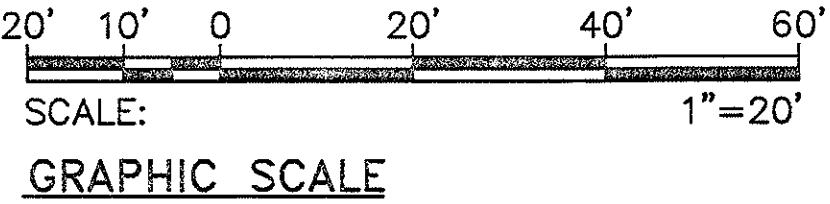

STATE OF HAWAII
DEPARTMENT OF TRANSPORTATION
HIGHWAYS DIVISION
ELECTRICAL PLAN IV


WAOKANAKA STREET
INSTALLATION OF HIGHWAY LIGHTS
PROJECT NO. HWY-0-10-98

SCALE: AS NOTED
DATE: JAN 1999
SHEET No. 7 OF 13 SHEETS

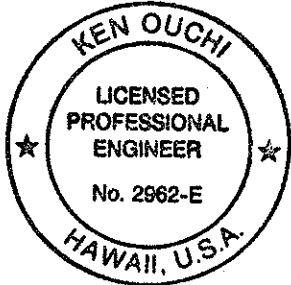


THIS WORK WAS PREPARED BY ME
OR UNDER MY SUPERVISION.
R. Ouchi
RONALD N. S. HO & ASSOC., INC.
ELECTRICAL ENGINEERS

FED. ROAD DIST. NO.	STATE	PROJ. NO.	FISCAL YEAR	SHEET NO.	TOTAL SHEETS
HAWAII	HAW.	HWY-0-10-98	1999	8	13


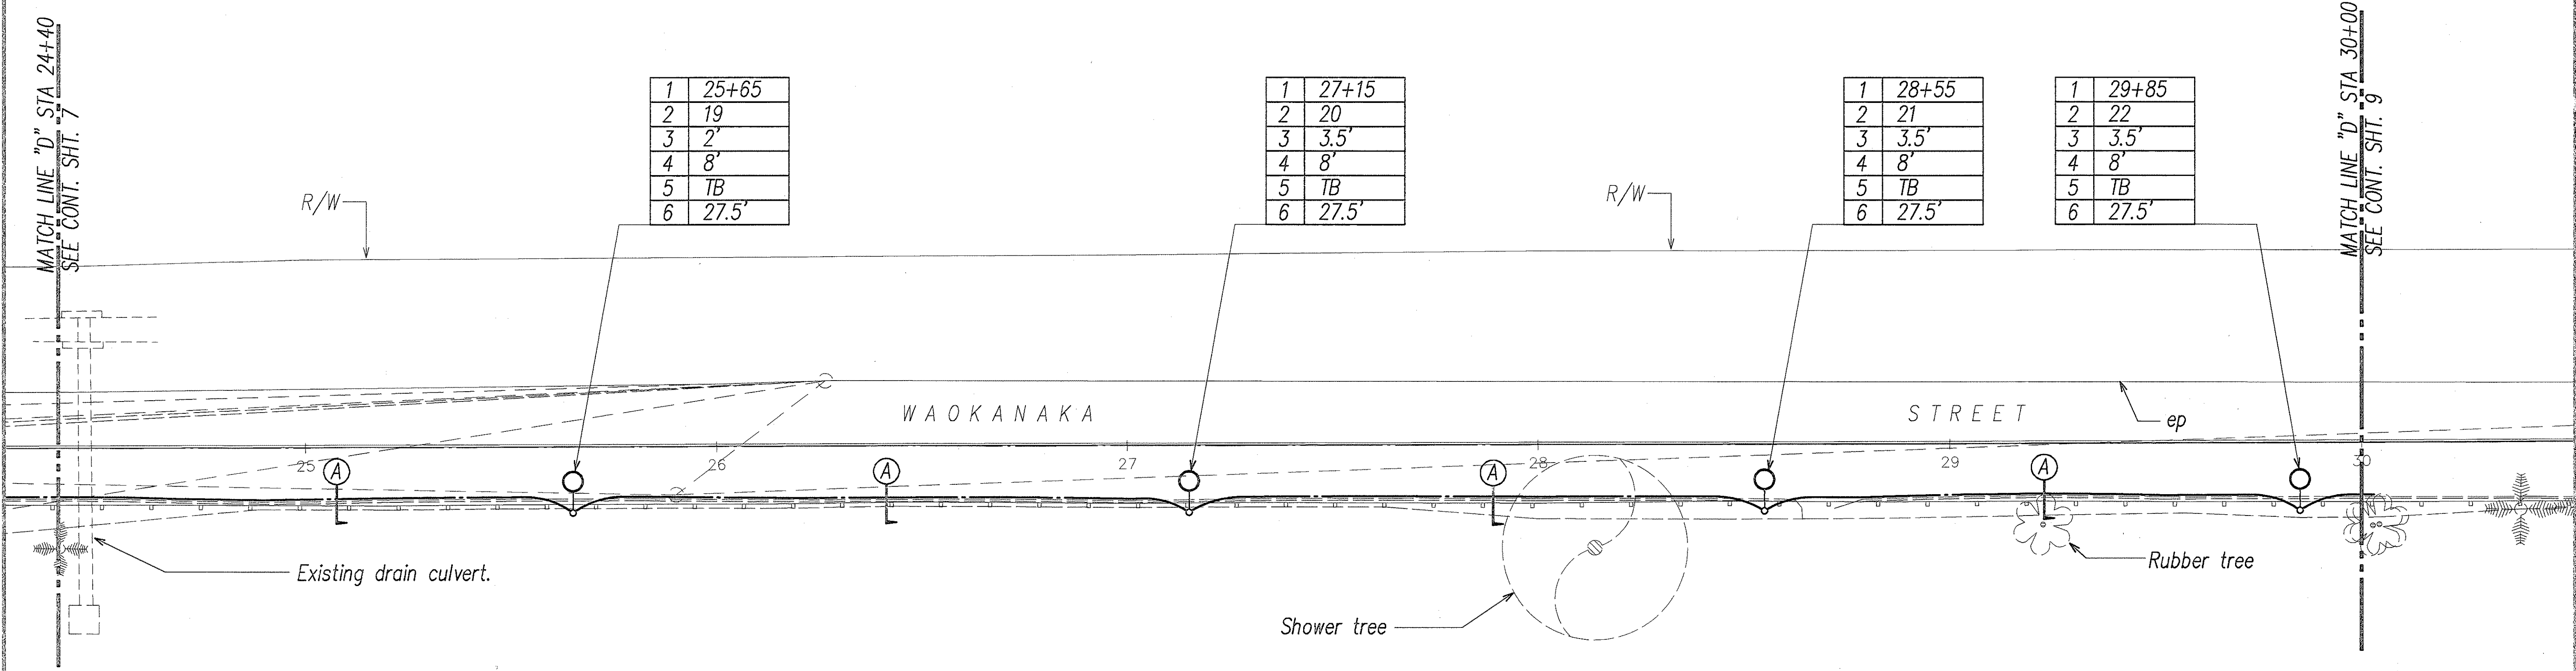


ORIGINAL PLAN	SURVEY PLOTTED BY	DATE
NOTE BOOK	DRAWN BY	
	TRACED BY	
	CHECKED BY	
	QUANTITIES BY	
	CHECKED BY	
	DATE	

LAST SAVE: 01/26/99 @ 16:25:35 BY: JH101051
 Z:\ACAD\PROJECTS\971051\71051.dwg XREFS: X71051.dwg

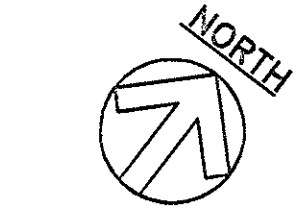

ELECTRICAL PLAN V
 SCALE: 1"=20'

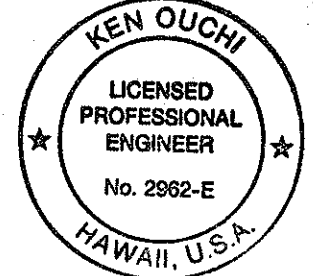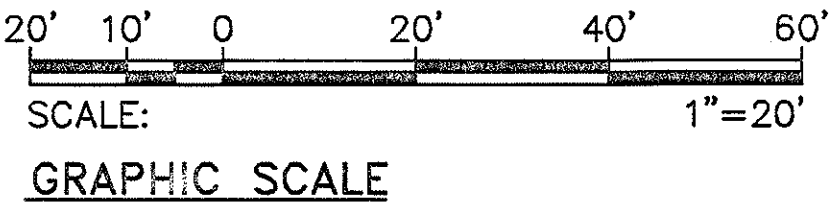

THIS WORK WAS PREPARED BY ME
 OR UNDER MY SUPERVISION.
R. S. Ho
 RONALD N. S. HO & ASSOC., INC.
 ELECTRICAL ENGINEERS

STATE OF HAWAII
DEPARTMENT OF TRANSPORTATION
HIGHWAYS DIVISION


ELECTRICAL PLAN V

WAOKANAKA STREET
INSTALLATION OF HIGHWAY LIGHTS
PROJECT NO. HWY-0-10-98

SCALE: AS NOTED DATE: JAN 1999

SHEET No. 8 OF 13 SHEETS

FED. ROAD DIST. NO.	STATE	PROJ. NO.	FISCAL YEAR	SHEET NO.	TOTAL SHEETS
HAWAII	HAW.	HWY-0-10-98	1999	9	13


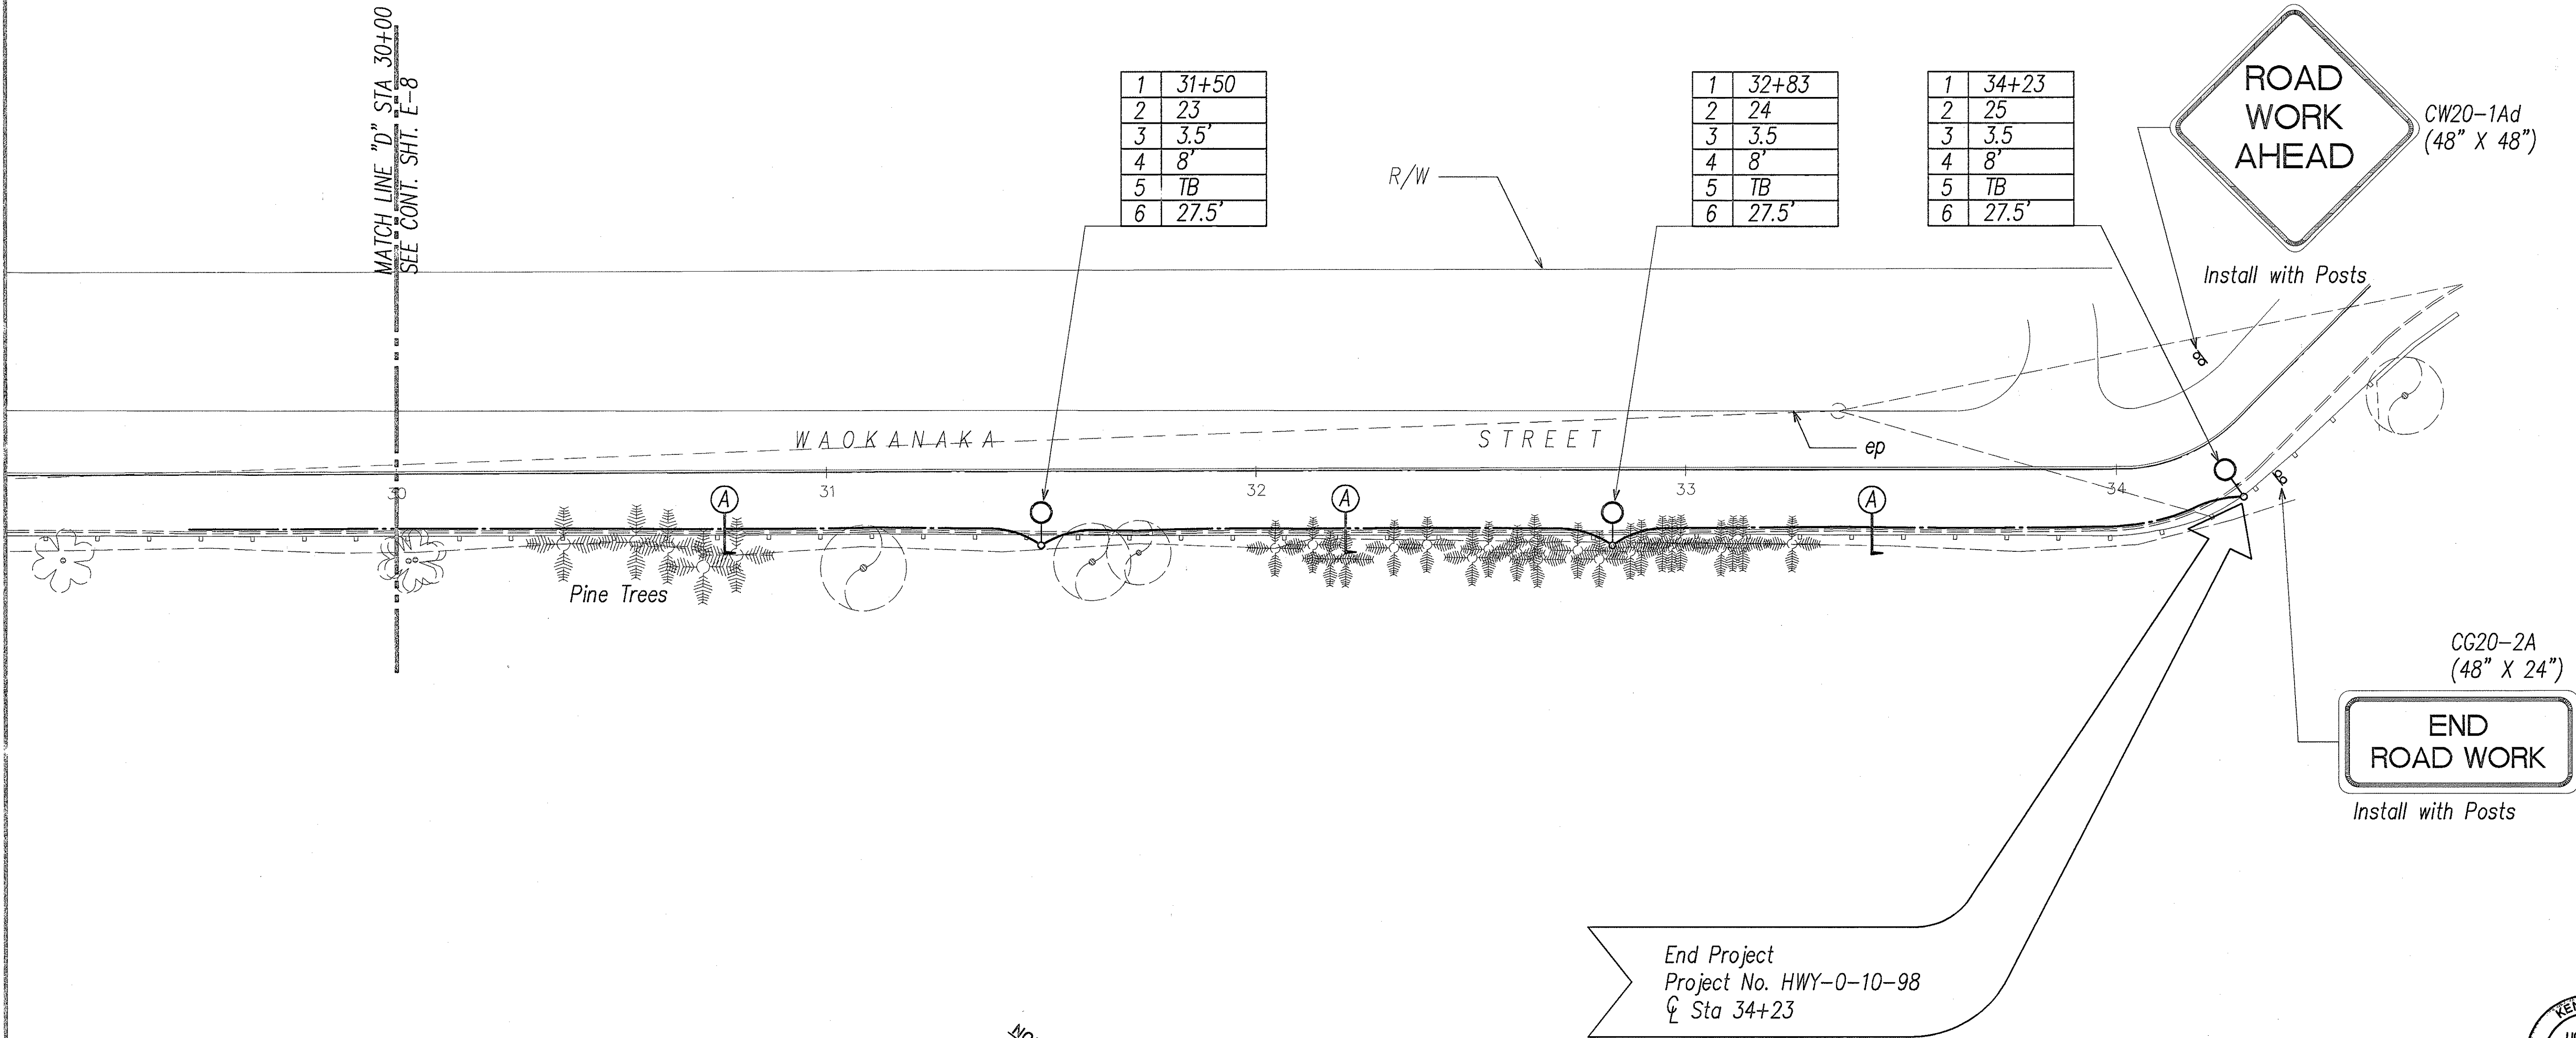


ORIGINAL PLAN	SURVEY PLOTTED BY	DATE
NOTE BOOK	DRAWN BY	
	DESIGNED BY	
	CHECKED BY	
	IN CHARGE	

LAST SAVE: 01/24/99 6:10:24 PM
 Z:\ACAD\PROJECTS\0109\7776166.MXD X7189-RD



ELECTRICAL PLAN VI
 SCALE: 1"=20'

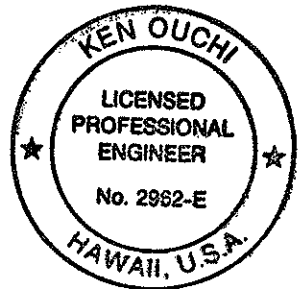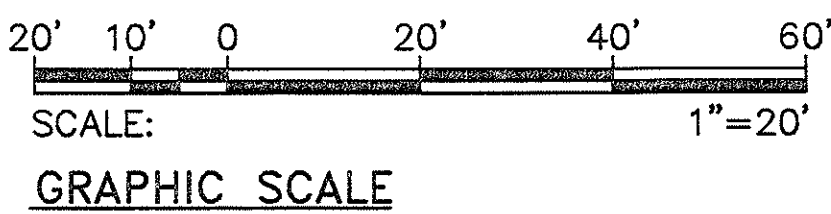

THIS WORK WAS PREPARED BY ME
 OR UNDER MY SUPERVISION.
R. Ouchi
 RONALD N. S. HO & ASSOC., INC.
 ELECTRICAL ENGINEERS

STATE OF HAWAII
DEPARTMENT OF TRANSPORTATION
HIGHWAYS DIVISION

ELECTRICAL PLAN VI

WAOKANAKA STREET
INSTALLATION OF HIGHWAY LIGHTS
PROJECT NO. HWY-0-10-98

SCALE: AS NOTED DATE: JAN 1999

SHEET No. 9 OF 13 SHEETS