


FED. ROAD DIST. NO.	STATE	PROJ. NO.	FISCAL YEAR	SHEET NO.	TOTAL SHEETS
HAWAII	HAW.	HWY-0-10-98	1999	12	13

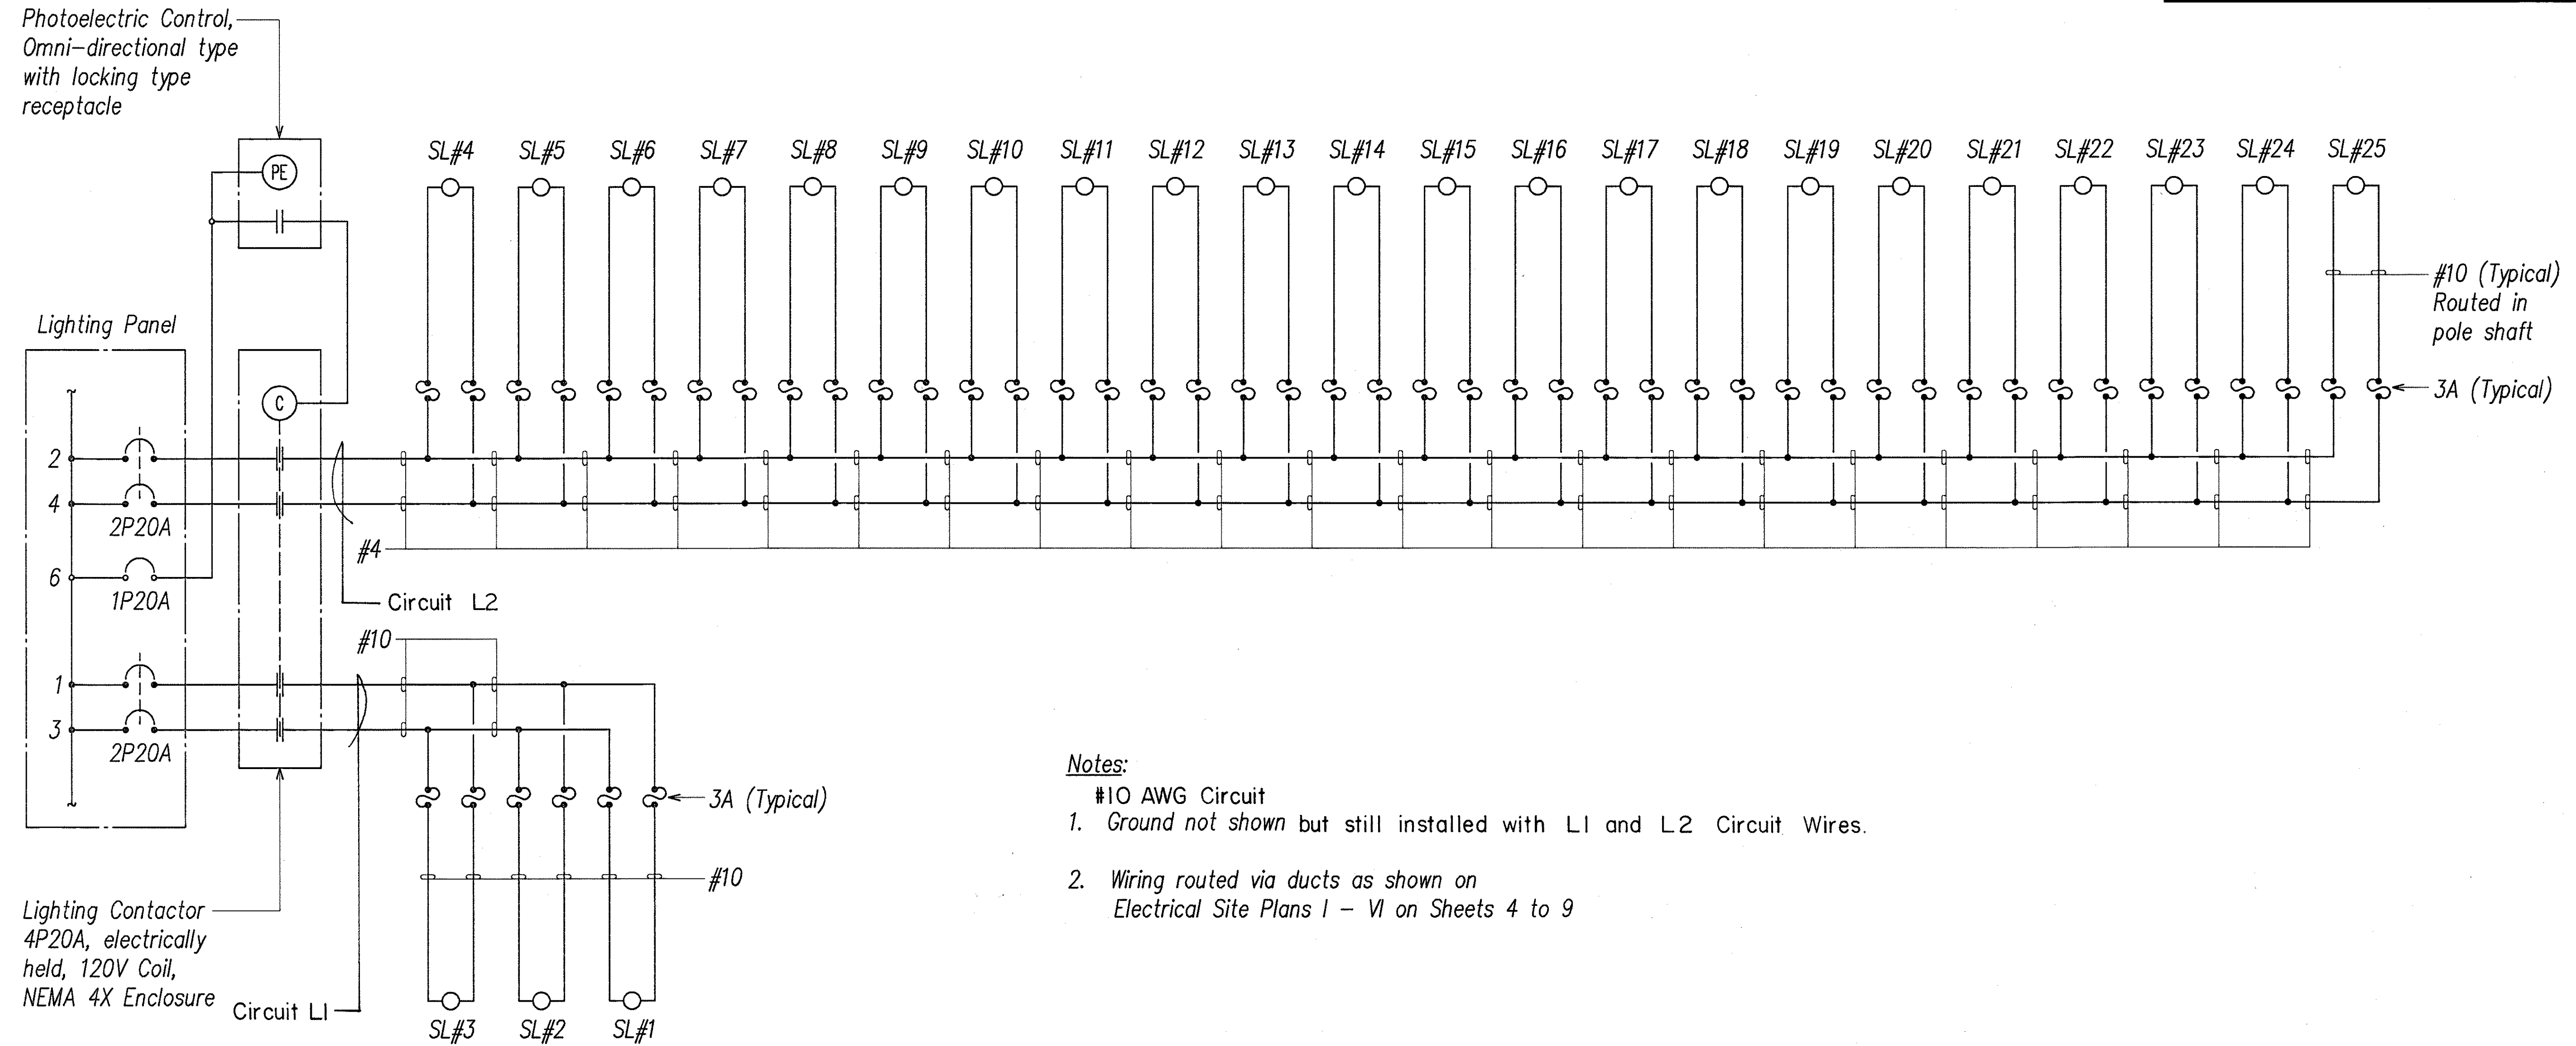


- Notes:
- #10 AWG Circuit
 - 1. Ground not shown but still installed with L1 and L2 Circuit Wires.
 - 2. Wiring routed via ducts as shown on Electrical Site Plans I - VI on Sheets 4 to 9

STREET LIGHT CIRCUIT WIRING DIAGRAM

ORIGINAL PLAN	SURVEY PLOTTED BY	DATE
NOTE BOOK	DRAWN BY	
	DESIGNED BY	
	QUANTITIES BY	
	CHECKED BY	
	IN CHARGE	

LAST SAVE: 02/10/99 16:09:00
Z:\ACAD\PROJECTS\97\HWY010\12\12.DWG

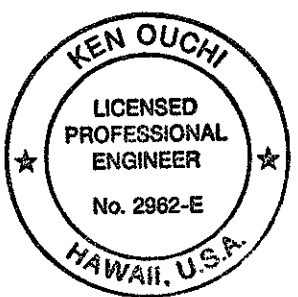

THIS WORK WAS PREPARED BY ME
OR UNDER MY SUPERVISION.
R. Ouchi
RONALD N. S. HO & ASSOC., INC.
ELECTRICAL ENGINEERS

STATE OF HAWAII
DEPARTMENT OF TRANSPORTATION
HIGHWAYS DIVISION

WIRING DIAGRAM

WAOOKANAKA STREET
INSTALLATION OF HIGHWAY LIGHTS
PROJECT NO. HWY-0-10-98

SCALE: NONE DATE: JAN 1999

SHEET No. 12 OF 13 SHEETS