
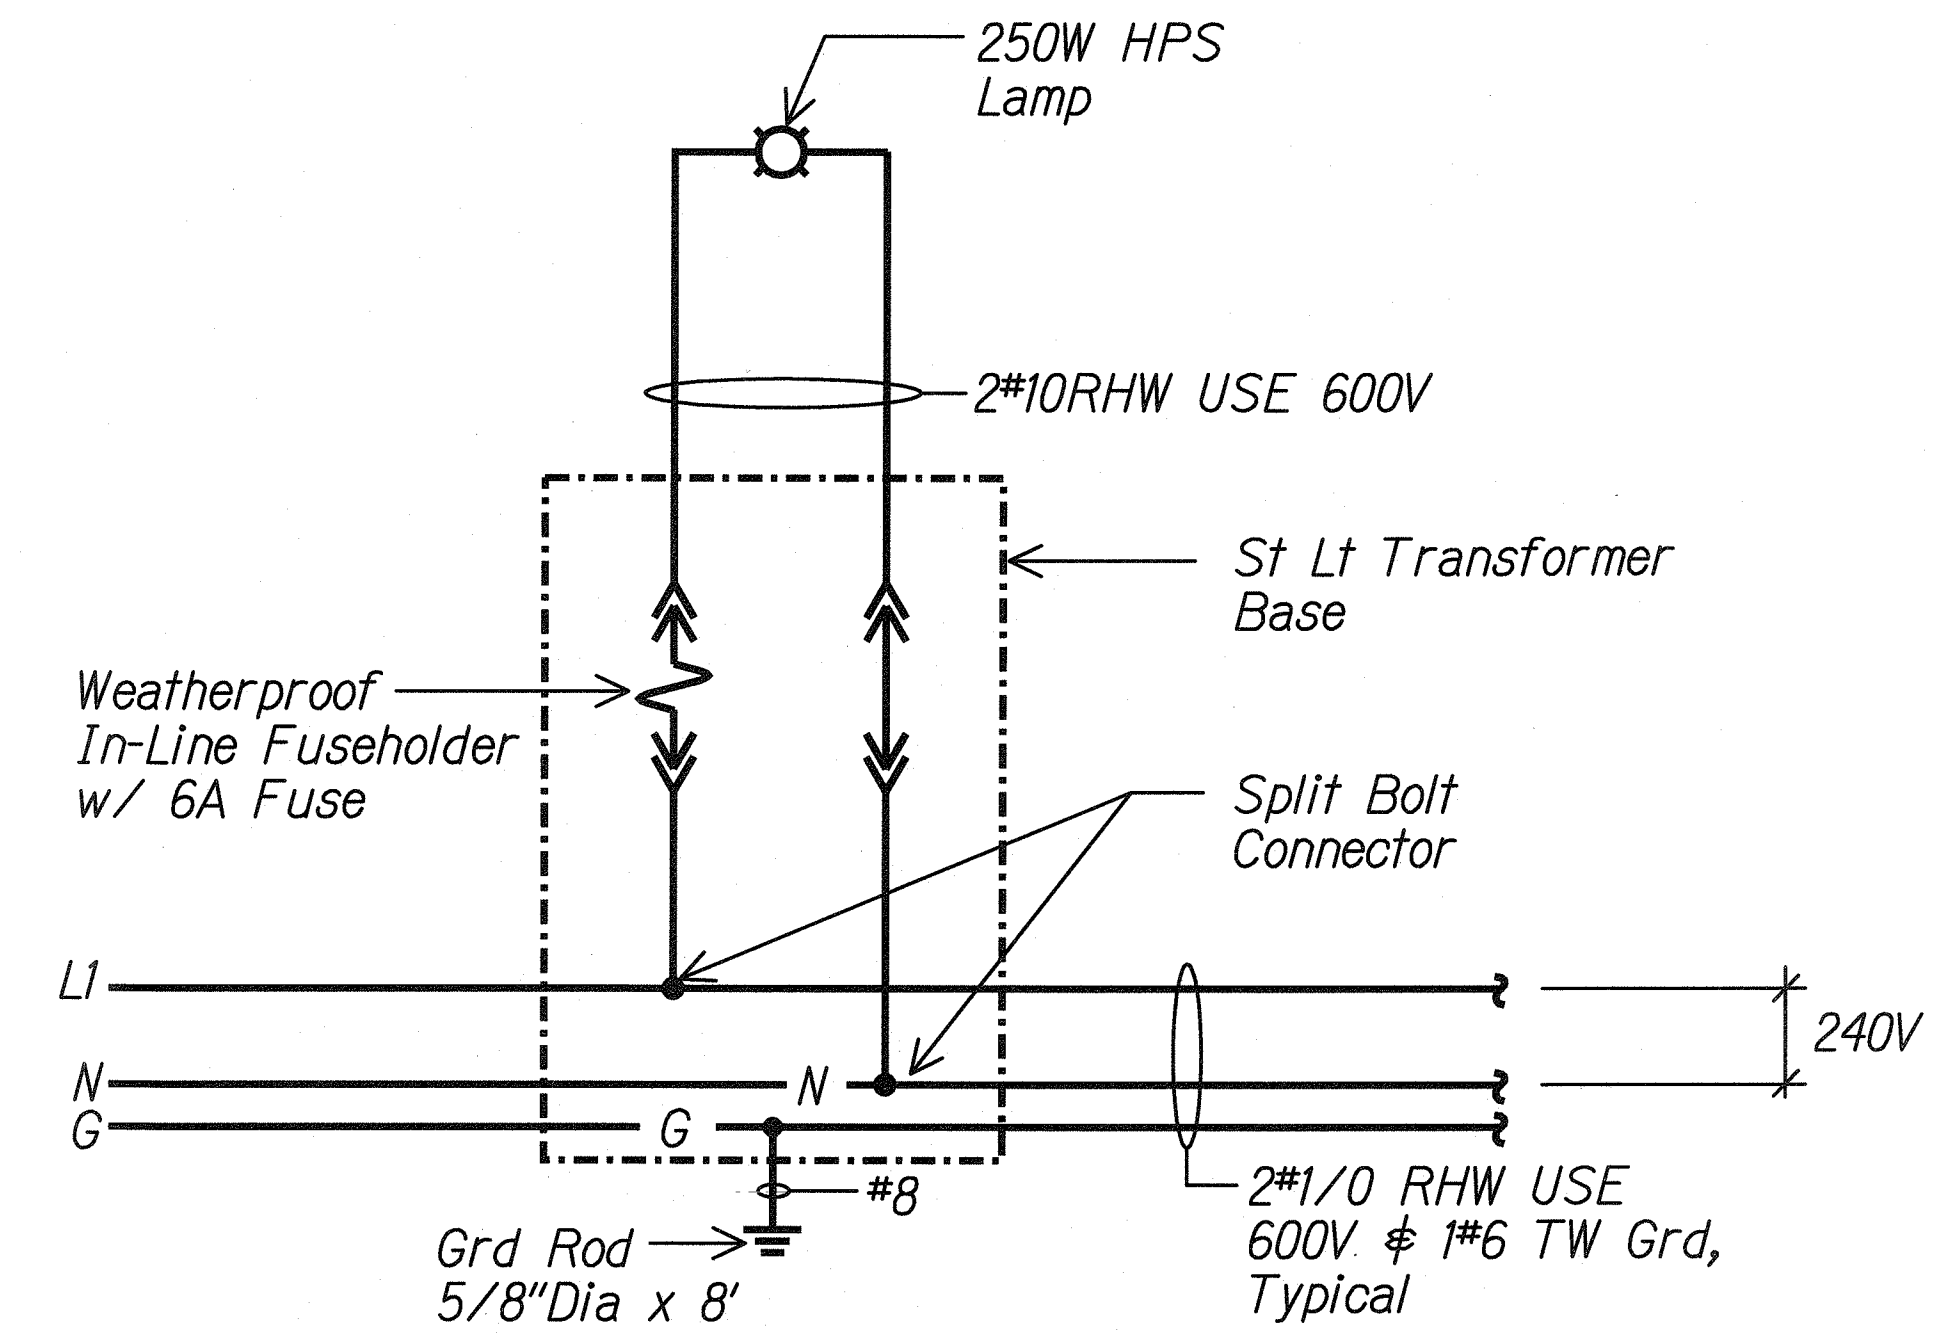


FED. ROAD DIST. NO.	STATE	PROJ. NO.	FISCAL YEAR	SHEET NO.	TOTAL SHEETS
HAWAII	HAW.	61C-01-04	2004	43	91


02-04

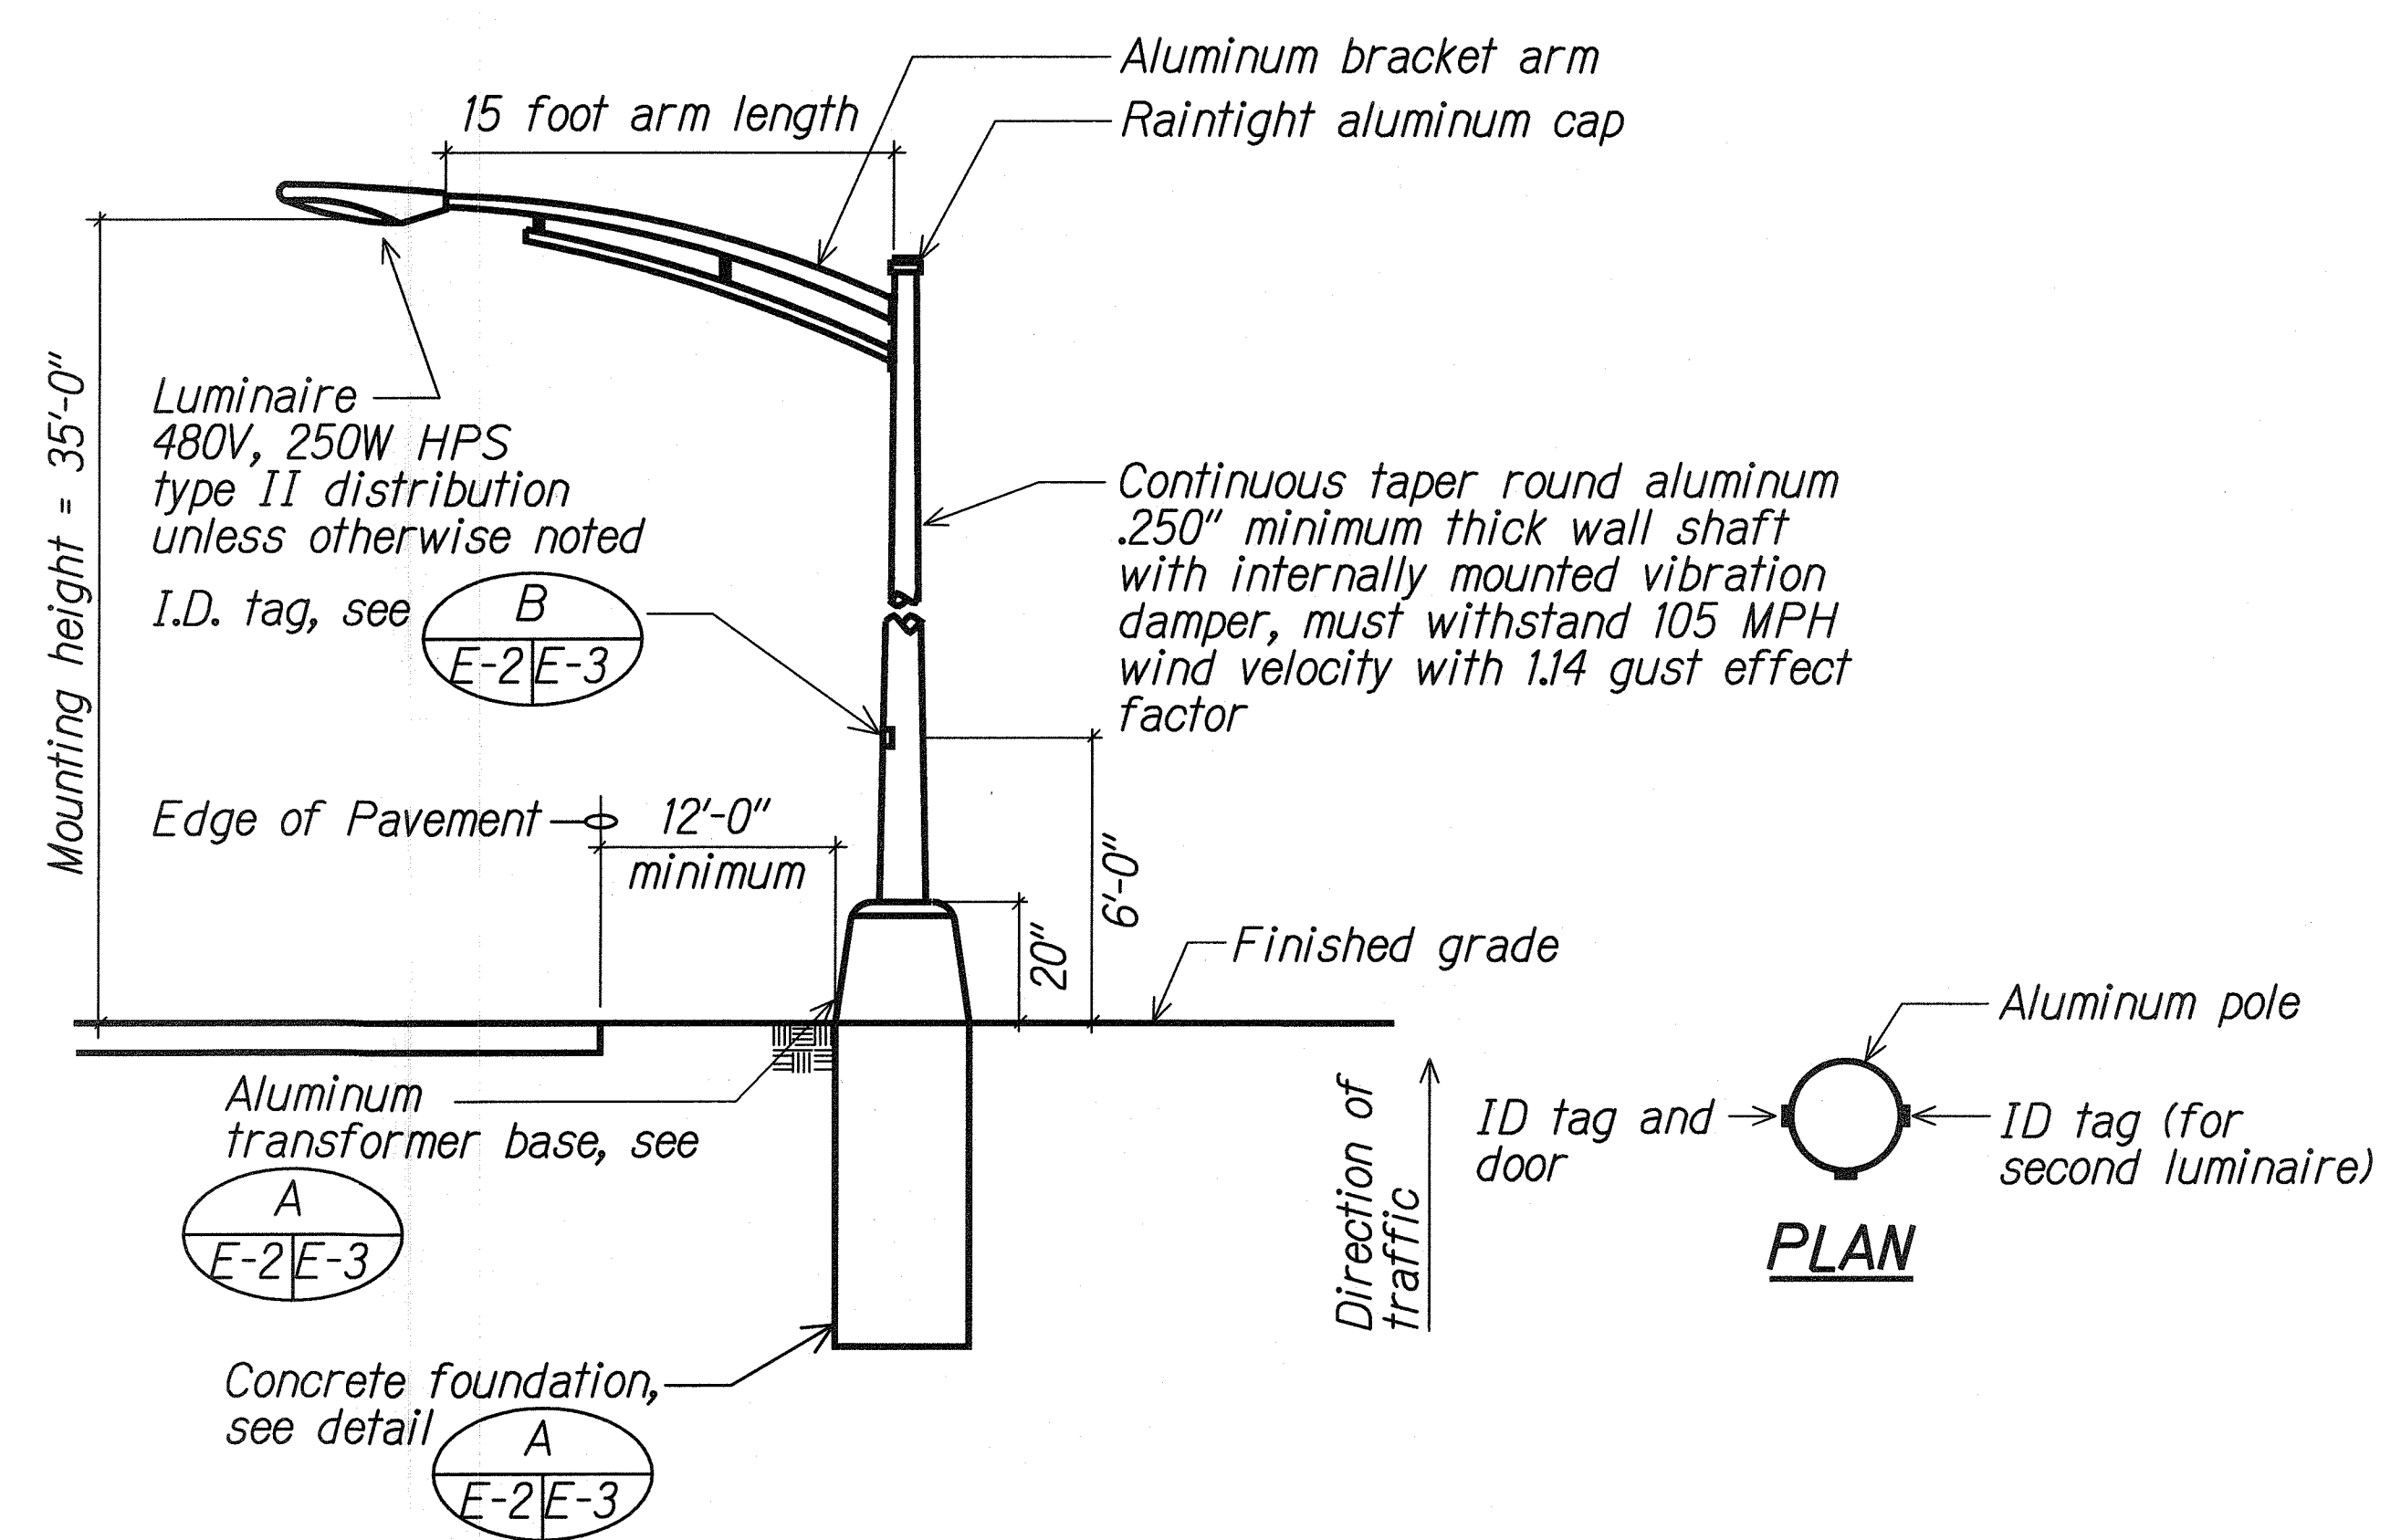

TYPICAL STREET LIGHT WIRING DIAGRAM

A TYPICAL LIGHT STANDARD INSTALLATION ON GRADE
E-1 E-2 Not to scale

- Notes:**
1. Aluminum pole must conform to the "2001 AASHTO Standard Specifications for structural supports for highway signs, luminaires and traffic signals.

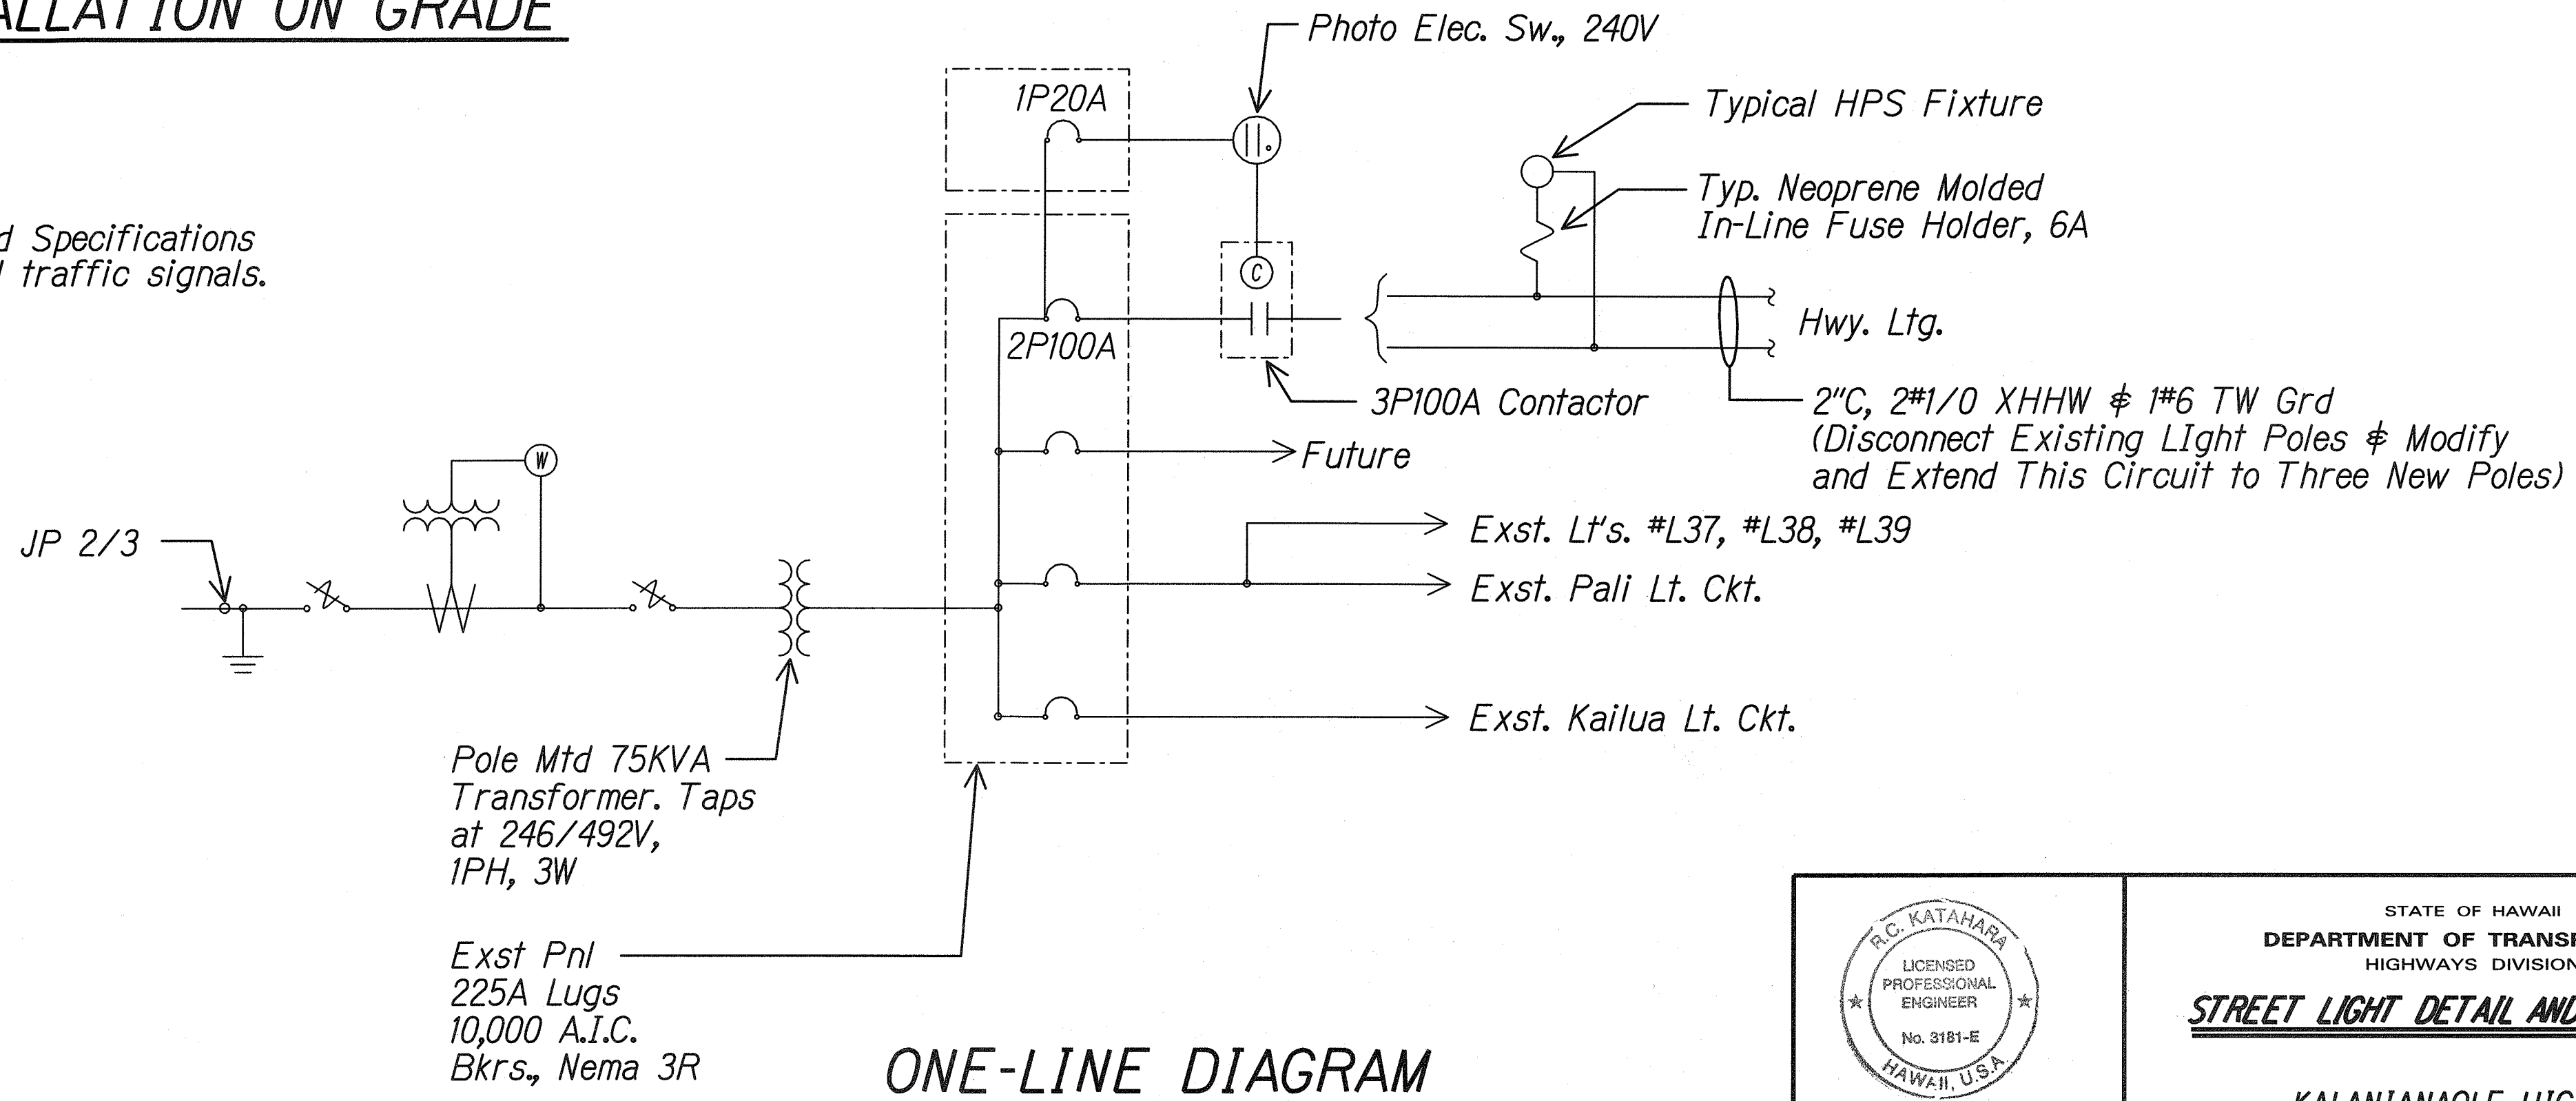

ONE-LINE DIAGRAM
Existing shown for information

THIS WORK WAS PREPARED BY ME OR UNDER MY SUPERVISION.
Date: 8/18/2009
R.C. KATAHARA
R.K. ENGINEERS, LTD.

STATE OF HAWAII
DEPARTMENT OF TRANSPORTATION
HIGHWAYS DIVISION

STREET LIGHT DETAIL AND DIAGRAMS

KALANIANA'OLE HIGHWAY
EMERGENCY LANDSLIDE REPAIRS AT CASTLE JUNCTION
PROJECT NO. 61C-01-04 02-04
Scale: Date: 9/12/03